

ASH/04 NOTES:
CEILING & BULKHEADS REVISED WITH
ASH/04 REVISIONS NOT CLOTTED.

CEILING NOTES:

1. TYPICAL GYPSUM BULKHEAD W/O ACOUSTIC INSULATION
2. CEILING TYPE C1 W/ ACOUSTIC INSULATION AT BATHROOMS AND LAUNDRY CLOSETS TYP.
3. KITCHEN BULKHEAD @ 2450mm AFF TYP. U.N.D. @ 2200mm AFF ON LEVELS 3 AND 4
4. ALL PLUMBING PENETRATING SLAB ABOVE TO BE WRAPPED W/ 38mm ACOUSTIC BATT EXCEPT IN BATHROOM CEILINGS.
5. PARTITIONS AROUND C1 CEILINGS TO BE FILLED W/ ACOUSTIC BATT ABOVE THE CEILING. EXTEND GYPSUM TO US SLAB ABOVE ON ONE SIDE OF PARTITION MIN.
6. WHERE PLUMBING FROM ABOVE IS LOCATED OVER A ROOM BELOW OTHER THAN A BATHROOM, PROVIDE AN INSULATED C1 CEILING, PLUS WRAP THE PLUMBING IN ACOUSTIC BATT.

PLAN DRAWING LEGEND:



- DENOTES PAINTED CIA GYPSUM BULKHEAD AT 2450 AFF UNLESS NOTED
- (MTL3) YELLOW METAL PANEL CLADDING
- W1A EXTERIOR WALL ASSEMBLIES UNLESS NOTED OTHERWISE

- DENOTES BARRIER-FREE DESIGNATED RESIDENTIAL SUITE
- RD X/X% DENOTES ROOF DRAIN AND ROOF DRAINAGE LAYOUT. REFER ALSO TO SLAB EDGE PLANS FOR SLOPES AND SLAB ELEVATIONS

REFER TO DWG. A620 FOR DETAILS OF WINDOW WASHING SYSTEMS

- AP ANCHOR POINT
- DB DAVIT BASE
- RDB RECESSED DAVIT BASE

- RRA RECESSED ROOF ANCHOR
- RA ROOF ANCHOR
- RA ROOF ANCHOR - WALL MOUNTED
- RS WINDOW WASHING RIGGING SLEEVE

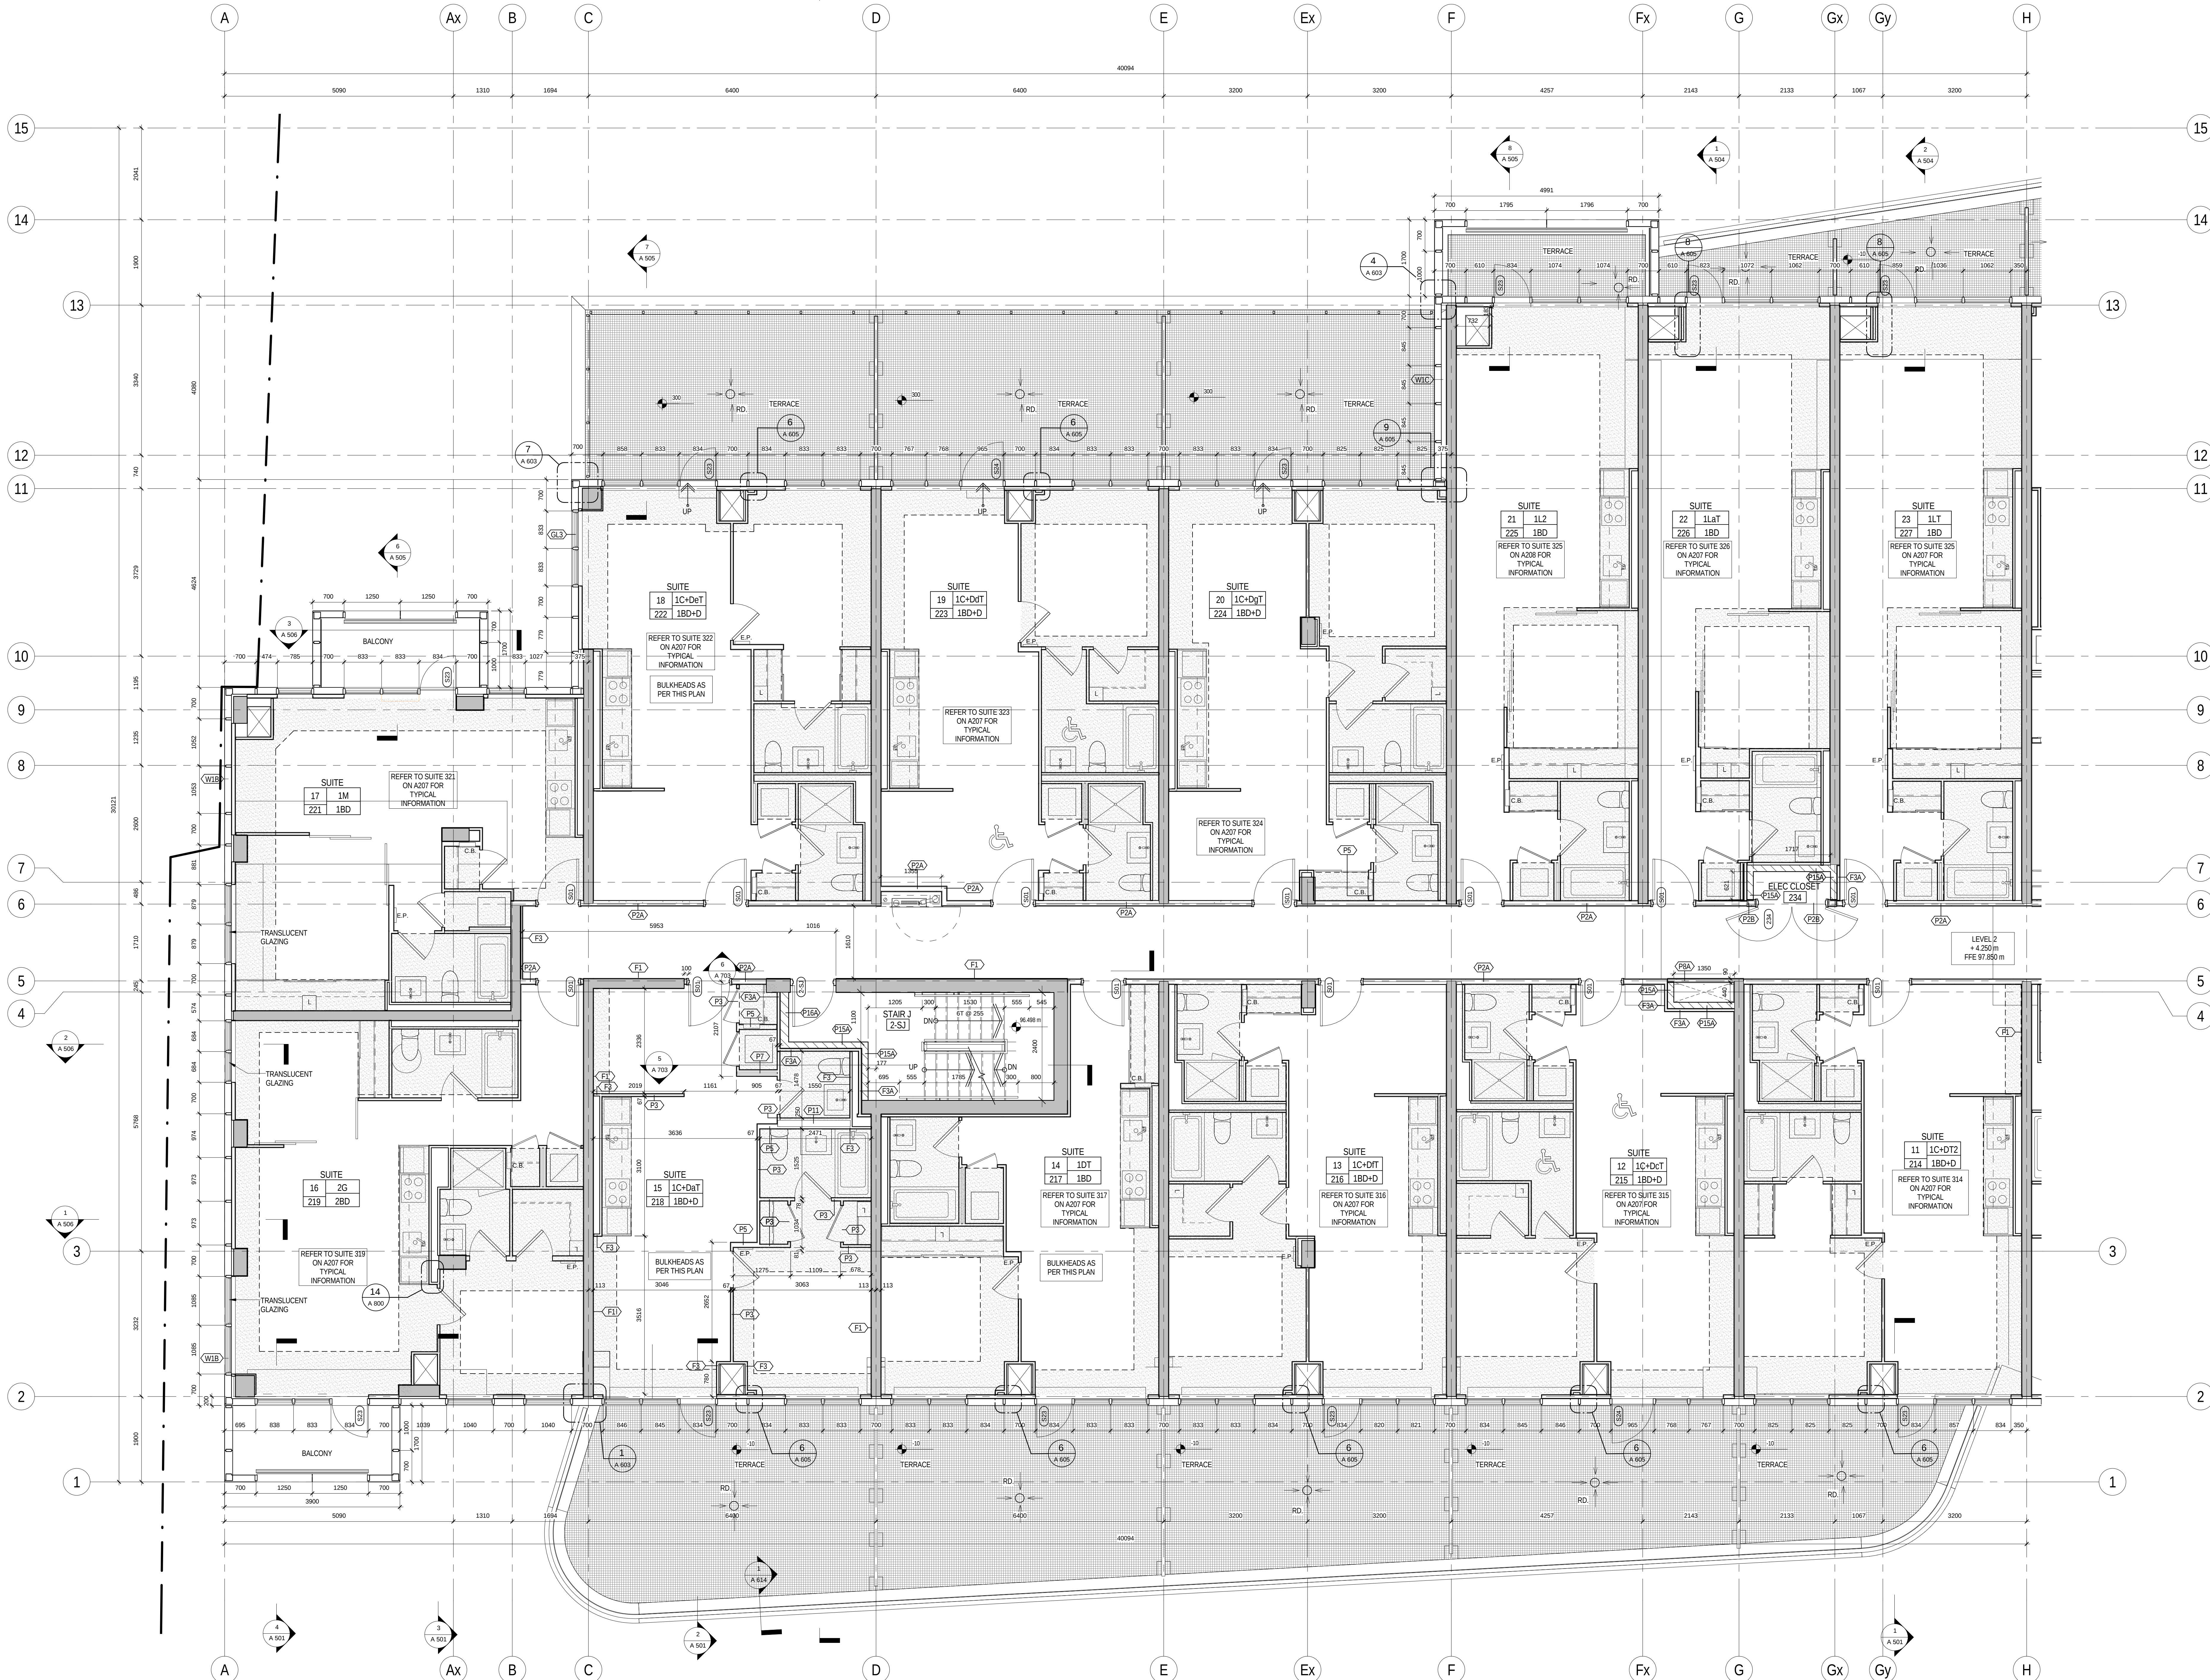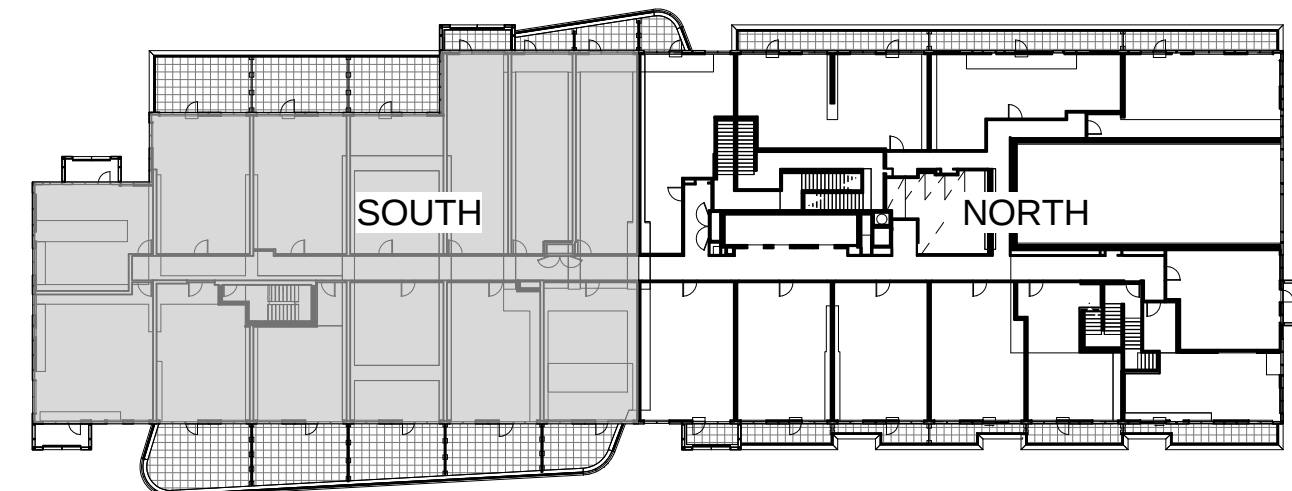

METRIC SCALE DRAWING

FIRST FLOOR ELEV. +93.60m

NO.	ISSUED/REVISED FOR	DATE
1	Issued for SPA	2013-03-26
2	Issued for SPA	2013-04-11
3	Issued for Construction	2013-04-17
4	Revised for SPA	2014-01-10
5	Issued for Construction	2014-03-18
6	Issued for Elevator Tender	2014-04-07
7	Issued for Construction	2014-05-07
8	Issued for 90% Completion	2014-05-12
9	Issued for Permit	2014-05-20
10	Issued for Construction	2014-06-03
11	Revised for Permit	2014-07-02
12	Revised for Permit	2014-08-12
13	Issued for Tender	2014-08-26
14	Issued for Tender	2014-09-12
15	Issued for Flooring Tender	2015-03-10
16	Issued for Tender	2015-05-06
17	Issued for AS/04	2015-05-17
18	Issued for Drywall Tender	2015-09-18

SQ ALEXANDRA PARK - BLOCK 11
38 CAMERON ST. TORONTO, ONTARIO M5T 2H2

project no: 12-115
scale: As indicated
drawn by: TA
reviewed by: AH
date: 2014-09-22

Teepie Architects

LEVEL 2 PLAN SOUTH

1
A 205

LEVEL 2 PLAN SOUTH

1:50

A 205