

AS-OF NOTES:
CEILING & BULKHEADS REVISED WITH
AS-OF REVISIONS NOT CLOUDED



- CEILING NOTES:
1. TYPICAL GYPSUM BULKHEAD W/O ACOUSTIC INSULATION
 2. CEILING TYPE C1 W/ ACOUSTIC INSULATION AT BATHROOMS AND LAUNDRY CLOSETS TYP.
 3. KITCHEN BULKHEAD @ 2450mm AFF TYP. U.N.D. @ 2200mm AFF ON LEVELS 3 AND 4
 4. ALL PLUMBING PENETRATING SLAB ABOVE TO BE WRAPPED W/ 38mm ACOUSTIC BATT EXCEPT IN BATHROOM CEILING.
 5. PARTITIONS AROUND C1 CEILING TO BE FILLED W/ ACOUSTIC BATT ABOVE THE CEILING. EXTEND GYPSUM TO U/S SLAB ABOVE ON ONE SIDE OF PARTITION MIN.
 6. WHERE PLUMBING FROM ABOVE IS LOCATED OVER A ROOM BELOW OTHER THAN A BATHROOM, PROVIDE AN INSULATED C1 CEILING, PLUS WRAP THE PLUMBING IN ACOUSTIC BATT.

- PLAN DRAWING LEGEND:
- DENOTES PAINTED CIA GYPSUM BULKHEAD AT 2200 AFF UNLESS NOTED
 - (MTL) YELLOW METAL PANEL CLADDING
 - (WIA) EXTERIOR WALL ASSEMBLIES W/ UNLESS NOTED OTHERWISE

- DENOTES BARRIER-FREE DESIGNATED RESIDENTIAL SUITE
- DENOTES ROOF DRAIN AND ROOF DRAINAGE LAYOUT. REFER ALSO TO SLAB EDGE TYP. AND FOR SLOPES AND SLAB ELEVATIONS

- REFER TO DWG. A202 FOR DETAILS OF WINDOW WASHING SYSTEMS
- AP ANCHOR POINT
 - DB DAWT BASE
 - RDB RECESSED DAWT BASE

- RA RECESSED ROOF ANCHOR
- RA ROOF ANCHOR
- RA ROOF ANCHOR - WALL MOUNTED
- RS WINDOW WASHING RIGGING SLEEVE

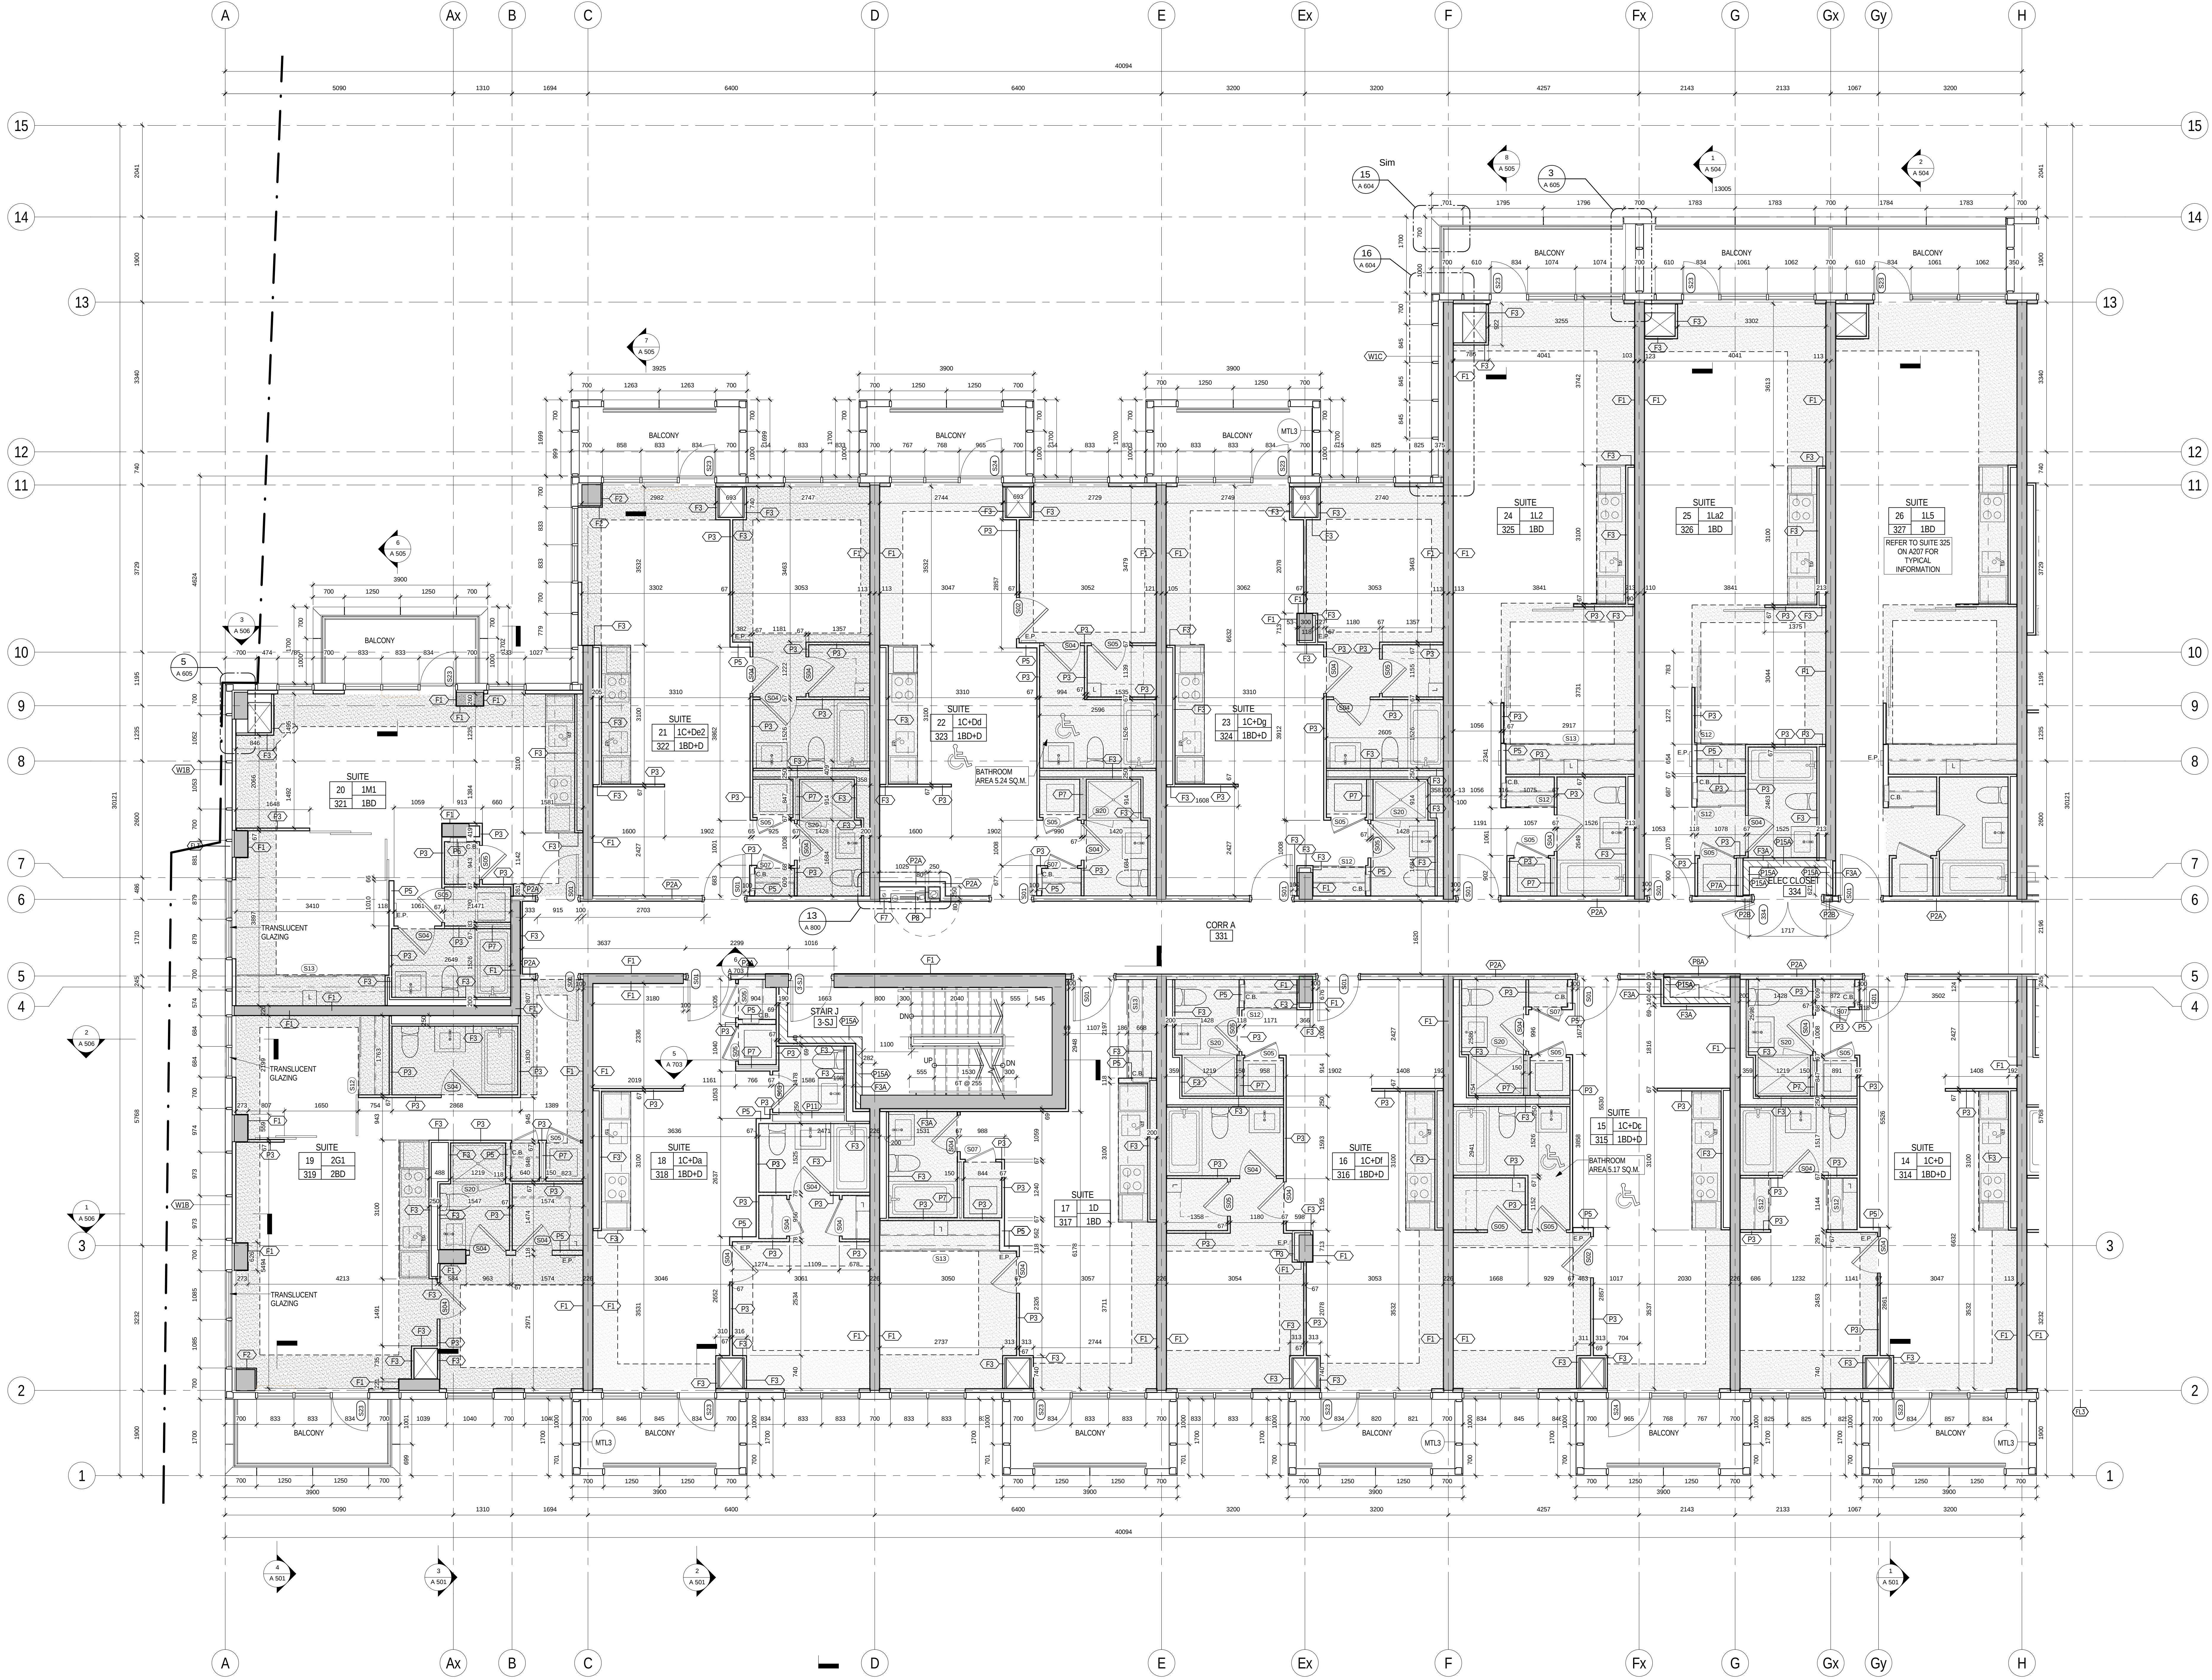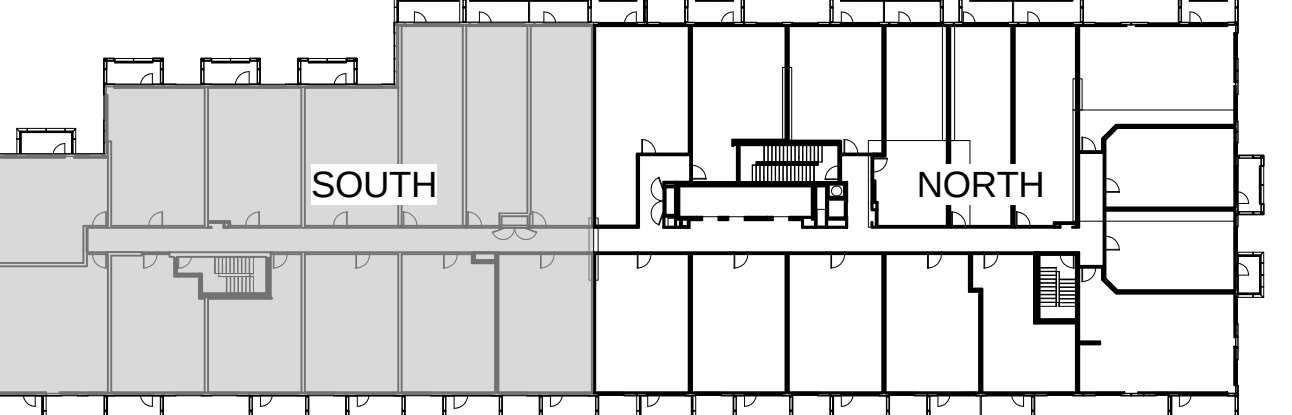

SQ
SPADINA QUEEN
TRIDEL

METRIC SCALE DRAWING
FIRST FLOOR ELEV. +93.60m

NO.	ISSUED/REVISED FOR	DATE
1	Issued for SPA	2013-03-26
2	Issued for SPA	2013-04-11
3	Issued for SPA	2013-04-17
4	Issued for SPA	2013-04-17
5	Issued for SPA	2013-04-17
6	Issued for SPA	2013-04-17
7	Issued for SPA	2013-04-17
8	Issued for SPA	2013-04-17
9	Issued for SPA	2013-04-17
10	Issued for SPA	2013-04-17
11	Issued for SPA	2013-04-17
12	Issued for SPA	2013-04-17
13	Issued for SPA	2013-04-17
14	Issued for SPA	2013-04-17
15	Issued for SPA	2013-04-17
16	Issued for SPA	2013-04-17
17	Issued for SPA	2013-04-17
18	Issued for SPA	2013-04-17

SQ ALEXANDRA PARK - BLOCK 11
38 CAMERON ST. TORONTO, ONTARIO M5T 2H2

project no: 12-115
scale: As indicated
drawn by: TAU
checked by: TAU
date: 2014-09-22

Teepie Architects
1000 BAYVIEW AVE. SUITE 1000 SCARBOROUGH, ONTARIO M1S 5B5
TEL: (416) 291-1111 FAX: (416) 291-1112
WWW.TEETPIEARCHITECTS.COM

LEVEL 3 PLAN SOUTH