

ASH/G4 NOTES:
CEILING & BULKHEADS REVISED WITH
ASH/G4 REVISIONS NOT CLOUDED

CEILING NOTES:

1. TYPICAL GYPSUM BULKHEAD W/O ACOUSTIC INSULATION
2. CEILING TYPE C1 W/ ACOUSTIC INSULATION AT
BATHROOMS AND LAUNDRY CLOSETS TYP.
3. KITCHEN BULKHEAD @ 2450mm AFF TYP. U.N.O. @ 2290mm
AFF ON LEVELS 3 AND 4
4. ALL PLUMBING PENETRATING SLAB ABOVE TO BE WRAPPED
W/ 38mm ACOUSTIC BATT EXCEPT IN BATHROOM CEILINGS.
5. PARTITIONS AROUND C1 CEILINGS TO BE FILLED
W/ ACOUSTIC BATT ABOVE THE CEILING.
EXTEND GYPSUM TO UIS SLAB ABOVE ON ONE SIDE OF
PARTITION MIN.
6. WHERE PLUMBING FROM ABOVE IS LOCATED OVER A
ROOM BELOW OTHER THAN A BATHROOM, PROVIDE AN
INSULATED C1 CEILING, PLUS WRAP THE PLUMBING IN
ACOUSTIC BATT.


BLIND DRAWING LEGEND:

- DENOTES PAINTED CIA GYPSUM BULKHEAD AT 2550
AFF UNLESS NOTED
- (MTL3) YELLOW METAL PANEL CLADDING
- W1A EXTERIOR WALL ASSEMBLIES
W/A UNLESS NOTED OTHERWISE

- DENOTES BARRIER-FREE DESIGNATED
RESIDENTIAL SUITE
- RD X/XN DENOTES ROOF DRAIN AND ROOF
DRAINAGE LAYOUT. REFER ALSO TO
SLAB EDGE PLANS FOR SLOPES AND
SLAB ELEVATIONS

REFER TO DWG. A420 FOR DETAILS OF
WINDOW WASHING SYSTEMS

- AP ANCHOR POINT
- DB DAVIT BASE
- RD6 RECESSED DAVIT BASE
- RA RECESSED ROOF ANCHOR
- RA ROOF ANCHOR
- RA ROOF ANCHOR - WALL MOUNTED
- RS WINDOW WASHING RIGGING SLEEVE

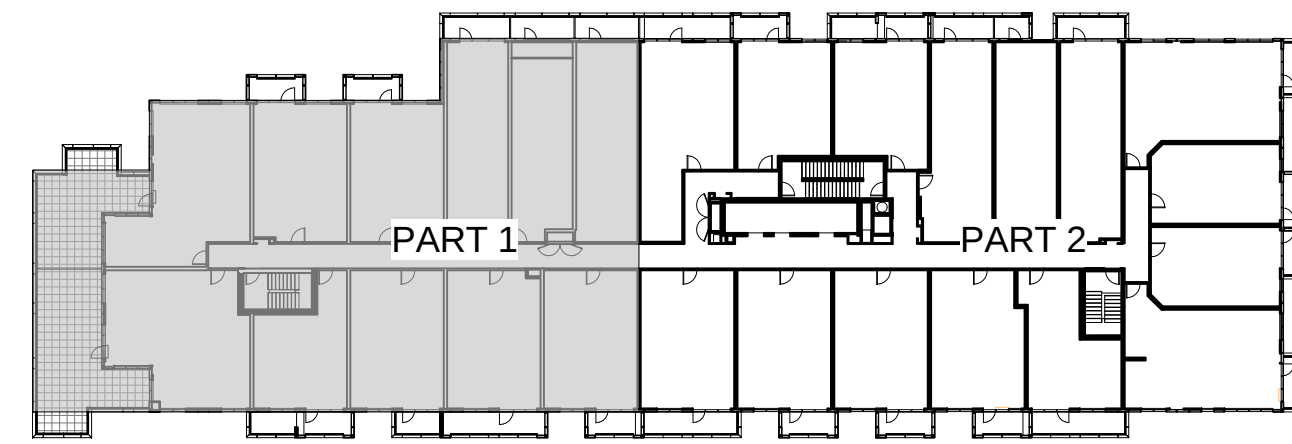

1. All drawings, specifications, schedules and notes are to be read in conjunction with the contract documents and the program of requirements for the project. The drawings are to be read in conjunction with the contract documents and the program of requirements for the project. The drawings are to be read in conjunction with the contract documents and the program of requirements for the project.

SQ
SPADINA QUEEN
TRIDEL

METRIC SCALE DRAWING
FIRST FLOOR ELEV. +93.60m

NO.	ISSUED/REVISED FOR	DATE
1	Issued for SPA	2013-03-26
2	Issued for Construction	2013-04-11
3	Issued for Construction	2013-04-17
4	Revised for SPA	2014-01-01
5	Issued for Construction	2014-03-28
6	Issued for Elevation Tender	2014-04-07
7	Issued for Construction	2014-05-01
8	Issued for 90% Completion	2014-05-23
9	Issued for Permit	2014-05-28
10	Issued for Construction	2014-06-03
11	Revised for Permit	2014-07-01
12	Revised for Permit	2014-08-02
13	Issued for Tender	2014-08-26
14	Issued for Tender	2014-09-25
15	Issued for Flooring Tender	2015-03-10
16	Issued for Tender	2015-05-06
17	Issued for AS/G4	2015-06-17
18	Issued for Final Tender	2015-09-18

SQ ALEXANDRA PARK - BLOCK 11
38 CAMERON ST., TORONTO, ONTARIO M5T 2H2

project no: 12-115
scale: As indicated
drawn by: TAU
reviewed by: JH
date: 2014-09-22

Teeples Architects

LEVEL 5 PLAN SOUTH

1
A 211
LEVEL 5 PLAN SOUTH
1:50

A 211