

AS/04 NOTES:  
CEILING & BULKHEADS REVISED WITH  
AS/04 REVISIONS NOT CLOUDED

CEILING NOTES:

1. TYPICAL GYPSUM BULKHEAD W/0 ACOUSTIC INSULATION
2. CEILING TYPE C1 W/ ACOUSTIC INSULATION AT BATHROOMS AND LAUNDRY CLOSETS TYP.
3. KITCHEN BULKHEAD @ 2450mm AFF TYP. U.N.O. @ 2290mm AFF ON LEVELS 3 AND 4
4. ALL PLUMBING PENETRATING SLAB ABOVE TO BE WRAPPED W/ 38mm ACOUSTIC BATT EXCEPT IN BATHROOM CEILINGS.
5. PARTITIONS AROUND C1 CEILINGS TO BE FILLED W/ ACOUSTIC BATT ABOVE THE CEILING. EXTEND GYPSUM TO US SLAB ABOVE ON ONE SIDE OF PARTITION MIN.
6. WHERE PLUMBING FROM ABOVE IS LOCATED OVER A ROOM BELOW OTHER THAN A BATHROOM, PROVIDE AN INSULATED C1 CEILING, PLUS WRAP THE PLUMBING IN ACOUSTIC BATT.

PLAN DRAWING LEGEND:


- DENOTES PAINTED CIA GYPSUM BULKHEAD AT 2450 AFF UNLESS NOTED
- (MTL3) YELLOW METAL PANEL CLADDING
- <W1A> EXTERIOR WALL ASSEMBLIES W/0 UNLESS NOTED OTHERWISE

- ♿ DENOTES BARRIER-FREE DESIGNATED RESIDENTIAL SUITE
- RD X/X% DENOTES ROOF DRAIN AND ROOF DRAINAGE LAYOUT. REFER ALSO TO SLAB EDGE ELEVATIONS FOR SLOPES AND SLAB ELEVATIONS

REFER TO DWG. A203 FOR DETAILS OF WINDOW WASHING SYSTEMS

- AP ANCHOR POINT
- DB DAVIT BASE
- RDB RECESSED DAVIT BASE

- RA RECESSED ROOF ANCHOR
- RA ROOF ANCHOR
- RA ROOF ANCHOR - WALL MOUNTED
- RS WINDOW WASHING RIGGING SLEEVE

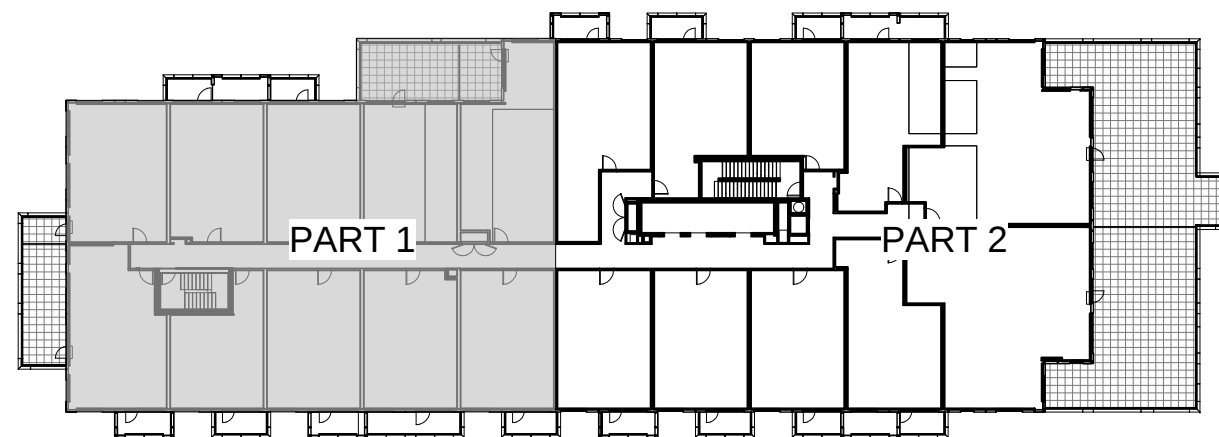

DO NOT SCALE THIS DRAWING

Revised by: [Signature]

Drawn by: [Signature]

Checked by: [Signature]

Approved by: [Signature]

**SQ**  
SPADINA QUEEN  
**TRIDEL**

METRIC SCALE DRAWING

FIRST FLOOR ELEV. +93.60m

NO. ISSUED/REVISED FOR DATE

| NO. | ISSUED/REVISED FOR | DATE       |
|-----|--------------------|------------|
| 1   | Issued for SPA     | 2013-03-26 |
| 2   | Issued for SPA     | 2013-04-11 |
| 3   | Issued for SPA     | 2013-04-17 |
| 4   | Revised for SPA    | 2014-01-10 |
| 5   | Issued for SPA     | 2014-03-18 |
| 6   | Issued for SPA     | 2014-04-07 |
| 7   | Issued for SPA     | 2014-05-07 |
| 8   | Issued for SPA     | 2014-05-23 |
| 9   | Issued for SPA     | 2014-06-05 |
| 10  | Issued for SPA     | 2014-06-23 |
| 11  | Revised for Permit | 2014-07-02 |
| 12  | Revised for Permit | 2014-08-12 |
| 13  | Issued for Permit  | 2014-08-26 |
| 14  | Issued for Permit  | 2014-09-23 |
| 15  | Issued for Permit  | 2015-03-10 |
| 16  | Issued for Permit  | 2015-03-10 |
| 17  | Issued for Permit  | 2015-03-17 |
| 18  | Issued for Permit  | 2015-03-17 |

**SQ ALEXANDRA PARK - BLOCK 11**  
38 CAMERON ST. TORONTO, ONTARIO M5T 2H2

project no: 12-115  
scale: As indicated  
drawn by: TAU  
reviewed by: TAU  
date: 2014-09-22

**Teeple Architects**

1000 BAYVIEW AVE. SUITE 1000 SCARBOROUGH, ONTARIO M1S 1B2

LEVEL 6 PLAN SOUTH

1 LEVEL 6 PLAN SOUTH  
A 213 1:50

A 213