

AS-04 NOTES:
CEILING & BULKHEADS REVISED WITH
AS-04 REVISIONS NOT CLOUDED

CEILING NOTES:

1. TYPICAL GYPSUM BULKHEAD W/0 ACOUSTIC INSULATION
2. CEILING TYPE C1 W/ ACOUSTIC INSULATION AT BATHROOMS AND LAUNDRY CLOSETS TYP.
3. KITCHEN BULKHEAD @ 2450mm AFF TYP. U.N.O. @ 2290mm AFF ON LEVELS 3 AND 4
4. ALL PLUMBING PENETRATING SLAB ABOVE TO BE WRAPPED W/ 38mm ACOUSTIC BATT EXCEPT IN BATHROOM CEILINGS.
5. PARTITIONS AROUND C1 CEILINGS TO BE FILLED W/ ACOUSTIC BATT ABOVE THE CEILING. EXTEND GYPSUM TO U/S SLAB ABOVE ON ONE SIDE OF PARTITION MIN.
6. WHERE PLUMBING FROM ABOVE IS LOCATED OVER A ROOM BELOW OTHER THAN A BATHROOM, PROVIDE AN INSULATED C1 CEILING, PLUS WRAP THE PLUMBING IN ACOUSTIC BATT.

PLAN DRAWING LEGEND:

- DENOTES PAINTED CIA GYPSUM BULKHEAD AT 2450 AFF UNLESS NOTED
- MTL3 YELLOW METAL PANEL CLADDING
- W1A EXTERIOR WALL ASSEMBLIES W/0 UNLESS NOTED OTHERWISE



DENOTES BARRIER-FREE DESIGNATED RESIDENTIAL SUITE


DENOTES ROOF DRAIN AND ROOF DRAINAGE LAYOUT. REFER ALSO TO SLAB EDGE PLANS FOR SLOPES AND SLAB ELEVATIONS

REFER TO DWG. A-201 FOR DETAILS OF WINDOW WASHING SYSTEMS

- AP ANCHOR POINT
- DB DAVIT BASE
- RDB RECESSED DAVIT BASE

RA

- RECESSED ROOF ANCHOR
- RA ROOF ANCHOR
- RA ROOF ANCHOR - WALL MOUNTED
- RS WINDOW WASHING RIGGING SLEEVE

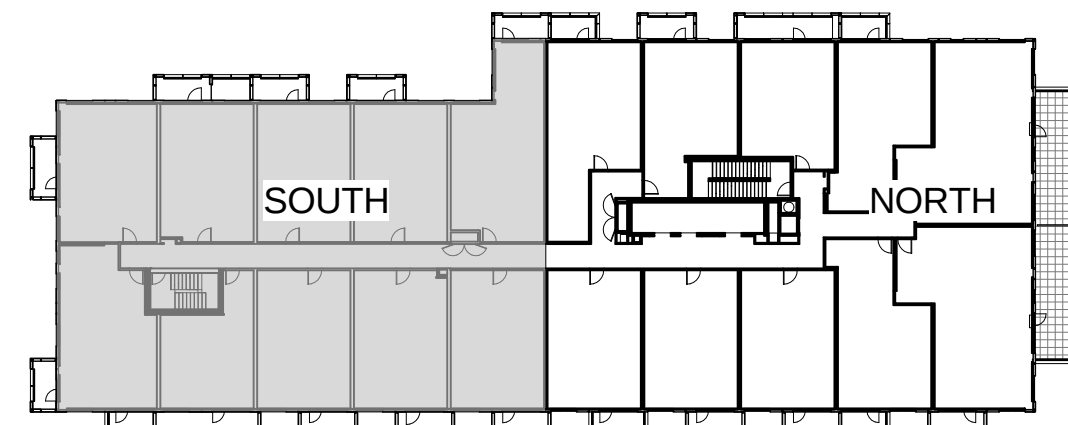

12-115
As indicated
TAU
2014-09-22

SQ
SPADINA QUEEN
TRIDEL

METRIC SCALE DRAWING

FIRST FLOOR ELEV. +93.60m

NO. ISSUED/REVISED FOR: DATE

NO.	ISSUED/REVISED FOR:	DATE
1	Issued for SPA	2013-03-26
2	Issued for Construction	2013-04-11
3	Issued for Construction	2013-04-17
4	Revised for SPA	2014-01-02
5	Issued for Construction	2014-03-18
6	Issued for Elevator Tender	2014-04-07
7	Issued for Construction	2014-05-07
8	Issued for 90% Completion	2014-05-23
9	Issued for Permit	2014-05-28
10	Issued for Construction	2014-06-02
11	Revised for Permit	2014-07-02
12	Revised for Permit	2014-08-02
13	Issued for Tender	2014-08-26
14	Issued for Tender	2014-09-22
15	Issued for Floor Tender	2015-03-10
16	Issued for Tender	2015-05-05
17	Issued for AS104	2015-05-17
18	Issued for Drywall Tender	2015-09-18

SQ ALEXANDRA PARK - BLOCK 11
38 CAMERON ST., TORONTO, ONTARIO M5T 2H2

project no: 12-115
scale: As indicated
drawn by: TAU
reviewed by: TAU
date: 2014-09-22

Teeple Architects

12-115
As indicated
TAU
2014-09-22

LEVEL 7 PLAN SOUTH

1
A 215
LEVEL 7 PLAN SOUTH
1:50

A 215