

AS/04 NOTES:
CEILING & BULKHEADS REVISED WITH
AS/04 REVISIONS NOT CLOUDED

CEILING NOTES:

1. TYPICAL GYPSUM BULKHEAD W/O ACOUSTIC INSULATION
2. CEILING TYPE C1 W/ ACOUSTIC INSULATION AT
BATHROOMS AND LAUNDRY CLOSETS TYP.
3. KITCHEN BULKHEAD @ 2450mm AFF TYP. U.N.O. @ 2290mm
AFF ON LEVELS 3 AND 4
4. ALL PLUMBING PENETRATING SLAB ABOVE TO BE WRAPPED
W/ 38mm ACOUSTIC BATT EXCEPT IN BATHROOM CEILINGS.
5. PARTITIONS AROUND C1 CEILINGS TO BE FILLED
W/ ACOUSTIC BATT ABOVE THE CEILING.
EXTEND GYPSUM TO US SLAB ABOVE ON ONE SIDE OF
PARTITION MIN.
6. WHERE PLUMBING FROM ABOVE IS LOCATED OVER A
ROOM BELOW OTHER THAN A BATHROOM, PROVIDE AN
INSULATED C1 CEILING, PLUS WRAP THE PLUMBING IN
ACOUSTIC BATT.


PLAN DRAWING LEGEND:

- DENOTES PAINTED CIA GYPSUM BULKHEAD AT 2550
AFF UNLESS NOTED
- (MTL3) YELLOW METAL PANEL CLADDING
- <WIA> EXTERIOR WALL ASSEMBLIES
W/A UNLESS NOTED OTHERWISE

- ♿ DENOTES BARRIER-FREE DESIGNATED
RESIDENTIAL SUITE
- RD X/X% DENOTES ROOF DRAIN AND ROOF
DRAINAGE LAYOUT. REFER ALSO TO
SLAB EDGE PLANS FOR SLOPES AND
SLAB ELEVATIONS

REFER TO DWG. A-201 FOR DETAILS OF
WINDOW WASHING SYSTEMS

- AP ANCHOR POINT
- DB DAVIT BASE
- RDB RECESSED DAVIT BASE
- RA RECESSED ROOF ANCHOR
- RA ROOF ANCHOR
- RA ROOF ANCHOR - WALL MOUNTED
- RS WINDOW WASHING RIGGING SLEEVE

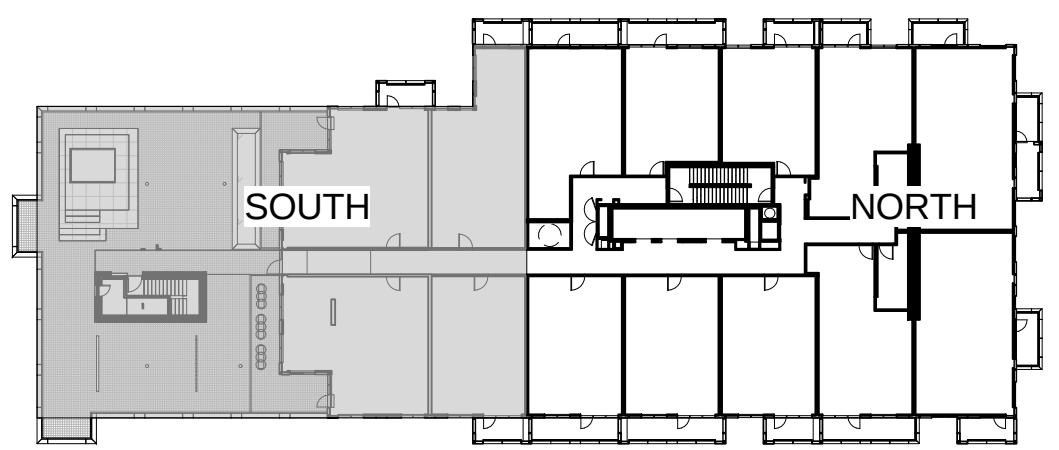

12-115
As indicated
TAU
2014-09-22

SQ
SPADINA QUEEN
TRIDEL

METRIC SCALE DRAWING		
FIRST FLOOR ELEV. +93.60m		
NO.	ISSUED / REVISED FOR	DATE
1	Issued for SPA	2013-03-26
2	Issued for SPA	2013-04-11
3	Issued for SPA	2013-04-17
4	Issued for SPA	2014-01-20
5	Issued for SPA	2014-03-28
6	Issued for SPA	2014-04-07
7	Issued for SPA	2014-05-07
8	Issued for SPA	2014-05-23
9	Issued for SPA	2014-05-23
10	Issued for SPA	2014-05-23
11	Issued for SPA	2014-05-23
12	Issued for SPA	2014-05-23
13	Issued for SPA	2014-05-23
14	Issued for SPA	2014-05-23
15	Issued for SPA	2014-05-23
16	Issued for SPA	2014-05-23
17	Issued for SPA	2014-05-23
18	Issued for SPA	2014-05-23
19	Issued for SPA	2014-05-23

SQ ALEXANDRA PARK - BLOCK 11
38 CAMERON ST., TORONTO, ONTARIO M5T 2H2

project no: 12-115
scale: As indicated
drawn by: TAU
reviewed by: TAU
date: 2014-09-22

Teeple Architects

1000 BAYVIEW AVE. TORONTO, ONT. M2W 1A3
416-461-1111
www.teeplearchitects.com

LEVEL 9 PLAN SOUTH

1
A 219
LEVEL 9 PLAN SOUTH
1:50

A 219