



- CEILING NOTES:
1. TYPICAL GYPSUM BULKHEAD W/O ACOUSTIC INSULATION
 2. CEILING TYPE C1 W/ ACOUSTIC INSULATION AT BATHROOMS AND LAUNDRY CLOSETS TYP.
 3. KITCHEN BULKHEAD @ 2450mm AFF TYP. U.N.O. @ 2300mm AFF ON LEVELS 3 AND 4
 4. ALL PLUMBING PENETRATING SLAB ABOVE TO BE WRAPPED W/ 38mm ACOUSTIC BATT EXCEPT IN BATHROOM CEILINGS.
 5. PARTITIONS AROUND C1 CEILINGS TO BE FILLED W/ ACOUSTIC BATT ABOVE THE CEILING. EXTEND GYPSUM TO UIS SLAB ABOVE ON ONE SIDE OF PARTITION MIN.
 6. WHERE PLUMBING FROM ABOVE IS LOCATED OVER A ROOM BELOW OTHER THAN A BATHROOM, PROVIDE AN INSULATED C1 CEILING, PLUS WRAP THE PLUMBING IN ACOUSTIC BATT.

- PLAN DRAWING LEGEND:
- DENOTES PAINTED GYPSUM BULKHEAD AT 2290 AFF UNLESS NOTED
 - (MTL) YELLOW METAL PANEL CLADDING
 - (WIA) EXTERIOR WALL ASSEMBLIES UNLESS NOTED OTHERWISE

- DENOTES BARRIER-FREE DESIGNATED RESIDENTIAL SUITE
- RD X/X% DENOTES ROOF DRAIN AND ROOF DRAINAGE LAYOUT. REFER ALSO TO SLAB EDGE T/ANS FOR SLOPES AND SLAB ELEVATIONS

- REFER TO DWG. A400 FOR DETAILS OF WINDOW WASHING SYSTEMS
- AP ANCHOR POINT
- DB DAVIT BASE
- RDB RECESSED DAVIT BASE

- RRA RECESSED ROOF ANCHOR
- RA ROOF ANCHOR
- RA ROOF ANCHOR - WALL MOUNTED
- RS WINDOW WASHING RIGGING SLEEVE

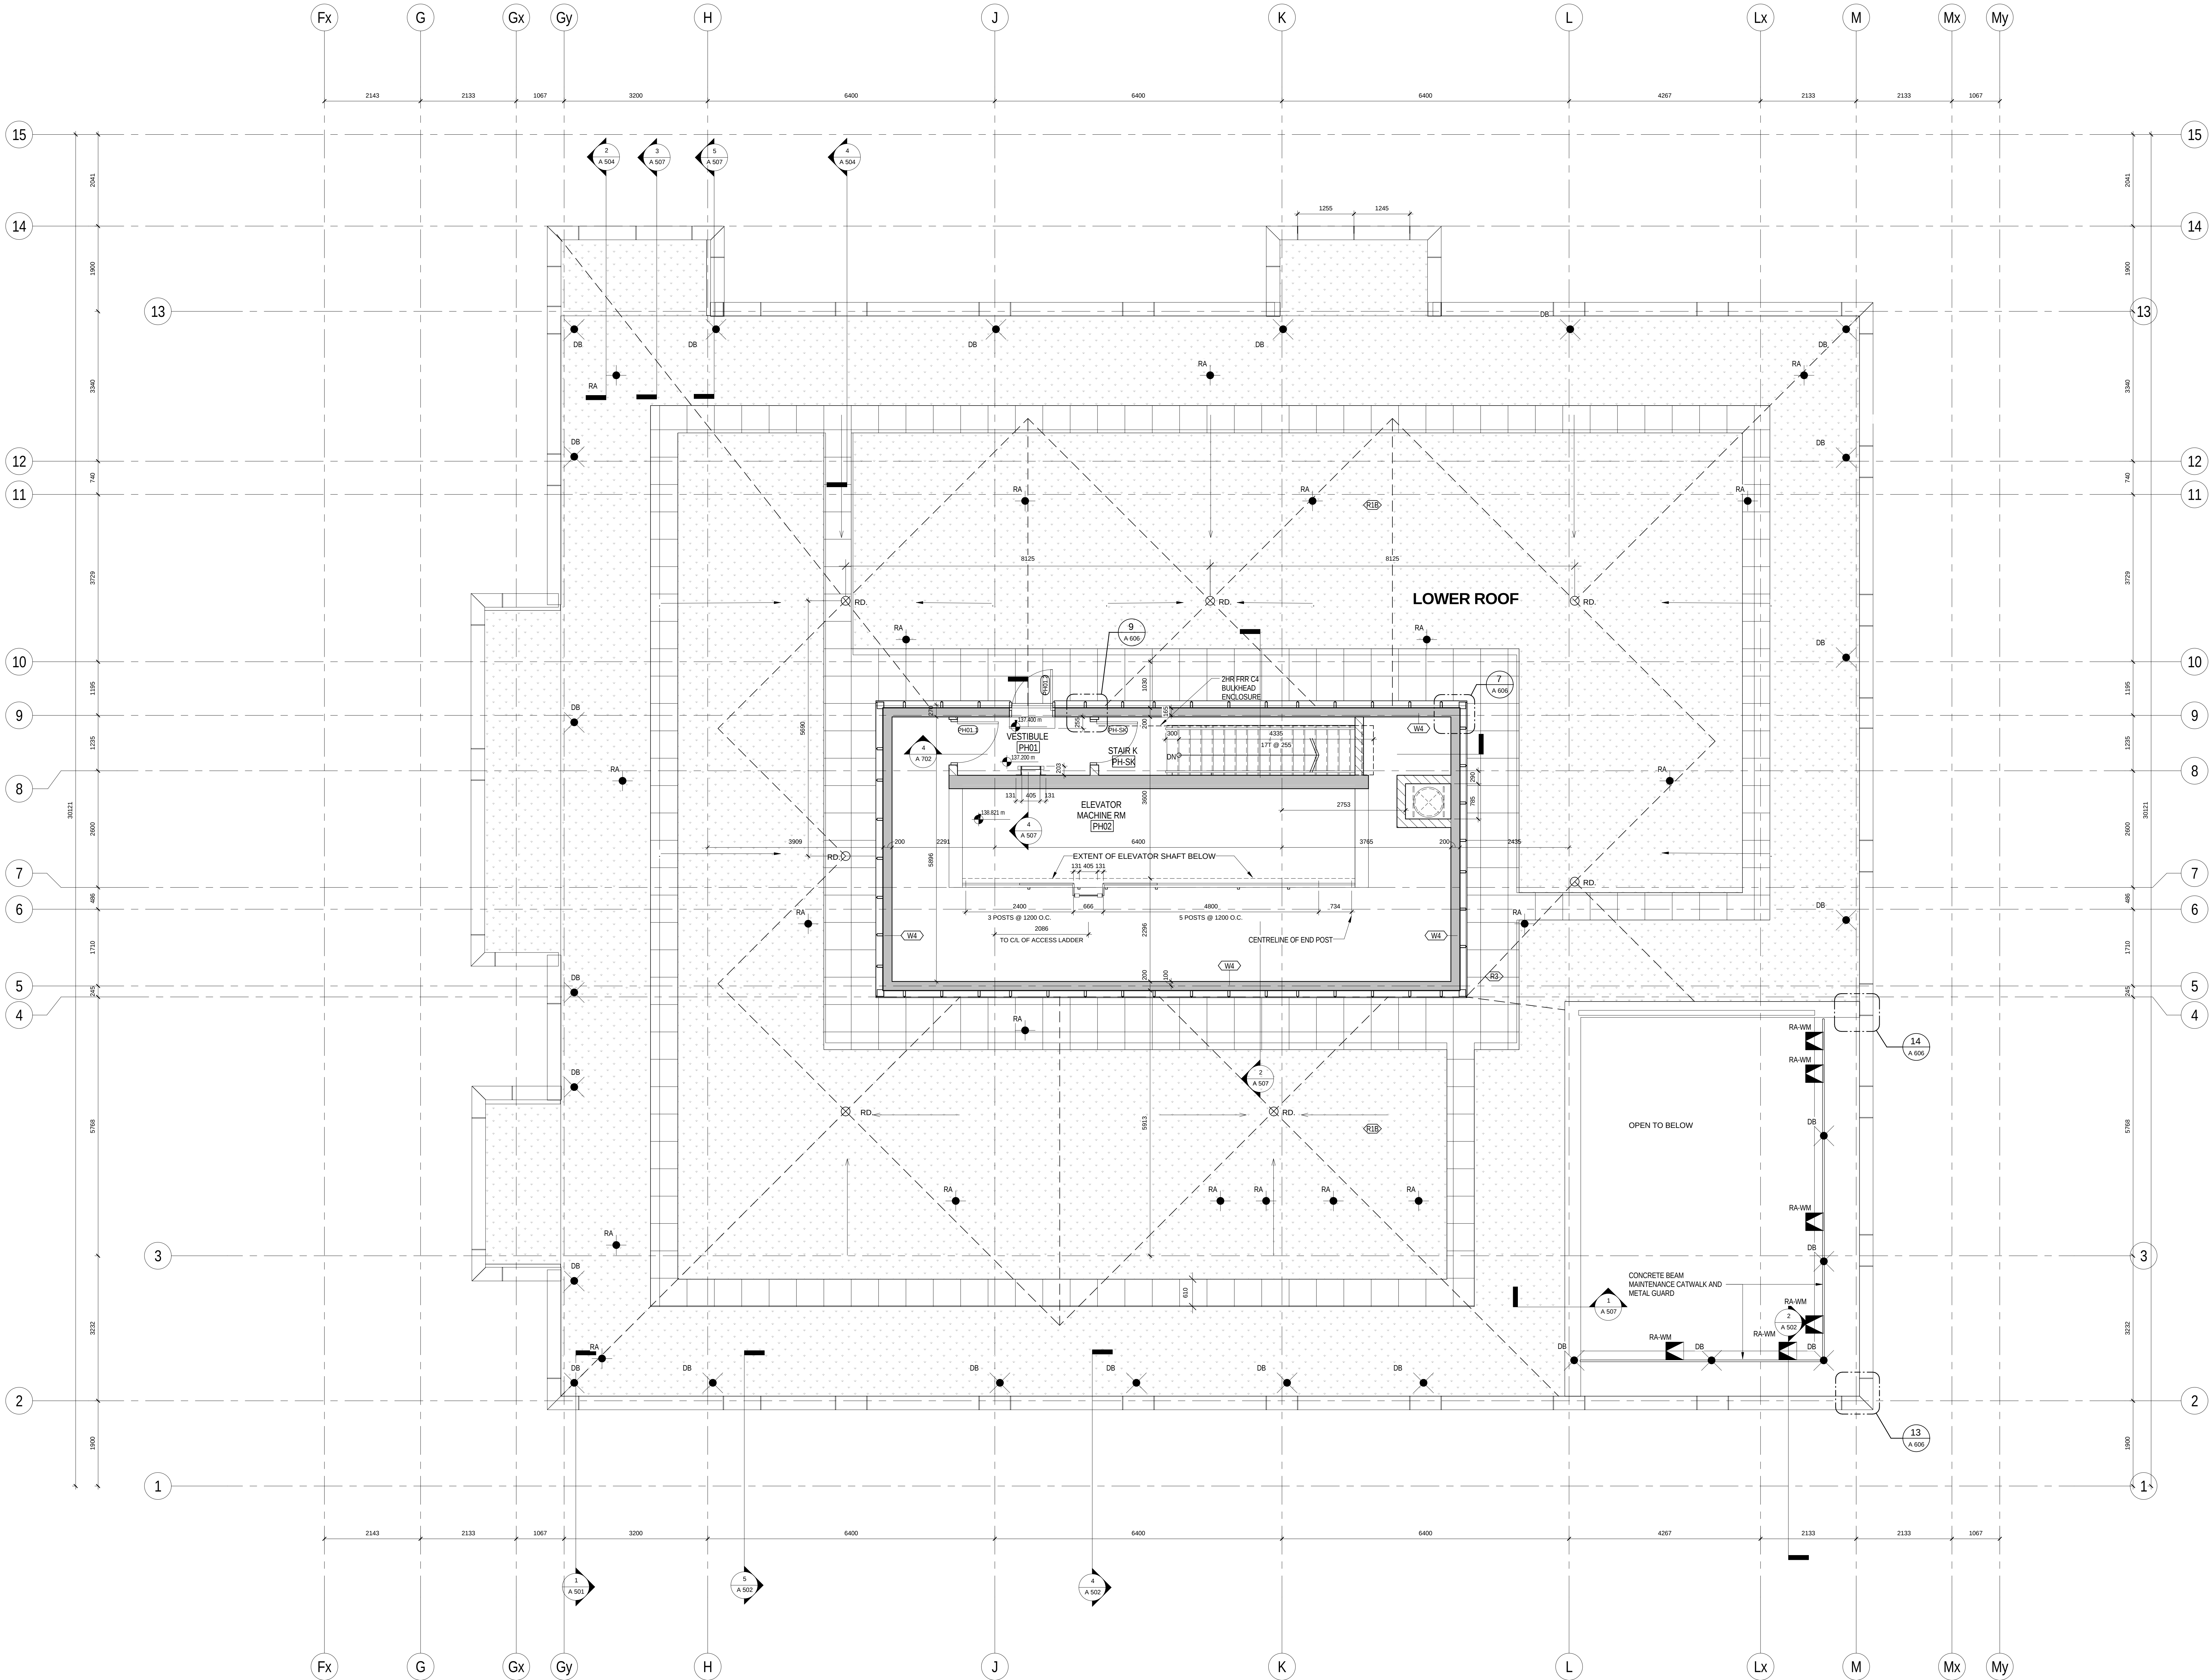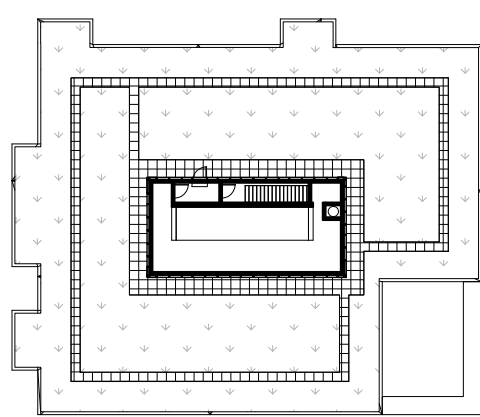

1. All drawings, specifications, schedules and details are subject to change without notice and shall be the responsibility of the client. The client shall be responsible for obtaining all necessary permits and approvals from the relevant authorities. The client shall be responsible for obtaining all necessary permits and approvals from the relevant authorities. The client shall be responsible for obtaining all necessary permits and approvals from the relevant authorities.

SQ
SPADINA QUEEN
TRIDEL

METRIC SCALE DRAWING
FIRST FLOOR ELEV. +93.60m

NO.	ISSUED/REVISED FOR	DATE
1	Issued for SPA	2013-03-26
2	Issued for Construction	2013-04-11
3	Issued for Construction	2013-04-17
4	Revised for SPA	2014-01-10
5	Issued for Construction	2014-03-18
6	Issued for Elevator Tender	2014-04-07
7	Issued for Construction	2014-05-01
8	Issued for 90% Completion	2014-05-12
9	Issued for Permit	2014-05-20
10	Issued for Construction	2014-06-03
11	Revised for Permit	2014-07-01
12	Revised for Permit	2014-08-02
13	Issued for Tender	2014-08-26
14	Issued for Tender	2014-09-21
15	Issued for Tender	2015-05-05
16	Issued for A400	2015-05-17
17	Issued for Drywall Tender	2015-09-18

SQ ALEXANDRA PARK - BLOCK 11
38 CAMERON ST., TORONTO, ONTARIO M5T 2H2

project no: 12-115
scale: As indicated
drawn by: TAU
reviewed by: JH
date: 2014-09-22

Teeple Architects
1000 BAYVIEW AVE. SUITE 1000 SCARBOROUGH, ONTARIO M1S 5B5
416-291-1111
www.teeplearchitects.com

LOWER ROOF PLAN

1
A 226
1:50
LOWER ROOF PLAN - PENTHOUSE

A 226