


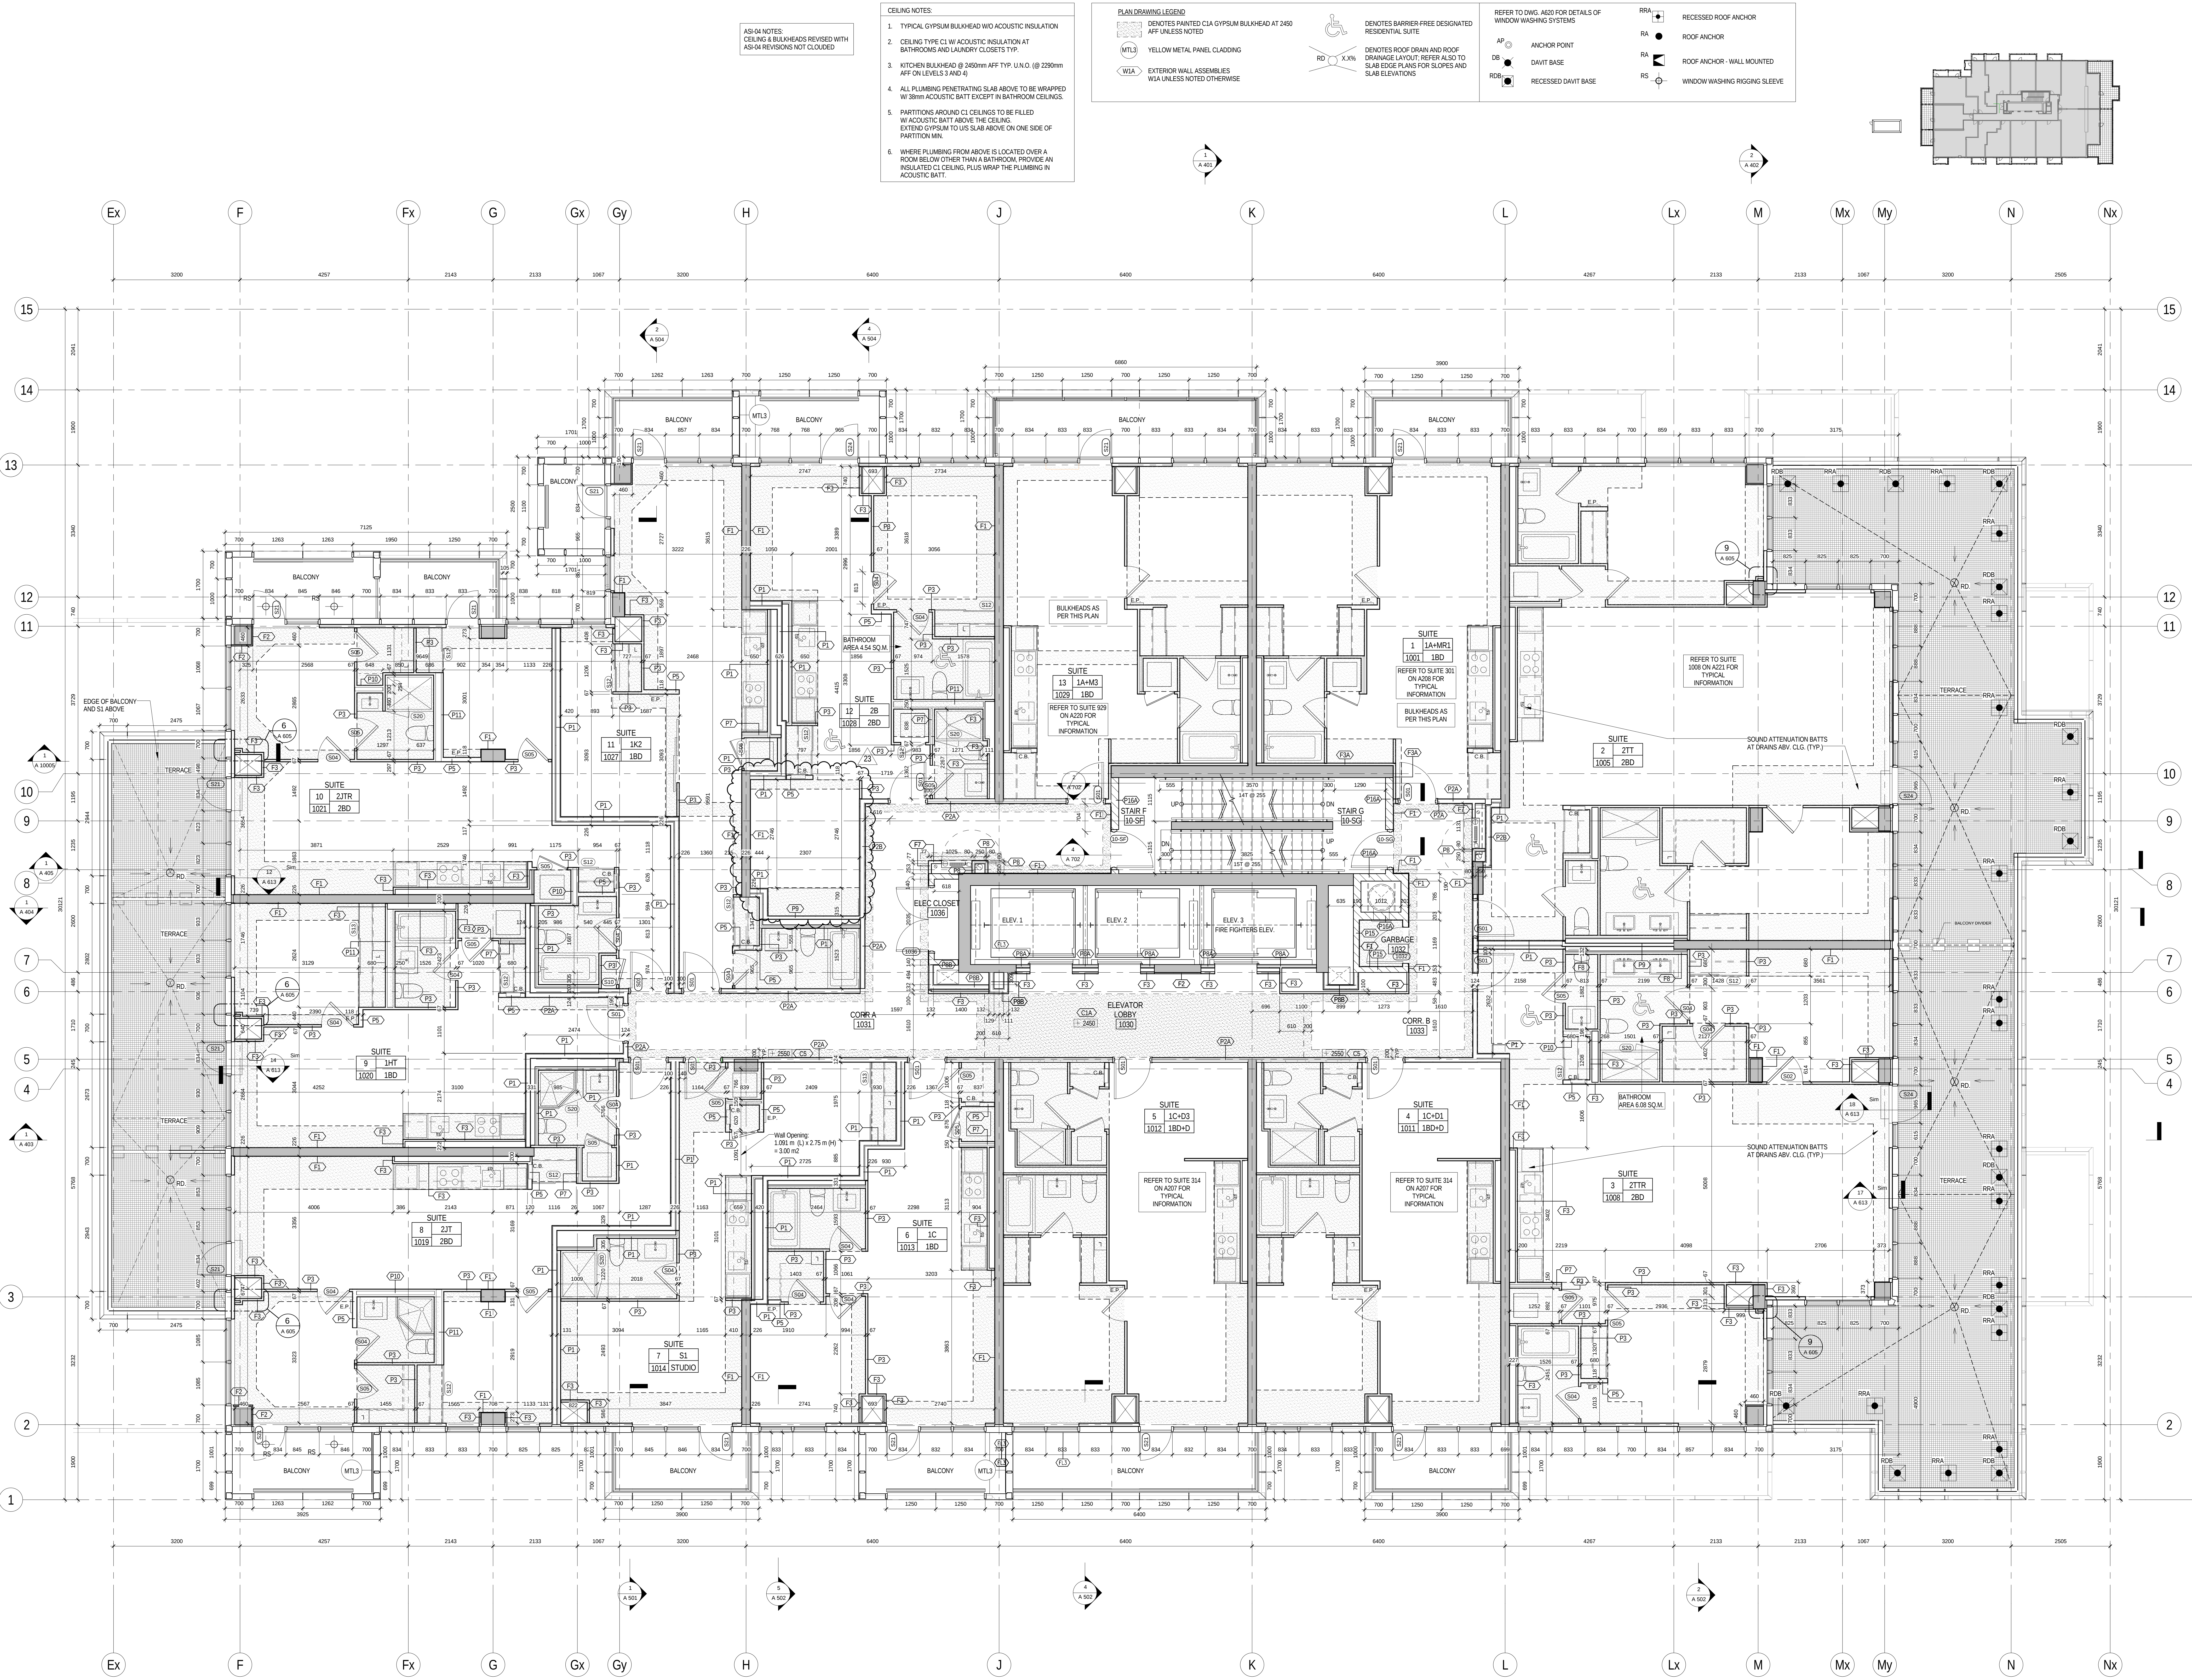

ASH-04 NOTES:
CEILING & BULKHEADS REVISED WITH
ASH-04 REVISIONS NOT CLOUDED

- CEILING NOTES:
1. TYPICAL GYPSUM BULKHEAD W/O ACUSTIC INSULATION
 2. CEILING TYPE C1 W/ ACUSTIC INSULATION AT BATHROOMS AND LAUNDRY CLOSETS TYP.
 3. KITCHEN BULKHEAD @ 2400mm AFF TYP. U.N.O. (@ 2300mm AFF ON LEVELS 3 AND 4)
 4. ALL PLUMBING PENETRATING SLAB ABOVE TO BE WRAPPED W/ 38mm ACUSTIC BATT EXCEPT IN BATHROOM CEILINGS.
 5. PARTITIONS AROUND C1 CEILINGS TO BE FILLED W/ ACUSTIC BATT ABOVE THE CEILING. EXTEND GYPSUM TO US SLAB ABOVE ON ONE SIDE OF PARTITION MIN.
 6. WHERE PLUMBING FROM ABOVE IS LOCATED OVER A ROOM BELOW OTHER THAN A BATHROOM, PROVIDE 2H INSULATED C1 CEILING, PLUS WRAP THE PLUMBING IN ACUSTIC BATT.

- PLAN DRAWING LEGEND:
- AP ANCHOR POINT
 - DB DAVIT BASE
 - RDB RECESSED DAVIT BASE
 - MTL3 YELLOW METAL PANEL CLADDING
 - W1A EXTERIOR WALL ASSEMBLIES W/VA UNLESS NOTED OTHERWISE

- CEILING NOTES:
- RD DENOTES ROOF DRAIN AND ROOF DRAINAGE LAYOUT. REFER ALSO TO SLAB EDGE ELEVATIONS FOR SLOPES AND SLAB ELEVATIONS
 - RD DENOTES BARRIER-FREE DESIGNATED RESIDENTIAL SUITE

- REFER TO DWG. A-201 FOR DETAILS OF WINDOW WASHING SYSTEMS
- AP ANCHOR POINT
 - DB DAVIT BASE
 - RDB RECESSED DAVIT BASE
 - RA RECESSED ROOF ANCHOR
 - RA ROOF ANCHOR
 - RA ROOF ANCHOR - WALL MOUNTED
 - RS WINDOW WASHING RIGGING SLEEVE

SQ
SPADINA QUEEN
TRIDEL

METRIC SCALE DRAWING
FIRST FLOOR ELEV. +93.60m

NO.	ISSUED / REVISED FOR	DATE
1	Issued for SPA	2013-03-26
2	Issued for SPA	2013-04-11
3	Issued for SPA	2013-04-17
4	Issued for SPA	2013-04-17
5	Issued for SPA	2013-04-17
6	Issued for SPA	2013-04-17
7	Issued for SPA	2013-04-17
8	Issued for SPA	2013-04-17
9	Issued for SPA	2013-04-17
10	Issued for SPA	2013-04-17
11	Issued for SPA	2013-04-17
12	Issued for SPA	2013-04-17
13	Issued for SPA	2013-04-17
14	Issued for SPA	2013-04-17
15	Issued for SPA	2013-04-17
16	Issued for SPA	2013-04-17
17	Issued for SPA	2013-04-17
18	Issued for SPA	2013-04-17
19	Issued for SPA	2013-04-17
20	Issued for SPA	2013-04-17
21	Issued for SPA	2013-04-17
22	Issued for SPA	2013-04-17
23	Issued for SPA	2013-04-17

project no: 12-115
scale: AS INDICATED
drawn by: TAU
reviewed by: TAU
date: 2014-09-22

Teeple Architects

12-115
AS INDICATED
TAU
2014-09-22

SQ ALEXANDRA PARK - BLOCK 11
38 CAMERON ST. TORONTO, ONTARIO M5T 2H2

LEVEL 10 PLAN
1:50

A 221