

AS144 NOTES:
1. TYPICAL GYPSUM BULKHEAD W/O ACOUSTIC INSULATION AT CEILING & BULKHEADS REVISED WITH AS144 REVISIONS NOT CLOUSED

- CEILING NOTES:
1. TYPICAL GYPSUM BULKHEAD W/O ACOUSTIC INSULATION
 2. CEILING TYPE C1 W/ ACOUSTIC INSULATION AT BATHROOMS AND LAUNDRY CLOSETS TYP.
 3. KITCHEN BULKHEAD @ 2450mm AFF TYP. U.N.O.
 4. ALL PLUMBING PENETRATING SLAB ABOVE TO BE WRAPPED W/ 38mm ACOUSTIC BATT EXCEPT IN BATHROOM CEILINGS
 5. PARTITIONS AROUND C1 CEILINGS TO BE FILLED W/ ACOUSTIC BATT ABOVE THE CEILING. EXTEND GYPSUM TO US SLAB ABOVE ON ONE SIDE OF PARTITION MIN.
 6. WHERE PLUMBING FROM ABOVE IS LOCATED OVER A ROOM BELOW OTHER THAN A BATHROOM, PROVIDE AN INSULATED C1 CEILING, PLUS WRAP THE PLUMBING IN ACOUSTIC BATT.
 7. SUITES PH05 & PH11 RECEIVE CEILING C3 THROUGHOUT
 8. SUITES PH13, PH13, PH13, PH13 RECEIVE GYPSUM CEILING C1 THROUGHOUT @ 2750. DUCTS ARE IN THE CEILING SPACE. BATHROOMS RECEIVE CEILING C1 @ 2450

PLAN DRAWING LEGEND

MTL3 DENOTES PAINTED CIA GYPSUM BULKHEAD AT 2700 AFF UNLESS NOTED OTHERWISE

MTL3 DENOTES ACOUSTIC GYPSUM CEILING C3 CONTINUOUS ABOVE BULKHEADS & DROPPED CEILINGS. PAINTED FINISH AT EXPOSED LOCATIONS

YELLOW METAL PANEL CLADDING

EXTERIOR WALL ASSEMBLIES W/IA UNLESS NOTED OTHERWISE

RD 1/2 X 1/2 DENOTES BARRIER-FREE DESIGNATED RESIDENTIAL SUITE

RD 1/2 X 1/2 DENOTES ROOF DRAIN AND ROOF DRAINAGE LAYOUT. REFER ALSO TO SLAB EDGE PLANS FOR SLOPES AND SLAB ELEVATIONS

REFER TO DWG. A201 FOR DETAILS OF WINDOW WASHING SYSTEMS

AP ANCHOR POINT

DB DAVIT BASE


RDB RECESSED DAVIT BASE

RRA RECESSED ROOF ANCHOR

RA ROOF ANCHOR


RA ROOF ANCHOR - WALL MOUNTED

RS WINDOW WASHING RIGGING SLEEVE

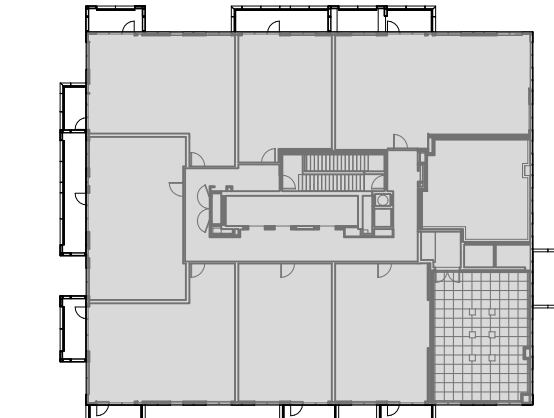

SUITES PH05 AND PH11:
ACOUSTIC CEILING C3 AT +2750 THROUGHOUT SUITE. ROUTE R/W. ACOUSTIC CEILING, DUCTS AND SPRINKLERS IN TYP. BULKHEADS AT +2450 BELOW ACOUSTIC CEILING.

ALL OTHER PH SUITES:
INSULATED CEILING C1 AT +2650 THROUGHOUT SUITE. ROUTE. SPRINKLERS AND DUCTS IN TYP. BULKHEADS AT +2550. INSULATE BULKHEADS-DO NOT EXTEND C1 CEILING ABOVE BULKHEADS.

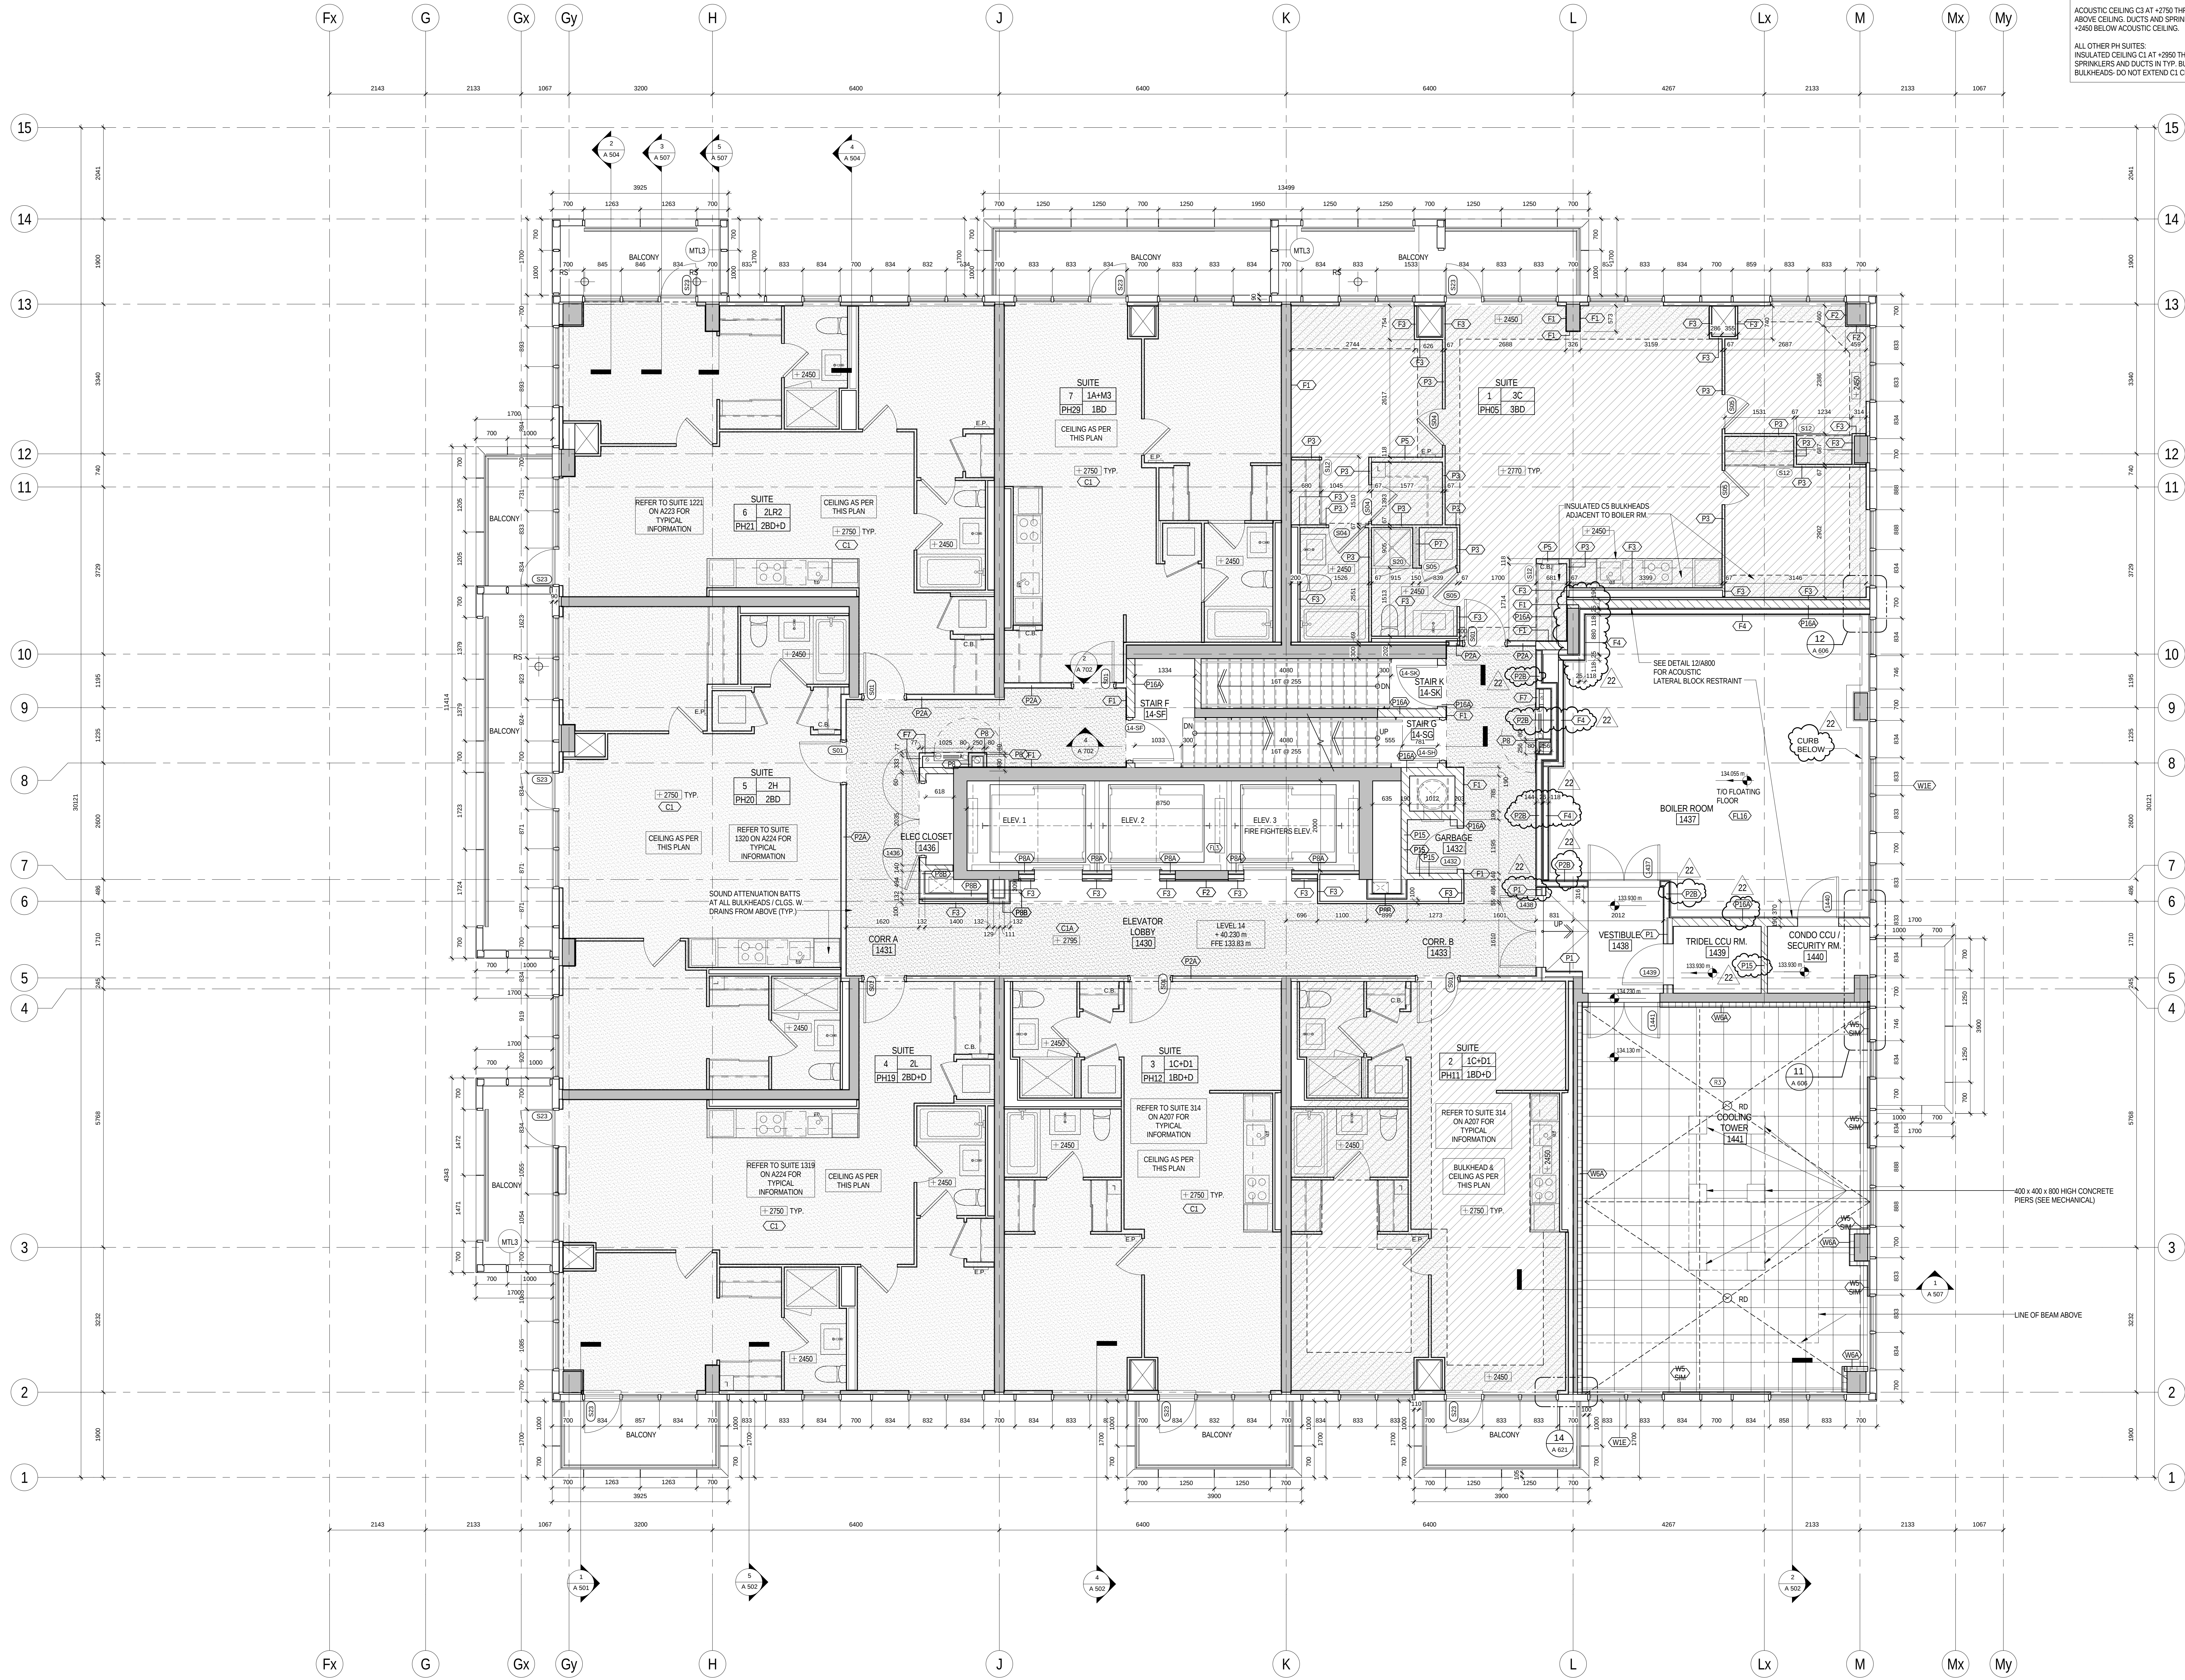

METRIC SCALE DRAWING
FIRST FLOOR ELEV. +93.60m

NO.	ISSUED/REVISED FOR	DATE
1	Issued for SPA	2013-03-26
2	Issued for Construction	2013-04-11
3	Issued for Construction	2013-04-17
4	Revised for SPA	2014-01-02
5	Issued for Construction	2014-03-18
6	Issued for Elevator Tender	2014-04-07
7	Issued for Construction	2014-05-01
8	Issued for 90% Completion	2014-05-23
9	Issued for Permit	2014-05-26
10	Issued for Construction	2014-06-03
11	Revised for Permit	2014-07-02
12	Revised for Permit	2014-08-02
13	Issued for Tender	2014-08-26
14	Issued for Tender	2014-09-02
15	Issued for Flooring Tender	2015-03-10
16	Issued for Tender	2015-03-10
17	Issued for AS104	2015-05-17
18	Issued for Drywall Tender	2015-09-01
19	Issued for Drywall Tender Add #1	2015-09-18
20	Issued for AS10	2015-09-23
21	Issued for AS10	2015-11-10
22	Issued for AS10	2016-02-24

SQ ALEXANDRA PARK - BLOCK 11
38 CAMERON ST. TORONTO, ONTARIO M5T 2H2

project no: 12-115
scale: As indicated
drawn by: TAU
reviewed by: TAU
date: 2014-09-22

Teeple Architects

1/1/2014 11:50 AM

LEVEL 14 PLAN

1/1/2014 11:50 AM

LEVEL 14 PLAN

1/1/2014 11:50 AM

LEVEL 14 PLAN