


DO NOT SCALE DRAWINGS.

CONTRACTOR MUST VERIFY ALL DRAWINGS, DIMENSIONS, DETAILS AND SPECIFICATIONS, AND REPORT ANY DISCREPANCIES TO UNION 31 INC. BEFORE PROCEEDING WITH WORK. MATERIALS MAY NOT BE SUBSTITUTED WITHOUT WRITTEN APPROVAL FROM UNION 31 INC.

ALL DRAWINGS AND SPECIFICATIONS ARE INSTRUMENTS OF SERVICE AND THE PROPERTY OF UNION 31 INC. WHICH MUST BE RETURNED AT THE COMPLETION OF THE WORK.

PRINTED: 15-M-15

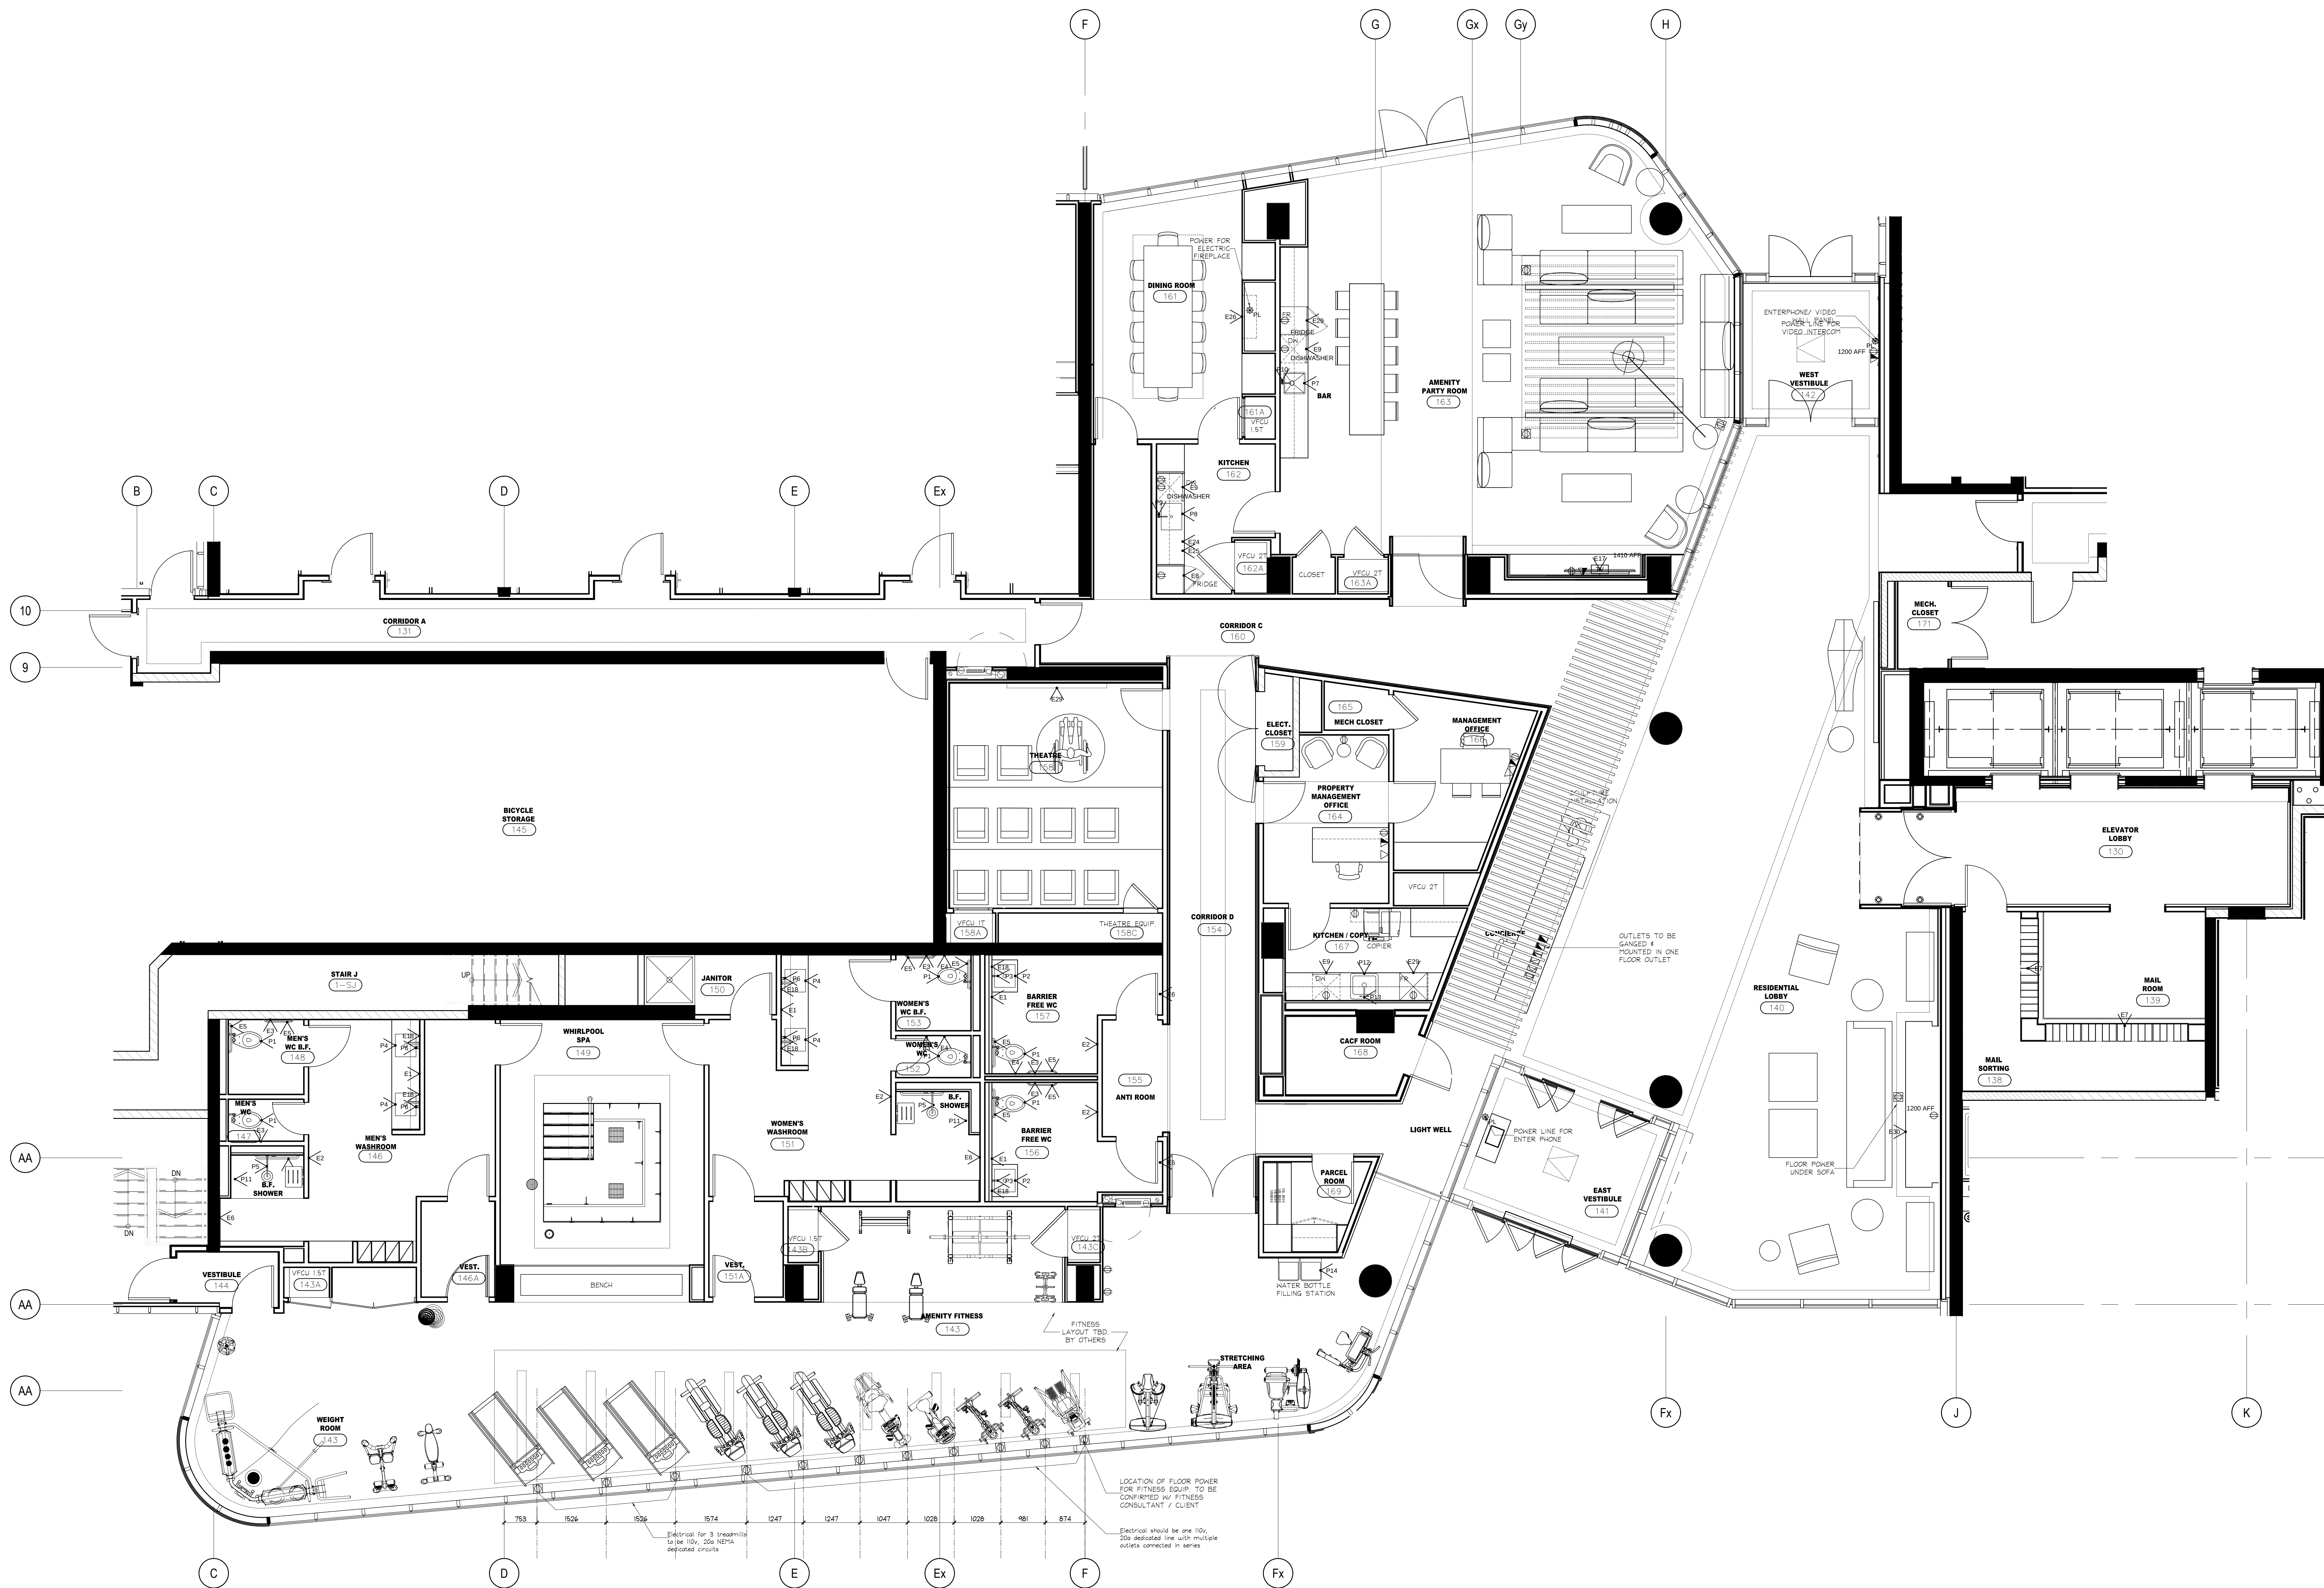

1 FURNITURE & POWER PLAN
ID11.1.2 GROUND FLOOR SCALE: 1:50

10	15 JULY 15	ISSUED FOR TRIM CARPENTRY TENDER	CB
09	16 JUNE 15	ISSUED FOR FINISH CARPENTRY	CB
08	11 JUNE 15	SITE INSTRUCTION #1	CB
03	06 MAR 15	ISSUED FOR TILE TENDER	AP
02	26 JAN 15	ISSUED FOR TENDER	AP
01	22 AUG 14	ISSUED FOR PERMIT	AP
NO	DATE	COMMENTS	INI

UNION31

UNION31 INC.
183 BATHURST STREET, STE. 201
TORONTO, ON, M5T 2R7, CANADA
TEL: 416-597-1576 FAX: 416-597-2139

PROJECT NAME: ALEXANDRA PARK MAIN BUILDING BLOCK 11 ON, Canada	
PROJECT NO.: 13-949	
DRAWINGS: GROUND FLOOR FURNITURE & POWER PLAN	
DATE STARTED: 07 AUG / 13	DRAWING NO.: ID
SCALE: 1 : 50	1.1.2
DRAWN BY: AP	
APPROVED BY: KC	