


DO NOT SCALE DRAWINGS.


CONTRACTOR MUST VERIFY ALL DRAWINGS, DIMENSIONS, DETAILS AND SPECIFICATIONS. AND REPORT ANY DISCREPANCIES TO UNION 31 INC. BEFORE PROCEEDING WITH WORK. MATERIALS MAY NOT BE SUBSTITUTED WITHOUT WRITTEN APPROVAL FROM UNION 31 INC.

ALL DRAWINGS AND SPECIFICATIONS ARE INSTRUMENTS OF SERVICE AND THE PROPERTY OF UNION 31 INC. WHICH MUST BE RETURNED AT THE COMPLETION OF THE WORK.


PRINTED: 15-M-15

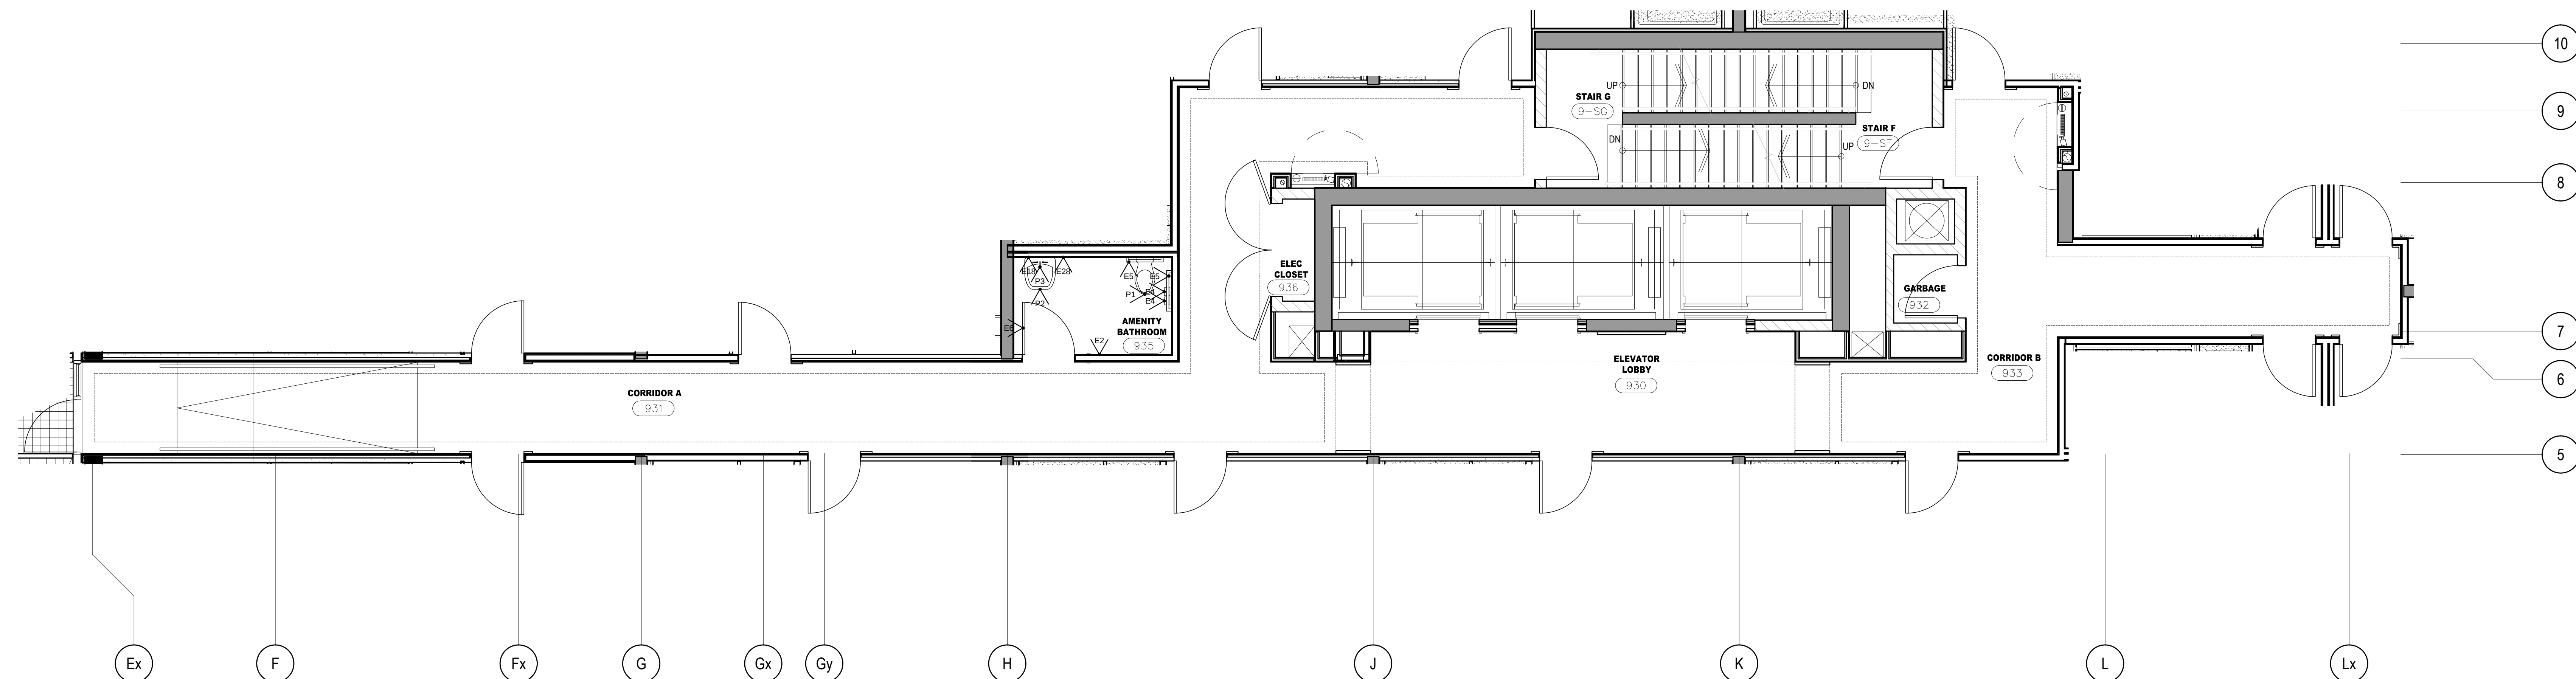

1 FURNITURE & POWER PLAN
ID1.9.1 9TH FLOOR SCALE 1:50

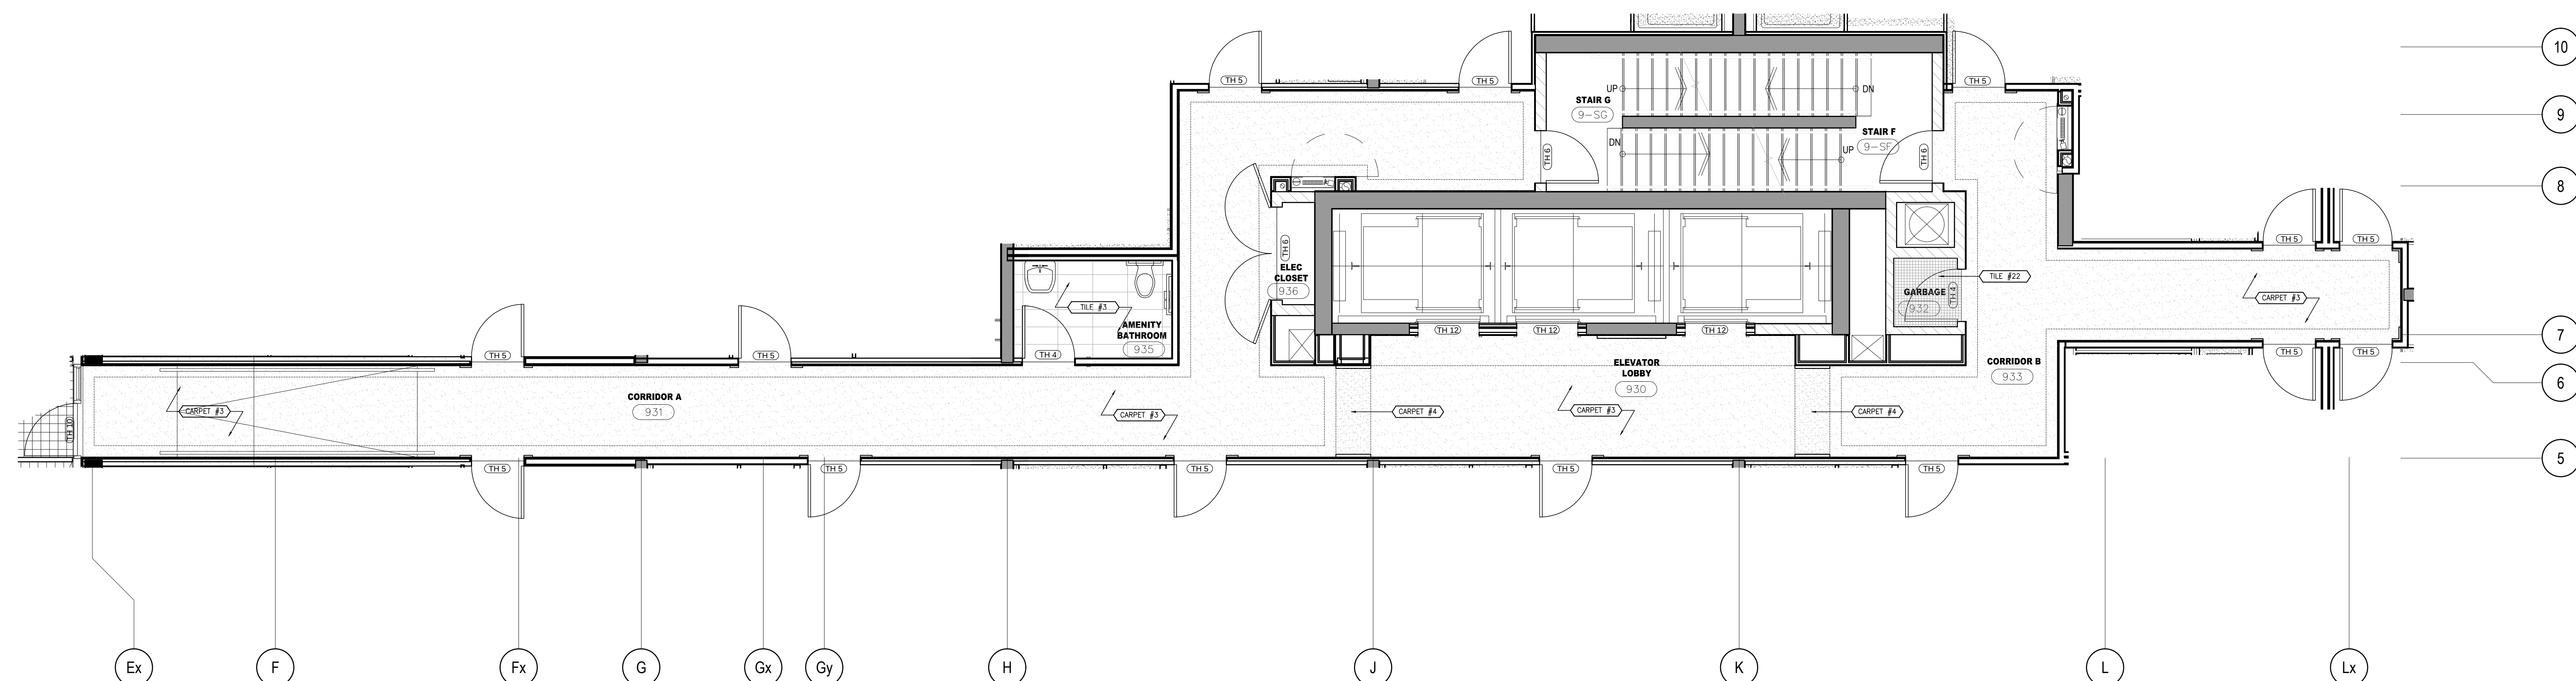

2 FLOOR FINISHES PLAN
ID1.9.1 9TH FLOOR SCALE 1:50

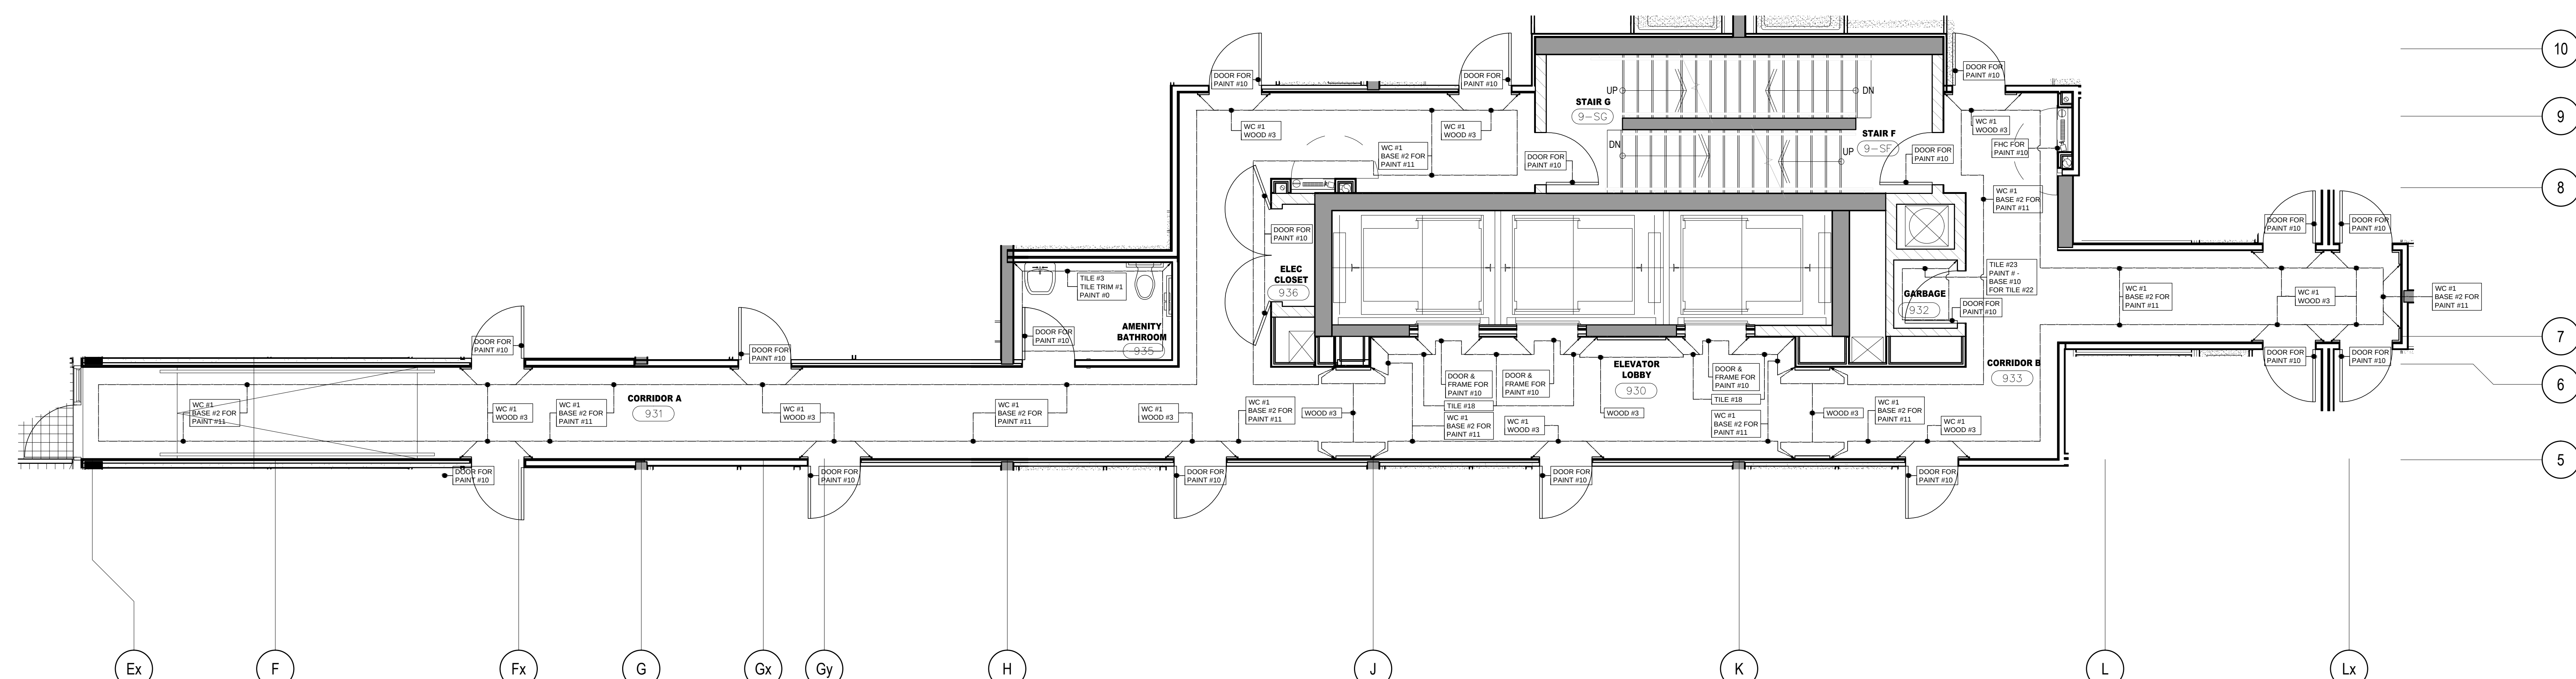

3 WALL FINISHES PLAN
ID1.9.1 9TH FLOOR SCALE 1:50

10	15 JULY 15	ISSUED FOR TRIM CARPENTRY TENDER	CB
09	16 JUNE 15	ISSUED FOR FINISH CARPENTRY	CB
03	06 MAR 15	ISSUED FOR TILE TENDER	AP
02	26 JAN 15	ISSUED FOR TENDER	AP
01	22 AUG 14	ISSUED FOR PERMIT	AP
NO	DATE	COMMENTS	INI

REVISIONS:

UNION 31

UNION31 INC.
183 BATHURST STREET, STE. 201
TORONTO, ON, M5T 2R7, CANADA
TEL: 416-597-1576 FAX: 416-597-2139

PROJECT NAME:		ALEXANDRA PARK MAIN BUILDING	
PROJECT NO.:		13-949	
DRAWING NO.:		9TH FLOOR FURNITURE & POWER PLAN FLOOR FINISHES PLAN & WALL FINISHES PLAN	
DATE STARTED:		07 AUG / 13	
SCALE:		1" = 50'	
DRAWN BY:		AP	
APPROVED BY:		KC	
DRAWING NO.:		ID	
SCALE:		1" = 50'	
DRAWN BY:		AP	
APPROVED BY:		KC	