

DO NOT SCALE DRAWINGS.

CONTRACTOR MUST VERIFY ALL DIMENSIONS, DIMENSIONS AND SPACING TYPES. DIMENSIONS SHOWN MAY VARY FROM DIMENSIONS TO BE CONSTRUCTED. DIMENSIONS WITH WORK. MATERIALS MAY NOT BE SUBSTITUTED WITHOUT THE WRITTEN APPROVAL OF THE ARCHITECT. ALL DIMENSIONS AND SPACING TYPES ARE INDICATED IN THIS DRAWING AND THE PROPERTY OF AIAA 37 INC. WHICH MUST BE RETURNED AT THE COMPLETION OF THE WORK.

PRINTED: 25-Aug-19


01	24 AUG 18	RE ISSUED FOR PERMITAL TENDER	02
02	24 AUG 18	ISSUED FOR PERMITAL TENDER	03
03	24 AUG 18	ISSUED FOR PERMITAL TENDER	04
04	24 AUG 18	ISSUED FOR PERMITAL TENDER	05
99	24 AUG 18	ISSUED FOR PERMITAL TENDER	100

UNION31
183 BATHURST STREET, STE 201
TORONTO ON M5T 2B7 CANADA
TEL: 416-597-1576 FAX: 416-597-2139

ALEXANDRA PARK
MAIN BUILDING
BLOCK 11
PROJECT NO.: 13-849
ON, Canada

GROUND FLOOR
FURNITURE & POWER PLAN

DATE STARTED: 07 AUG 13
SCALE: 1:50
DRAWN BY: AP
APPROVED BY: KC
DRAWING NO.: ID
1.1.2

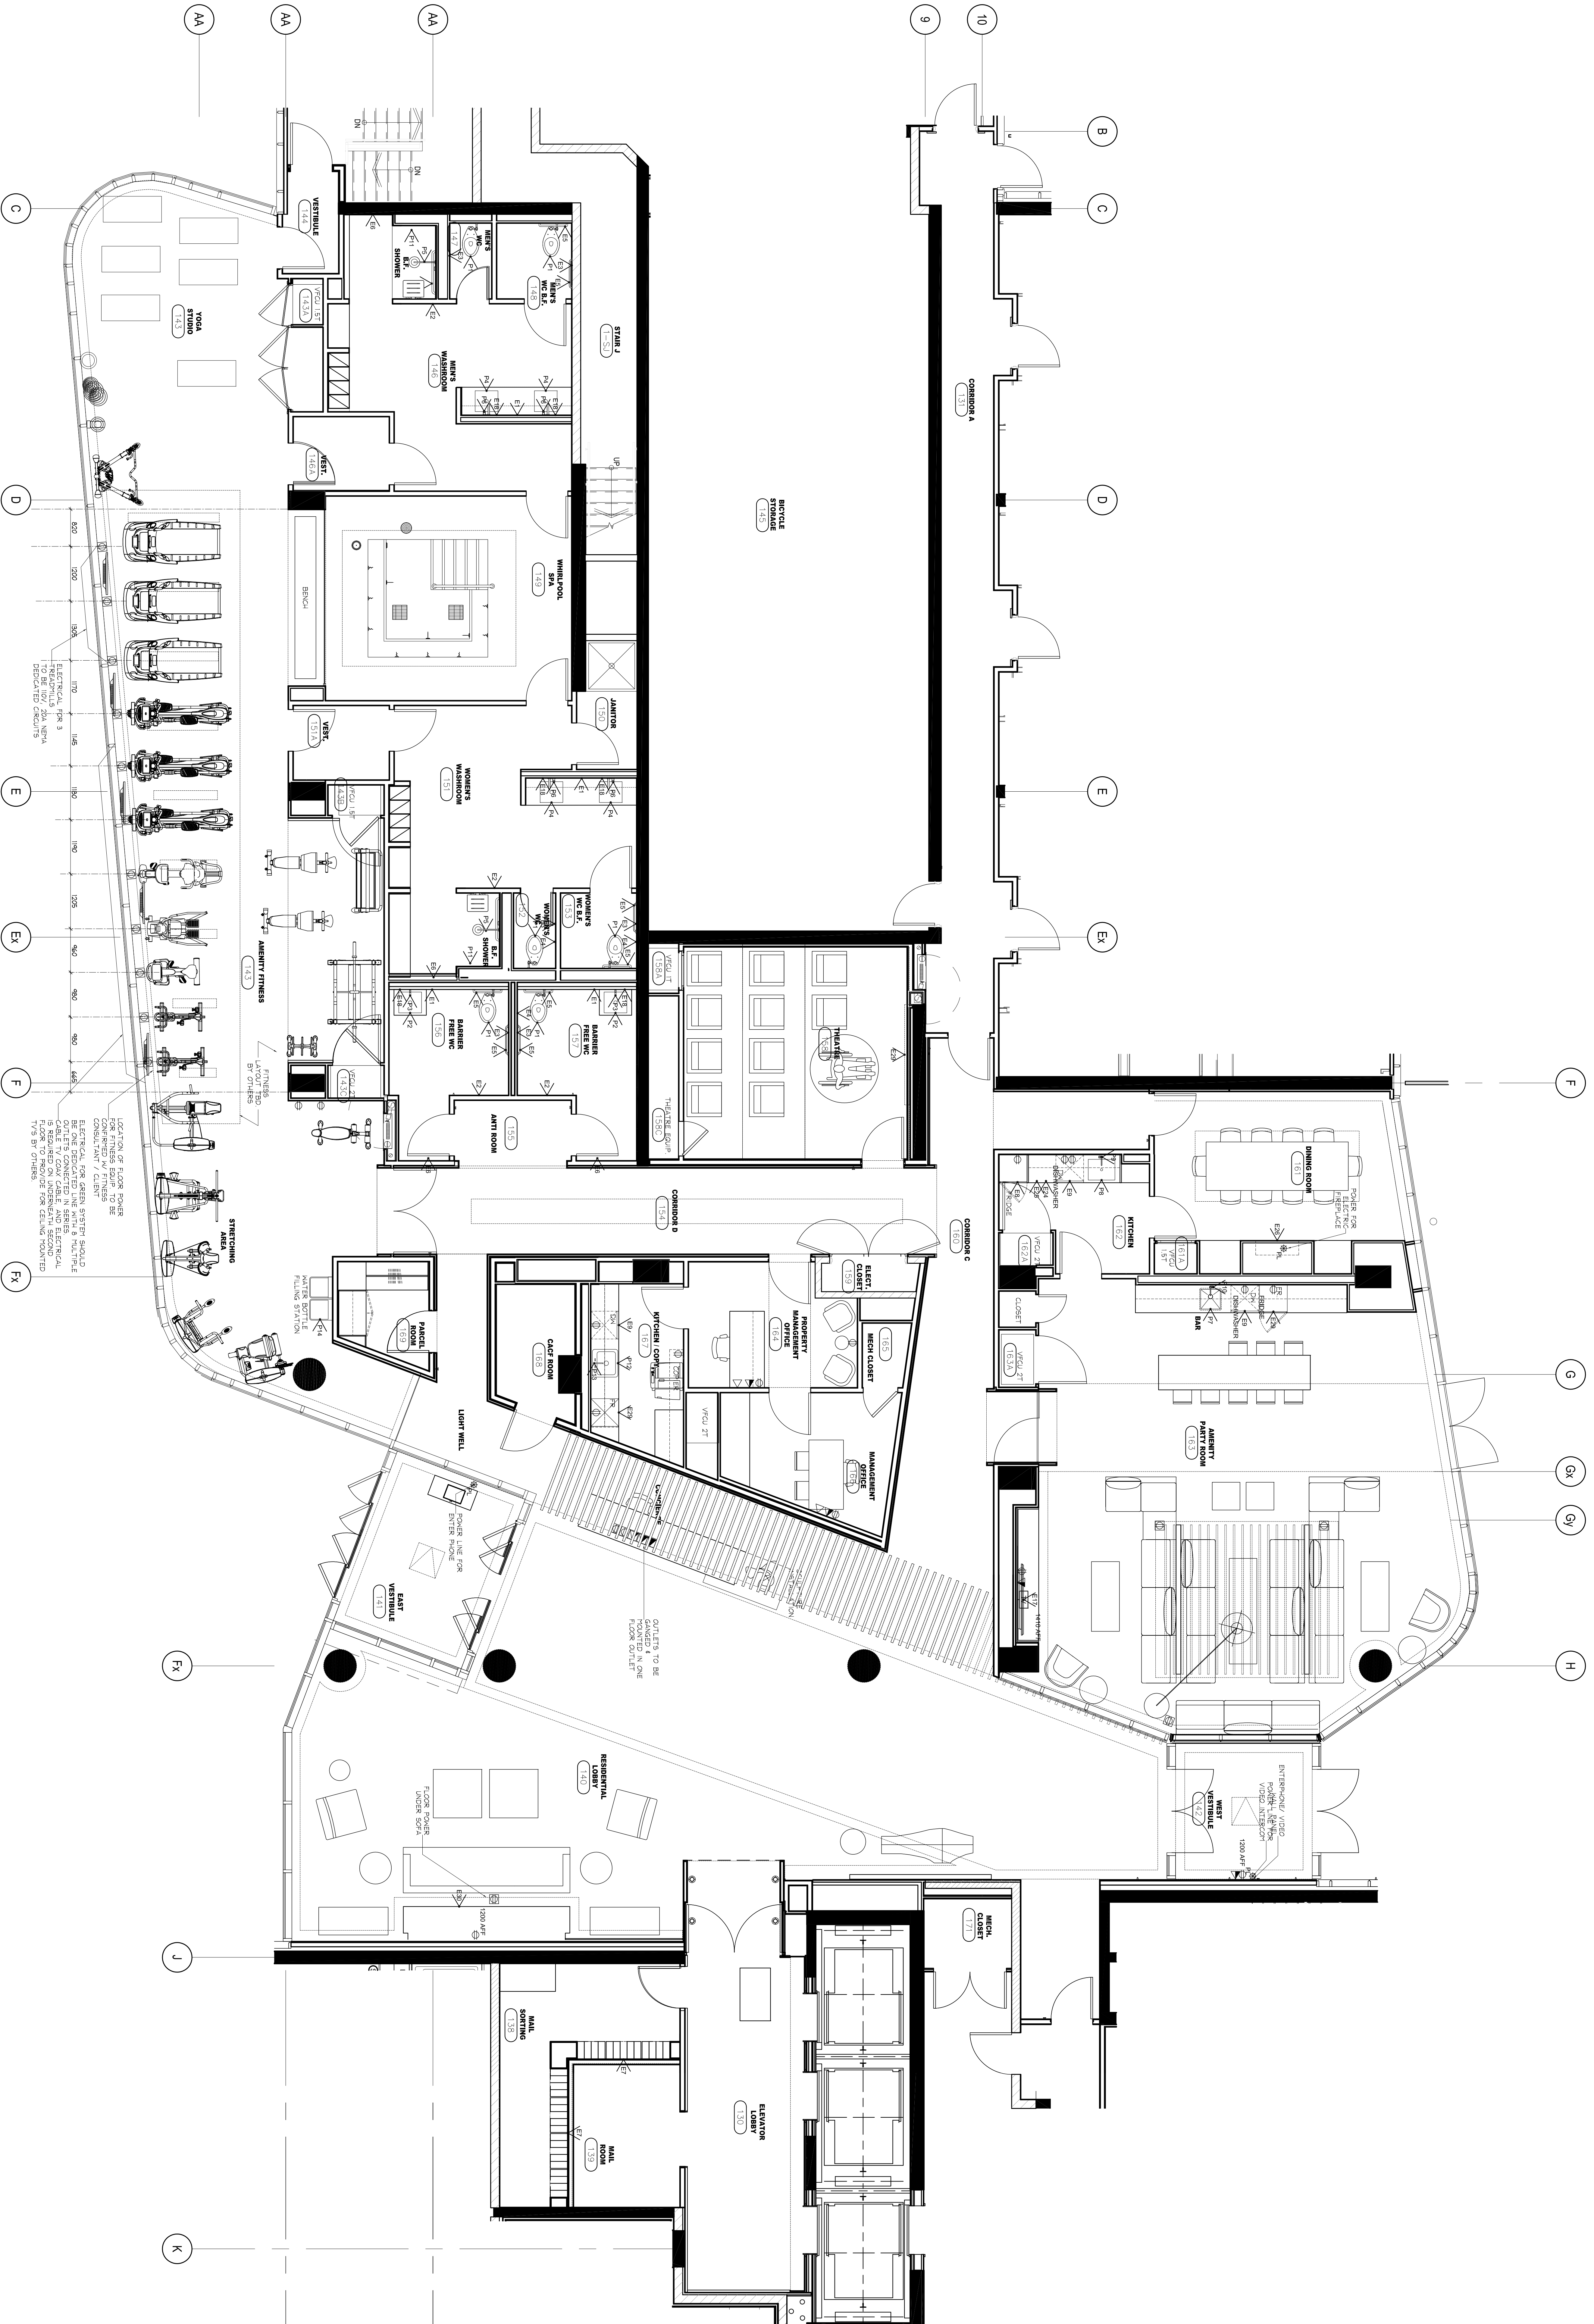

1 FURNITURE & POWER PLAN
BLOCK 11
SCALE: 1:50