


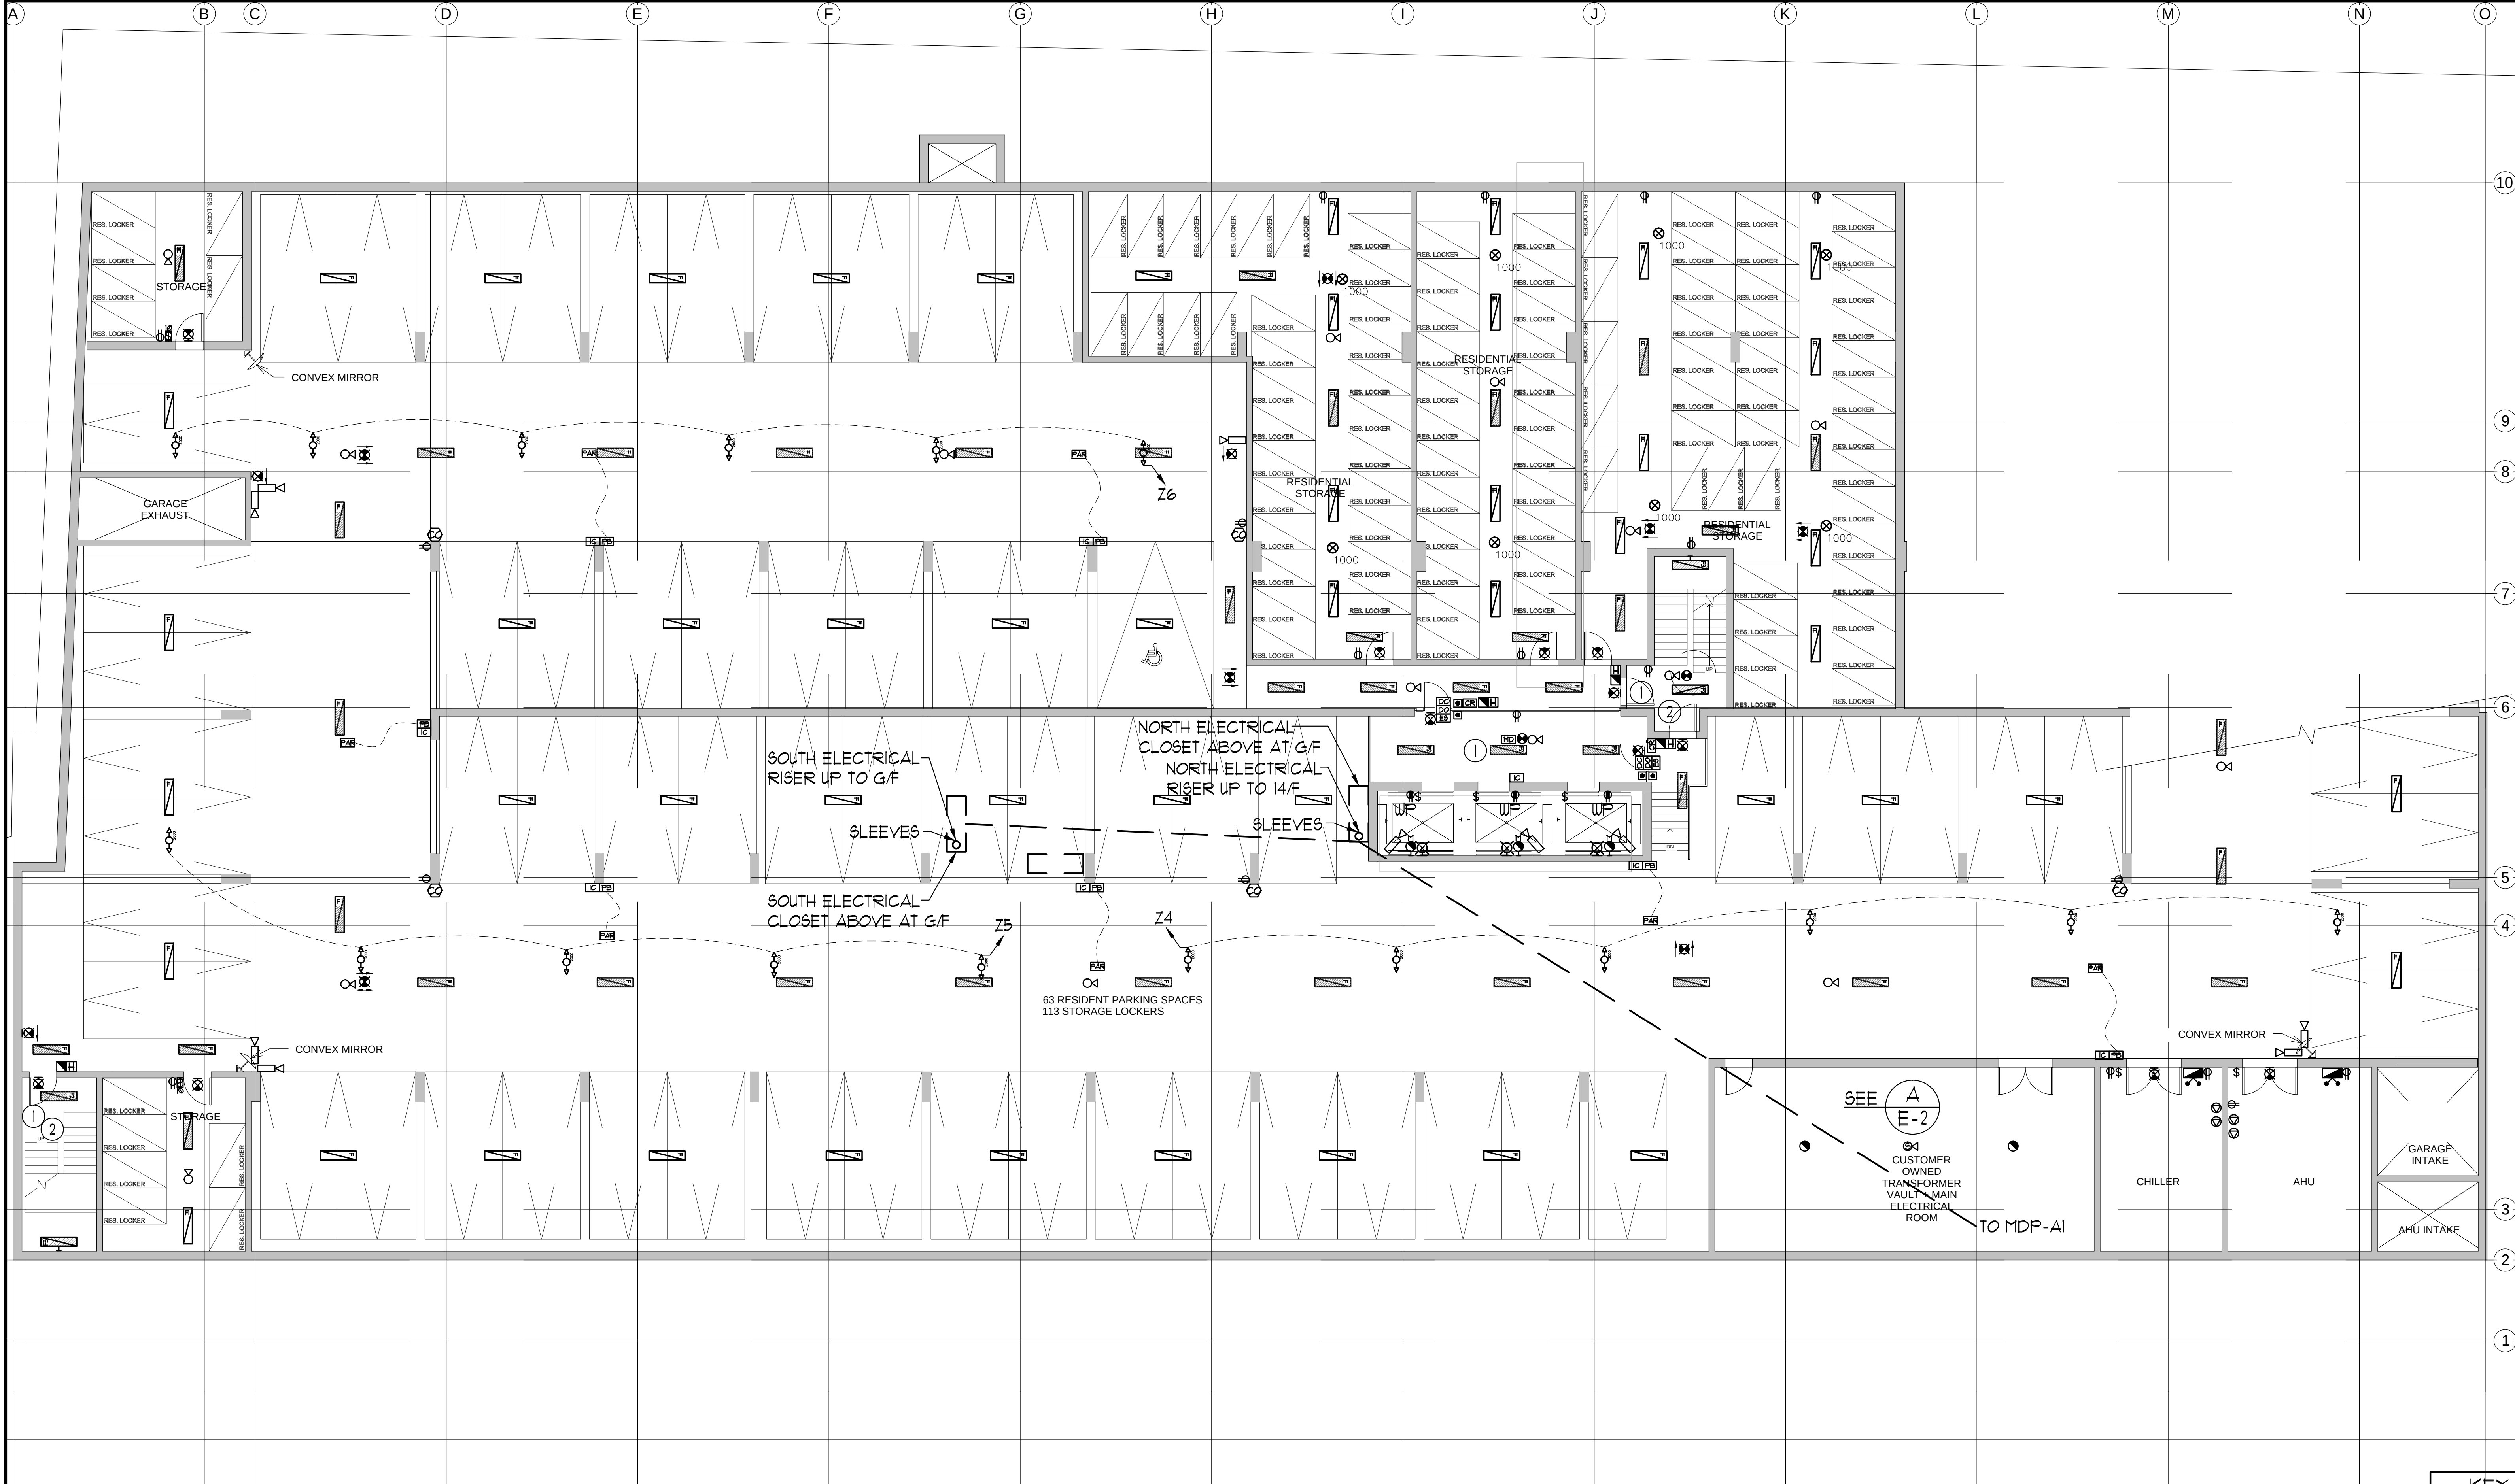


GENERAL AREA CIRCUITING - TABLE #1			
LIGHTING FIXTURE LOCATION	CCT #	RECEPTACLE LOCATION	CCT #
P4 TO P1 - EXIT SIGNS	EX-XX	LOBBY (P4 TO P1)	EX-XX
G/F TO 10/F - EXIT SIGNS	EX-XX	STAIR "A" (5/F, 7/F)	EX-XX
11/F TO ROOF - EXIT SIGNS	EX-XX	STAIR "B" (23, 26, 30, 21, 24) FLOORS	EX-XX
LOBBY (P4 TO P1)	EX-XX	STAIR "B" (10, 9, 6, 3, P1, P4) FLOORS	EX-XX
STAIR "A" (P4 TO G/F)	EX-XX	STAIR "C" (10, 9, 6, 3, 21, 24) FLOORS	EX-XX
CORRIDOR	EX-XX	STAIR "C" (10, 9, 6, 3, 26, 3) FLOORS	EX-XX
-	EX-XX	STAIR "D" (P1, P4) FLOORS	EX-XX
-	EX-XX	STAIR "E" (P1) FLOOR	EX-XX
-	EX-XX	CORRIDOR	EX-XX

- GENERAL NOTES - PARKING:
- ELECTRICAL DRAWINGS SHALL BE READ IN CONJUNCTION WITH MECHANICAL, STRUCTURAL, ARCHITECTURAL AND LANDSCAPE DRAWINGS.
 - CONTRACTOR SHALL RUN CABLES WITHIN CEILING SLAB OR ENCLOSURES TO RETAIN 2 HOUR FIRE PROTECTION RATING FOR ALL LOADS THAT CONNECT TO EMERGENCY POWER.
 - FIRE ALARM RISERS SHALL BE RUN IN 2 HOUR FIRE RATED ELECTRICAL CLOSET. REFER TO DWG. E-32 FOR RISER DIAGRAM AND DETAILS.
 - STAIRWAY WALL MOUNTED EMERGENCY LIGHT FIXTURES SHALL BE MOUNTED @ 1' AFF.
 - EMERGENCY LIGHT FIXTURES IN LOCKERS, STORAGE, UTILITY AND SERVICE ROOMS SHALL BE CONNECTED TO BOTH NORMAL AND EMERGENCY POWER AS PER DETAIL #28 OF DWG. E-35.
 - FOR STORAGE ROOM VENTILATION SYSTEM, DIV. 16 TO PROVIDE CONDUIT, WIRING AND SWITCH(S) TO START/STOP FAN AND DAMPER. FAN AND 120V ACTUATOR TO BE SUPPLIED AND INSTALLED BY DIV. 15.
 - FOR UTILITY ROOM VENTILATION SYSTEM, DIV. 15 WILL PROVIDE LINE VOLTAGE THERMOSTAT (T) TO DIV. 16. DIV. 16 TO PROVIDE CONDUIT AND WIRING TO START/STOP FAN AND DAMPER VIA THERMOSTAT. FAN AND 120V ACTUATOR TO BE SUPPLIED AND INSTALLED BY DIV. 15.
 - FOR UNIT HEATER, DIV. 15 TO PROVIDE LINE VOLTAGE THERMOSTAT (T), DIV. 16 TO PROVIDE CONDUIT AND WIRING TO START/STOP UNIT HEATER.
 - F.H.C. IN UNHEATED AREAS ARE TO BE HEAT TRACED BY DIV. 16. CONNECT TO GFI CIRCUIT AS SHOWN.
 - SANITARY PIPE AS NOTED, ALL STANDPIPE, ALL WET SPRINKLER AND DOMESTIC WATER PIPE RUN IN UNHEATED AREA SHALL BE HEAT TRACED BY DIV. 16.
 - CONTROL PANEL FOR SANITARY PUMP AND STORM PUMP BY DIV. 15. POWER CONNECTION UP TO CONTROL PANELS SHALL BE INSTALLED BY DIV. 16. CONTRACTOR THIS CONTRACTOR SHALL SUPPLY UNDER SLAB CONDUITS FOR POWER AND CONTROL WIRING FROM CONTROL PANELS TO SANITARY/PUMP PIT.
 - INSTALL 3/4" CONDUIT C/W FULL STRING FROM SANITARY AND STORM PUMP CONTROL PANEL TO CONCIERGE DESK AND CACG FOR HIGH WATER ALARM SYSTEM.
 - ALLOCATE 2, 120V, 15A CCTS FROM PANEL 'X' FOR MECHANICAL CONTROL. CONTRACTOR COORDINATE WITH DIV. 15 FOR EXACT LOCATION. REFER TO PANEL SCHEDULE FOR CCT# X-XX, X-XX.
 - ULTRASONIC CEILING MOUNTED SENSORS SHOULD BE LOCATED AT A MINIMUM OF 6 FEET FROM HVAC SUPPLY/RETURN VENTS.
 - REFER TO DETAIL #6 ON DWG. E-35 FOR OCCUPANCY SENSORS ON LIGHTING CONTROL BLOCK DIAGRAM.
 - CONTRACTOR IS RESPONSIBLE FOR PROPER SENSITIVITY AND TIME DELAY SETTINGS FOR NON-ADAPTIVE PRODUCTS, FOLLOWING THE MANUFACTURER'S RECOMMENDED PLACEMENT, AND FIELD VERIFICATION OF CIRCUITS WITH RESPECT TO POWER PACK FOR OCCUPANCY SENSORS REPLACEMENT. (IF USED)
 - CONTRACTOR IS RESPONSIBLE FOR FIELD VERIFICATION OF REQUIRED NUMBER OF POWER PACKS FOR OCCUPANCY SENSORS. (IF USED).
 - CARBON MONOXIDE CONDUIT SYSTEM TO BE PROVIDED AND INSTALLED BY DIV. 16 THROUGHOUT PARKING LOT, AND SHALL BE MOUNTED ON COLUMNS AT 1200mm AFF. REFER TO DETAIL #22 ON DWG. E-35.
 - GARAGE EXHAUST FANS SHALL BE CONTROLLED BY CO SENSOR SYSTEM C/W OVERRIDE ON/OFF SWITCH LOCATED AT THE CACG.
 - REFER TO SPRINKLER DRAWINGS FOR FIRE PROTECTION DEVICE TO BE CONNECTED TO THE FIRE ALARM SYSTEM. THE DEVICE AND EQUIPMENT SHALL FORM AN INTEGRAL PART OF THE ELECTRICAL CONTRACT.

ELECTRICAL LEGEND	
LIGHTING	
[Symbol]	FLUORESCENT LIGHT FIXTURE, TYPE AS NOTED
[Symbol]	NIGHT LIGHT OR LIGHT CONNECTED TO EMERGENCY POWER
[Symbol]	CEILING MOUNTED WALL MOUNTED LIGHT FIXTURE, INCREASED LETTER DENOTES TYPE
[Symbol]	POLE MOUNTED LIGHT FIXTURE, INCREASED LETTER DENOTES TYPE
[Symbol]	CEILING MOUNTED LIGHT OUTLET
[Symbol]	TRACK LIGHT
[Symbol]	STRIP LIGHT
[Symbol]	UNDER CABINET FLUORESCENT LIGHT FIXTURE
[Symbol]	CEILING MOUNTED WALL MOUNTED EXIT SIGN
[Symbol]	EMERGENCY BATTERY PACK
[Symbol]	EMERGENCY BATTERY PACK
[Symbol]	OCCUPANCY SENSOR POWER PACKS
[Symbol]	SINGLE/THREE POLE, SINGLE/THREE THRU LOCAL SWITCH RESPECTIVELY
[Symbol]	3/4" CONDUIT DENOTES 3-WAY/4-WAY/PILOT LIGHT, OTHER SWITCHED LIGHT RESPECTIVELY
[Symbol]	MASTER LIGHTING SHUT-OFF SWITCH
[Symbol]	SENSOR WALL SWITCH, FIRE SELF POWERED
[Symbol]	OCCUPANCY SENSOR CEILING MOUNTED
POWER	
[Symbol]	REGULAR DUPLEX RECEPTACLE
[Symbol]	DUPLEX RECEPTACLE, GROUND FAULT INTERRUPT
[Symbol]	3-20A T-100T DUPLEX RECEPTACLE
[Symbol]	SINGLE RECEPTACLE, TYPE AND CONFIGURATION AS SPECIFIED FOR DRYER
[Symbol]	CONNECTION FOR OVEN/COOKTOP
[Symbol]	ABOVE COUNTER DEVICE
[Symbol]	CEILING MOUNTED DEVICES
[Symbol]	FLOOR MOUNTED DEVICES
[Symbol]	DISCONNECT SWITCH, NON-FUSED
[Symbol]	DISCONNECT SWITCH, FUSED
[Symbol]	COMPENSATION STARTER
[Symbol]	FRACTIONAL MOTOR/FAN DIRECT CONNECTION
[Symbol]	DIRECT CONNECTION, SINGLE PHASE
[Symbol]	DIRECT CONNECTION, THREE PHASE
[Symbol]	THERMOSTAT
[Symbol]	DRYER SENSOR
[Symbol]	HEAT TRACE
[Symbol]	ELECTRICAL HEATER
[Symbol]	ELECTRICAL PANEL / SECURITY PANEL
TELECOMMUNICATION	
[Symbol]	TV/CABLE OUTLET
[Symbol]	TELEPHONE OUTLET
[Symbol]	TELEVISION CABLE (MULTI-PORT OUTLET)
[Symbol]	DATA OUTLET
[Symbol]	DATA/TELEPHONE OUTLET
[Symbol]	IN-SITE TELEPHONE BOX C/W RECEPTACLE
[Symbol]	WIFI LOCATION
[Symbol]	MUSIC SPEAKER / VOLUME CONTROL
[Symbol]	RADIO RECEIVER
SECURITY	
[Symbol]	INTERCOM / INTERPHONE
[Symbol]	INTERCOM WITH CAMERA
[Symbol]	PANIC BUTTON / PANIC INTERCOM STATION
[Symbol]	CARD READER
[Symbol]	AUTOMATIC RELEASE CARD ACCESS/RADIO RECEIVER
[Symbol]	MAGLOCK
[Symbol]	DOOR CONTACT / WINDOW CONTACT
[Symbol]	AUTOMATIC DOOR OPERATOR
[Symbol]	MOTION DETECTOR
[Symbol]	PUSH BUTTON
[Symbol]	SECURITY CAMERA
LIFE SAFETY	
[Symbol]	FIRE ALARM SMOKE DETECTOR
[Symbol]	SPOKE ALARM
[Symbol]	FIRE ALARM DUCT TYPE SMOKE DETECTOR
[Symbol]	FIRE ALARM HEAT DETECTOR
[Symbol]	FIXED TEMP. 68 °C (150 °F) HEAT DETECTOR
[Symbol]	MOISTURE PROOF HEAT DETECTOR
[Symbol]	CO ALARM
[Symbol]	COMBINATION SMOKE & CO ALARM
[Symbol]	CO SENSOR / NO SENSOR
[Symbol]	FIRE ALARM MANUAL CALL STATION
[Symbol]	FIREFIGHTERS HATCHET
[Symbol]	FIRE ALARM STROBE/ALARM WALL MTD.
[Symbol]	FIRE ALARM 120V HORN WALL MTD.
[Symbol]	FIRE ALARM 120V HORN CEILING MTD.
[Symbol]	FIRE ALARM SPEAKER/SNOBCE CEILING MTD.
[Symbol]	FIRE ALARM SPEAKER, CEILING MTD.
[Symbol]	FIRE ALARM ANNUNCIATOR PANEL
[Symbol]	FIRE ALARM CONTROL PANEL

KEY NOTES:

- GROUND LOOP PER ONT. ELEC. SAFETY CODE SECTION 10.
- PROVIDE 3/4" X 10 FT STEEL GROUND RODS BURIED IN EARTH & CONNECT TO GROUND BUS BY 2-1/0 STRANDED COPPER WIRES. MIN. OF GROUND RODS SHALL BE SPACED AT LEAST 3 METERS APART.
- ALL DOOR FRAMES, SWITCHGEAR FRAMES & OTHER METAL OBJECTS SHALL BE BONDED TO THE GROUND BUS. METAL FRAME OF BUILDING TO BE CONNECTED TO GROUND GRID BY MIN. OF 2-1/0 CU. CONDUCTORS.
- CONNECT STATION GROUND WITH IN-EARTH GROUND LOOP BY MIN. OF 2 LEADS SEPARATED BY A MINIMUM OF 2 METERS.
- WARNING SIGNS TO BE POSTED AS PER ONT. ELEC. SAFETY CODE RULES: 36-006, 36-100(4), 2-100, 14-506(D) BULLETIN 36-12-0, BULLETIN 36-6-17
- LOW VOLTAGE NEUTRAL 'XO' OF TRANSFORMER MUST BE GROUNDED TO THE SUBSTATION ELECTRODE WITH 3/0 AUG COPPER AND THE NEUTRAL INSTALLED TO THE SERVICE EQUIPMENT. THE 'XO' SHALL ALSO BE BONDED TO THE TRANSF. ENCLOSURE/GROUND BUS WITH A MIN. 500 MCM COPPER CONDUCTOR.
- ALL CONNECTIONS TO THE STATION GROUND ELECTRODE THAT ARE TO BE PERMANENTLY BURIED MUST BE MADE WITH AN APPROVED THERMIT WELD, COMPRESSION CONNECTORS OR AN APPROVED MECHANICAL CONNECTOR.
- GROUND LOOP SIZE SHALL BE EQUIVALENT TO THE FOOT PRINT OF THE TRANSFORMER VAULT.
- THE ELECTRICAL CONTRACTOR SHALL SUBMIT SHOP DRAWING & ROUTING DETAILS OF HV CABLES INSIDE THE SUBSTATION PRIOR TO INSTALLATION.
- THE GROUND GRID CONDUCTORS SHALL BE BARE COPPER BURIED TO A MAXIMUM DEPTH OF 600MM BELOW ROUGH STATION GRADE AND A MINIMUM DEPTH OF 150 MM BELOW THE FINISHED STATION GRADE.
- PROVIDE HYDRO METER BASE OUTLIER HAMMER (EATON) TSU-13 IN 12"x12" ELEC. BOX; C/W 1/2" EMT. PROVIDE 1-1/2" EMT TO UTILITY COMPARTMENT OF MAIN SWITCHBOARD.

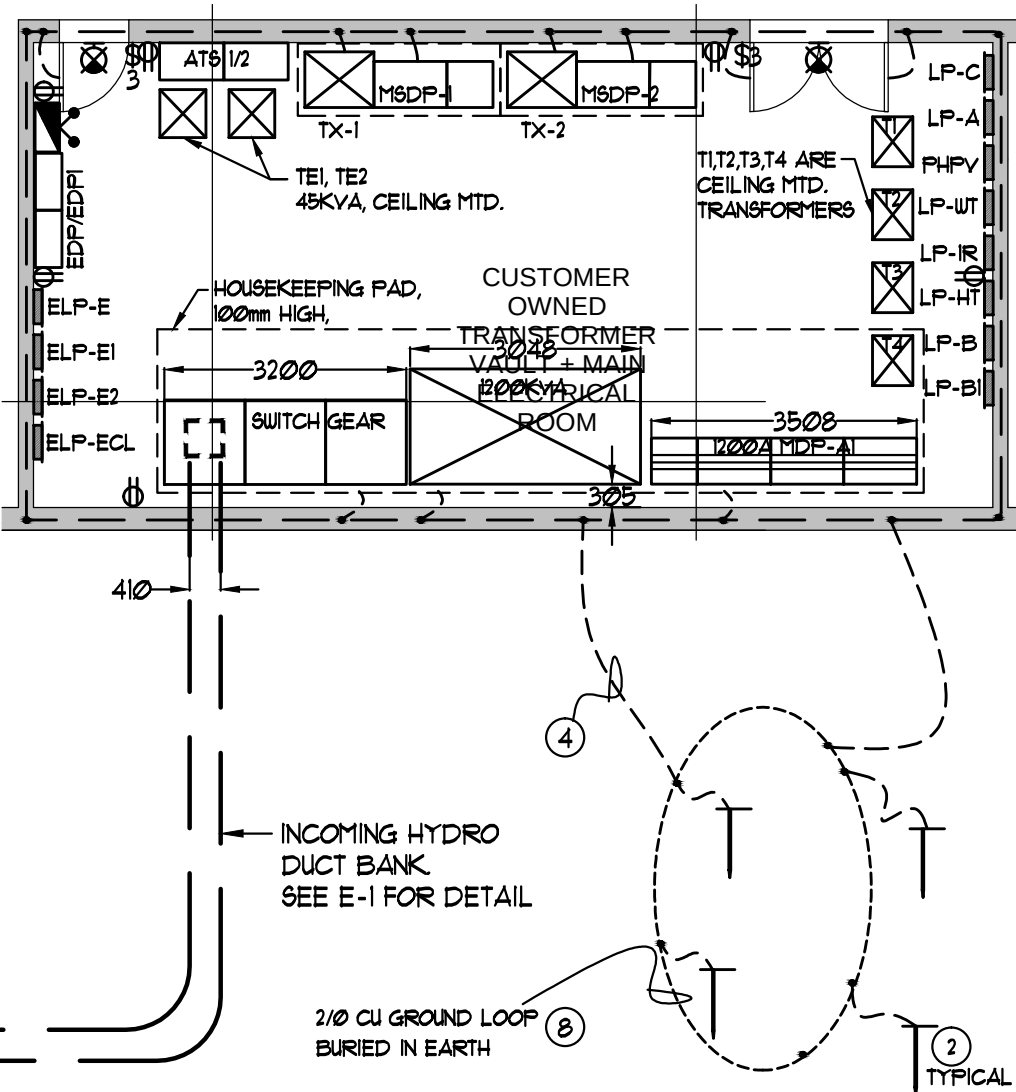

C ELECTRICAL & SWITCH GEAR ROOM PLAN VIEW & GROUNDING DETAILS
E-2 SCALE 1:100

KEY NOTES - PARKING:

- FOR CIRCUITING, REFER TO TABLE #1.
- PROVIDE ALARM SPEAKER, SMOKE DETECTOR AND RECEPTACLE AT EVERY THIRD FLOOR STAIR WELL STARTING FROM TOP FLOOR, AS PER TO DWG. E-32 FOR FIRE ALARM RISER DIAGRAM.
- SANITARY TRAPS ARE TO BE HEAT TRACED BY DIV. 16. CONNECT TO CIRCUIT 'XXXX'.
- SANITARY AND STORM LINE IN PARKING FLOORS ARE TO BE HEAT TRACED WITH SELF REGULATING CABLE BY DIV. 16. CONNECT TO GFI CIRCUIT AS SHOWN.
- CONNECT DUCT TYPE SMOKE DETECTOR TO FIRE ALARM SYSTEM. ACTIVATION OF THE DETECTOR SHALL CAUSE THE FIRE ALARM SYSTEM TO ACTIVATE AND THE FAN TO START AUTOMATICALLY.
- ELECTRICAL CONTRACTOR SHALL PROVIDE A RECEPTACLE C/W 1-1/2" CONDUIT TO 120/208V PANEL 'EV' WITH METER FOR PHEV (PLUG-IN HYBRID ELECTRIC VEHICLES). XX DEDICATED 1ø, 208V, 20A CIRCUITS.
- ELECTRICAL CONTRACTOR SHALL PROVIDE XX ROUGH-IN OUTLET BOXES C/W 1-1/2" CONDUIT TO 120/208V PANEL 'EV' FOR FUTURE RECEPTACLES FOR PHEV (PLUG-IN HYBRID ELECTRIC VEHICLES). SEAL AND LABEL THE XX ROUGH-IN CONDUITS THAT TERMINATE IN CEILING SLAB.

REVISIONS	
NOV001	1
DATE	NOV 01, 2014
BY	ST
DESCRIPTION	ISSUED FOR PERMIT



115 West Beaver Creek Road, Unit 31
Richmond Hill, Ontario L4B 3H1
Tel: 905 882-5445
Fax: 905 882-5441
Email: info@novatrendeng.com

DRAWING TITLE
P-2 FLOOR PLAN
ELECTRICAL LAYOUT

PROJECT TITLE
ALEXANDRA PARK

XXX TORONTO ONTARIO
DRAWN BY: S.O. CHECKED BY: S.T. SCALE: 1:100
DATE: FEB 13 PROJECT NUMBER: 1313 DRAWING NUMBER: E-2 OF