



GENERAL AREA CIRCUITING - TABLE #1			
LIGHTING FIXTURE LOCATION	CCT.*	RECEPTACLE LOCATION	CCT.*
P4 TO P1 - EXIT SIGNS	EX-XX	LOBBY (P4 TO P1)	EX-XX
G/F TO I/O/F - EXIT SIGNS	EX-XX	STAIR "A" (5/F2/FF2)	EX-XX
I/F TO ROOF - EXIT SIGNS	EX-XX	STAIR "B" (1/6,3/21,24,18,5/F) FLOORS	EX-XX
LOBBY (P4 TO P1)	EX-XX	STAIR "B" (1/6,3/21,24,18,5/F) FLOORS	EX-XX
STAIR "A" (P4 TO G/F)	EX-XX	STAIR "C" (1/6,3/21,24,18,5/F) FLOORS	EX-XX
CORRIDOR	EX-XX	STAIR "C" (1/6,3/21,24,18,5/F) FLOORS	EX-XX
	EX-XX	STAIR "D" (1/6,3/21,24,18,5/F) FLOORS	EX-XX
	EX-XX	STAIR "E" (1/F) FLOOR	EX-XX
	EX-XX	CORRIDOR	EX-XX
	EX-XX		EX-XX

KEY NOTES - RESIDENTIAL:

FOR CIRCUITING, REFER TO TABLE "1".

PROVIDE ALARM SPEAKER, SMOKE DETECTOR AND RECEPTACLE AT EVERY THIRD FLOOR STAIR WELL, STARTING FROM TOP FLOOR, AS PER TO DUG. E-32 FOR FIRE ALARM RISER DIAGRAM.

REFER TO SUPERVISED VALVE AND FLOW SWITCH SCHEDULE ON DUG. E-XX FOR DETAILS ON TYPICAL FLOORS.

PROVIDE TELECOMMUNICATION BACKBOARD C/W 15V, 1A 15A RECEPTACLE AS PER COMMUNICATION RISER DIAGRAM ON DUG. E-31.

CONTRACTOR SHALL REFER TO ELECTRICAL SINGLE LINE DIAGRAM ON DUG. E-30 AND SDP RISER ON DUG. E-31 FOR SDP LOCATIONS AND DISTRIBUTION.

REFER CONDUIT AS PER RISER DETAIL "9" ON DUG. E-35 FOR BISORTER/TRISORTER CIRCUIT SYSTEM.

ALL SUITE DOOR CONTACTS MUST COMPLETE WITH INTRUSION ALARM SYSTEM THAT CONTACT TO THE CONCIERGE STATION.

DESIGNATED "LAUNDRY RECEPTACLE" AS DEFINED BY ESA CODE 26-110/6(11), 26-120(6) AND ESA BULLETIN 26-26-0 (WITHIN 3m RADIUS OF LAUNDRY CLOSET). RECEPTACLE SHALL BE CONNECTED TO A DEDICATED CIRCUIT. SEE DETAIL "4" ON DUG. E-35.

SWITCHES, RECEPTACLES, ETC., TO BE INSTALLED AS TO NOT INTERFERE WITH THE OPENING AND OPERATION OF SLIDING DOOR.

SECURITY	
[E] [ENT]	INTERCOM / INTERPHONE
[E5]	INTERCOM WITH CAMERA
[E6] [ENT]	PAUSE BUTTON / PAUSE INTERCOM STATION
[E7]	CARD READER
[E8] [ENT]	AUTOMATIC RELEASE CARD ACCESS/RADIO
[E9]	RECEIVER
[E10]	ELECTRIC STRIKE
[E11]	MAGLOCK
[E12] [ENT]	DOOR CONTACT / WINDOW CONTACT
[E13]	AUTOMATIC DOOR OPERATOR
[E14]	NOTION DETECTOR
[E15]	PUSH BUTTON
[E16] [ENT]	SECURITY CAMERA
LIFE SAFETY	
[E17]	FIRE ALARM SMOKE DETECTOR
[E18]	SPOKE ALARM
[E19]	FIRE ALARM DUCT TIE SPOKE DETECTOR
[E20]	FIRE ALARM HEAT DETECTOR
[E21]	FIRE ALARM TYP A °C DEGREE HEAT DETECTOR
[E22]	MOISTURE PROOF HEAT DETECTOR
[E23]	GO ALARM
[E24]	CORRELATION SPOKE + GO ALARM
[E25] [ENT]	CO SENSOR / NO SENSOR
[E26]	FIRE ALARM MANUAL PULL STATION
[E27]	PREPAREDNESS LINCHEST
[E28]	FIRE ALARM SMOKE/NOX/HEAT HALL MTD
[E29]	FIRE ALARM MIN-HORN HALL MTD
[E30]	FIRE ALARM SPOKE/NOX/ROSE CEILING MTD
[E31]	FIRE ALARM SPOKE/ER, CEILING MTD
[E32]	FIRE ALARM ANNIHILATOR PANEL
[E33]	FIRE ALARM CONTROL PANEL

[illegible]

REVISIONS
 CONTRACTOR MUST CHECK AND VERIFY ALL DIMENSIONS AND CONDITIONS
 ON THE JOB AND REPORT DISCREPANCIES TO THE ENGINEERS BEFORE
 PROCEEDING WITH THE WORK. THIS DRAWING IS THE PROPERTY OF THE
 ENGINEERS AND MUST BE RETURNED UPON COMPLETION OF THE WORK.
 DRAWINGS ARE NOT TO BE SCALED



175 West Beaver Creek Road, Unit 31
Richmond Hill, Ontario L4B 3M1
Tel: 905 882-5445
Fax: 905 882-5447
Email: cad@novatrendeng.com

DRAWING TITLE:
5/F NORTH FLOOR PLAN
ELECTRICAL LAYOUT


PROJECT TITLE:
ALEXANDRA PARK

XXX
TORONTO

ONTARIO

DRAWN BY: CHECKED BY: SCALE:

S.O.	S.T.	1:50
DATE: FEB. 13	PROJECT NUMBER: 1313	DRAWING NUMBER: E-15 OF

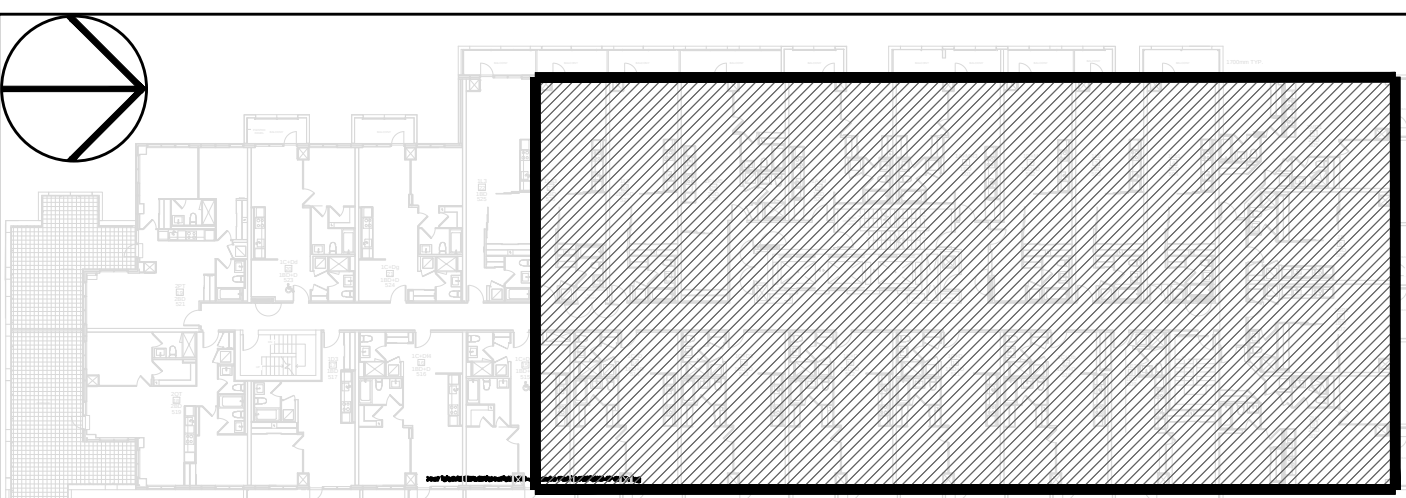

KEY PLAN	N.T.S.
----------	--------