


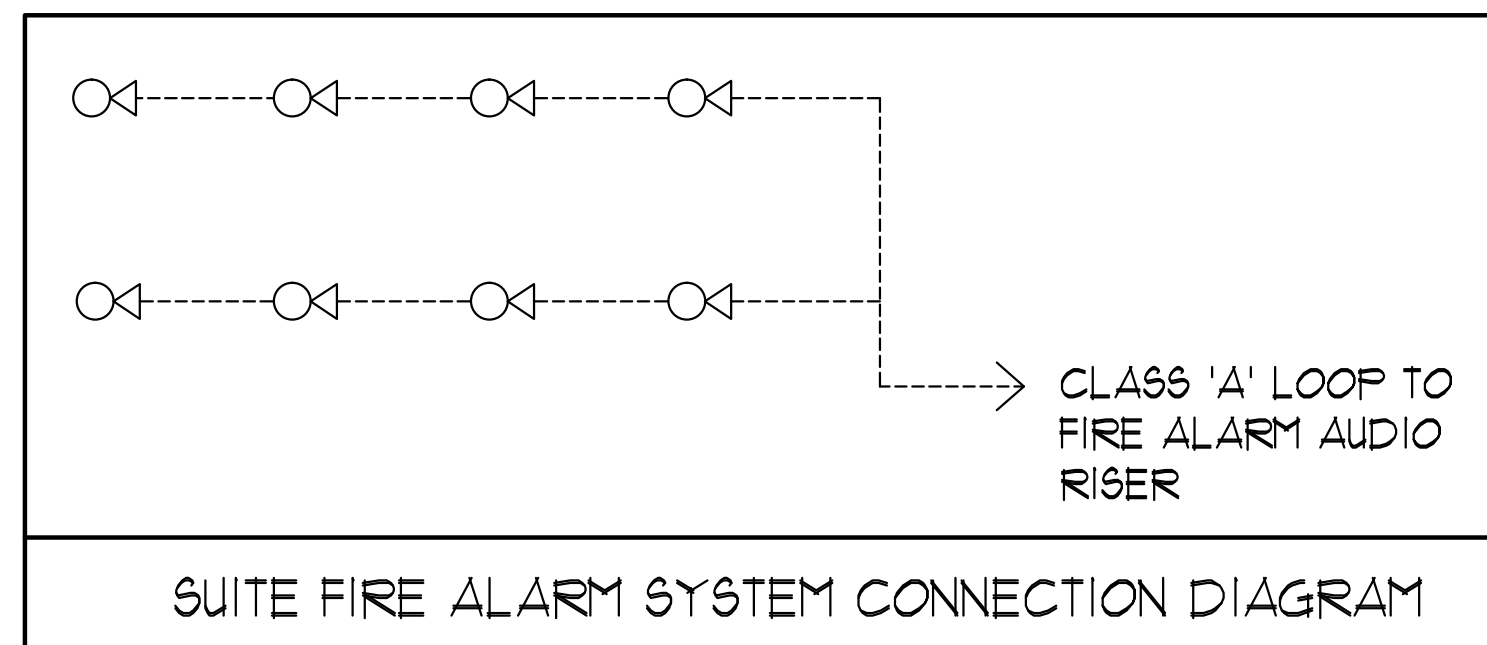


MOUNTING HEIGHT SCHEDULE (DIMENSIONS ARE FROM FINISH FLOOR TO TOP OF WALL BOX)		
OUTLET	SUITES	PUBLIC AREA
RECEPTACLE	18" FFF	18" FFF
KITCHEN COUNTER SPLIT RECEPTACLE	46" FFF	46" FFF
TV/TELEPHONE (MULTI-PORT) OUTLET	18" FFF	18" FFF
LIGHT SWITCH	38" FFF	38" FFF
SECURITY PANEL	62" FFF	62" FFF
WALL THERMOSTAT	62" FFF	62" FFF
FRIDGE RECEPTACLE	TO SUIT EQUIPMENT	
MICROWAVE/FAN UNIT RECEPTACLE	LOCATE IN UPPER CABINET ABOVE	
UNDER CABINET LIGHTING RECEPTACLE	LOCATE IN UPPER CABINET ABOVE MICROWAVE / FAN UNIT	
INTERCOM		41" FFF
FIREFIGHTER'S HANDSET		41" FFF
FULL STATION		41" FFF

GENERAL AREA CIRCUITING - TABLE #1			
LIGHTING FIXTURE LOCATION	CGT. #	RECEPTACLE LOCATION	CGT. #
P4 TO P1 - EXIT SIGNS	EX-XX	LOBBY (P4 TO P1)	EX-XX
G/F TO 10/F - EXIT SIGNS	EX-XX	STAIR "A" (5/F, 6/F, 7/F)	EX-XX
11/F TO ROOF - EXIT SIGNS	EX-XX	STAIR "B" (ME30, 30, 21, 24, 21, 10, 15) FLOORS	EX-XX
LOBBY (P4 TO P1)	EX-XX	STAIR "B" (12, 13, 14, 15, 16, 17, 18, 19) FLOORS	EX-XX
STAIR "A" (P4 TO G/F)	EX-XX	STAIR "C" (MP4, 30, 21, 24, 21) FLOORS	EX-XX
CORRIDOR	EX-XX	STAIR "C" (18, 19, 20, 21, 22, 23) FLOORS	EX-XX
-	EX-XX	STAIR "D" (P1, P4) FLOORS	EX-XX
-	EX-XX	STAIR "E" (P1) FLOOR	EX-XX
-	EX-XX	CORRIDOR	EX-XX

- GENERAL NOTES - RESIDENTIAL:**
- ELECTRICAL DRAWINGS SHALL BE READ IN CONJUNCTION WITH MECHANICAL, STRUCTURAL, ARCHITECTURAL AND LANDSCAPE DRAWINGS.
 - CONTRACTOR SHALL RUN CABLES WITHIN CEILING SLAB OR ENCLOSURES TO RETAIN 2 HOUR FIRE PROTECTION RATING FOR ALL LOADS THAT CONNECT TO EMERGENCY POWER.
 - FIRE ALARM RISERS SHALL BE RUN IN 2 HOUR FIRE RATED ELECTRICAL CLOSET. REFER TO DWG. E-32 FOR RISER DIAGRAM AND DETAILS.
 - STAIRWAY WALL MOUNTED EMERGENCY LIGHT FIXTURES SHALL BE MOUNTED @ 1' AFF.
 - EMERGENCY LIGHT FIXTURES IN LOCKERS, STORAGE, GARBAGE, UTILITY AND SERVICE ROOMS SHALL BE CONNECTED TO BOTH NORMAL AND EMERGENCY POWER AS PER DETAIL #21 OF DWG. E-35.
 - FOR STORAGE ROOM VENTILATION SYSTEM, DIV. 16 TO PROVIDE CONDUIT, WIRING AND SWITCH (S) TO START/STOP FAN AND DAMPER. FAN AND 110V ACTUATOR TO BE SUPPLIED AND INSTALLED BY DIV. 15.
 - FOR UTILITY ROOM VENTILATION SYSTEM, DIV. 15 WILL PROVIDE LINE VOLTAGE THERMOSTAT (T) TO DIV. 16. DIV. 16 TO PROVIDE CONDUIT AND WIRING TO START/STOP FAN AND DAMPER VIA THERMOSTAT. FAN AND 110V ACTUATOR TO BE SUPPLIED AND INSTALLED BY DIV. 15.
 - REFER TO SPRINKLER DRAWINGS FOR FIRE PROTECTION DEVICE TO BE CONNECTED TO THE FIRE ALARM SYSTEM. THE DEVICE AND EQUIPMENT SHALL FORM AN INTEGRAL PART OF THE ELECTRICAL CONTRACT.
 - REFER TO SUITE PANEL SCHEDULES FOR INSUITE CIRCUIT ARRANGEMENT.
 - ALL DUELLING UNIT RECEPTACLES EXCEPT IN KITCHEN SHALL BE TAMPER PROOF.
 - PROVIDE GROUND FAULT PROTECTION FOR SUITE KITCHEN AND WASHROOM RECEPTACLES WITHIN 1500mm OF SINK.
 - PROVIDE TELECOMMUNICATION BOX C/W BUILT-IN RECEPTACLE FOR TELECOMMUNICATION. TELECOMMUNICATION BOX SHALL BE COMPLIANT WITH THE TELECOM SERVICE PROVIDER SPECIFICATION. REFER TO DETAIL #9 ON DWG. E-35 FOR TELECOM JUNCTION BOX INSTALLATION.
 - DRYER SENSOR TO START DRYER VENTILATION FAN AUTOMATICALLY WHEN DRYER IS RUNNING.
 - ALL SMOKE ALARMS WITHIN THE SUITE SHALL BE HARDWIRED TOGETHER AND TO A 15A, 1P CIRCUIT BREAKER AHEAD OF OTHER LOADS.

- KEY NOTES - RESIDENTIAL:**
- FOR CIRCUITING, REFER TO TABLE #1.
 - PROVIDE ALARM SPEAKER, SMOKE DETECTOR AND RECEPTACLE AT EVERY THIRD FLOOR STAIR WELL, STARTING FROM TOP FLOOR, AS PER TO DWG. E-32 FOR FIRE ALARM RISER DIAGRAM.
 - REFER TO SUPERVISED VALVE AND FLOW SWITCH SCHEDULE ON DWG. E-XX FOR DETAILS ON TYPICAL FLOORS.
 - PROVIDE TELECOMMUNICATION BACKBOARD C/W 115V, 1Ø, 15A RECEPTACLE AS PER COMMUNICATION RISER DIAGRAM ON DWG. E-31.
 - CONTRACTOR SHALL REFER TO ELECTRICAL SINGLE LINE DIAGRAM ON DWG. E-30 AND SDP RISER ON DWG. E-31 FOR SDP LOCATIONS AND DISTRIBUTION.
 - PROVIDE CONDUIT AS PER RISER DETAIL #19 ON DWG. E-35 FOR DISORTER/TRISORTER CONTROL SYSTEM.
 - ALL SUITE DOOR CONTACTS WILL COMPLETE WITH INTRUSION ALARM SYSTEM THAT CONTACT TO THE CONCIERGE STATION.
 - DESIGNATED "LAUNDRY RECEPTACLE" AS DEFINED BY ESA CODE 26-1101(a)(11) 26-1201(b) AND ESA BULLETIN 26-16-0 (WITHIN 3m RADIUS OF LAUNDRY CLOSET). RECEPTACLE SHALL BE CONNECTED TO A DEDICATED CIRCUIT. SEE DETAIL #4 ON DWG. E-35.
 - SWITCHES, RECEPTACLES, ETC., TO BE INSTALLED AS NOT INTERFERE WITH THE OPENING AND OPERATION OF SLIDING DOOR.

ELECTRICAL LEGEND	
LIGHTING	
	FLUORESCENT LIGHT FIXTURE, TYPE AS INDICATED
	NIGHT LIGHT OR LIGHT CONNECTED TO EMERGENCY POWER
	CEILING MOUNTED WALL MOUNTED LIGHT FIXTURE, INSCRIBED LETTER DENOTES TYPE
	POLE MOUNTED LIGHT FIXTURE, INSCRIBED LETTER DENOTES TYPE
	TRACK LIGHT
	STRIP LIGHT
	UNDER CABINET FLUORESCENT LIGHT FIXTURE
	CEILING MOUNTED WALL MOUNTED EXIT SIGN
	SINGLE/DOUBLE EMERGENCY LAMP NEPNOTE HEAD
	EMERGENCY BATTERY PACK
	OCCUPANCY SENSOR POWER PACKS
	SINGLE/DOUBLE POLE, SINGLE/DOUBLE THREE WAY TOGGLE SWITCH RESPECTIVELY
	3-WAY/4-WAY SWITCHES 3-WAY/4-WAY/4-WAY/4-WAY, OTHER SWITCHED LIGHT RESPECTIVELY
	MASTER LIGHTING SHUT-OFF SWITCH
	SENSOR WALL SWITCH FIRE SELF POWERED
	OCCUPANCY SENSOR CEILING MOUNTED
POWER	
	REGULAR DUPLEX RECEPTACLE
	DUPLEX RECEPTACLE GROUND FAULT INTERRUPT
	3-WAY/4-WAY DUPLEX RECEPTACLE
	SINGLE RECEPTACLE TYPE AND CONFIGURATION AS SPECIFIED FOR DRYER
	CONNECTION FOR OVEN/COOKTOP
	ABOVE COUNTER DEVICE
	CEILING MOUNTED DEVICES
	FLOOR MOUNTED DEVICES
	DISCONNECT SWITCH NON-FUSED
	DISCONNECT SWITCH FUSED
	COMBINATION STARTER
	FRACTIONAL MOTOR/FAN DIRECT CONNECTION
	DIRECT CONNECTION SINGLE PHASE
	DIRECT CONNECTION THREE PHASE
	THERMOSTAT
	DRYER SENSOR
	HEAT TRACE
	ELECTRICAL HEATER
	ELECTRICAL PANEL / SECURITY PANEL
TELECOMMUNICATION	
	TV/CABLE OUTLET
	TELEPHONE OUTLET
	TELEPHONE CABLE (MULTI-PORT OUTLET)
	DATA OUTLET
	DATA/TELEPHONE OUTLET
	IN-SUITE TELEPHONY BOX C/W RECEPTACLE
	UPI LOCATION
	MUSIC SPEAKER / VOLUME CONTROL
	RADIO RECEIVER
SECURITY	
	INTERCOM / INTERPHONE
	INTERCOM WITH CAMERA
	PANIC BUTTON / PANIC INTERCOM STATION
	CARD READER
	AUTOMATIC RELEASE CARD ACCESS RADIO RECEIVER
	ELECTRIC STRIKE
	MAGLOCK
	DOOR CONTACT / WINDOW CONTACT
	AUTOMATIC DOOR OPERATOR
	MOTION DETECTOR
	PUSH BUTTON
	SECURITY CAMERA
LIFE SAFETY	
	FIRE ALARM SMOKE DETECTOR
	SMOKE ALARM
	FIRE ALARM DUCT TYPE SMOKE DETECTOR
	FIRE ALARM HEAT DETECTOR
	FIXED TYPE 68 °C (158 °F) GLASS HEAT DETECTOR
	MOISTURE PROOF HEAT DETECTOR
	CO ALARM
	COMBINATION SMOKE & CO ALARM
	CO SENSOR / NO SENSOR
	FIRE ALARM MANUAL PULL STATION
	FIRE ALARM HORN
	FIRE ALARM STROBES HORN WALL MTD.
	FIRE ALARM HORN WALL MTD.
	FIRE ALARM SPEAKER STROBE CEILING MTD.
	FIRE ALARM SPEAKER CEILING MTD.
	FIRE ALARM ANNUNCIATION PANEL
	FIRE ALARM CONTROL PANEL

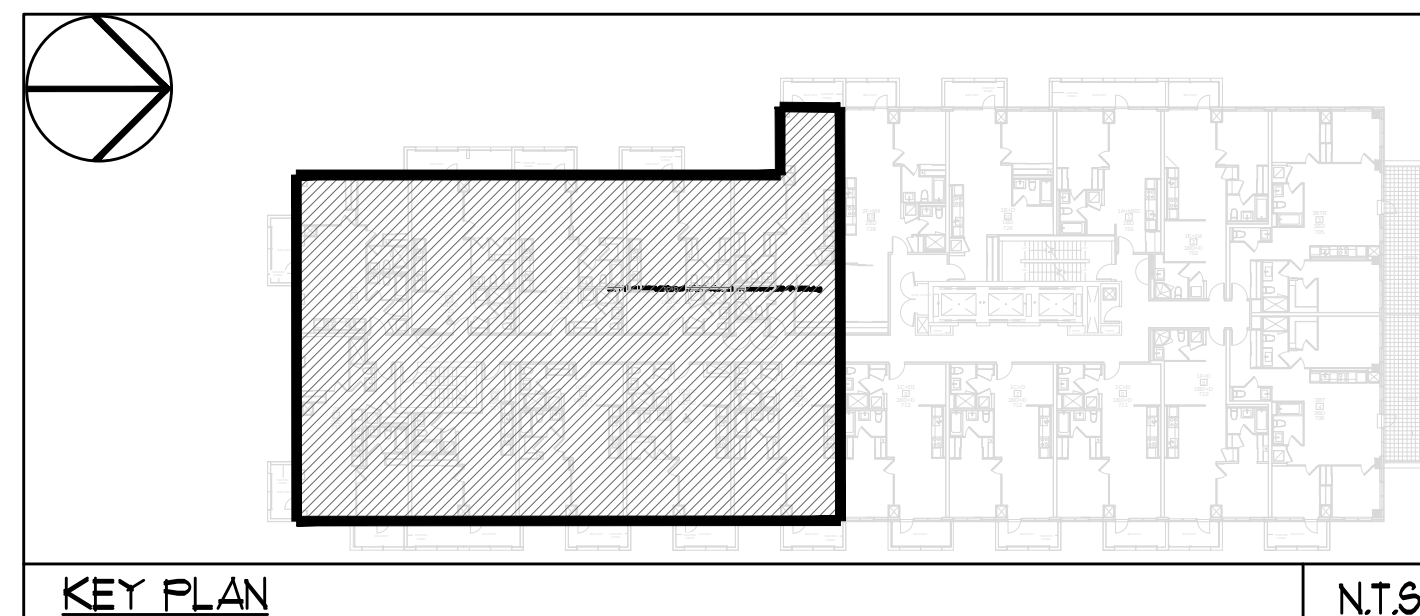

REVISIONS	
NO.	DESCRIPTION
1	ISSUED FOR ...
2	...
3	...
4	...
100	...

NOVA TREND
ARCHITECTURE & ENGINEERING

115 West Beaver Creek Road Unit 31
Richmond Hill, Ontario L4B 3H1
Tel: 905-882-5445
Fax: 905-882-5441
Email: cadd@novatrendeng.com

PROJECT TITLE
ALEXANDRA PARK

1/F SOUTH FLOOR PLAN
ELECTRICAL LAYOUT

PROJ. NO. XXX TORONTO ONTARIO

DRAWN BY: S.O. CHECKED BY: S.T. SCALE: 1:50

DATE: FEB, 13 PROJECT NUMBER: 1313 DRAWING NUMBER: E-18 OF