
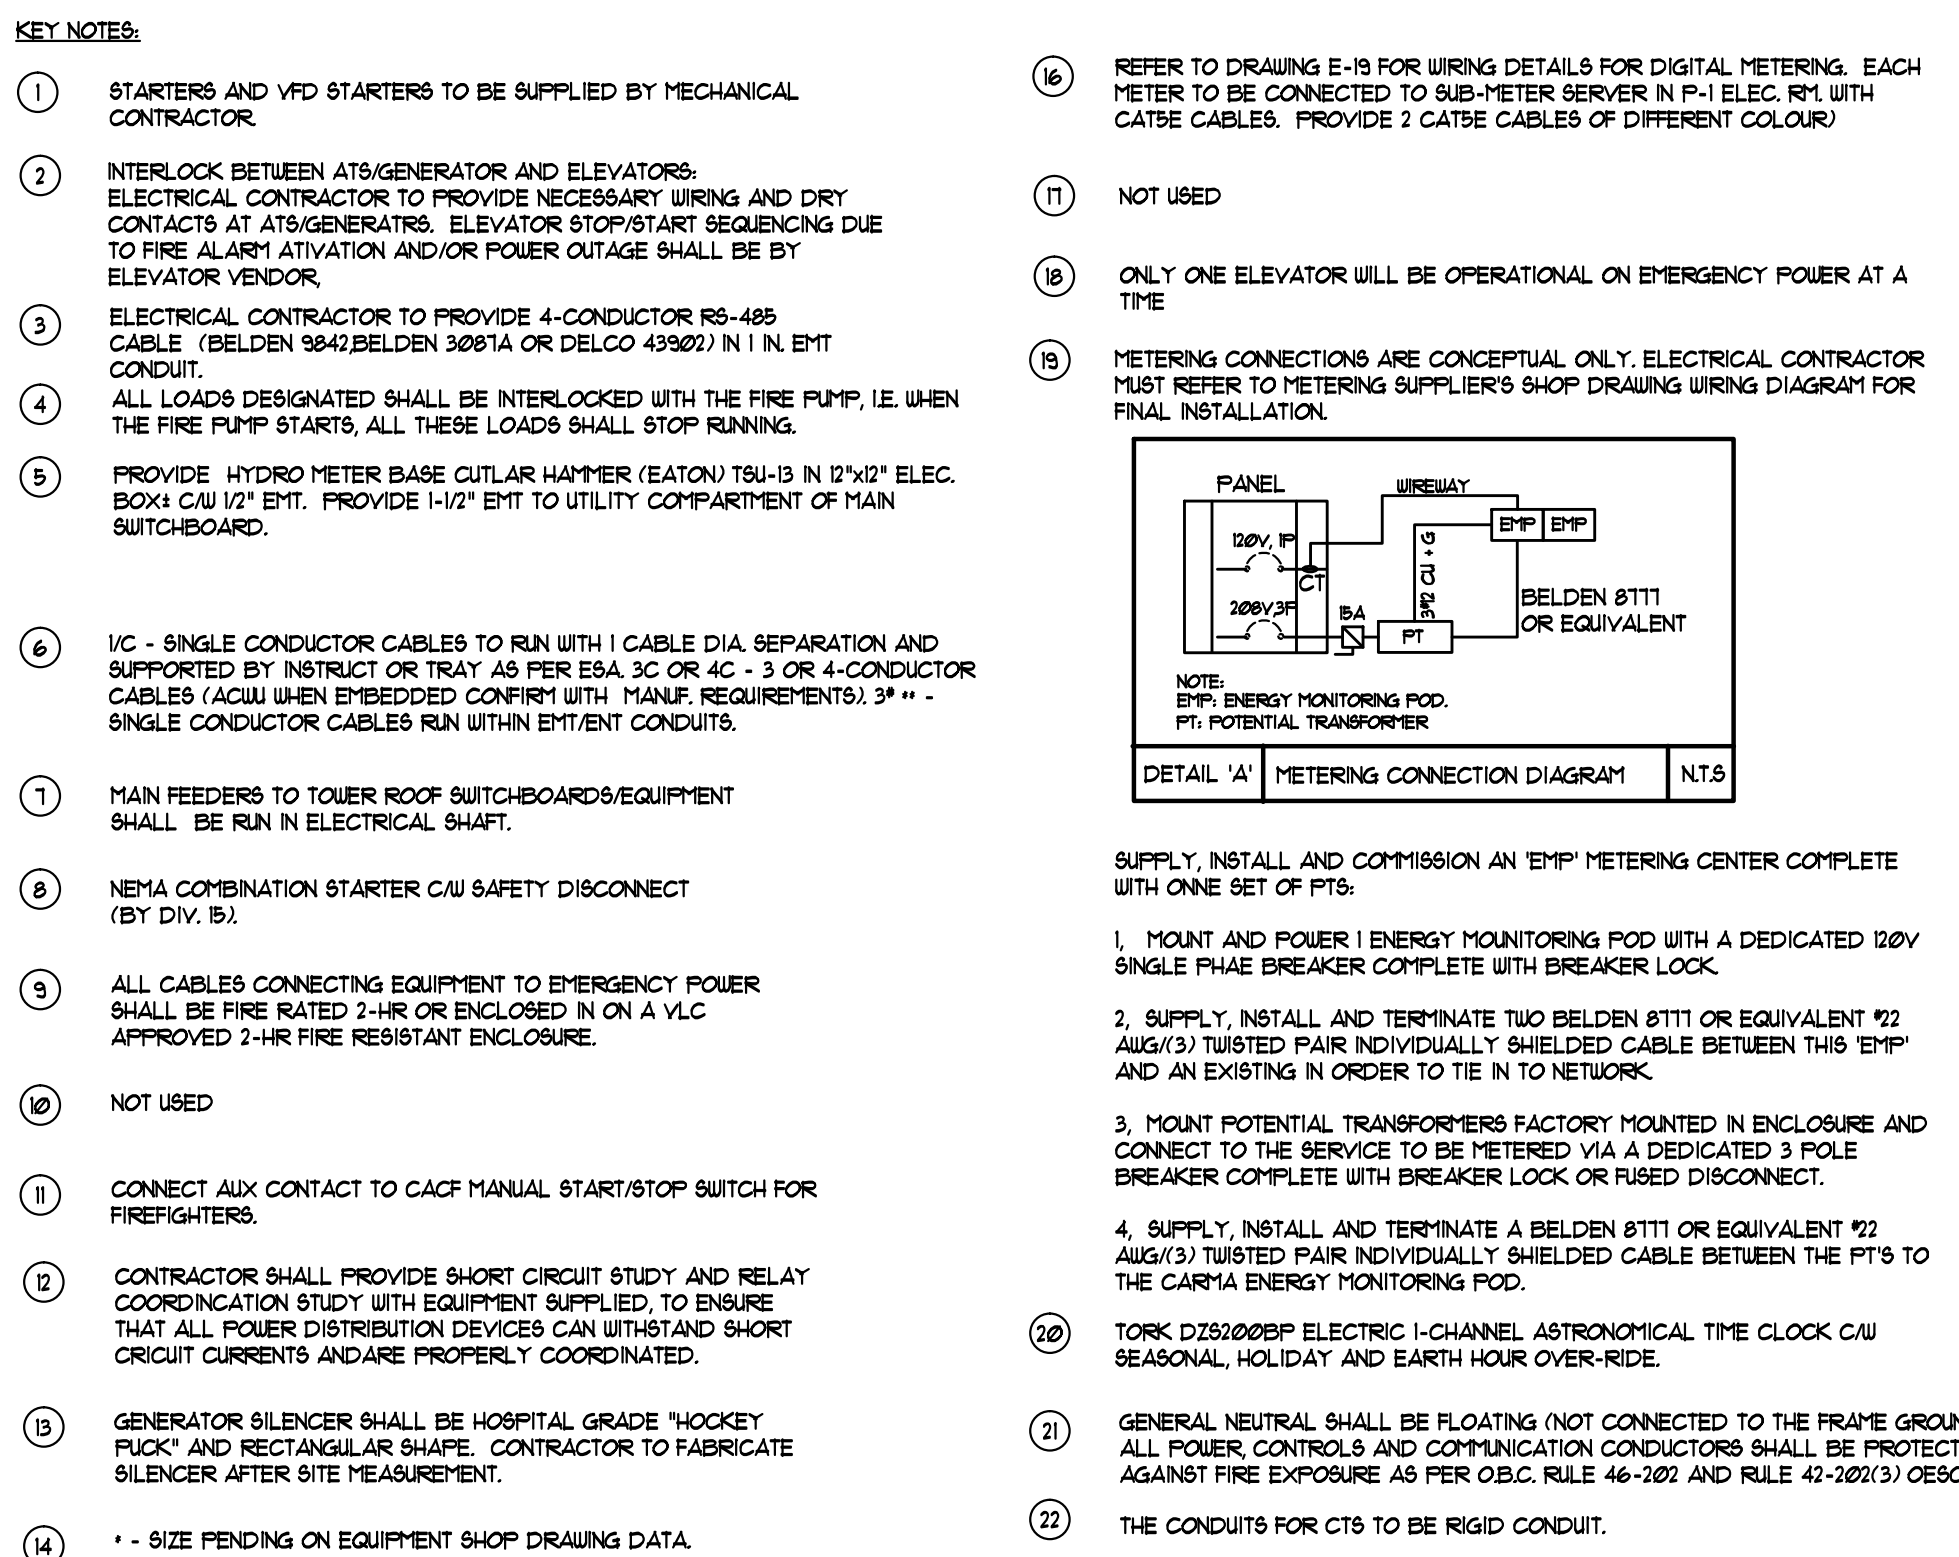


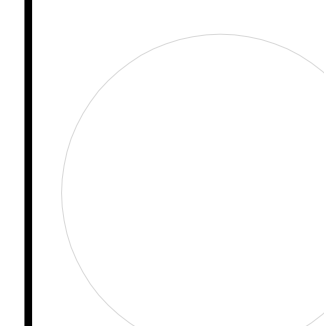

LIFE SAFETY	
	FIRE ALARM SMOKE DETECTOR
	SMOKE ALARM
	FIRE ALARM DUCT TYPE SMOKE DETECTOR
	FIRE ALARM HEAT DETECTOR
	FIXED TEMP. 88 °C DEGREE HEAT DETECTOR
	MOISTURE PROOF HEAT DETECTOR
	CO ALARM
	CARBONATION SMOKE & CO ALARM
	NO SENSOR / NO SENSOR
	FIRE ALARM MANUAL PULL STATION
	FIREFIGHTER'S HANDSET
	FIRE ALARM STROBE HORN, WALL MTD.
	FIRE ALARM MINI HORN, WALL MTD.
	FIRE ALARM SPEAKER/STROBE CEILING MTD.
	CO FIRE ALARM SPEAKER, CEILING MTD.
	FIRE ALARM ANNUNCIATOR PANEL
	FIRE ALARM CONTROL PANEL

ISSUED TO...	DATE	NO.	ISSUED FOR...	ASSIGNMENT	BY
THANK YOU! ALL PRINTS DATED PREVIOUS TO FINAL DATE ABOVE					
REVISIONS					
CONTRACTOR MUST CHECK AND SIGN ALL DISCREPANCIES AND CONDITIONS ON THE JOB AND REPORT DISCREPANCIES TO THE ENGINEER BEFORE PROCEEDING WITH THE WORK. THE DRAWING IS THE PROPERTY OF THE FIRM. THE DRAWINGS MUST BE RETURNED UPON COMPLETION OF THE WORK.					
DRAWINGS ARE NOT TO BE SCALED					
* * * * * NOVA T R E N D ENGINEERING S O U T H, L T D					

175 West Beaver Creek Road, Unit 31 Richmond Hill, Ontario L4B 3M1 Tel: 905 882-5445 Fax: 905 882-5441 Email: cad@mavtrading.com			
DRAWING TITLE: SINGLE LINE DIAGRAM			
PROJECT TITLE: XXXXXXXXXX PARK			
XXXX TORONTO		ONTARIO	
DRAWN BY: S.O.	CHECKED BY: S.T.	SCALE:	
DATE: FEB. 13	PROJECT NUMBER: 1313	DRAWING NUMBER: E-30 OF	