


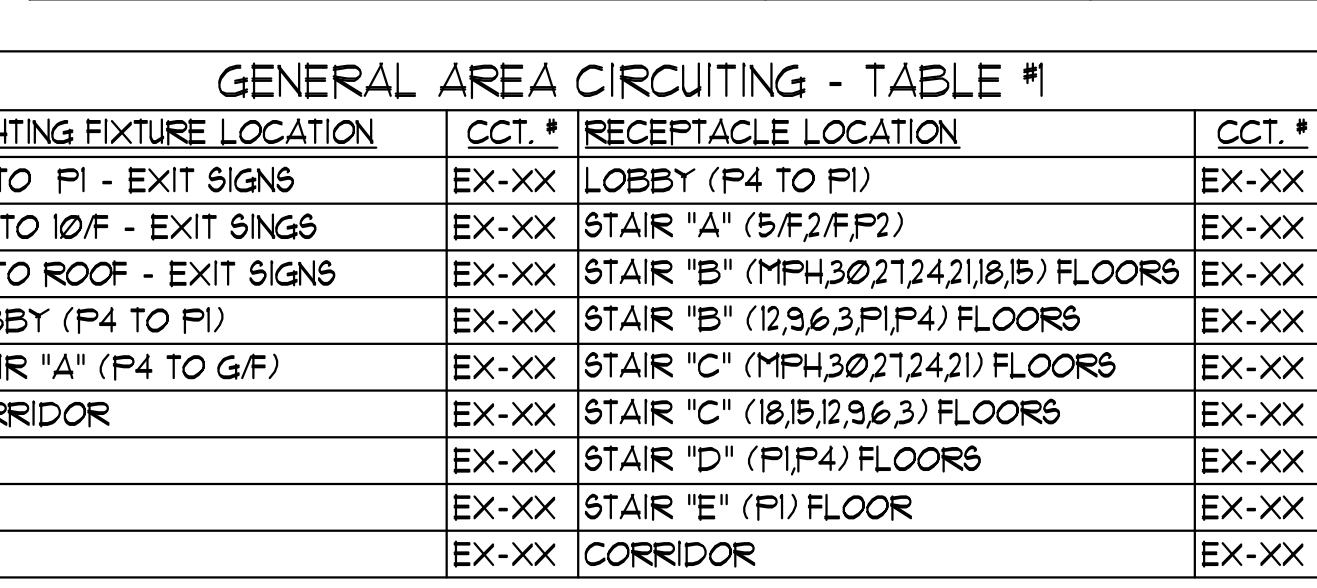

		175 West Beaver Creek Road Unit 31 Richmond Hill, Ontario L4B 3M1 Tel: 905 882-5445 Fax: 905 882-5447 Email: cad@innovatend.com						
		DRAWING TITLE G/F SOUTH FLOOR PLAN POWER LAYOUT						
		PROJECT TITLE ALEXANDRA PARK XXXX TORONTO ONTARIO <table border="1"> <tr> <td>DRAWN BY: S.O.</td> <td>CHECKED BY: S.T.</td> <td>SCALE: 1:50</td> </tr> <tr> <td>DATE: FEB, 13</td> <td>PROJECT NUMBER: 1313</td> <td>DRAWING NUMBER: E-4 OF</td> </tr> </table>	DRAWN BY: S.O.	CHECKED BY: S.T.	SCALE: 1:50	DATE: FEB, 13	PROJECT NUMBER: 1313	DRAWING NUMBER: E-4 OF
DRAWN BY: S.O.	CHECKED BY: S.T.	SCALE: 1:50						
DATE: FEB, 13	PROJECT NUMBER: 1313	DRAWING NUMBER: E-4 OF						
EY PLAN	N.T.S.							