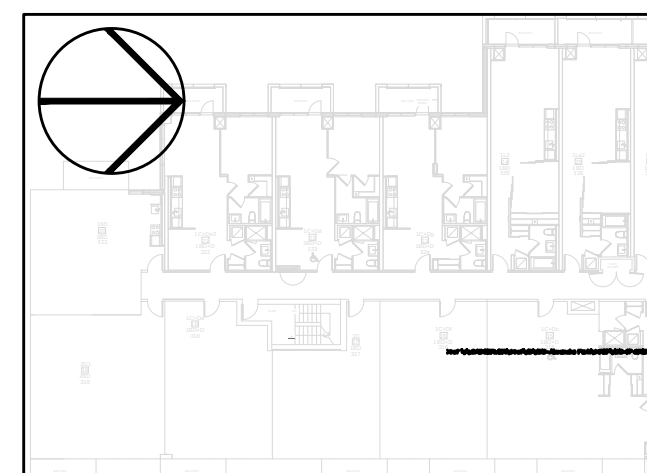
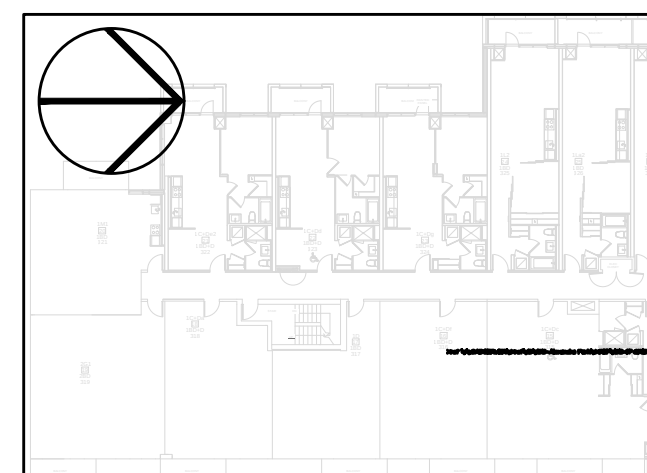


THANK YOU! ALL PRINTS DATE PREVIOUS TO FINAL DATE ABOVE REVISIONS CONTRACTOR MUST CHECK AND VERIFY ALL DIMENSIONS AND CONDITIONS ON THE JOB AND REPORT ANY DISCREPANCIES TO THE DESIGN ENGINEERS BEFORE PROCEEDING WITH THE WORK. THIS DRAWING IS THE PROPERTY OF THE ENGINEER AND MUST BE RETURNED UPON COMPLETION OF THE WORK. DRAWINGS ARE NOT TO BE SCALED	NOVA TREND ARCHITECTS REGISTERED PROFESSIONAL ARCHITECT ONTARIO SY-P. 1111 <i>Stephen</i> Professional Services						
	115 West Beaver Creek Road, Unit 31 Richmond Hill, Ontario L4B 3P1 Tel: 905 882-5445 Fax: 905 882-5447 Email: caroline@novatrend.com DRAWING TITLE 3/F NORTH FLOOR PLAN ELECTRICAL LAYOUT PROJECT TITLE ALEXANDRA PARK XXX TORONTO ONTARIO <table style="width: 100%; border-collapse: collapse; margin-top: 10px;"> <tr> <td style="width: 33%;">DRAWN BY: S.O.</td> <td style="width: 33%;">CHECKED BY: S.T.</td> <td style="width: 33%;">SCALE: 1:50</td> </tr> <tr> <td>DATE: FEB, 13</td> <td>PROJECT NUMBER: 1313</td> <td>DRAWING NUMBER: E-11 of</td> </tr> </table>	DRAWN BY: S.O.	CHECKED BY: S.T.	SCALE: 1:50	DATE: FEB, 13	PROJECT NUMBER: 1313	DRAWING NUMBER: E-11 of
DRAWN BY: S.O.	CHECKED BY: S.T.	SCALE: 1:50					
DATE: FEB, 13	PROJECT NUMBER: 1313	DRAWING NUMBER: E-11 of					

	NOVA TREND ARCHITECTS REGISTERED PROFESSIONAL ARCHITECT ONTARIO SY-P. 1111 <i>Stephen</i> Professional Services						
	115 West Beaver Creek Road, Unit 31 Richmond Hill, Ontario L4B 3P1 Tel: 905 882-5445 Fax: 905 882-5447 Email: caroline@novatrend.com DRAWING TITLE 3/F NORTH FLOOR PLAN ELECTRICAL LAYOUT PROJECT TITLE ALEXANDRA PARK XXX TORONTO ONTARIO <table style="width: 100%; border-collapse: collapse; margin-top: 10px;"> <tr> <td style="width: 33%;">DRAWN BY: S.O.</td> <td style="width: 33%;">CHECKED BY: S.T.</td> <td style="width: 33%;">SCALE: 1:50</td> </tr> <tr> <td>DATE: FEB, 13</td> <td>PROJECT NUMBER: 1313</td> <td>DRAWING NUMBER: E-11 of</td> </tr> </table>	DRAWN BY: S.O.	CHECKED BY: S.T.	SCALE: 1:50	DATE: FEB, 13	PROJECT NUMBER: 1313	DRAWING NUMBER: E-11 of
DRAWN BY: S.O.	CHECKED BY: S.T.	SCALE: 1:50					
DATE: FEB, 13	PROJECT NUMBER: 1313	DRAWING NUMBER: E-11 of					

KEY PLAN

N.T.S.