


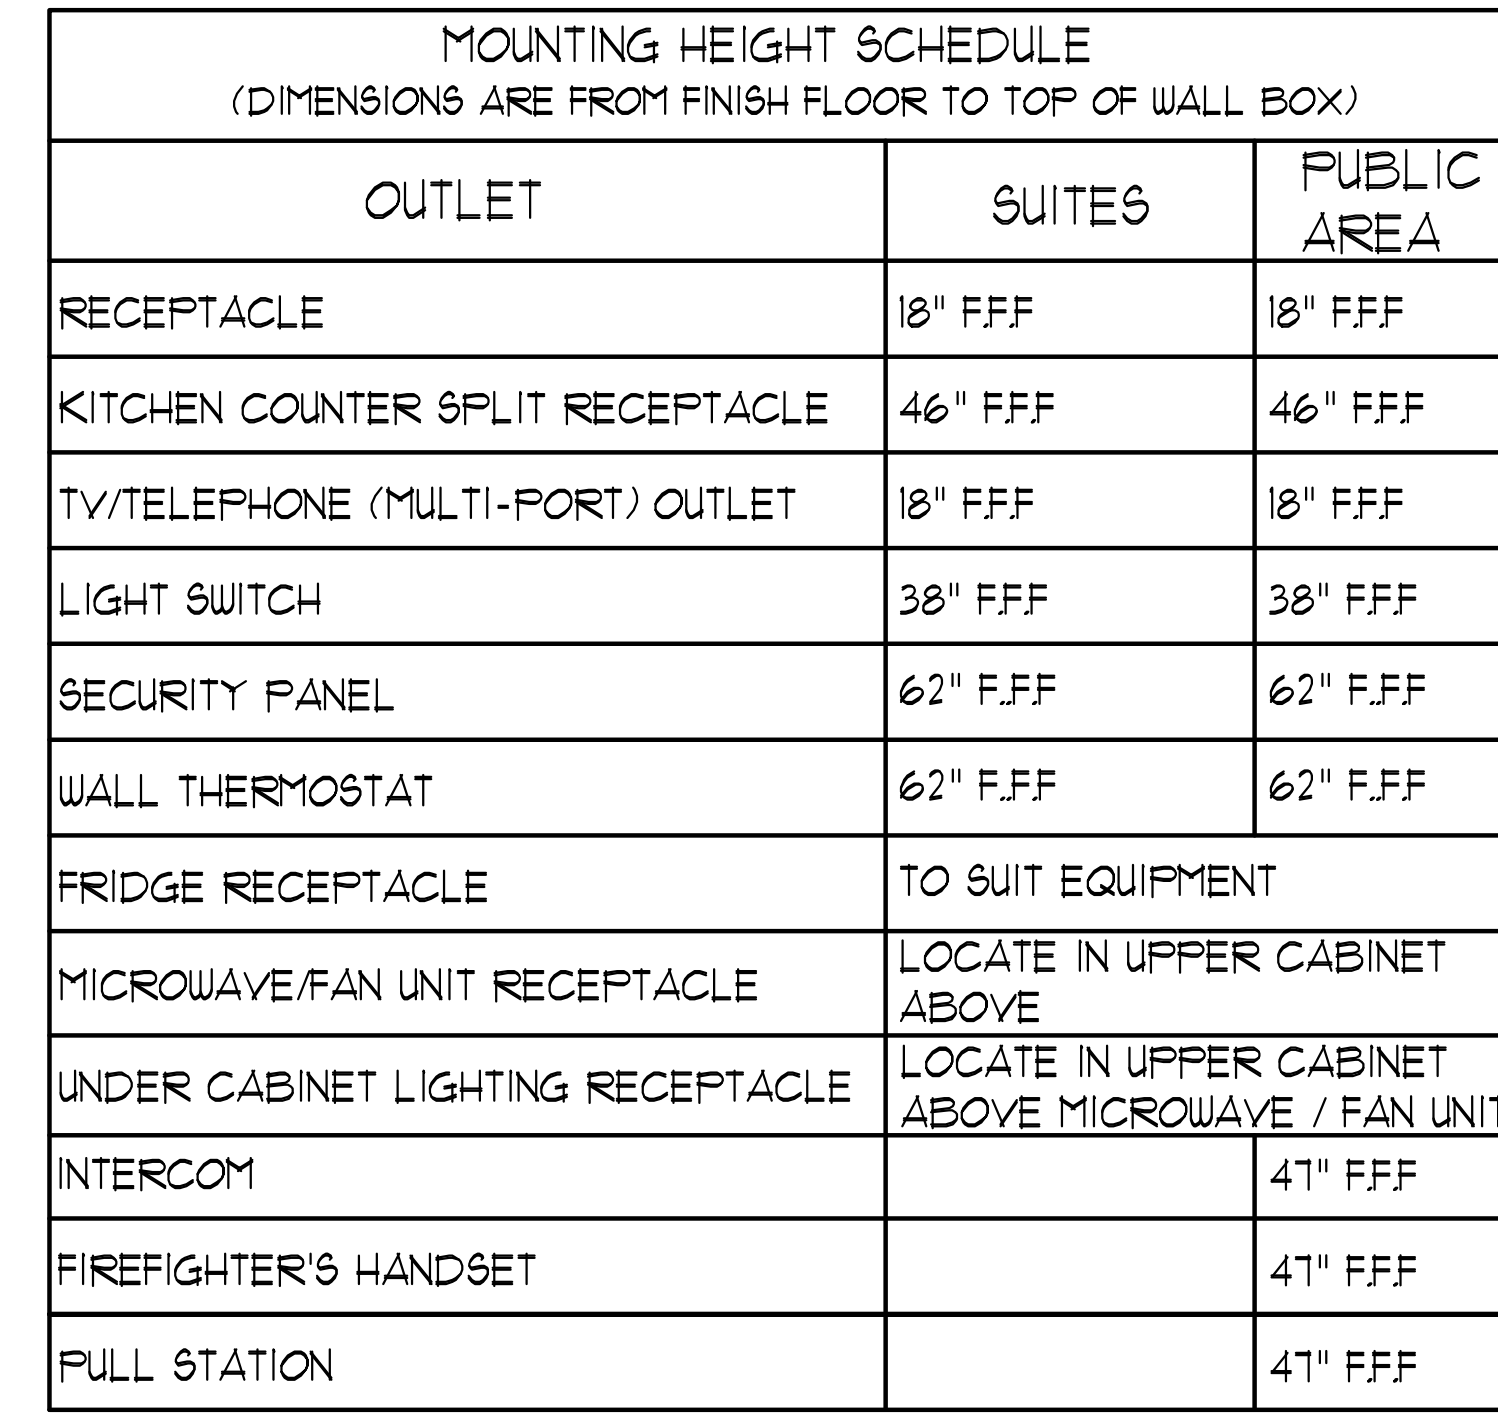

KEY NOTES - RESIDENTIAL:

FOR CIRCUITING, REFER TO TABLE #1.

PROVIDE ALARM SPEAKER, SMOKE DETECTOR AND RECEPTACLE AT EVERY THIRD FLOOR STAIR WELL, STARTING FROM TOP FLOOR, AS PER TO DUG. E-32 FOR FIRE ALARM RISER DIAGRAM.

REFER TO SUPERVISED VALVE AND FLOW SWITCH SCHEDULE ON DUG. E-XX FOR DETAILS ON TYPICAL FLOORS.

PROVIDE TELECOMMUNICATION BACKBOARD CALL 15V, 1A, 15A RECEPTACLE AS PER COMMUNICATION RISER DIAGRAM ON DUG. E-31.

CONTRACTOR SHALL REFER TO ELECTRICAL SINGLE LINE DIAGRAM ON DUG. E-30 AND SDP RISER ON DUG. E-31 FOR SDP LOCATIONS AND DISTRIBUTION.

PROVIDE CONDUIT AS PER RISER DETAIL #19 ON DUG. E-35 FOR BISOIRTER/TRISOIRTER CONTROL SYSTEM.

ALL SUITE DOOR CONTACTS MUST COMPLETE WITH INTRUSION ALARM SYSTEM THAT CONTACT TO THE CONCIERGE STATION.

DESIGNATED "LAUNDRY RECEPTACLE" AS DEFINED BY ESA CODE 26-120(a)(11), 26-120(b) AND ESA BULLETIN 26-26-0 (WITHIN 3m RADIUS OF LAUNDRY CLOSET). RECEPTACLE SHALL BE CONNECTED TO A DEDICATED CIRCUIT. SEE DETAIL #4 ON DUG. E-35.

(SWITCHES, RECEPTACLES, ETC., TO BE INSTALLED AS TO NOT INTERFERE WITH THE OPENING AND OPERATION OF SLIDING DOOR

FOR FAN COIL UNITS (FCU-4), ELECTRICAL CONTRACTOR TO SUPPLY AND INSTALL CONDUIT, AND JUNCTION BOX FOR REMOTE THERMOSTAT MECHANICAL CONTRACTOR SUPPLY AND WIRE THERMOSTATS, MOUNT THERMOSTAT AND TERMINATE WIRING

CONTRACTOR MUST CHECK AND VERIFY ALL DIMENSIONS AND CONDITIONS ON THE JOB AND REPORT DISCREPANCIES TO THE ENGINEERS BEFORE PROCEEDING WITH THE WORK. THIS DRAWING IS THE PROPERTY OF THE ENGINEERS AND MUST BE RETURNED UPON COMPLETION OF THE WORK.

DRAWINGS ARE NOT TO BE SCALED

115 West Beaver Creek Road, Unit 31 Richmond Hill, Ontario L4B 3M1 Tel: 905 882-5445 Fax: 905 882-5447 Email: cadden@attending.com			
DRAWING TITLE			
1/1 NORTH FLOOR PLAN ELECTRICAL LAYOUT			
PROJECT TITLE			
ALEXANDRA PARK			
XXXX TORONTO		ONTARIO	
DRAWN BY	CHECKED BY	SCALE	
S.O.	S.T.	1:50	
DATE	PROJECT NUMBER	DRAWING NUMBER	
FEB, 13	1313	E-19 of	

