


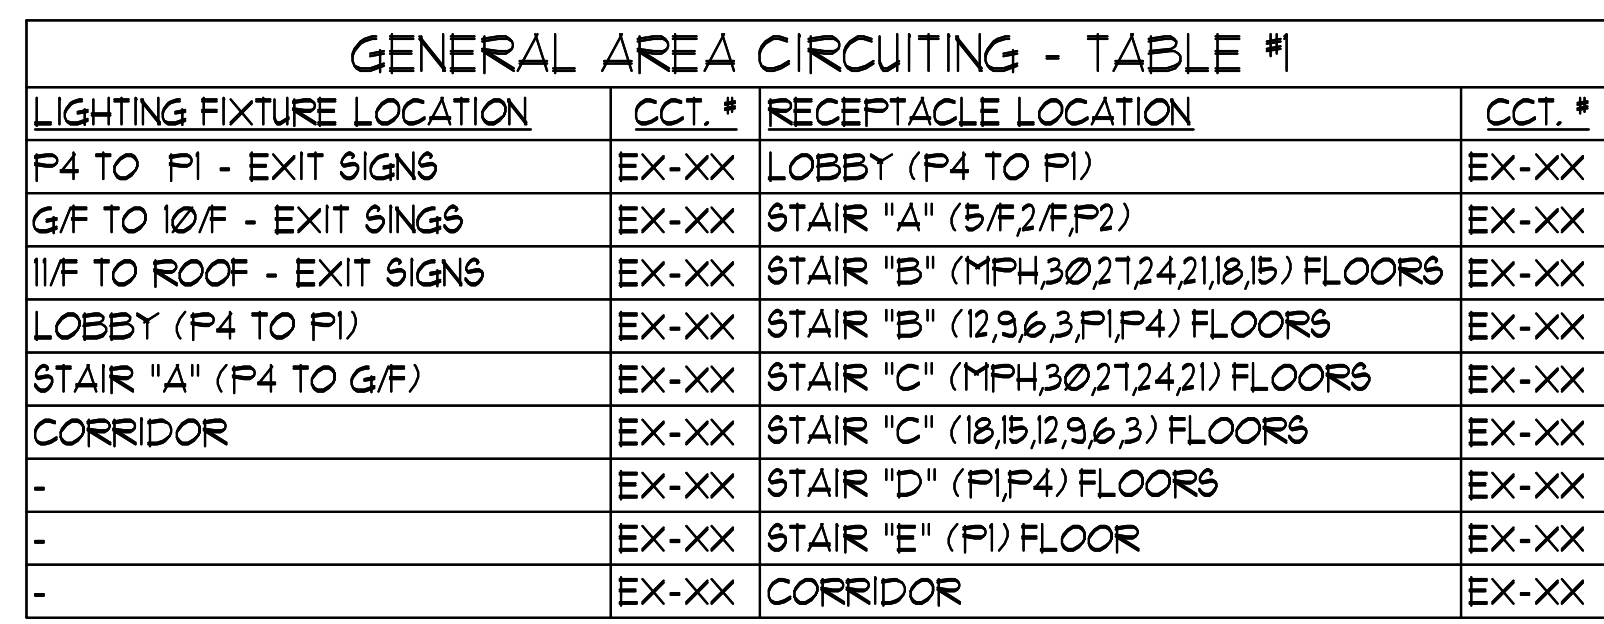

	DATE: _____	DESCRIPTION: _____
	REVISIONS	
	CONTRACTOR MUST CHECK AND VERIFY ALL DIMENSIONS AND CONDITIONS ON THE JOB, AND REPORT DISCREPANCIES TO THE ENGINEER BEFORE PROCEEDING WITH THE WORK. THIS DRAWING IS THE PROPERTY OF THE ENGINEER AND MUST BE RETURNED UPON COMPLETION OF THE WORK.	
	DRAWINGS ARE NOT TO BE SCALED	
175 West Beaver Creek Road, Unit 31 Richmond Hill, Ontario L4B 3M1 Tel: 905-882-5445 Fax: 905-882-5447 Email: cad@novatransd.com	NOVA TRANS DESIGN INC.	REGISTERED PROFESSIONAL ENGINEER 07/10/14 S.Y.-P. TAM Ontario Professional Engineer
8/8 SOUTH FLOOR PLAN ELECTRICAL LAYOUT	PROJECT TITLE: ALEXANDRA PARK	XXX TORONTO ONTARIO DRAIN BY: S.O. CHECKED BY: S.T. SCALE: 1:50 DATE: FEB, 13 PROJECT NUMBER: 1313 DRAINING NUMBER: E-20 OF
KEY PLAN	N.T.S.	