


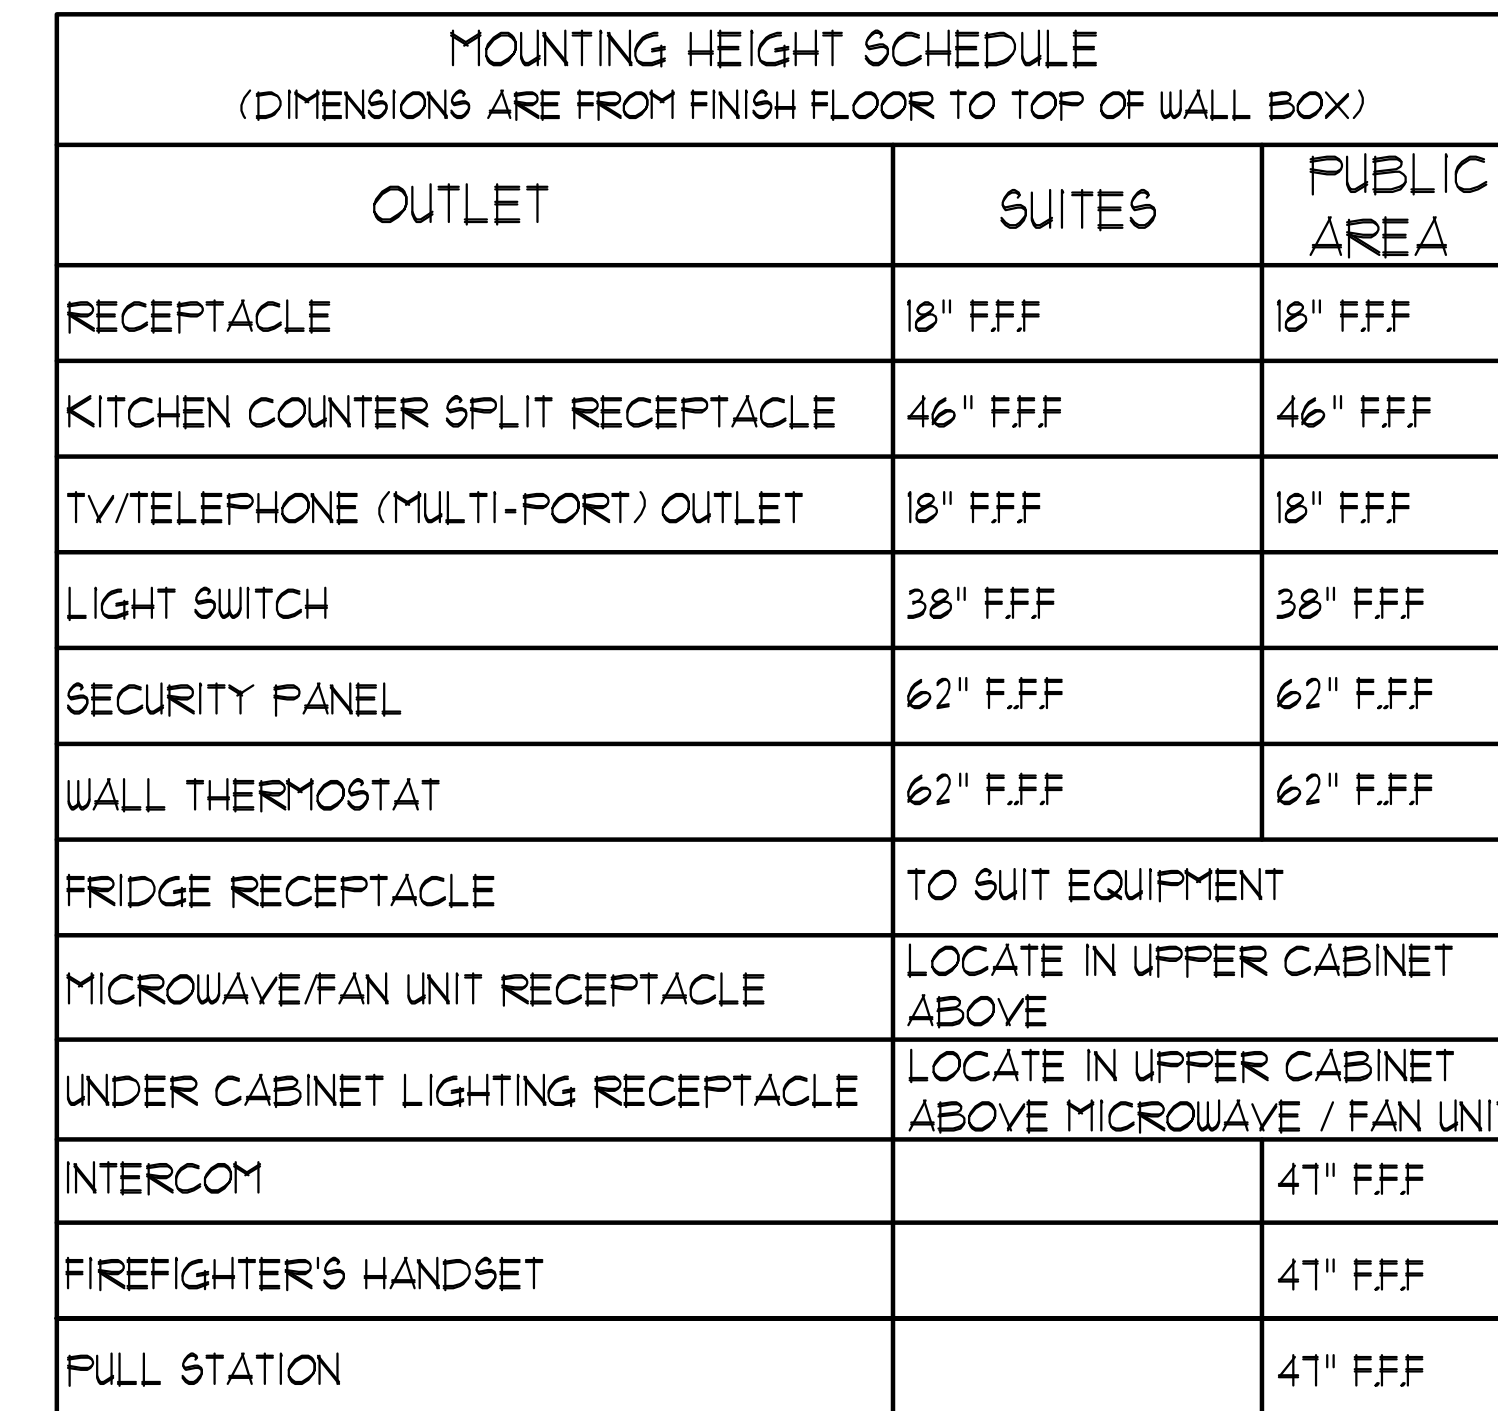

ALL DUELLING UNIT RECEPTACLES, INCLUDING KITCHEN COUNTER RECEPTACLES, OF CSA CONFIGURATION 5-1BR AND 2-2OR SHALL BE TAMPER RESISTANT RECEPTACLES WITH EXCEPTION OF RECEPTACLES PROVIDED FOR STATIONARY APPLIANCES SUCH THAT THE RECEPTACLE IS CONSIDERED ACCESSIBLE, OR THOSE LOCATED ABOVE 2m FROM THE FLOOR OR FINISHED GRADE. RULE 26-112(g) 26-112(h). BULLETIN 26-25-11.		LE/IBD	INTERCOM / INTERPHONE
5. ALL BEDROOM RECEPTACLES SHALL BE CONNECTED TO ARC-FAULT CIRCUIT BREAKERS (AFBIS).		IRB/IBD	INTERCOM / TV CABLE
		IRB/IBD	PANIC BUTTON / PANIC INTERCOM STATION
6. RECEPTACLES INSTALLED IN A DINING AREA FORMING PART OF A KITCHEN OF A DWELLING UNIT SHALL BE SUPPLIED BY A BRANCH CIRCUIT THAT DOES NOT SUPPLY ANY OTHER OUTLETS. RULE 26-127(c).		SR	CARD READER
		ZKAR/IBD	AUTOMATIC RELEASE CARD ACCESSARIO
		IBD	ELECTRIC STRIKE
		IBD	MAGLOCK
		IBD	DOOR CONTACT / WINDOW CONTACT
		IBD	AUTOMATIC DOOR OPERATOR
		IBD	MOTION DETECTOR
		IBD	PUSH BUTTON
		IBD	SECURITY CAMERA

BR/DO/4	1	MAILED FOR PERMIT	6.1
DATE	NO.	DESCRIPTION	BY
THANK YOU! ALL PRINTS DATED PREVIOUS TO FINAL DATE ABOVE			
REVISIONS			
CONTRACTOR MUST CHECK AND VERIFY ALL DIMENSIONS AND CONDITIONS ON THE JOB AND REPORT DISCREPANCIES TO THE ENGINEER BEFORE PROCEEDING WITH THE WORK. THIS DRAWING IS THE PROPERTY OF THE ENGINEER AND MUST BE RETURNED UPON COMPLETION OF THE WORK. DRAWINGS ARE NOT TO BE SCALED			

		
KEY PLAN		

DRAWING TITLE: S/F NORTH FLOOR PLAN ELECTRICAL LAYOUT	116 West Beaver Creek Road, Unit 31 Richmond Hill, Ontario L4B 3H1 Tel: 905 882-5445 Fax: 905 882-5441 Email: cask@trendeng.com
PROJECT TITLE: ALEXANDRA PARK	
XXX TORONTO ONTARIO	
DRAWN BY: S.O.	CHECKED BY: S.T.
DATE: FEB, 13	PROJECT NUMBER: 1313
DRAWING NUMBER: E-21 OF	