
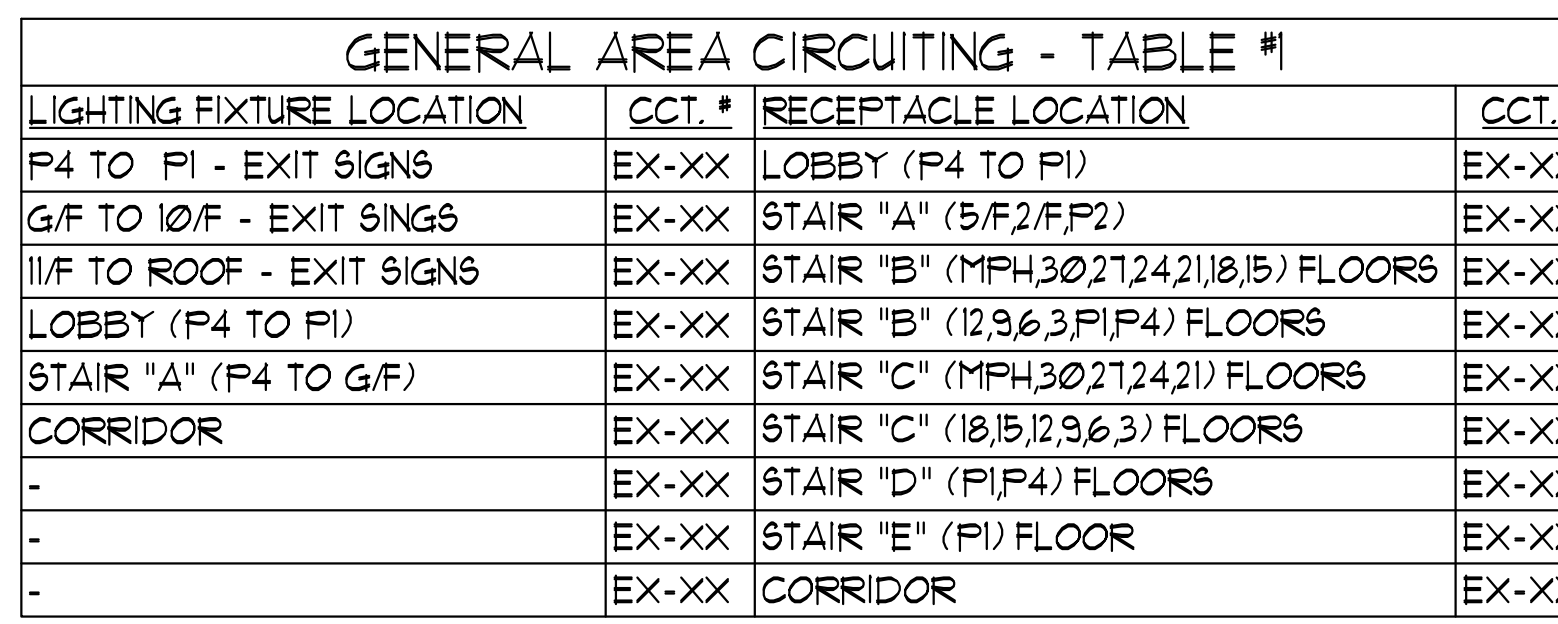


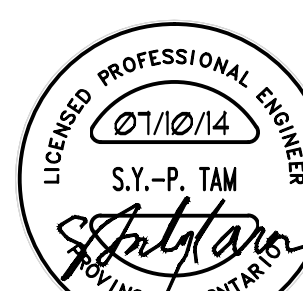

- | | | | | | | | |
|---|--|-------------------------------|----------------------------|-----------------------|-------------------------|--------------------------------|-------------------------------|
|  | <p>ON THE JOB AND REPORT DISCREPANCIES TO THE ENGINEER BEFORE PROCEEDING WITH THE WORK. THIS DRAWING IS THE PROPERTY OF THE ENGINEER. IT NOT BE LOANED, REPRODUCED OR COPIED FOR ANY WORK.</p> <p>DRAWINGS ARE NOT TO BE SCALED</p> <div style="display: flex; justify-content: space-around; align-items: center;"> <div style="text-align: center;">  <p>NOVA
ARCHITECTURE
EST. 1987</p> </div> <div style="text-align: center;">  </div> </div> | | | | | | |
| | <p>175 West Beaver Creek Road, Unit 31
Richmond Hill, Ontario L4B 3M1
Tel: 905-882-5445
Fax: 905-882-5447
Email: cad@novarchitect.com</p> <p>DRAWING TITLE:
2/F NORTH FLOOR PLAN
ELECTRICAL LAYOUT</p> | | | | | | |
| | <p>PROJECT TITLE:
ALEXANDRA PARK</p> <p>XXX TORONTO ONTARIO</p> <table border="1" style="width: 100%;"> <tr> <td>DESIGN BY:
S.O.</td> <td>CHECKED BY:
S.T.</td> <td>SCALE:
1:50</td> </tr> <tr> <td>DATE:
FEB, 13</td> <td>PROJECT NUMBER:
1313</td> <td>DRAWING NUMBER:
E-3</td> </tr> </table> <p style="text-align: right;">OF</p> | DESIGN BY:
S.O. | CHECKED BY:
S.T. | SCALE:
1:50 | DATE:
FEB, 13 | PROJECT NUMBER:
1313 | DRAWING NUMBER:
E-3 |
| DESIGN BY:
S.O. | CHECKED BY:
S.T. | SCALE:
1:50 | | | | | |
| DATE:
FEB, 13 | PROJECT NUMBER:
1313 | DRAWING NUMBER:
E-3 | | | | | |
| <p>KEY PLAN</p> | <p>N.T.S.</p> | | | | | | |