


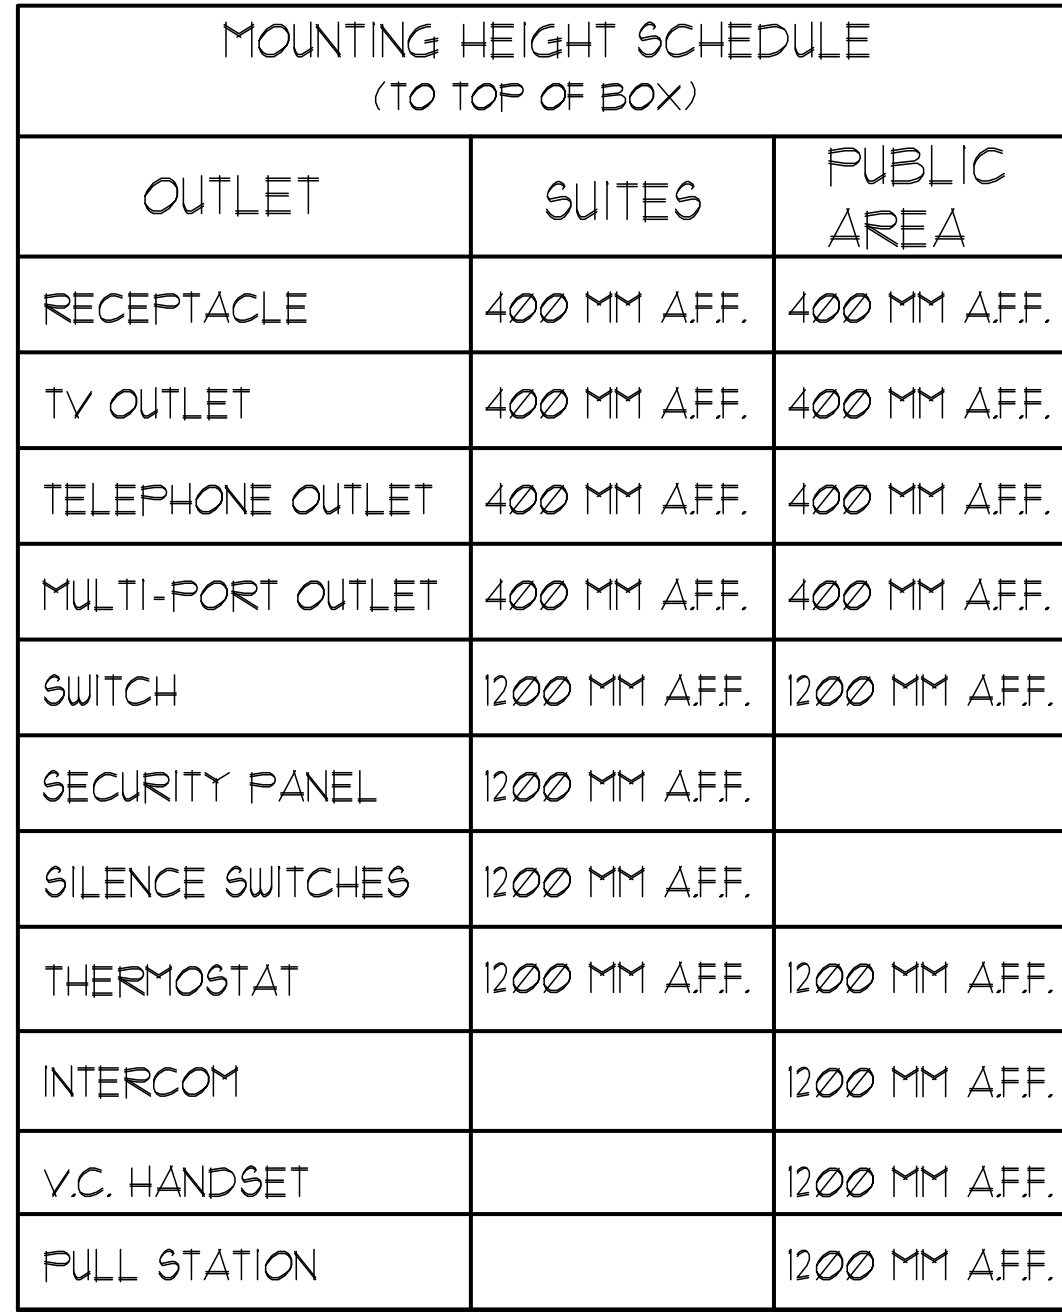


- KEY NOTES - RESIDENTIAL - COMMON AREA:

[illegible]

REVISIONS	
CONTRACTOR MUST CHECK AND VERIFY ALL DIMENSIONS AND CONDITIONS ON THE JOB AND REPORT DISCREPANCIES TO THE ENGINEERS BEFORE PROCEEDING WITH THE WORK. THIS DRAWING IS THE PROPERTY OF THE ENGINEERS AND MUST BE RETURNED UPON COMPLETION OF THE WORK.	
DRAWINGS ARE NOT TO BE SCALED	

		
175 Beaver Creek Road, Unit 3 Richmond Hill, Ontario L4B 3M1 Tel: 905-882-5445 Fax: 905-882-5441 Email: sales@vstrading.com		
PROJECT: 3/4 NORTH FLOOR PLAN ELECTRICAL LAYOUT		
PROJECT FILE: ALEXANDRA PARK		
38 CAMERON STREET, BLOCK 11 ONTARIO TORONTO		
DATE: 9.0.	DRAWN BY: ST.	SCALE: 1:50
DATE: FEB. 13	PROJECT NUMBER: 1313	DRAWING NUMBER: E-11 of

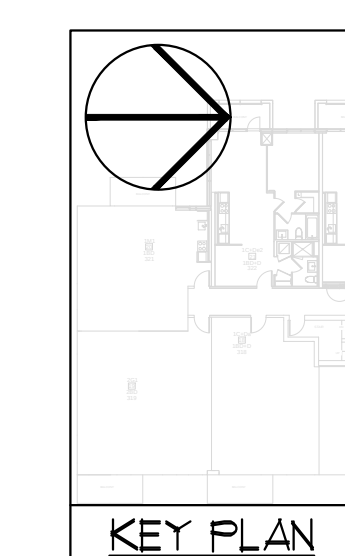

NTS

PROJECT TITLE: ALEXANDRA PARK		
38 CAMELTON STREET, BLOCK II TORONTO ONTARIO		
DRAWN BY: S.O.	CHECKED BY: S.T.	SCALE: 1:50
DATE: FEB, 13	PROJECT NUMBER: 1313	DRAWING NUMBER: E-11 OF