


KEY NOTES - INSULITE:

- 1) DESIGNATED "LAUNDRY RECEPTACLE" AS DEFINED BY ESA CODE 26-710(X11), 26-710(X1) AND ESA BULLETIN 26-26-0 (WITHIN 3m RADIUS OF LAUNDRY CLOSET). RECEPTACLE SHALL BE CONNECTED TO A DEDICATED CIRCUIT. SEE DETAIL #4 ON DUG. E-35.
- 2) SUITE DOOR CONTACTS AND GLASS BREAK DETECTOR WILL COMPLETE WITH INTRUSION ALARM SYSTEM THAT CONTACT TO THE CONCIERGE STATION. (TYPICAL)
- 3) FOR FAN COIL UNITS (FCU) ELECTRICAL CONTRACTOR TO SUPPLY AND INSTALL CONDUIT AND JUNCTION BOX FOR RECEPTACLE THERMOSTAT. MECHANICAL CONTRACTOR SHALL SUPPLY WIRE, TERMINATE WIRING AND MOUNT THERMOSTAT.
- 4) INSTALL SIDE-MOUNTED RECEPTACLE ON KITCHEN ISLAND CABINET.

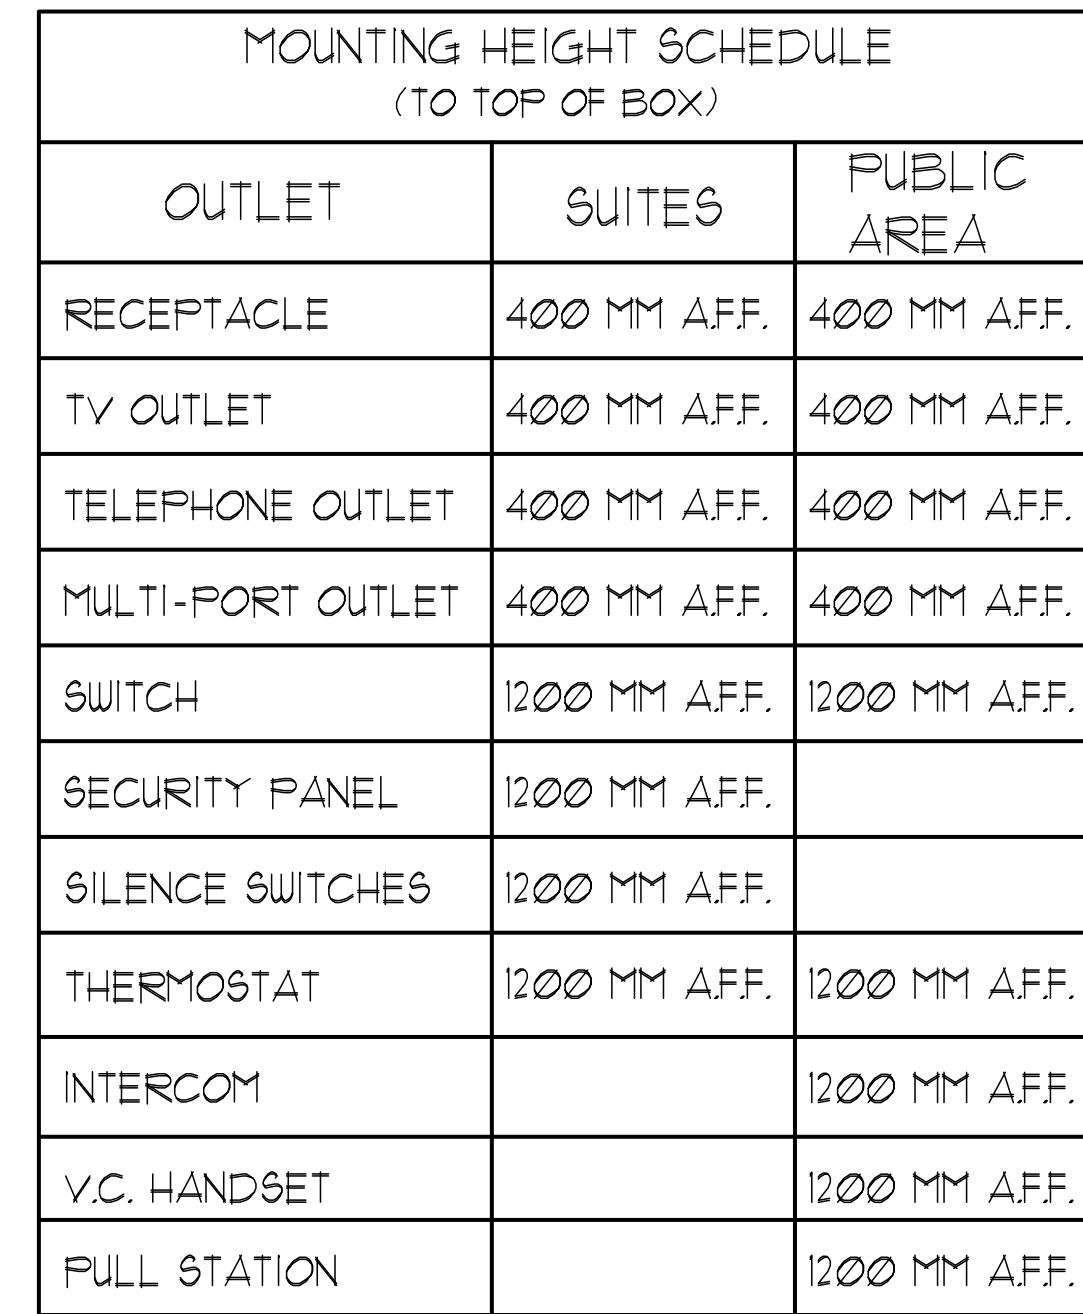

- ## KEY NOTES - RESIDENTIAL - COMMON AREA:
- (1) FOR CIRCUITING, REFER TO TABLE #1.
 - (8) PROVIDE ALARM SPEAKER, SMOKE DETECTOR AND RECEPTACLE AT EVERY THIRD FLOOR STAIR WELL, STARTING FROM TOP FLOOR, AS PER T. DUG. E-32 FOR FIRE ALARM RISER DIAGRAM.
INSTALL SIDE-MOUNTED RECEPTACLE ON KITCHEN ISLAND CABINET.
 - (9) PROVIDE TELECOMMUNICATION BACKBOARD C/W 115V, 1A, 15A RECEPTACLE AS PER COMMUNICATION RISER DIAGRAM ON DUG. E-31.
 - (10) CONTRACTOR SHALL REFER TO ELECTRICAL SINGLE LINE DIAGRAM ON DUG. E-30 AND SDP RISER ON DUG. E-31 FOR RDP LOCATIONS AND DISTRIBUTION.
 - (11) PROVIDE CONDUIT AS PER RISER DETAIL #3 ON DUG. E-35 FOR BISSOR/TRISOR/CONTROL SYSTEM.
 - (13) REFER TO SUPERVISED VALVE AND FLOW SWITCH SCHEDULE ON DUG. E-33 FOR DETAILS ON TYPICAL FLOORS.

CONTRACTOR MUST CHECK AND VERIFY ALL DRAWINGS AND CONDITIONS BEFORE PROCEEDING WITH THE WORK. THE ENGINEER BEHINDS PROVIDING THE WORK. THIS DRAWING IS THE PROPERTY OF THE ENGINEER AND MUST BE RETURNED TO HIM/HER IMMEDIATELY AFTER THE WORK.			
DRAWINGS ARE NOT TO BE SCALED			
			
1715 West Beaver Creek Road, Unit 31 Richmond Hill, Ontario L4B 3H1 Tel: 905 882-5445 Fax: 905 882-5447 Email: cad@novatrend.com www.novatrend.com			
PROJECT TITLE: 4/F SOUTH FLAN PLAN ELECTRICAL LAYOUT			
PROJECT ADDRESS: ALEXANDER PARK			
38 CAMERON STREET, BLOCK II TORONTO, ONTARIO			
DRAWN BY: S.O.	CHECKED BY: S.T.	SCALE: 1:50	
DATE: FEB, 13	PROJECT NUMBER: 1313	DRAWING NUMBER: E-12 OF	