
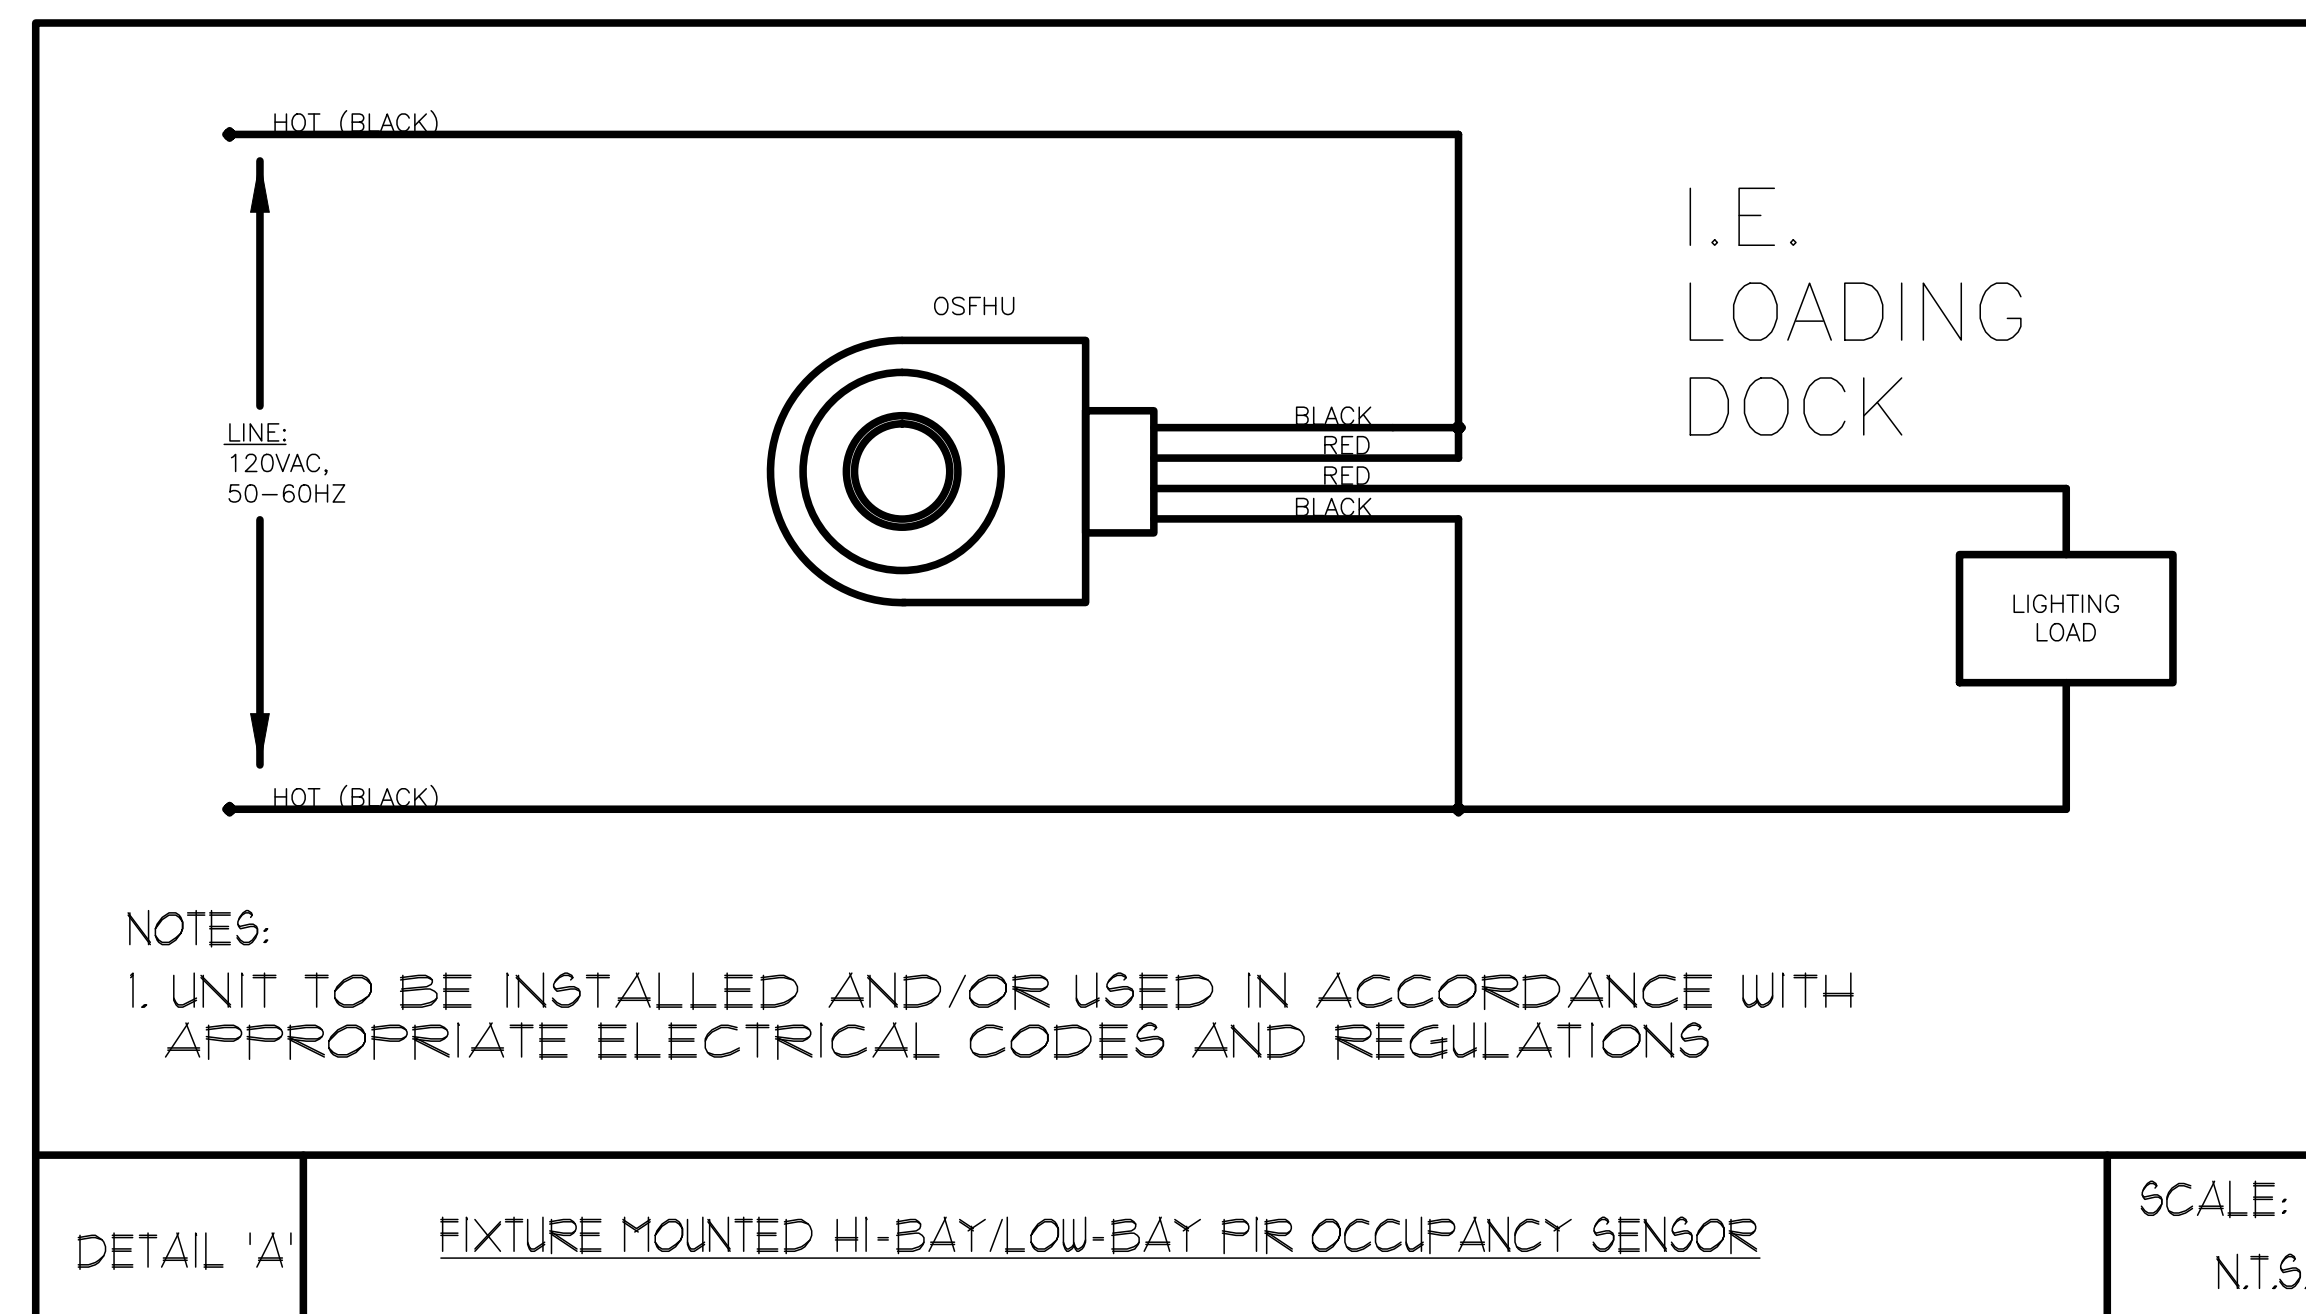


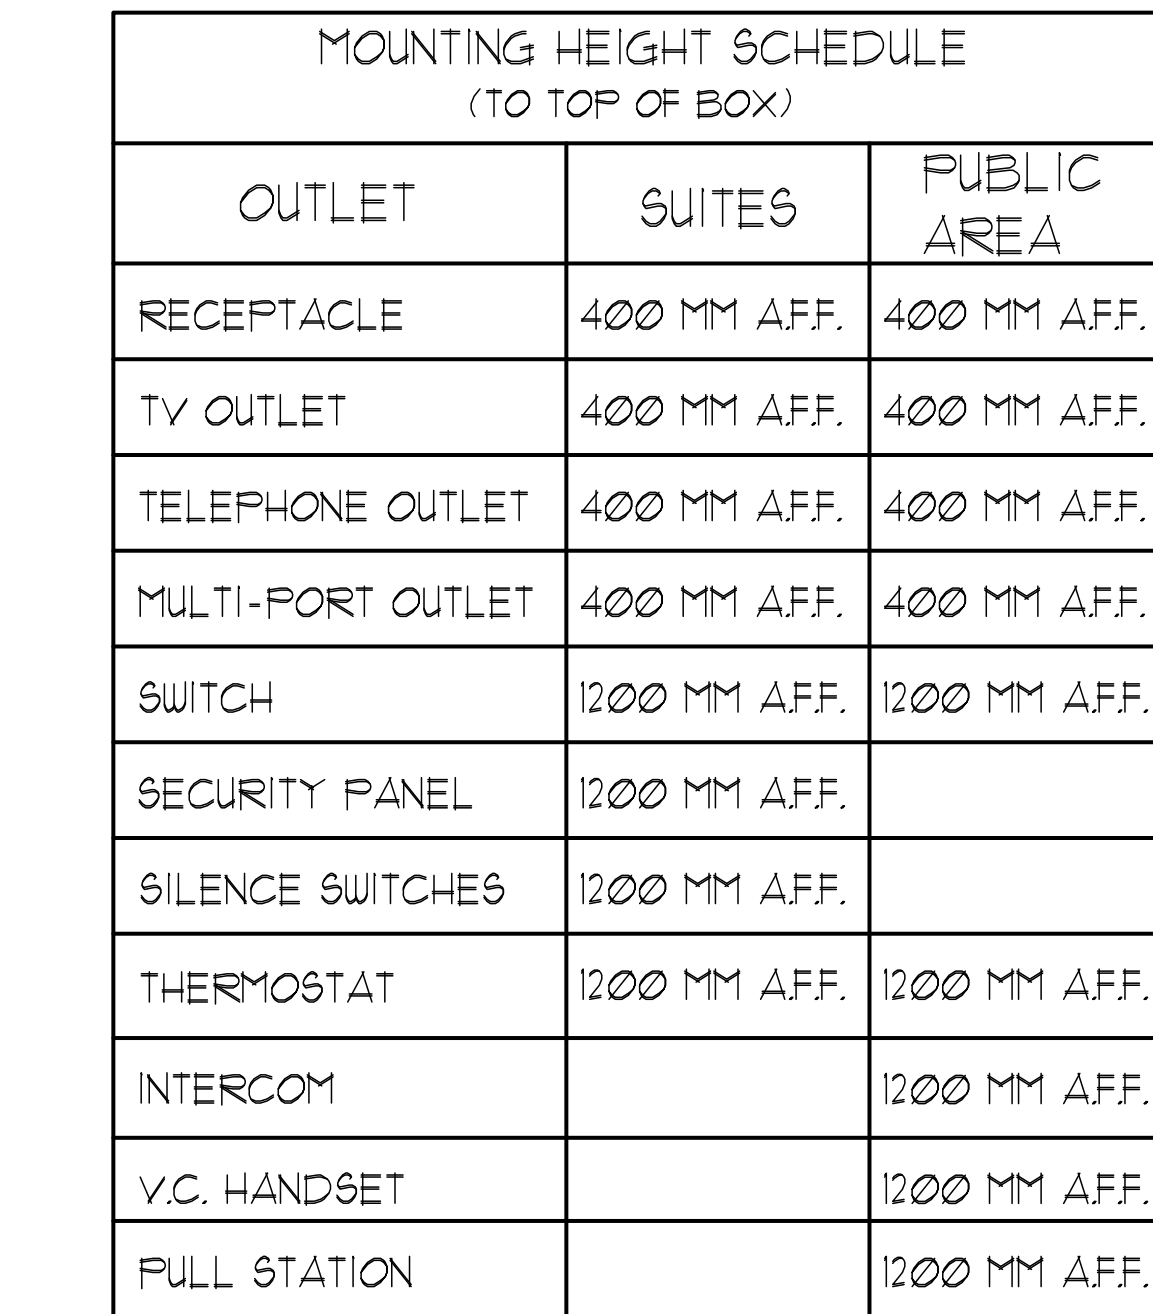

- | ELECTRICAL LEGEND | |
|-------------------|---|
| LIGHTING | |
| | FLUORESCENT LIGHT FIXTURE, TYPE AS INDICATED |
| | NIGHT LIGHT |
| | EMERGENCY POWER |
| | GANGED MOUNTED PENDANT LIGHT FIXTURE,
INSCRIBED LETTERS DENOTES TYPE |
| | PENDANT LIGHT FIXTURE,
INSCRIBED LETTERS DENOTES TYPE |
| | GANGED CEILING LIGHT OUTLET |
| | TRACK LIGHT |
| | STREET LIGHT |
| | CEILING MOUNTED FLUORESCENT LIGHT FIXTURE |
| | CEILING MOUNTED PENDANT EXIST. SIGN |
| | SINGLE ENDED FLUORESCENT LAMP REMOTE HEAD |
| | OCCUPANCY SENSOR POWER PACKS |
| | 1/3 SINGLE/THREE POLE, SINGLE/THREE
THROW TOGGLE SWITCH RESPECTIVELY |
| | 1/3 SINGLE/THREE POLE, SINGLE/THREE
THROW PILOT LIGHT RESPECTIVELY |
| | MASTER LIGHTING SHUT-OFF SWITCH |
| | SINGLE PHASE SPLIT WIRE FUSED
OCCUPANCY SENSOR, CEILING MOUNTED |
| POWER | |
| | REGULAR DUPLEX RECEPTACLE |
| | DUPLEX RECEPTACLE GROUND FAULT INTERRUPT |
| | 3-WIRE 1-BOLT DUPLEX RECEPTACLE |
| | SINGLE RECEPTACLE TYPE AND CONFIGURATION
AS INDICATED FOR POWER FACTOR |
| | CONNECTION FOR OVERVOLTAGE
PROTECTION |
| | ABOVE COUNTER DEVICE |
| | FIXED MOUNTED DEVICES |
| | FLOOR MOUNTED DEVICES |
| | DISCONNECT SWITCH NON-RATED |
| | DISCONNECT SWITCH RATED |
| | CONNECTION STARTER |
| | TERMINAL, MOTORBAR DIRECT CONNECTION |
| | DIRECT CONNECTION, SINGLE PHASE |
| | DIRECT CONNECTION, THREE PHASE |
| | THERMOSTAT |
| | ORDER NUMBER |
| | HEAT TRACE |
| | ELECTRICAL HEATER |
| | ELECTRICAL PANEL / SECURITY PANEL |
| TELECOMMUNICATION | |
| | TIE CABLE OUTLET |
| | TELEPHONE OUTLET |
| | TELEPHONE / CABLE (MULTI-PORT) OUTLET |
| | DATA/TELEPHONE OUTLET |
| | IN SUITE TELEPHONY BOX/CABLE RECEPTACLE |
| | JF |
| | MUSIC SPEAKER / VOLUME CONTROL |
| | RADIO RECEIVER |
| SECURITY | |
| | INTERCOM / INTERPHONE |
| | INTERCOM WITH CAMERA |
| | PANIC BUTTON / PANIC INTERCOM STATION |
| | AUTOMATIC RELEASE CARD ACCESS-RADIO
RECEIVER |
| | ALARM STRIKE |
| | MAGNETIC |
| | DOOR CONTACT / WINDOW CONTACT |
| | GLASS BREAK DETECTOR |
| | AUTOMATIC DOOR OPERATOR |
| | MOTION DETECTOR |
| | PUSH BUTTON |
| | SECURITY CAMERA |
| LIFE SAFETY | |
| | FIRE ALARM SMOKE DETECTOR |
| | SMOKE ALARM |
| | FIRE ALARM DUTY TIME SMOKE DETECTOR |
| | FIRE ALARM HEAT DETECTOR |
| | FIRE ALARM TO PRESSURE HEAT DETECTOR |
| | MOISTURE PROOF HEAT DETECTOR |
| | CO ALARM |
| | CONCENTRATION SMOKE / CO ALARM |
| | SENSOR / NO SENSOR |
| | FIRE ALARM MANUAL PULL STATION |
| | FIRE EXTINGUISHER |
| | FIRE ALARM STROBE/HORN, WALL MTD |
| | FIRE ALARM HORN, WALL MTD |
| | FIRE ALARM SPEAKER/STROBE CEILING MTD |
| | FIRE ALARM SPEAKER, CEILING MTD |
| | FIRE ALARM ANNUNCIATOR, CEILING MTD |
| | FIRE ALARM ALARM PANEL |

[illegible]

MARK VOID ALL PRINTS DATED PREVIOUS TO FINAL DATE ABOVE

REVISIONS

CONTRACTOR MUST CHECK AND VERIFY ALL DIMENSIONS AND CONDITIONS ON THE JOB AND REPORT DISCREPANCIES TO THE ENGINEERS BEFORE PROCEEDING WITH THE WORK. THIS DRAWING IS THE PROPERTY OF THE ENGINEERS AND MUST BE RETURNED UPON COMPLETION OF THE WORK.

DRAWINGS ARE NOT TO BE SCALED



175 West Beaver Creek Road, Unit 31
Richmond Hill, Ontario L4B 3M1
Tel: 905 882-5445
Fax: 905 882-5447
Email: cad@novatrendeng.com

DRAWING TITLE:
2/F NORTH FLOOR PLAN
ELECTRICAL LAYOUT

PROJECT TITLE:
ALEXANDRA PARK

38 CAMERON STREET, BLOCK II
TORONTO ONTARIO

DRAWN BY: S.O.	CHECKED BY: S.T.	SCALE: 1:50
DATE: FEB, 13	PROJECT NUMBER: 1313	DRAWING NUMBER: E-9 OF