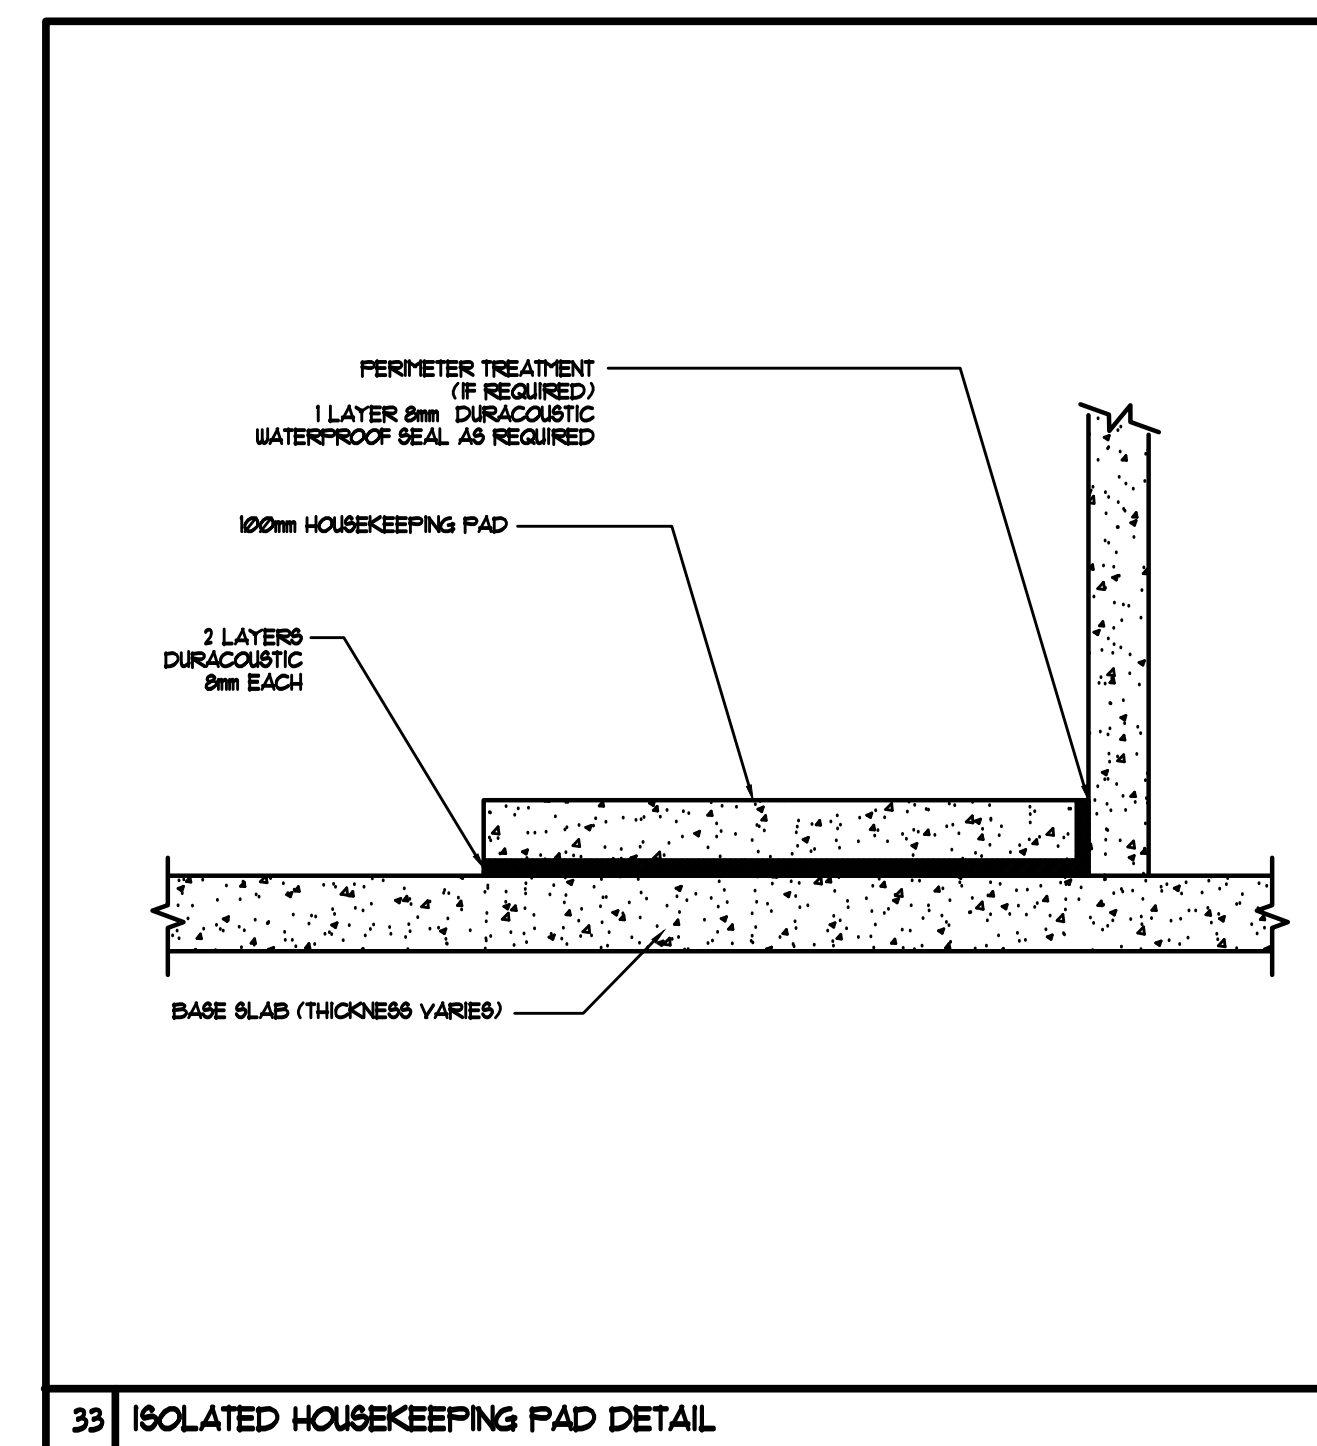
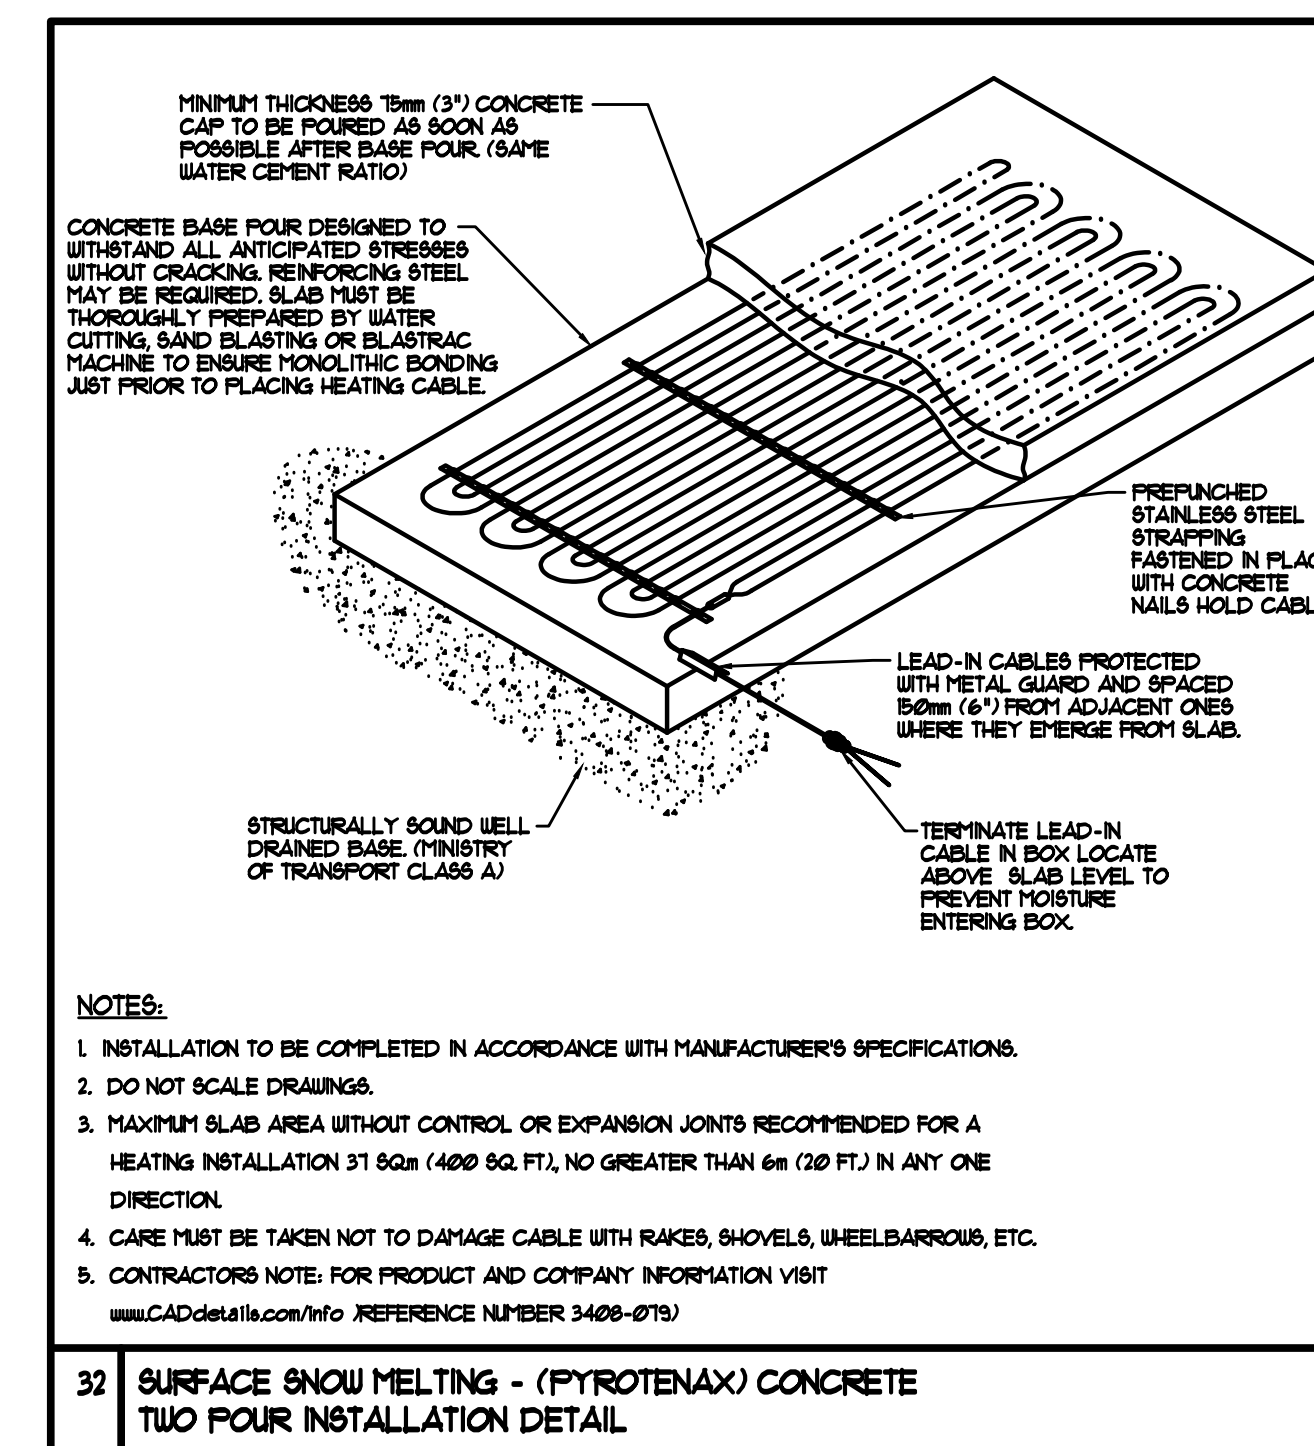
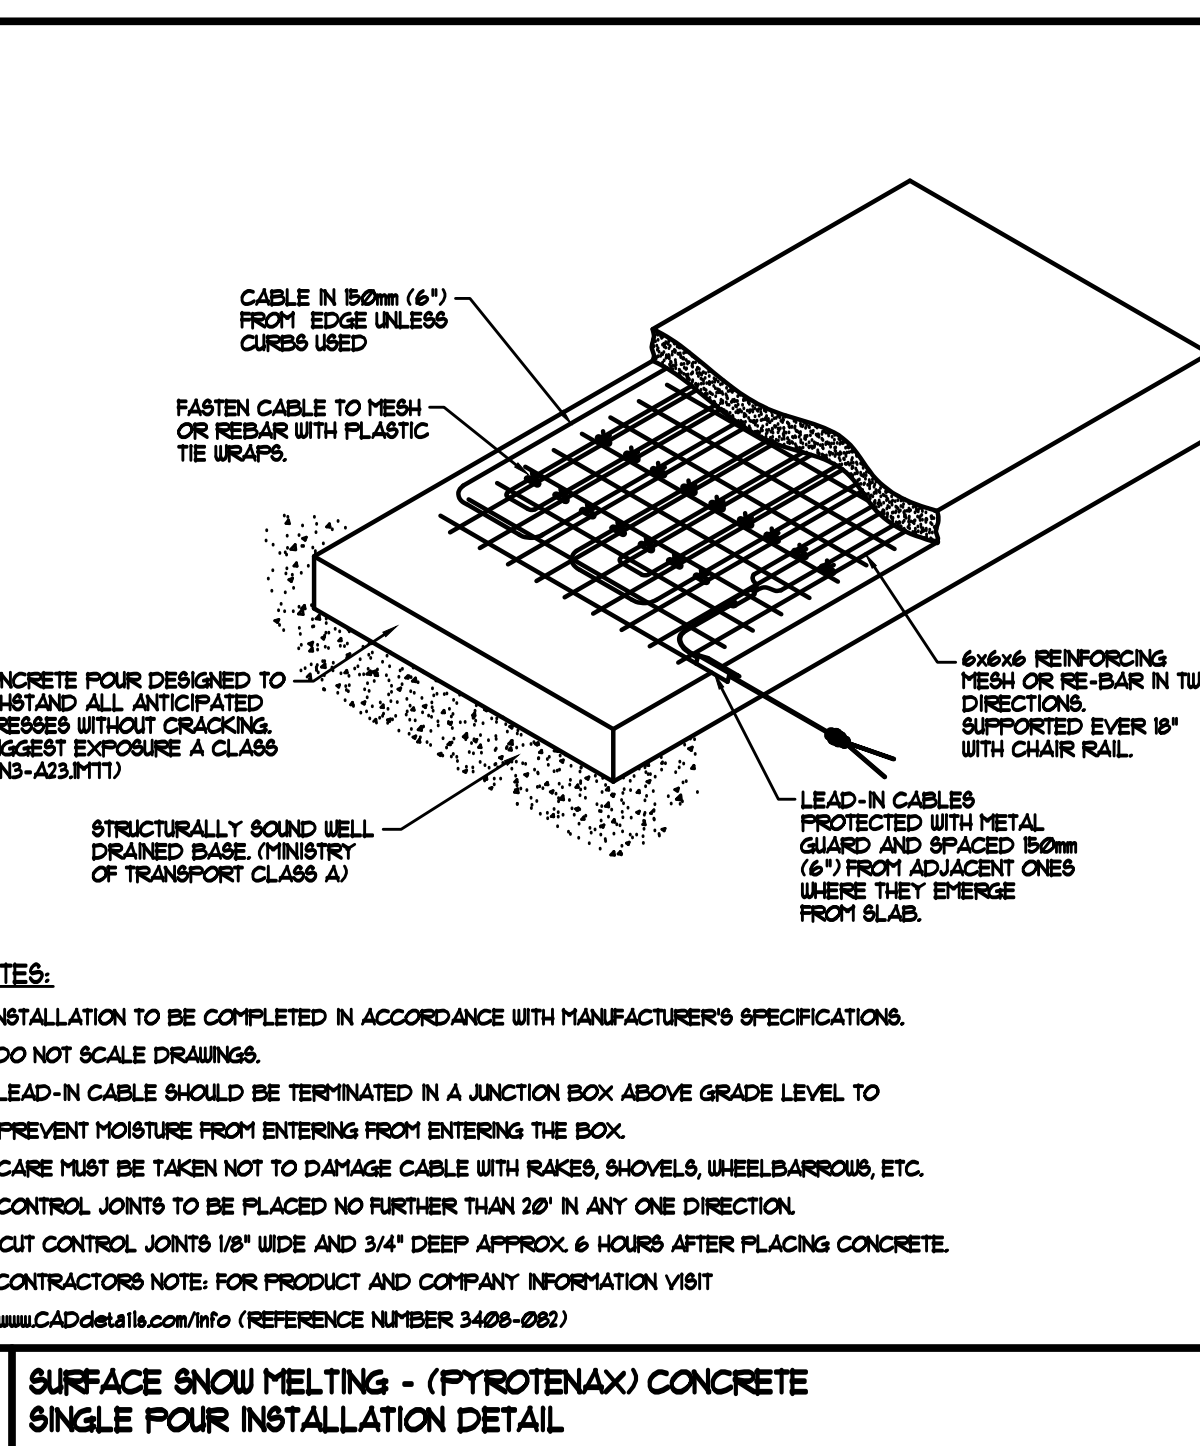
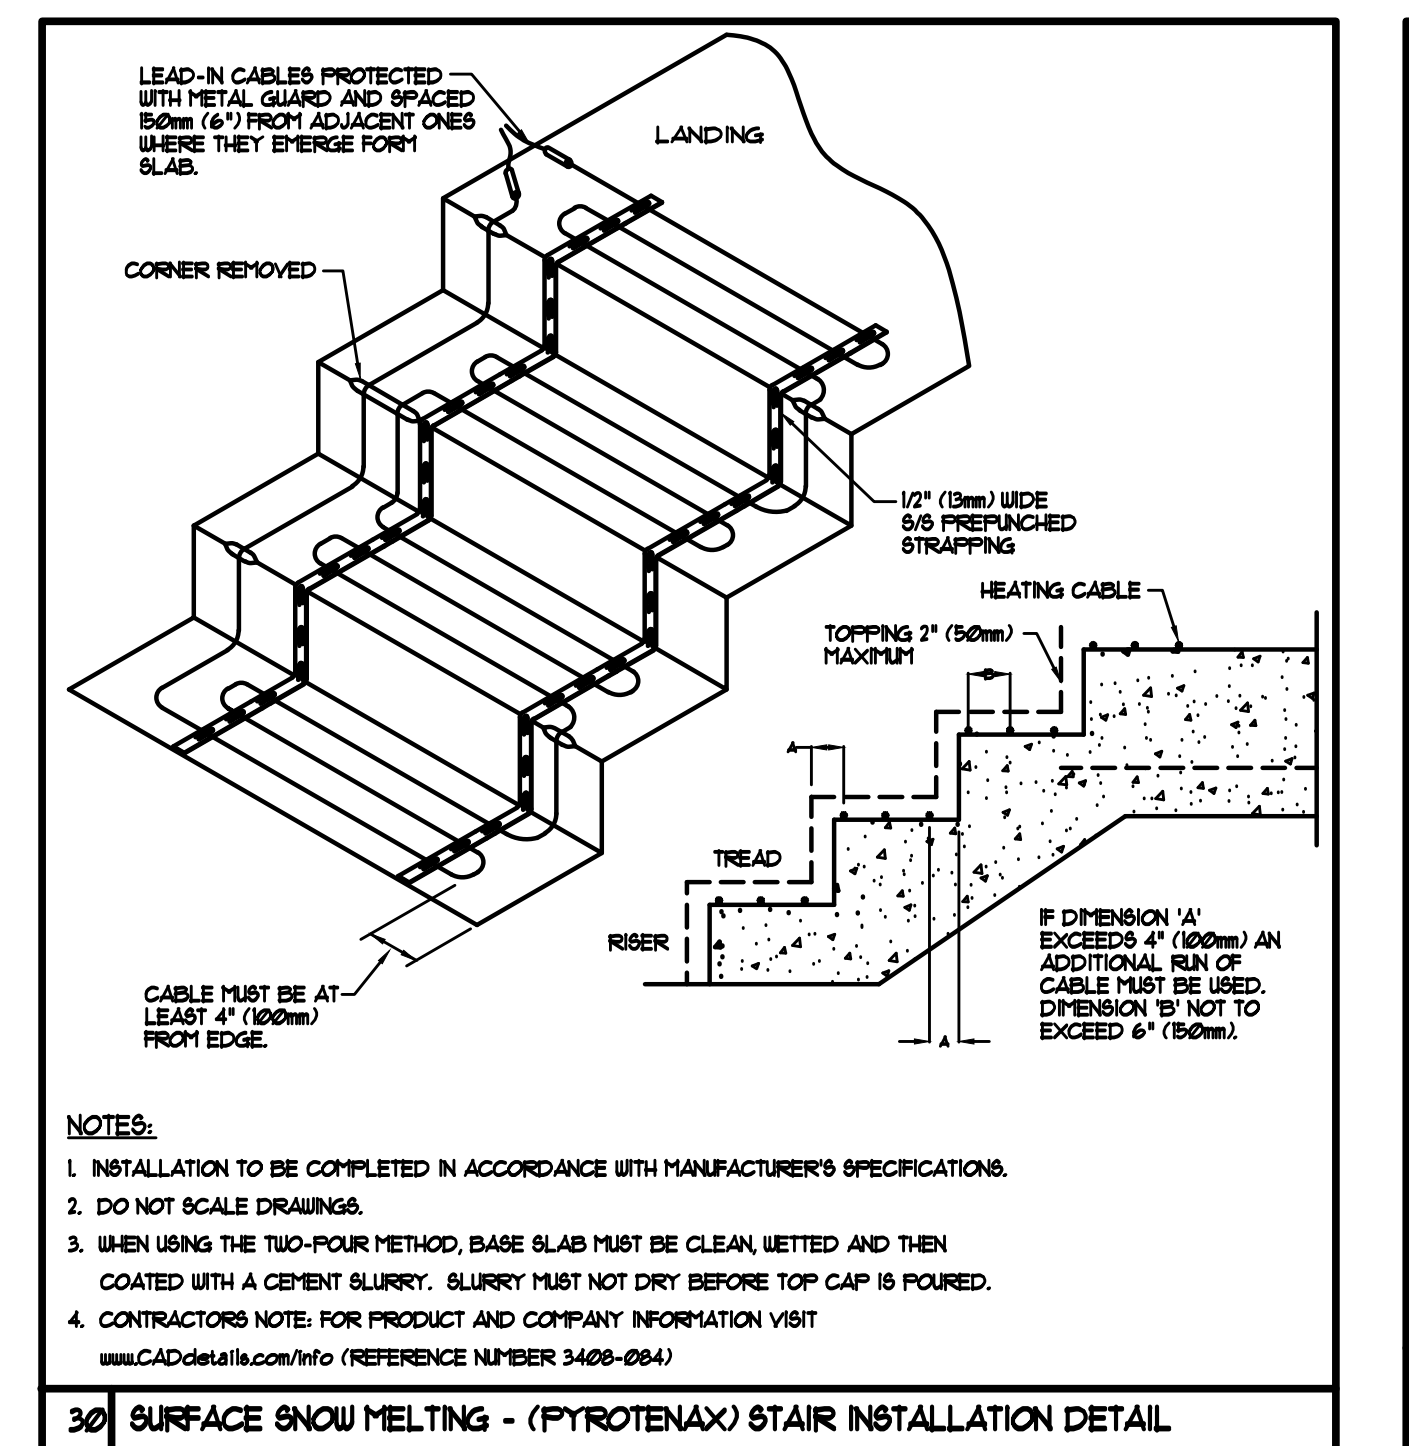
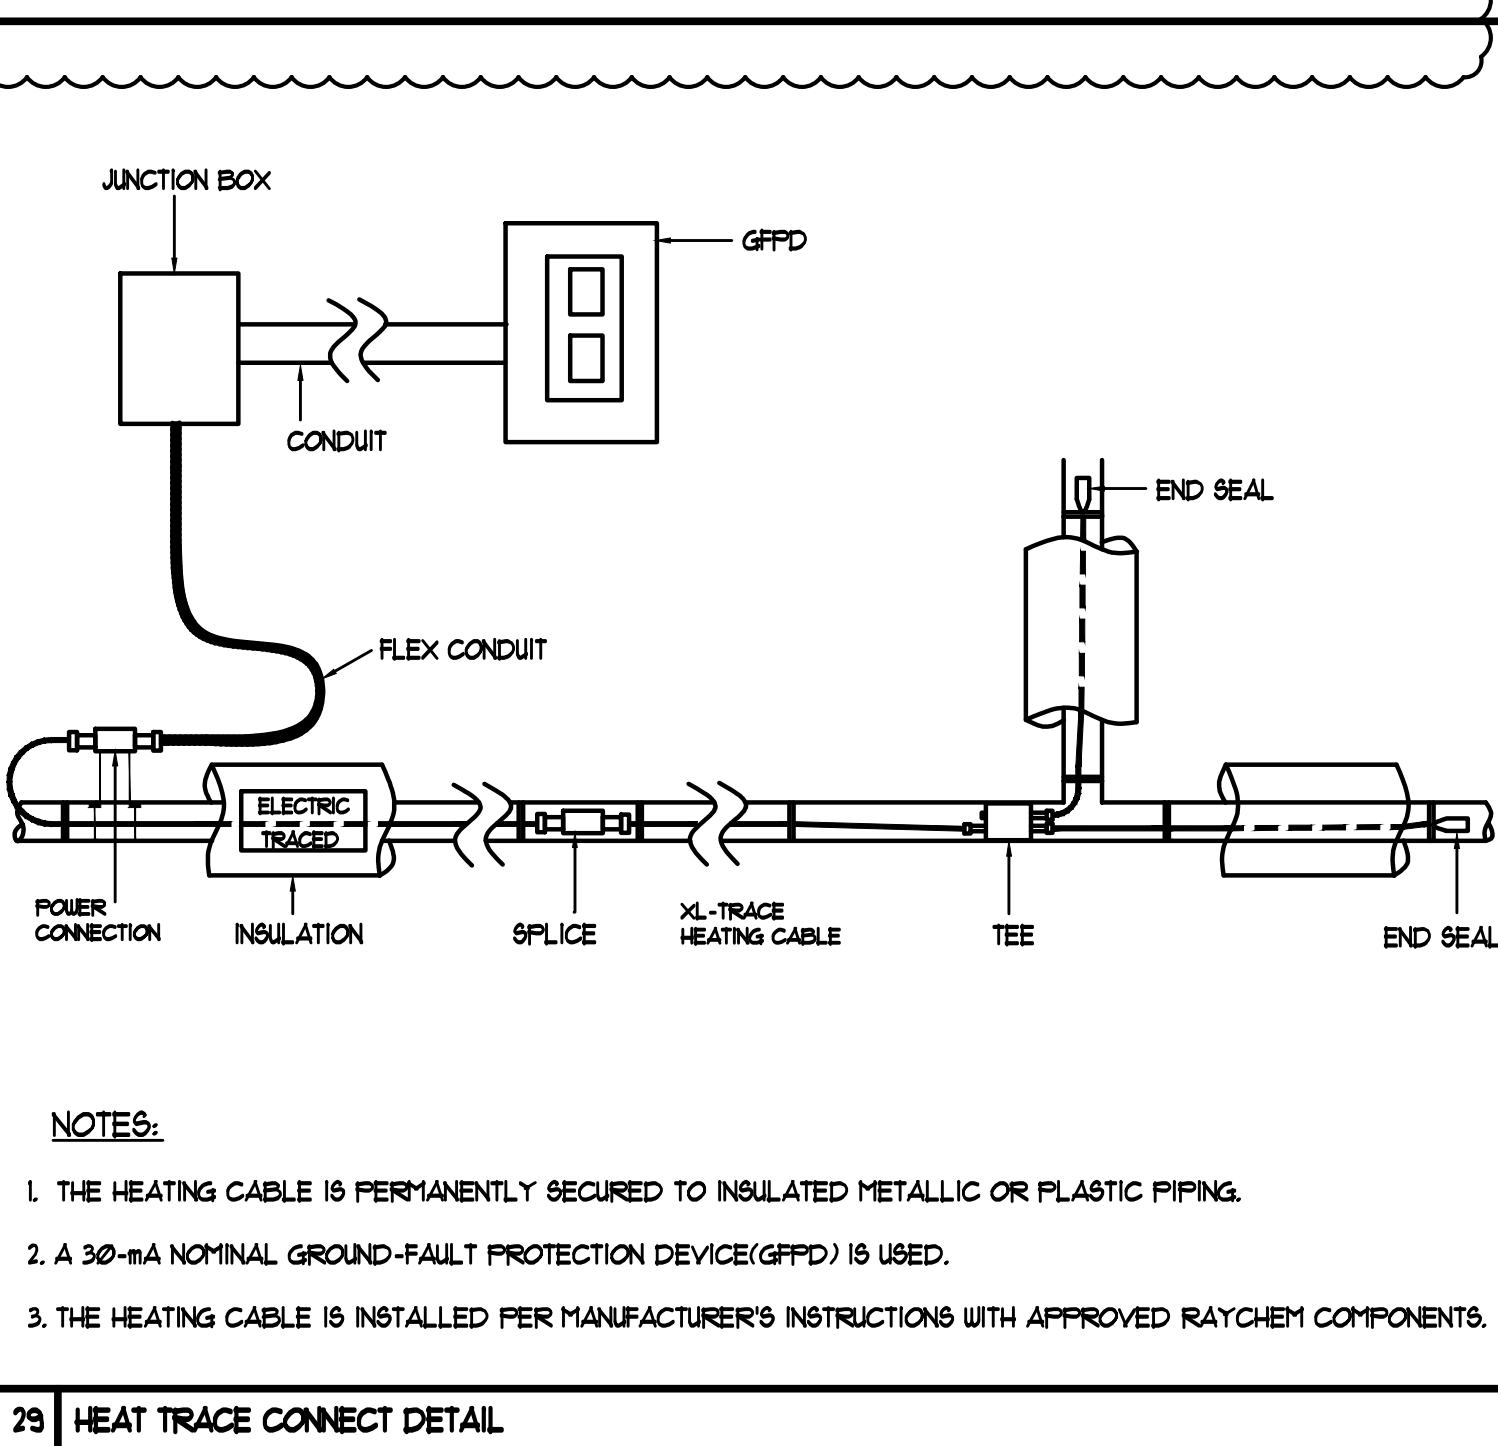
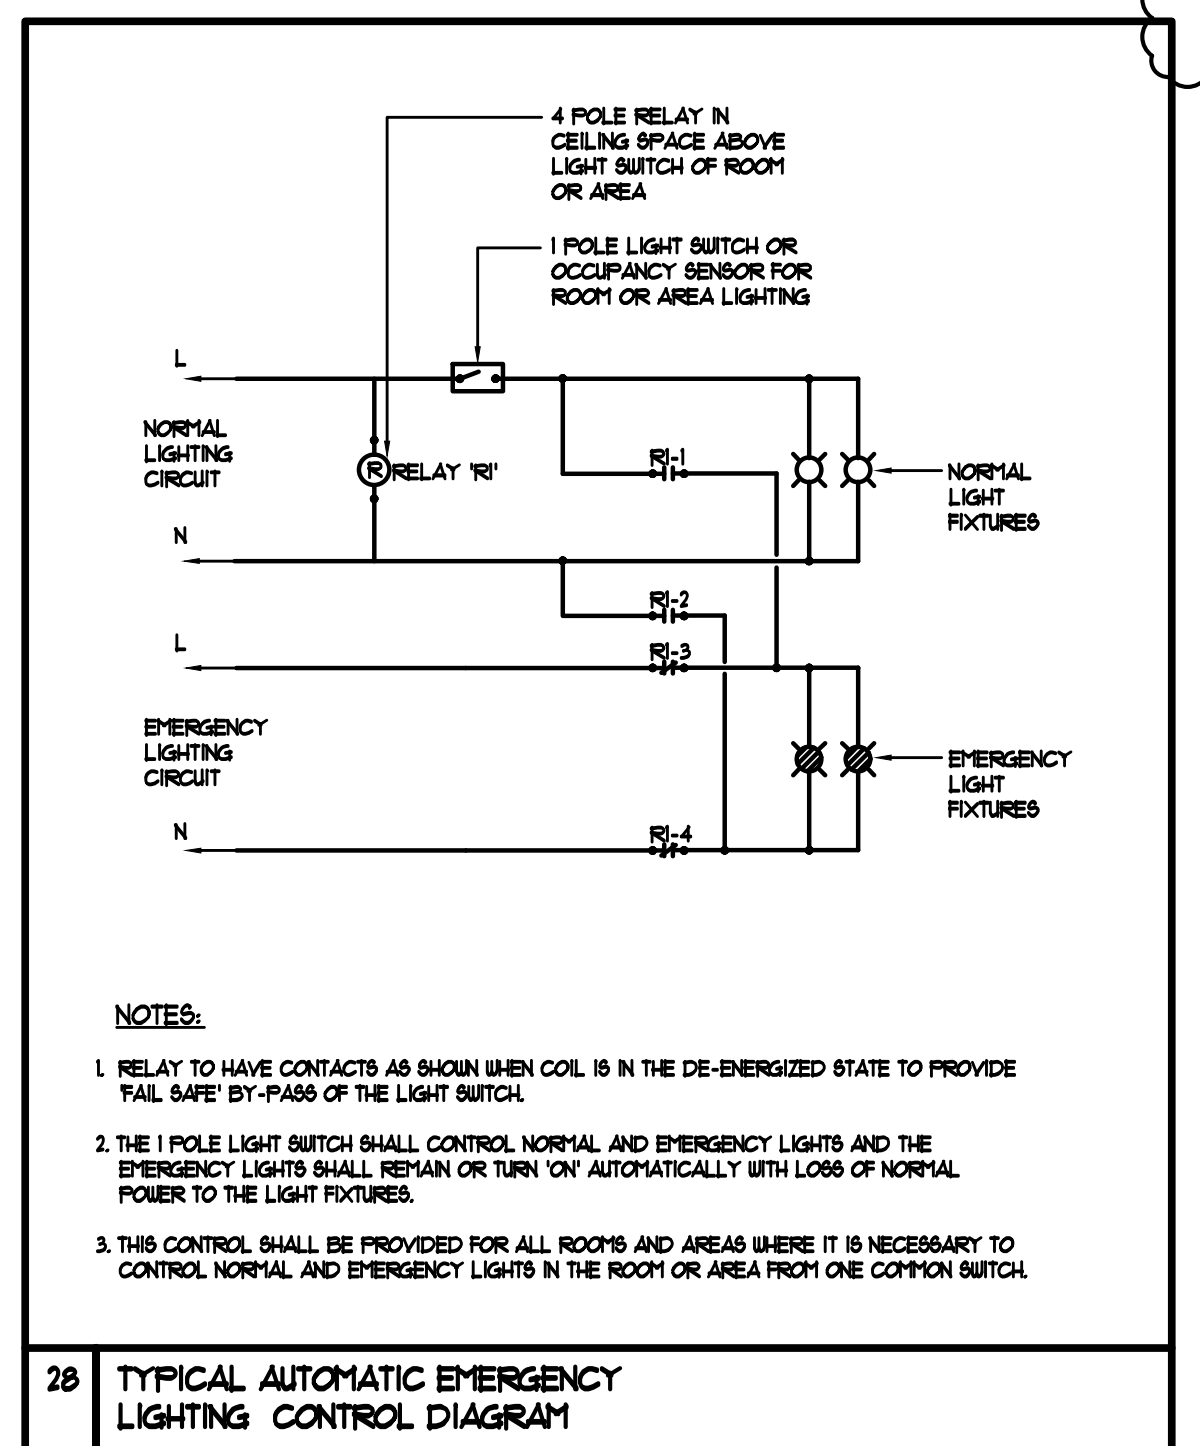
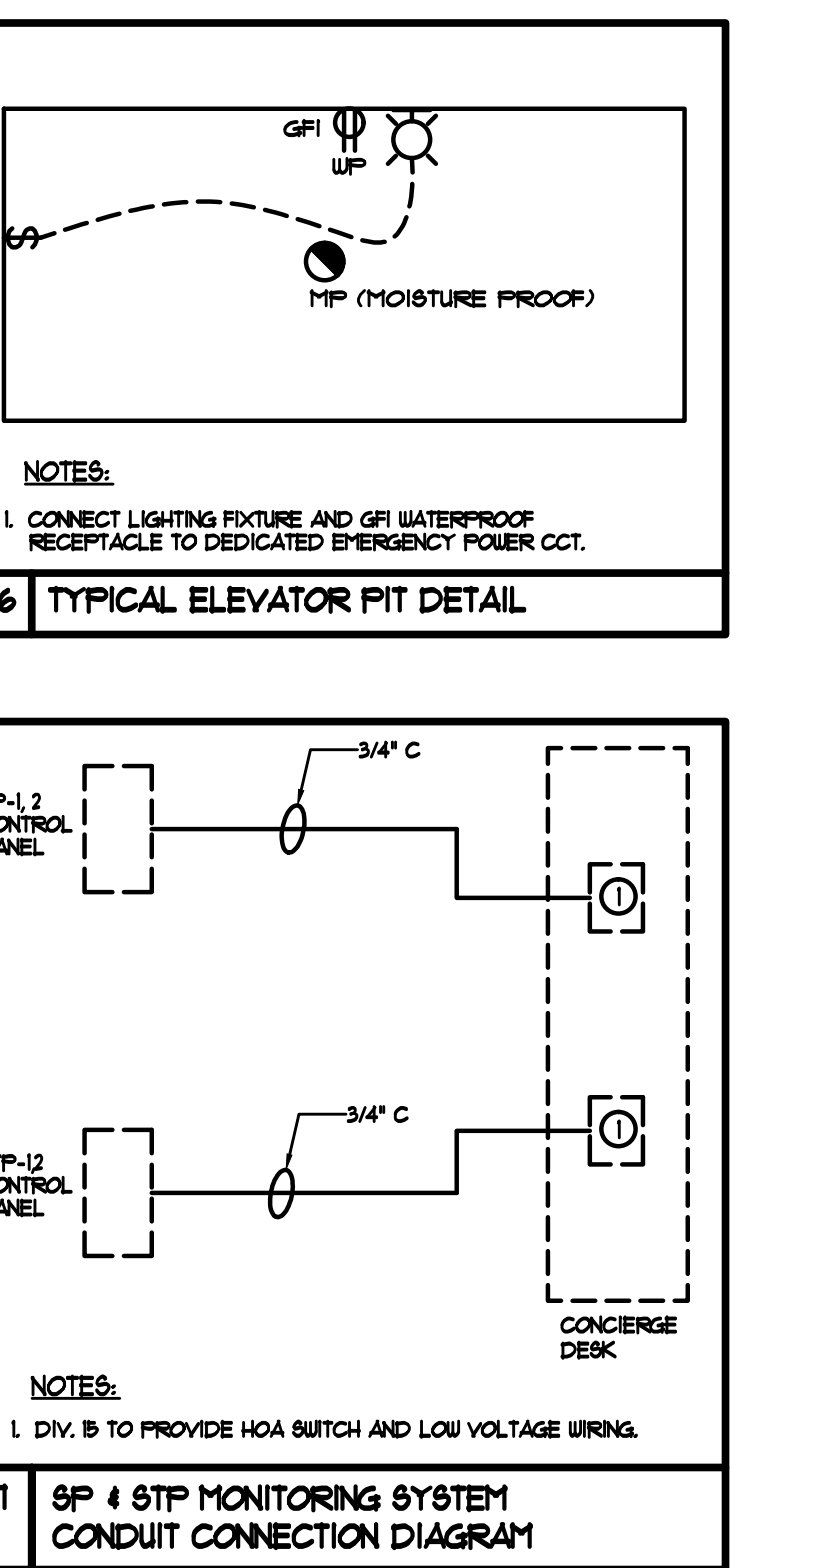
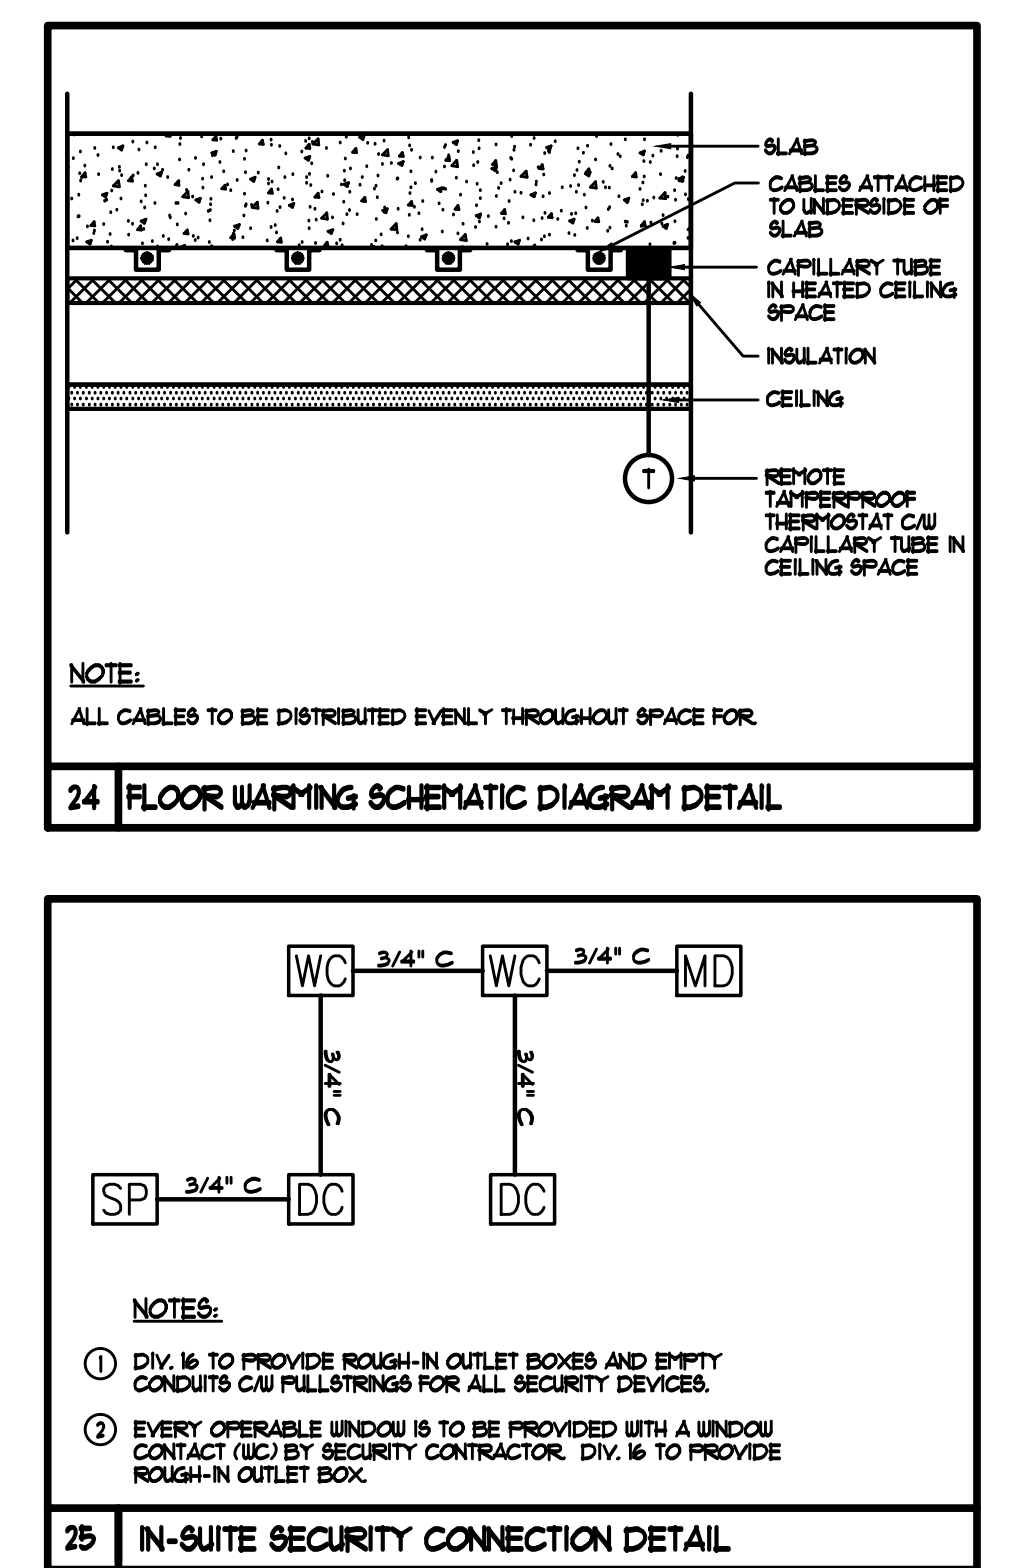
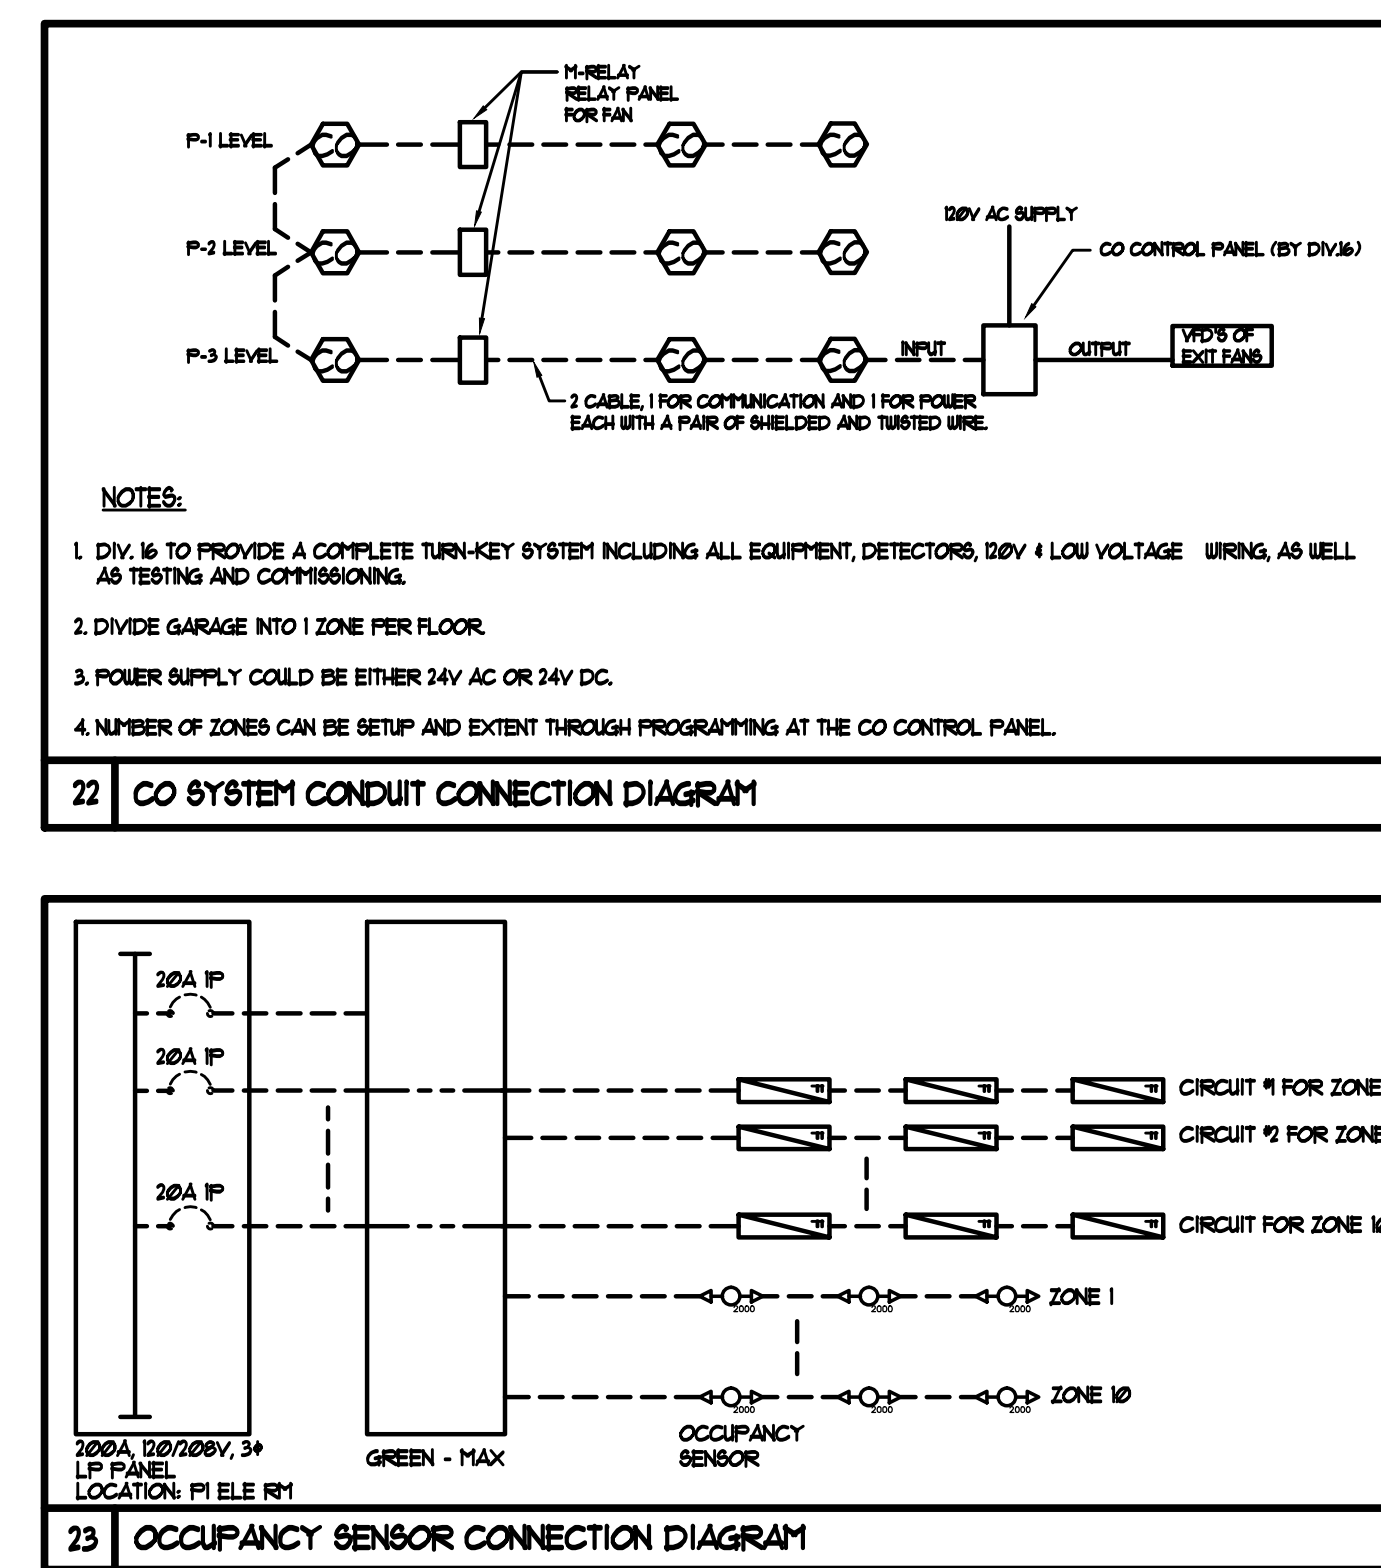
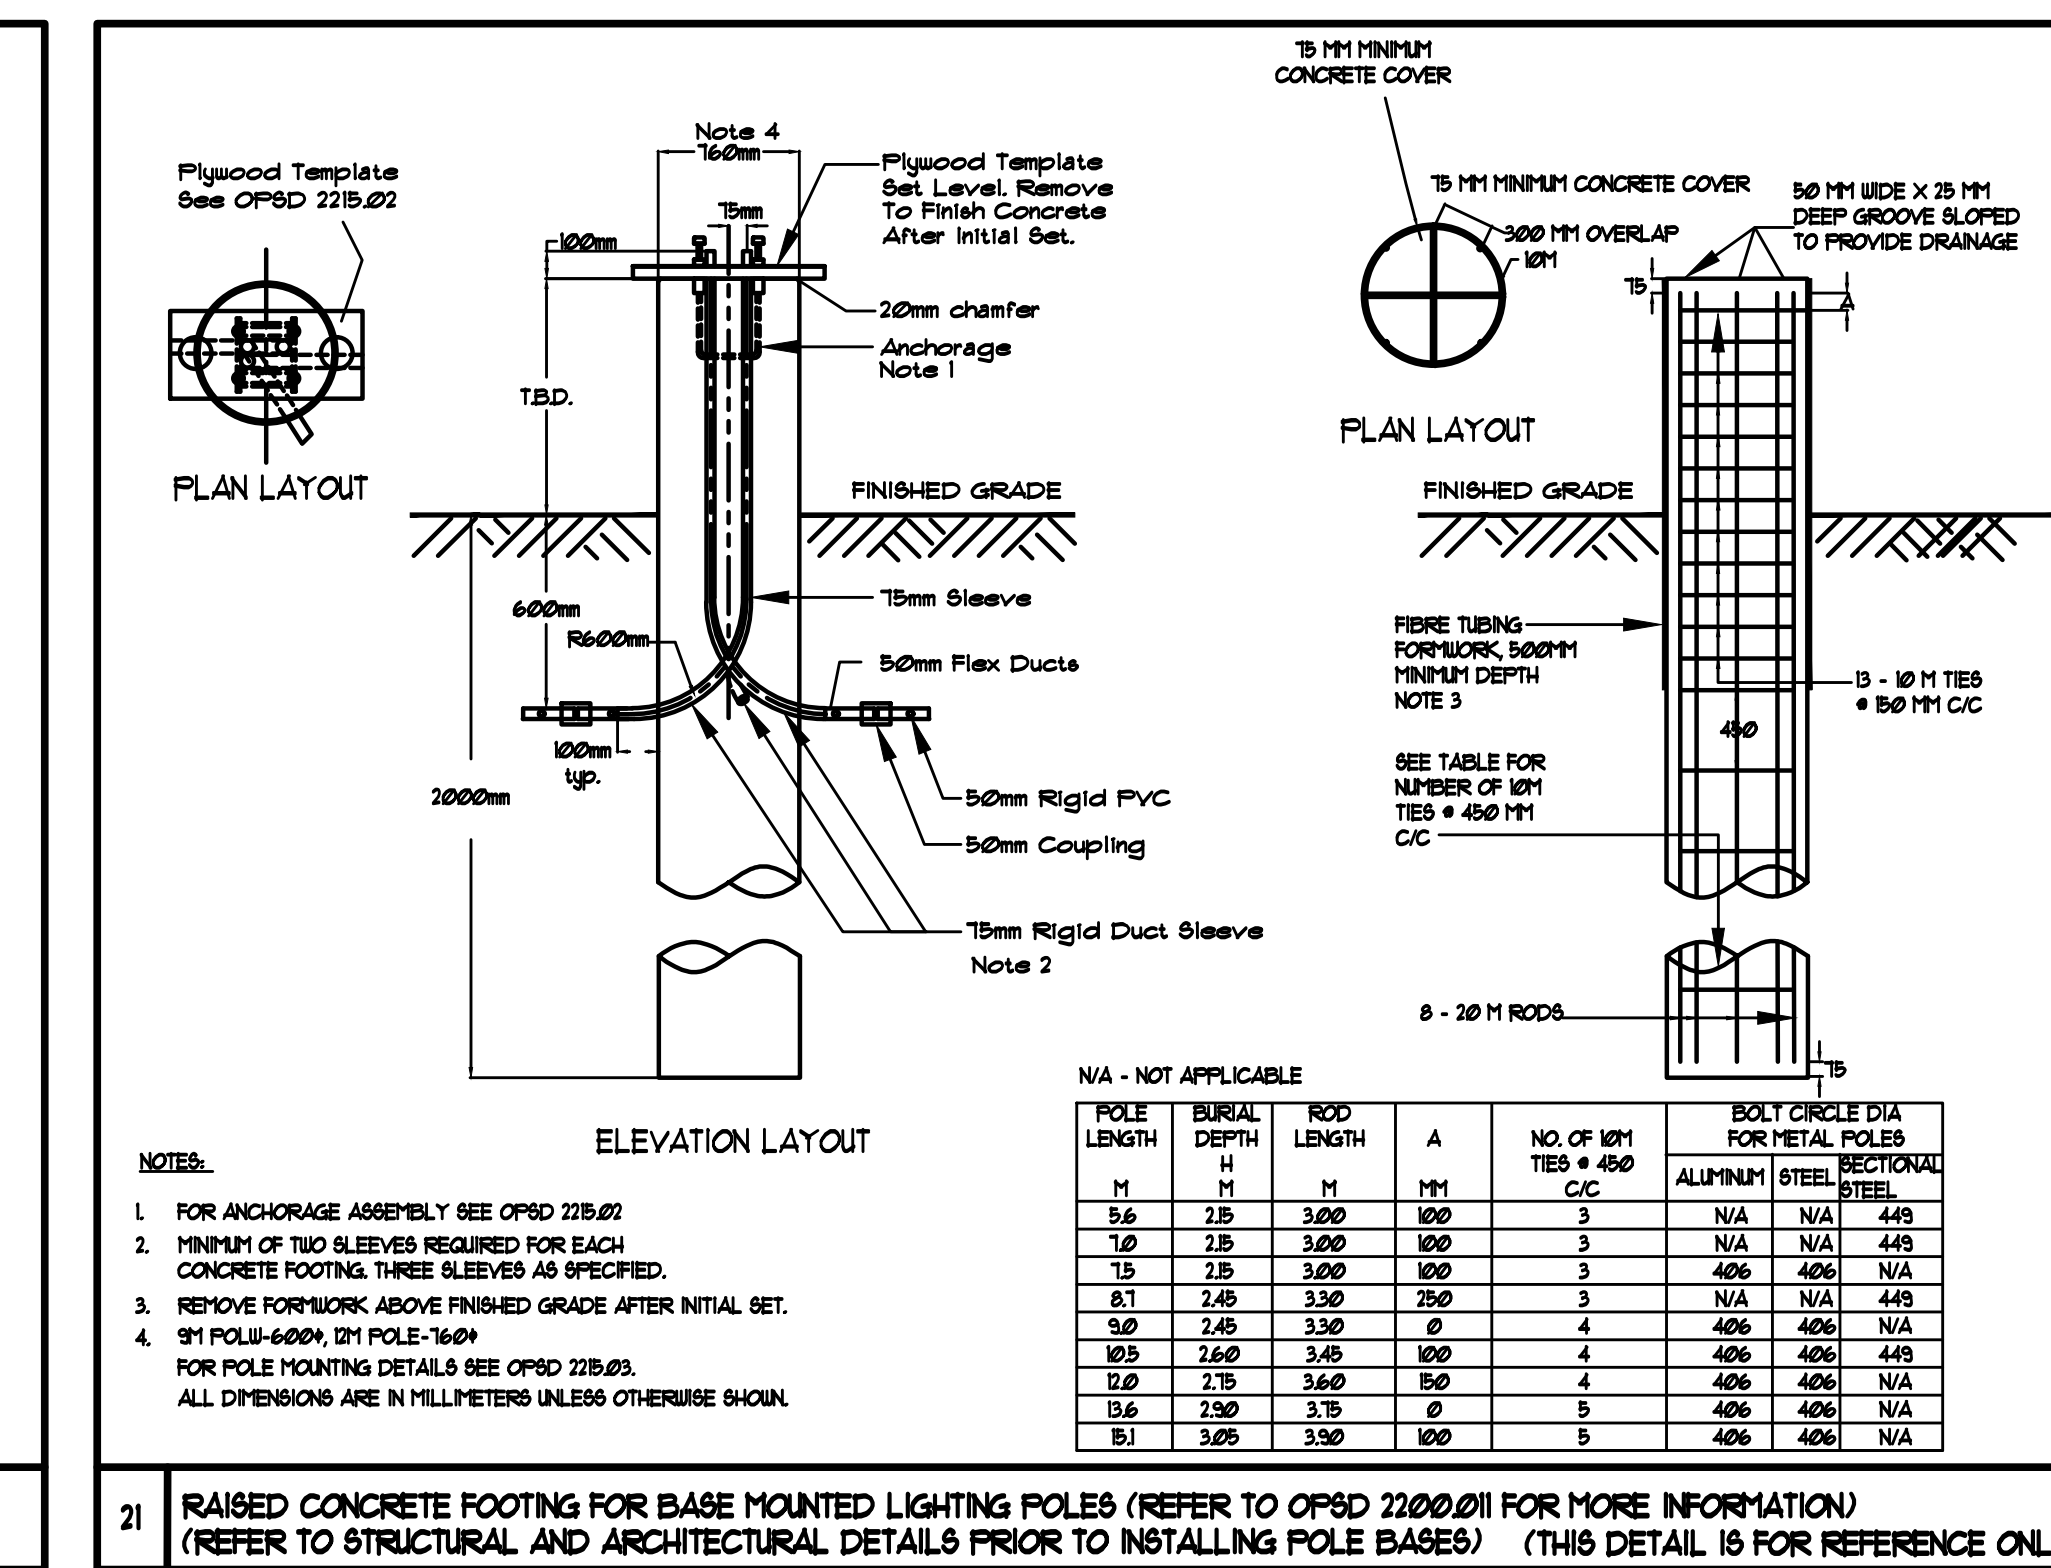
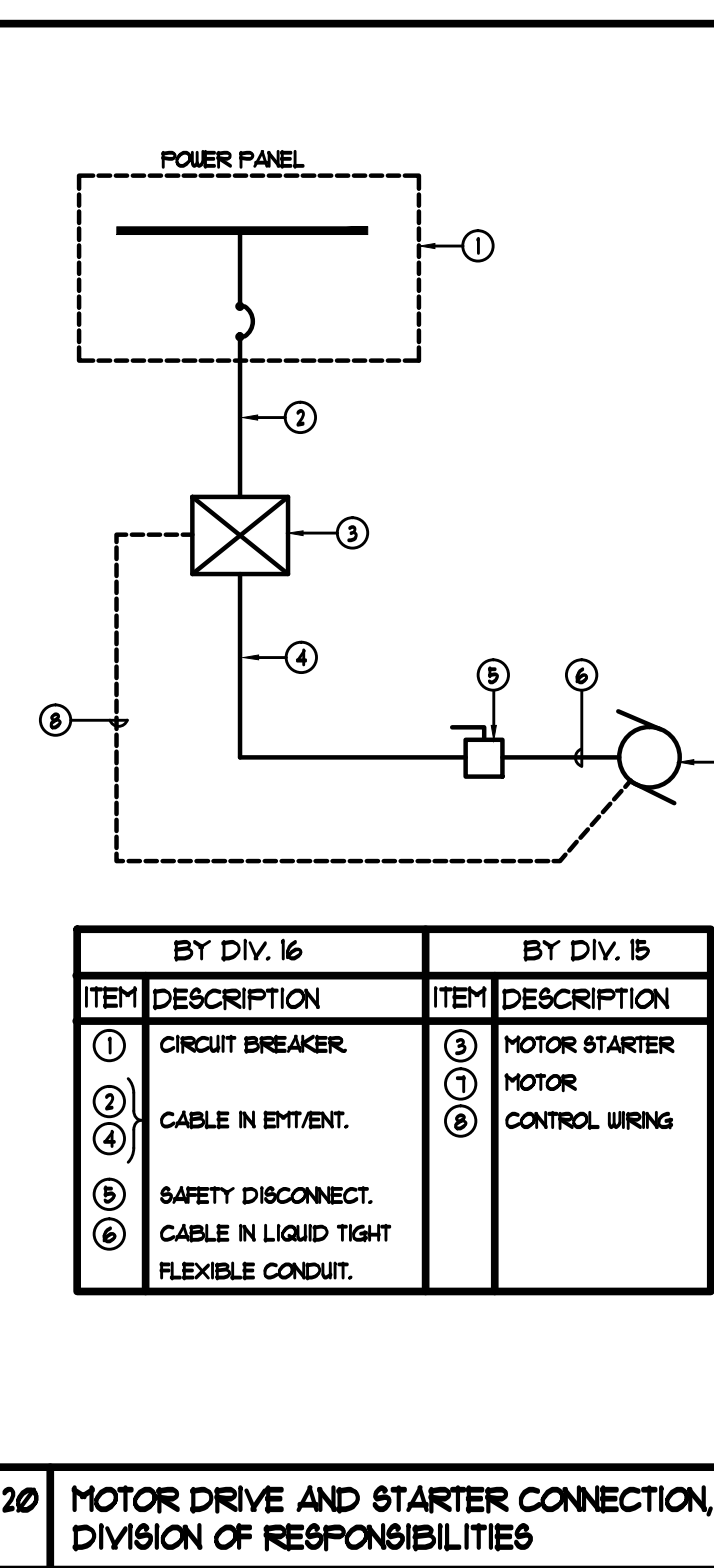
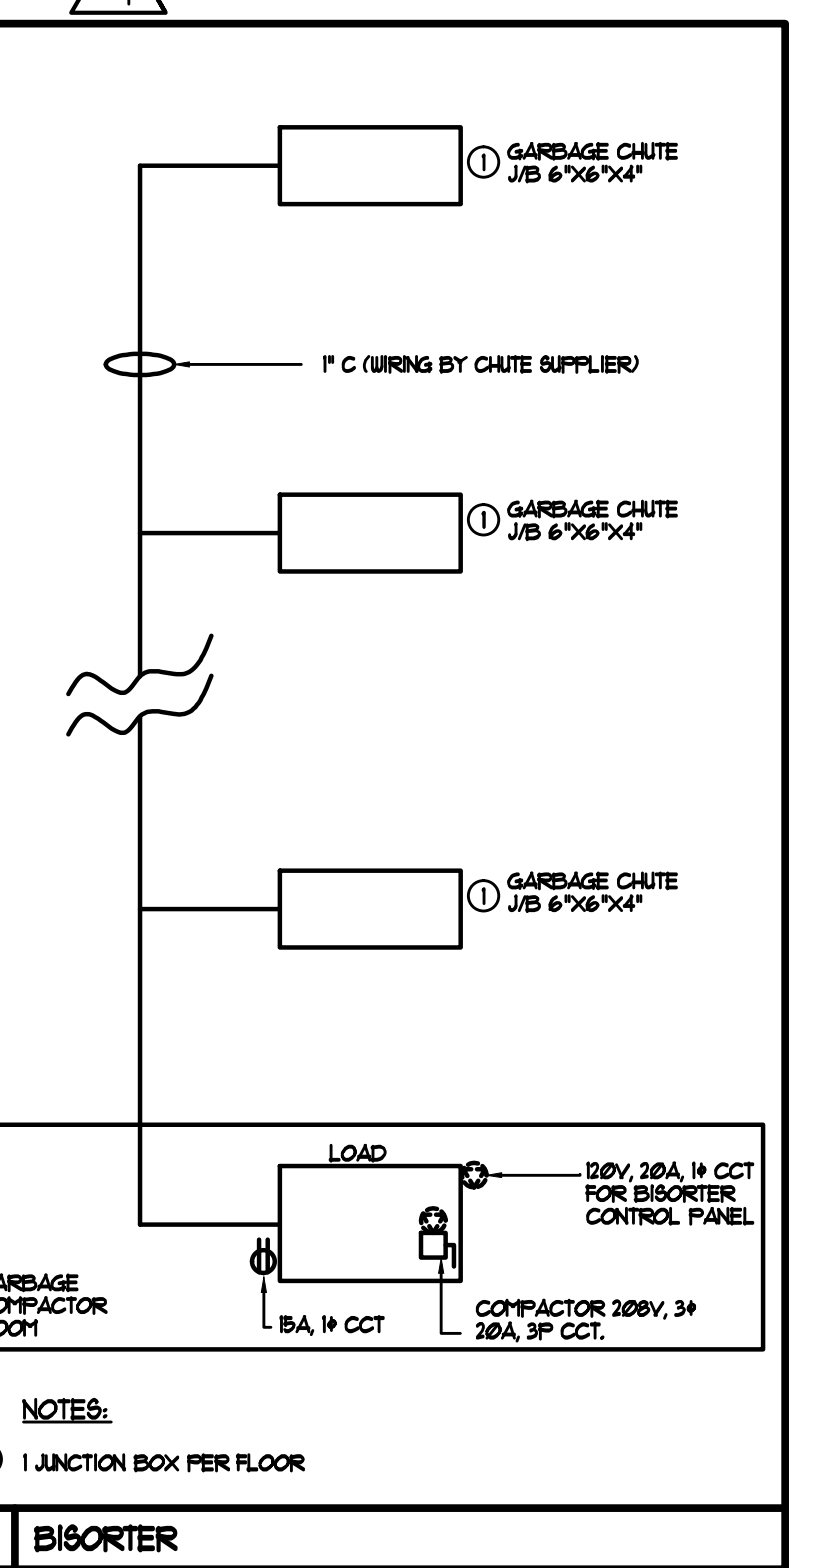
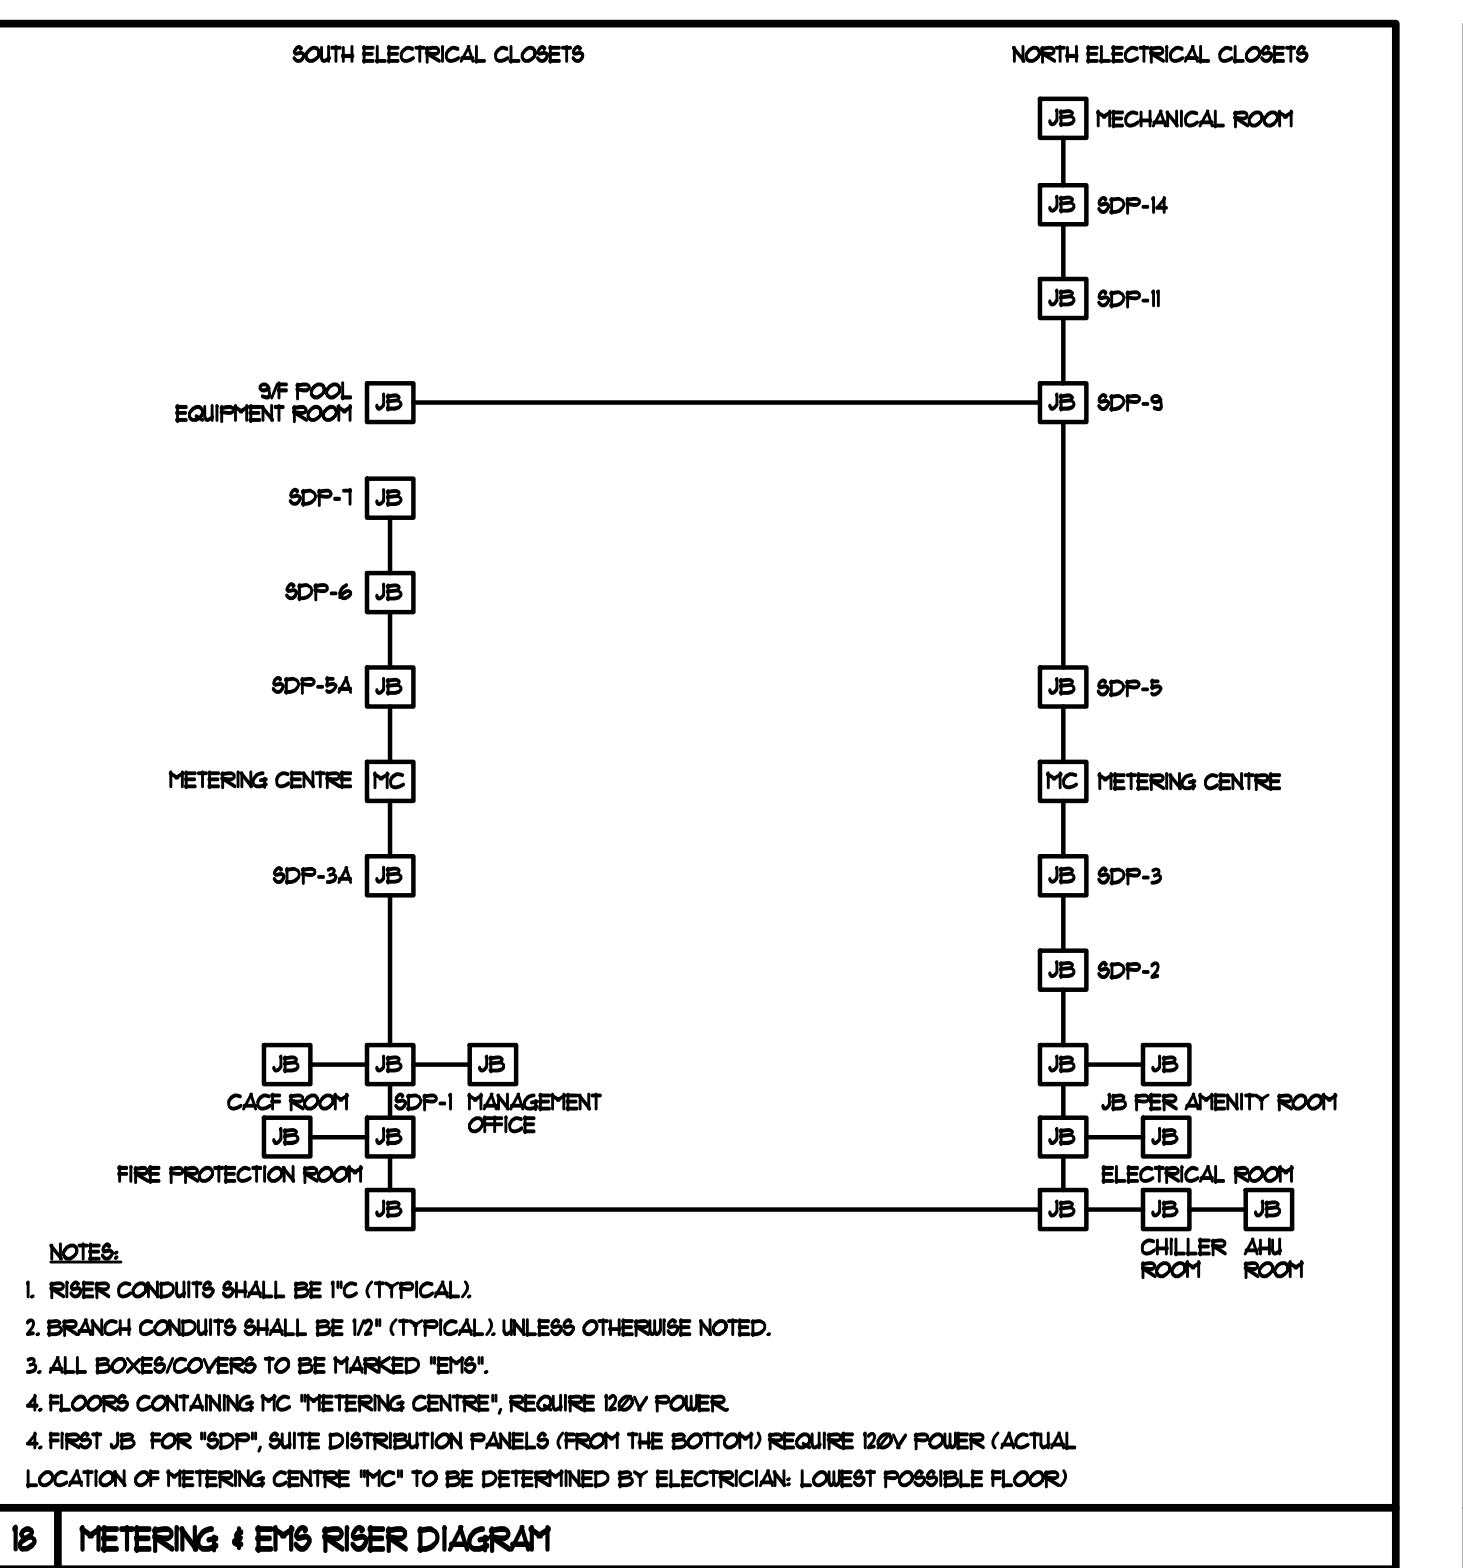
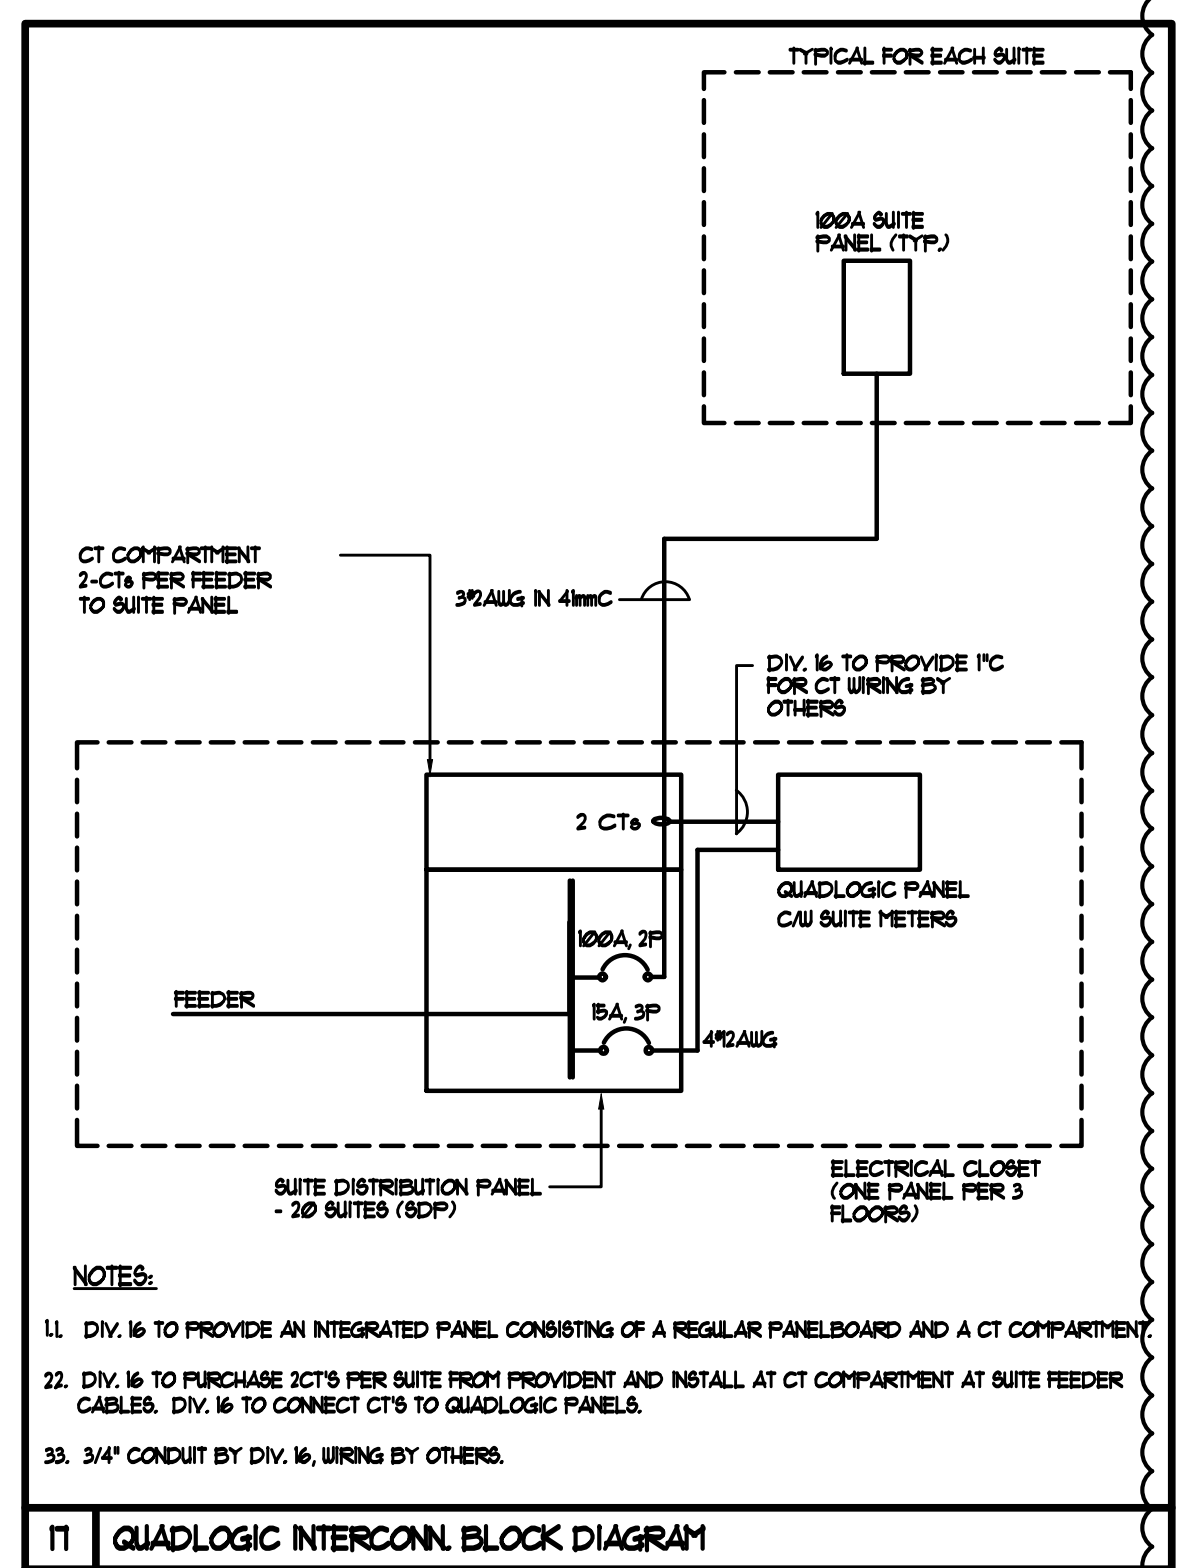
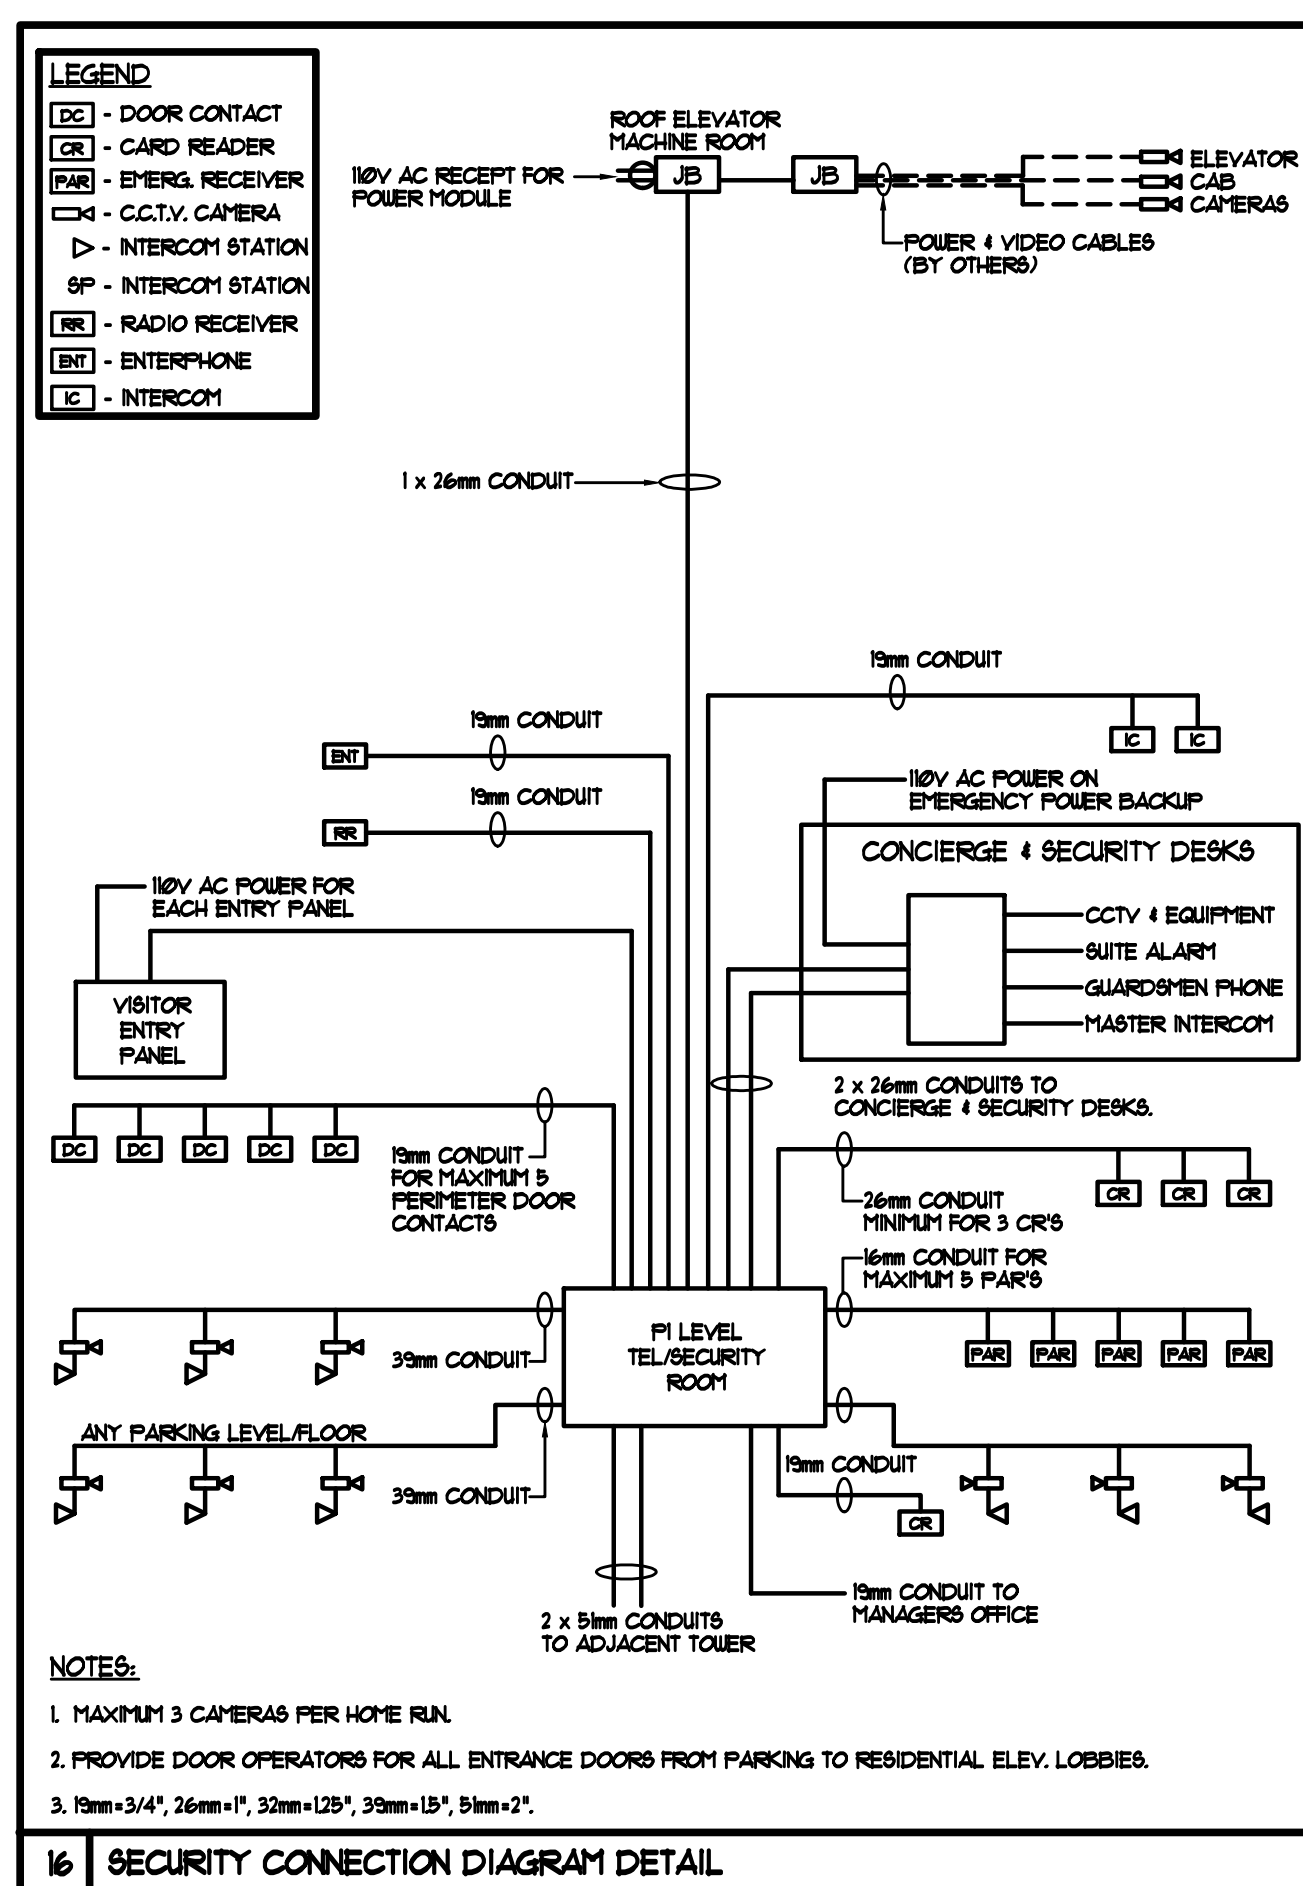
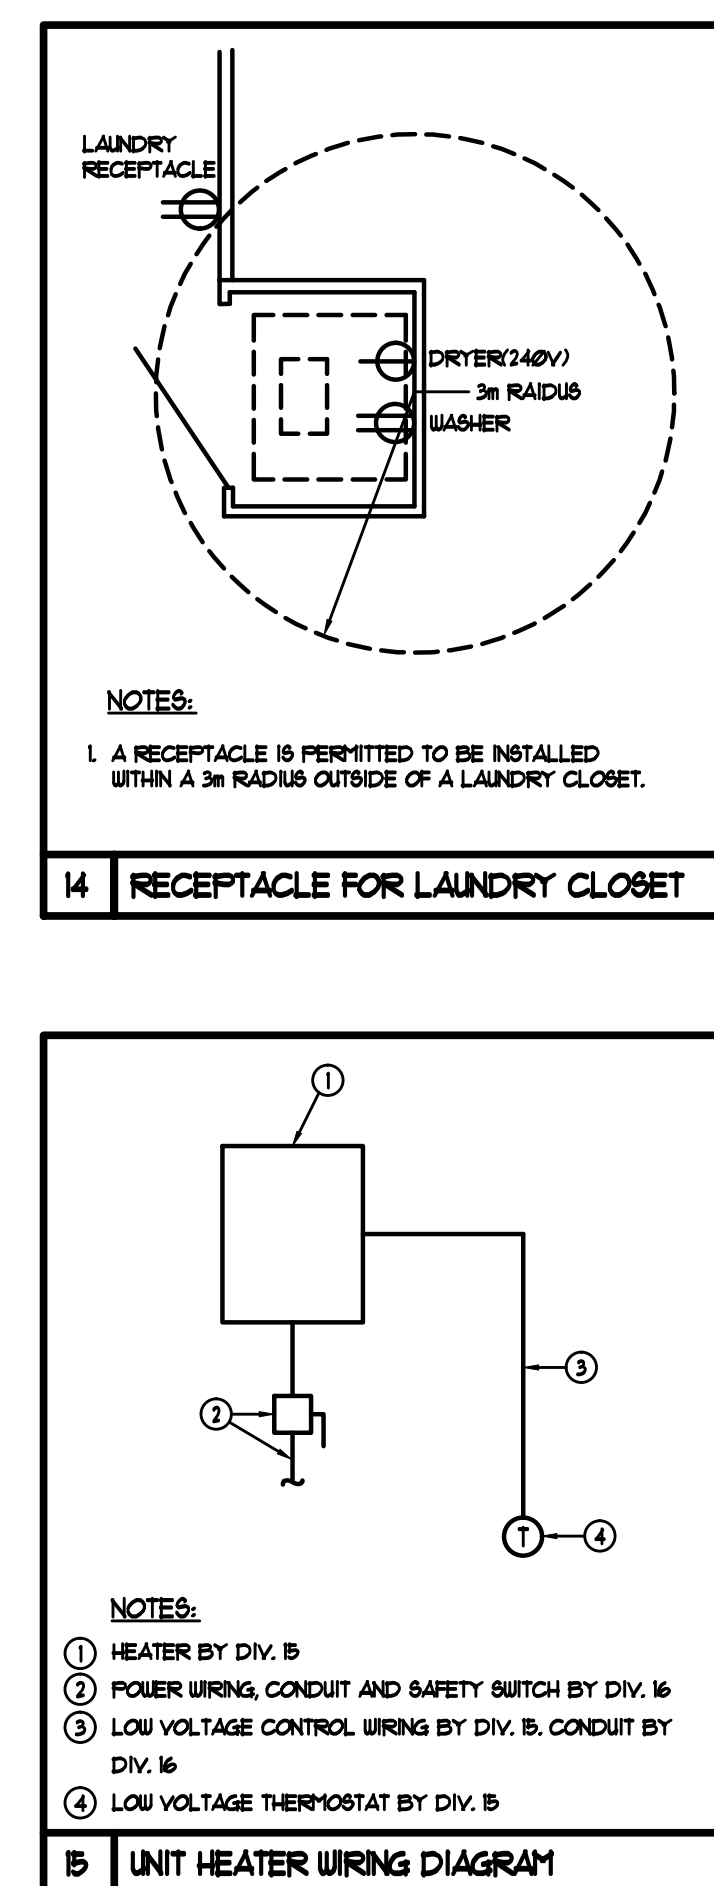
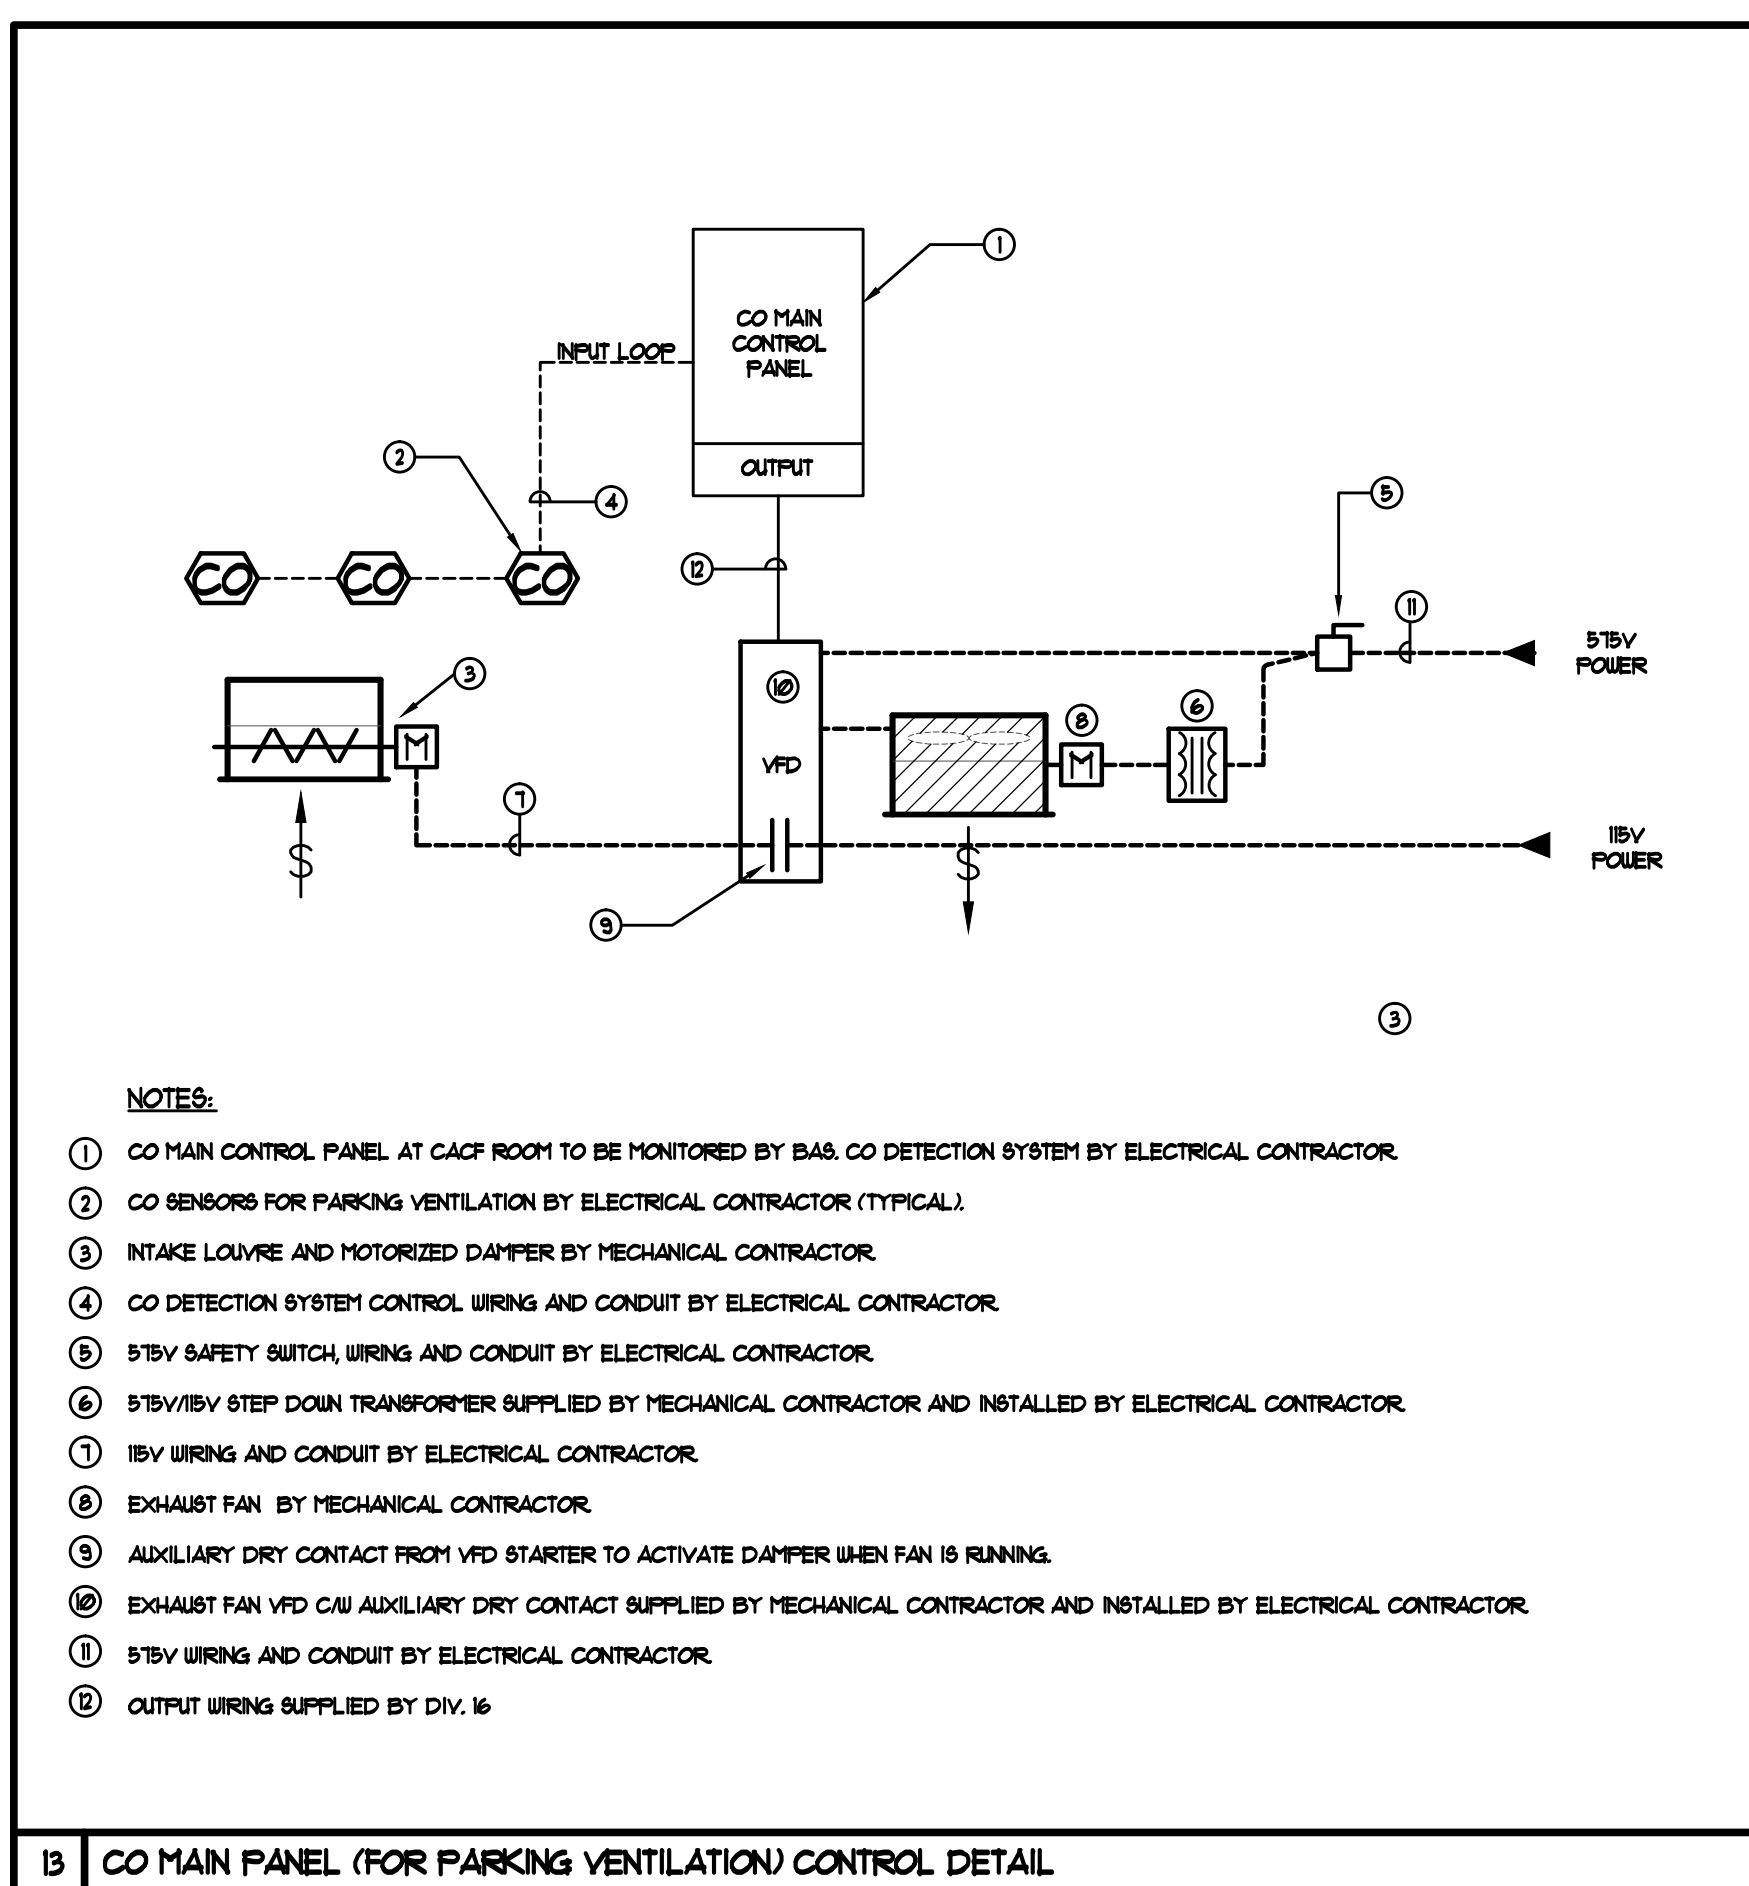
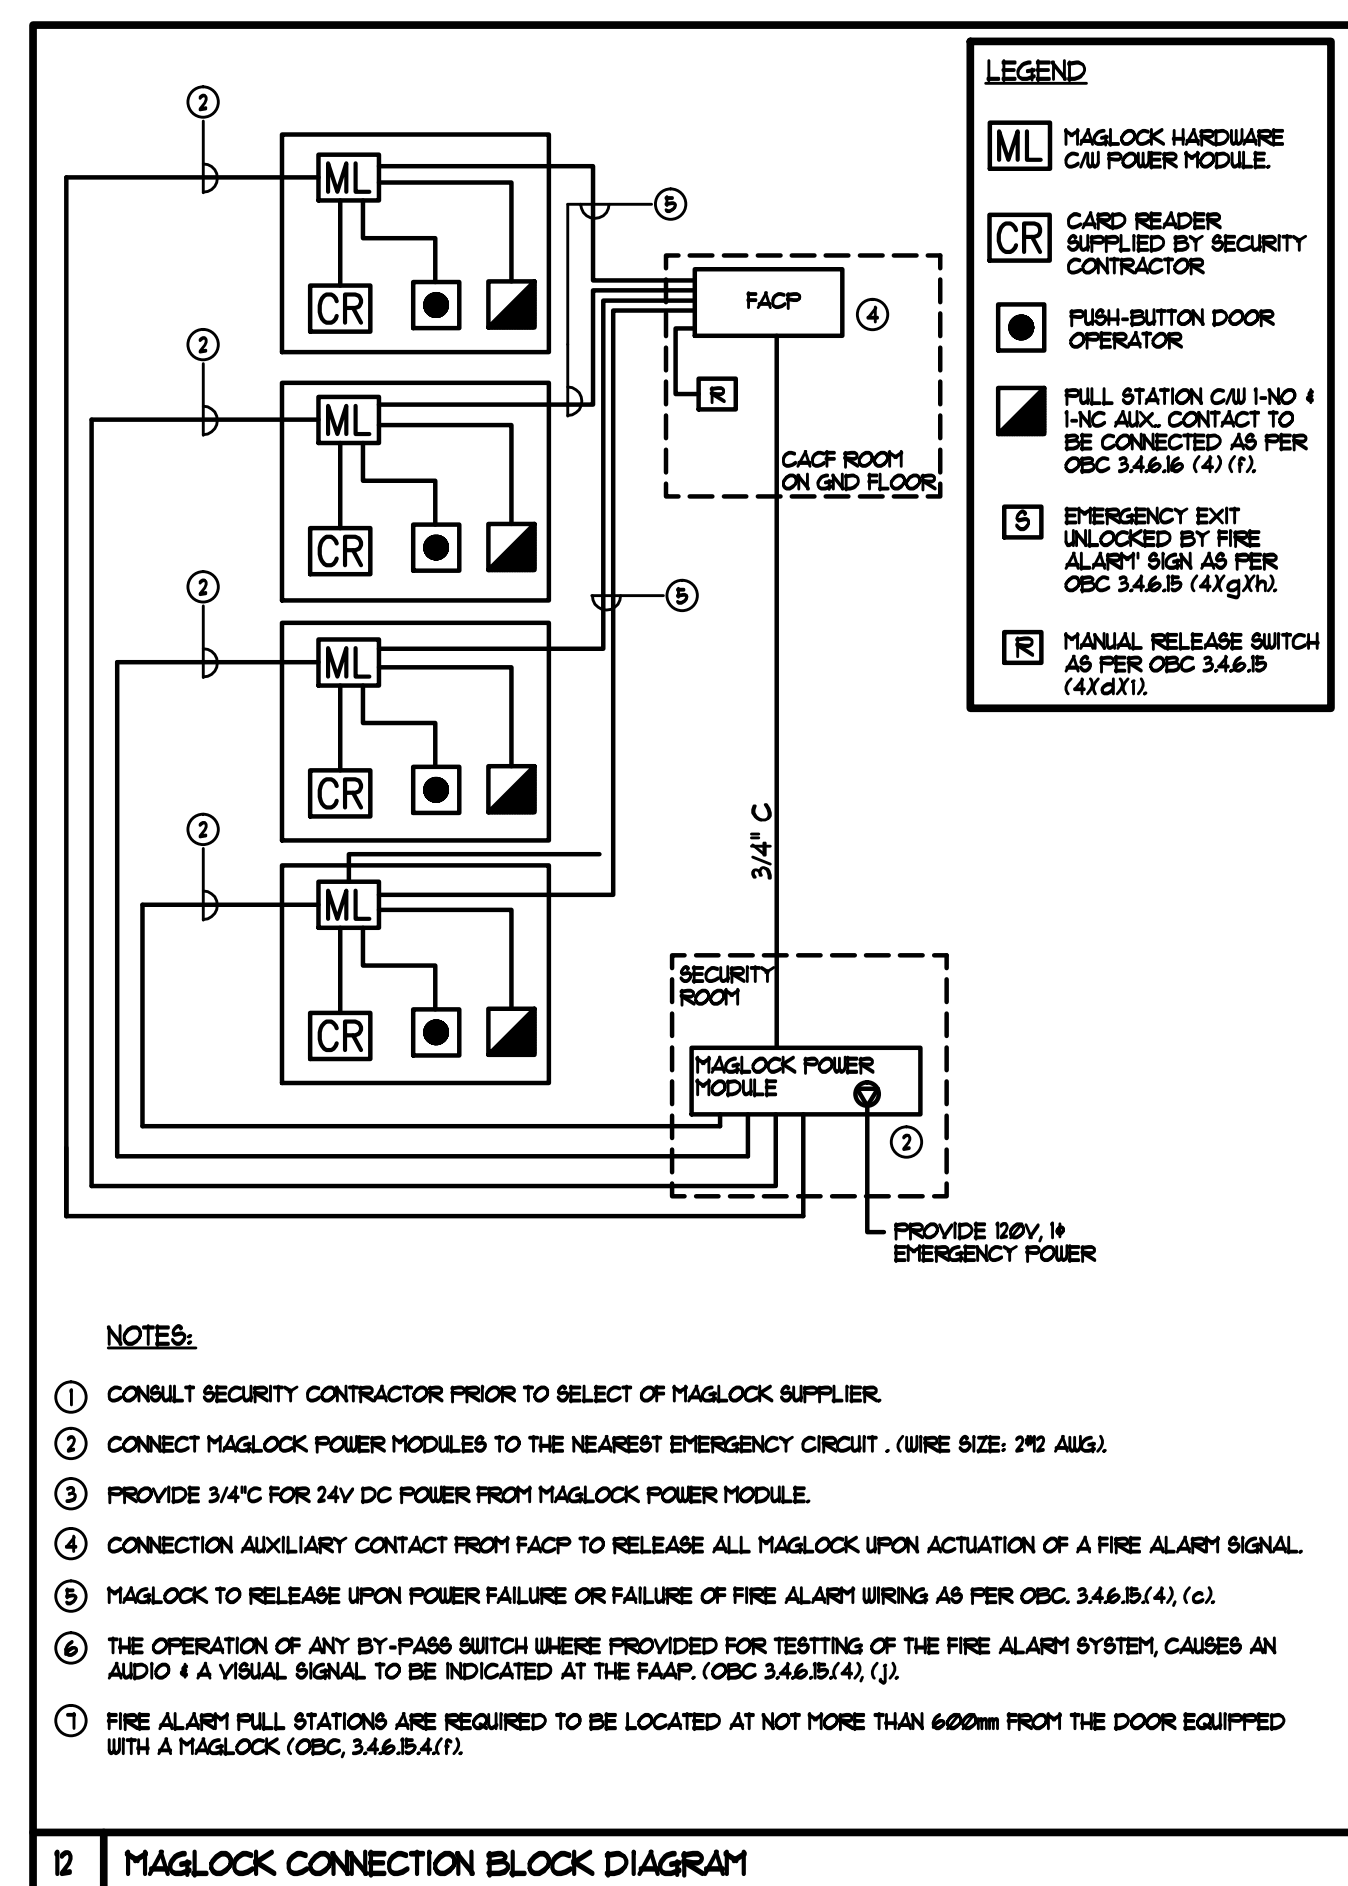
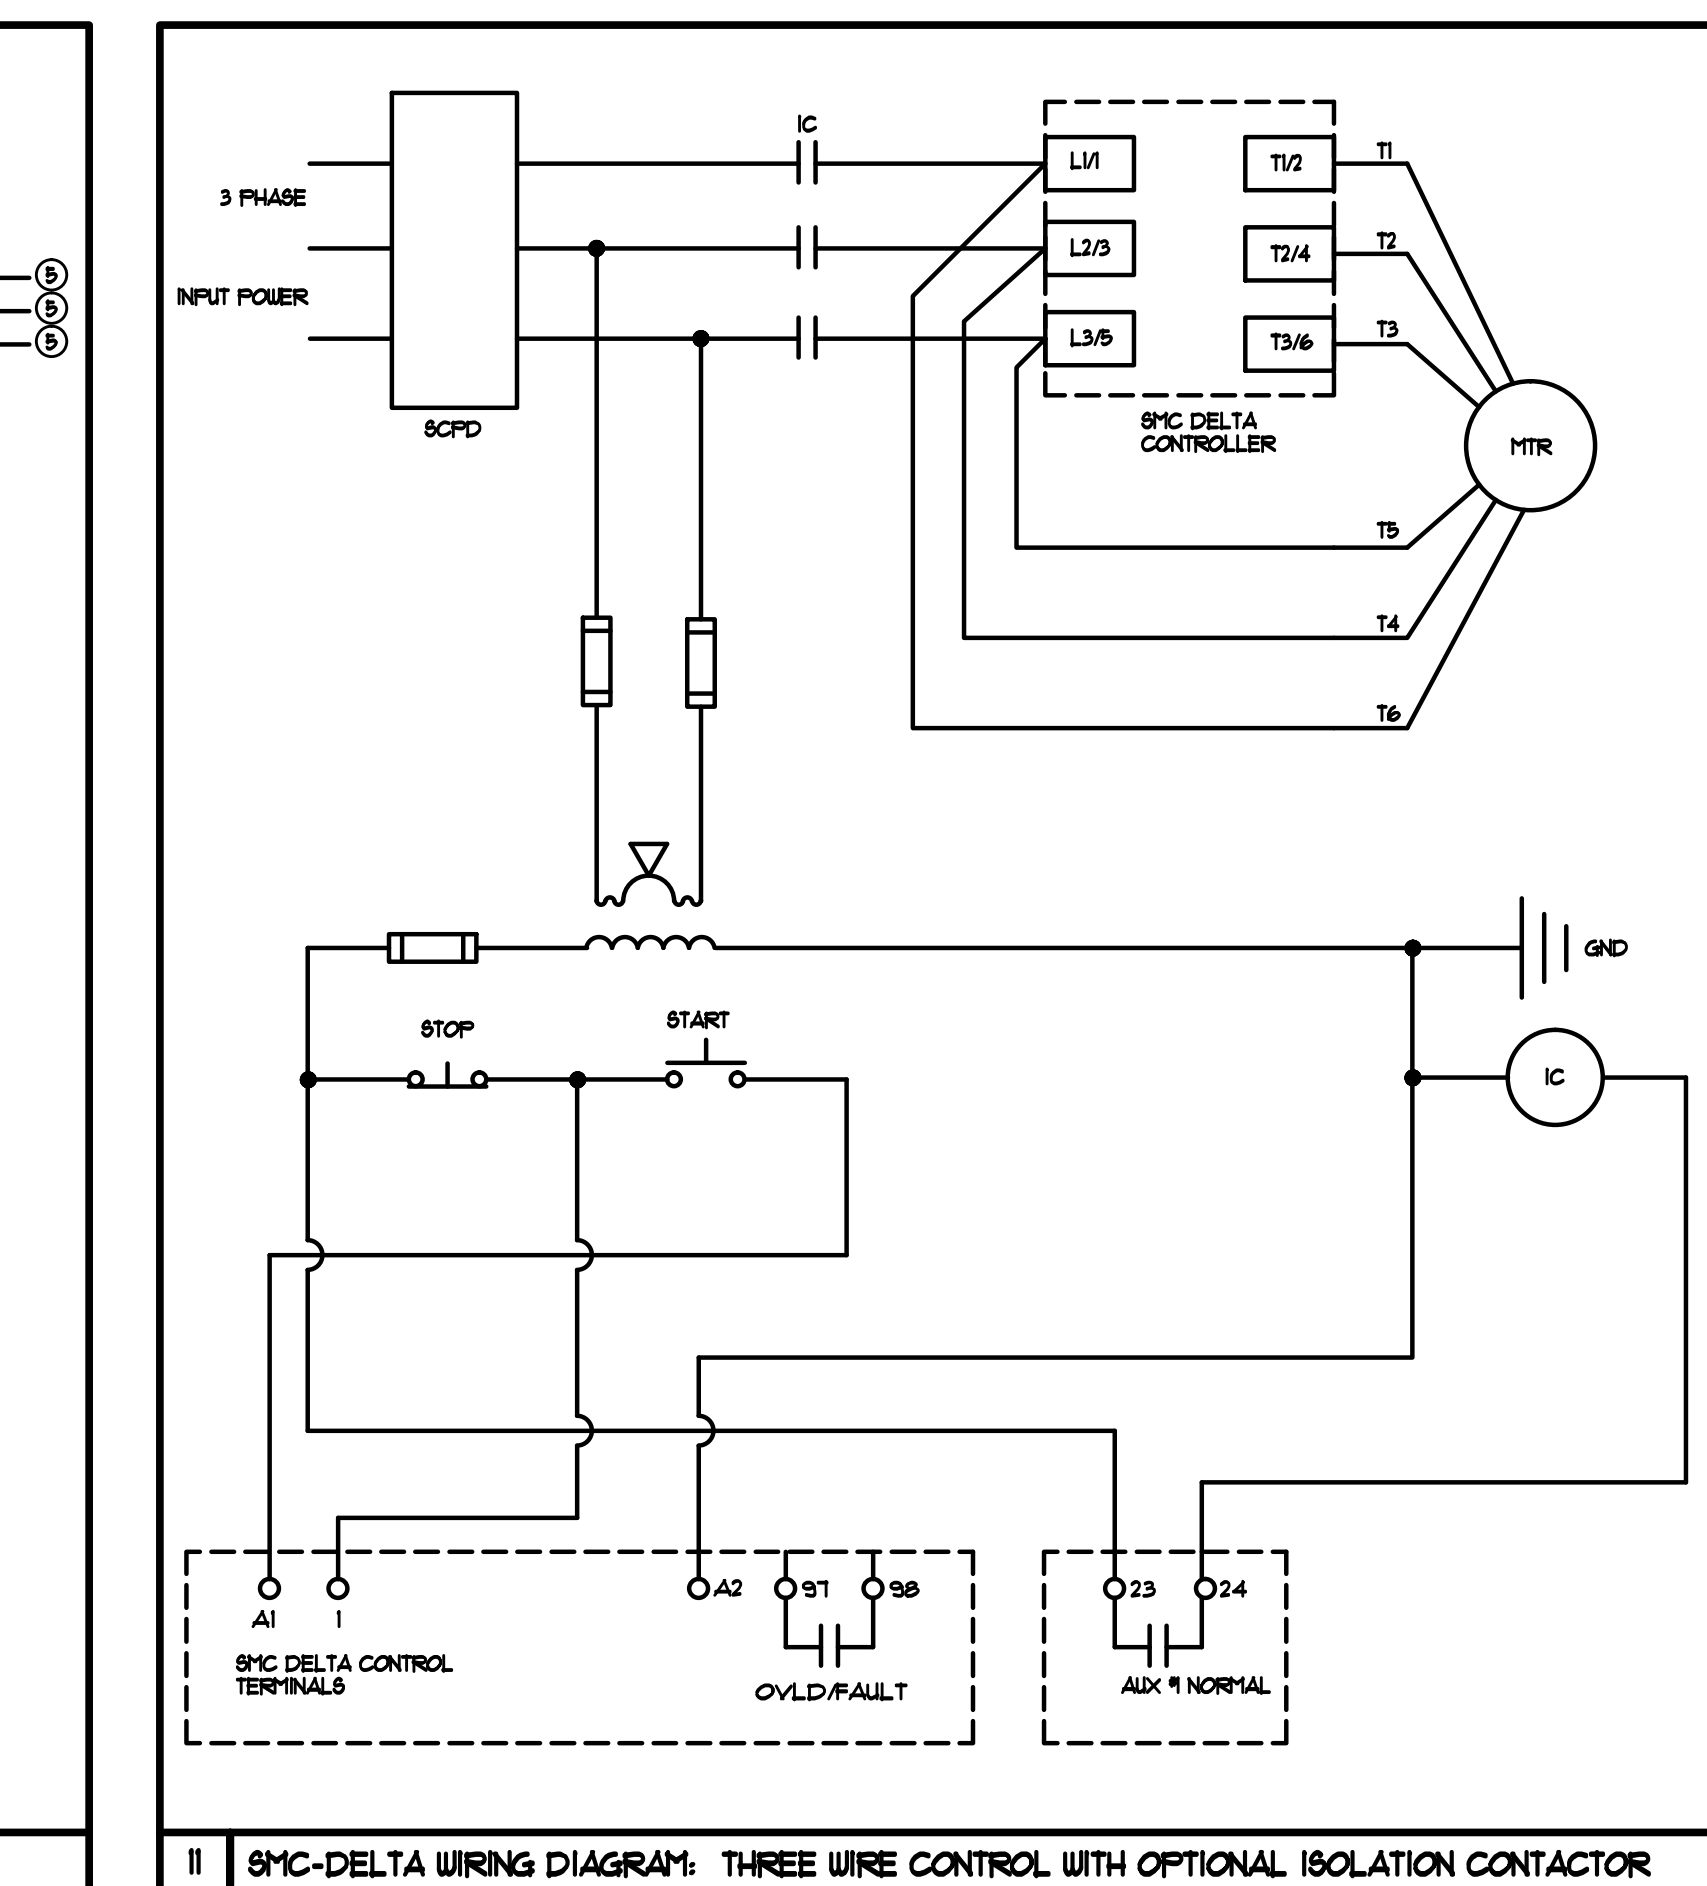
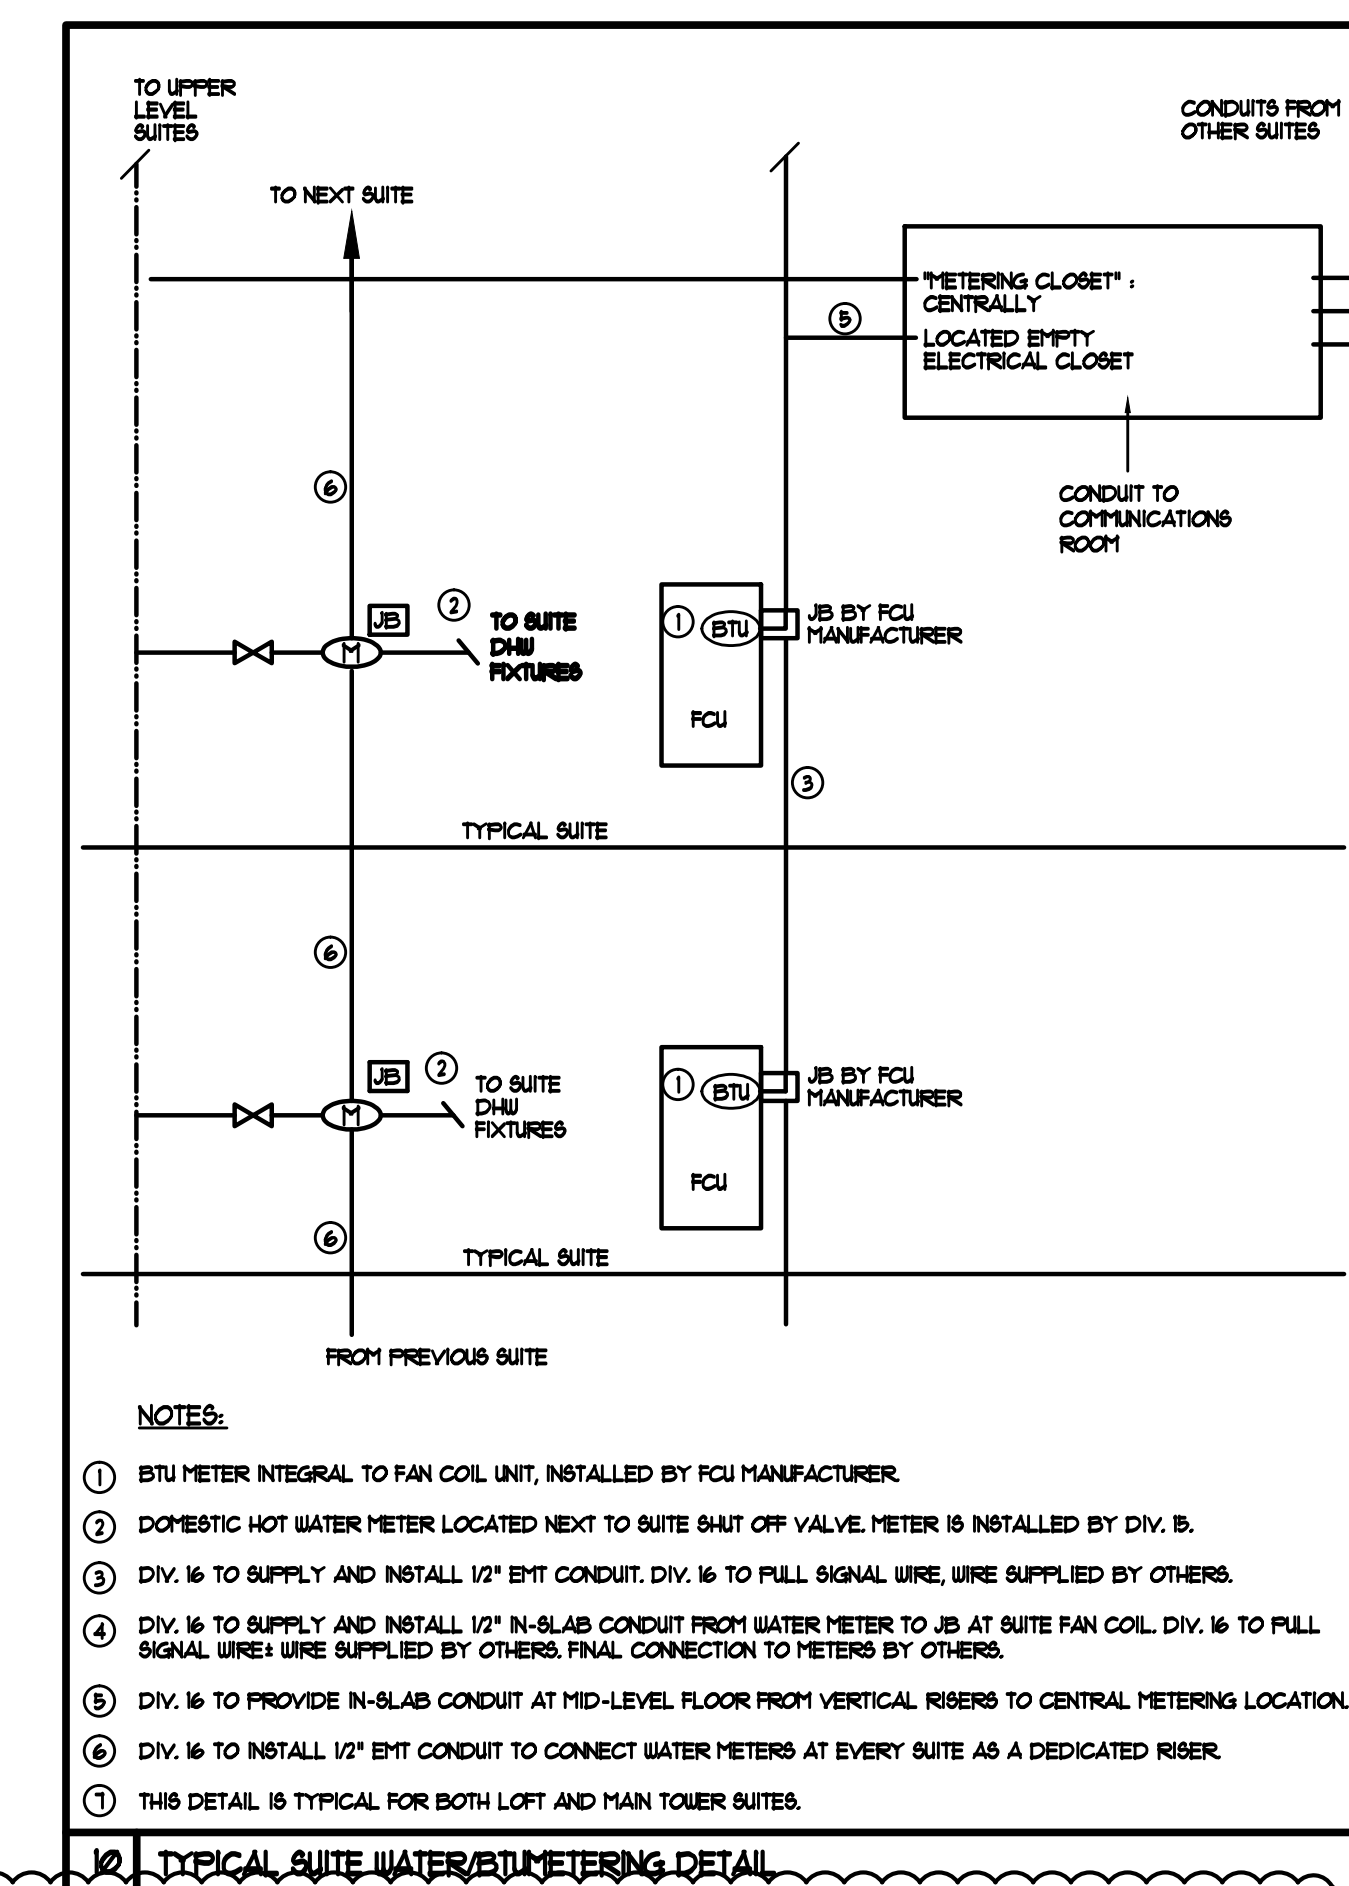
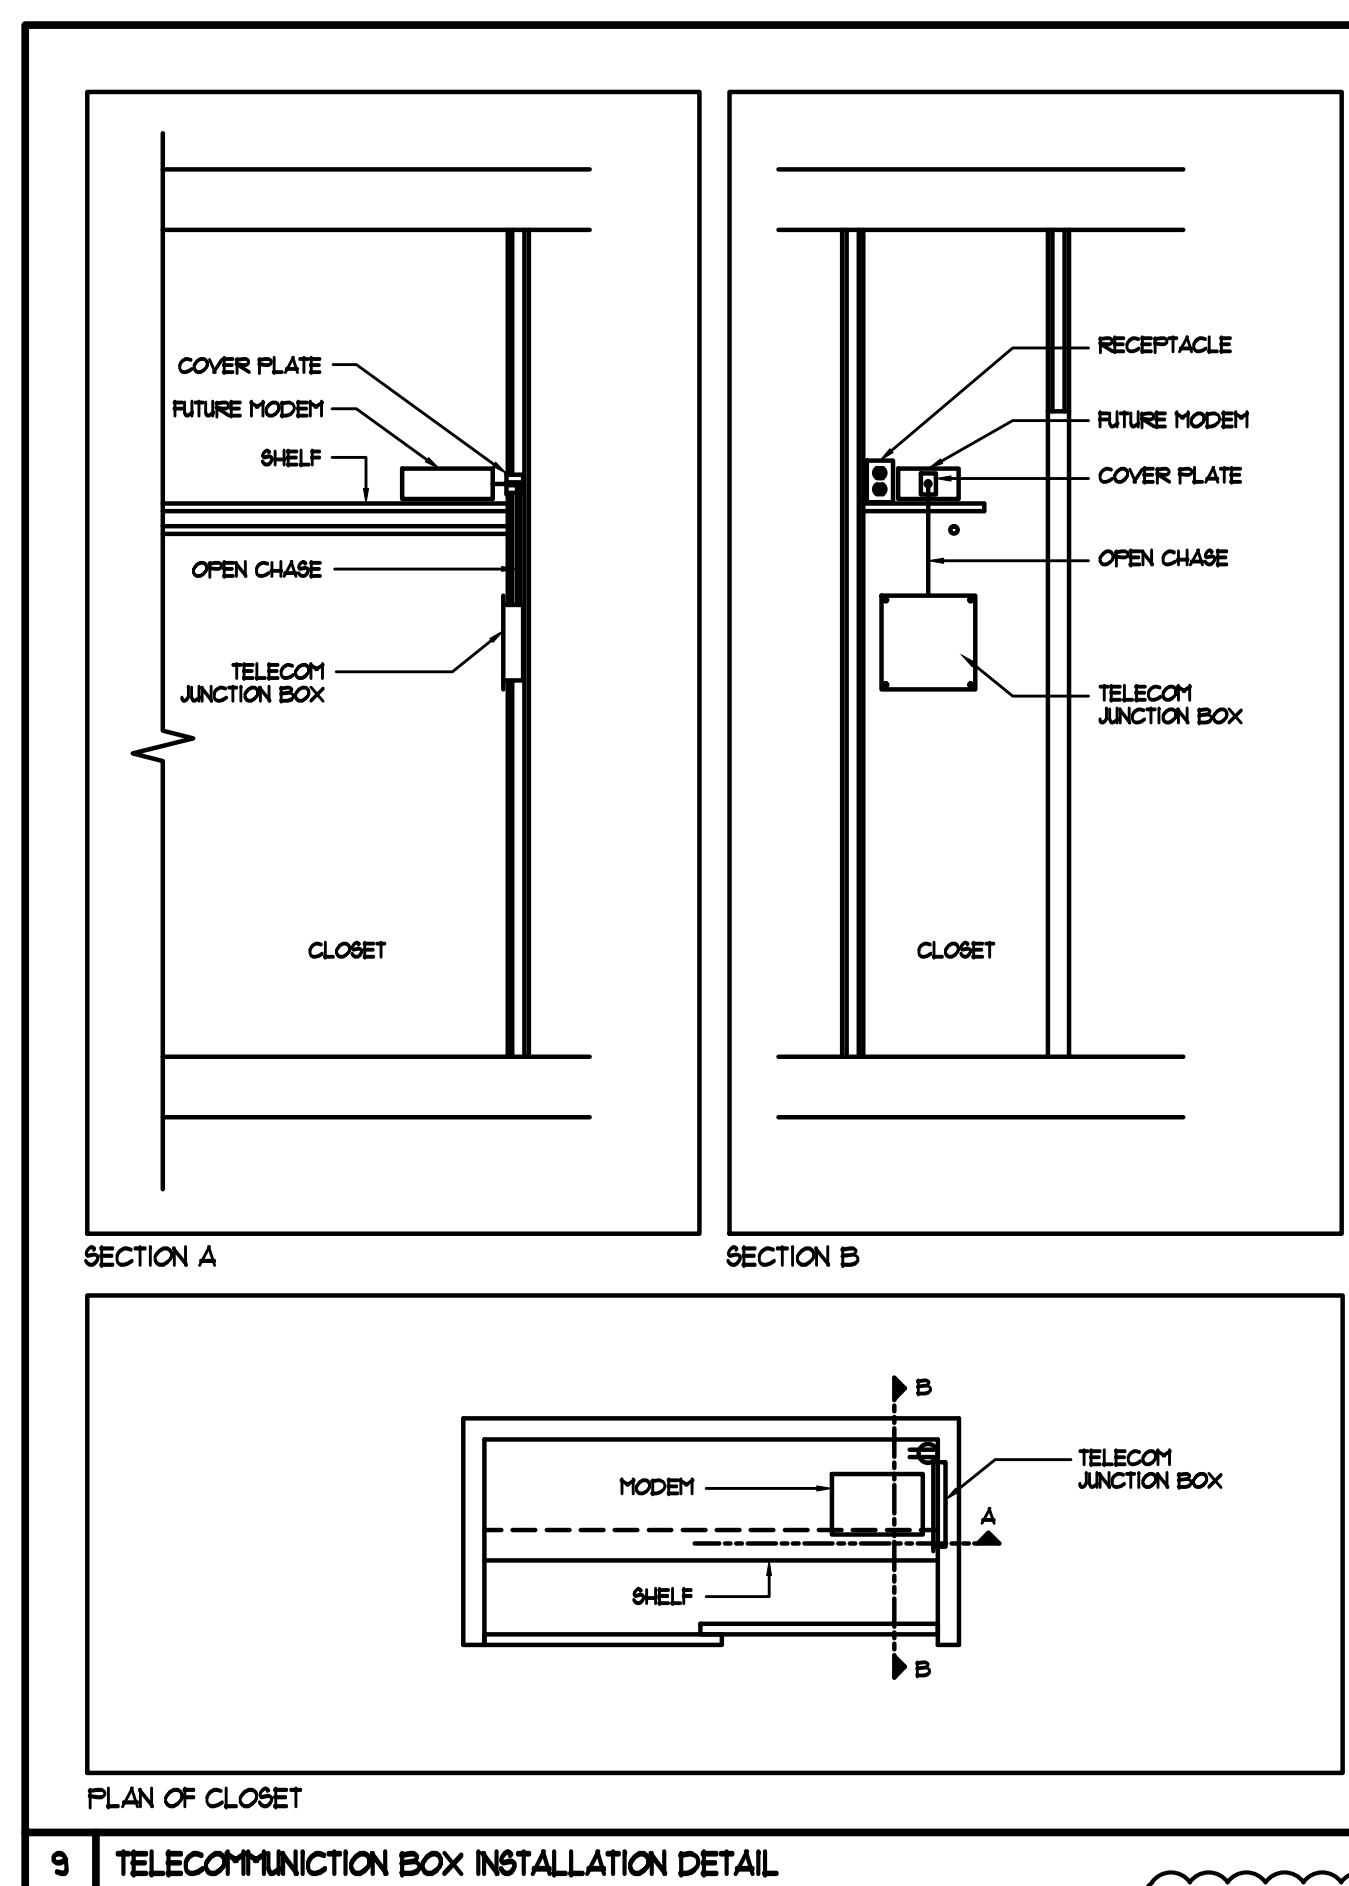
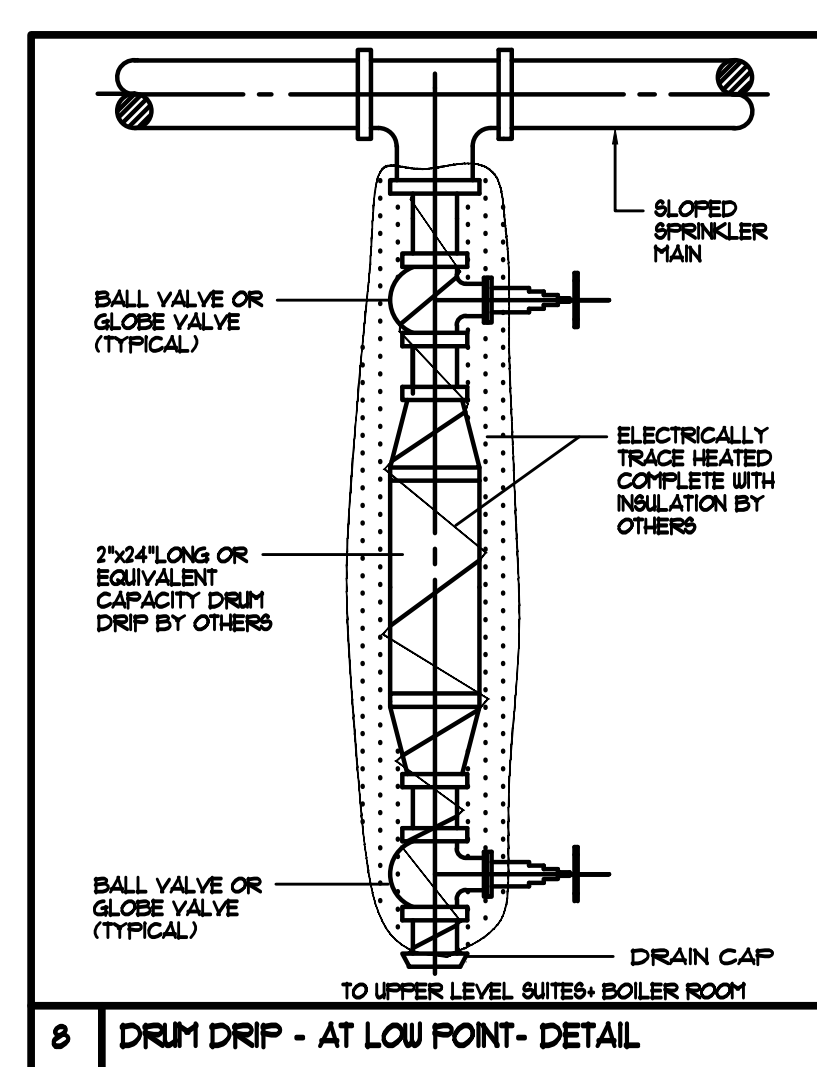
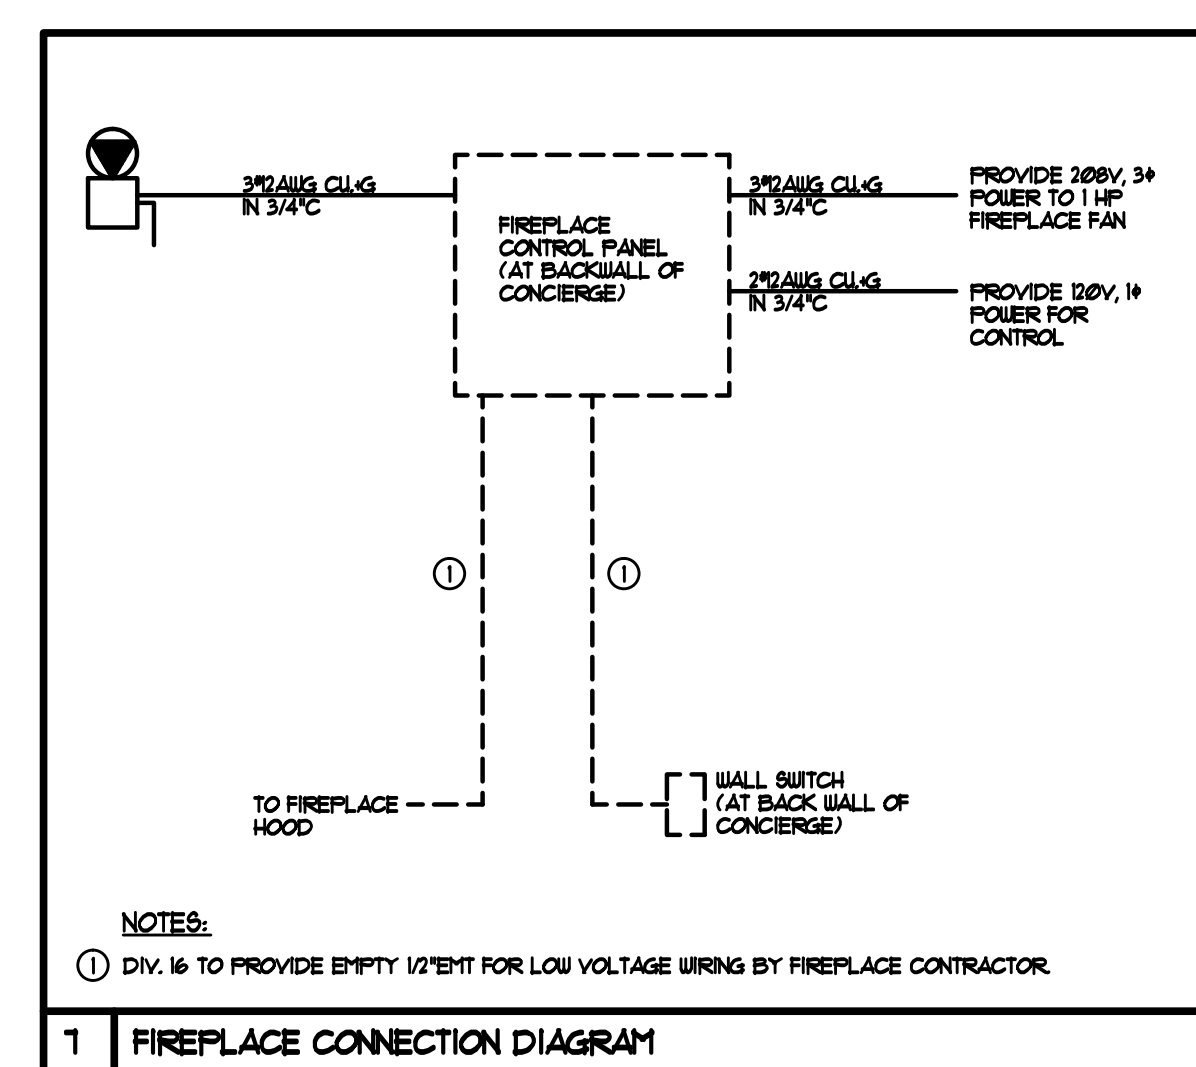
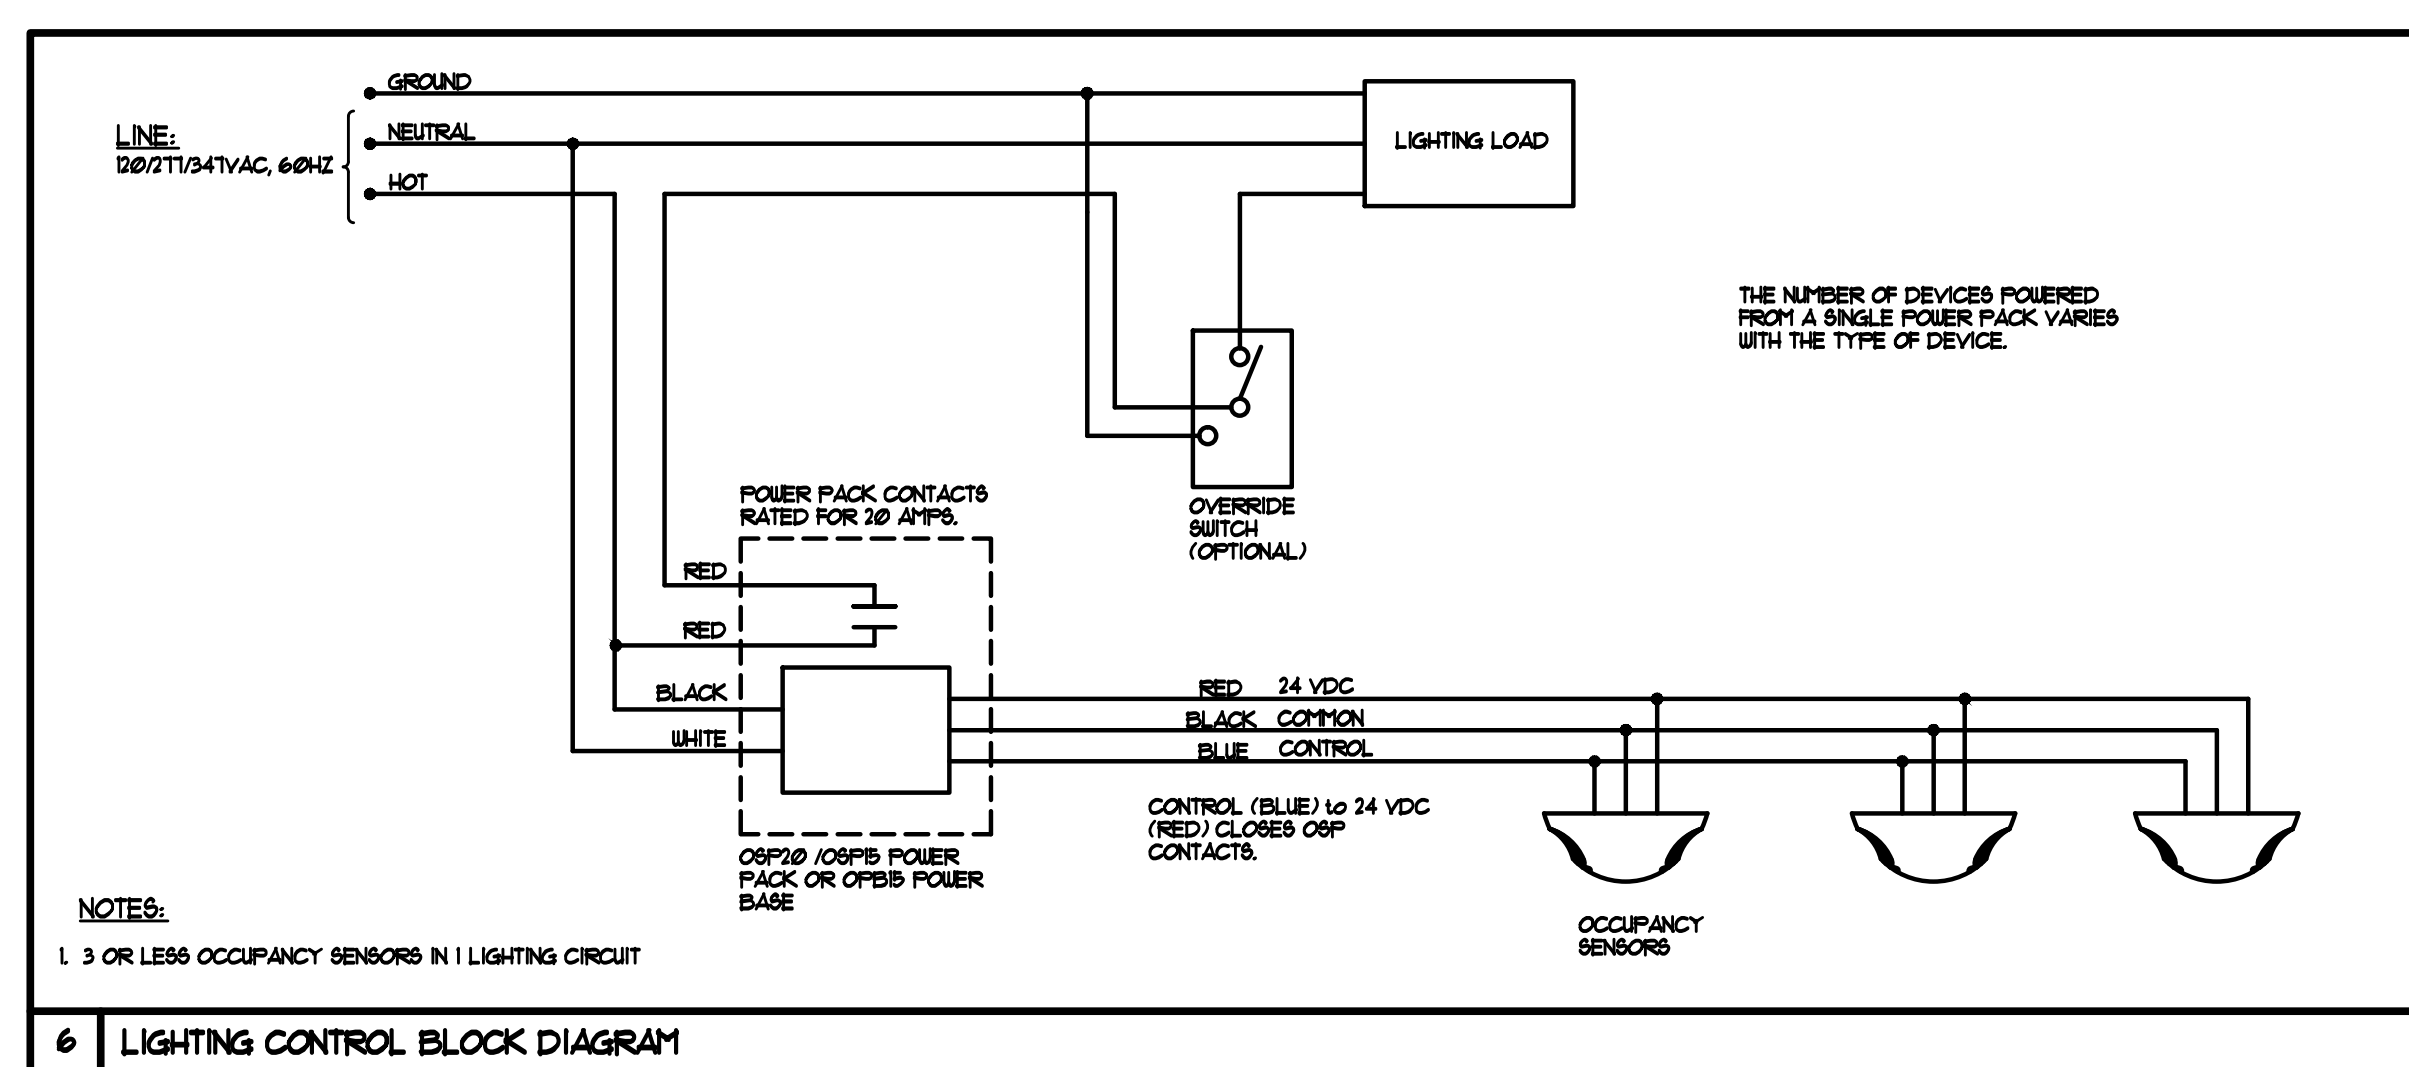
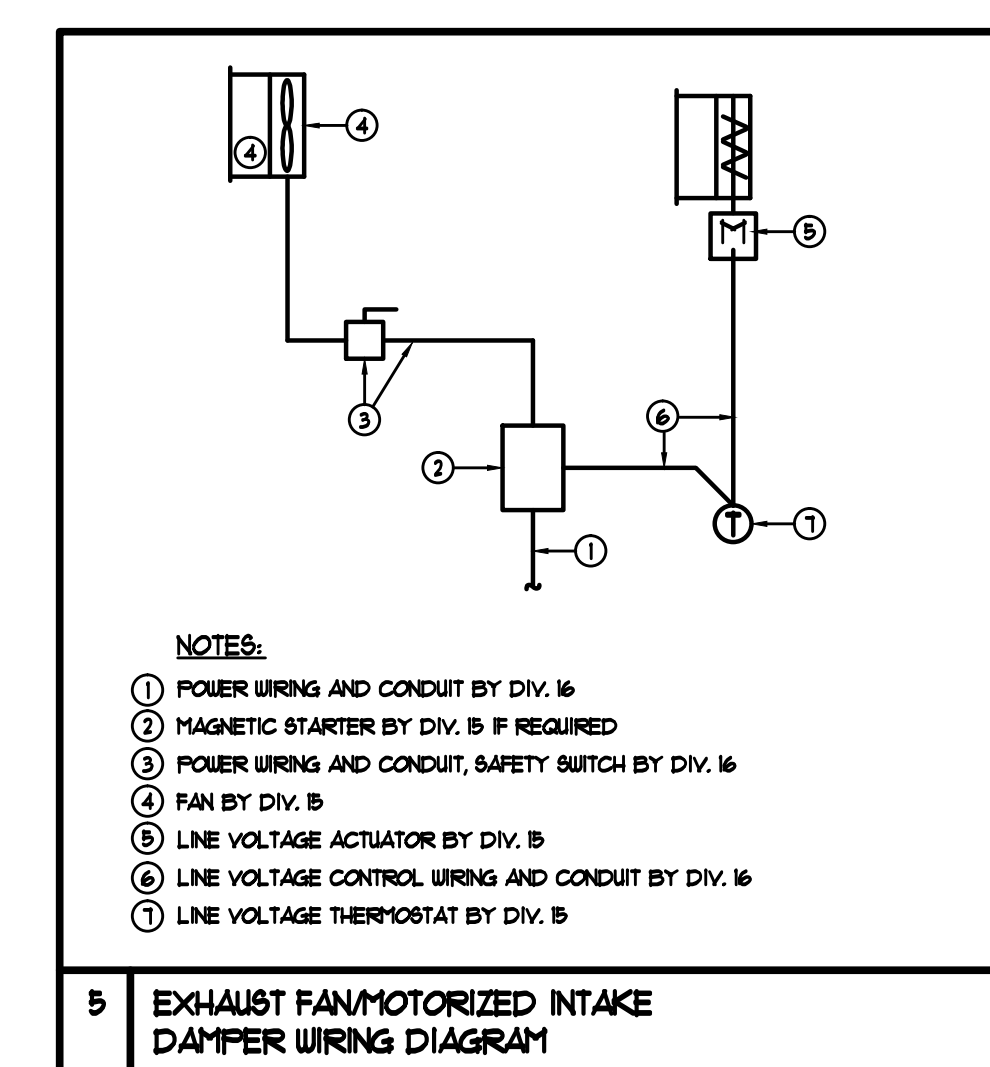
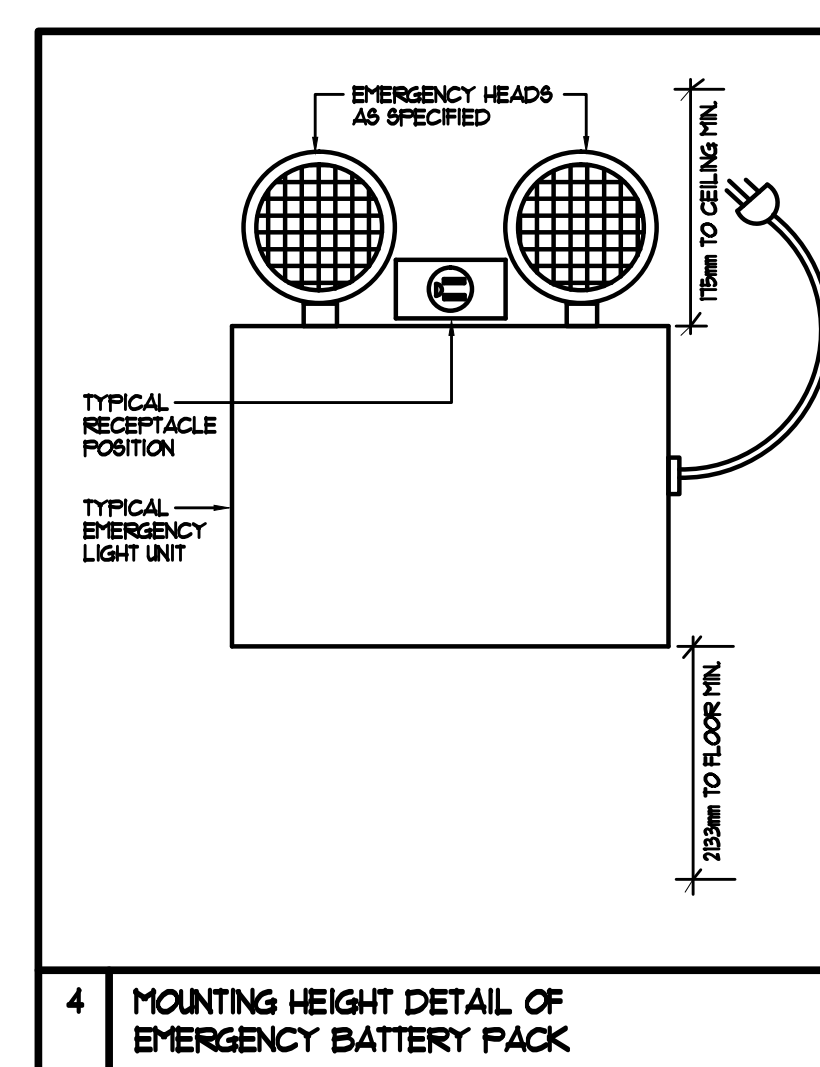
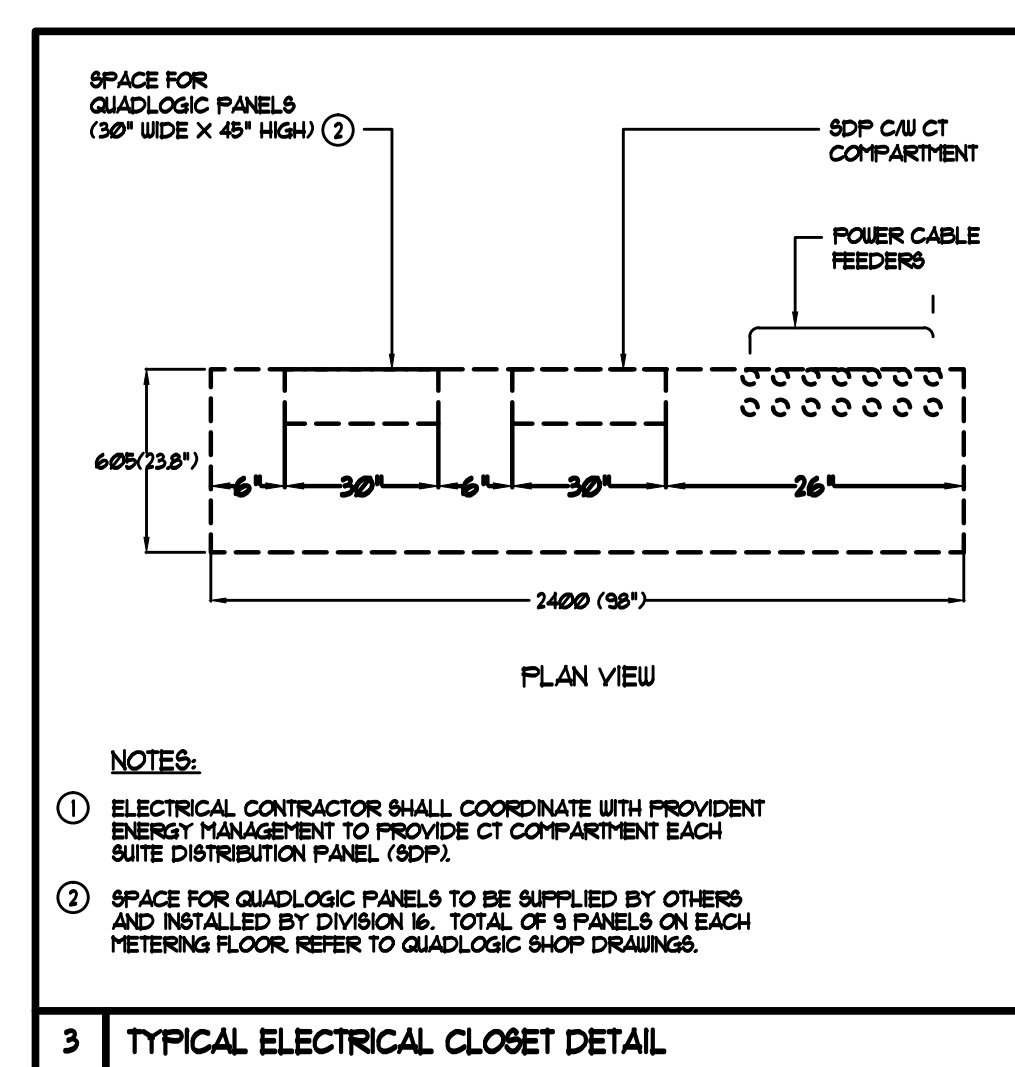
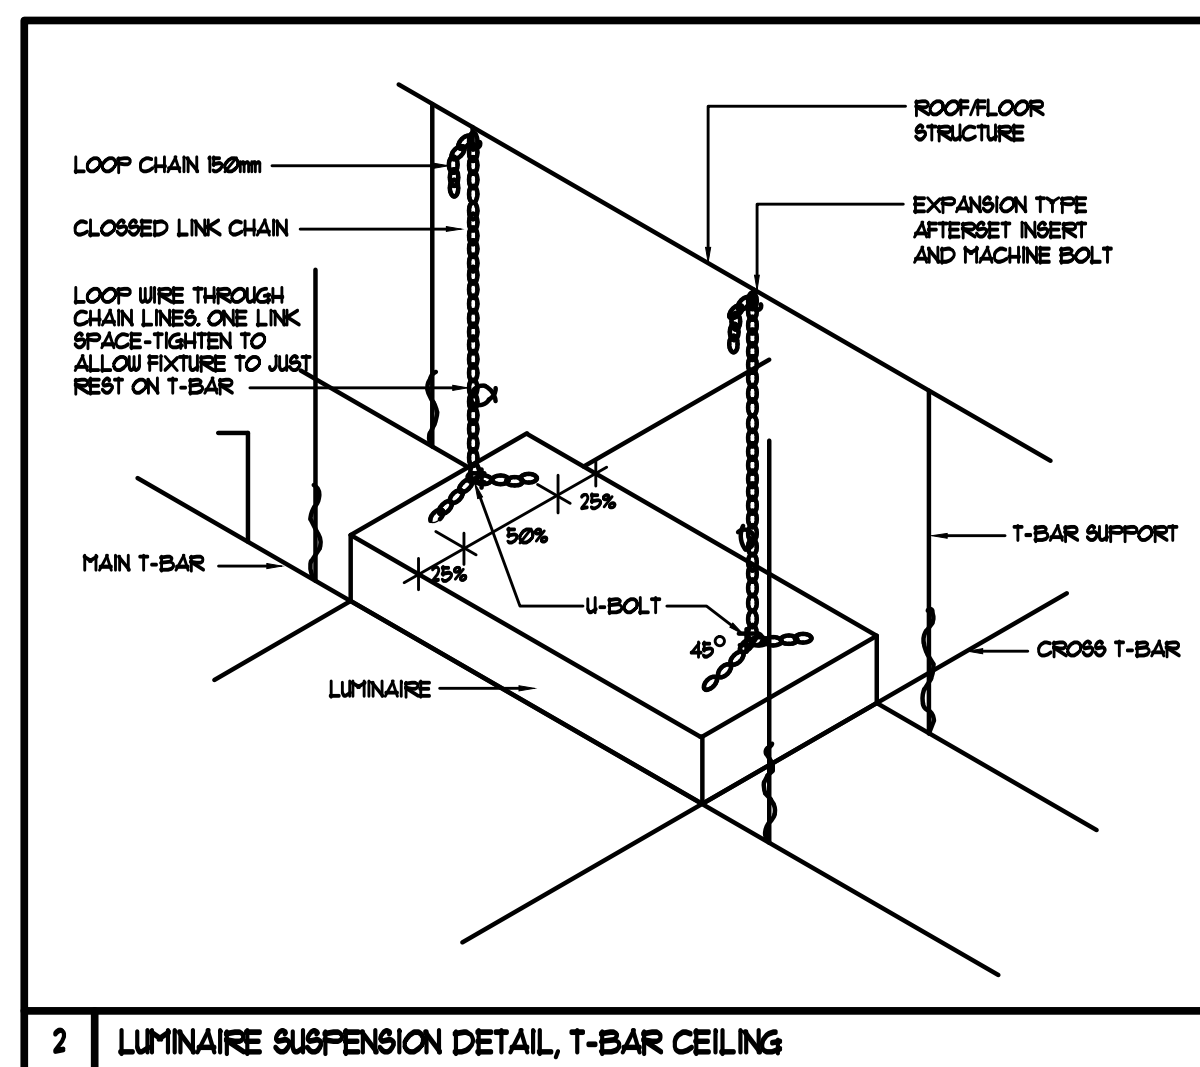
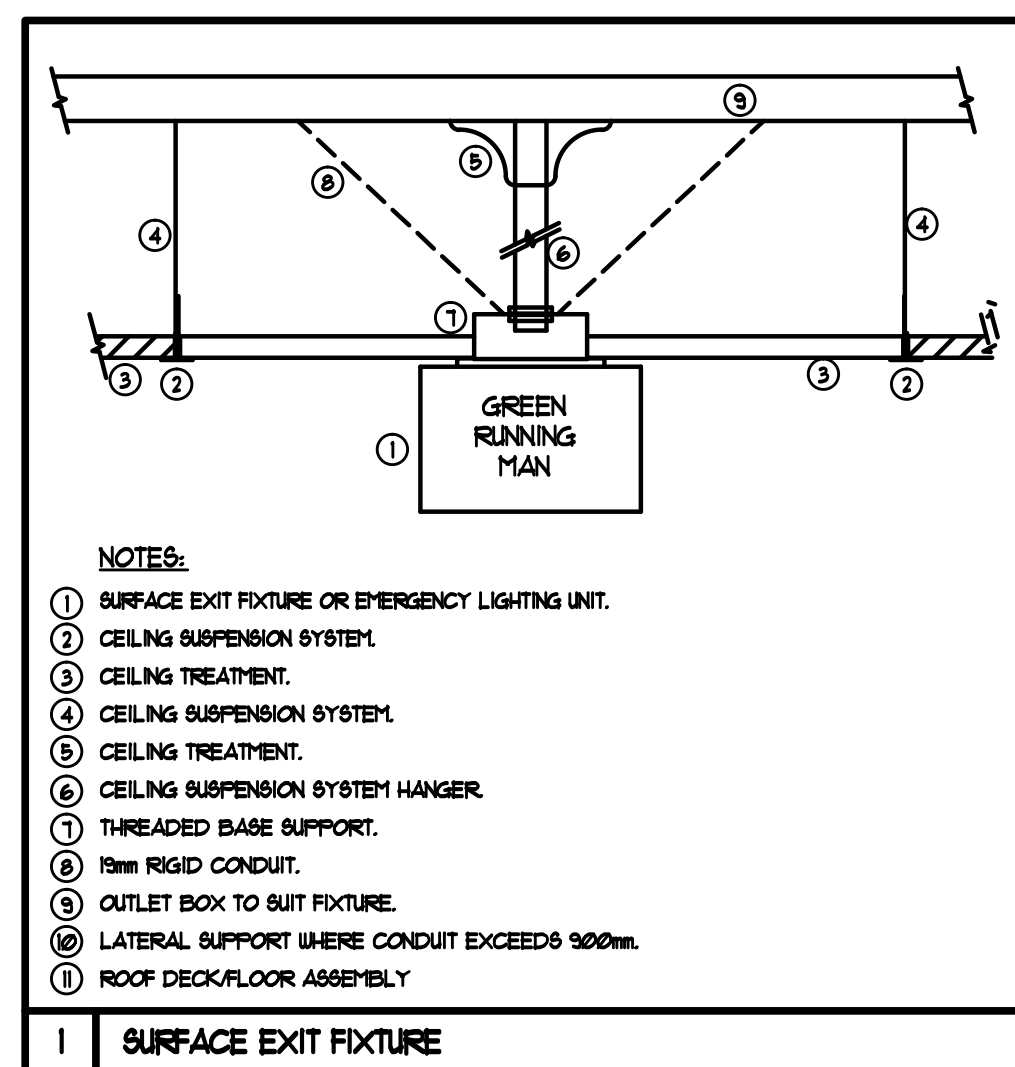


[illegible][illegible]

HAVE YOUR SET PREPARED PRIOR TO FINAL DATE ABOVE DRAWINGS			
CONTRACTOR THAT PREPARE, OR HAVE ALL DIMENSIONS AND CONDITIONS ON THE JOB AND REPORT REQUIREMENTS TO THE ENGINEERS BEFORE PROCEEDING WITH THE WORK. THIS DRAWING IS THE PROPERTY OF THE ENGINEERS AND WILL BE RETURNED UPON COMPLETION OF THE WORK.			
DRAWINGS ARE NOT TO BE SCALED			
			
1175 West Beaver Creek Road, Unit 31 Richmond Hill, Ontario L4B 3H1 Tel: 905-882-5445 Fax: 905-882-5441 Email: calvin@novatrend.com			
ELECTRICAL DETAILS			
DRAWING TITLE: _____ PROJECT: _____ CLIENT: ALEXANDRA PARK 38 CAMERON STREET, BLOCK II TORONTO, ONTARIO			
DATE: FEB 13	DESIGNED BY: S.T. 1313	SCALE: N.T.S.	
		DRAWING NUMBER: E-35	OF: _____