


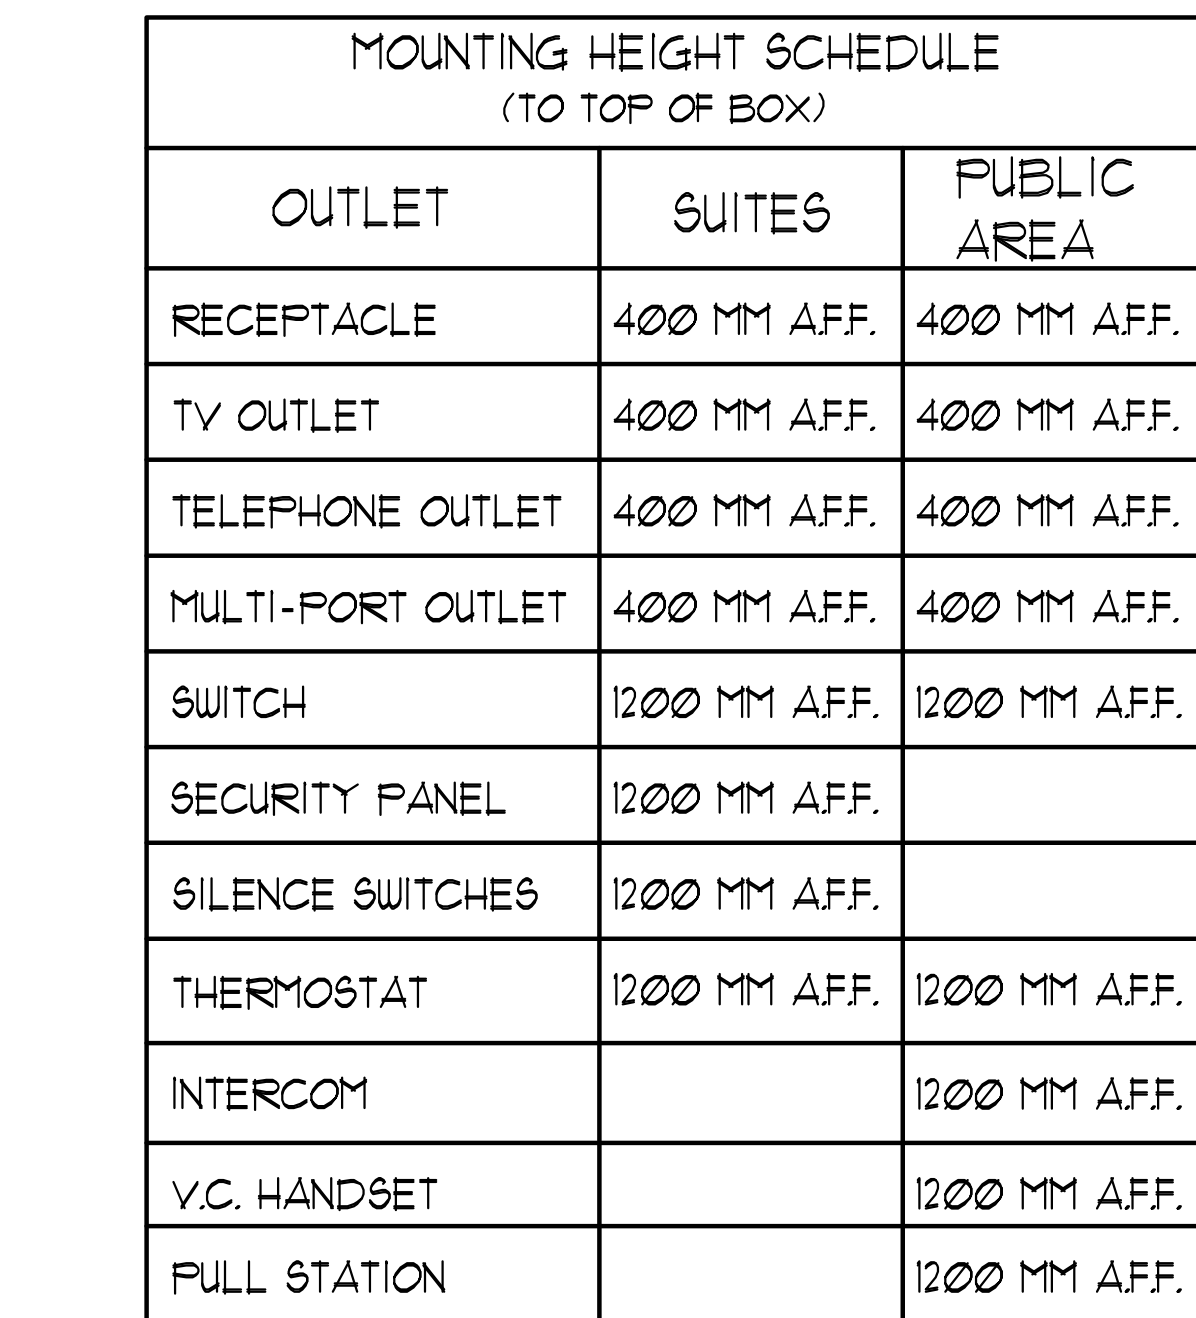

- ## KEY NOTES - RESIDENTIAL - COMMON AREA:
- ① PROVIDE CIRCUITING, REFER TO TABLE #1.
 - ② PROVIDE ALARM SPEAKER SMOKE DETECTOR AND RECEPTACLE AT EVERY THIRD FLOOR STAIR WELL STARTING FROM TOP FLOOR, AS PER TO DWG. E-33 FOR FIRE ALARM RISER DIAGRAM.
 - ③ PROVIDE TELECOMMUNICATION BACKBOARD C/W 115V, 1ø, 15A RECEPTACLE AS PER COMMUNICATION RISER DIAGRAM ON DWG. E-31.
 - ④ CONTRACTOR SHALL REFER TO ELECTRICAL SINGLE LINE DIAGRAM ON DWG. E-30 AND SDP RISER ON DWG. E-31 FOR SDP LOCATIONS AND DISTRIBUTION.
 - ⑤ PROVIDE CONDUIT AS PER RISER DETAIL #9 ON DWG. E-35 FOR TRISORTER CONTROL SYSTEM.
 - ⑥ REFER TO SUPERVISED VALVE AND FLOW SWITCH SCHEDULE ON DWG. E-33 FOR DETAILS ON TYPICAL FLOORS.

DATE	NO.	DESCRIPTION	BT
06/11/10	1	ISSUED FOR SL #E-SLIGHTING ACCIDENT#11	BT
00/11/0	0	ISSUED FOR SECURITY TENDER	BT
01/09/0	0	ISSUED FOR SL #2	BT
00/01/0	0	RE- ISSUED FOR TENDER	BT
00/01/0	0	ISSUED FOR TENDER	BT
01/01/0	0	RE- ISSUED FOR TENDER	BT
00/01/0	0	ISSUED FOR TENDER	BT
DATE	NO.	DESCRIPTION	BT

REVISONS			
CONTRACTOR MUST CHECK AND VERIFY ALL DIMENSIONS AND CONDITIONS OF THE JOB AND REPORT DISCREPANCIES TO THE DRAWER BEFORE PROCEEDING WITH THE WORK. THIS DRAWING IS THE PROPERTY OF THE ENGINEER AND WILL BE RETURNED UPON COMPLETION OF THE WORK.			
DRAWINGS ARE NOT TO BE SCALED			
			
175 West Beaver Creek Road, Unit 31 Richmond Hill, Ontario L4B 3M1 Tel: 905-882-5448 Fax: 905-882-5441 Email: csd@novatransdeng.com			
DRAWING TITLE: 5/F NORTH FLOOR PLAN ELECTRICAL LAYOUT			
PROJECT TITLE: ALEXANDRA PARK			
38 CARRIDGE STREET, CHERRYVILLE ONTARIO			
DRAWN BY: S.O.	CHECKED BY: S.T.	SCALE: 1:50	
DATE: FEB, 13	PROJECT NUMBER: 1313	DRAWING NUMBER: E-15 of 04	

