


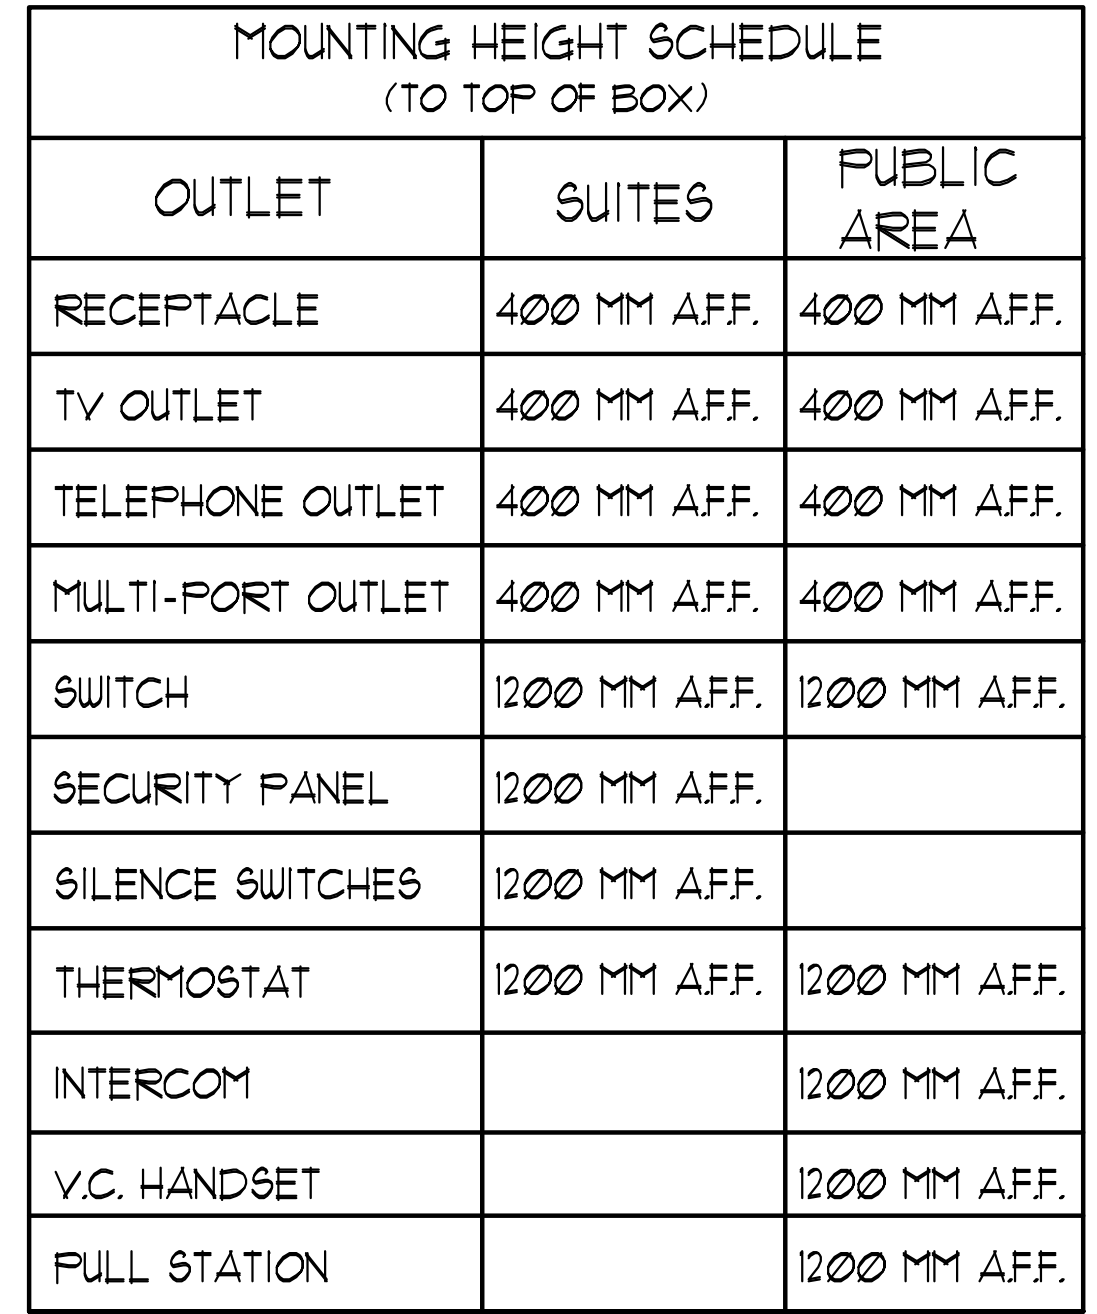

KEY NOTES - INQUIRY:

- 1) DESIGNATED "LAUNDRY RECEPTACLE" AS DEFINED BY EISA CODES 26-1108 (E111) 26-TIME-2, AND EISA EULETIN 26-126-2 (WITHIN 3M RADIUS OF LAUNDRY CLOSET). RECEPTACLE SHALL BE CONNECTED TO A DEDICATED CIRCUIT. SEE DETAIL #4 ON DWG. E-35.
- 2) SUITE DOOR CONTACTS AND GLASS BREAK DETECTOR WILL COMPLETE WITH INTRUSION ALARM SYSTEM THAT CONTACT TO THE CONCIERGE STATION. (TYPICAL)
- 3) FOR FAN COIL UNITS (FCU) ELECTRICAL CONTRACTOR TO SUPPLY AND INSTALL CONDUIT AND JUNCTION BOX FOR REBIL. THERMOSTAT. MECHANICAL CONTRACTOR SHALL SUPPLY, WIRE, TERMINATE WIRING AND MOUNT THERMOSTAT.
- 4) INSTALL SIDE-MOUNTED RECEPTACLE ON KITCHEN ISLAND CABINET.
- 5) SWITCHES, RECEPTACLES, ETC. TO BE INSTALLED AS TO NOT INTERFERE WITH THE OPENING AND OPERATION OF SLIDING DOOR.



-

			
115 West Beaver Creek Road, Unit 31 Richmond Hill, Ontario L4B 3M1 Tel: 905 882-5448 Fax: 905 882-5447 Email: cad@novatrend.com			
PROJECT: 2/F SOUTH PLAN ELECTRICAL LAYOUT			
PROJECT TITLE: ALEXANDRA PARK			
38 CARMON STREET, BLOCK 11 TORONTO, ONTARIO			
DRAWN BY: S.O.	DESIGNED BY: S.T.	SCALE: 1:50	
DATE: FEB, 13	PROJECT NUMBER: E-20	DRAWING NUMBER: 01	