


KEY NOTES - INSUITE:

- 1 DESIGNATED "LAUNDRY RECEPTACLE" AS DEFINED BY ESA CODE 26-120(a)(11), 26-120(b) and ESA BULLETIN 26-26-0 (WITHIN 3" RADIUS OF LAUNDRY CLOSET). RECEPTACLE SHALL BE CONNECTED TO A DEDICATED CIRCUIT. SEE DETAIL #4 ON DWG. E-35.
- 2 SUITE DOOR CONTACTS AND GLASS BREAK DETECTOR WILL COMPLETE WITH INTRUSION ALARM SYSTEM THAT CONTACT TO THE CONCIERGE STATION. (TYPICAL)
- 3 FOR FAN COIL UNITS (FCU) ELECTRICAL CONTRACTOR TO SUPPLY AND INSTALL CONDUIT AND JUNCTION BOX FOR REHEAT/COOL. MECHANICAL CONTRACTOR SHALL SUPPLY, WIRE, TERMINATE WIRING AND MOUNT THERMOSTAT.
- 4 INSTALL SIDE-MOUNTED RECEPTACLE ON KITCHEN ISLAND CABINET.
- 5 SWITCHES, RECEPTACLES, ETC. TO BE INSTALLED AS TO NOT INTERFERE WITH THE OPENING AND OPERATION OF SLIDING DOOR.

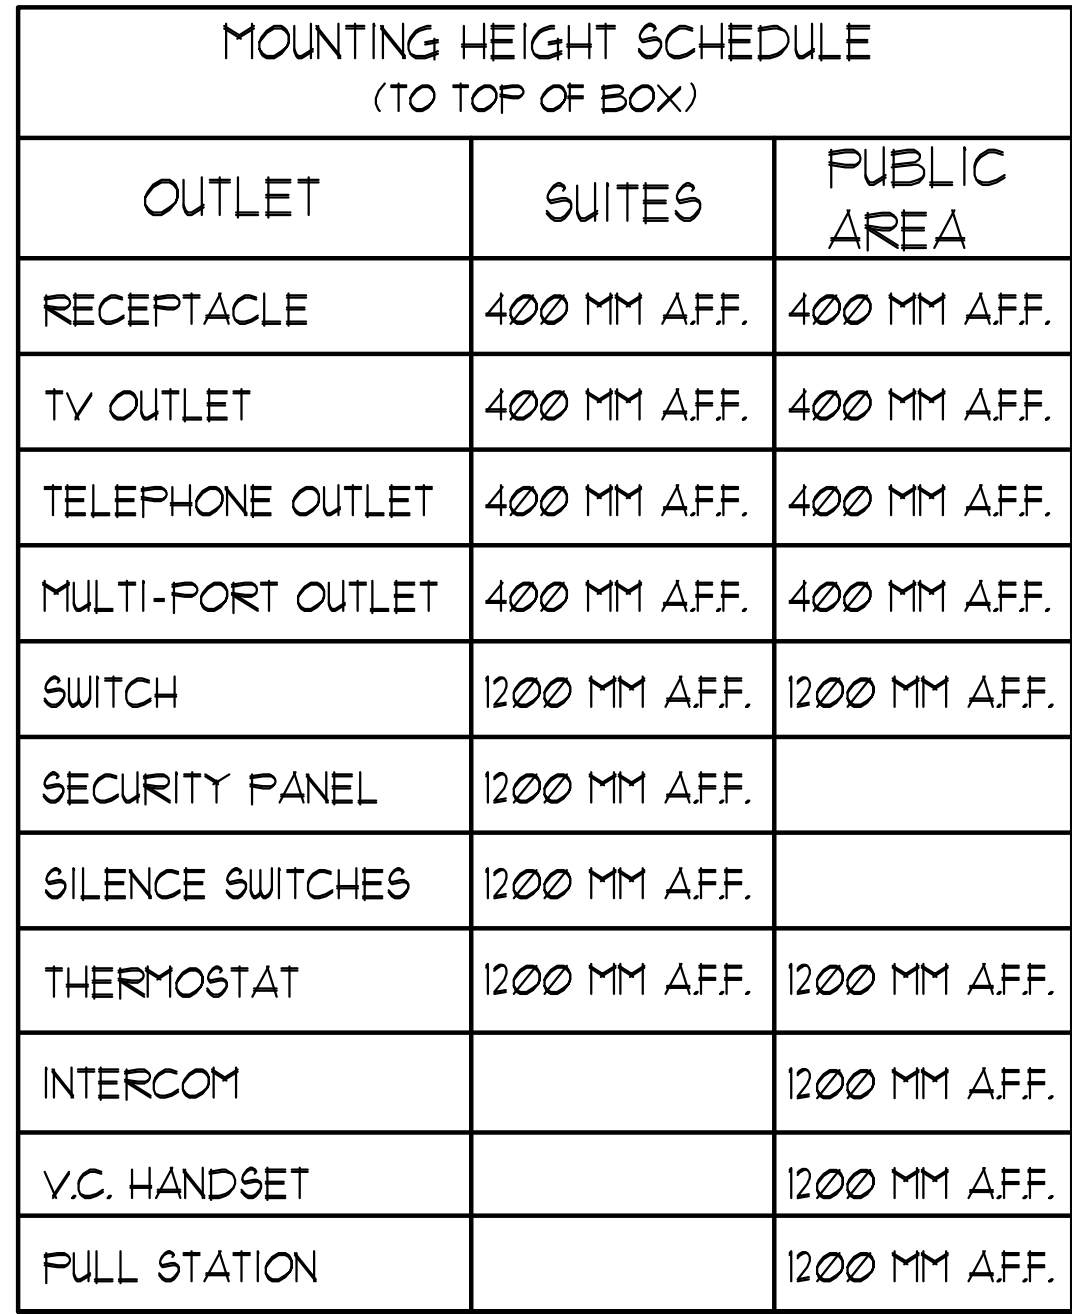

REVISONS CONTRACTOR MUST CHECK AND VERIFY ALL DIMENSIONS AND CONDITIONS ON THE JOB AND REPORT DISCREPANCIES TO THE ENGINEER BEFORE PROCEEDING WITH THE WORK. THIS DRAWING IS THE PROPERTY OF THE ENGINEER AND WILL BE RETAINED UPON COMPLETION OF THE WORK. DRAWINGS ARE NOT TO BE SCALED			
			
175 West Beaver Creek Road, Unit 31 Richmond Hill, Ontario L4B 3P1 Tel: 905 882-5445 Fax: 905 882-5441 Email: cad@novatransdeng.com			
DRAWING TITLE: 2/F NORTH FLOOR PLAN ELECTRICAL LAYOUT			
PROJECT TITLE: ALEXANDRA PARK			
38 CAMERON STREET, BLOCK II TORONTO, ONTARIO			
DRAWN BY: S.O.	CHECKED BY: S.T.	SCALE: 1:50	
DATE: FEB, 13	PROJECT NUMBER: 1313	DRAWING NUMBER: E-21	OF