
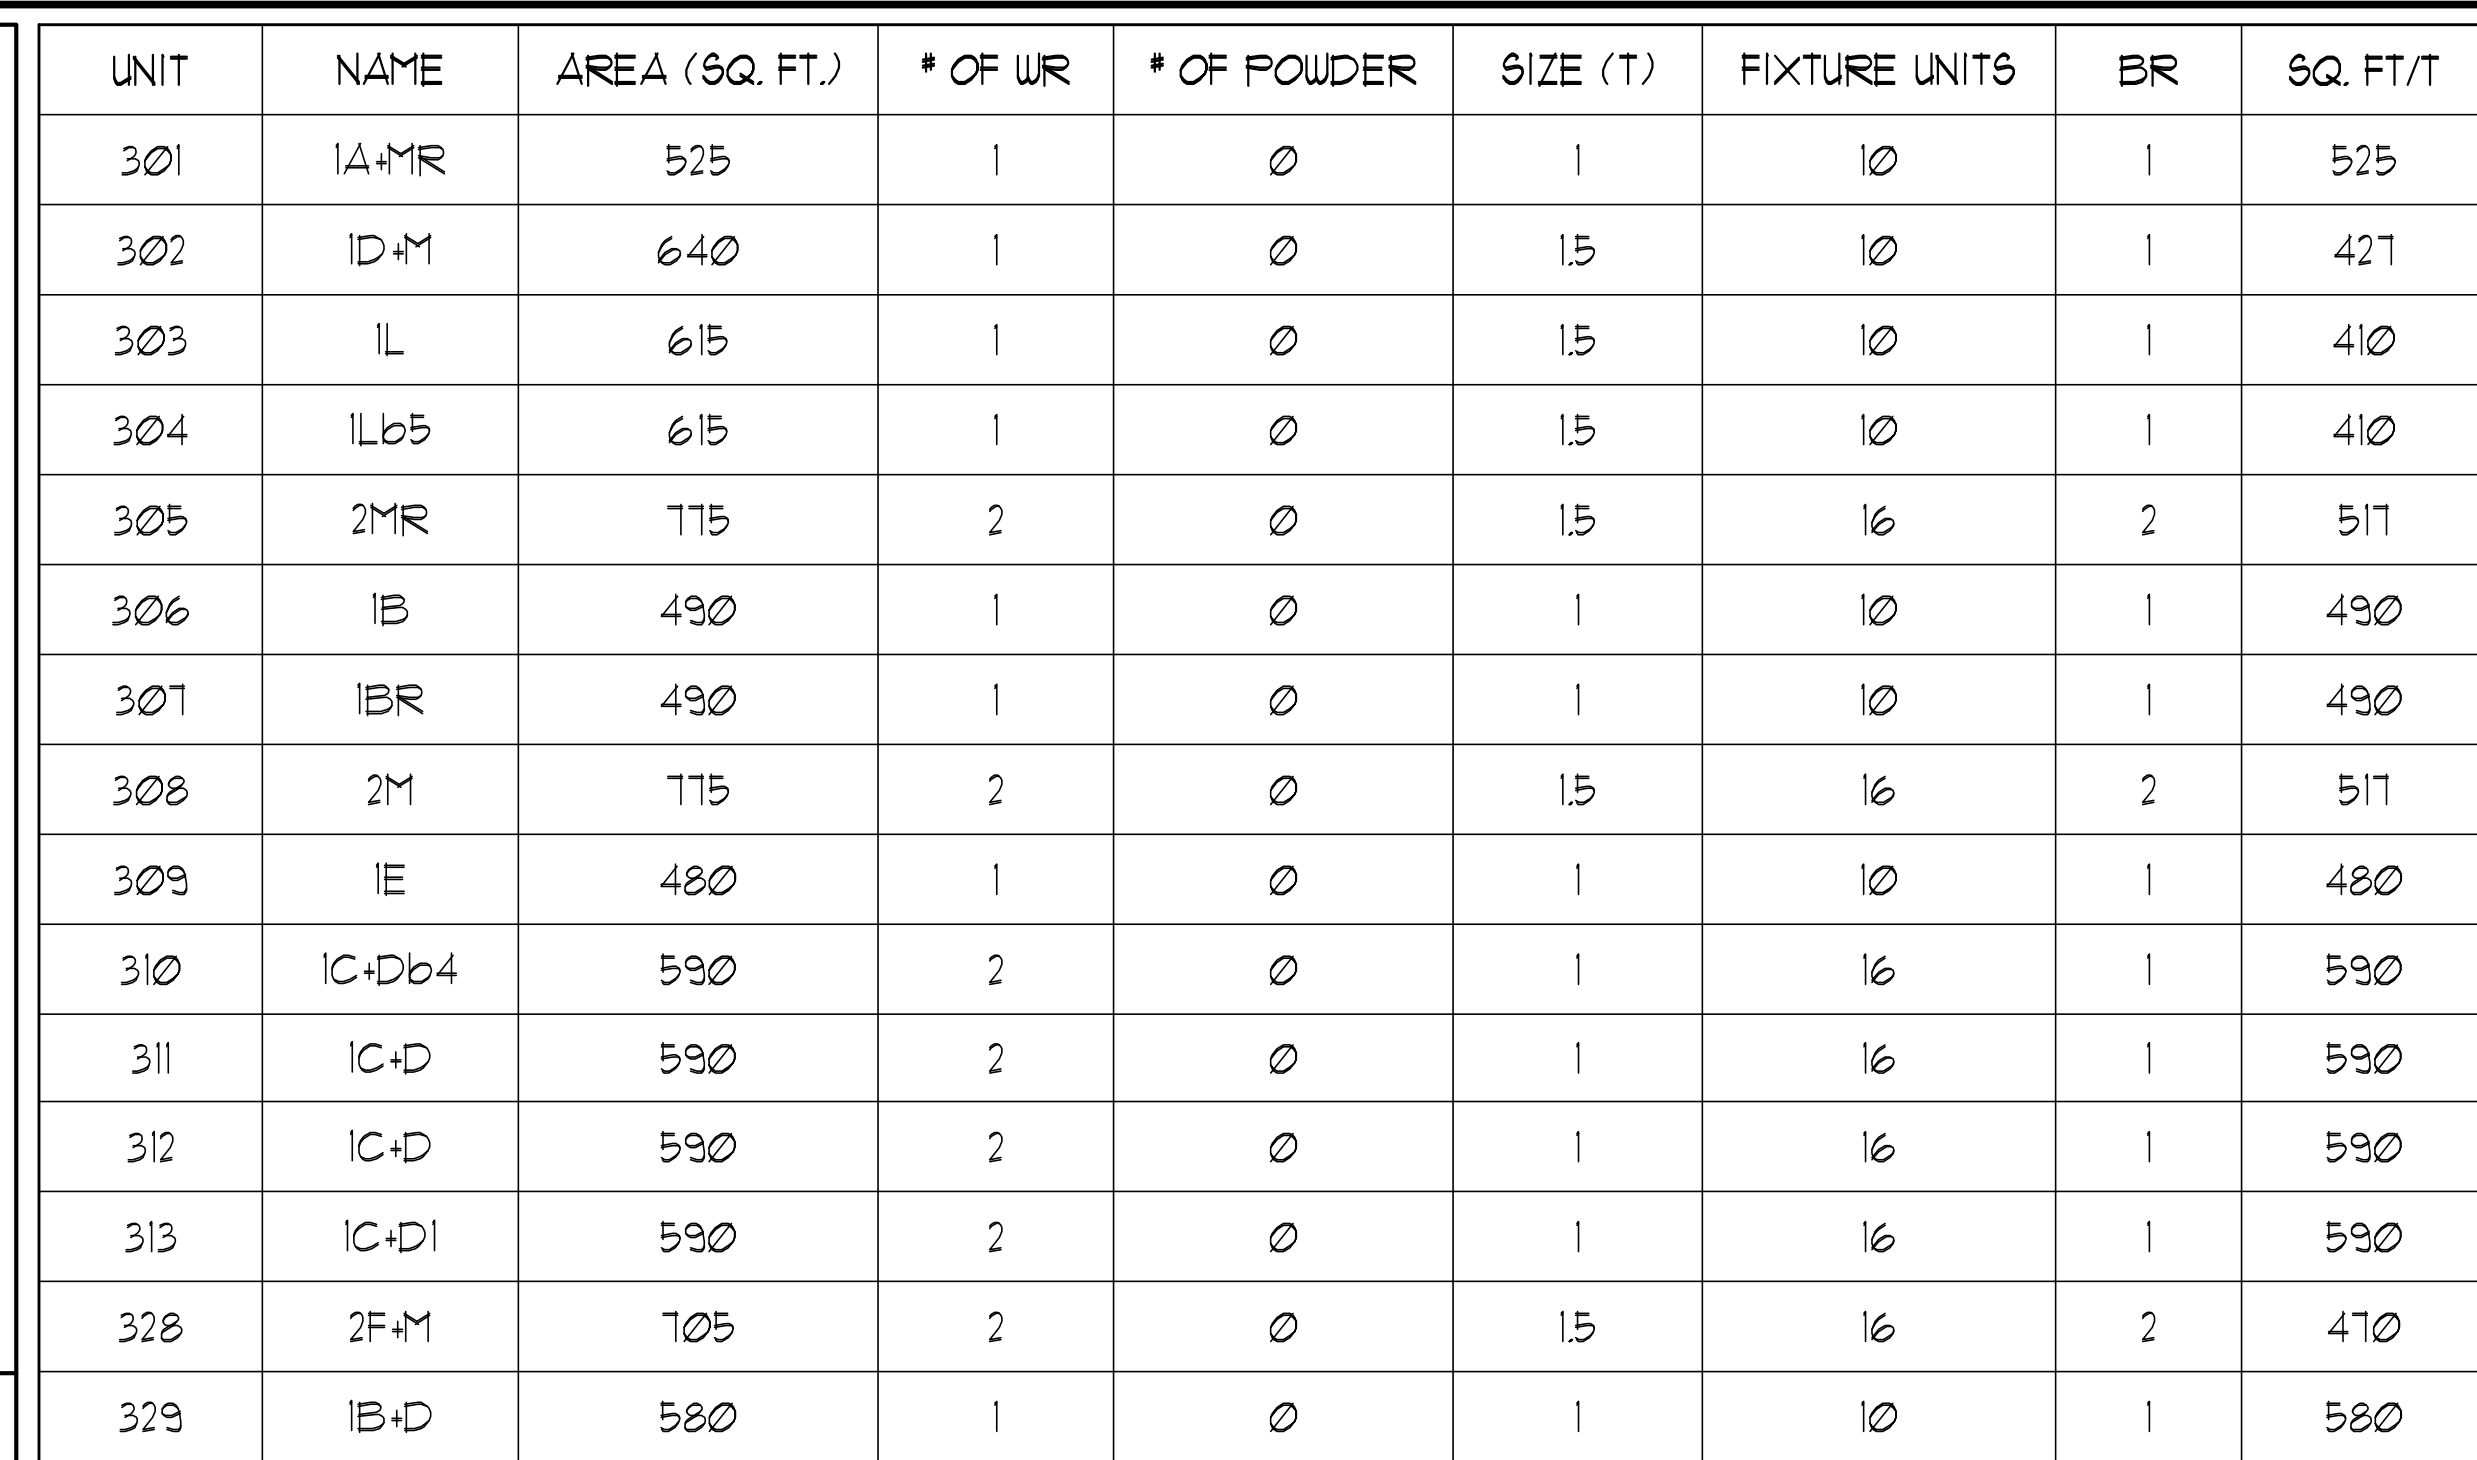



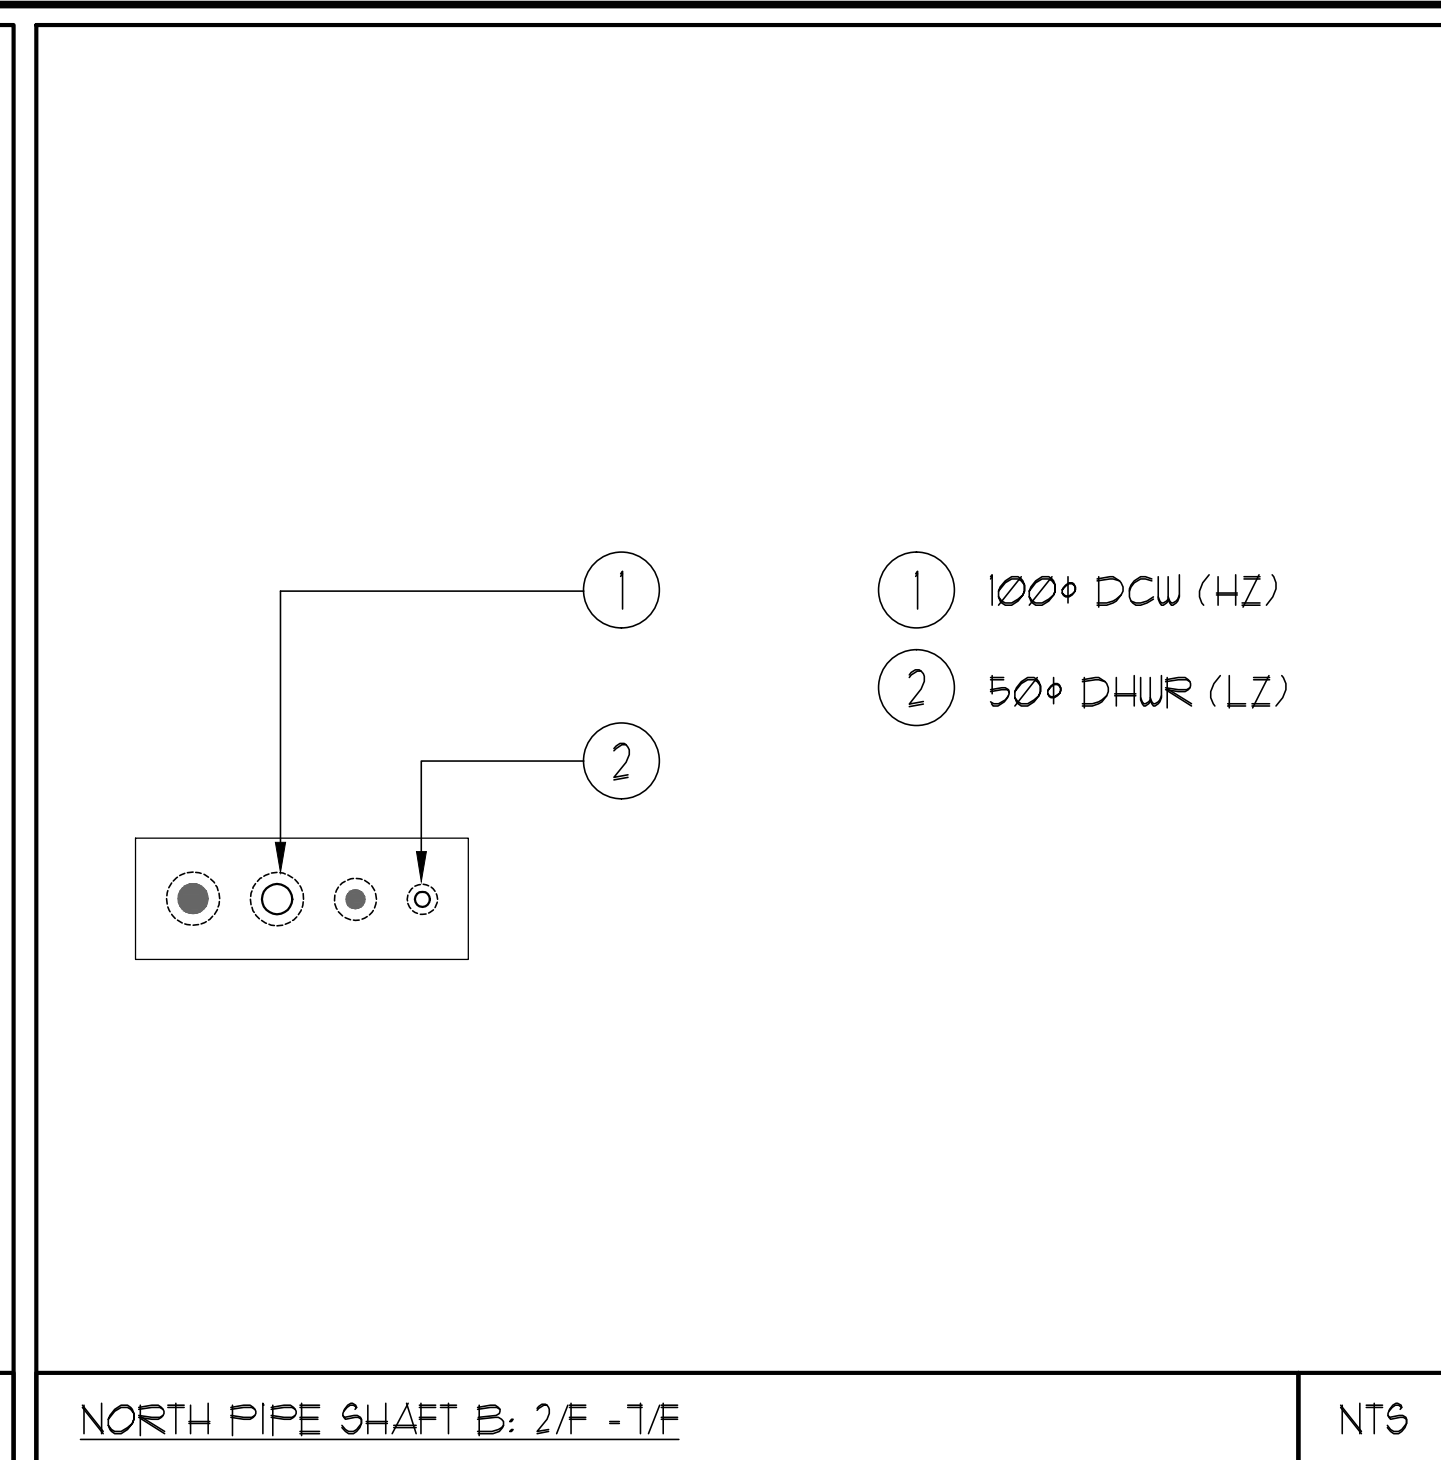


VERTICAL FAN COIL SIZE		
DESIGNATION	MODEL	W x D
FCU-1T	450	508x660
FCU-1.5T	600	508x660
FCU-2T	800	508x660
FCU-2.5T	1000	559x660
FCU-3T	1200	559x660


NOTE:
A MIN. OF 125mm IS REQUIRED ON THE SIDE OF PIPE RISER.

DESIGNATION	L/s	DUCT SIZE	DESIGNATION	L/s	DUCT SIZE
(A)	47	100x150	(G)	189	350x150
(B)	71	150x150	(H)	236	450x150
(C)	94	200x150	(J)	283	500x150
(D)	118	200x150	(K)	330	600x150
(E)	141	250x150	(L)	377	500x200
(F)	165	300x150			

- REFER TO DWG. M-X FOR ACOUSTIC NOTES
- CLEAR FLOOR TO UNDERSLAB = 2590mm
 CLEAR PRODUCT = 2550mm

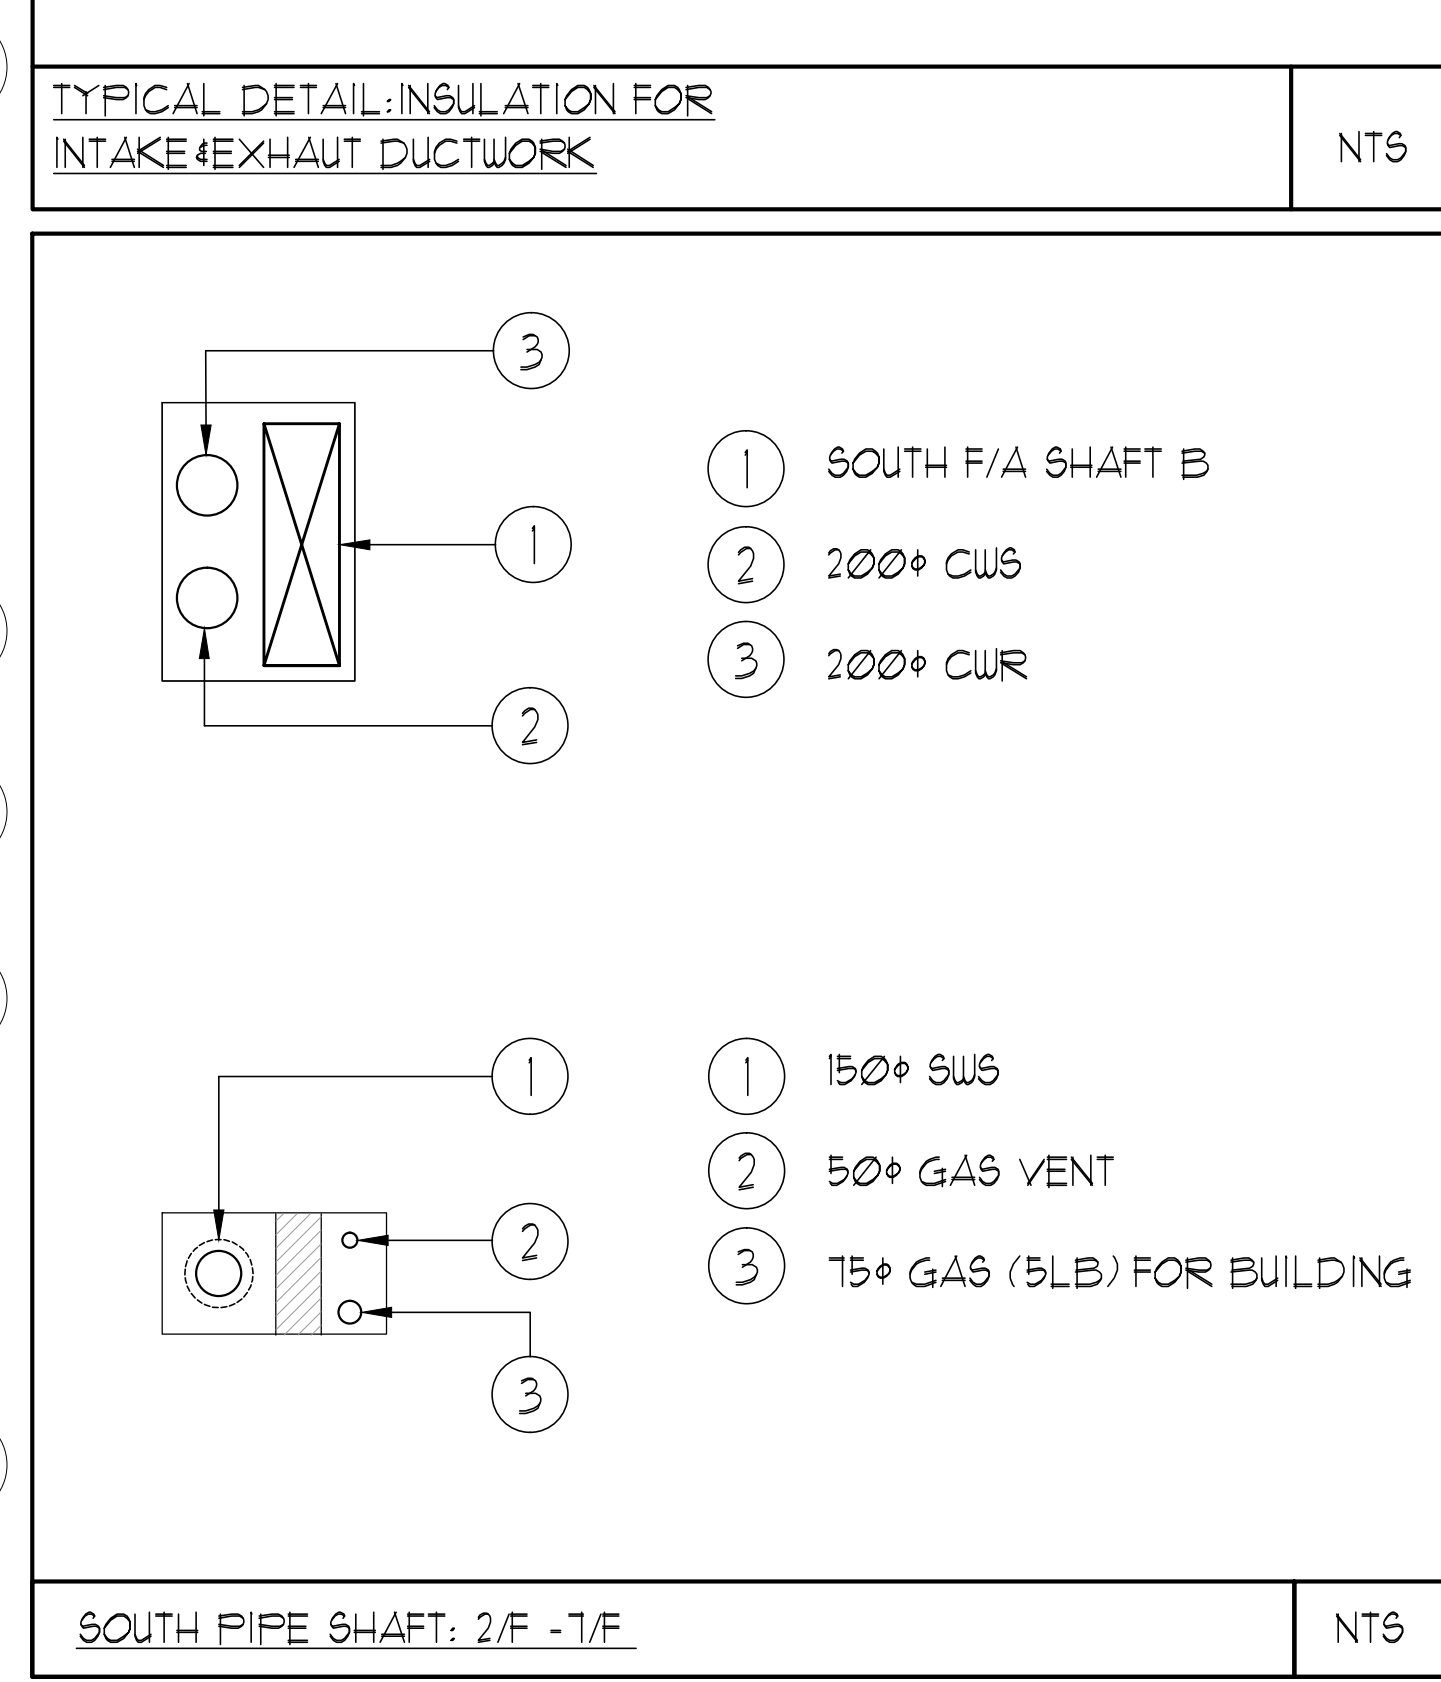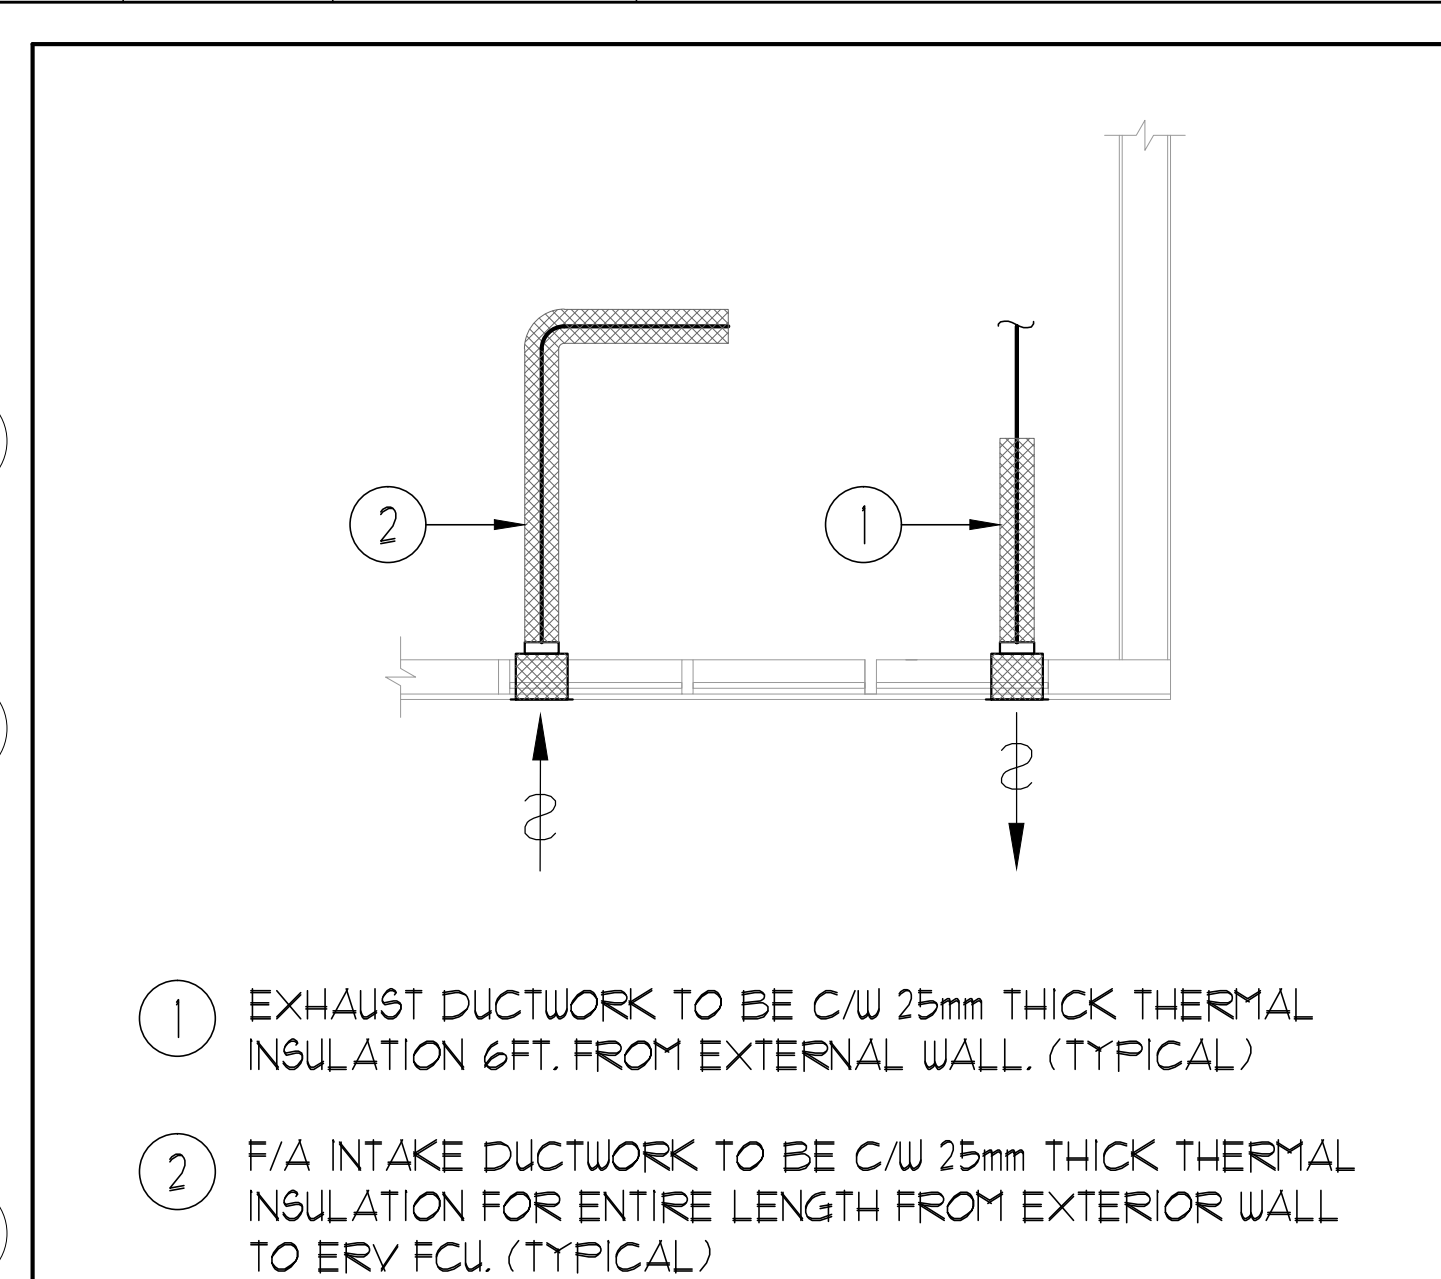[illegible]

- NOTES:
- ① NORTH F/A SHAFT SERVING FROM G/F TO 14/F. F/A DUCT SERVING CORRIDOR FROM G/F TO 14/F. SEE VENTILATION RISER DIAGRAM FOR DETAILS.
 - ② PIPE SHAFT - REFER TO PIPE RISER DETAIL ON THIS DRAWING FOR DETAILS.
 - ③ 150° KITCHEN / DRYER / W/R / FCU INTAKE / FCU EXHAUST DUCT.
(TYPICAL UNLESS OTHERWISE NOTED)
 - ④ SOUTH F/A SHAFT B FROM G/F TO 14/F. F/A DUCT SERVING CORRIDOR FROM 9/F TO 14/F. SEE VENTILATION RISER DIAGRAM FOR DETAILS.

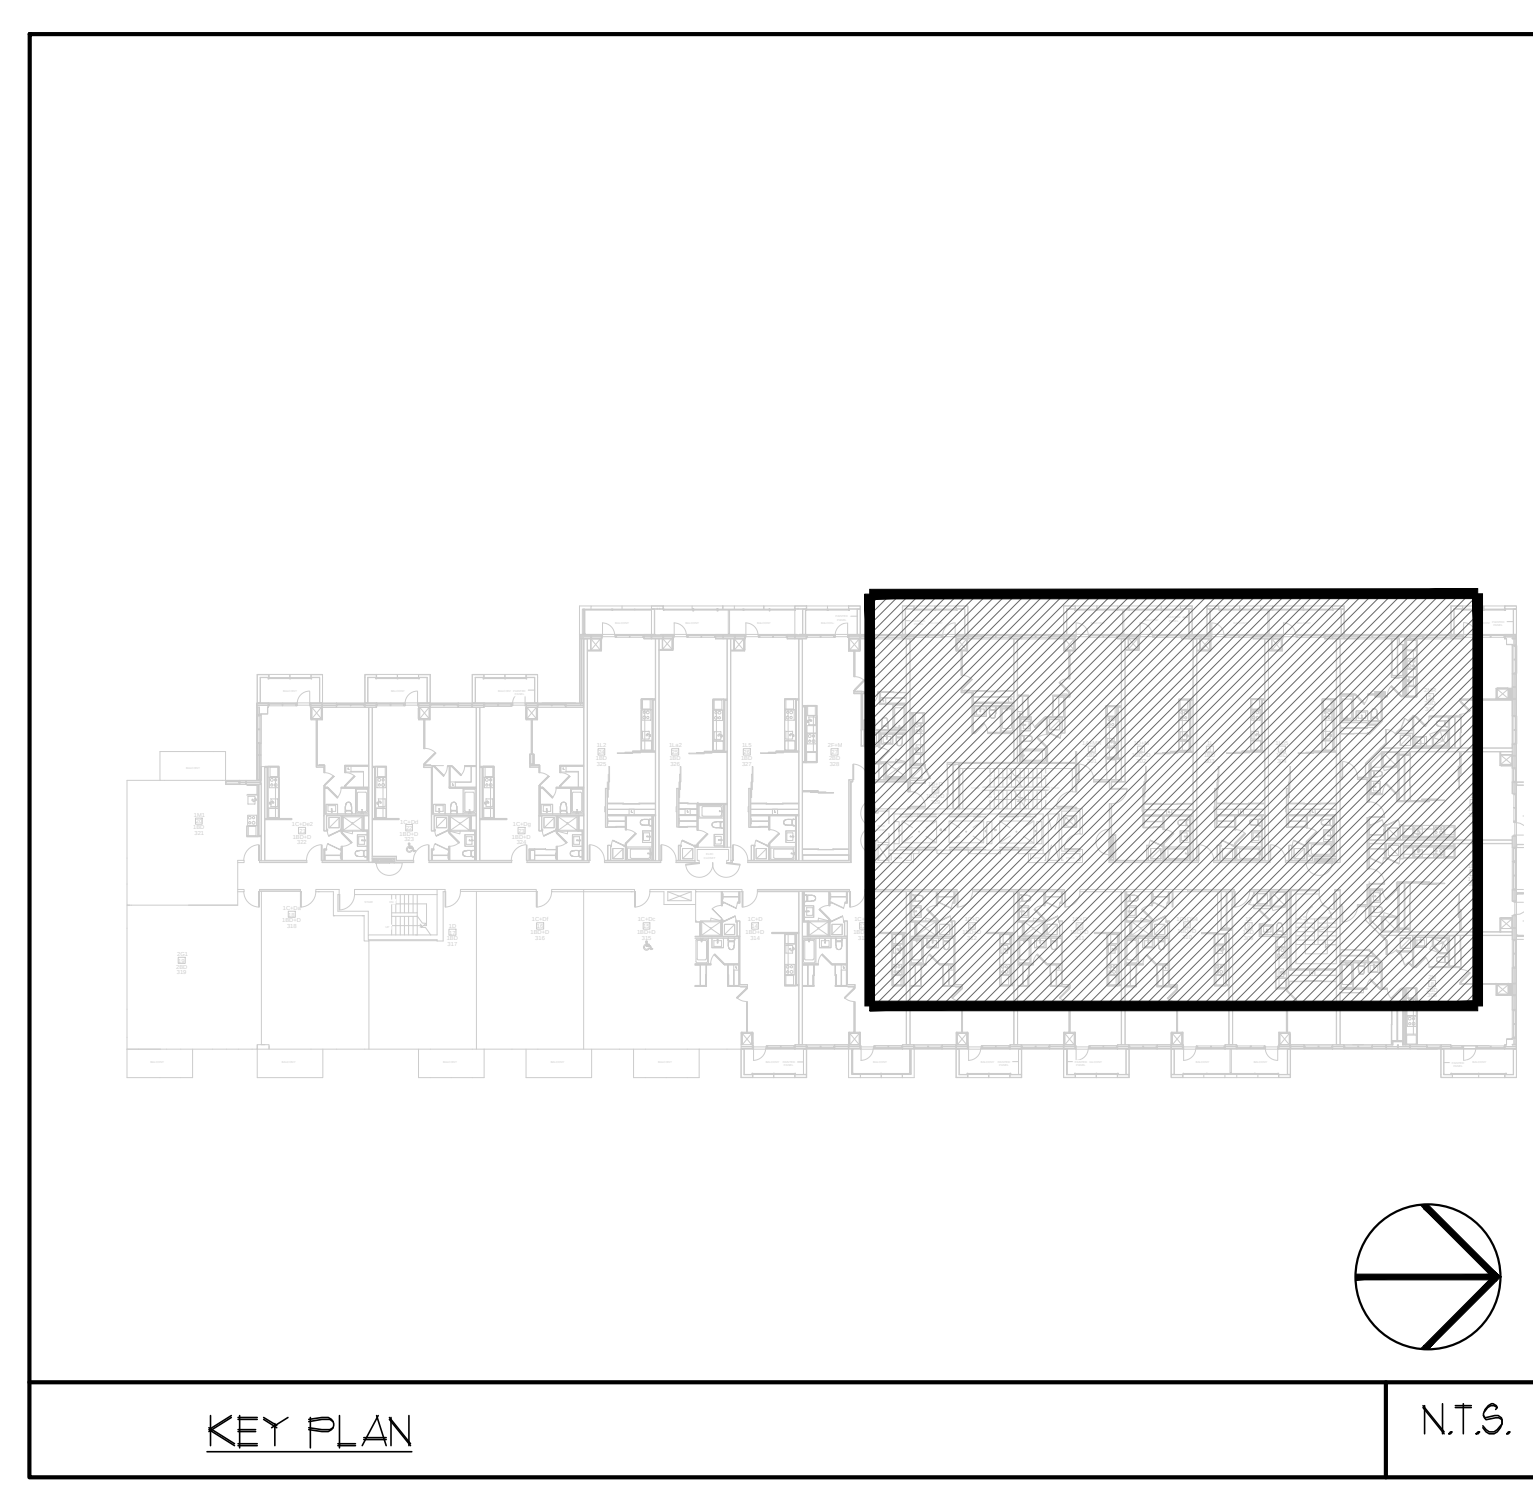

			
IT5 West Beaver Creek Road Unit 31 Richmond Hill, Ontario L4B 3M1 Tel: 905 882-5445 Fax: 905 882-5447 Email: cad@novaconsulting.com			
DRAWING TITLE: 3/F NORTH MECHANICAL LAYOUT			
PROJECT TITLE: ALEXANDRA PARK			
XXX TORONTO		ONTARIO	
DRAWN BY: G.S.	CHECKED BY: E.P.	SCALE: 1:50	
DATE: FEB 13	PROJECT NUMBER: 1313	DRAWING NUMBER: M-15	OF 39