

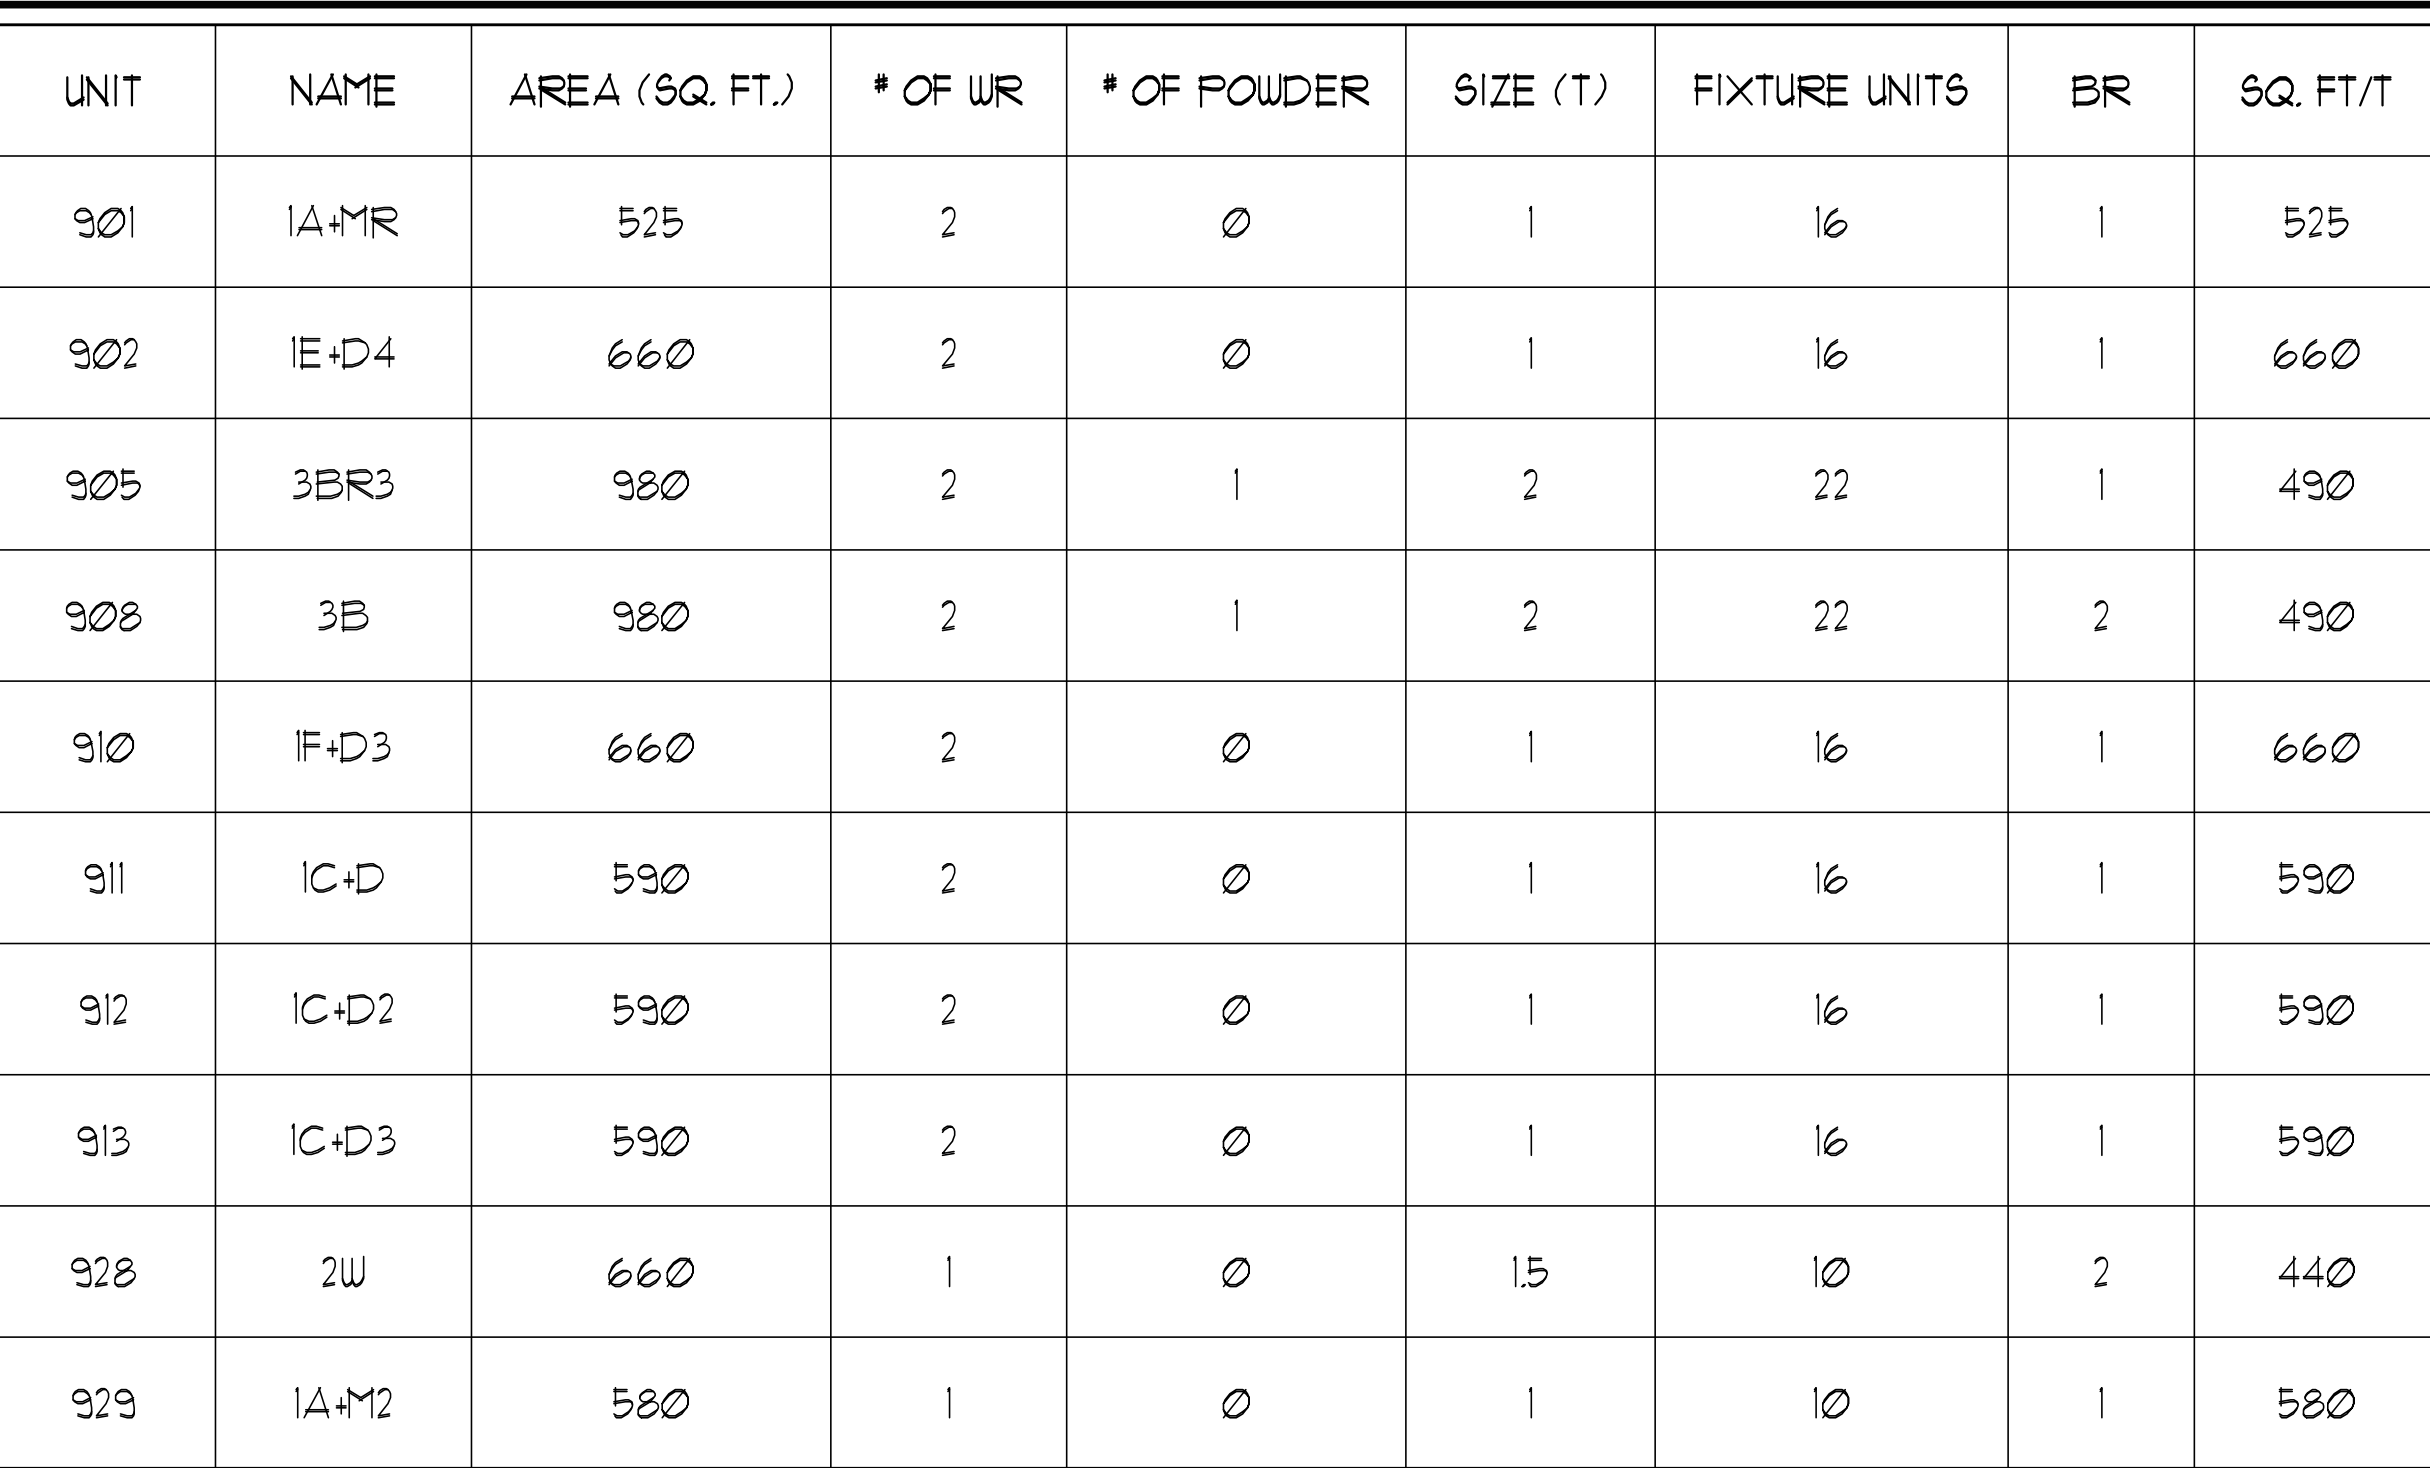
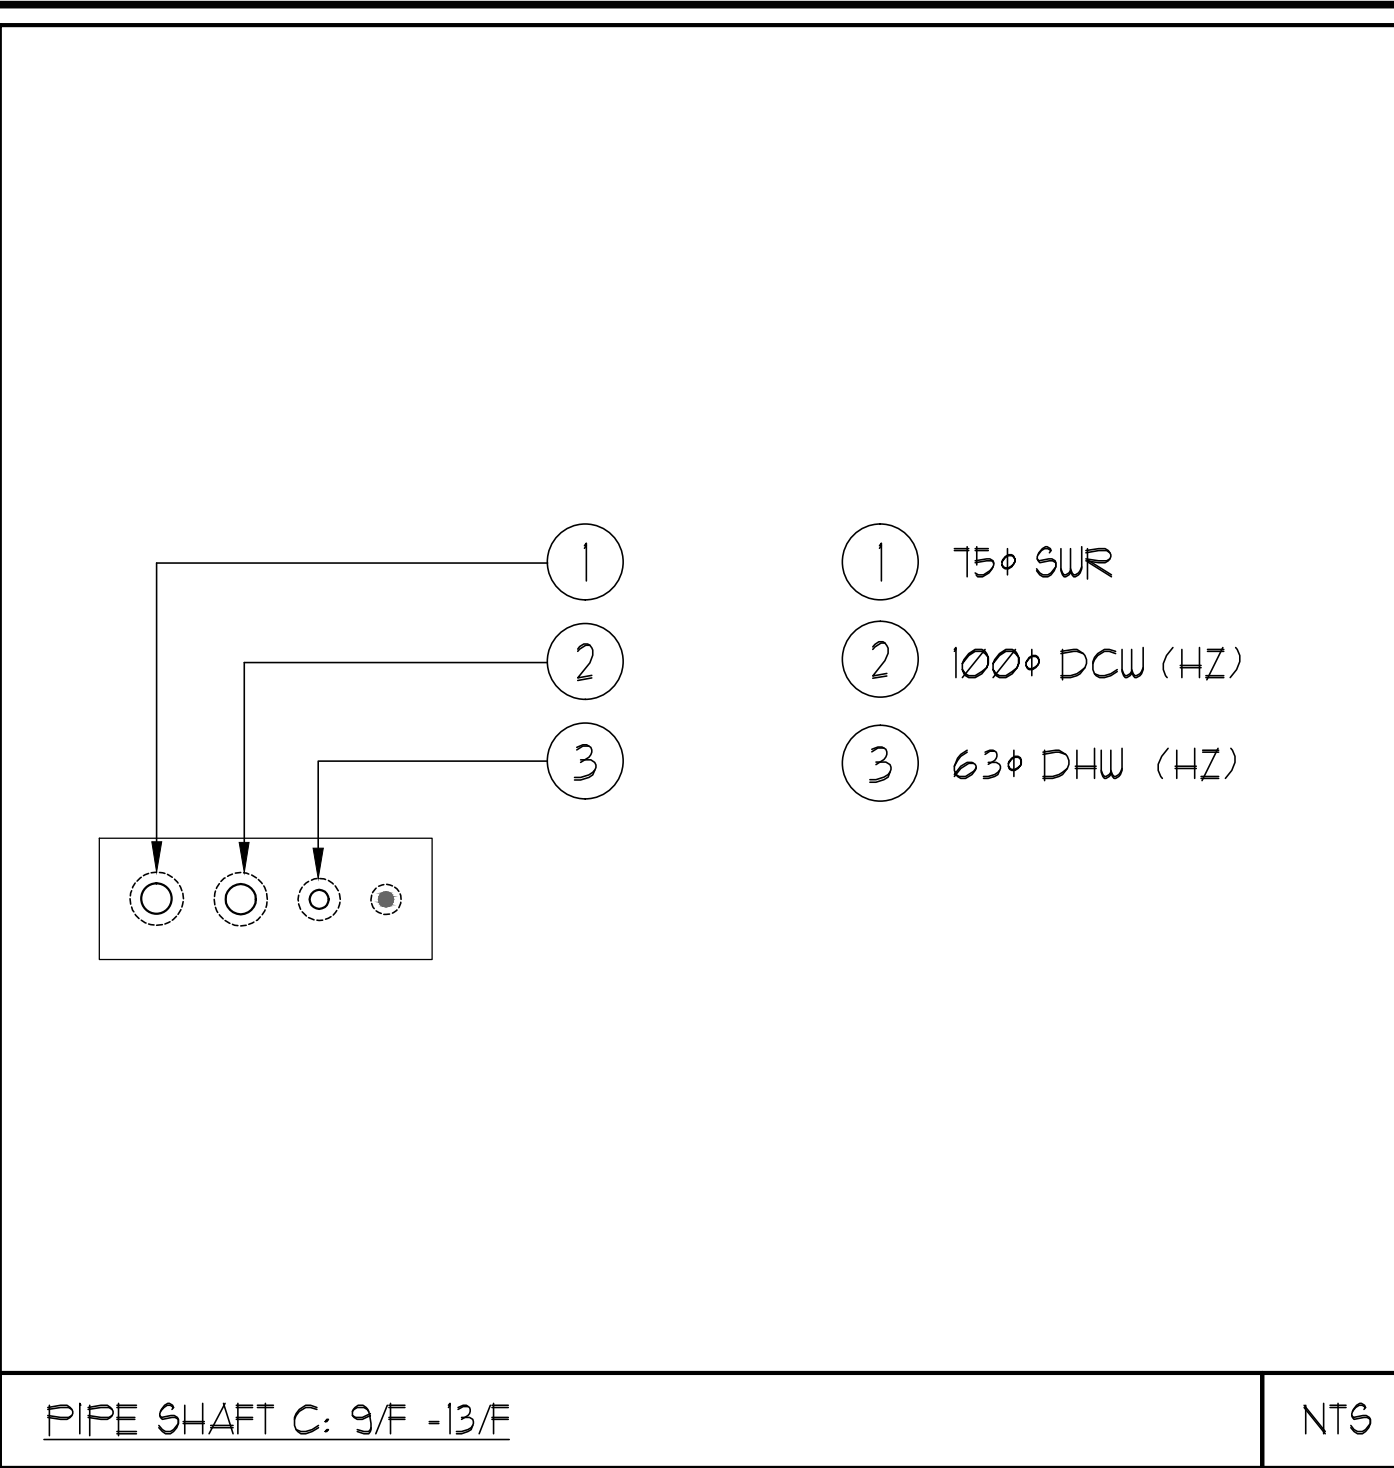


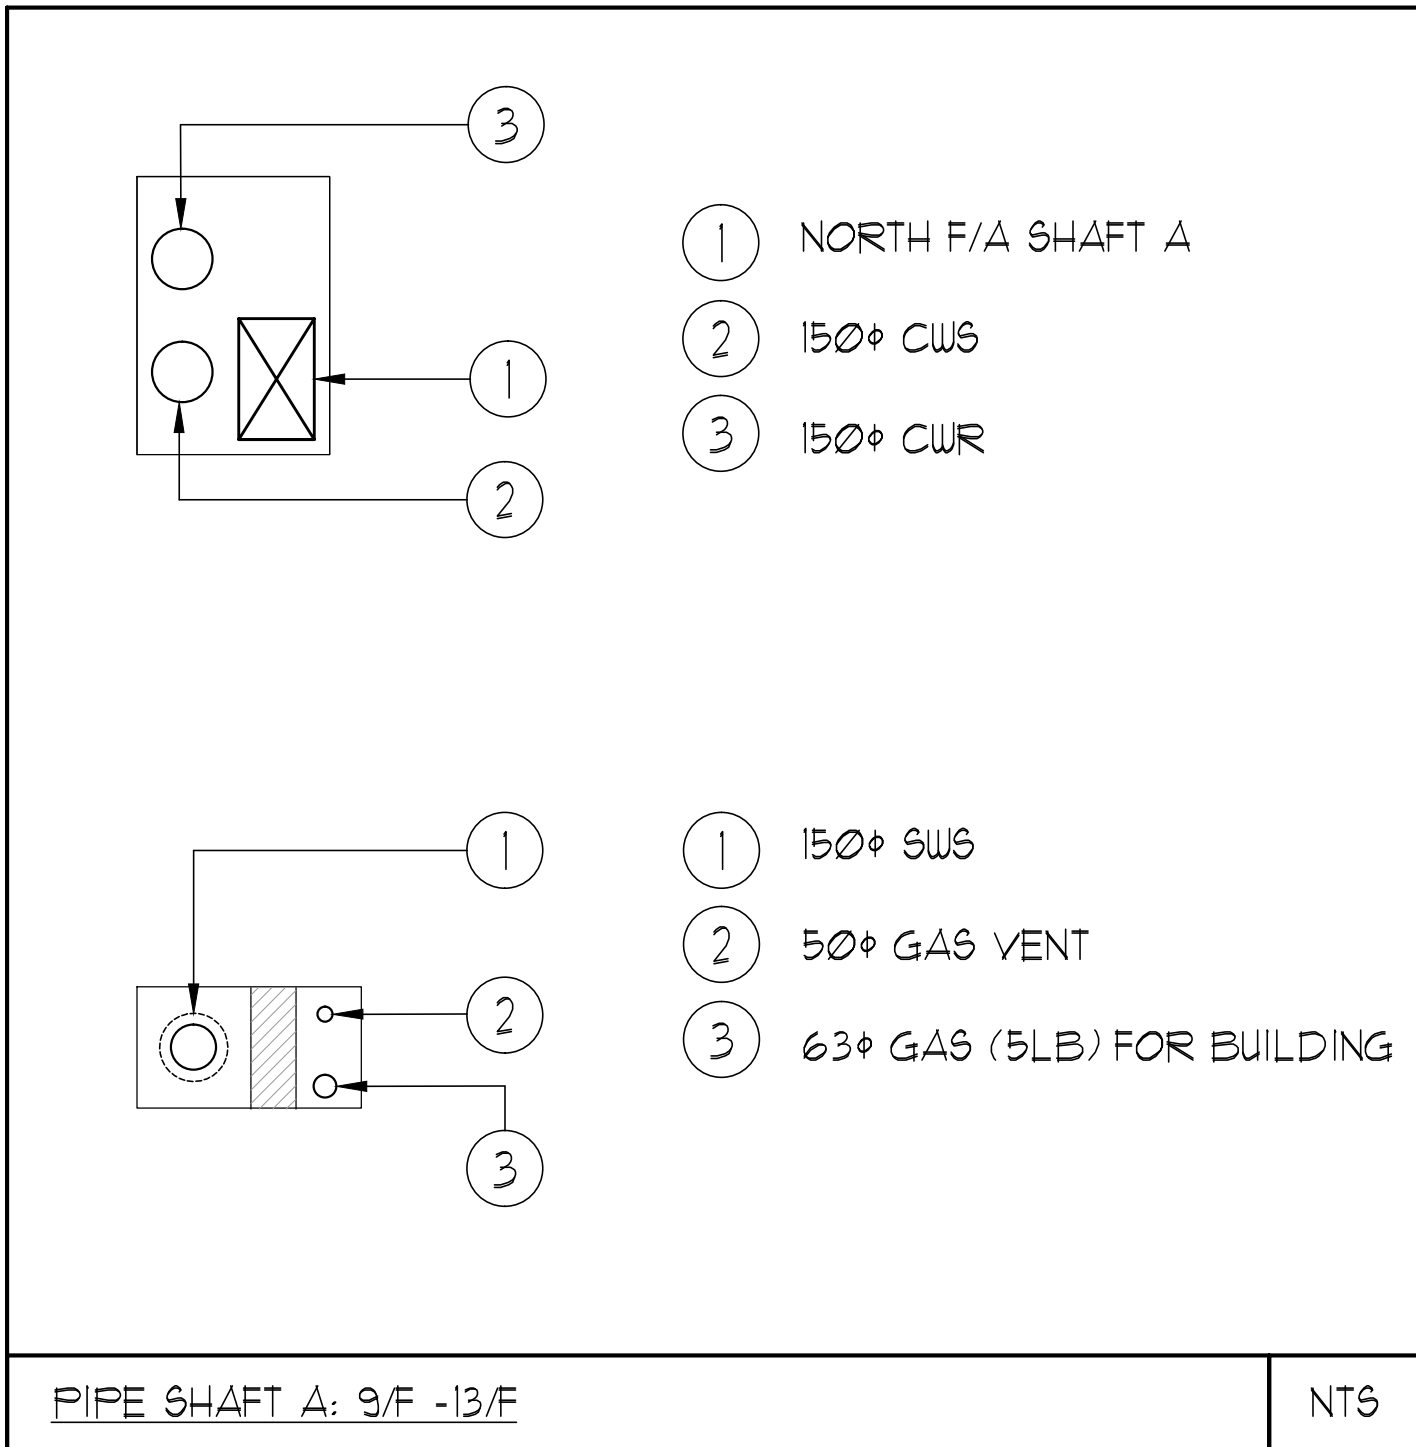


GRILLE SIZING TABLE				VERTICAL FAN COIL SIZE		
DESIGNATION	SIZE	L/S	(UNLESS SPECIFIED ELEMENT)	DESIGNATION	MODEL	W x D
SG-A	300x100	41-10		FCU-1T	450	500x660
SG-B	300x150	71-33		FCU-15T	600	500x660
SG-C	400x150	94-140		FCU-2T	800	500x660
SG-D	450x150	141-188		FCU-25T	1000	550x660
EG-A	150x150	35		FCU-3T	1200	550x660
W-1	225x200	210mm(L)		NOTE: A MIN. OF 125mm IS REQUIRED ON THE SIDE OF PIPE RISER.		
W-2	425x200	INSULATED				
W-3	625x200	WALL BOX				

- [illegible]

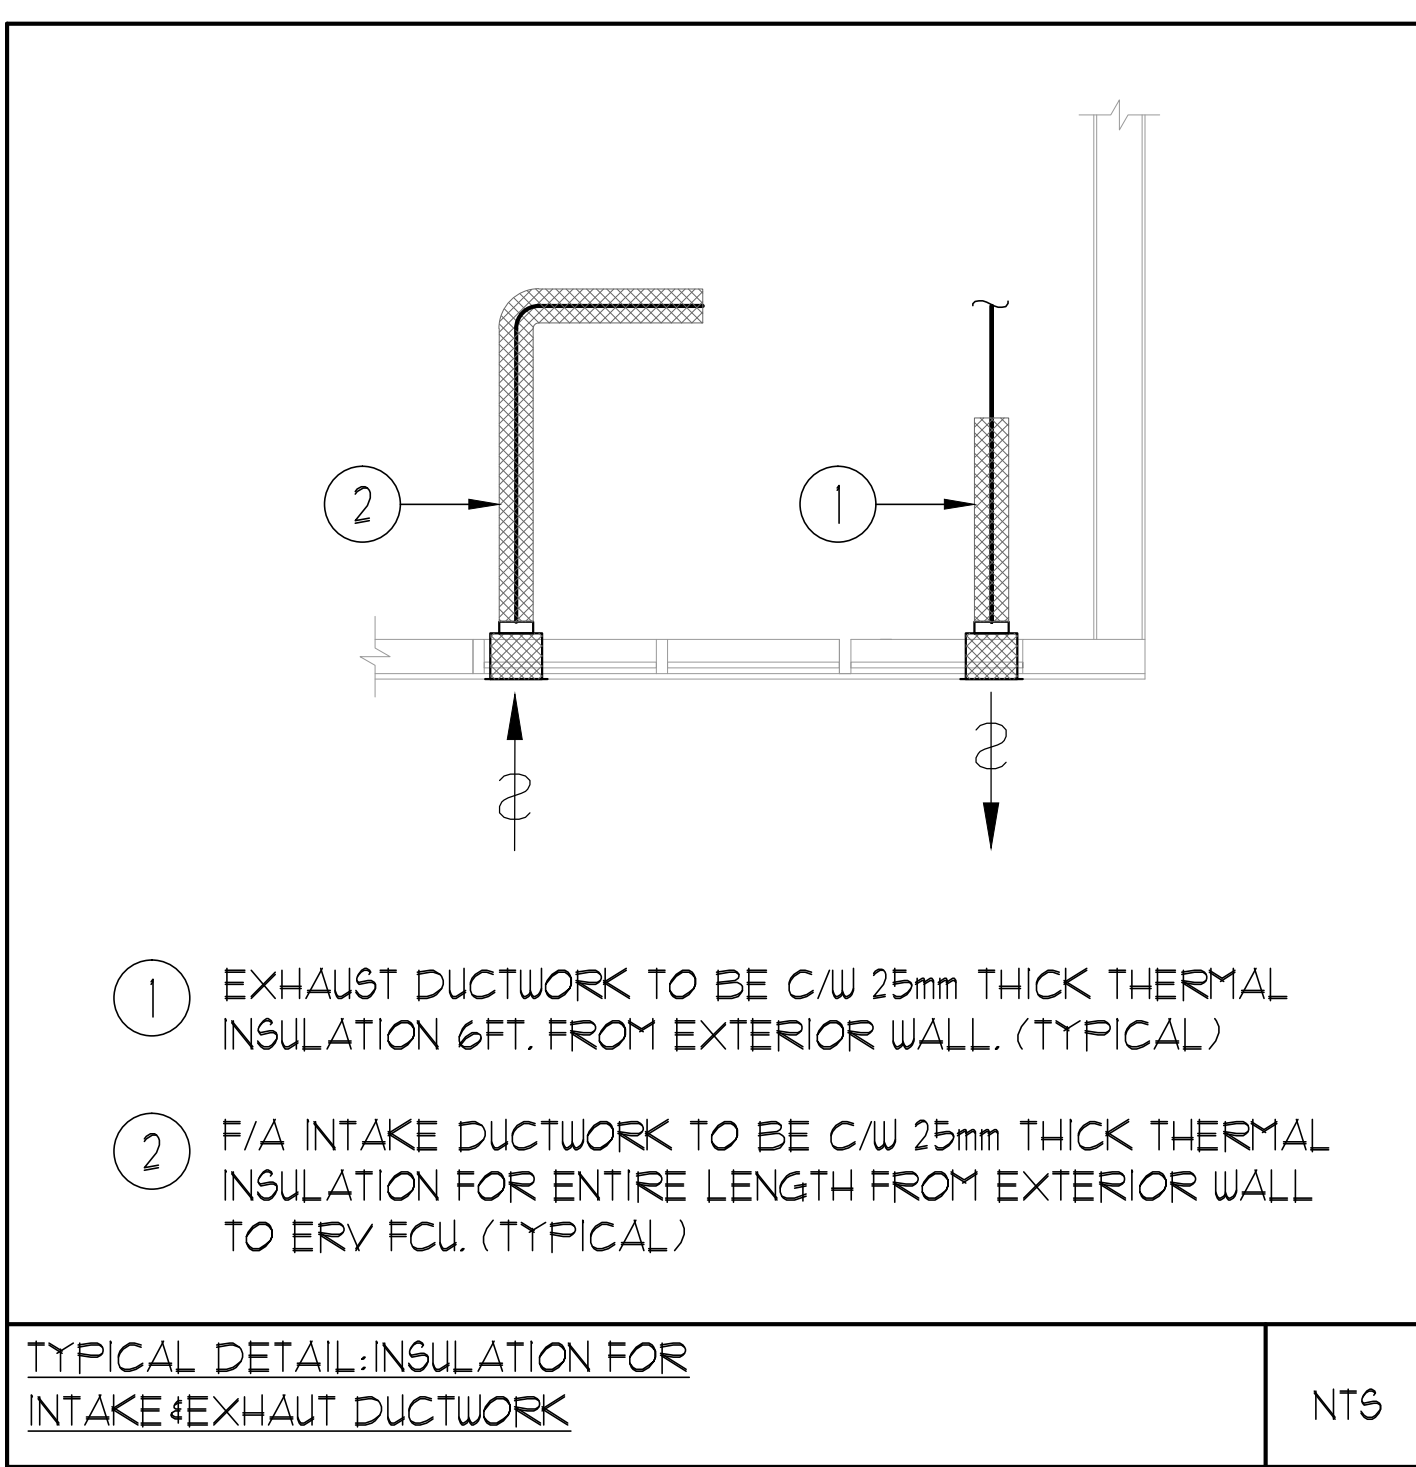

- NOTES:
- 1 NORTH F/A SHAFT B FROM G/F TO 14/F. F/A DUCT SERVING CORRIDOR FROM G/F TO 14/F. SEE PRESSURIZATION / VENTILATION RISER DIAGRAM FOR DETAILS.
- 2 PIPE SHAFT - REFER TO PIPE DIAGRAM FOR DETAILS.
- 3 150° KITCHEN / DRYER / W/R / FCU INTAKE / FCU EXHAUST DUCT. (TYPICAL UNLESS OTHERWISE NOTED)
- 4 NORTH F/A SHAFT A FROM G/F TO 14/F DUCT SERVING CORRIDOR FROM G/F TO 14/F. SEE PRESSURIZATION / VENTILATION RISER DIAGRAM FOR DETAILS.
- 5 15° DHUR.
- 6 600° GARBAGE CHUTE.
- 7 100° RUL FROM ABOVE AND DOWN.
- 8 100° RUL FROM ABOVE.
- 9 100° RUL DOWN.
- 10 100° STM @1%.
- 11 150° RUL DOWN.
- 12 150° STM @1%.

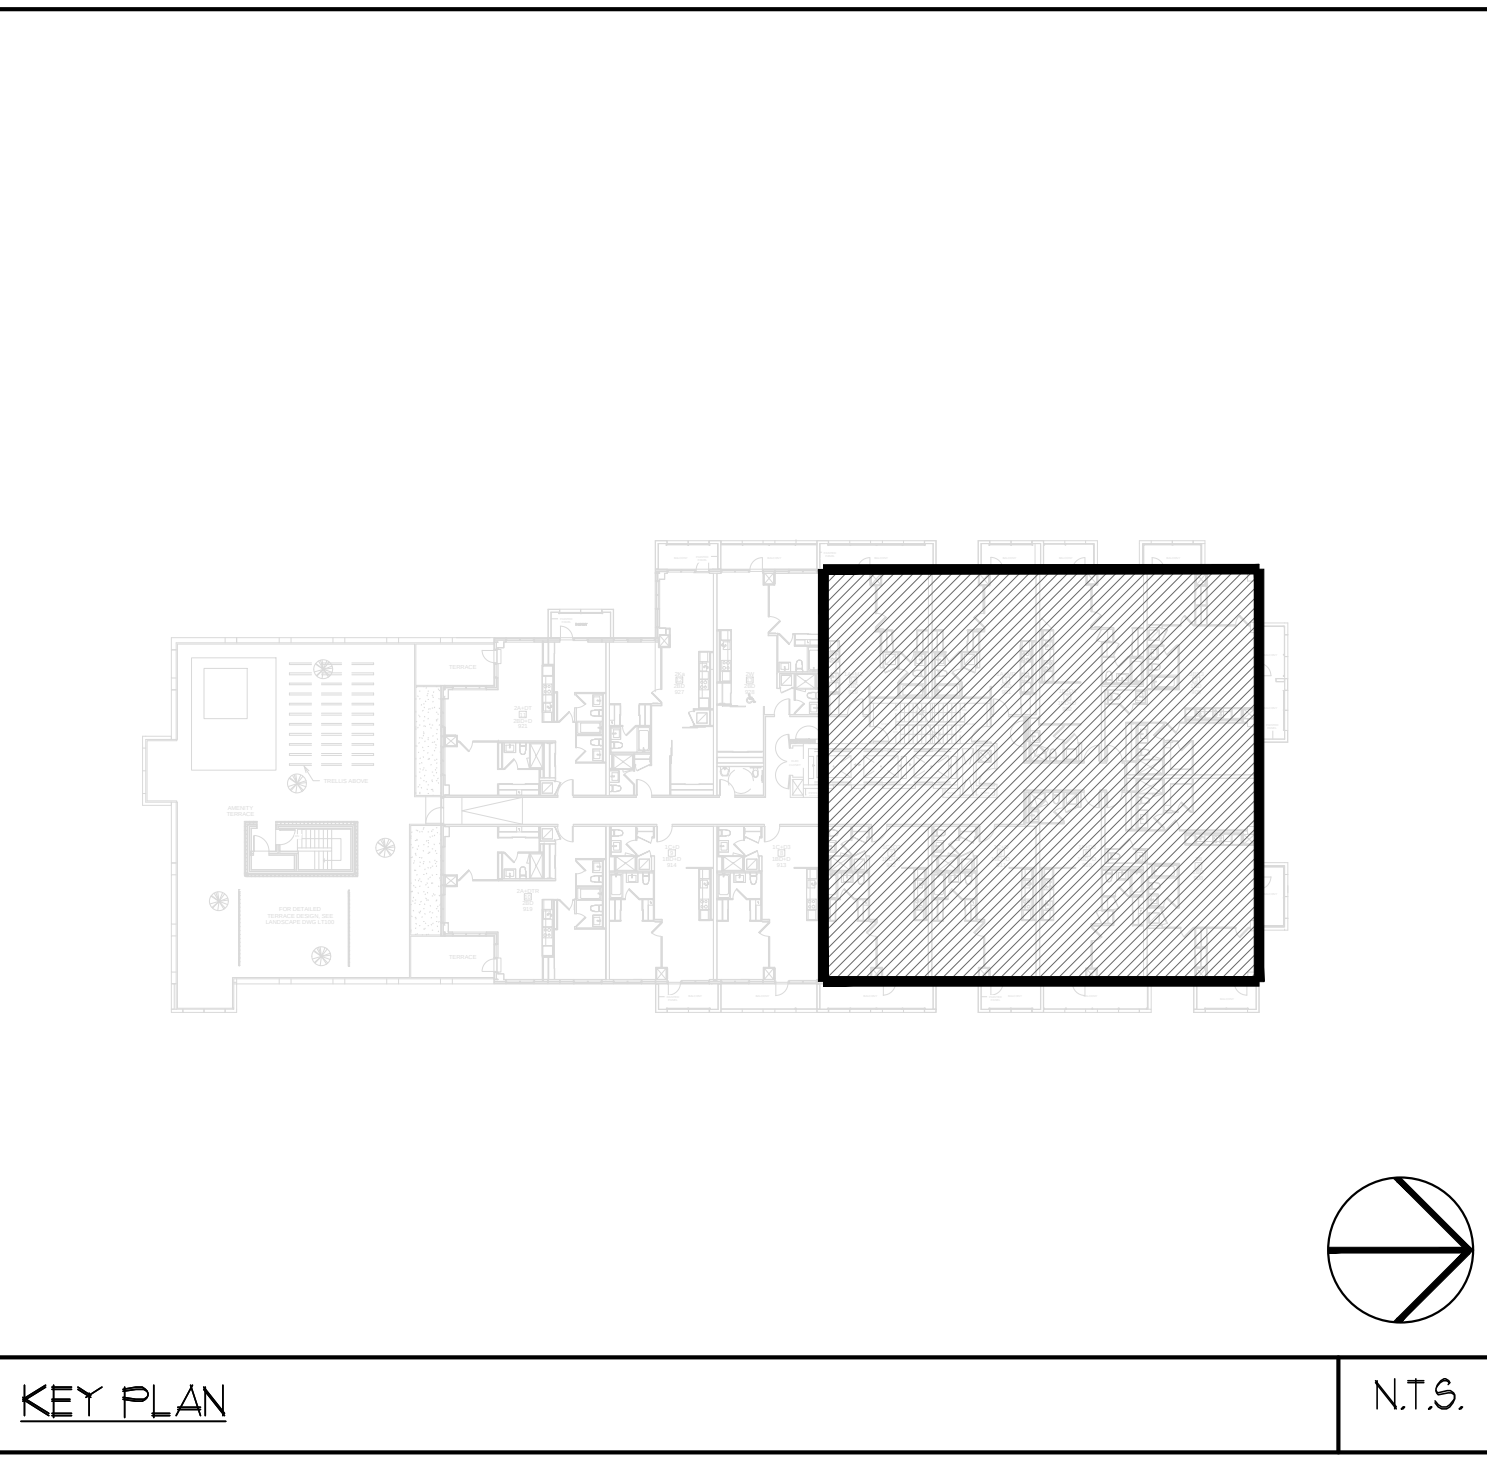

DESIGN	3	USED FOR REVIEW	EA
DESIGN	1	NEEDED FOR PERMIT	EP
DESIGN	1	USED FOR PERMIT	EA
DATE	NO.	DESCRIPTION	BY


THANK YOU! ALL PRINTS DATED PREVIOUS
TO FINAL DATE ABOVE

REVISIONS

CONTRACTOR MUST CHECK AND VERIFY ALL DIMENSIONS AND CONDITIONS
ON THE JOB AND REPORT DISCREPANCIES TO THE ENGINEER BEFORE
PROCEEDING WITH THE WORK. THIS DRAWING IS THE PROPERTY OF THE
ENGINEER AND MUST BE RETURNED UPON COMPLETION OF THE WORK.

DRAWINGS ARE NOT TO BE SCALED



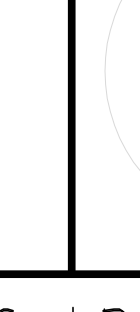

175 West Beaver Creek Road, Unit 31
Richmond Hill, Ontario L4B 3N1
Tel: 905 882-5445
Fax: 905 882-5444

DRAWING TITLE
**3/4" NORTH
MECHANICAL LAYOUT**

PROJECT TITLE
**@& ALEXANDRA PARK
BLOCK II**

32 CANTERON STREET
TORONTO, ONTARIO

DESIGNED BY	DRAWN BY	SCALE
G.S.	E.P.	1:50
DATE	PROJECT NUMBER	DRAWING NUMBER
FEB. 13	1303	M-21

OF 43