


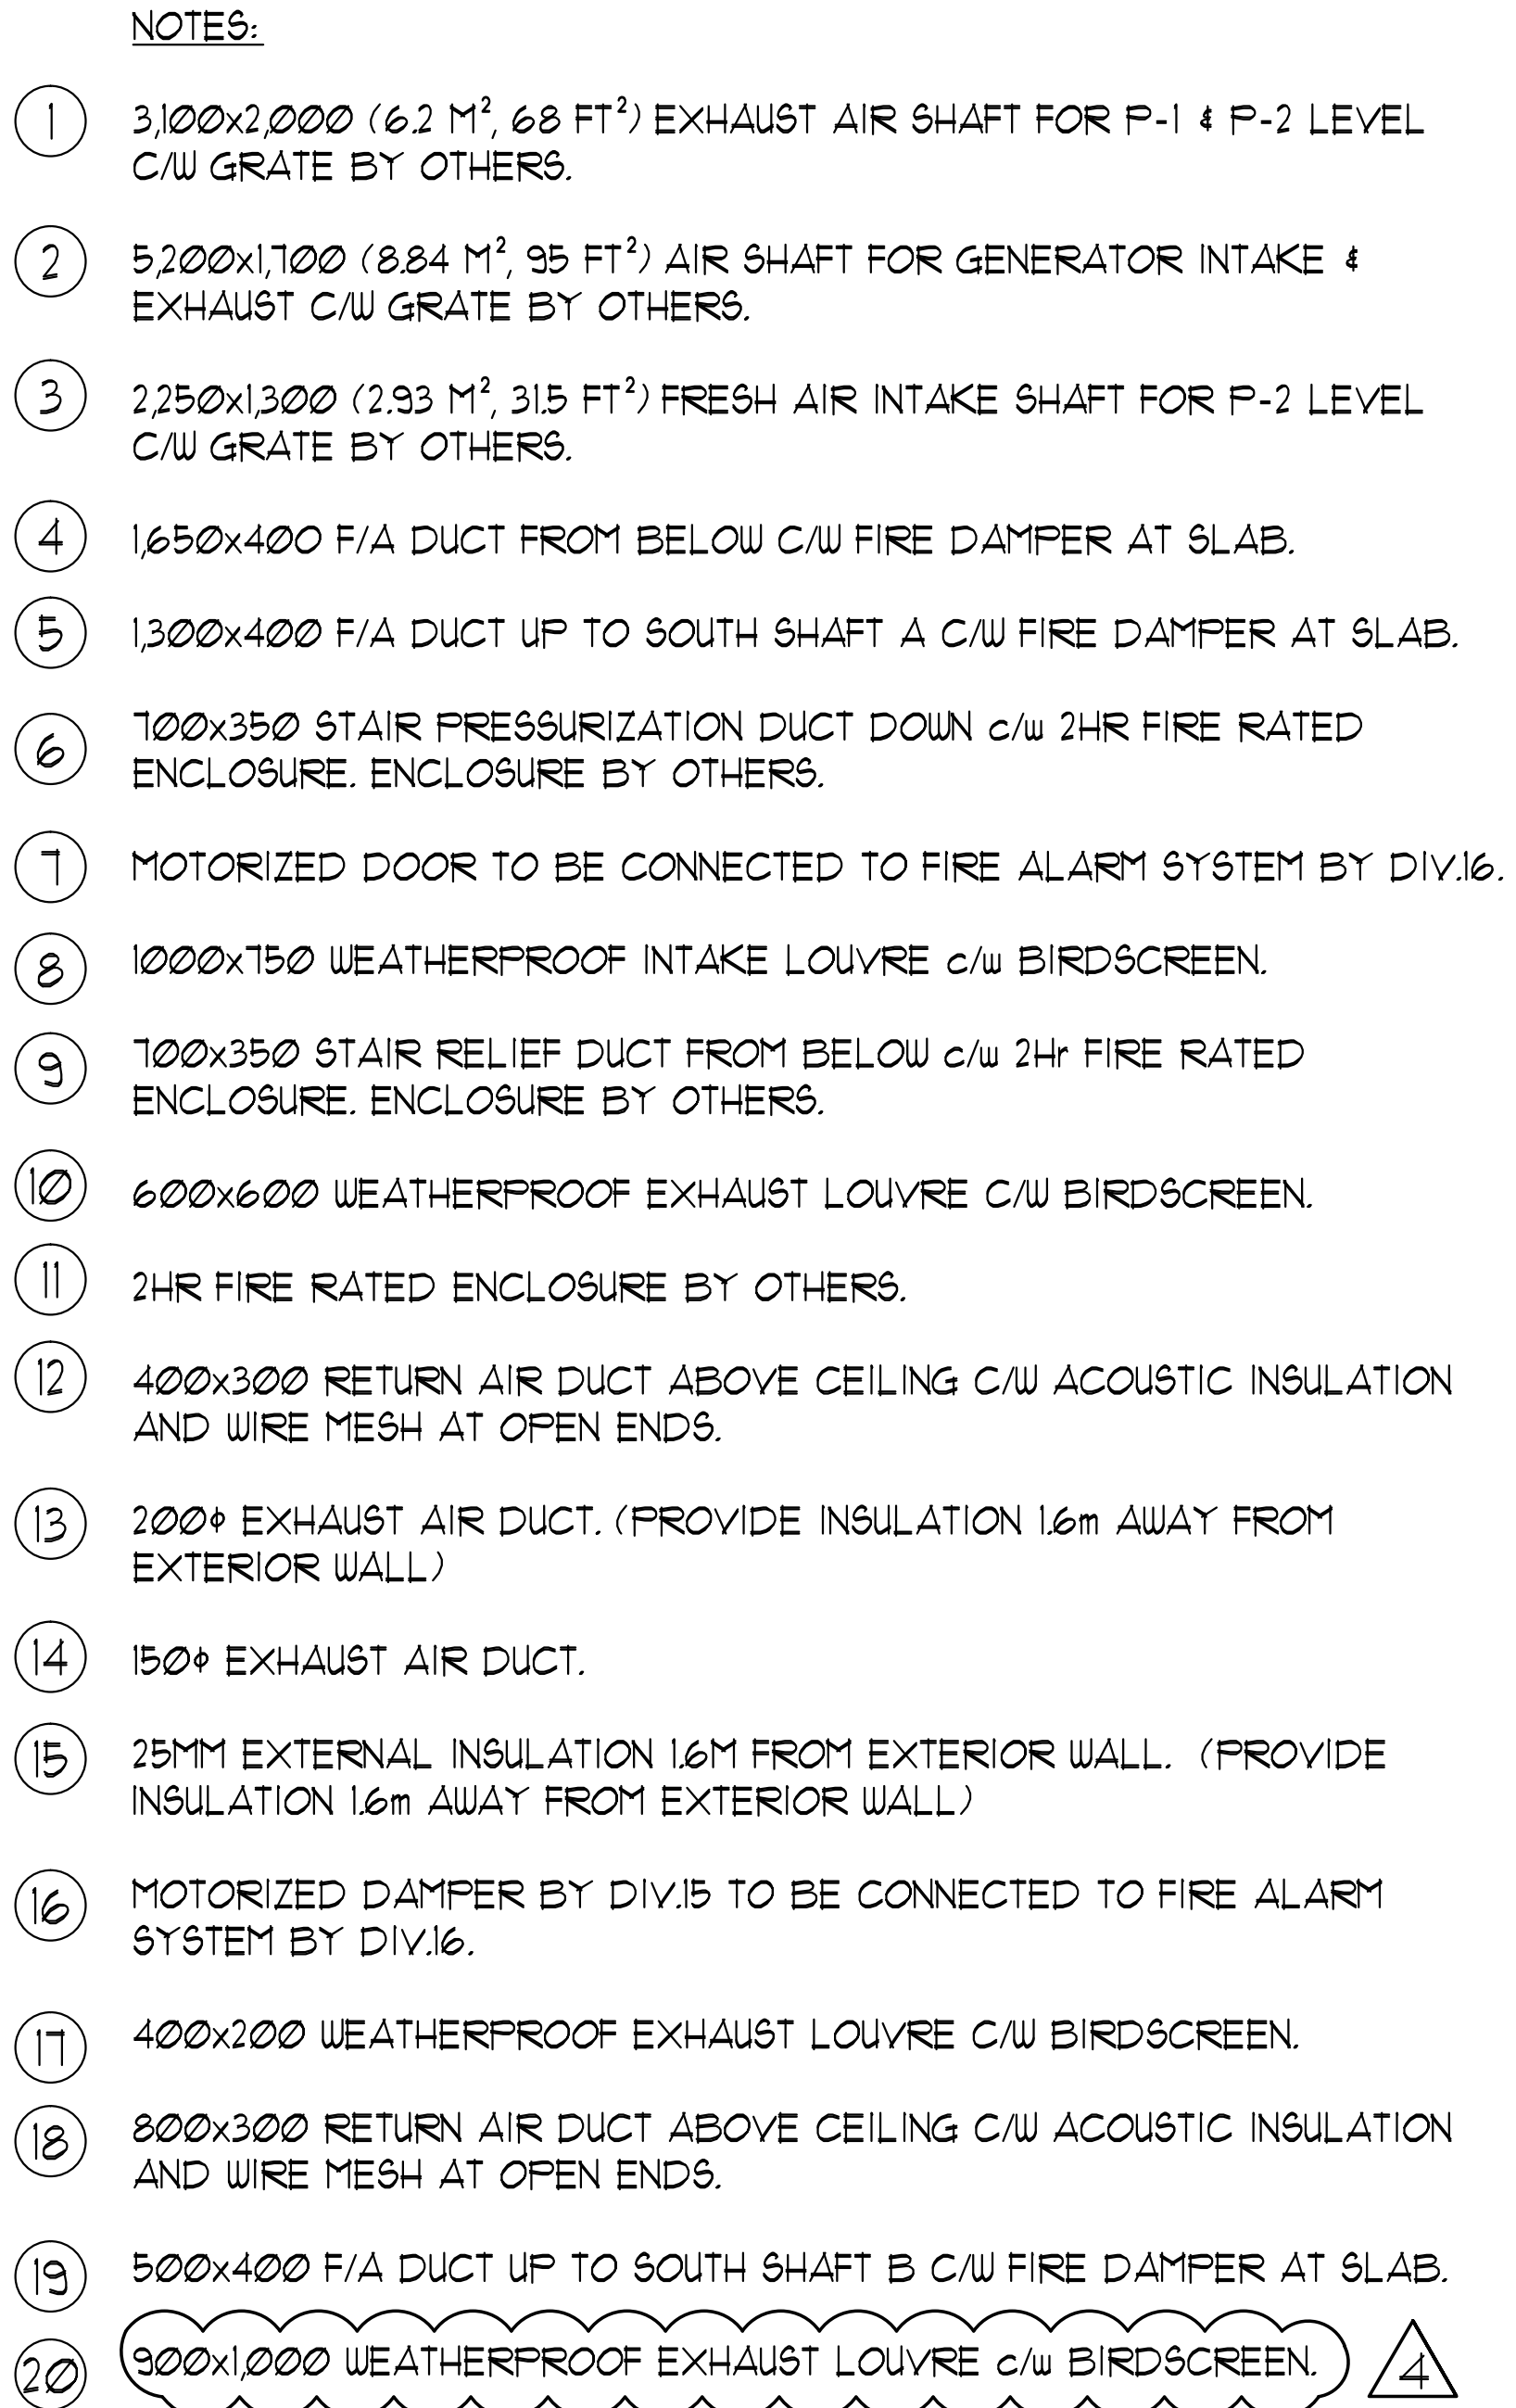

CONTRACTOR MUST CHECK AND VERIFY ALL DIMENSIONS AND CONDITIONS
BEFORE STARTING WORK AND REPORT DISCREPANCIES TO THE DESIGNER BEFORE
PROCEEDING WITH THE WORK. THIS DRAWING IS THE PROPERTY OF THE
DESIGNER AND MUST BE RETURNED UPON COMPLETION OF THE WORK.

DRAWINGS ARE NOT TO BE SCALED



NOVA
ENGINEERING & DESIGN LTD.
REGISTERED PROFESSIONAL ENGINEER
02/19/10
EXP. PUI KAI PUI
PROVINCE OF ONTARIO

175 West Beaver Creek Road Unit 31
Rich Hill, Ontario L4B 3M1
Tel: 905-884-5449
Fax: 905-884-5440

DRAWING TITLE:
G/F SOUTH
HVAC DUCTWORK LAYOUT

PROJECT FILE:
3Q ALEXANDRA PARK
BLVD
38 CAMERON STREET
TORONTO ONTARIO

DRAWN BY: EF
CHECKED BY: EF
SCALE: 1:50

DATE: FEB. 13
PROJECT NUMBER: 1313
DRAWING NUMBER: M-6 OF 43