

Teeple Architects INC.

Package 7 - Level 6

Reviewed
Reviewed as noted

()
()

Revise and resubmit

()


Not Reviewed

()

Date: Aug 9/15

Reviewed by: MBarn

This review by Teeple Architects Inc. is for the sole purpose of ascertaining conformance with the general design concept. This review shall not mean that Teeple Architects Inc. approves the detailed design inherent in the shop drawings, responsibility for which shall remain with the Contractor submitting same, and such review shall not relieve the Contractor of the responsibility for errors or omissions in the shop drawings or of the responsibility for meeting all requirements of the Contract Documents. The Contractor is responsible for dimensions to be confirmed and correlated at the job site, for information that pertains solely to fabrication processes or to techniques of construction and installation, and for coordination of the work of all trades.

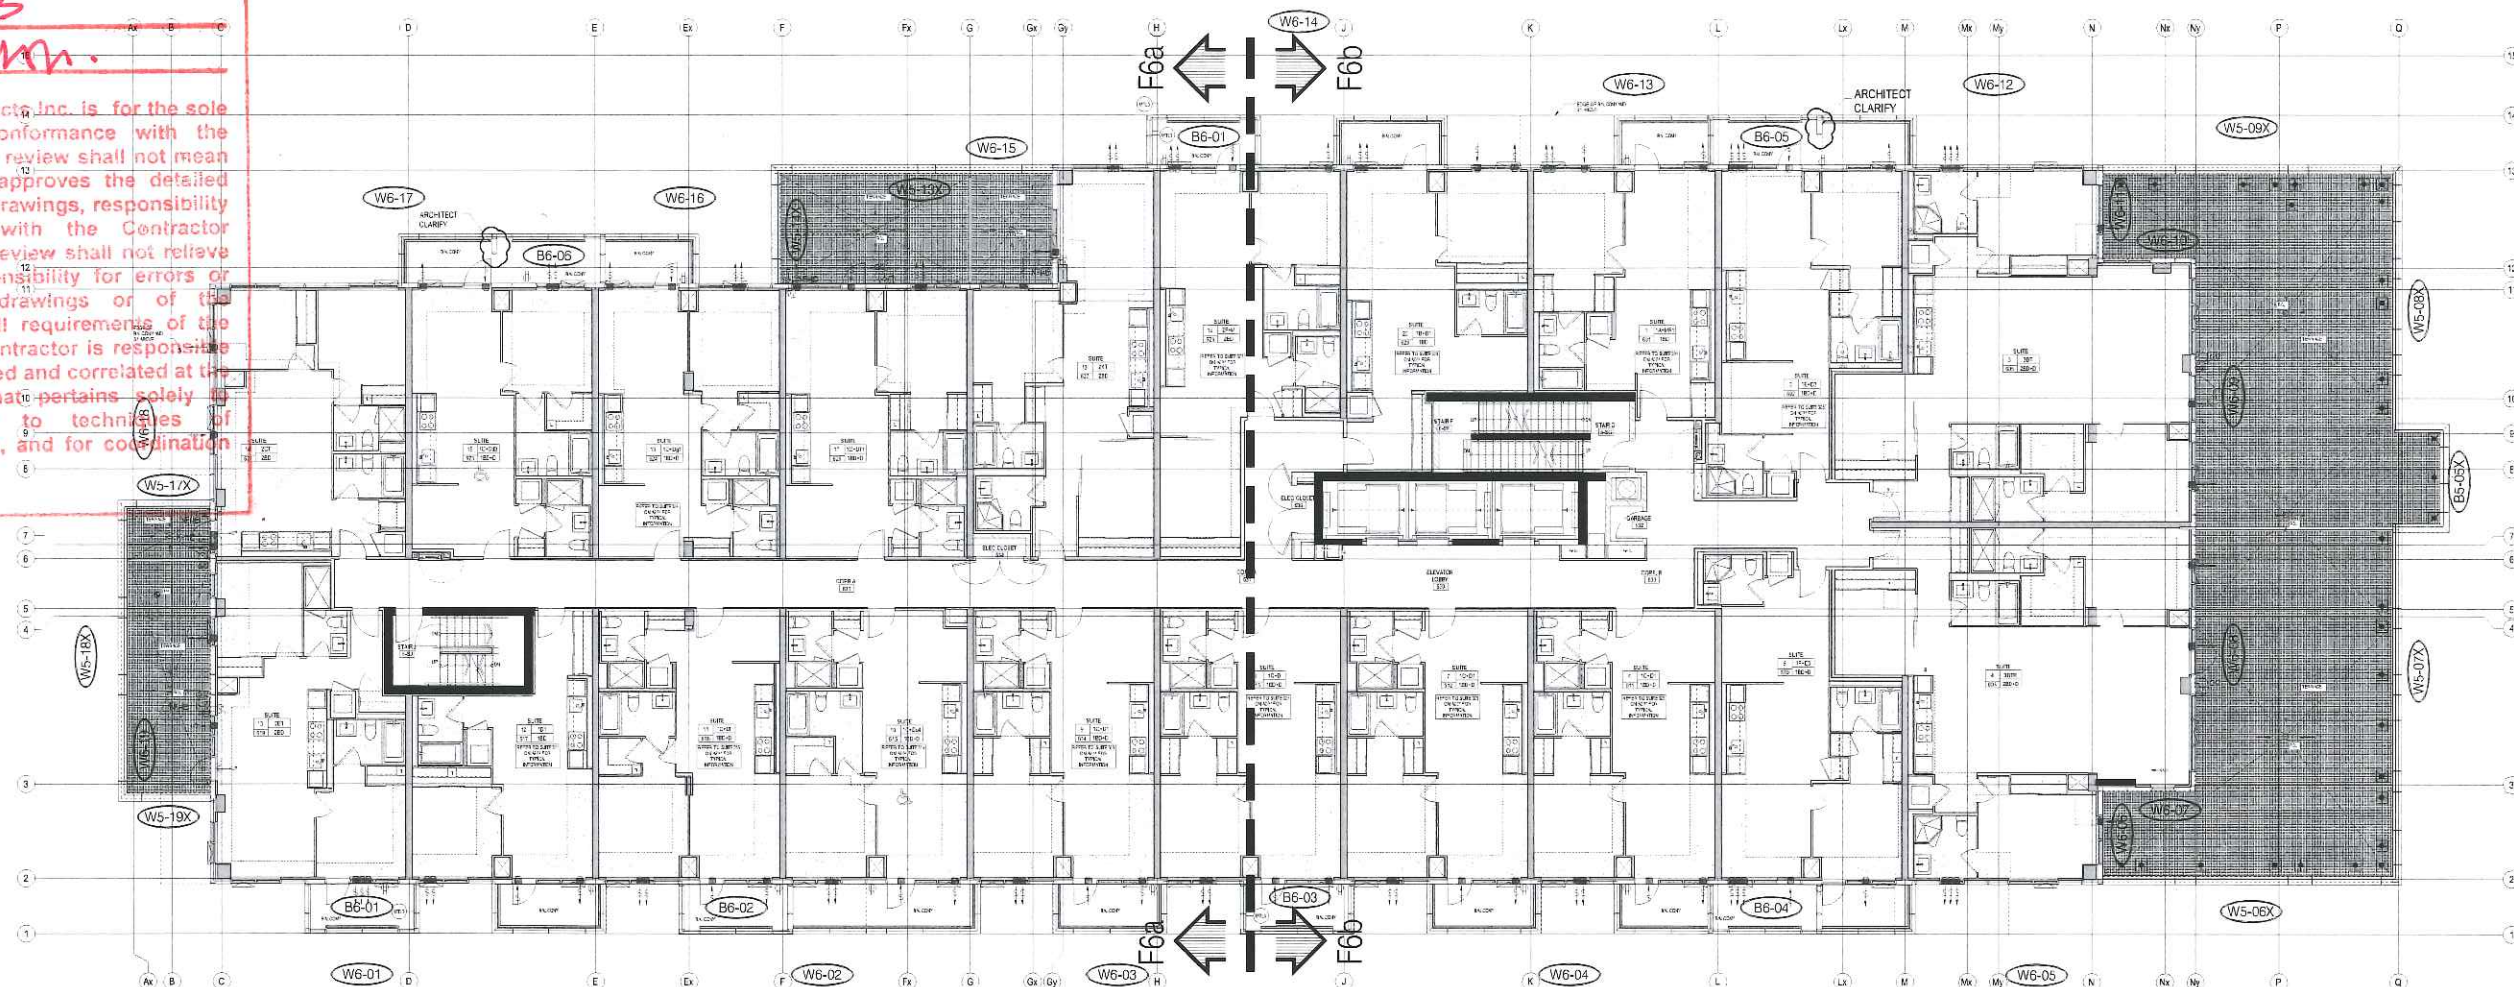

PROJECT NAME: SQ ALEXANDRA PARK - BLOCK11

DRAWING TITLE: 6th FLOOR KEY PLAN

ARCHITECT: TEEPLE ARCHITECTS

CONTRACTOR: TRIDEL

SCALE: N/T/S


DRAWN BY: S.C.

DATE: MARCH 4, 2015

DRAWING No.


F6

REVISION

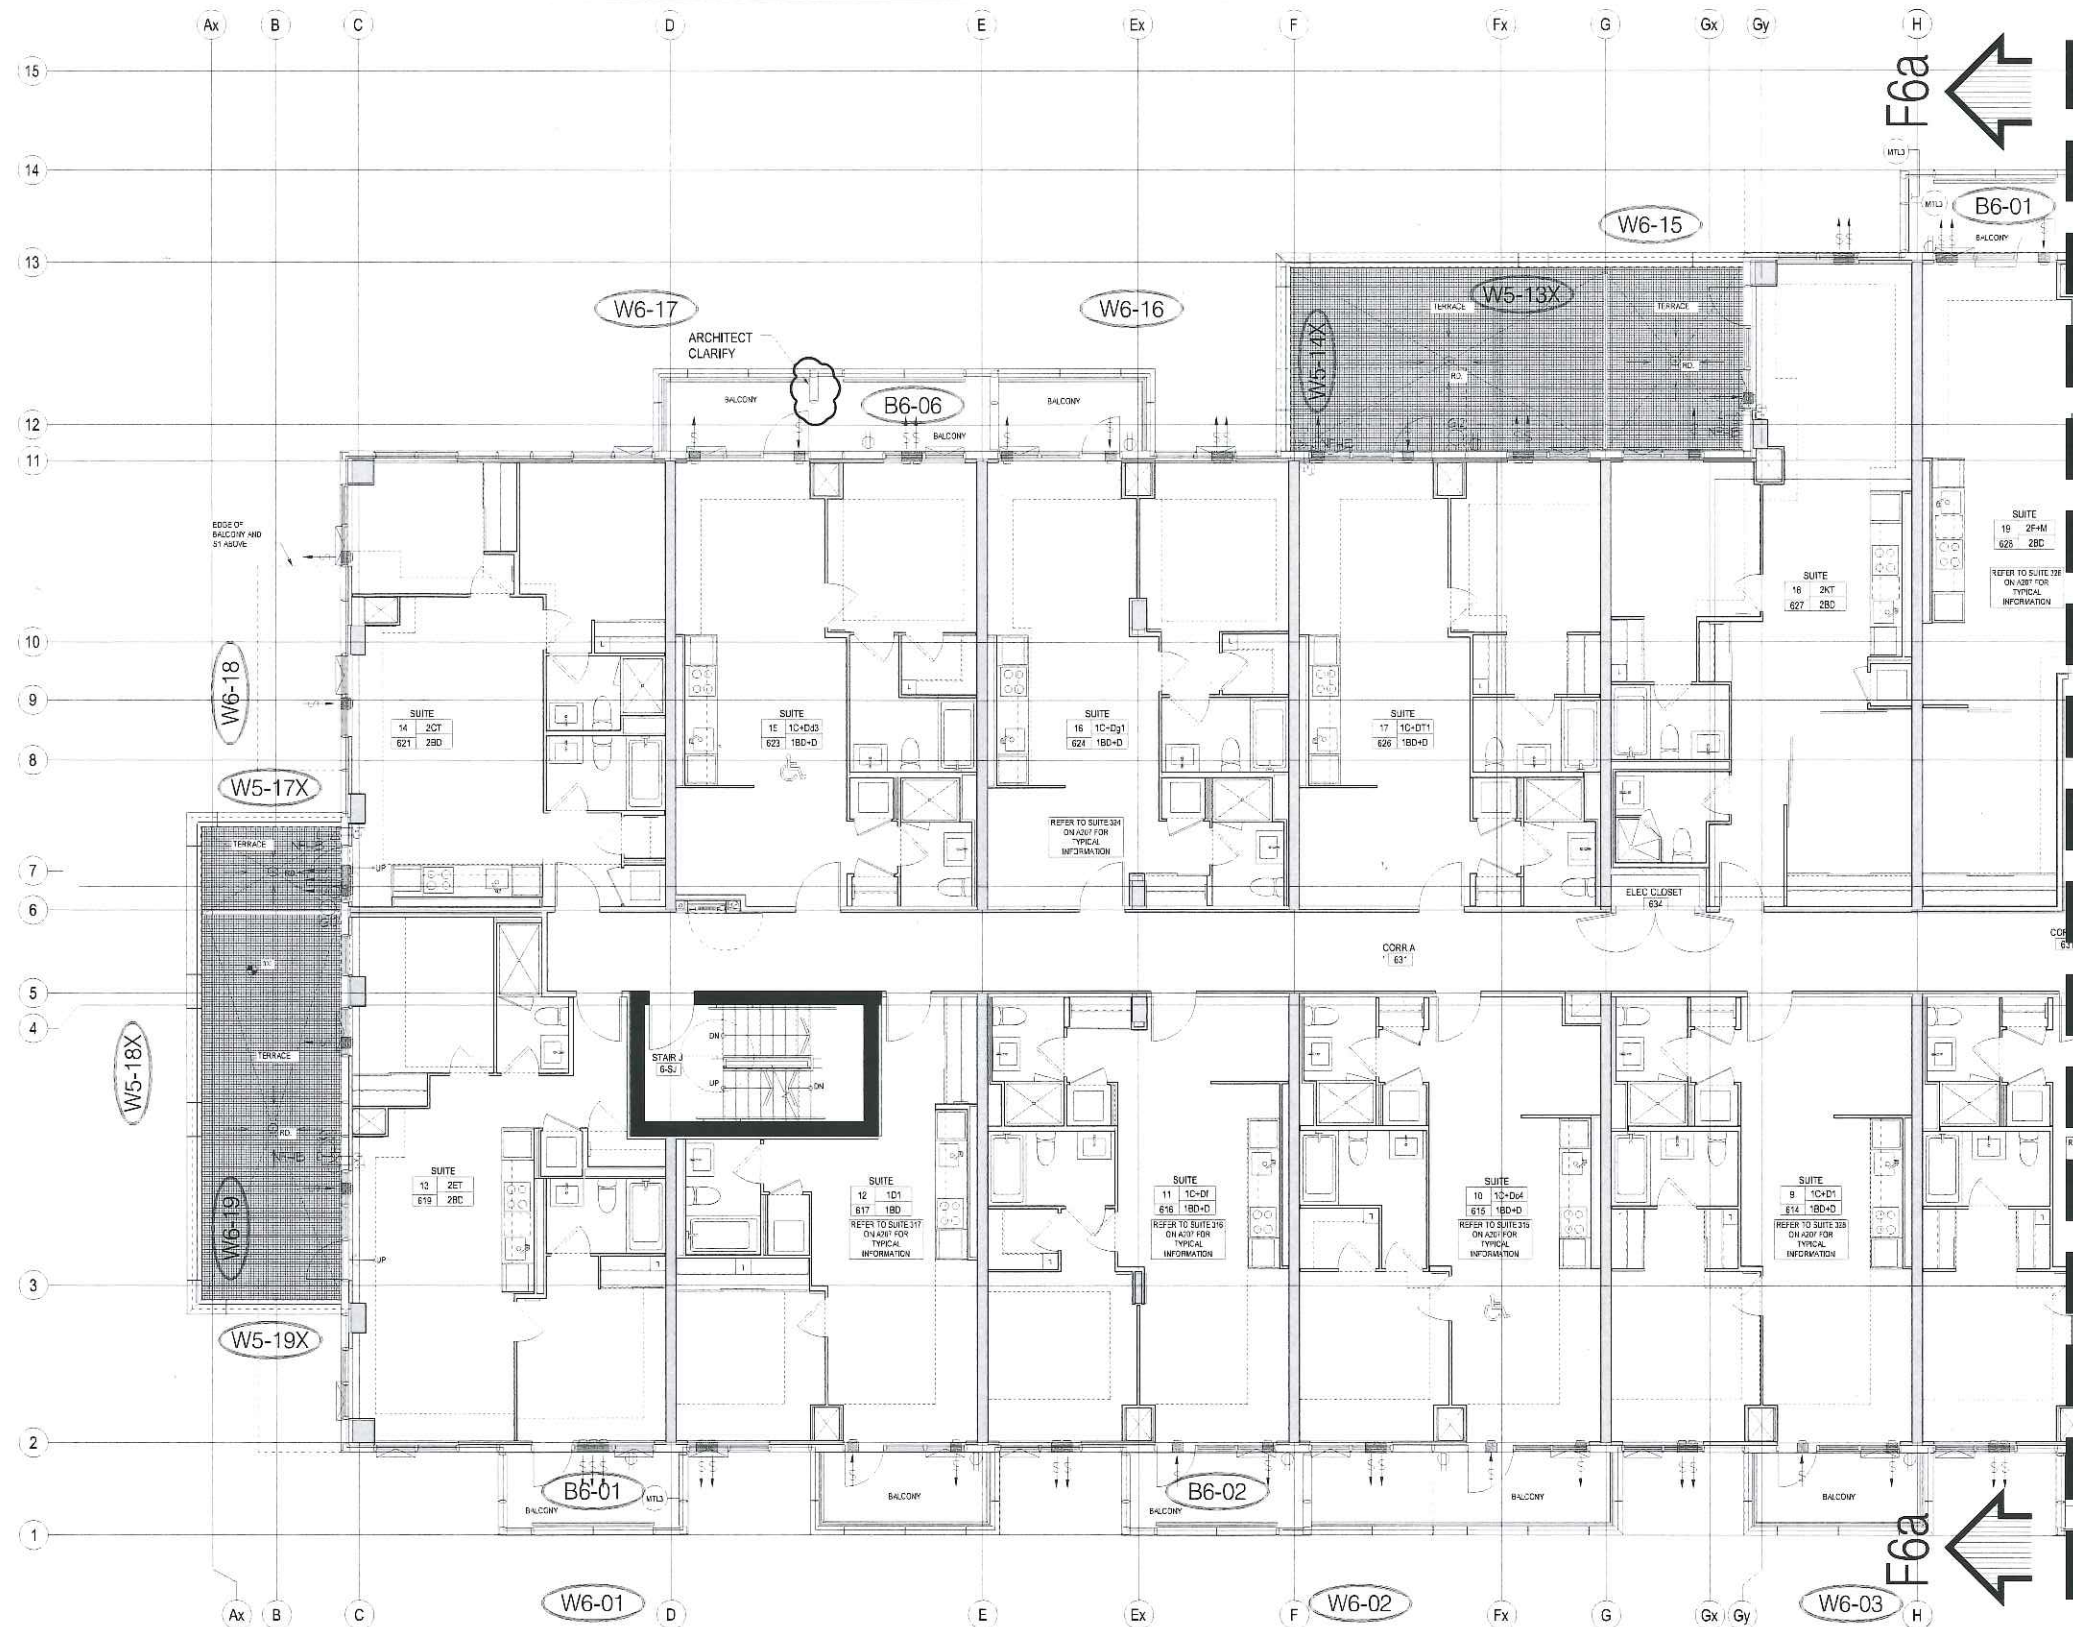


No.	REVISION	BY	DATE

PROJECT NAME:	SQ ALEXANDRA PARK - BLOCK 11		
DRAWING TITLE:	6th FLOOR PARTIAL PLAN		
ARCHITECT:	TEEPLE ARCHITECTS		
CONTRACTOR:	TRIDEL		
SCALE:	N/T/S	DRAWN BY:	S/C
DATE:	MARCH 4, 2015	DRAWING No.	F6a

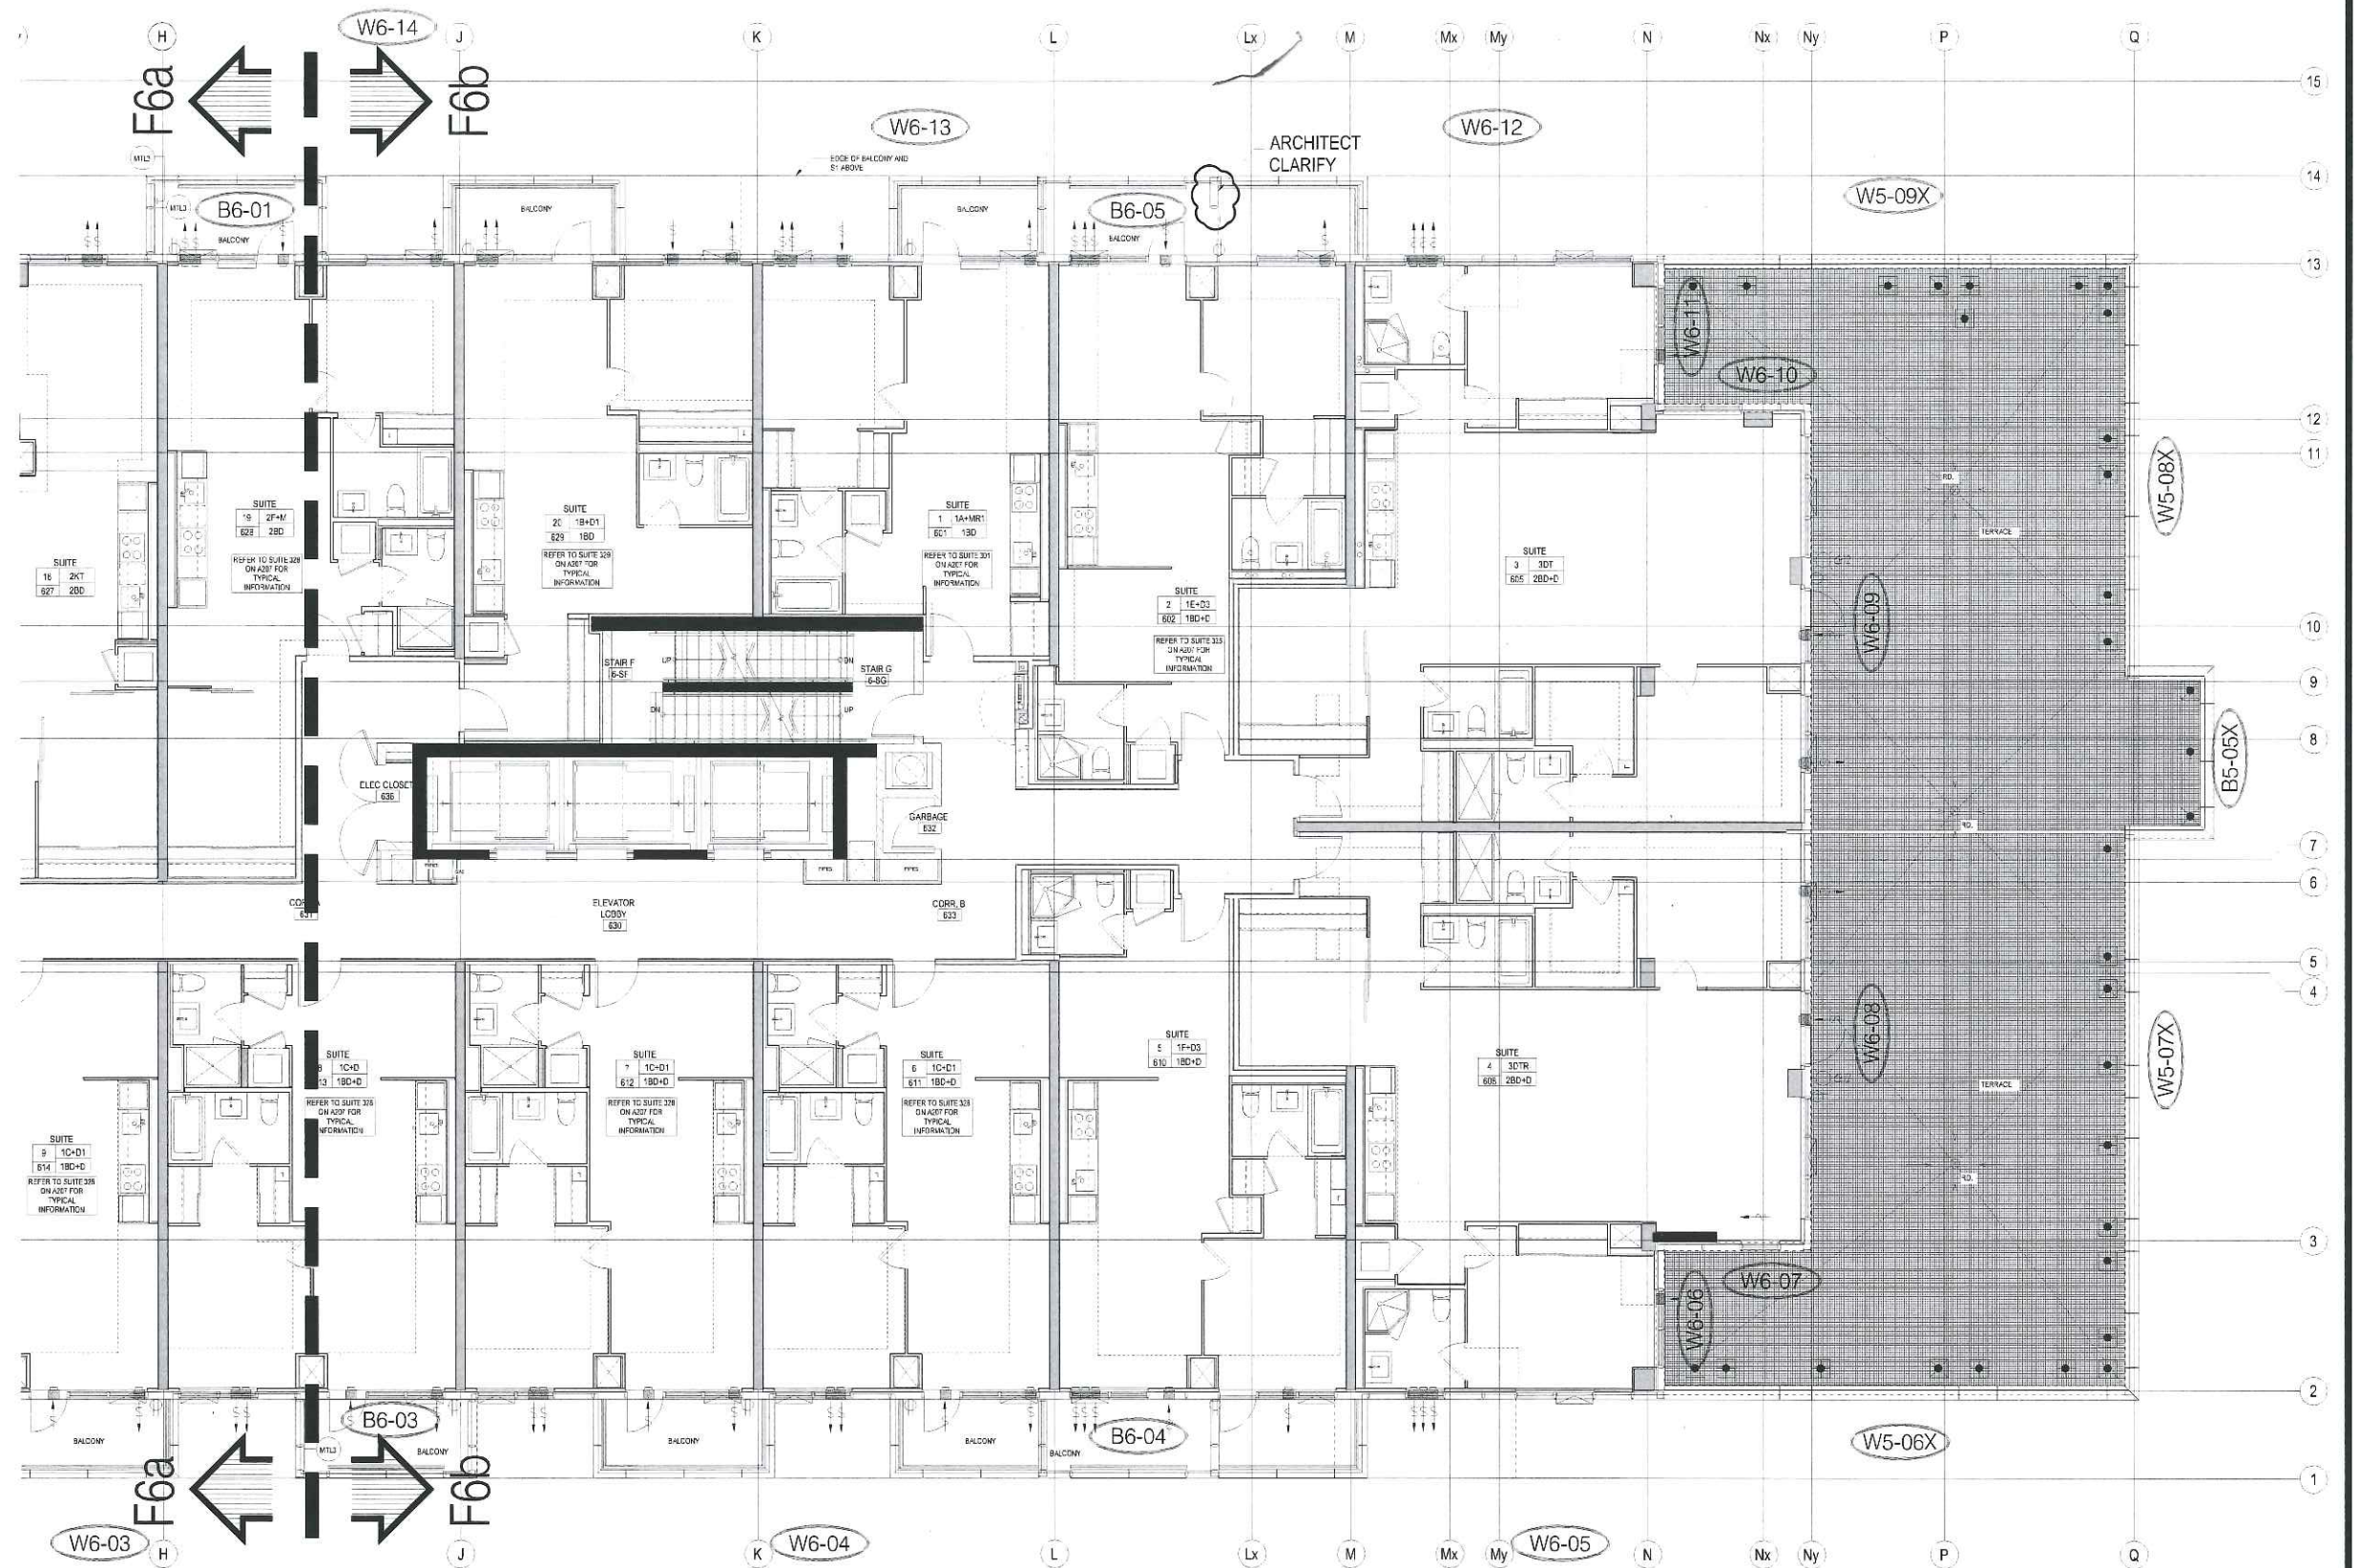


NO.	REVISION	BY	DATE

PROJECT NAME:	SQ ALEXANDRA PARK - BLOCK 11		
DRAWING TITLE:	6th FLOOR PARTIAL PLAN		
ARCHITECT:	TEEPLE ARCHITECTS		
CONTRACTOR:	TRIDEL		
SCALE:	N/T/S	DRAWN BY:	S-C
DATE:	MARCH 4, 2015	DRAWING No.:	F6b

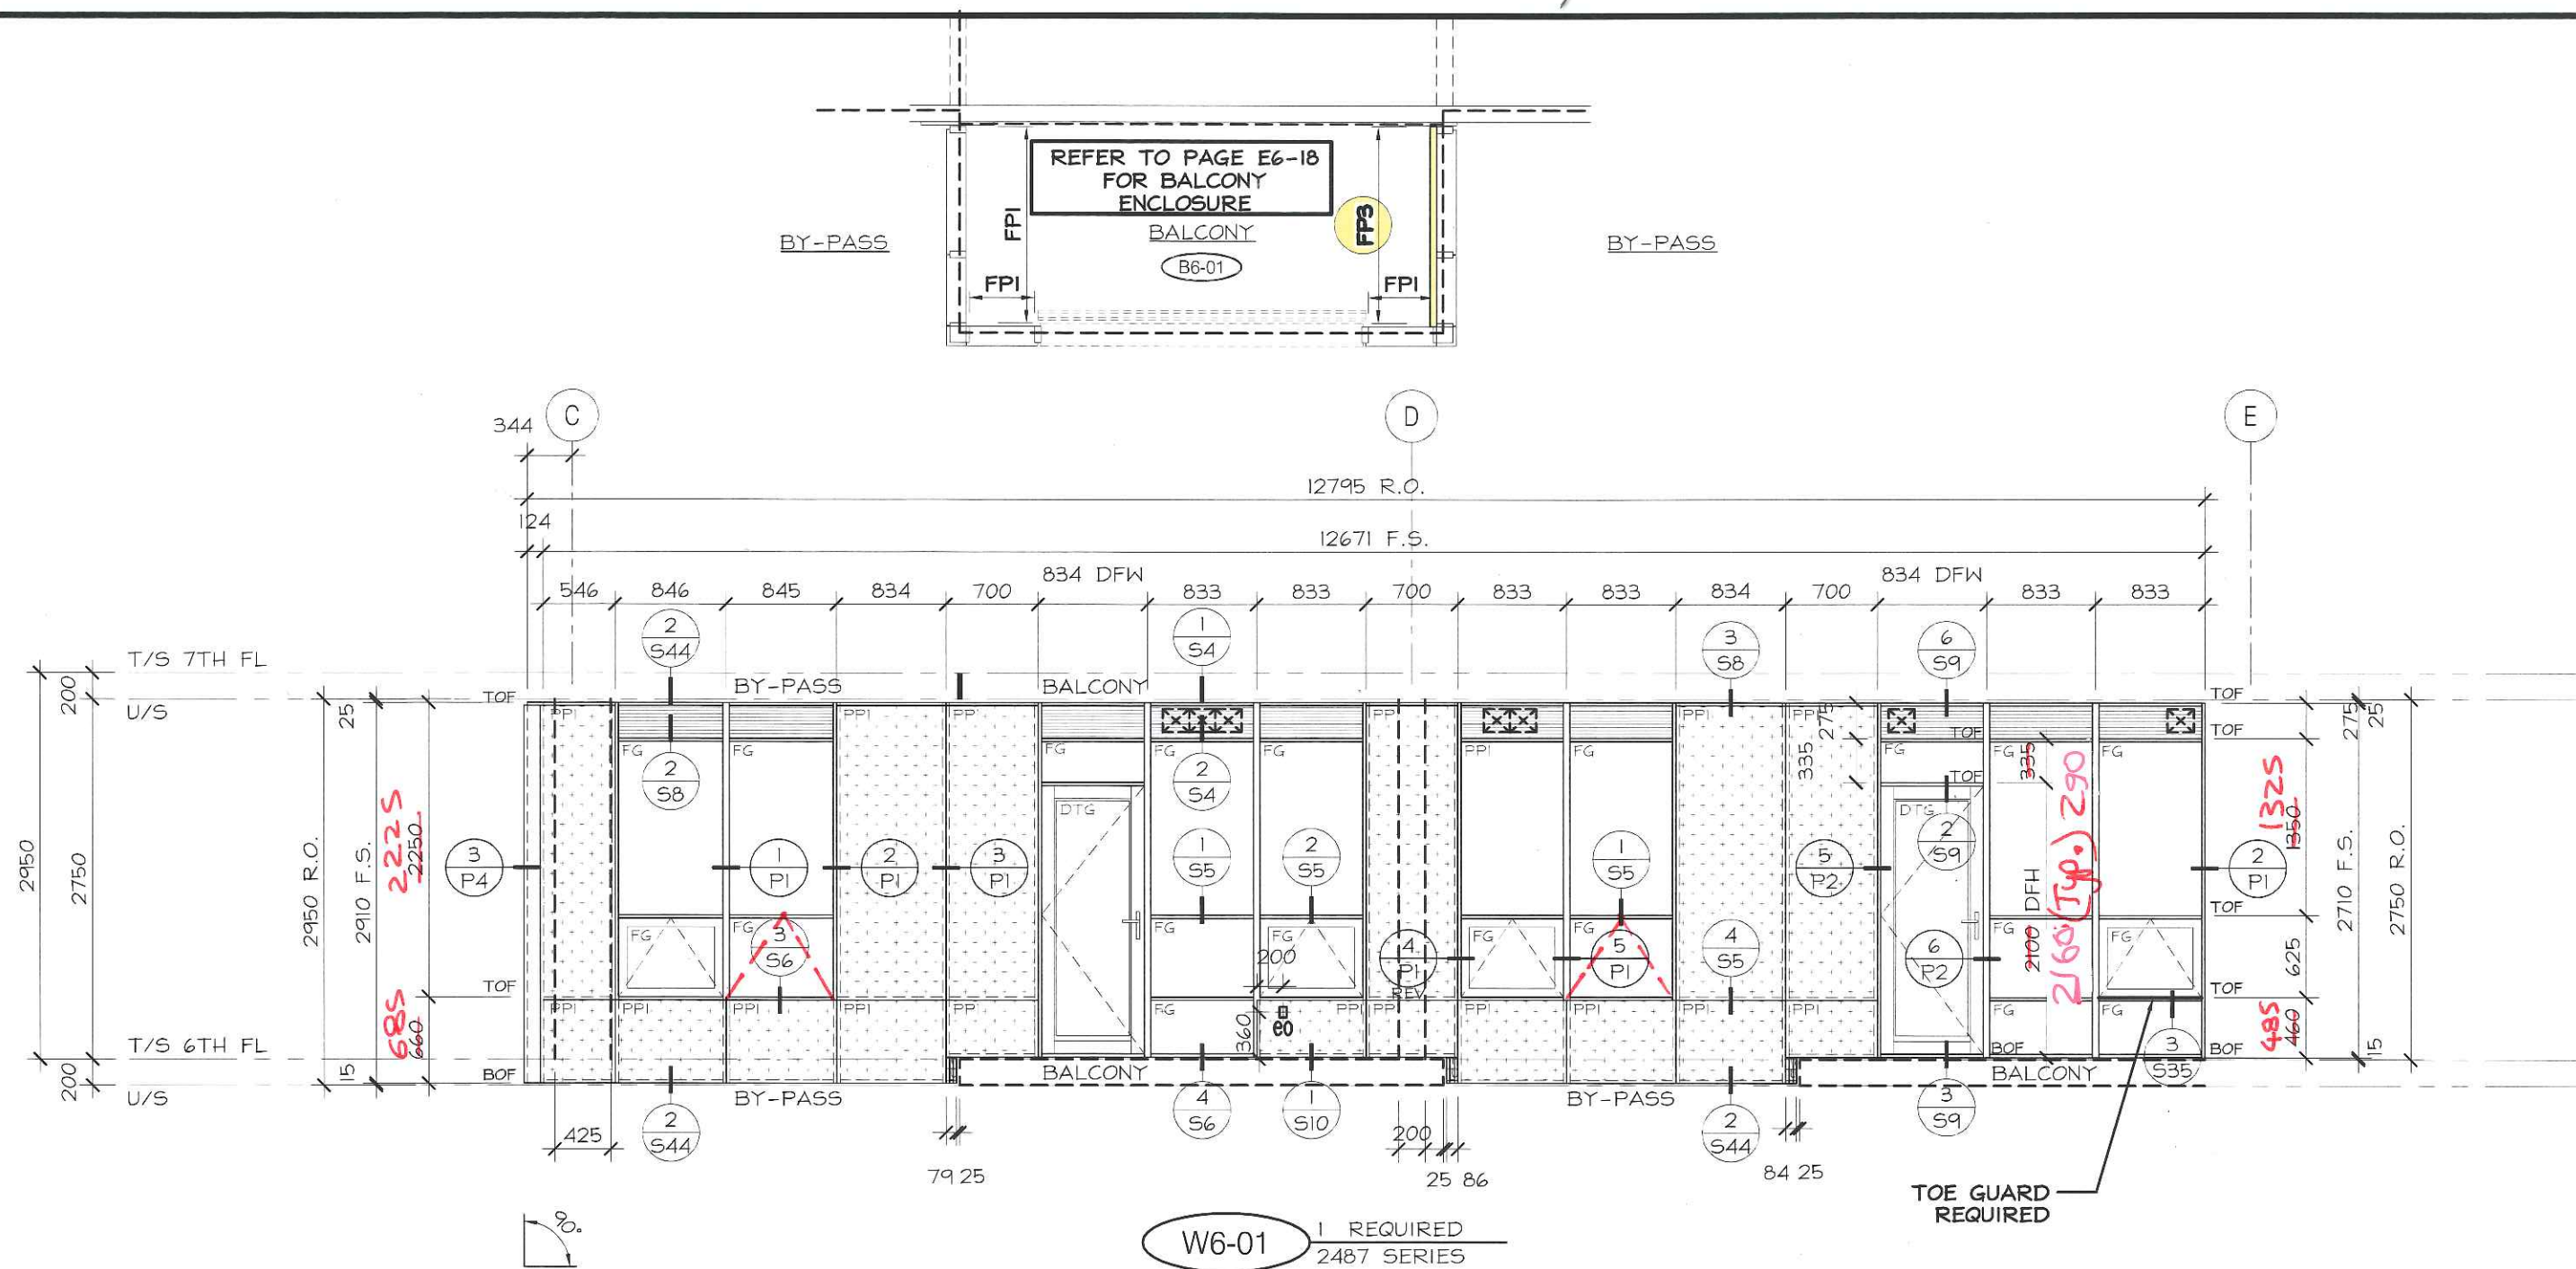


No.	REVISION	BY	DATE

PROJECT NAME:	SQ ALEXANDRA PARK - BLOCK 11
DRAWING TITLE:	6th FLOOR ELEVATIONS
ARCHITECT:	TEEPLE ARCHITECTS
CONTRACTOR:	TRIDEL
SCALE:	1:50
DRAWN BY:	S.C.
DATE:	MARCH 4, 2015
DRAWING No.:	E6-1

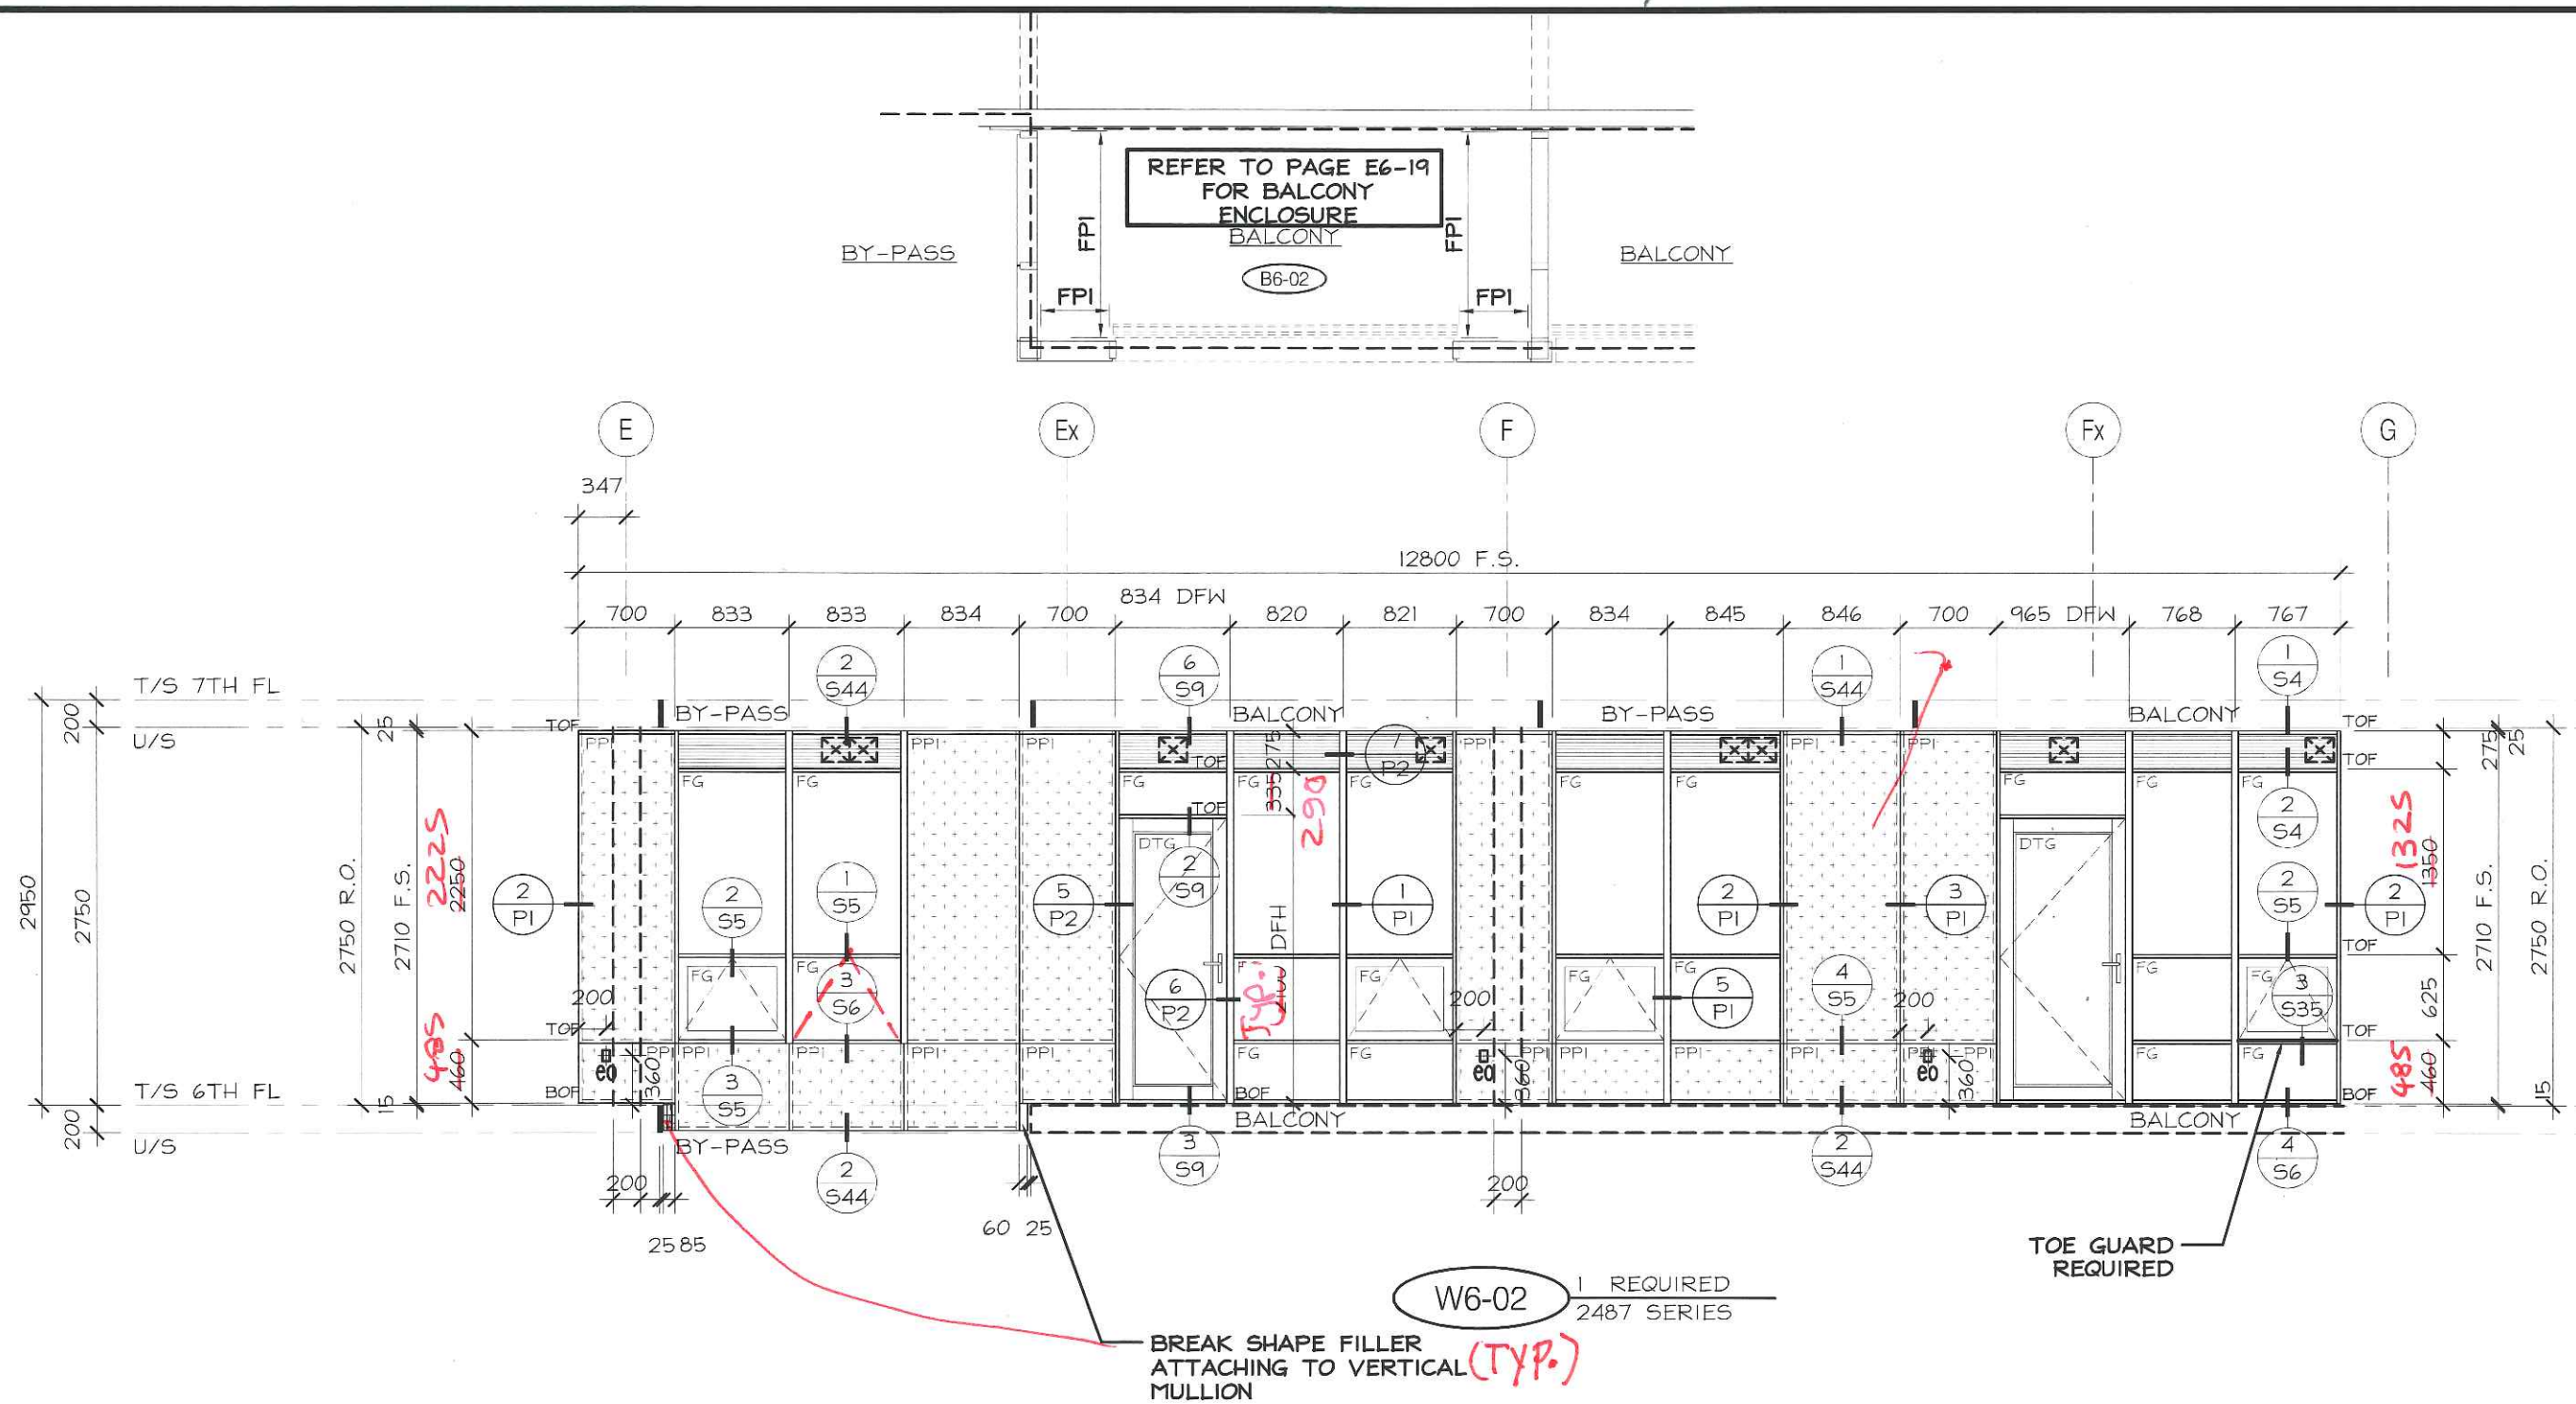


No.	REVISION	BY	DATE

PROJECT NAME:	SQ ALEXANDRA PARK - BLOCK 11
DRAWING TITLE:	6th FLOOR ELEVATIONS
ARCHITECT:	TEEPLE ARCHITECTS
CONTRACTOR:	TRIDEL
SCALE:	1:50
DRAWN BY:	S.C.
DATE:	MARCH 4, 2015

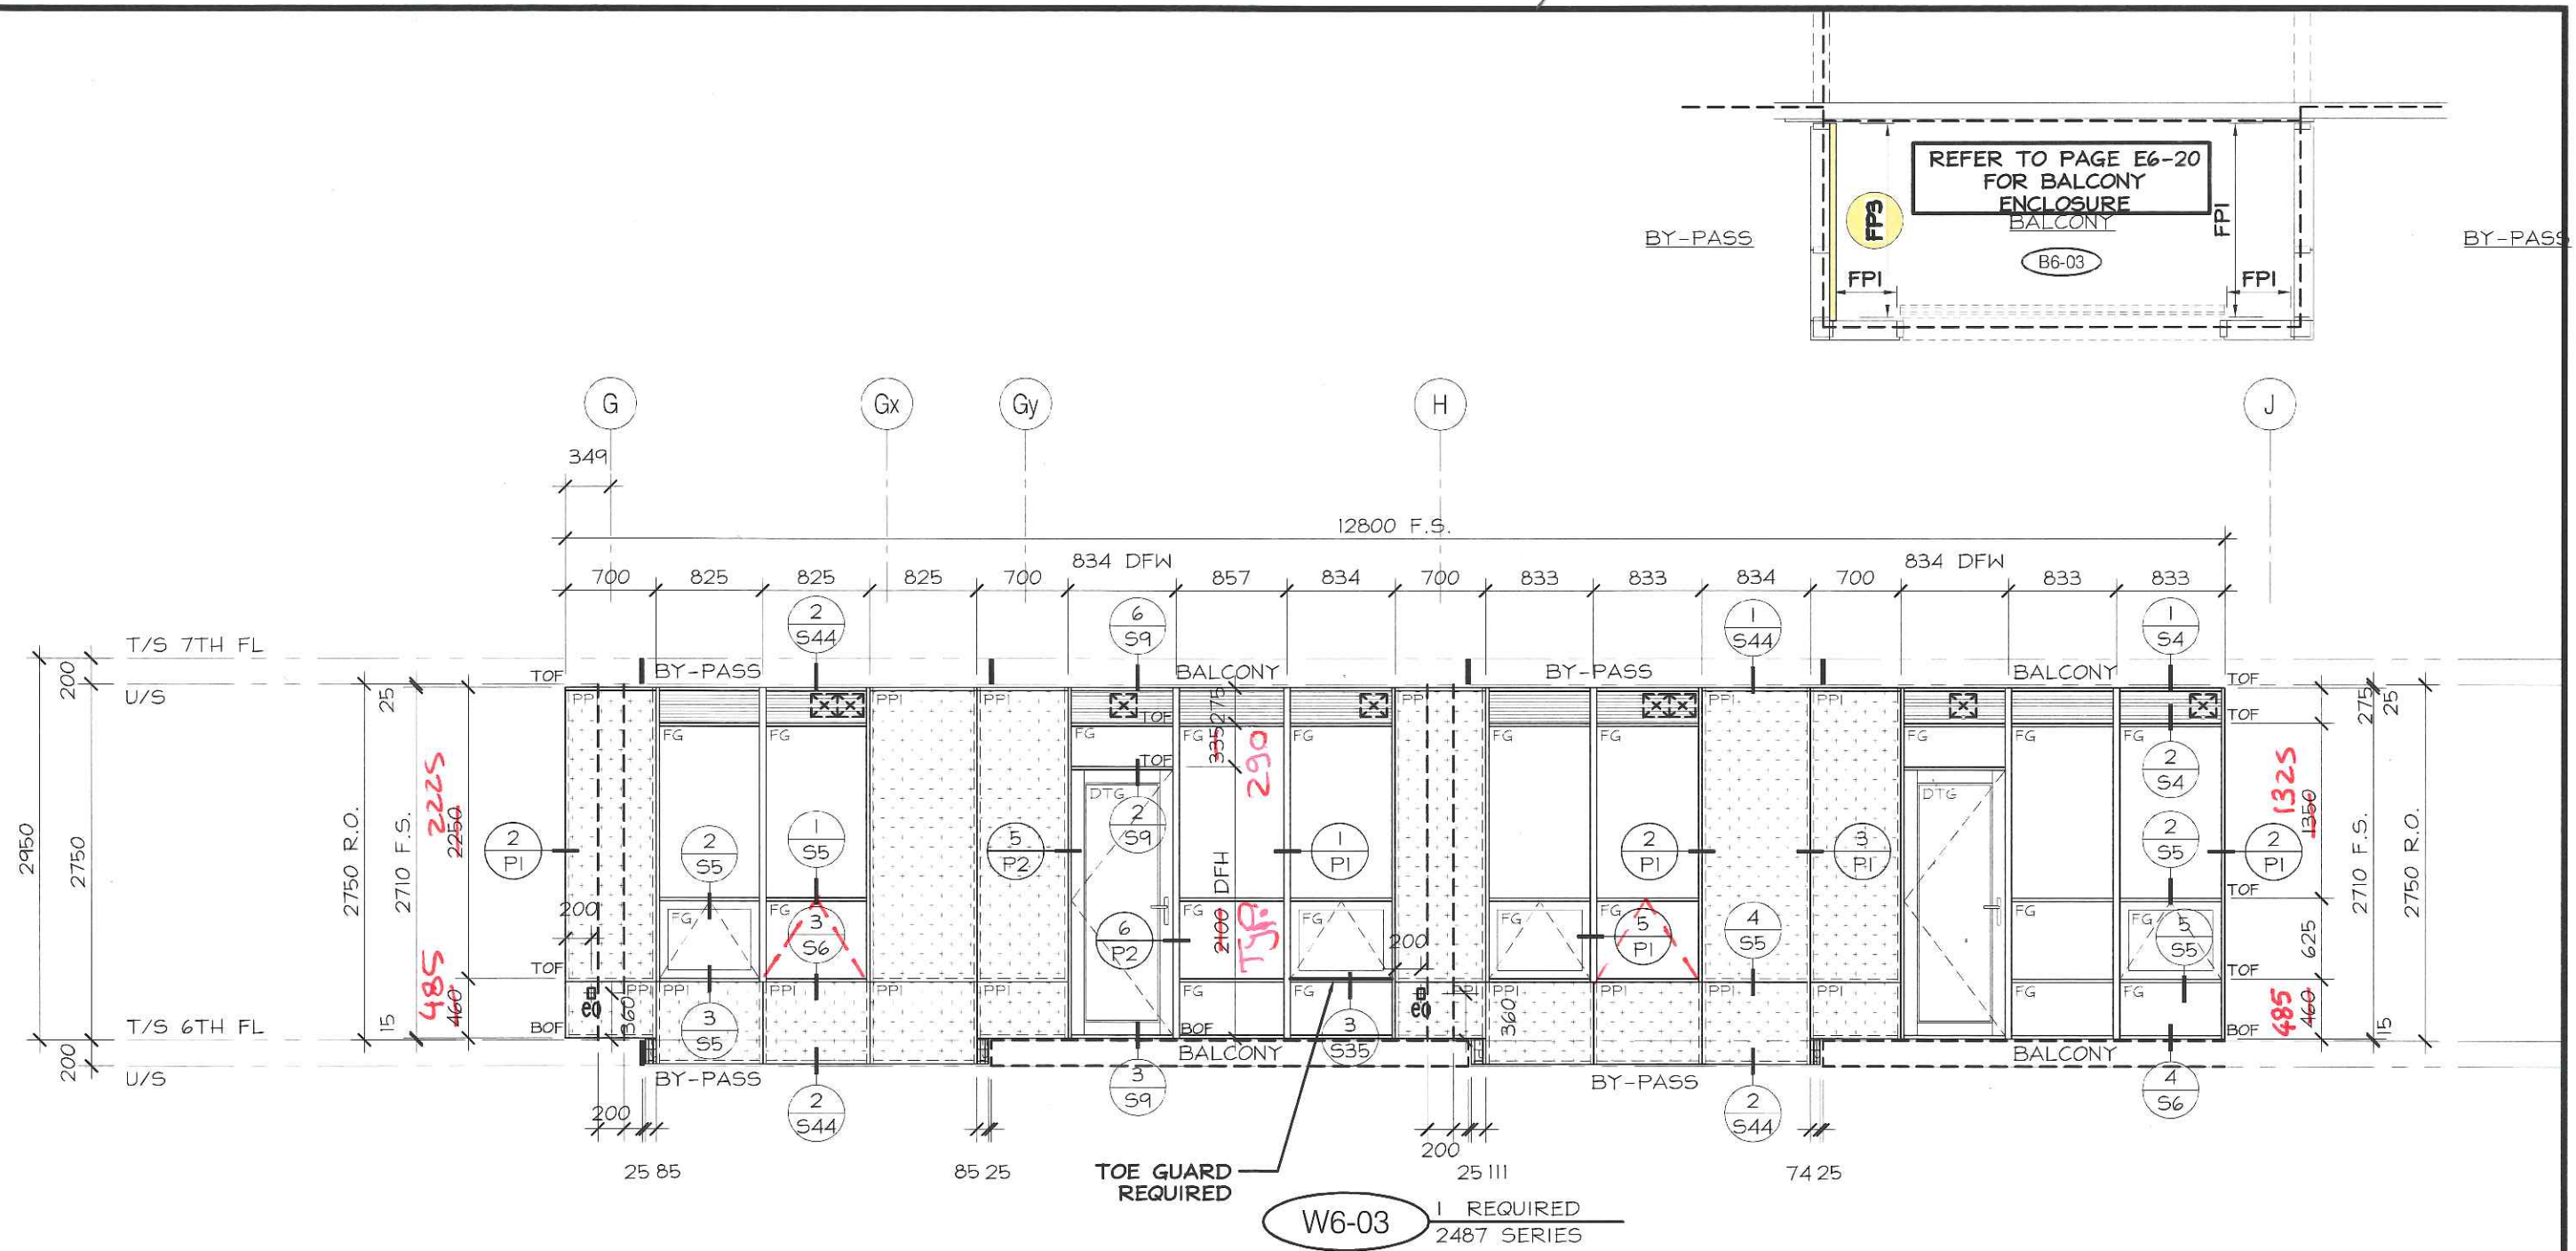


No.	REVISION	BY	DATE

PROJECT NAME:	SQ ALEXANDRA PARK - BLOCK 11		
DRAWING TITLE:	6th FLOOR ELEVATIONS		
ARCHITECT:	TEEPLE ARCHITECTS		
CONTRACTOR:	TRIDEL		
SCALE:	1:50	DRAWN BY:	S.C.
DATE:	MARCH 4, 2015		
DRAWING No.:			E6-3

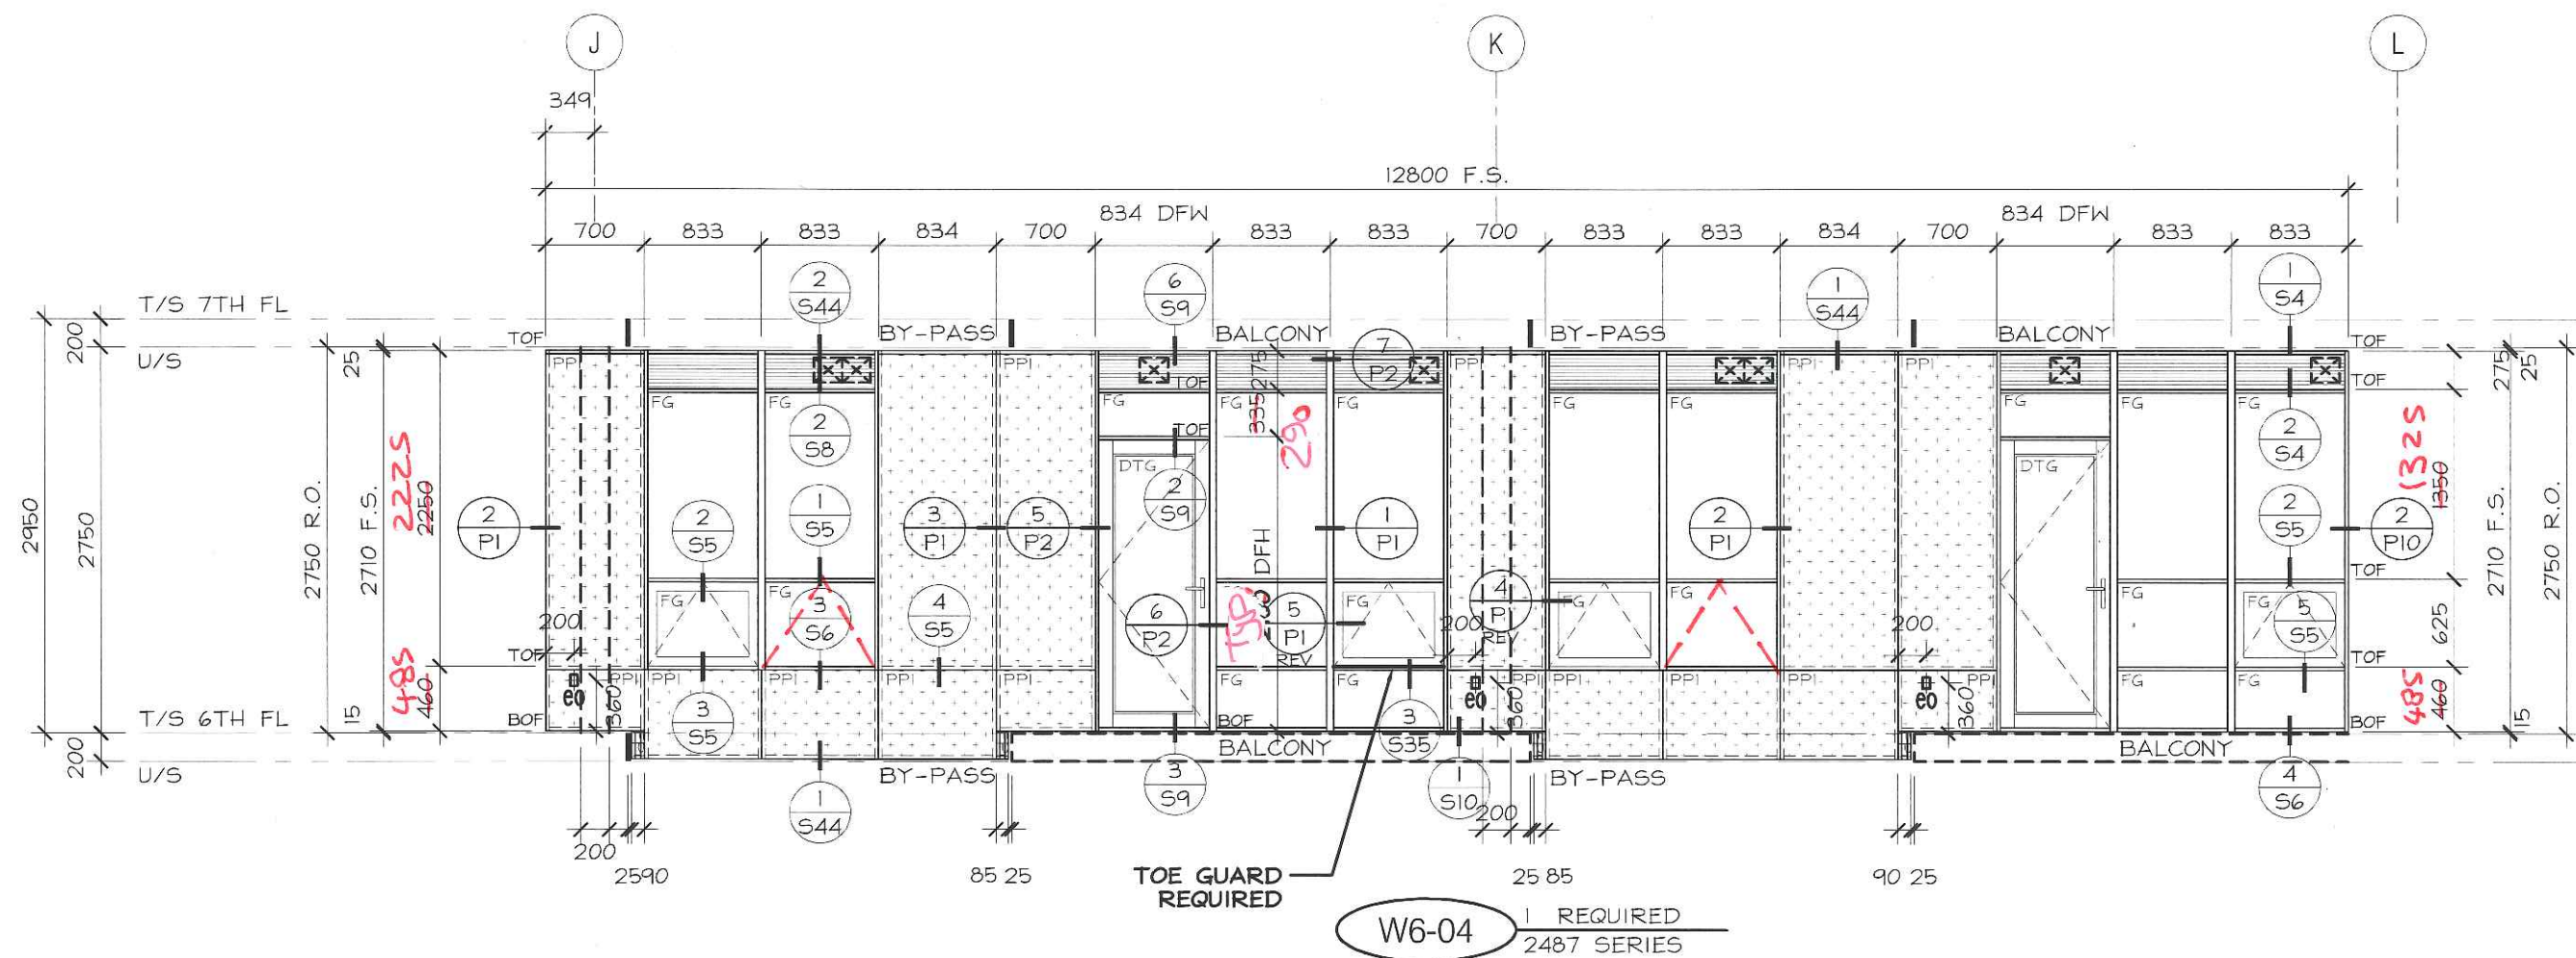

No.	REVISION	BY	DATE




PROJECT NAME:	SQ ALEXANDRA PARK - BLOCK 11
DRAWING TITLE:	6th FLOOR ELEVATIONS
ARCHITECT:	TEEPLE ARCHITECTS
CONTRACTOR:	TRIDEL
SCALE:	1:50
DRAWN BY:	S.C.
DATE:	MARCH 4, 2015

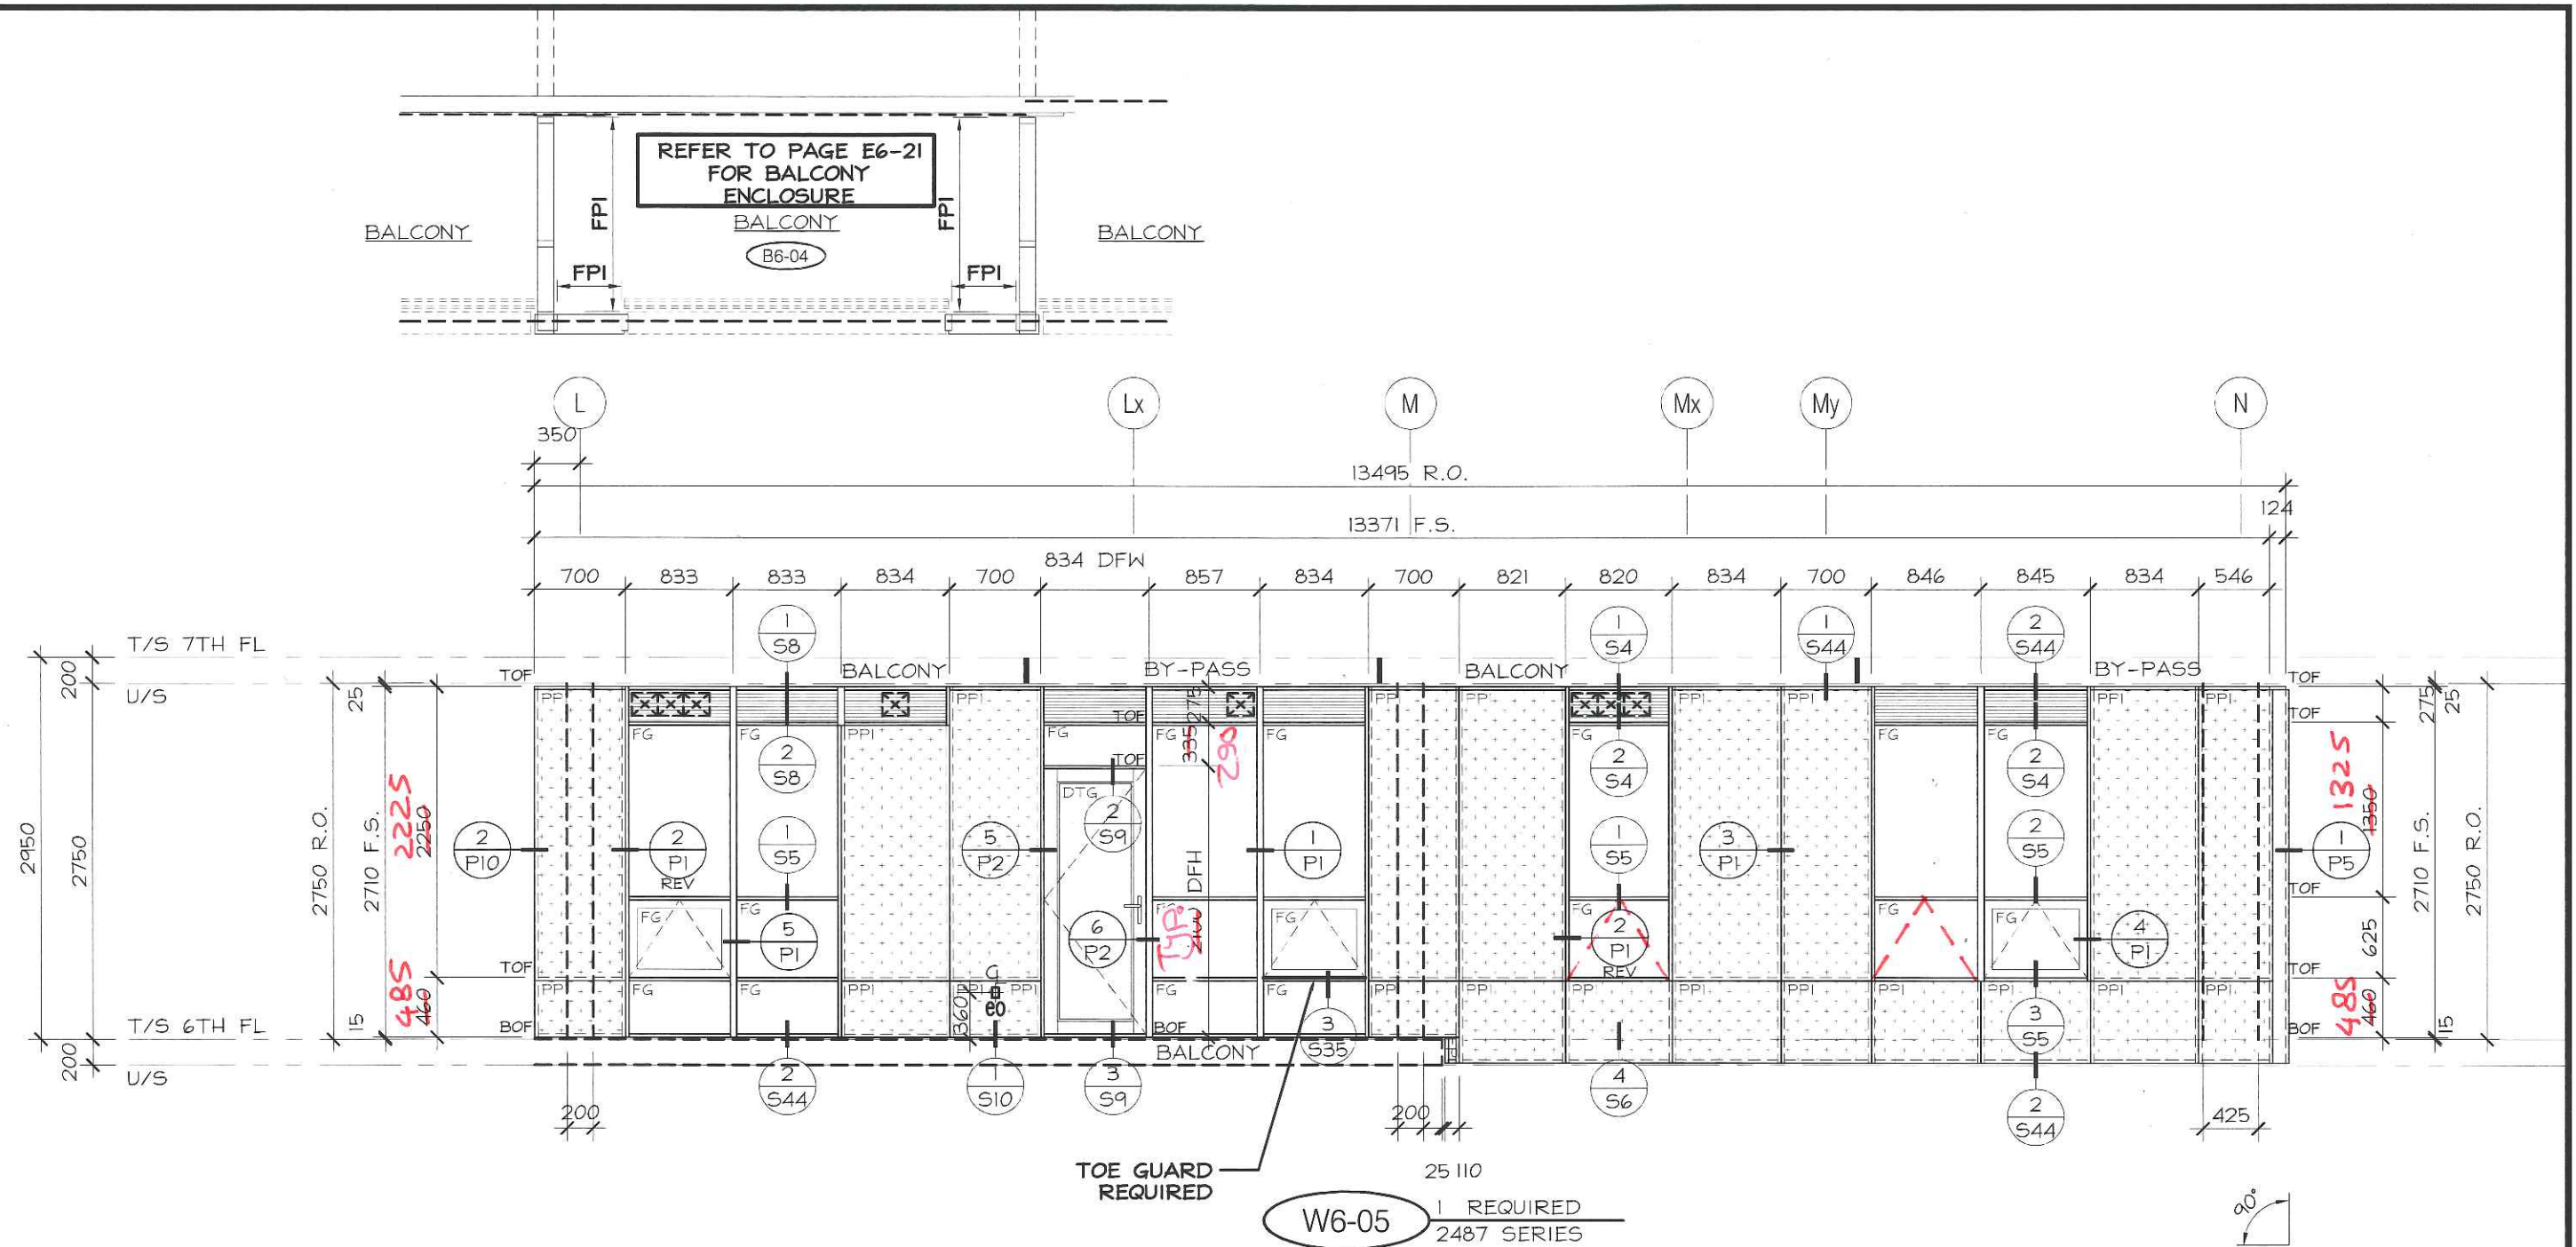

No.	REVISION	BY	DATE


PROJECT NAME:	SQ ALEXANDRA PARK - BLOCK 11		
DRAWING TITLE:	6th FLOOR ELEVATIONS		
ARCHITECT:	TEEPLE ARCHITECTS		
CONTRACTOR:	TRIDEL		
SCALE:	1:50	DRAWN BY:	S.C.
DATE:	MARCH 4, 2015		
DRAWING No.:	E6-5		

500
T/S PARAPET
200
T/S 7TH FL
U/S

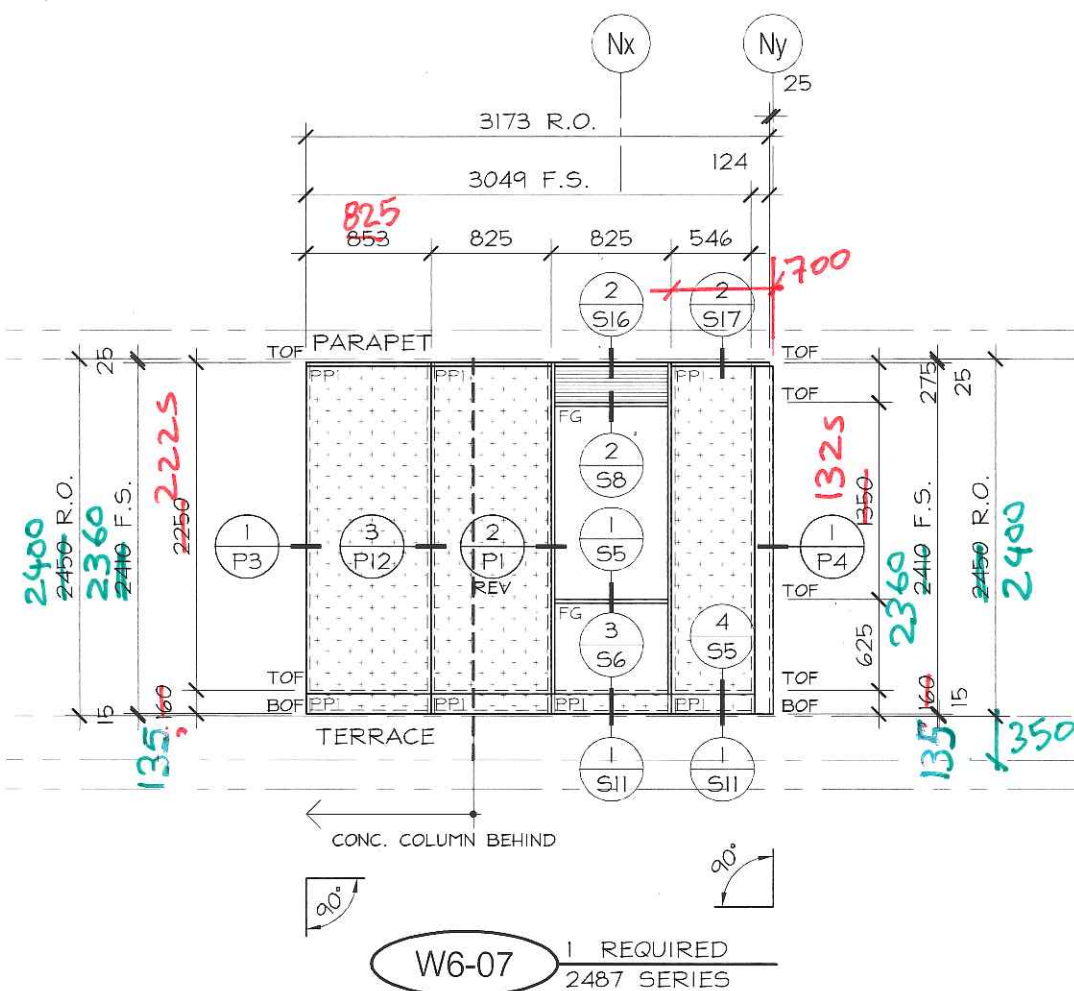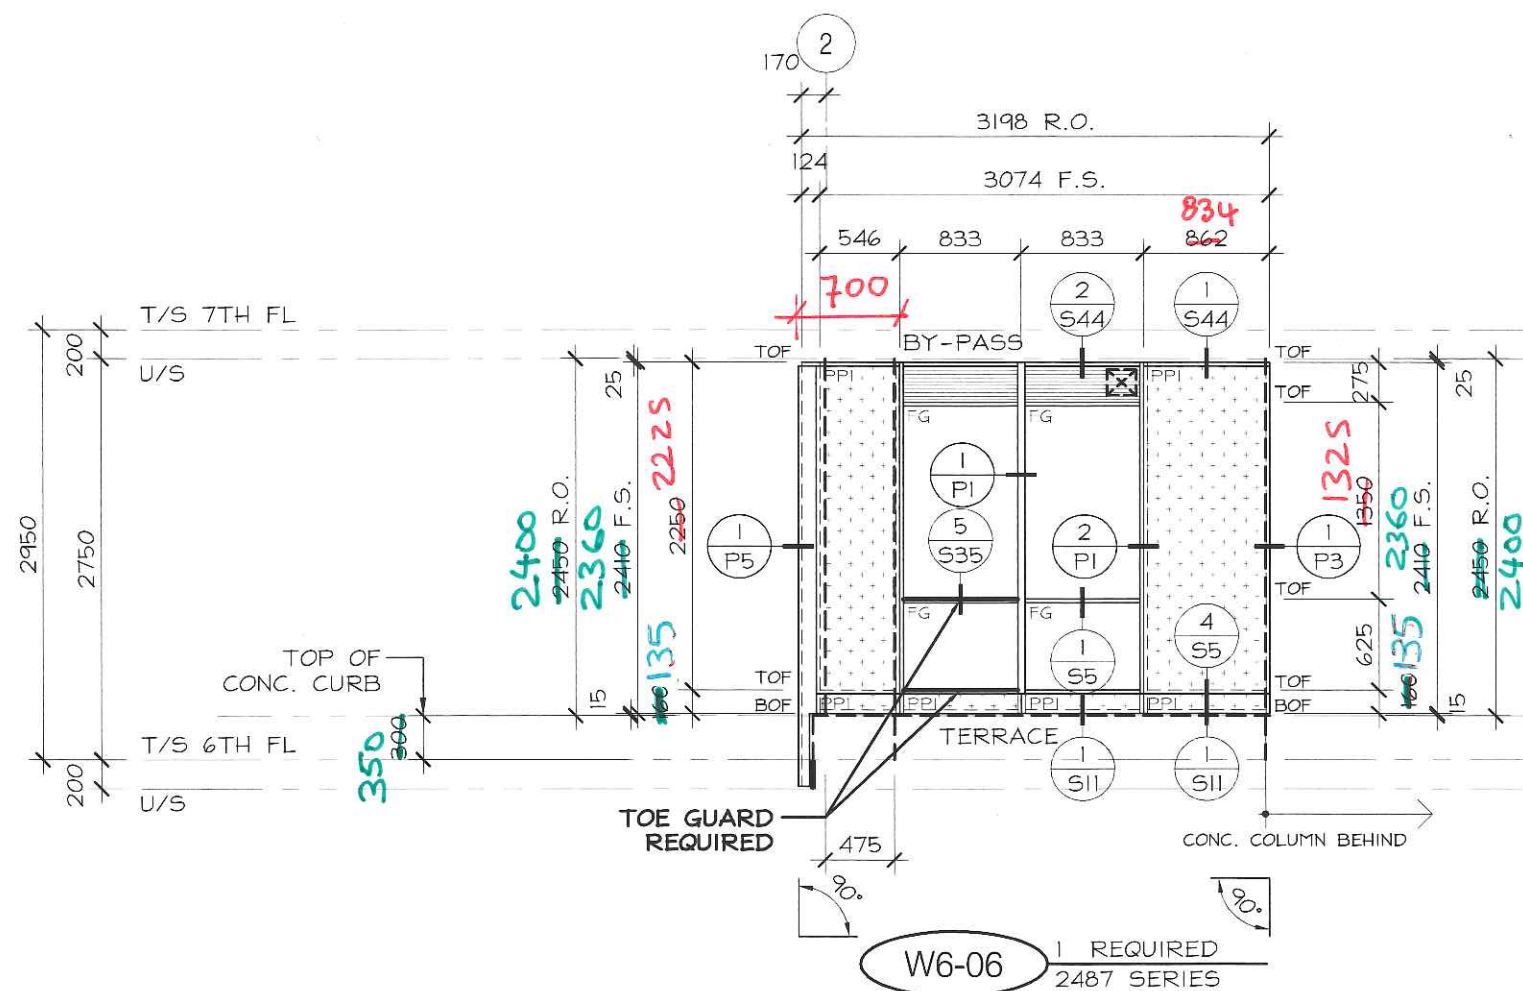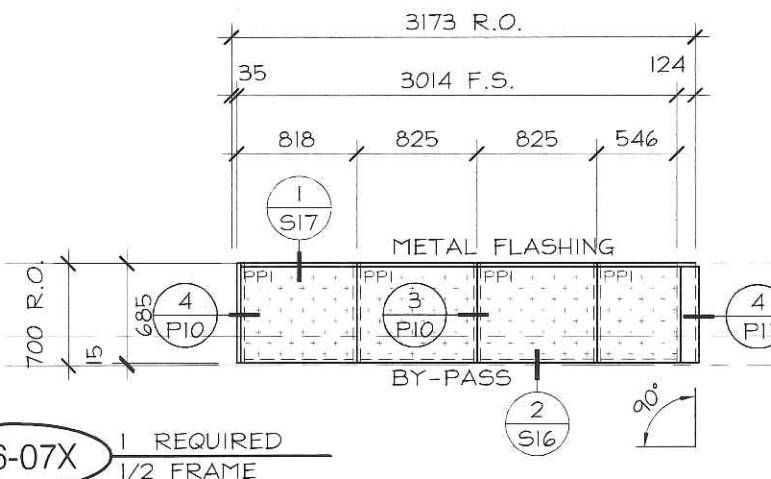


No.	REVISION	BY	DATE

PROJECT NAME:	SQ ALEXANDRA PARK - BLOCK11
DRAWING TITLE:	6th FLOOR ELEVATIONS
ARCHITECT:	TEEPLE ARCHITECTS
CONTRACTOR:	TRIDEL
SCALE:	1:50
DRAWN BY:	S.C.
DATE:	MARCH 4, 2015
DRAWING No.:	E6-6

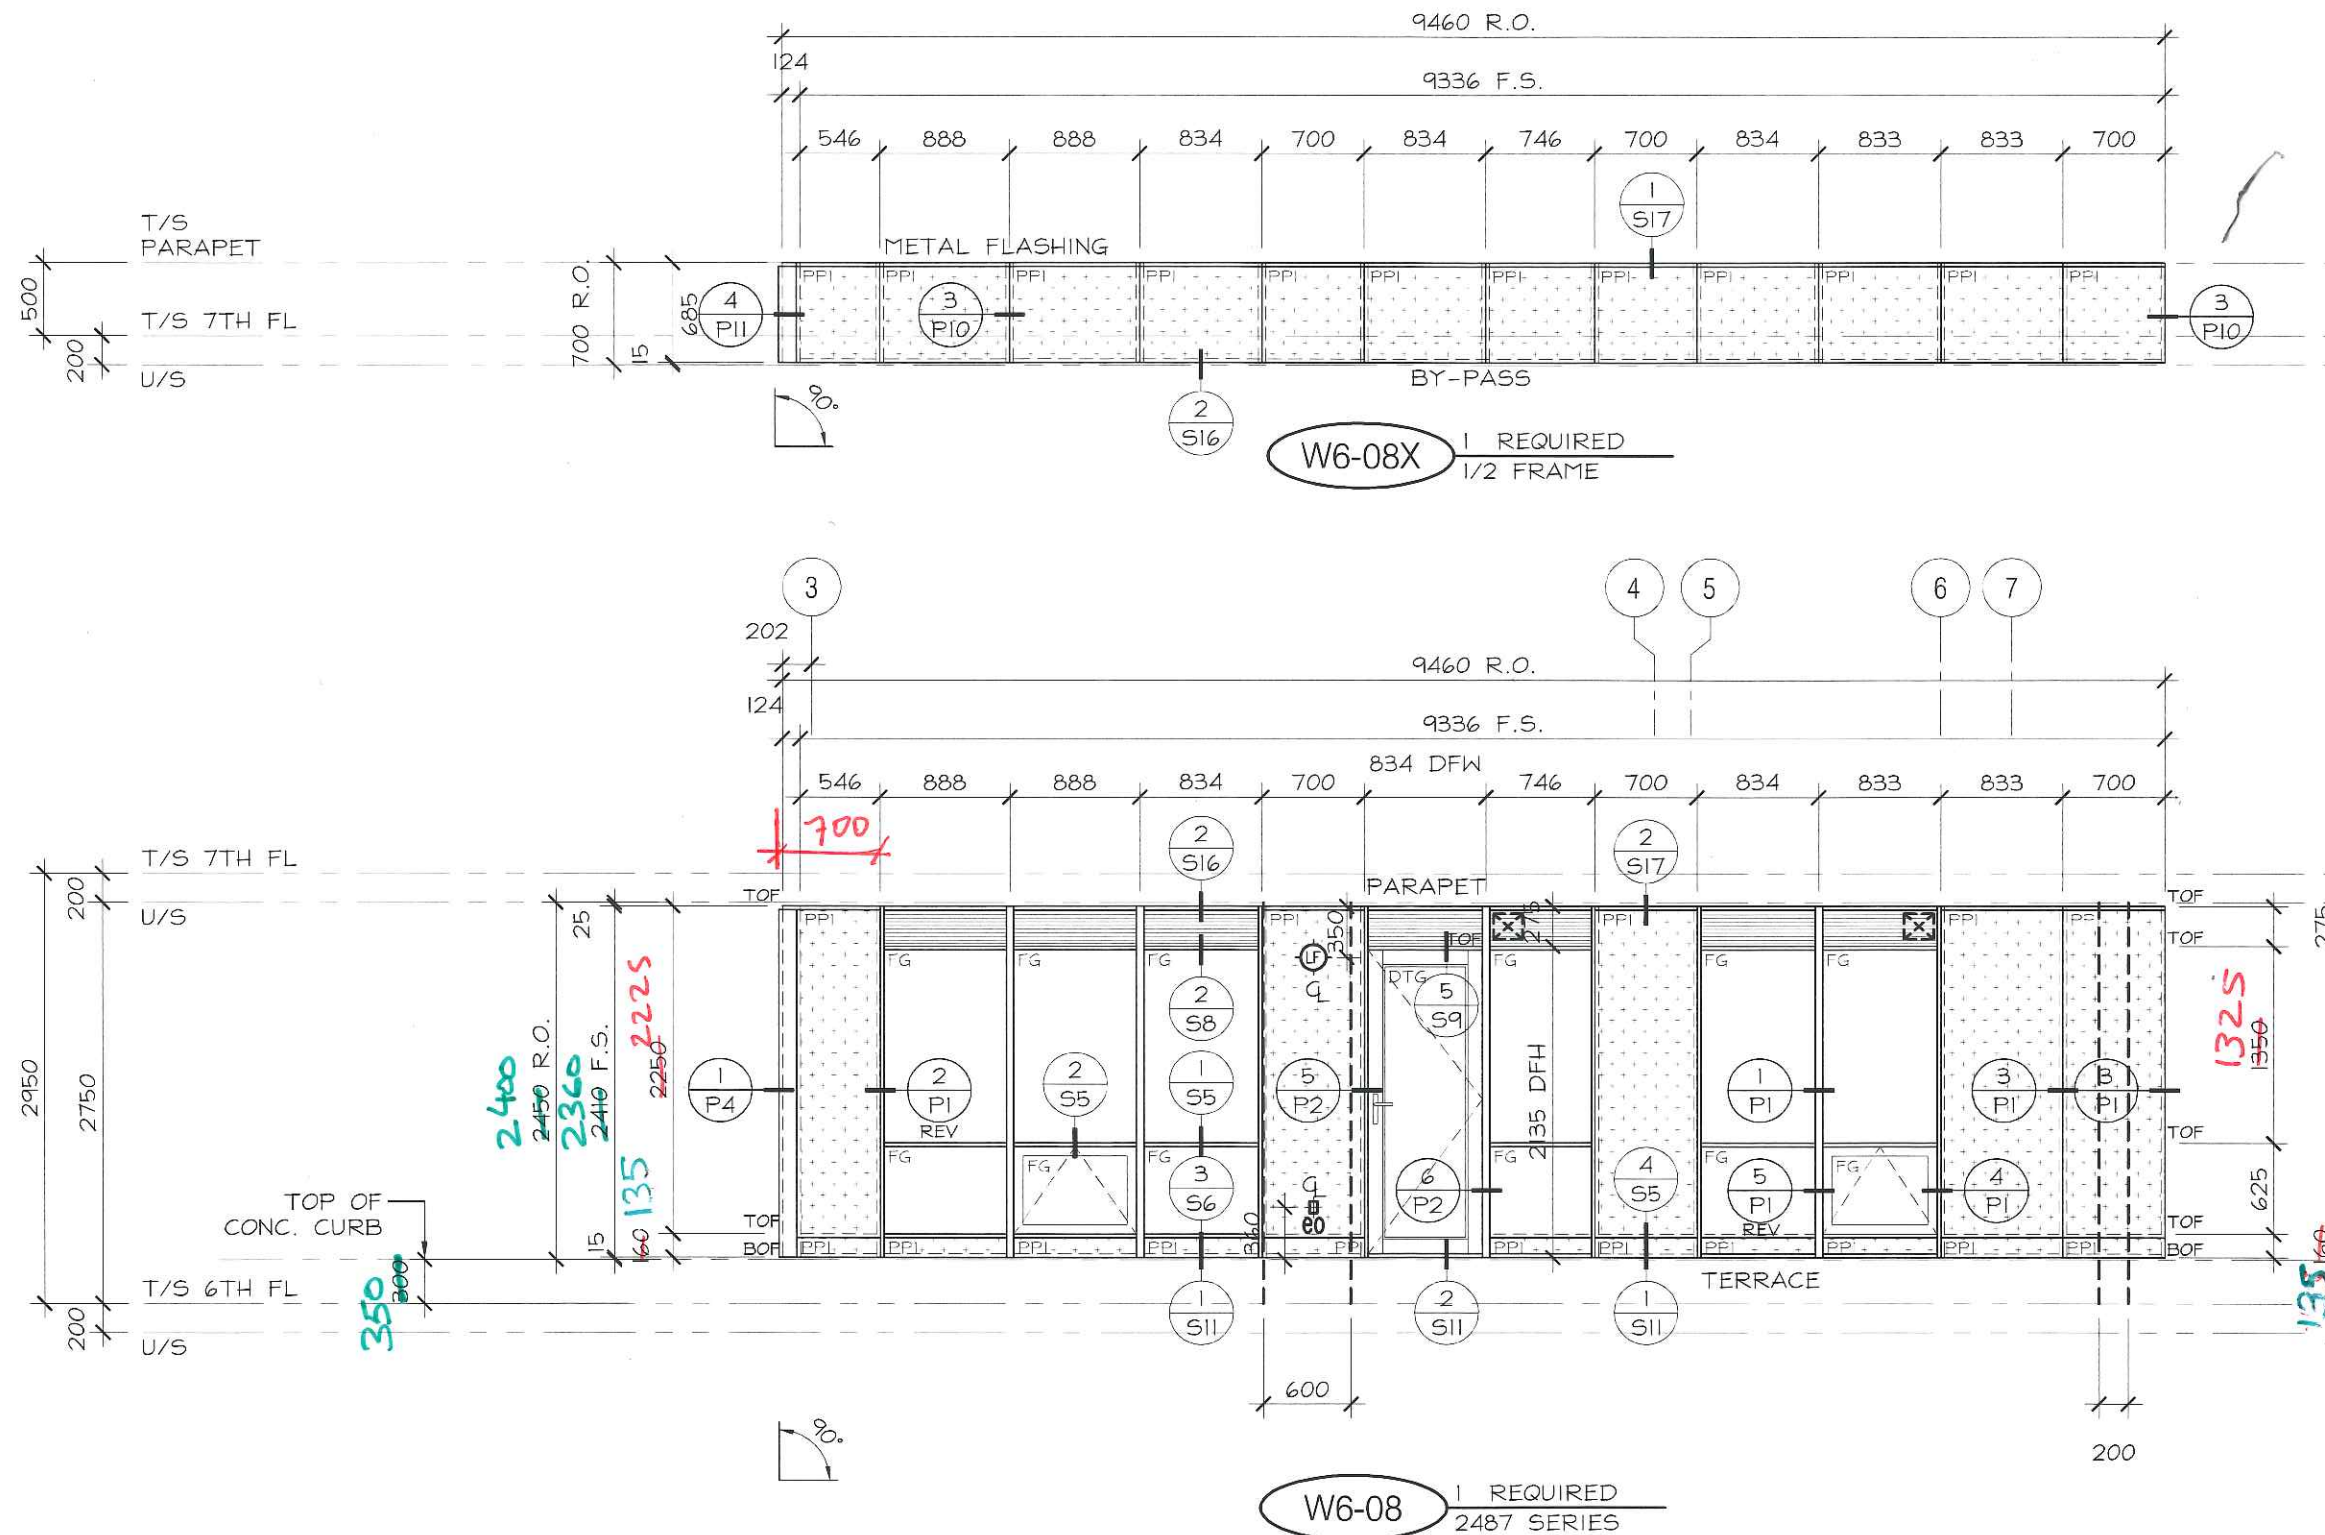

No.	REVISION	BY	DATE

PROJECT NAME:	SQ ALEXANDRA PARK - BLOCK 11		
DRAWING TITLE:	6th FLOOR ELEVATIONS		
ARCHITECT:	TEEPLE ARCHITECTS		
CONTRACTOR:	TRIDEL		
SCALE:	1:50	DRAWN BY:	S.C.
DATE:	MARCH 4, 2015		
DRAWING No.:			E6-7

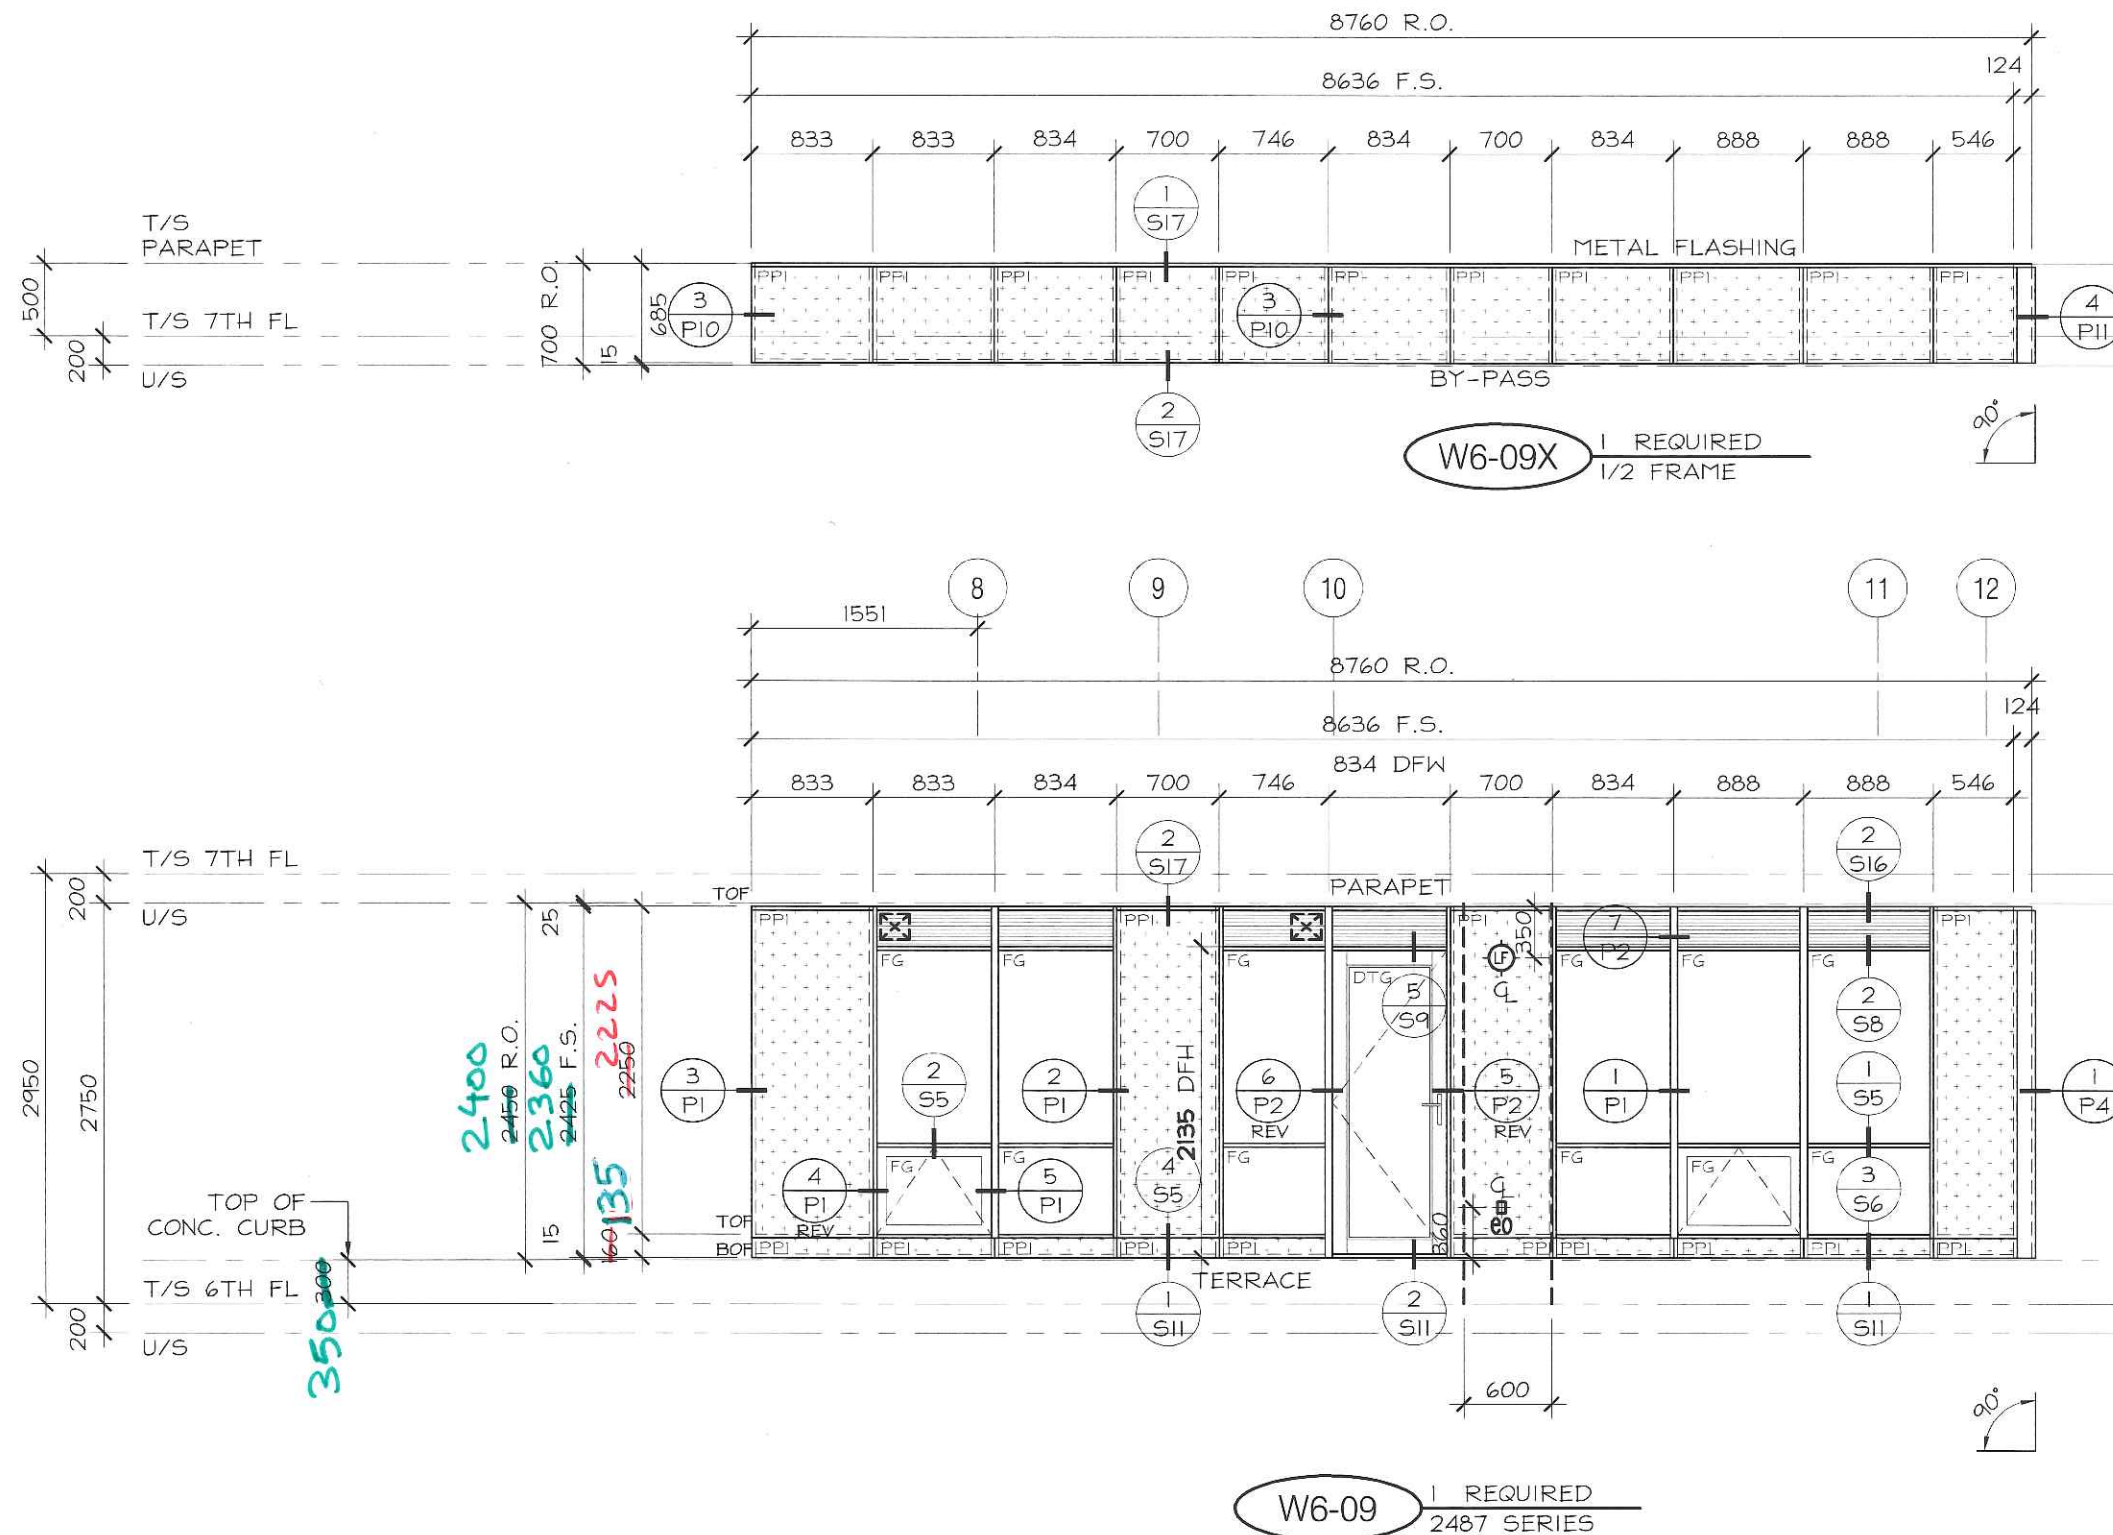

No.	REVISION	BY	DATE

PROJECT NAME: SQ ALEXANDRA PARK - BLOCK 11

DRAWING TITLE: 6th FLOOR ELEVATIONS

ARCHITECT: TEEPLE ARCHITECTS




CONTRACTOR: TRIDEL

SCALE: 1:50

DRAWN BY: S.C.

DATE: MARCH 4, 2015

DRAWING No.:
E6-8

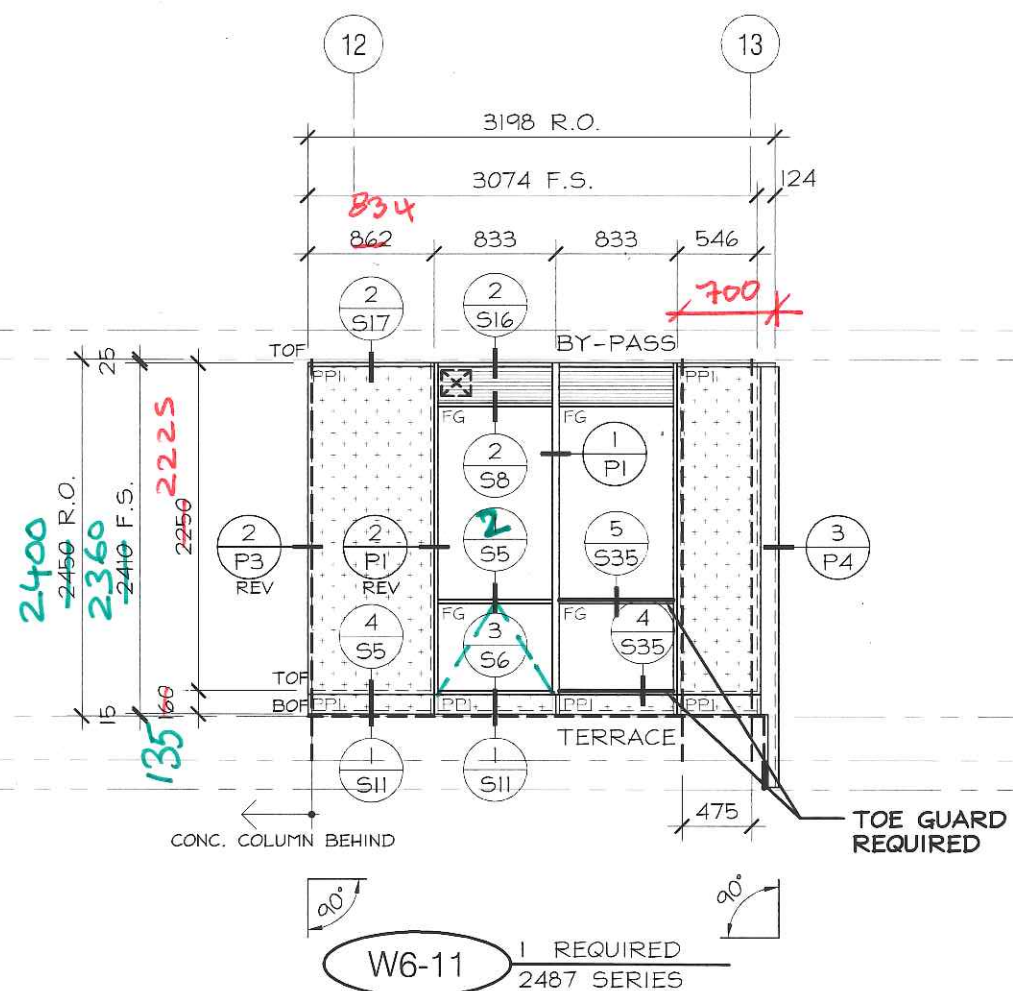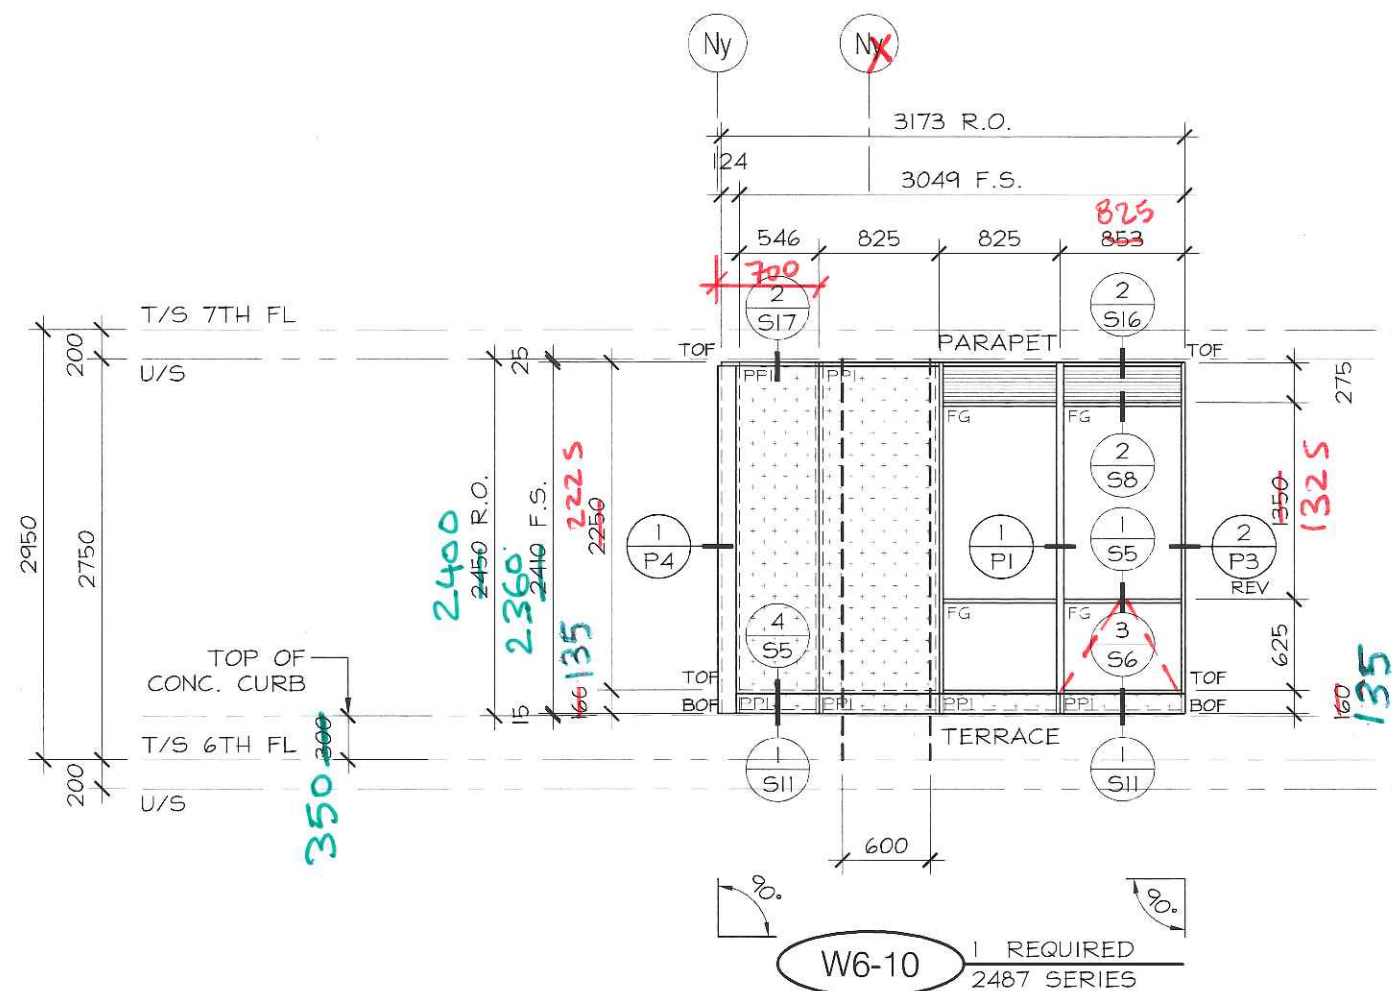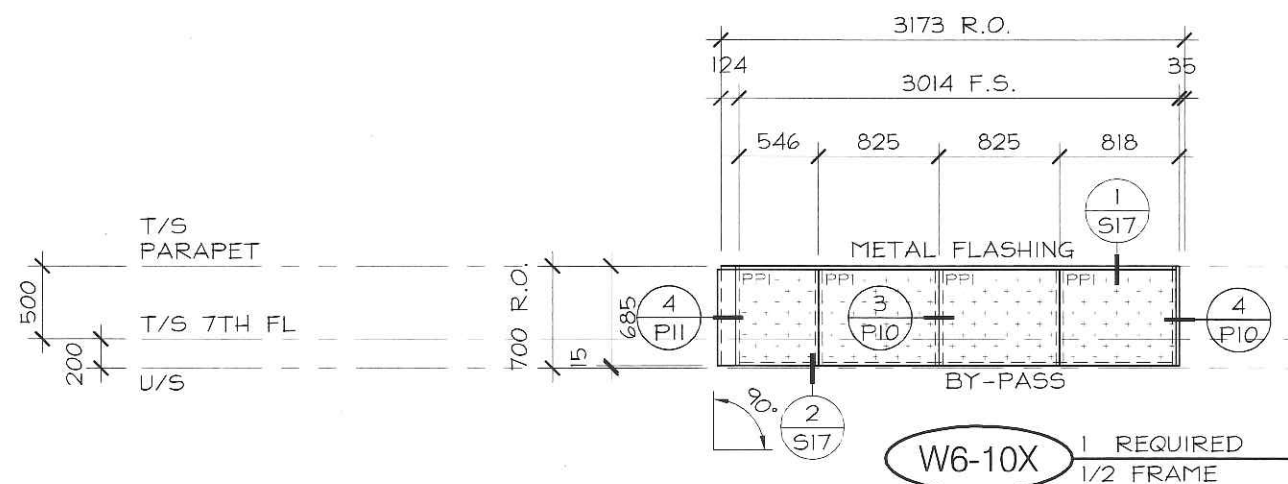


No.	REVISION	BY	DATE

PROJECT NAME:	SQ ALEXANDRA PARK - BLOCK11
DRAWING TITLE:	6th FLOOR ELEVATIONS
ARCHITECT:	TEEPLE ARCHITECTS
CONTRACTOR:	TRIDEL
SCALE:	1:50
DRAWN BY:	S.C.
DATE:	MARCH 4, 2015
DRAWING No.:	E6-9




PROJECT NAME: SQ ALEXANDRA PARK - BLOCK11		
DRAWING TITLE: 6th FLOOR ELEVATIONS		
ARCHITECT: TEEPLE ARCHITECTS		DRAWING No.: E6-11
CONTRACTOR: TRIDEL		
SCALE: 1:50	DRAWN BY: S.C.	
		DATE: MARCH 4, 2015

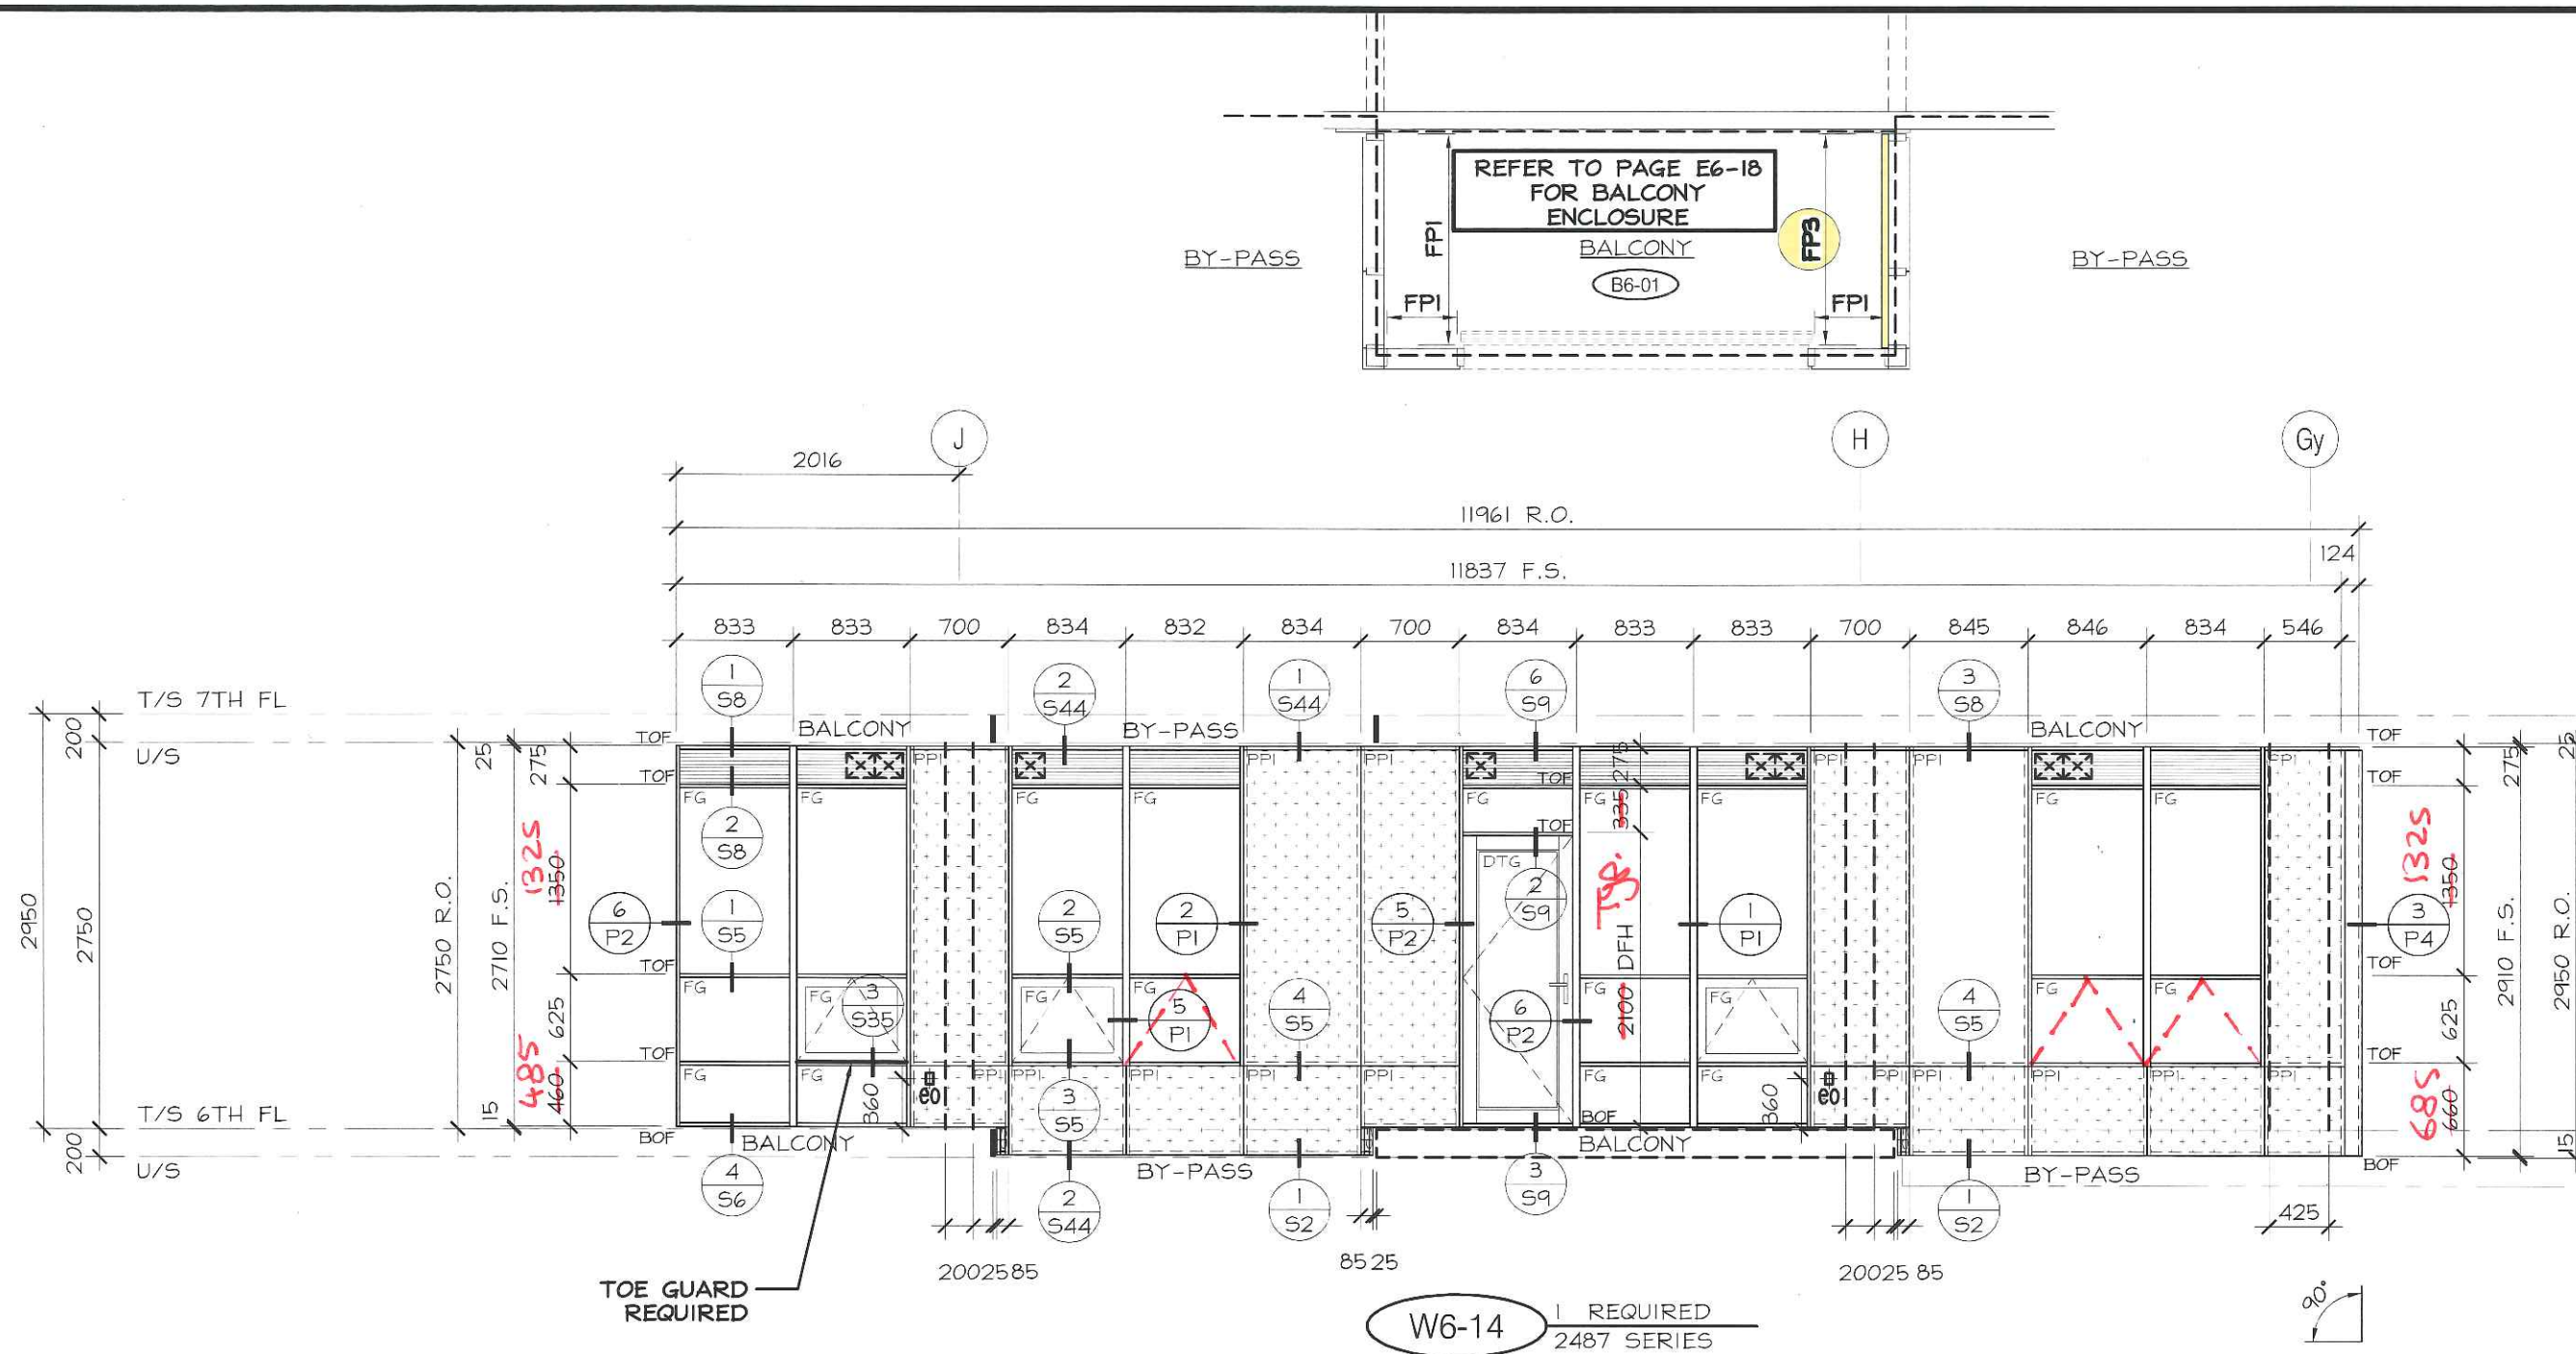


No.	REVISION	BY	DATE

PROJECT NAME:	SQ ALEXANDRA PARK - BLOCK 11
DRAWING TITLE:	6th FLOOR ELEVATIONS
ARCHITECT:	TEEPLE ARCHITECTS
CONTRACTOR:	TRIDEL
SCALE:	1:50
DRAWN BY:	S.C.
DATE:	MARCH 4, 2015

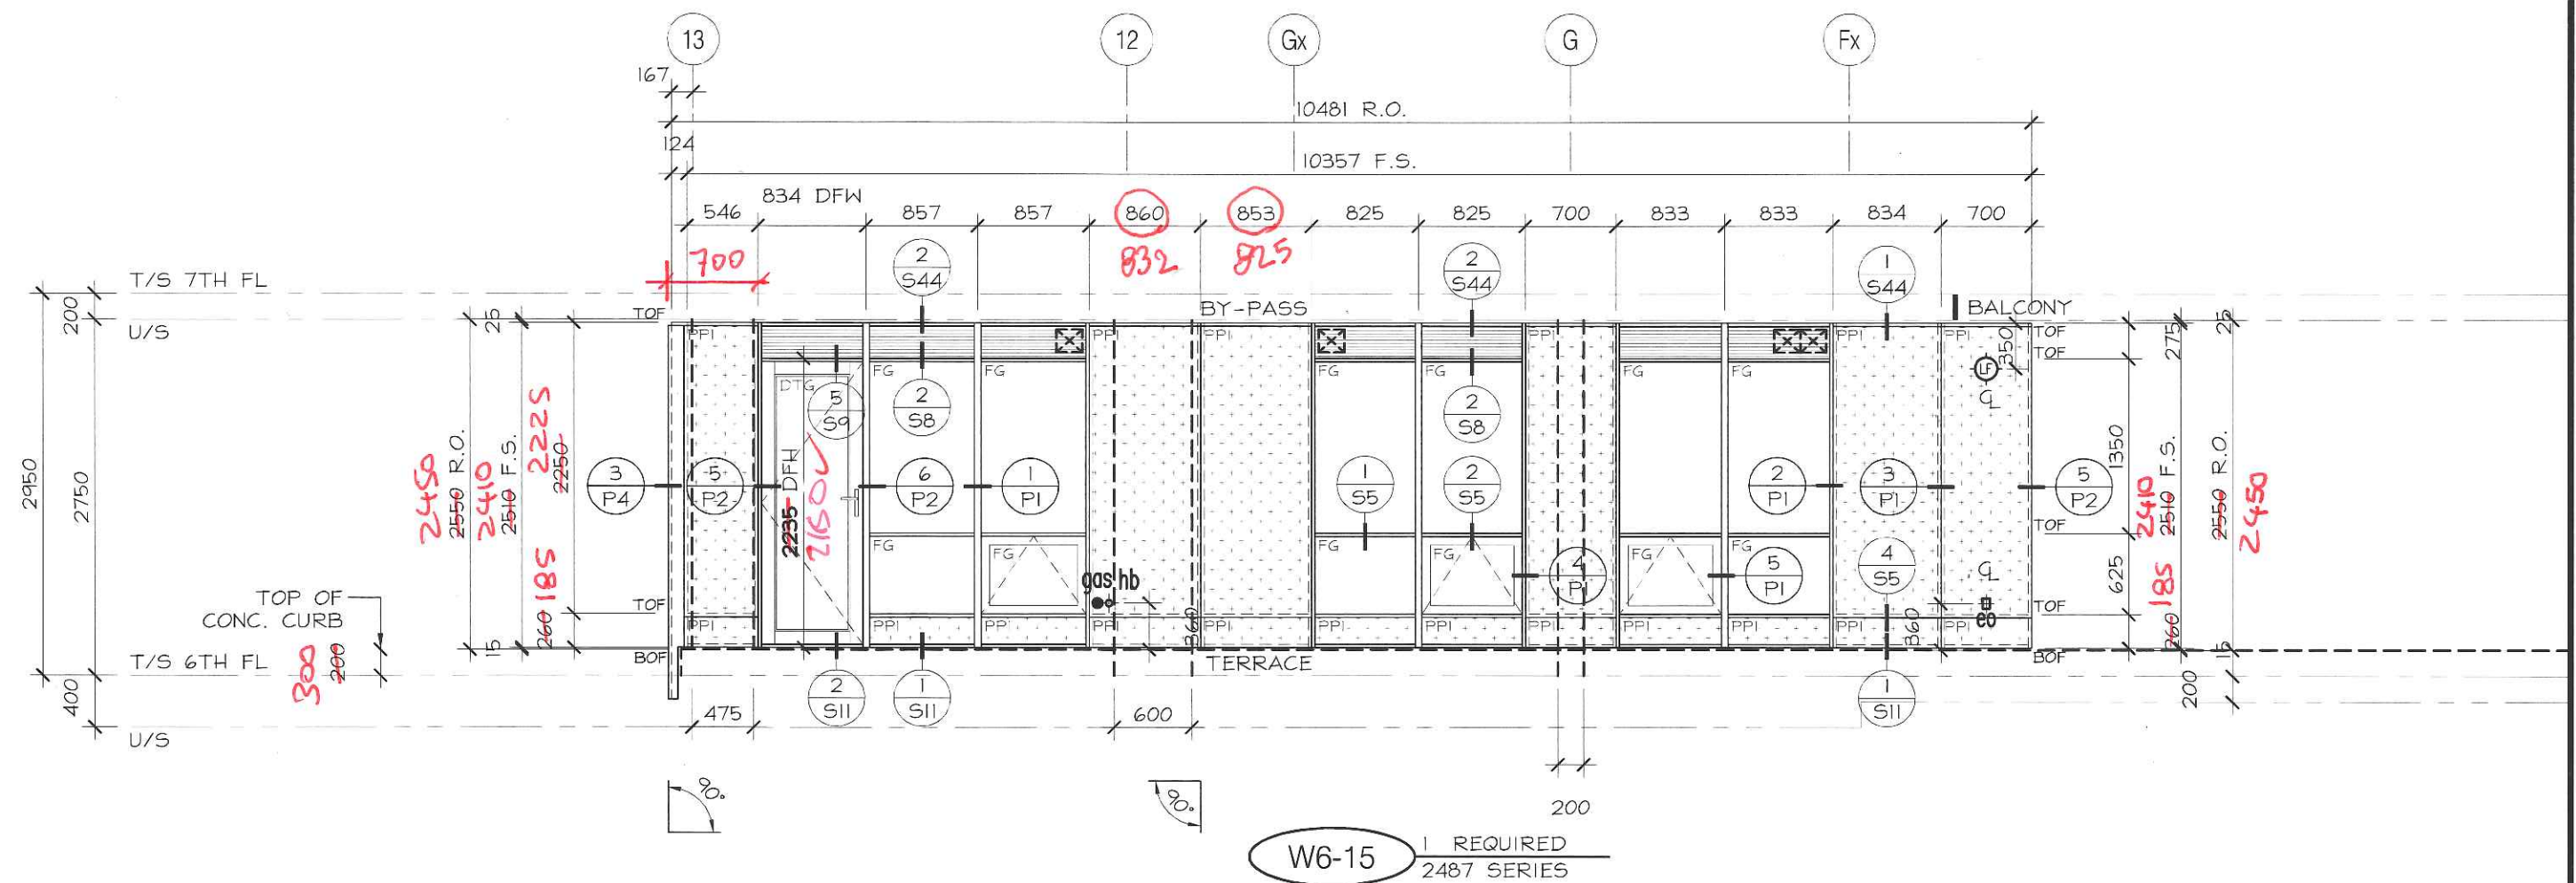


No.	REVISION	BY	DATE

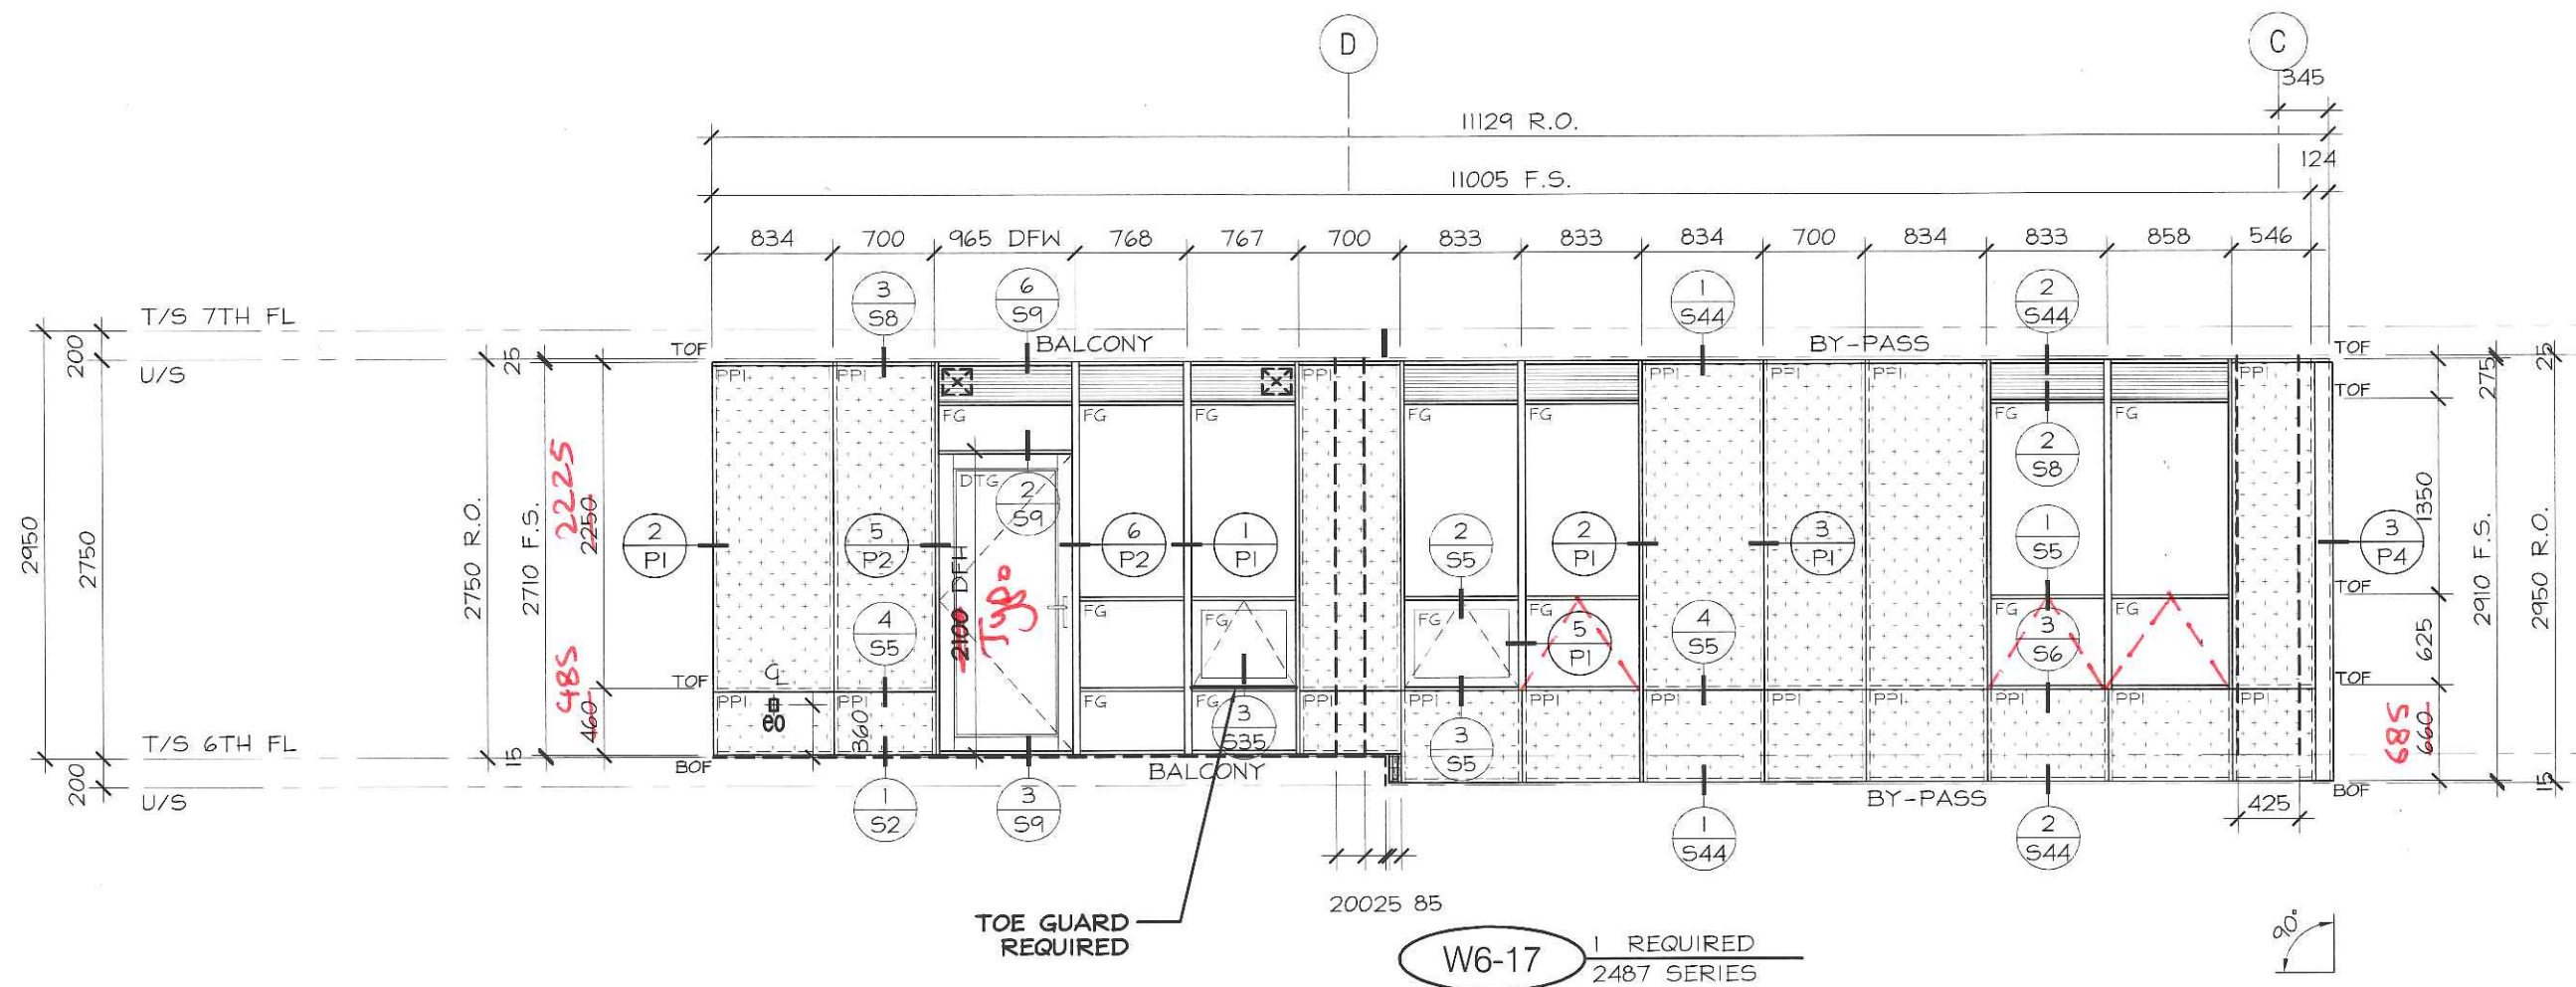


No.	REVISION	BY	DATE

PROJECT NAME:	SQ ALEXANDRA PARK - BLOCK11		
DRAWING TITLE:	6th FLOOR ELEVATIONS		
ARCHITECT:	TEEPLE ARCHITECTS		
CONTRACTOR:	TRIDEL		
SCALE:	1:50	DRAWN BY:	S.C.
DATE:	MARCH 4, 2015		
DRAWING No.:	E6-15		

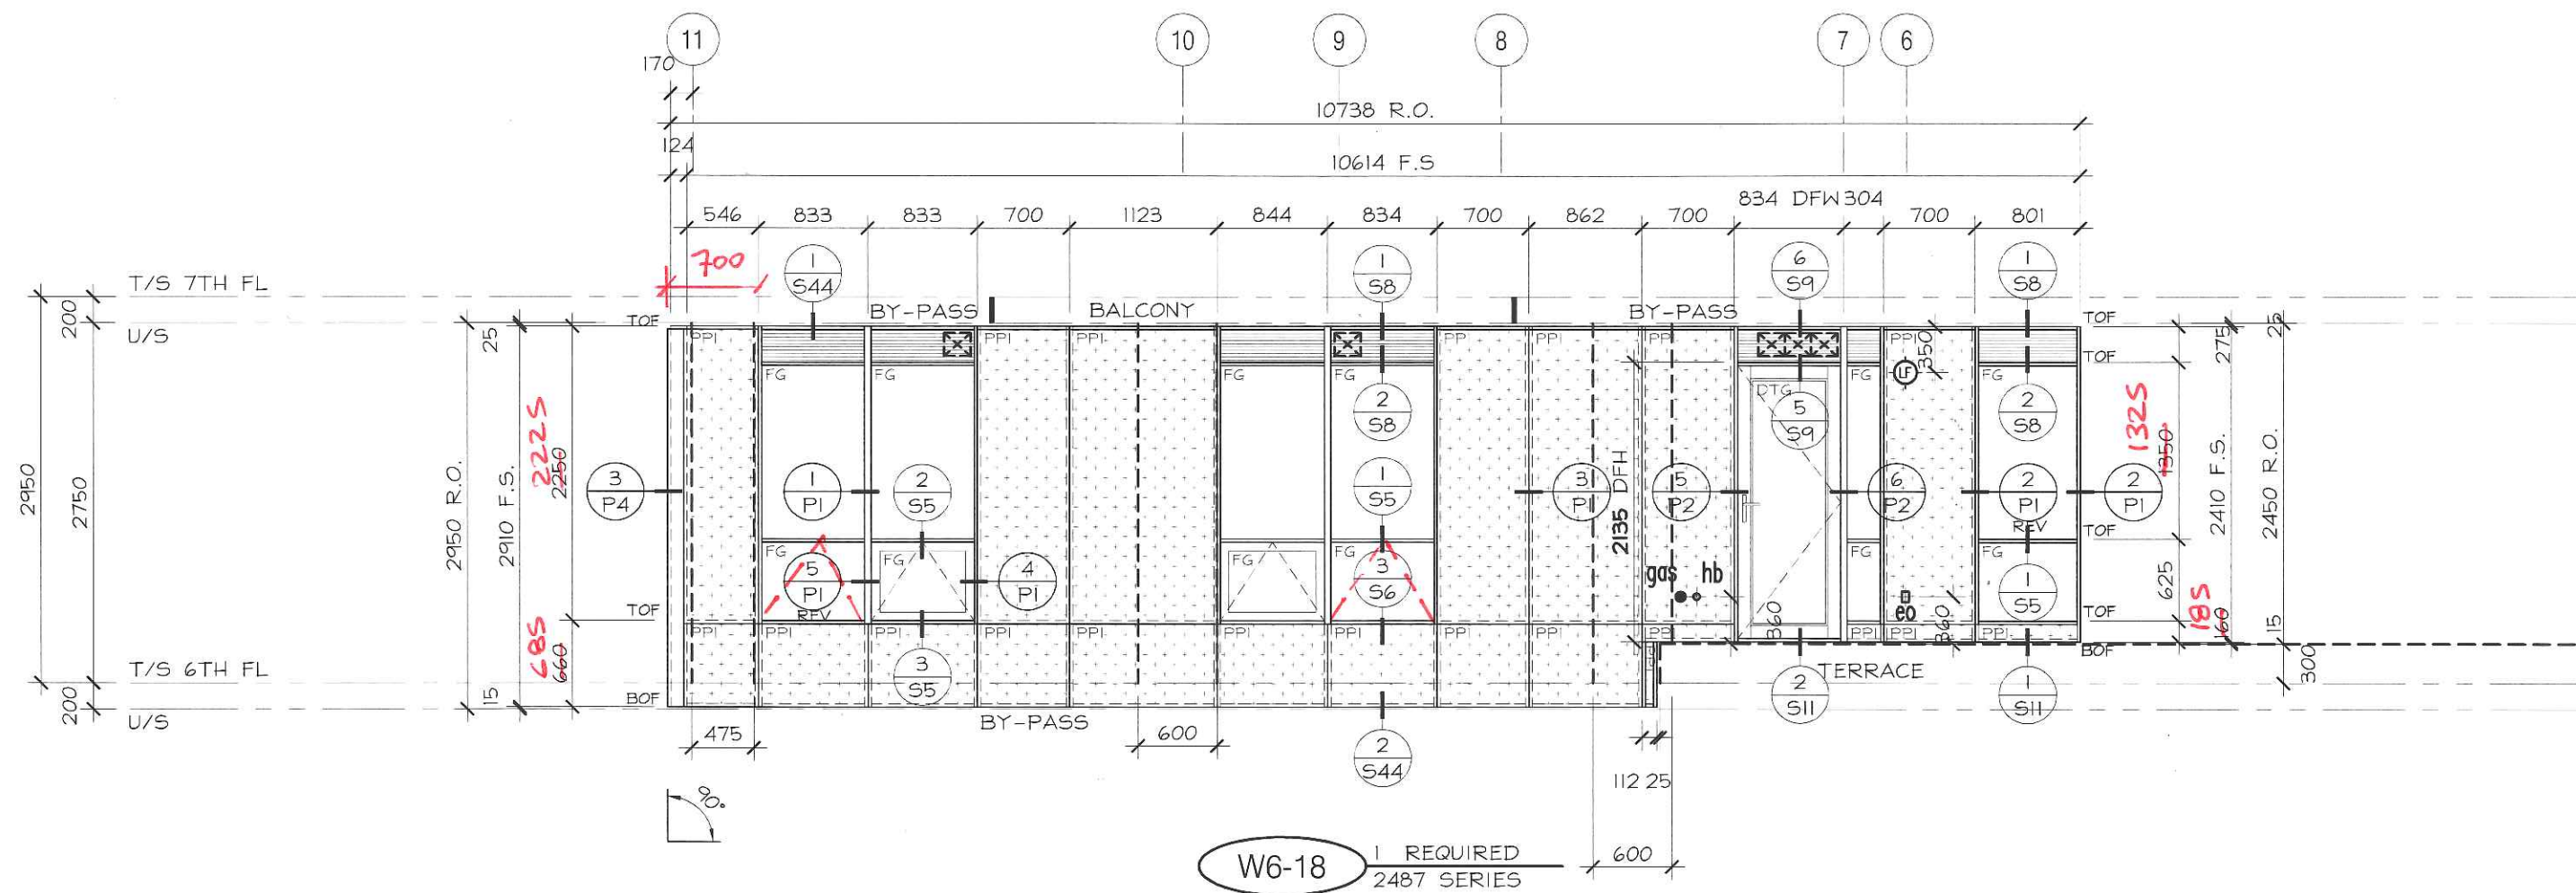

No.	REVISION	BY	DATE


PROJECT NAME:	SQ ALEXANDRA PARK - BLOCK 11
DRAWING TITLE:	6th FLOOR ELEVATIONS
ARCHITECT:	TEEPLE ARCHITECTS
CONTRACTOR:	TRIDEL
SCALE:	1:50
DRAWN BY:	S.C.
DATE:	MARCH 4, 2015

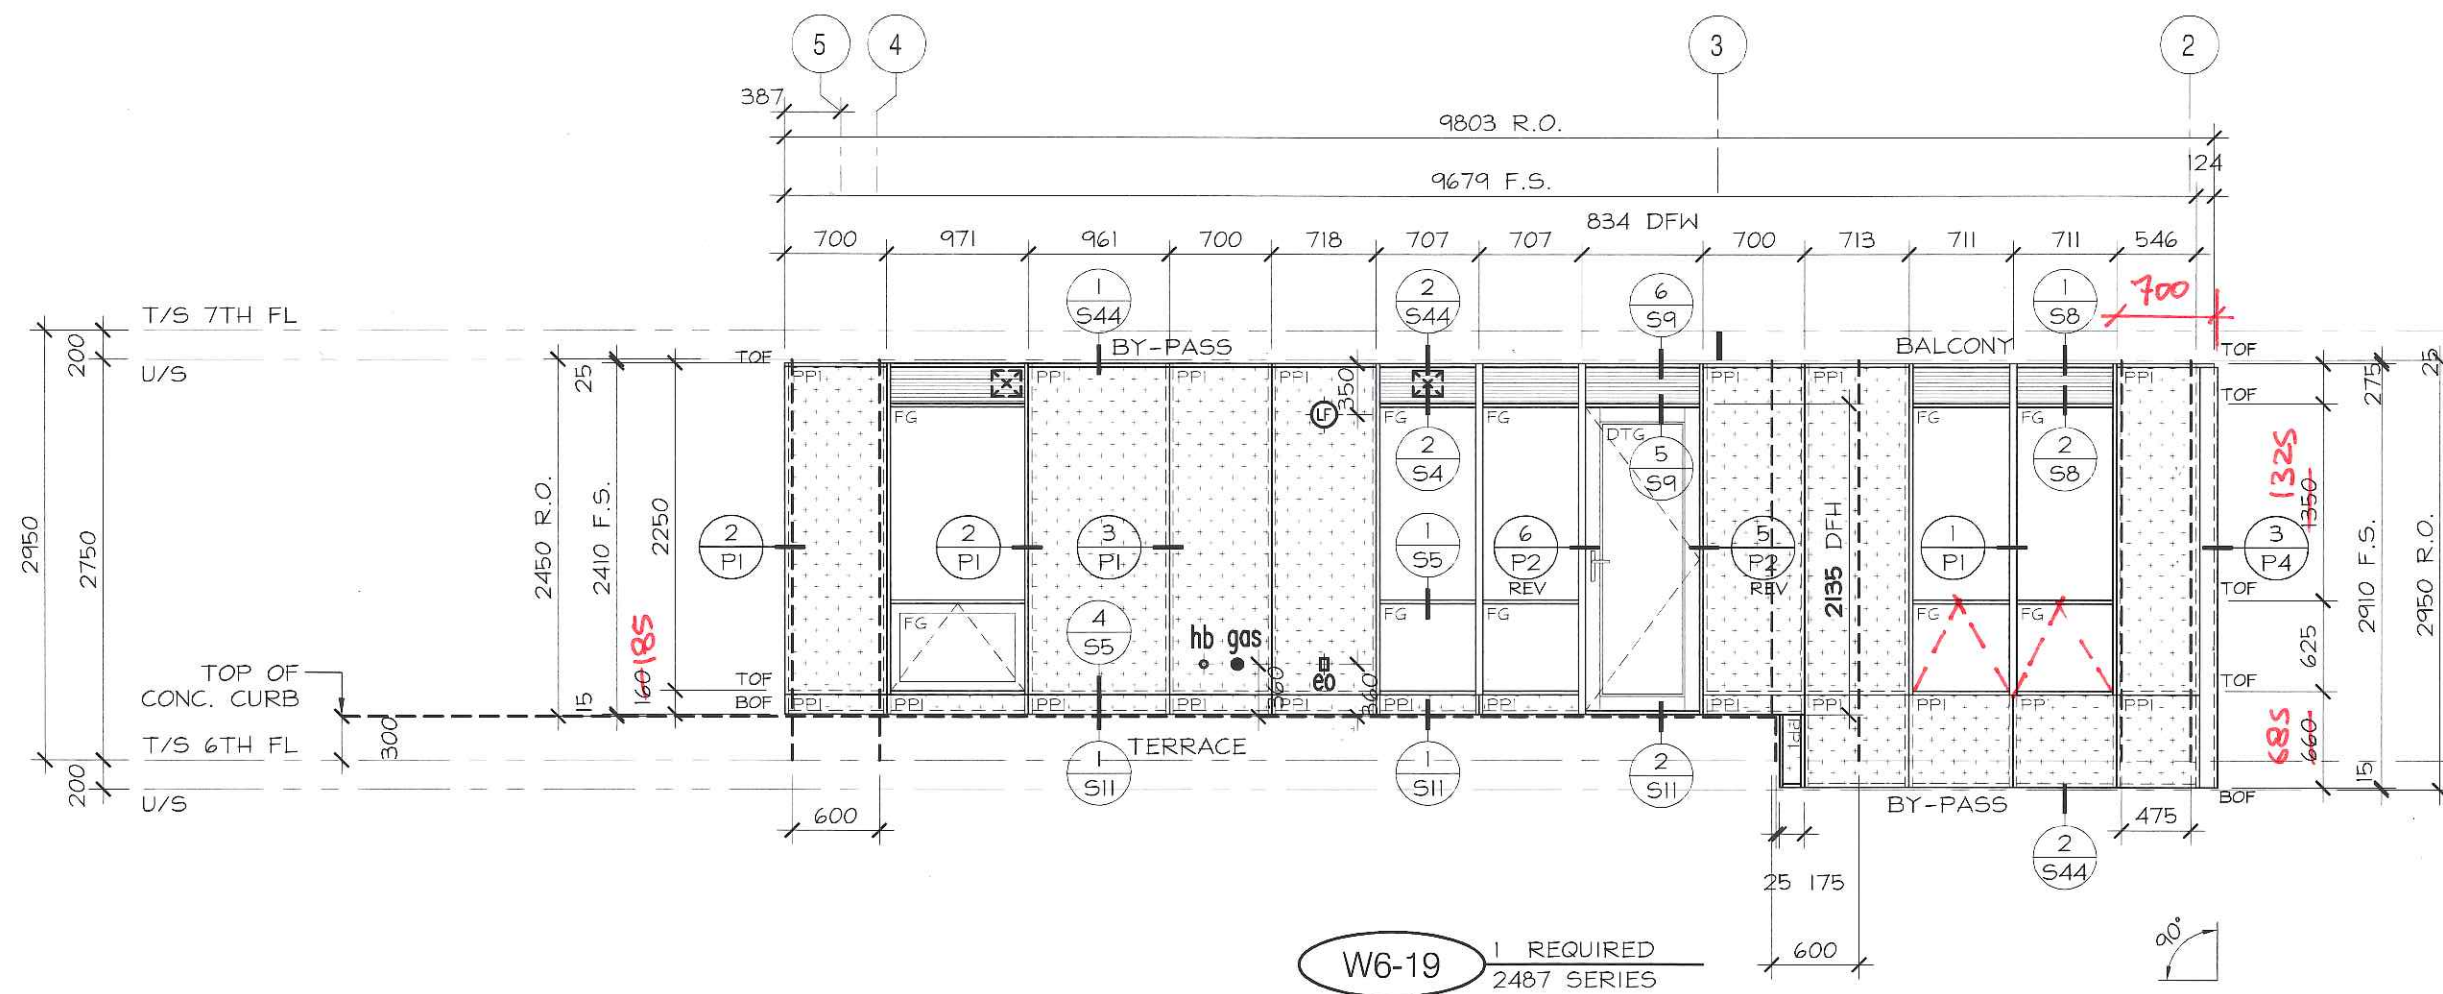

No.	REVISION	BY	DATE



PROJECT NAME:	SQ ALEXANDRA PARK - BLOCK11
DRAWING TITLE:	6th FLOOR ELEVATIONS
ARCHITECT:	TEEPLE ARCHITECTS
CONTRACTOR:	TRIDEL
SCALE:	1:50
DRAWN BY:	S.C.
DATE:	MARCH 4, 2015
DRAWING No.:	E6-17

The diagram shows a rectangular balcony labeled "BALCONY" and "B6-01". The width is dimensioned as "a" and the length as "b". On the left and right sides, there are "BY-PASS" labels. The fire protection details include "FPI" (Fire Protection Insulation) at the corners and along the walls, and "FPS" (Fire Protection System) in the center. The diagram also shows a dashed line indicating a boundary or partition.

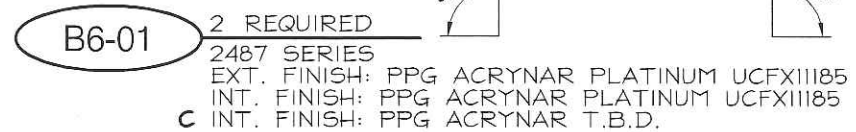

PROJECT NAME: SQ ALEXANDRA PARK - BLOCK11		DRAWING No.: E6-18
DRAWING TITLE: 6th FLOOR ELEVATIONS		
ARCHITECT: TEEPLE ARCHITECTS		
CONTRACTOR: TRIDEL		
SCALE: 1:50	DRAWN BY: S.C.	DATE: MARCH 4, 2015

FOR ALUMINUM BALCONY
& TERRACE RAILINGS
REFER TO TORO
ALUMINUM RAILING SHOP
DRAWINGS

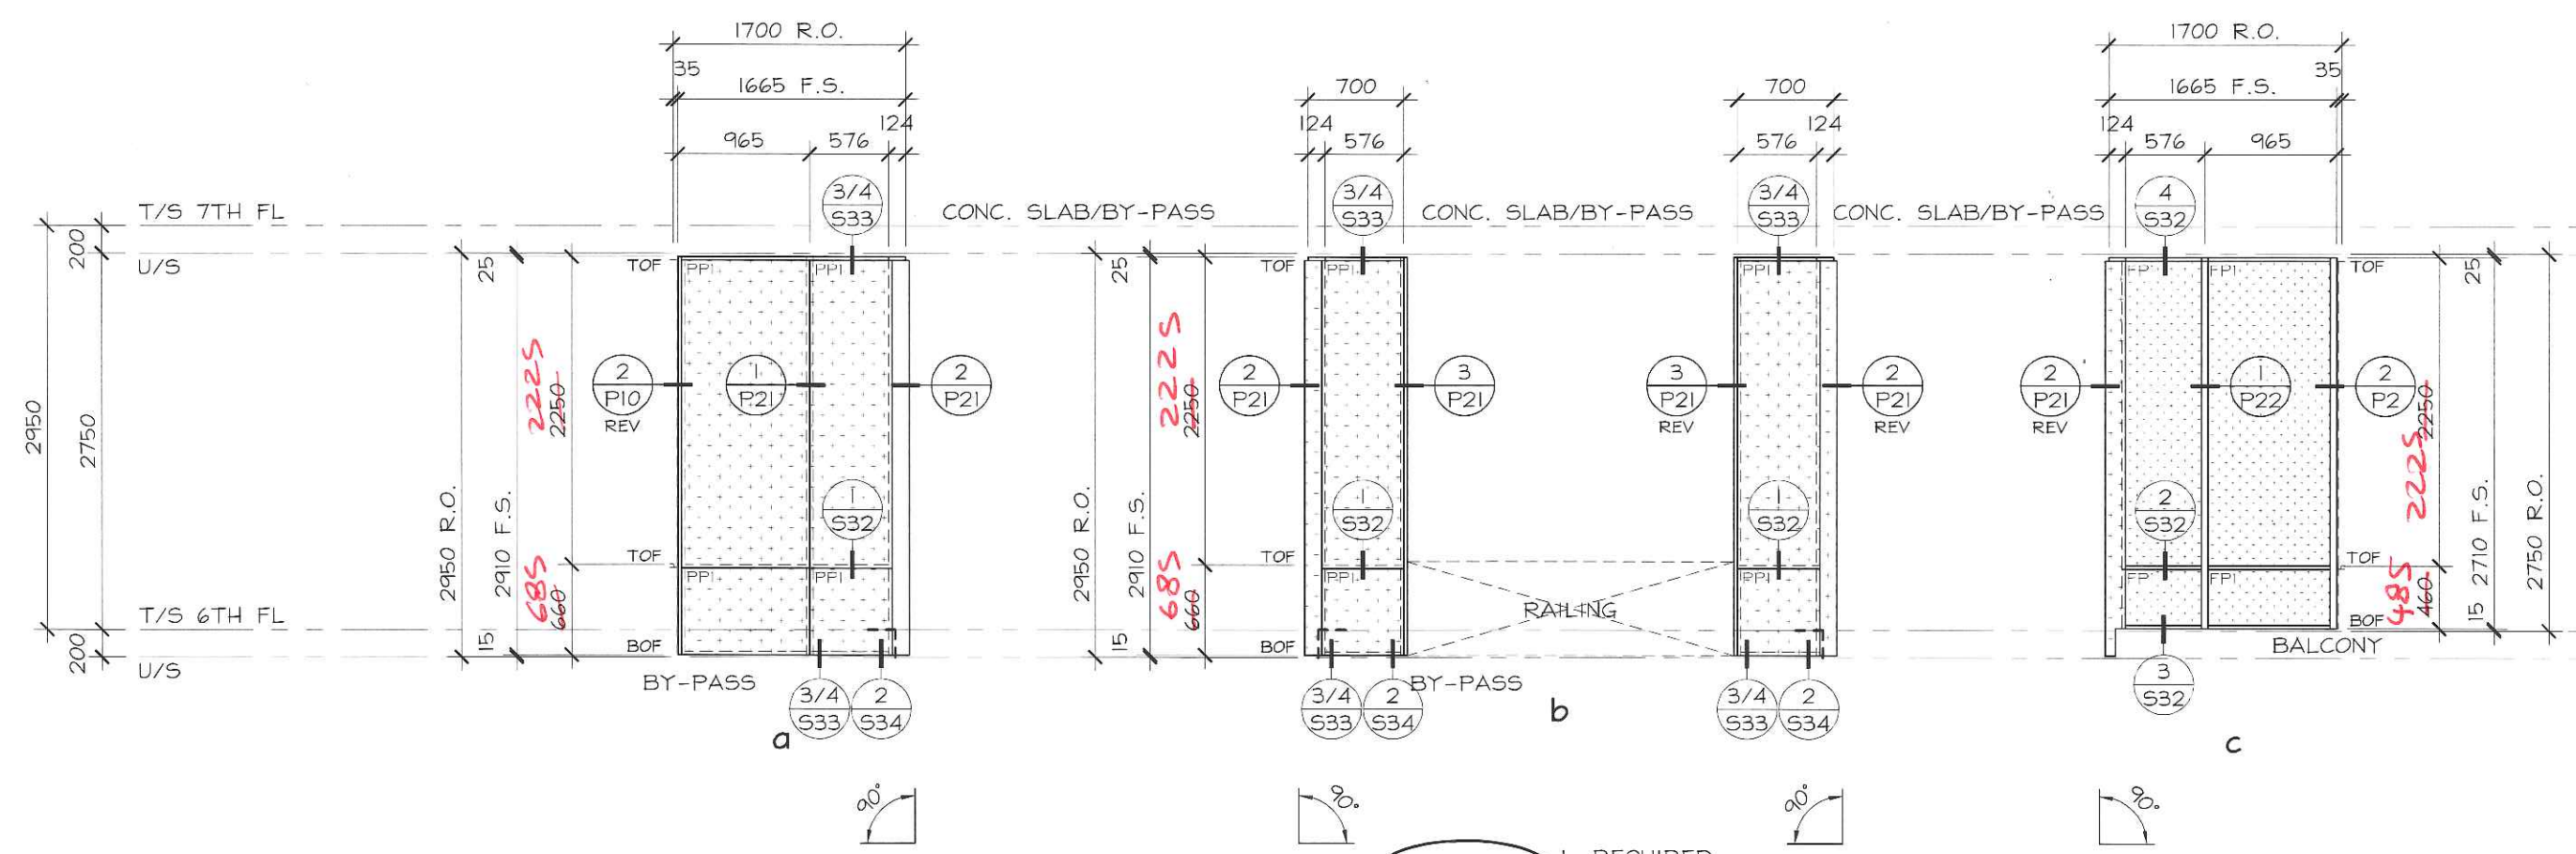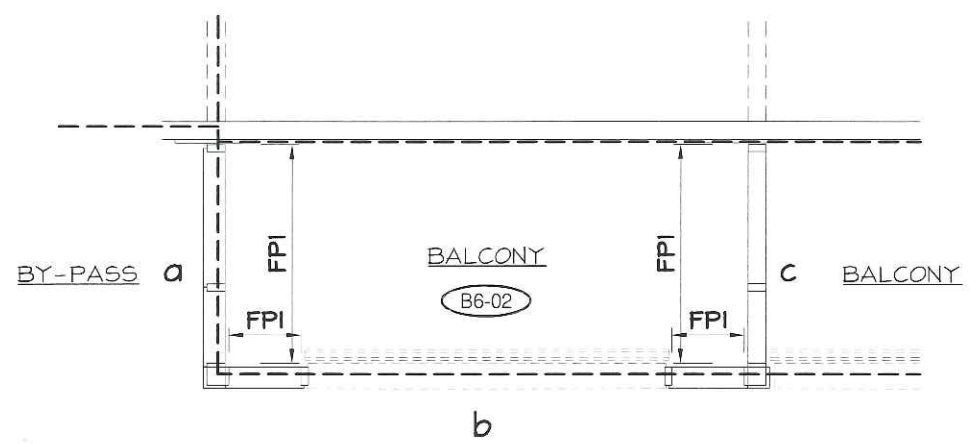

B6-02 1 REQUIRED
2487 SERIES
EXT. FINISH: PPG ACRYNAR PLATINUM UCFXIII85
INT. FINISH: PPG ACRYNAR PLATINUM UCFXIII85



TORO ALUMINUM
COMMERCIAL INDUSTRIAL RESIDENTIAL
330 APPLEWOOD CRESCENT TEL: (905) 738-5220
CONCORD, ON, CANADA FAX: (905) 738-5481
L4K 4V2 WWW.TOROALUMINUM.COM

06-27-15
D.T. PROHASKA
37549011
PROVINCE OF ONTARIO

No.	REVISION	BY	DATE

PROJECT NAME: SQ ALEXANDRA PARK - BLOCK11
DRAWING TITLE: 6th FLOOR ELEVATIONS
ARCHITECT: TEEPLE ARCHITECTS
CONTRACTOR: TRIDEL
SCALE: 1:50
DRAWN BY: S.C.
DATE: MARCH 4, 2015
DRAWING No.: E6-19

FOR ALUMINUM BALCONY
& TERRACE RAILINGS
REFER TO TORO
ALUMINUM RAILING SHOP
DRAWINGS

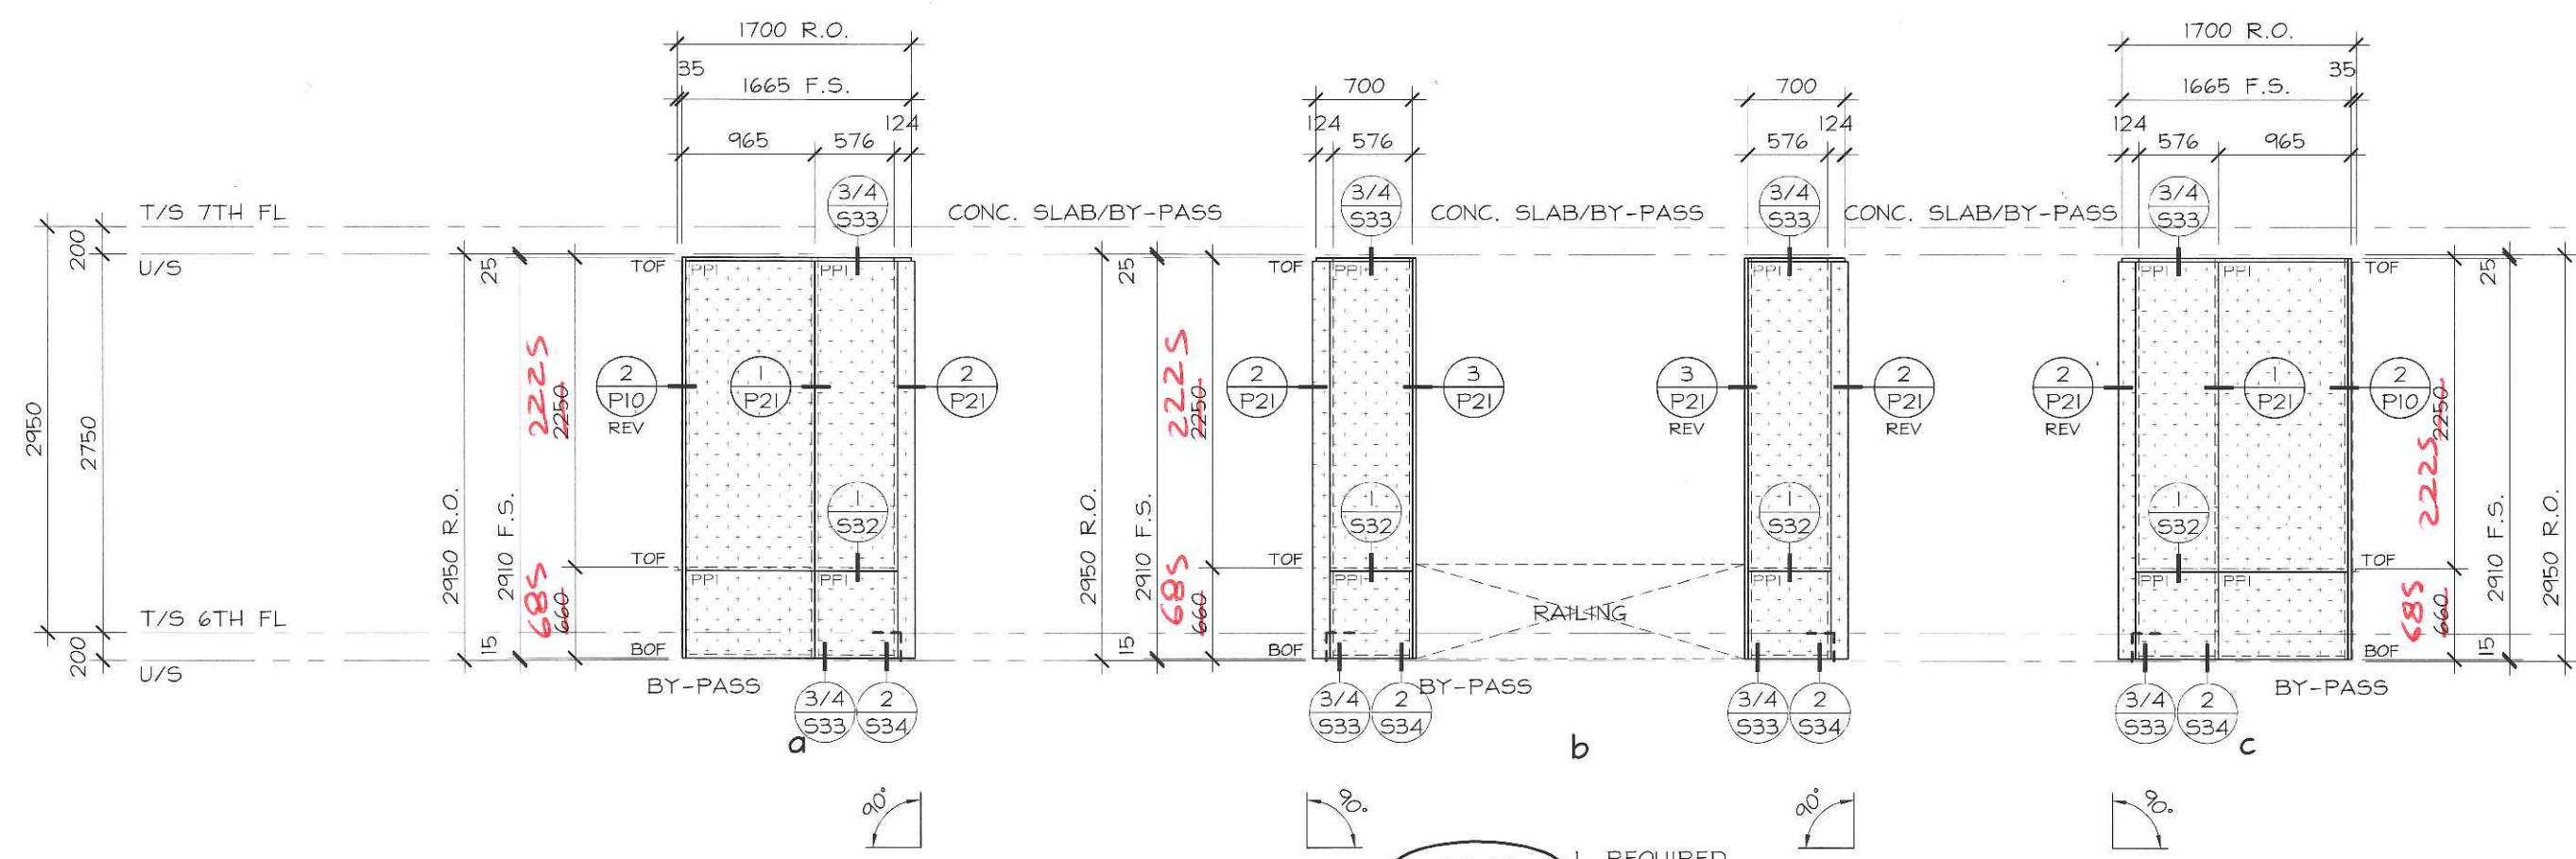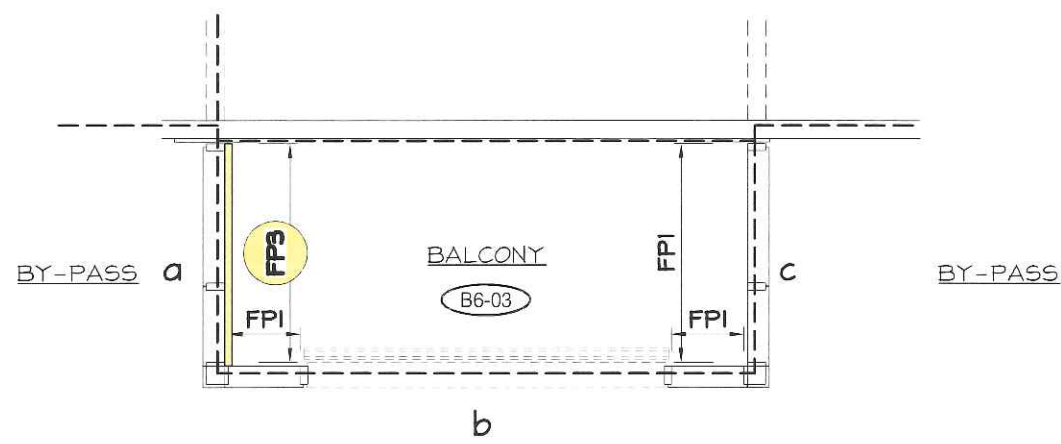



B6-03 1 REQUIRED
2487 SERIES
EXT. FINISH: PPG ACRYNAR PLATINUM UCFXIII85
INT. FINISH: PPG ACRYNAR PLATINUM UCFXIII85
a INT. FINISH: PPG ACRYNAR T.B.D.

TORO ALUMINUM
COMMERCIAL INDUSTRIAL RESIDENTIAL
330 APPLEWOOD CRESCENT TEL: (905) 738-5220
CONCORD, ON, CANADA FAX: (905) 738-5481
L4K 4V2 WWW.TOROALUMINUM.COM

LICENSED PROFESSIONAL ENGINEER
06-27-15
D.T. PROHASKA
37549014
PROVINCE OF ONTARIO

No.	REVISION	BY	DATE

PROJECT NAME: **SQ ALEXANDRA PARK - BLOCK11**
DRAWING TITLE: **6th FLOOR ELEVATIONS**
ARCHITECT: **TEEPLE ARCHITECTS**
CONTRACTOR: **TRIDEL**
SCALE: 1:50 DRAWN BY: **S.C.** DATE: **MARCH 4, 2015**
DRAWING No.: **E6-20**

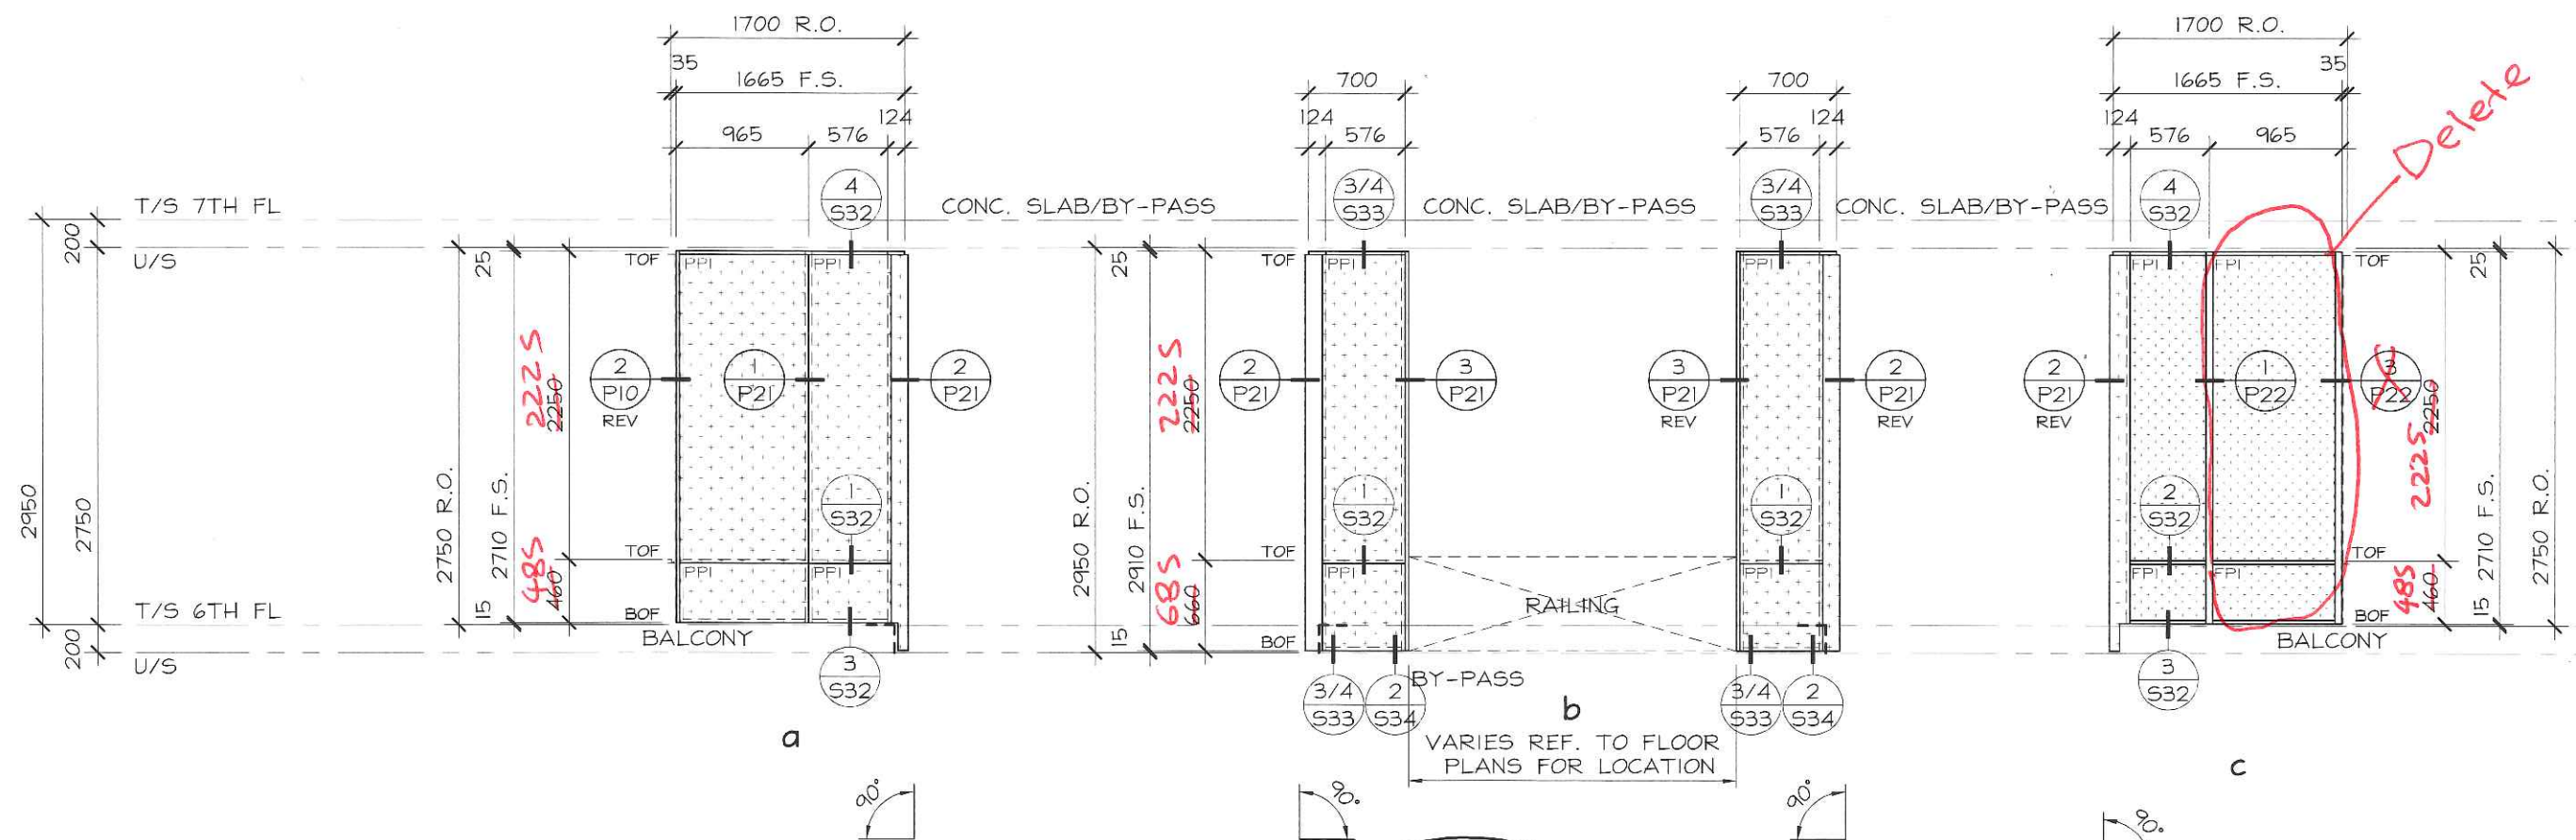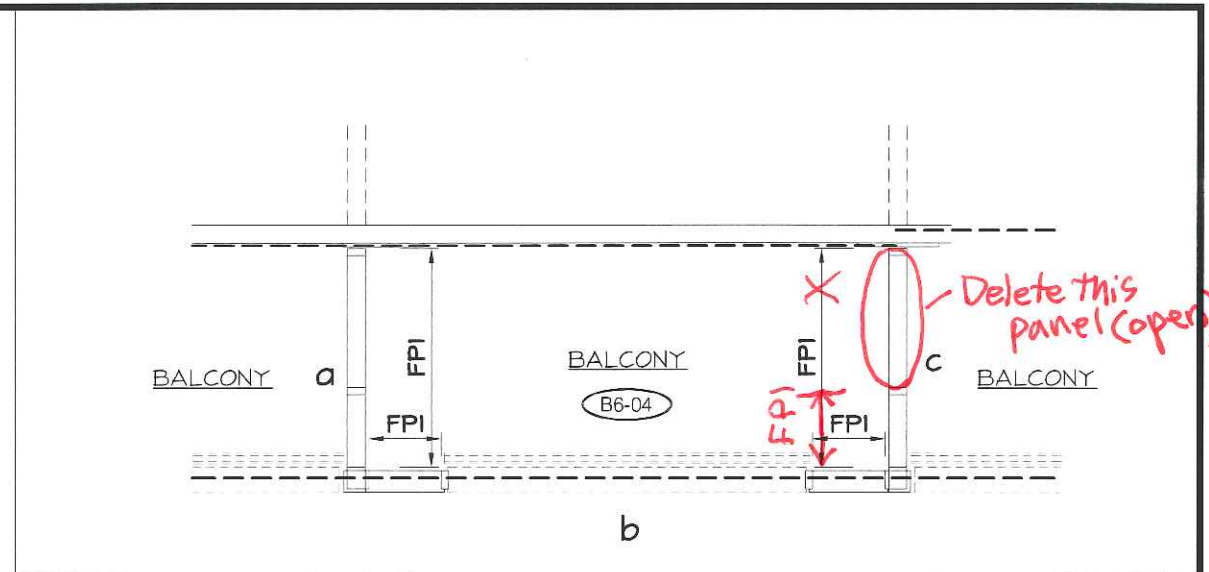

B6-04

1 REQUIRED

2487 SERIES

EXT. FINISH: PPG ACRYNAR PLATINUM UCFXIII85

INT. FINISH: PPG ACRYNAR PLATINUM UCFXIII85



No.	REVISION	BY	DATE

PROJECT NAME: SQ ALEXANDRA PARK - BLOCK11

DRAWING TITLE: 6th FLOOR ELEVATIONS

ARCHITECT: TEEPLE ARCHITECTS

CONTRACTOR: TRIDEL

SCALE: 1:50



DRAWN BY: S.C.

DATE: MARCH 4, 2015

DRAWING No.:

E6-21

FOR ALUMINUM BALCONY
& TERRACE RAILINGS
REFER TO TORO
ALUMINUM RAILING SHOP
DRAWINGS

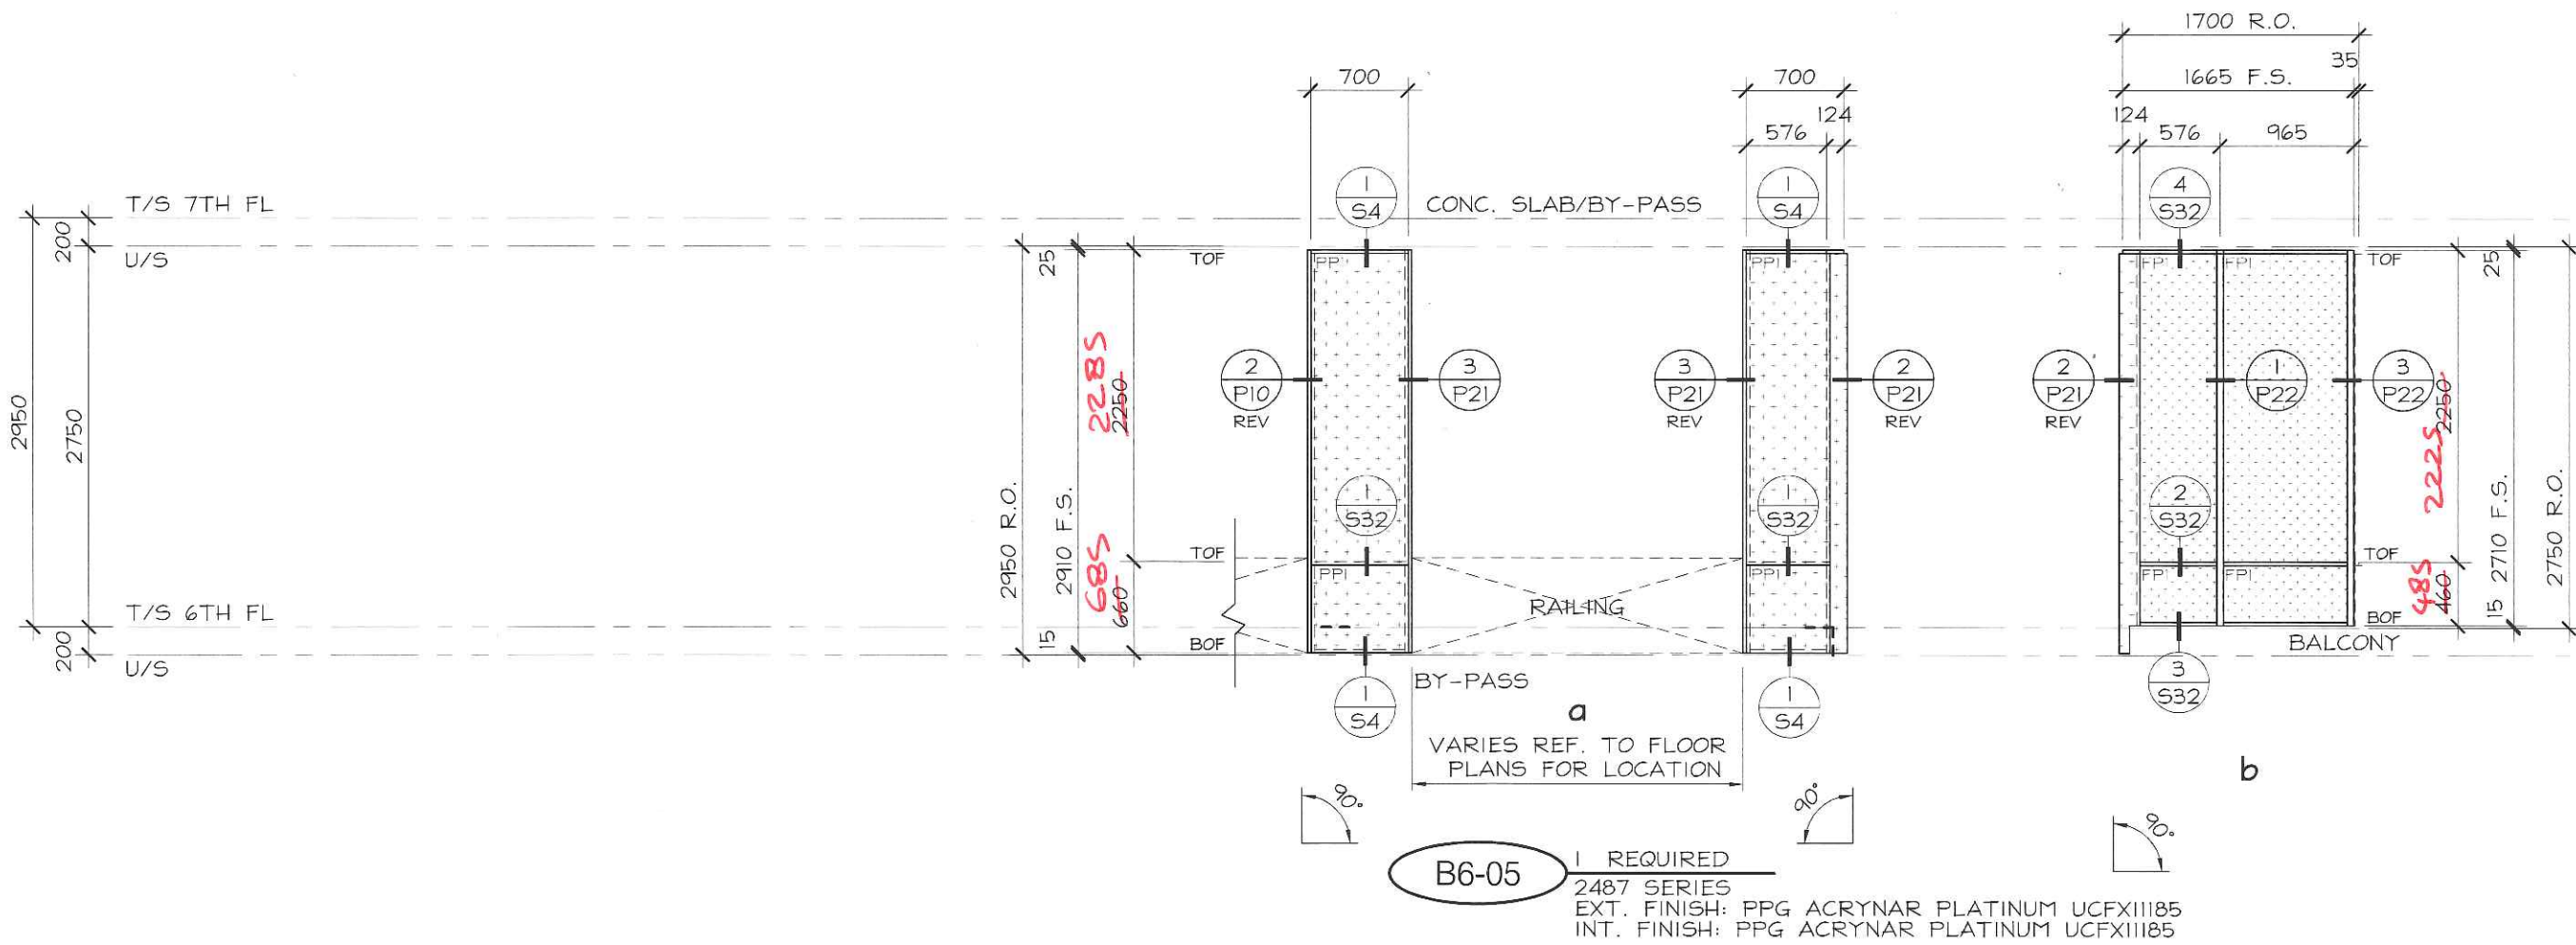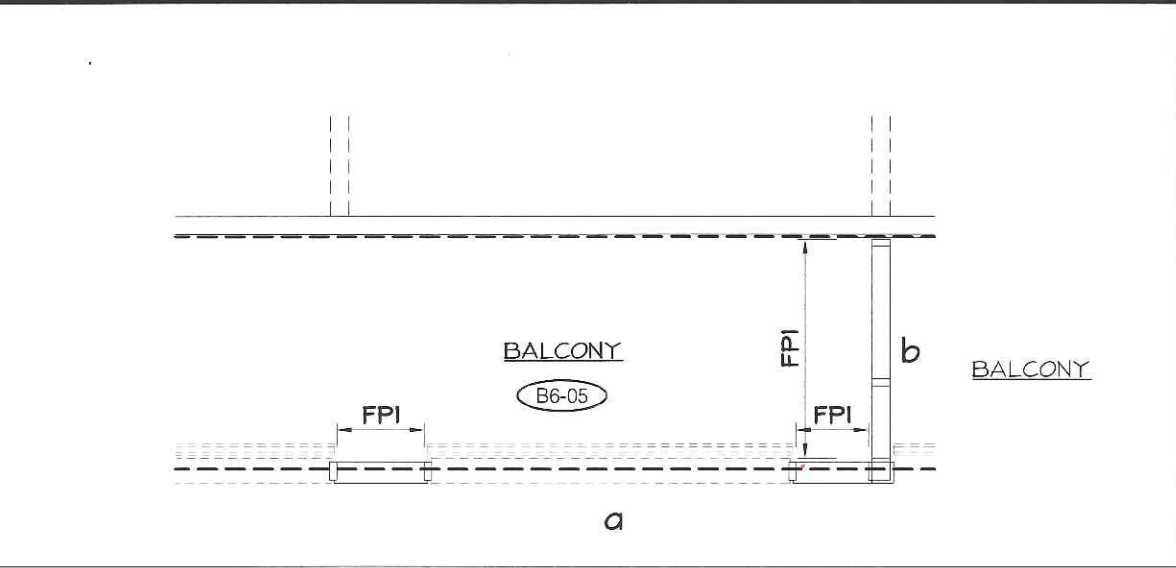

B6-05 1 REQUIRED
2487 SERIES
EXT. FINISH: PPG ACRYNAR PLATINUM UCFX11185
INT. FINISH: PPG ACRYNAR PLATINUM UCFX11185

TORO ALUMINUM
COMMERCIAL INDUSTRIAL RESIDENTIAL
330 APPLEWOOD CRESCENT TEL: (905) 738-5220
CONCORD, ON, CANADA FAX: (905) 738-5481
L4K 4V2 WWW.TOROALUMINUM.COM


LICENSED PROFESSIONAL ENGINEER
06-27-15
D.T. PROHASKA
3754901
PROVINCE OF ONTARIO

No.	REVISION	BY	DATE


PROJECT NAME:	SQ ALEXANDRA PARK - BLOCK11
DRAWING TITLE:	6th FLOOR ELEVATIONS
ARCHITECT:	TEEPLE ARCHITECTS
CONTRACTOR:	TRIDEL
SCALE:	1:50
DRAWN BY:	S.C.
DATE:	MARCH 4, 2015

DRAWING No.:
E6-22

FOR ALUMINUM BALCONY
& TERRACE RAILINGS
REFER TO TORO
ALUMINUM RAILING SHOP
DRAWINGS

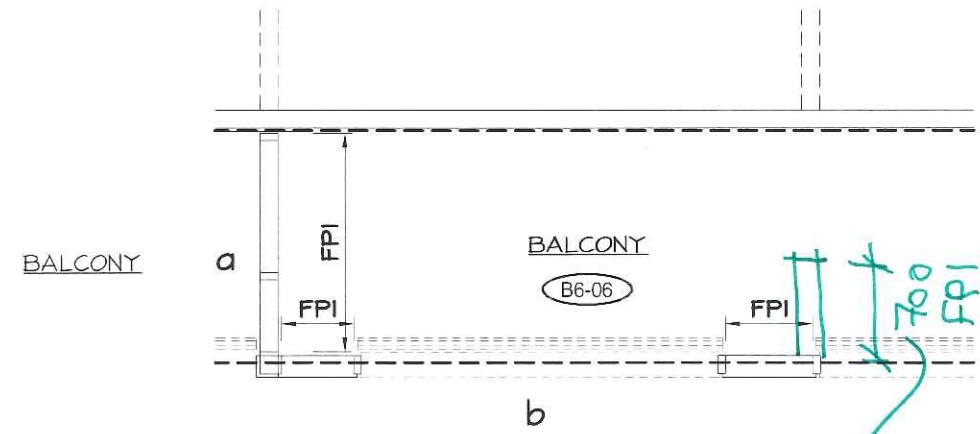

same C Panel
@ B6-04
Dwg. No. E6-21

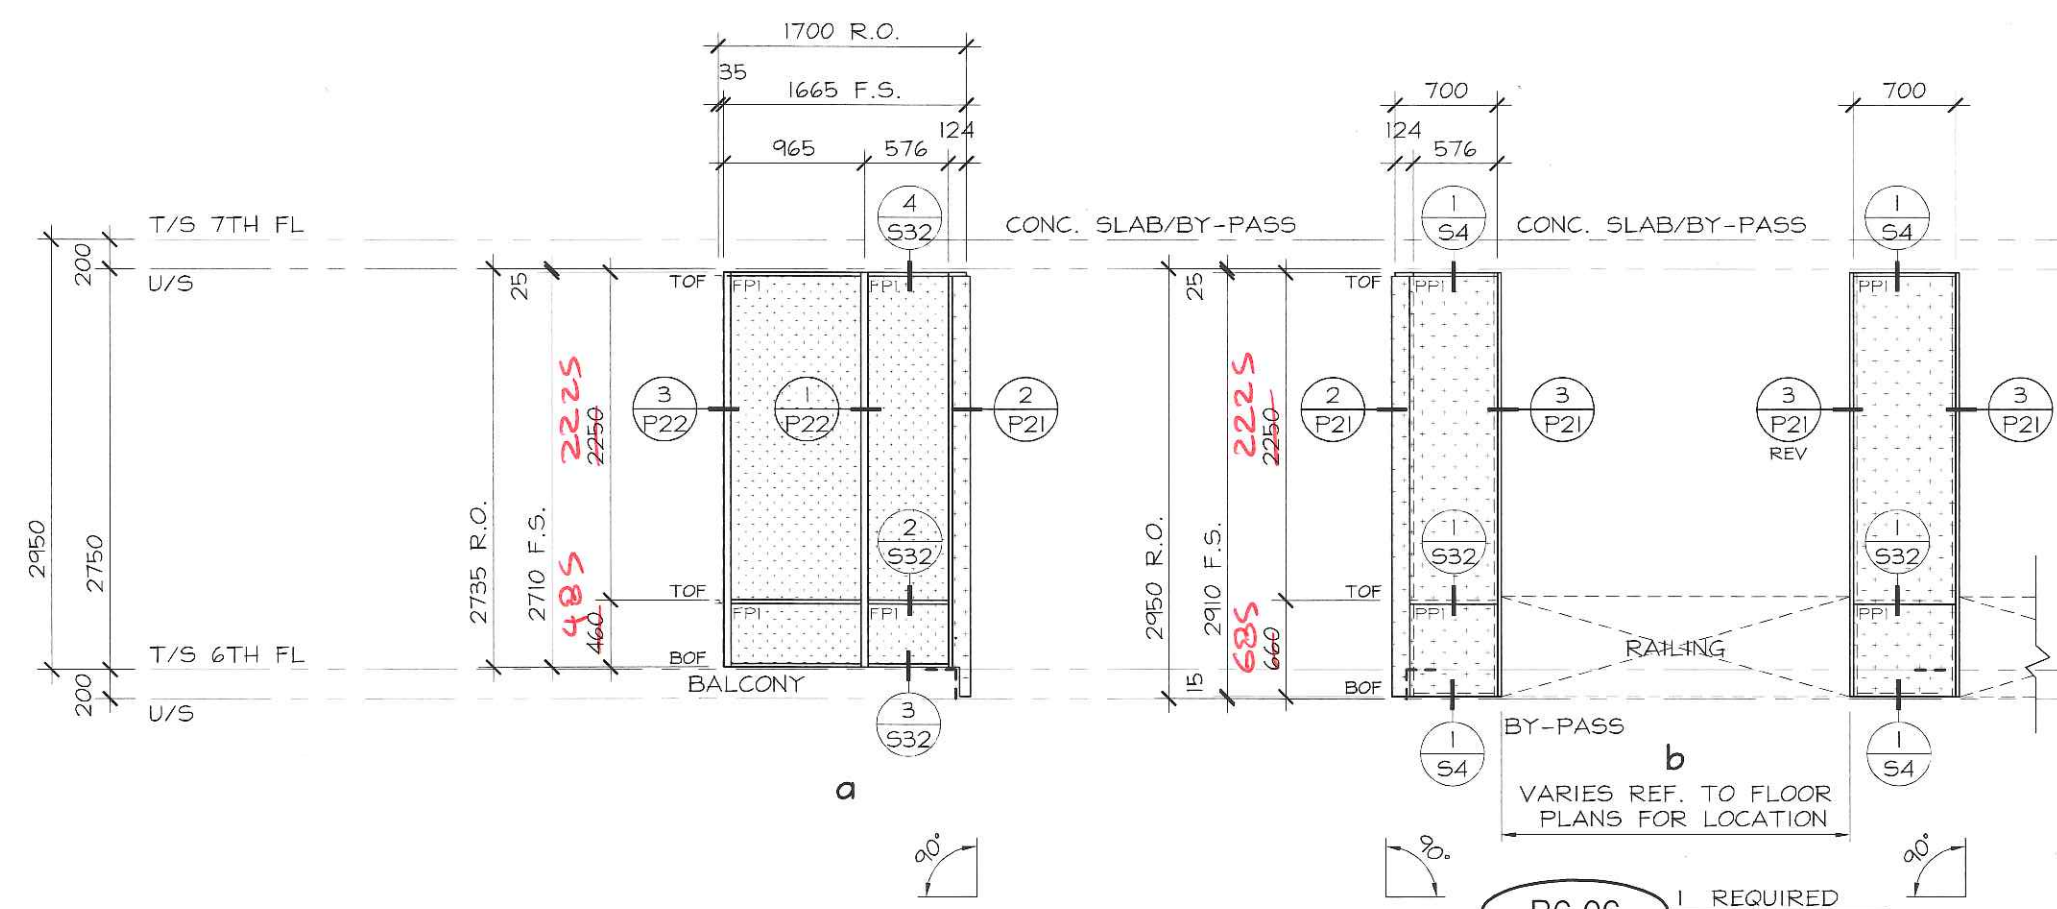

B6-06 1 REQUIRED
2487 SERIES
EXT. FINISH: PPG ACRYNAR PLATINUM UCFX11185
INT. FINISH: PPG ACRYNAR PLATINUM UCFX11185

TORO ALUMINUM
COMMERCIAL INDUSTRIAL RESIDENTIAL
330 APPLEWOOD CRESCENT TEL: (905) 738-5220
CONCORD, ON, CANADA FAX: (905) 738-5481
L4K 4V2 WWW.TOROALUMINUM.COM

LICENSED PROFESSIONAL ENGINEER
06-27-15
D.T. PROHASKA
37549017
PROVINCE OF ONTARIO

No.	REVISION	BY	DATE

PROJECT NAME:	SQ ALEXANDRA PARK - BLOCK11
DRAWING TITLE:	6th FLOOR ELEVATIONS
ARCHITECT:	TEEPLE ARCHITECTS
CONTRACTOR:	TRIDEL
SCALE:	1:50
DRAWN BY:	S.C.
DATE:	MARCH 4, 2015

DRAWING No.:
E6-23