




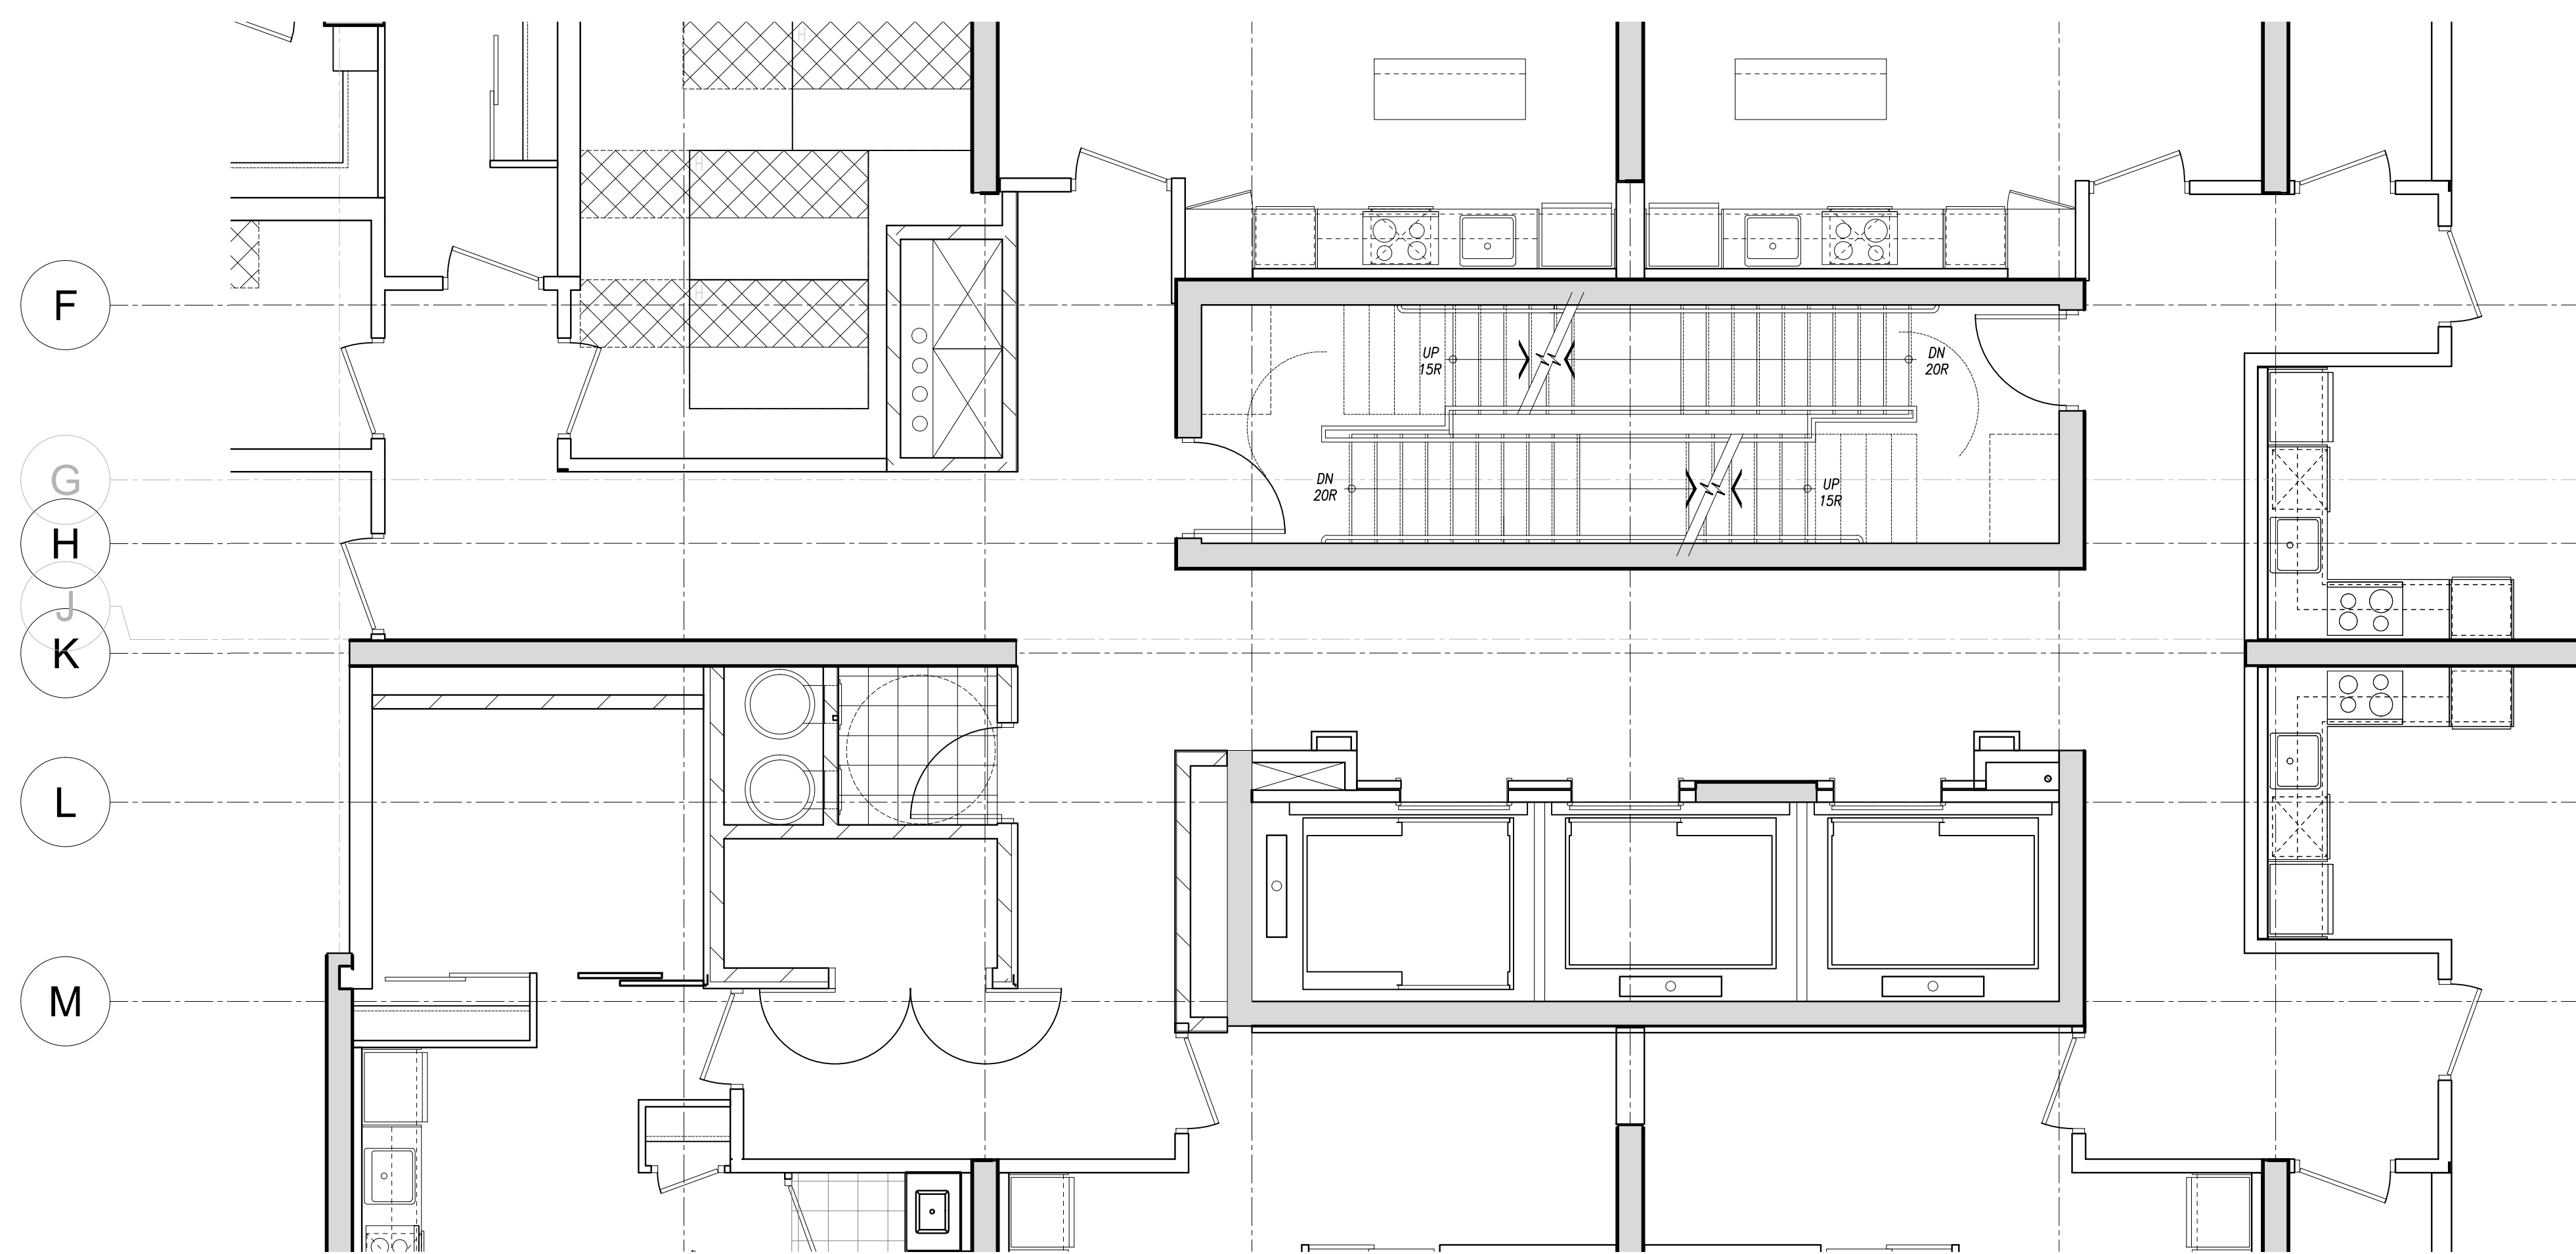


3 3rd FLOOR CORRIDOR FINISHES & POWER PLAN (BUILDING-D)
ID3.3 SCALE= 1:50

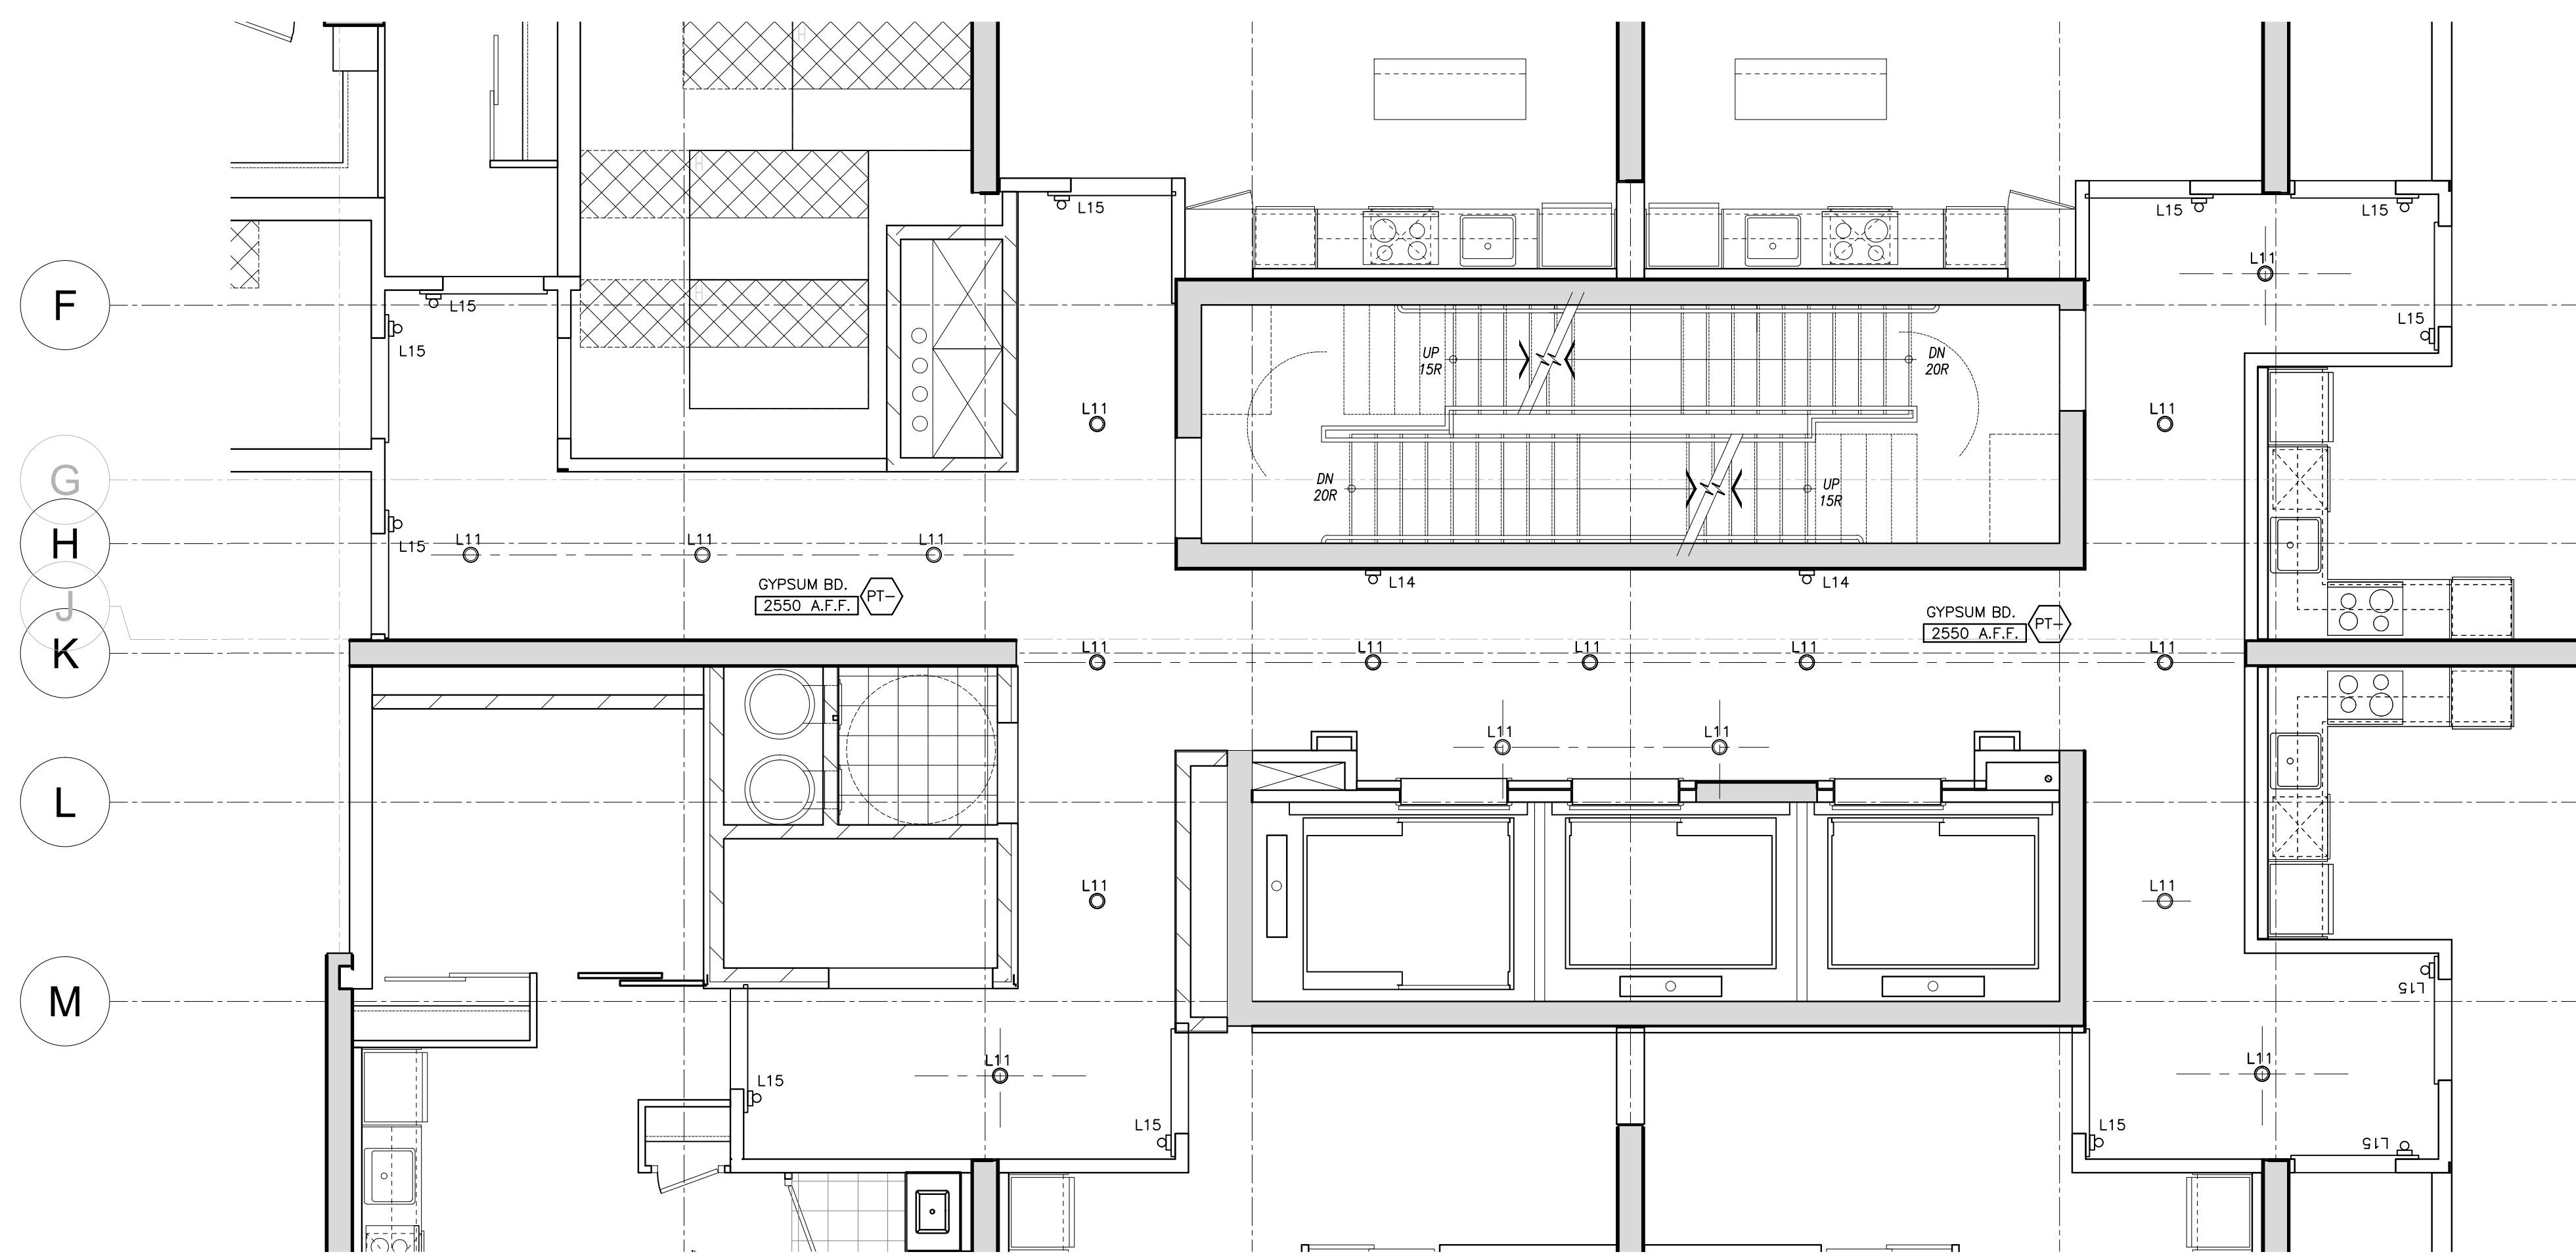

4 3rd FLOOR CORRIDOR RCP (BUILDING-D)
ID3.3 SCALE= 1:50

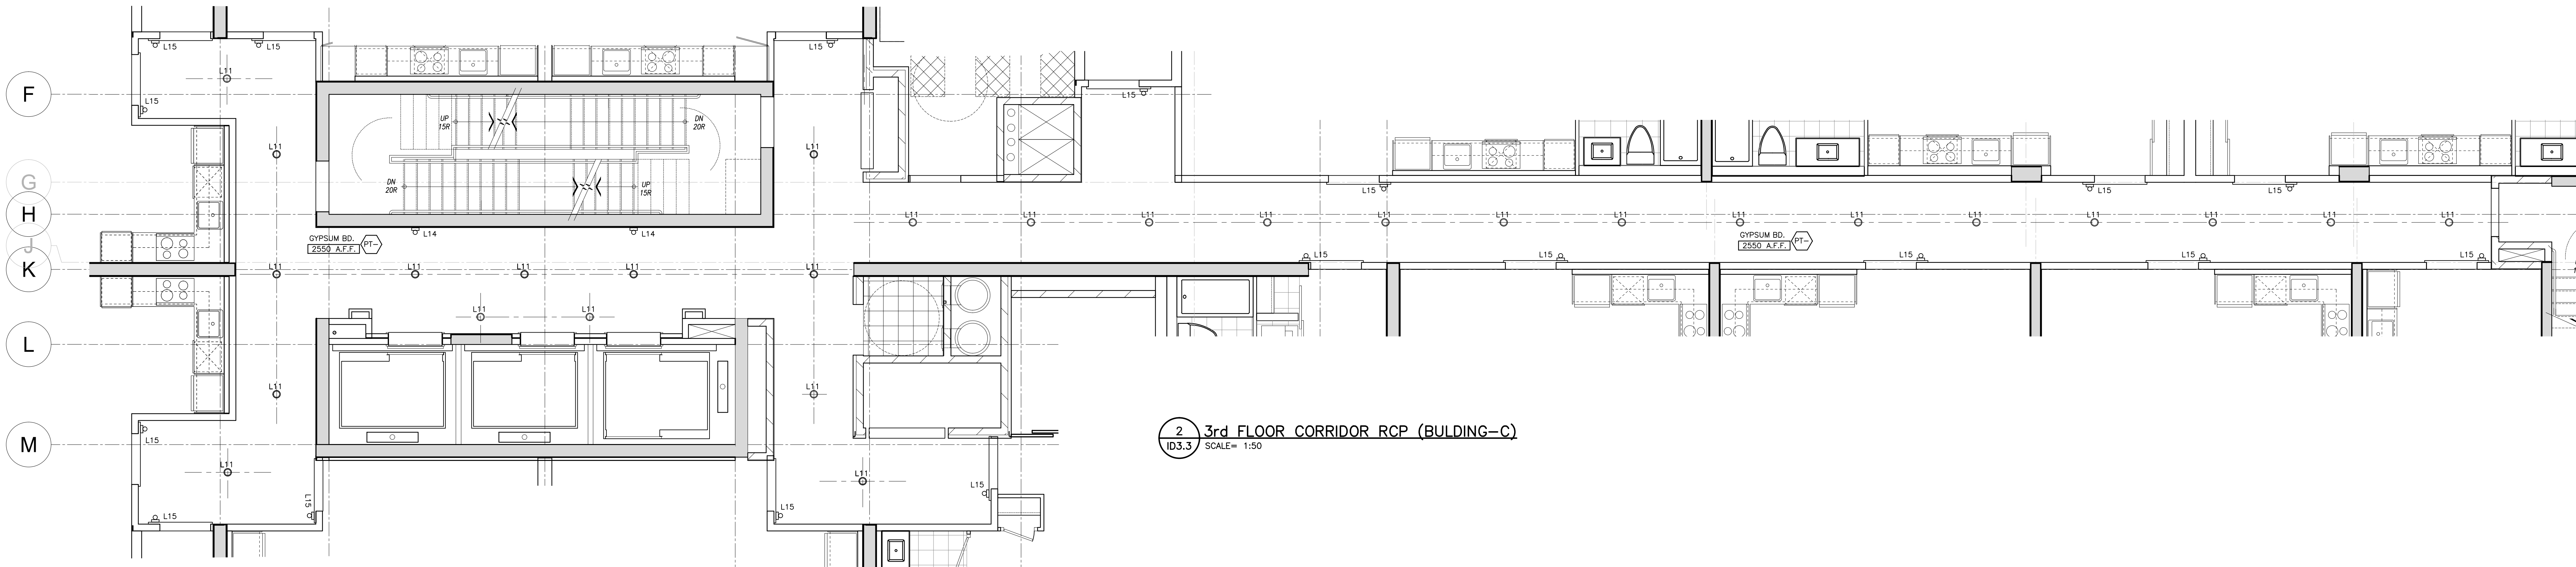

2 3rd FLOOR CORRIDOR RCP (BUILDING-C)
ID3.3 SCALE= 1:50

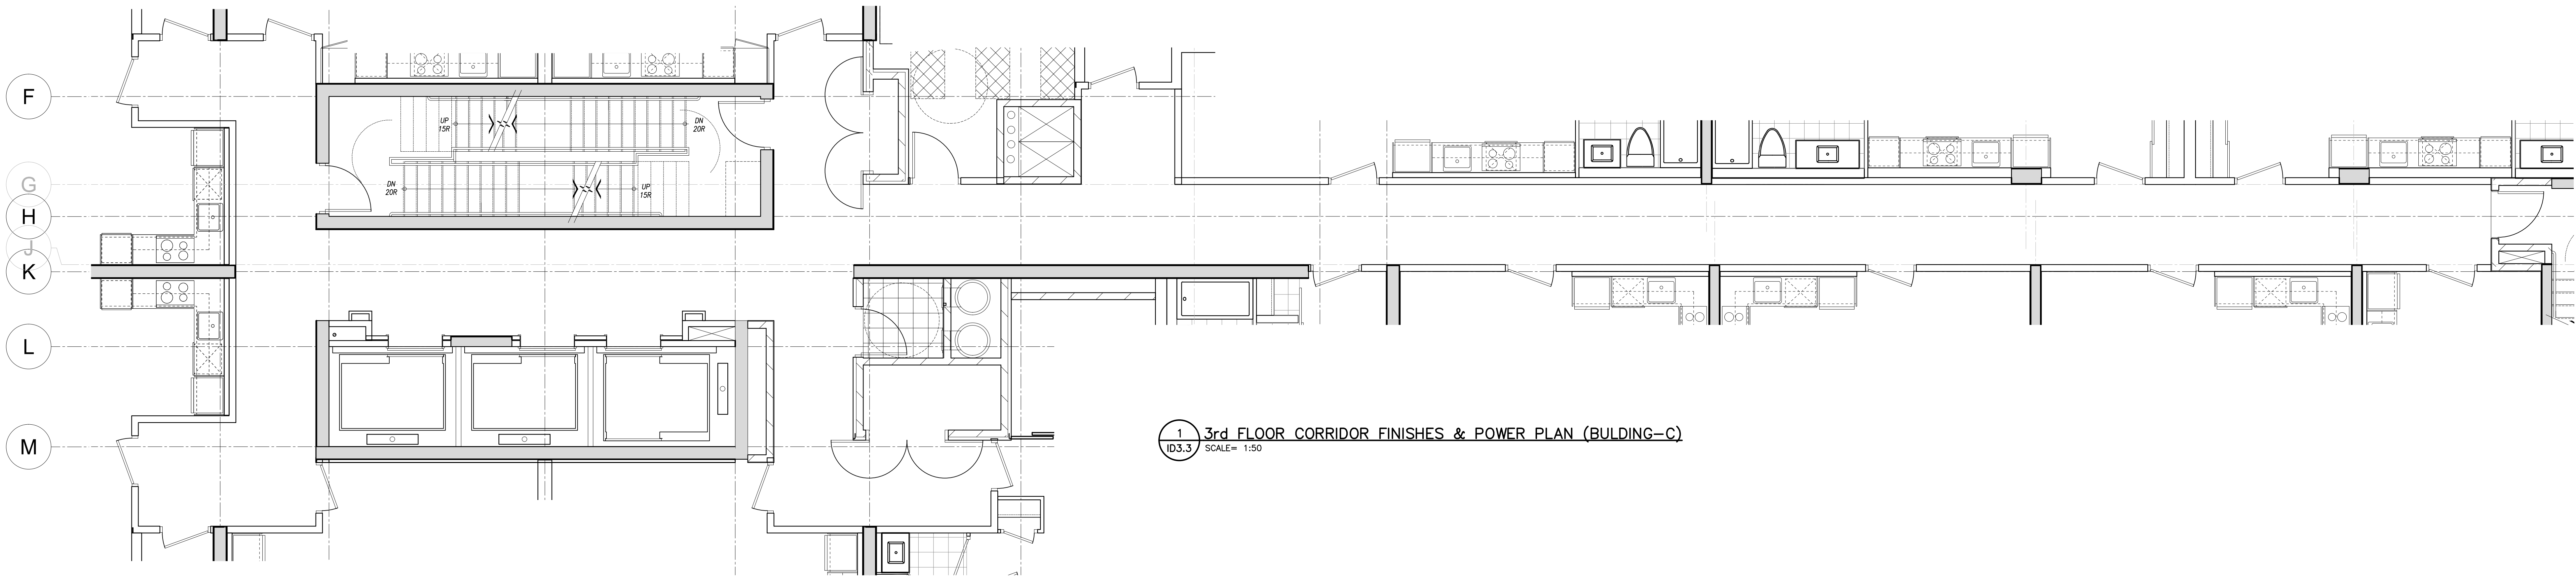

1 3rd FLOOR CORRIDOR FINISHES & POWER PLAN (BUILDING-C)
ID3.3 SCALE= 1:50

ml

munge // leung

171 East Liberty Street, Suite 290
Toronto, ON, Canada, M6K 3P6
Tel: 416.588.1668
Fax: 416.588.3393
www.mungeleung.com
e-mail> studio@mungeleung.com

Contractor must check and verify
all job dimensions, drawings,
details and specifications; and
report any discrepancies to
designer before proceeding with
work.

Drawing
Title


3rd FLOOR
CORRIDOR PLANS

Project
K&G DEVELOPMENT GROUP
TRIDEL

ARISTO at AVONSHIRE

120 & 130 HARRISON GARDEN BLVD.
NORTH YORK, ONTARIO

Scale
1:50
Date
AUGUST 2011
Drawn by
10126
Project No.
Drawing No.

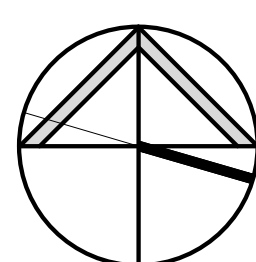

ID3.3