




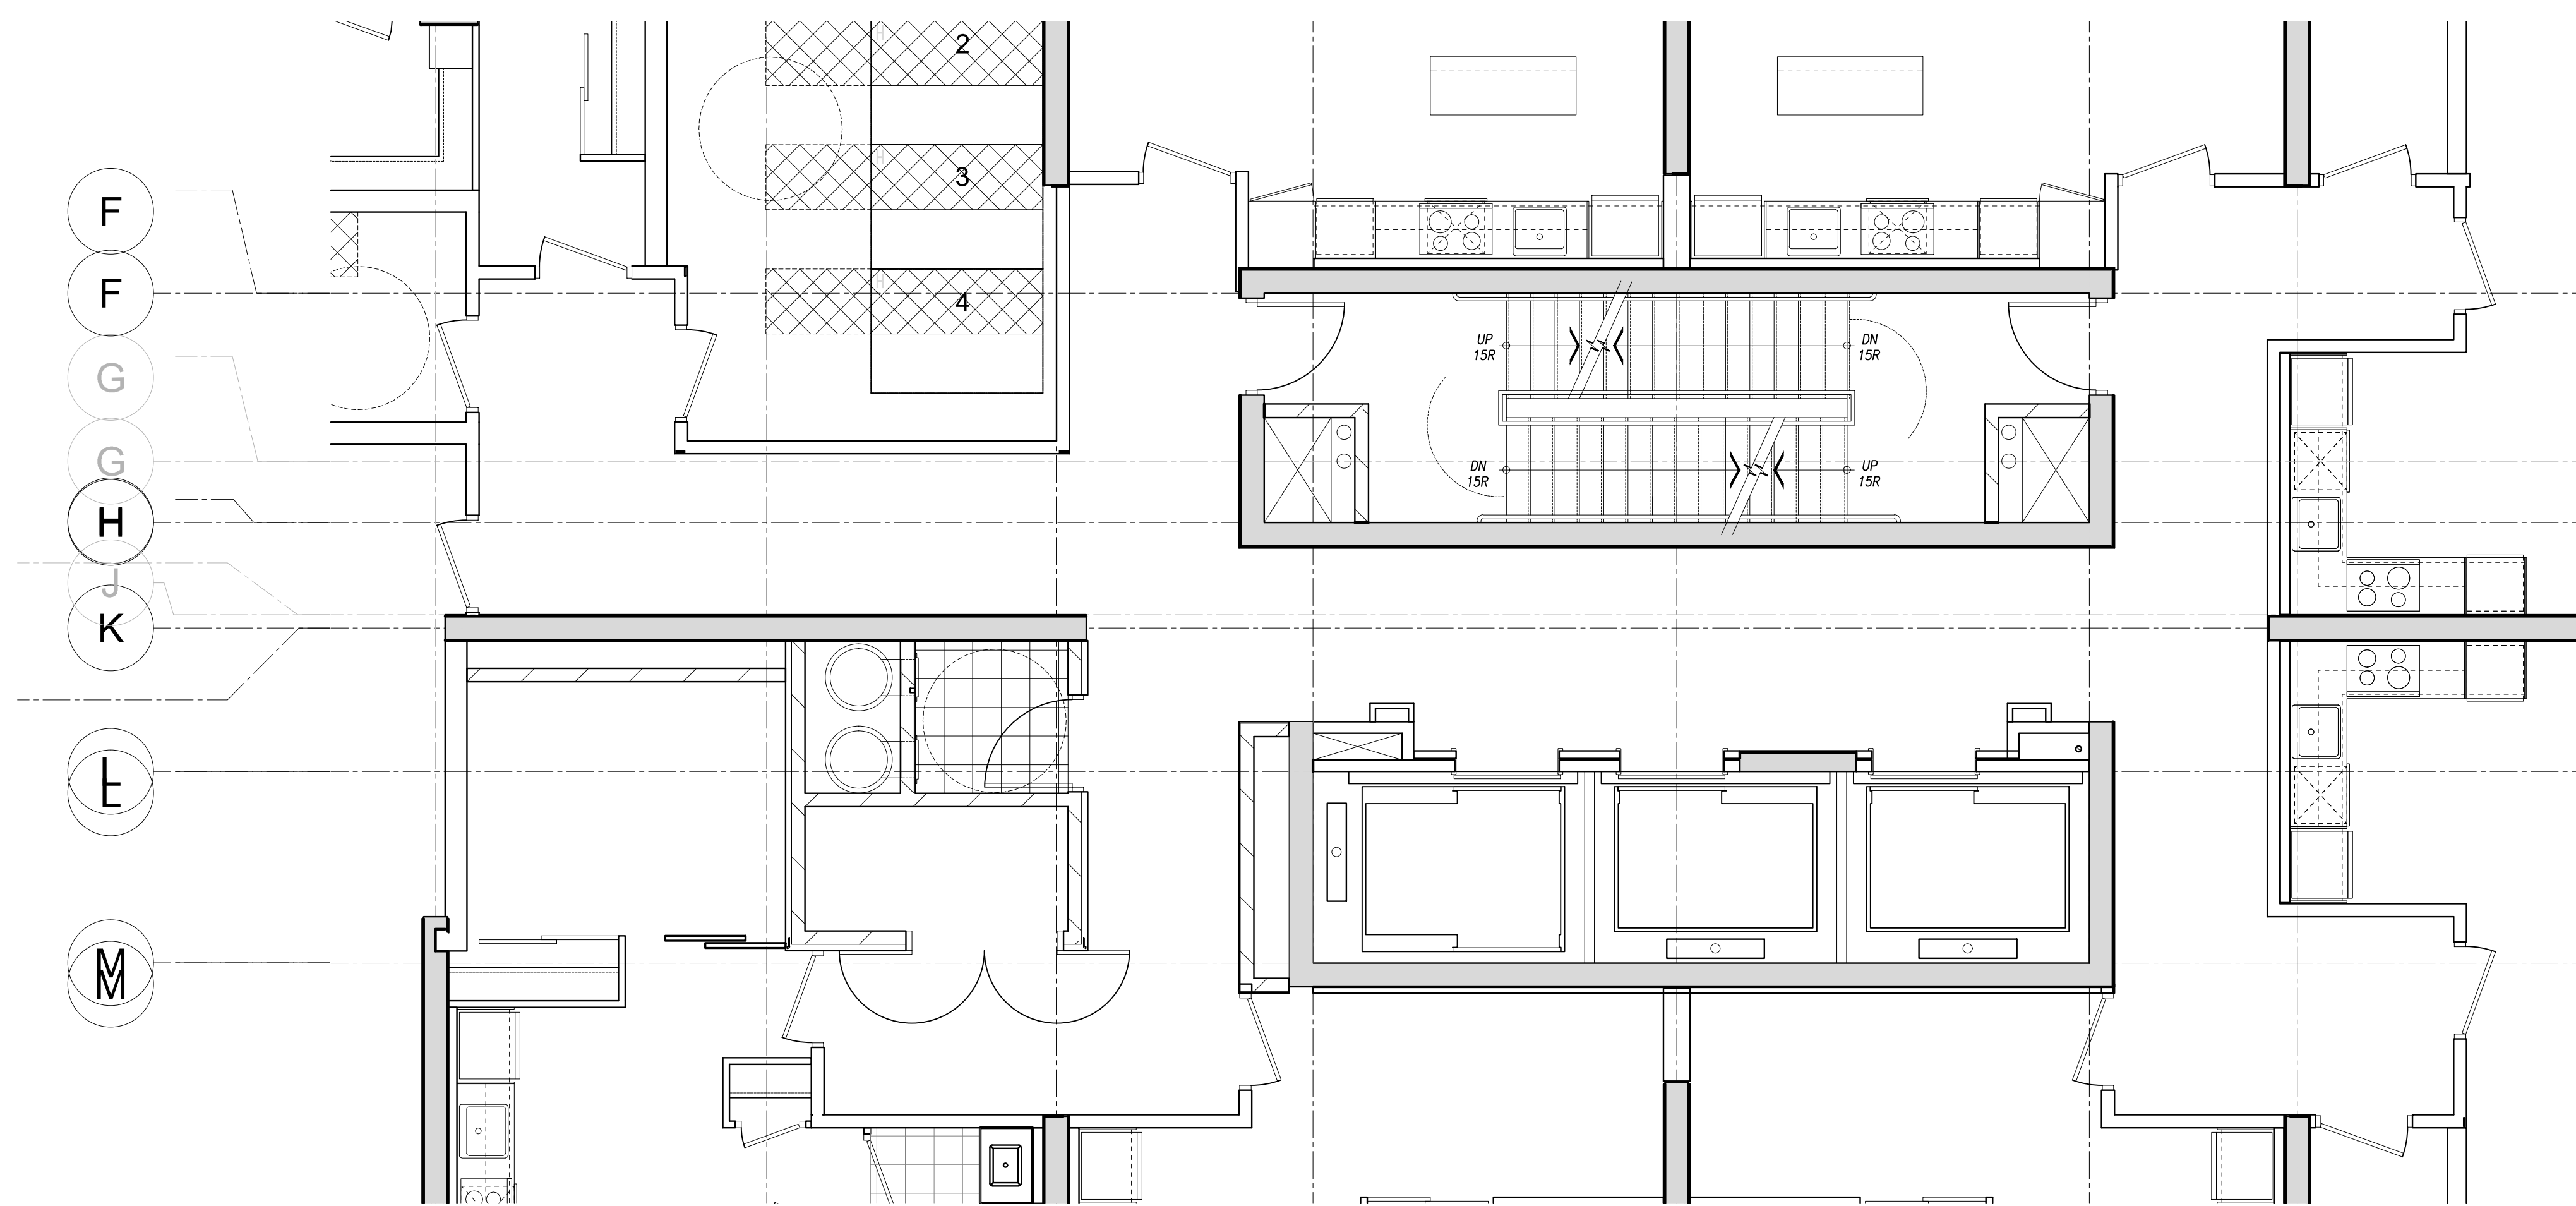


3 4th TO 7th FLOOR CORRIDOR FINISHES & POWER PLAN (BUILDING-D)
ID3.4 SCALE= 1:50

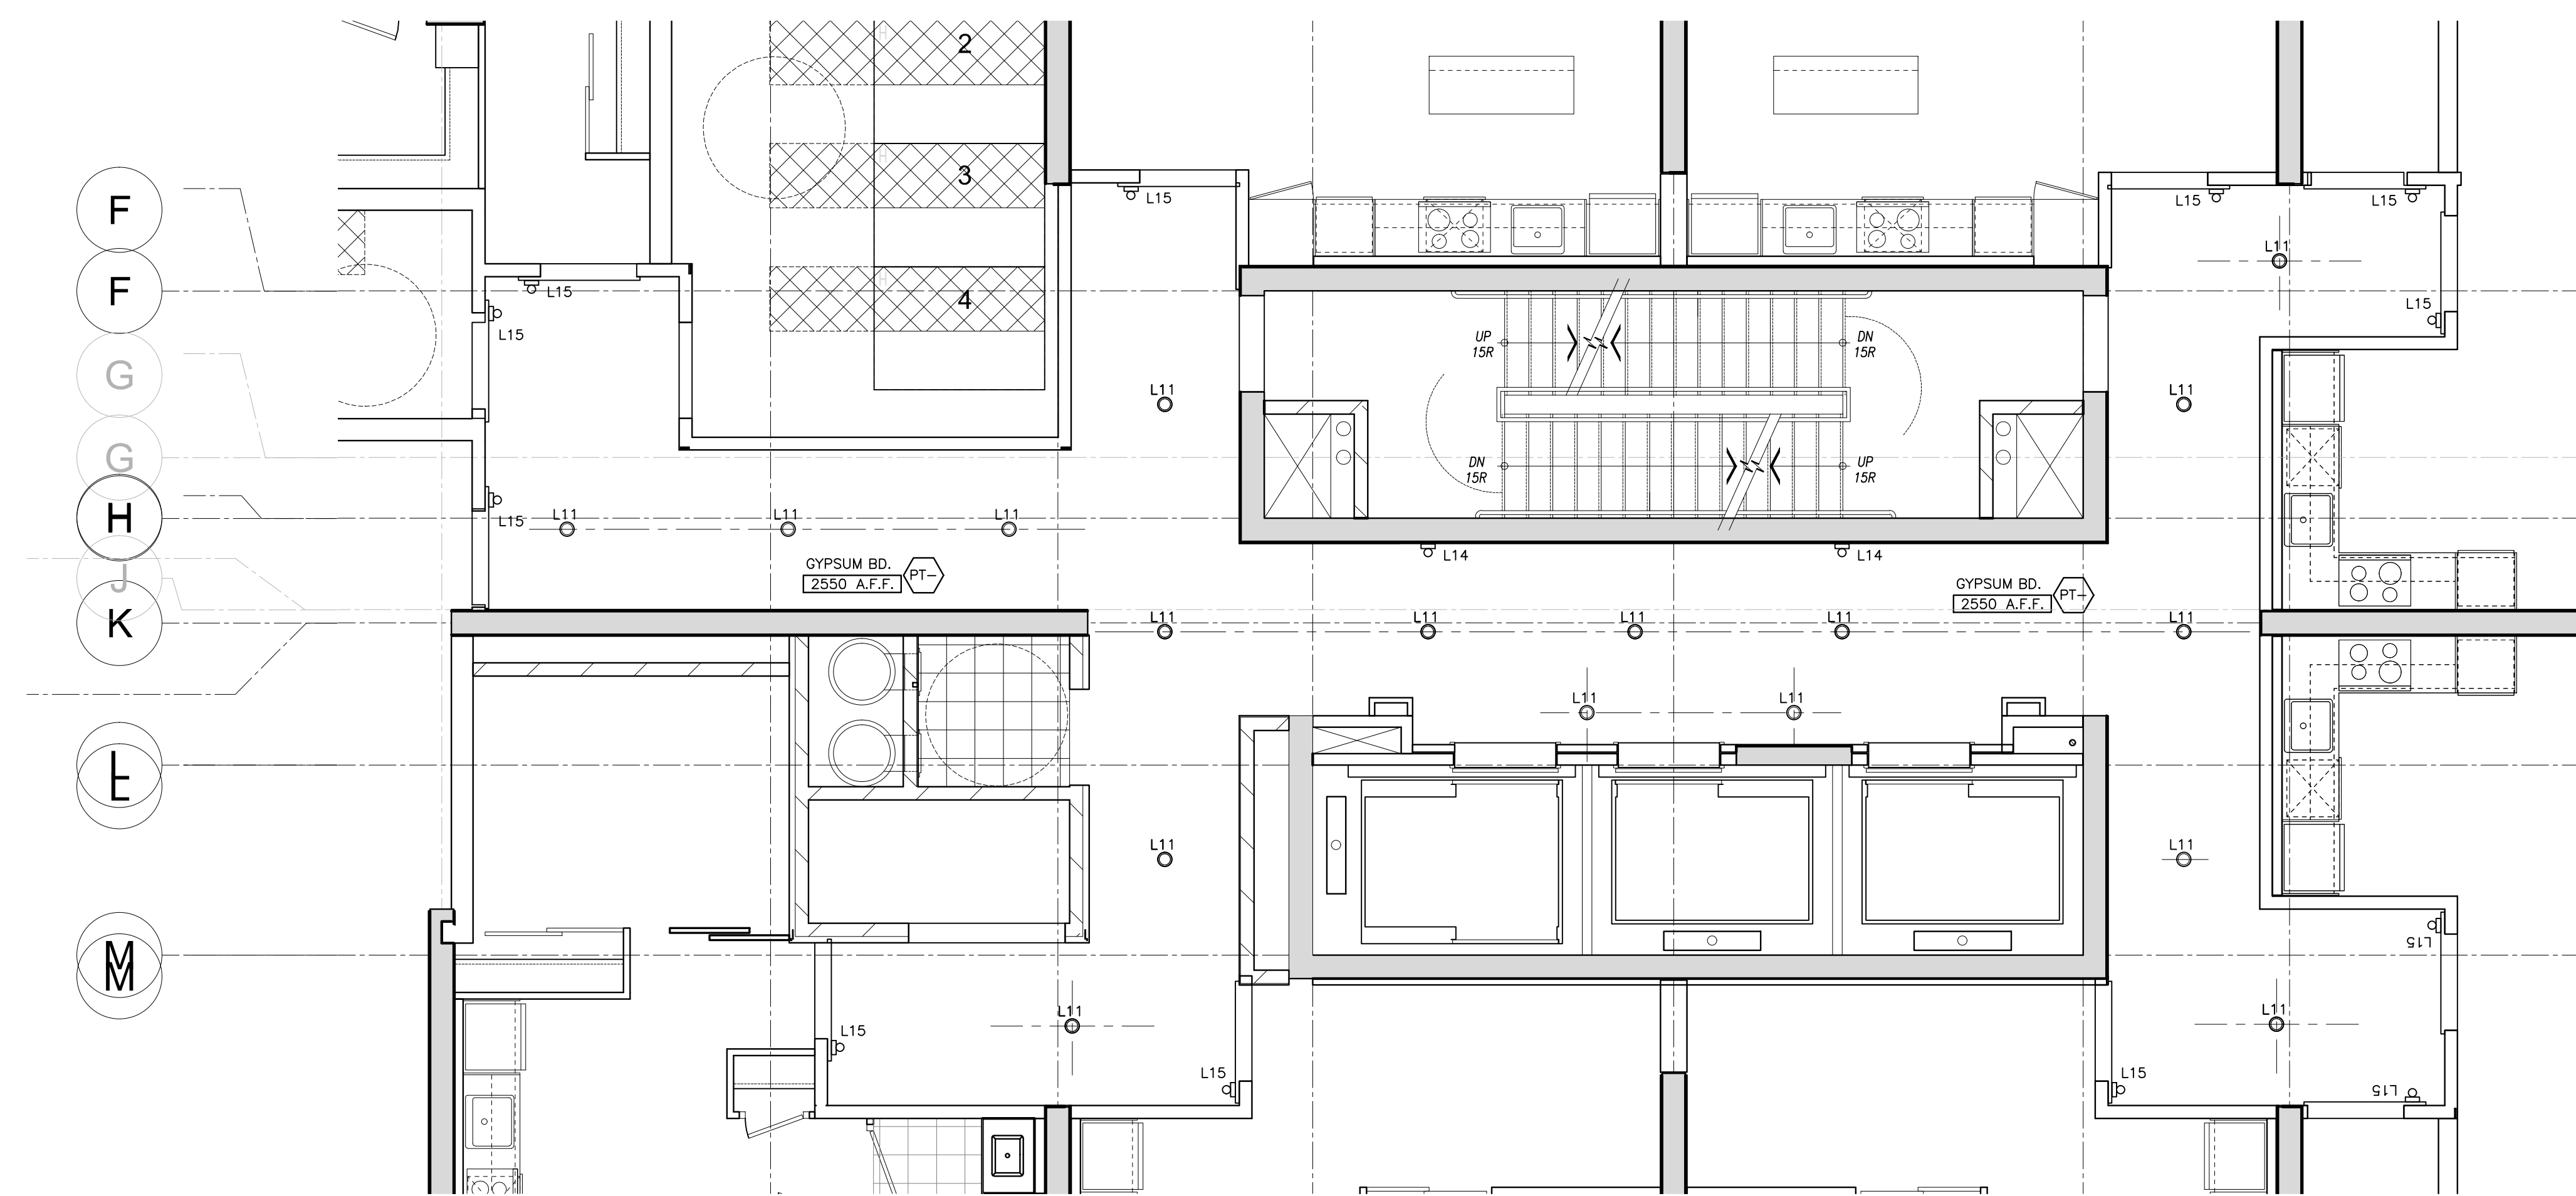

4 4th TO 7th FLOOR CORRIDOR RCP (BUILDING-D)
ID3.4 SCALE= 1:50

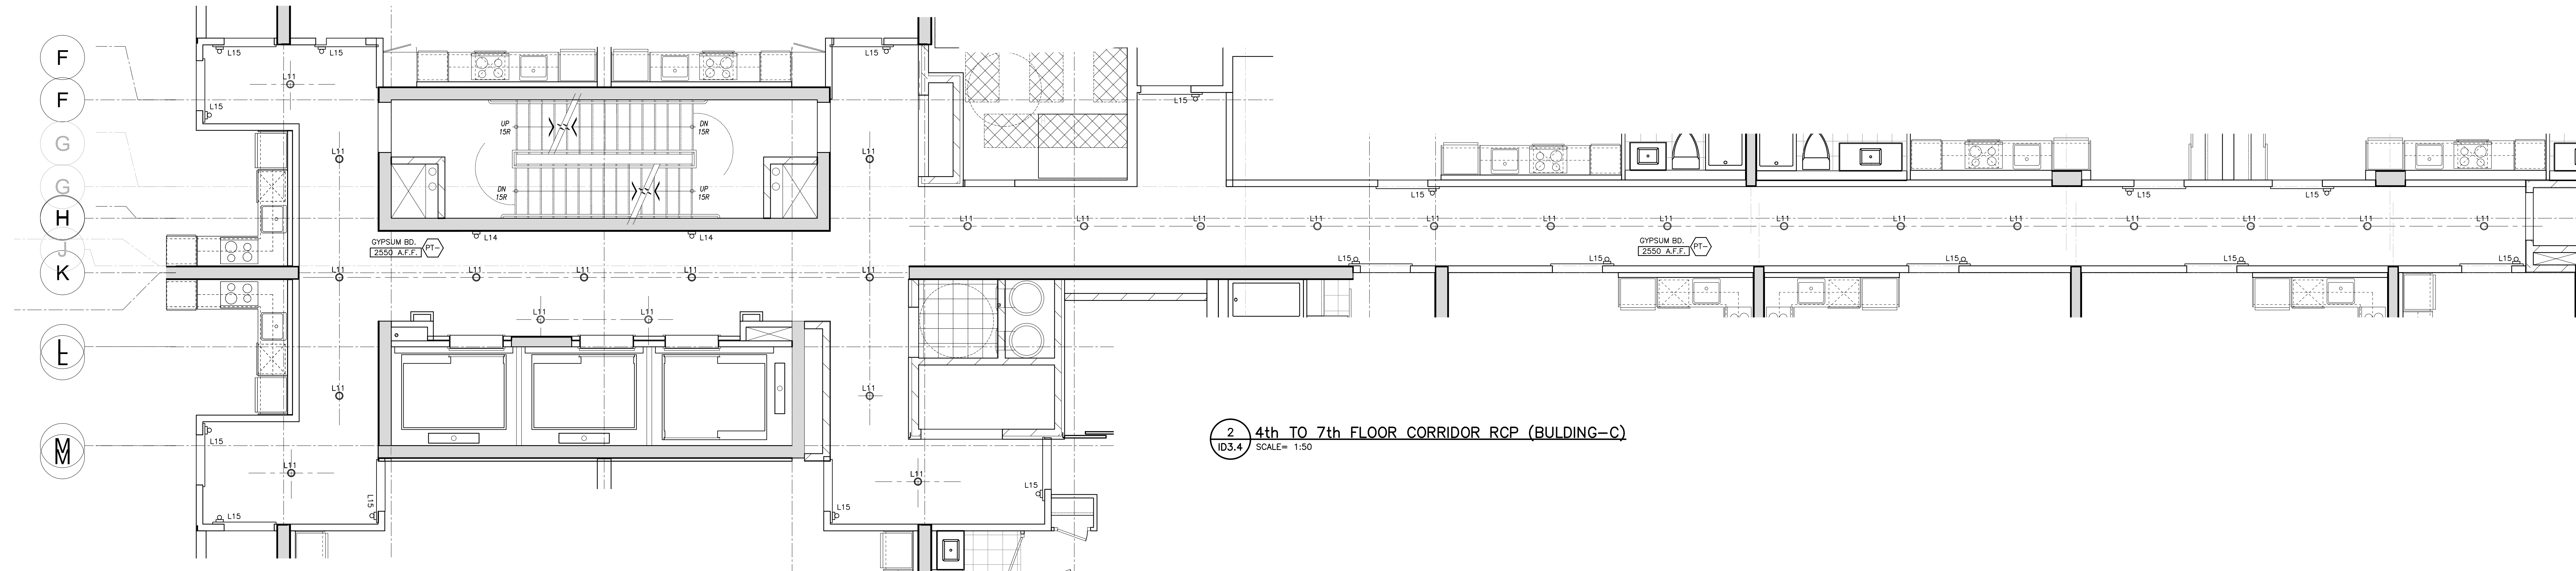

2 4th TO 7th FLOOR CORRIDOR RCP (BUILDING-C)
ID3.4 SCALE= 1:50

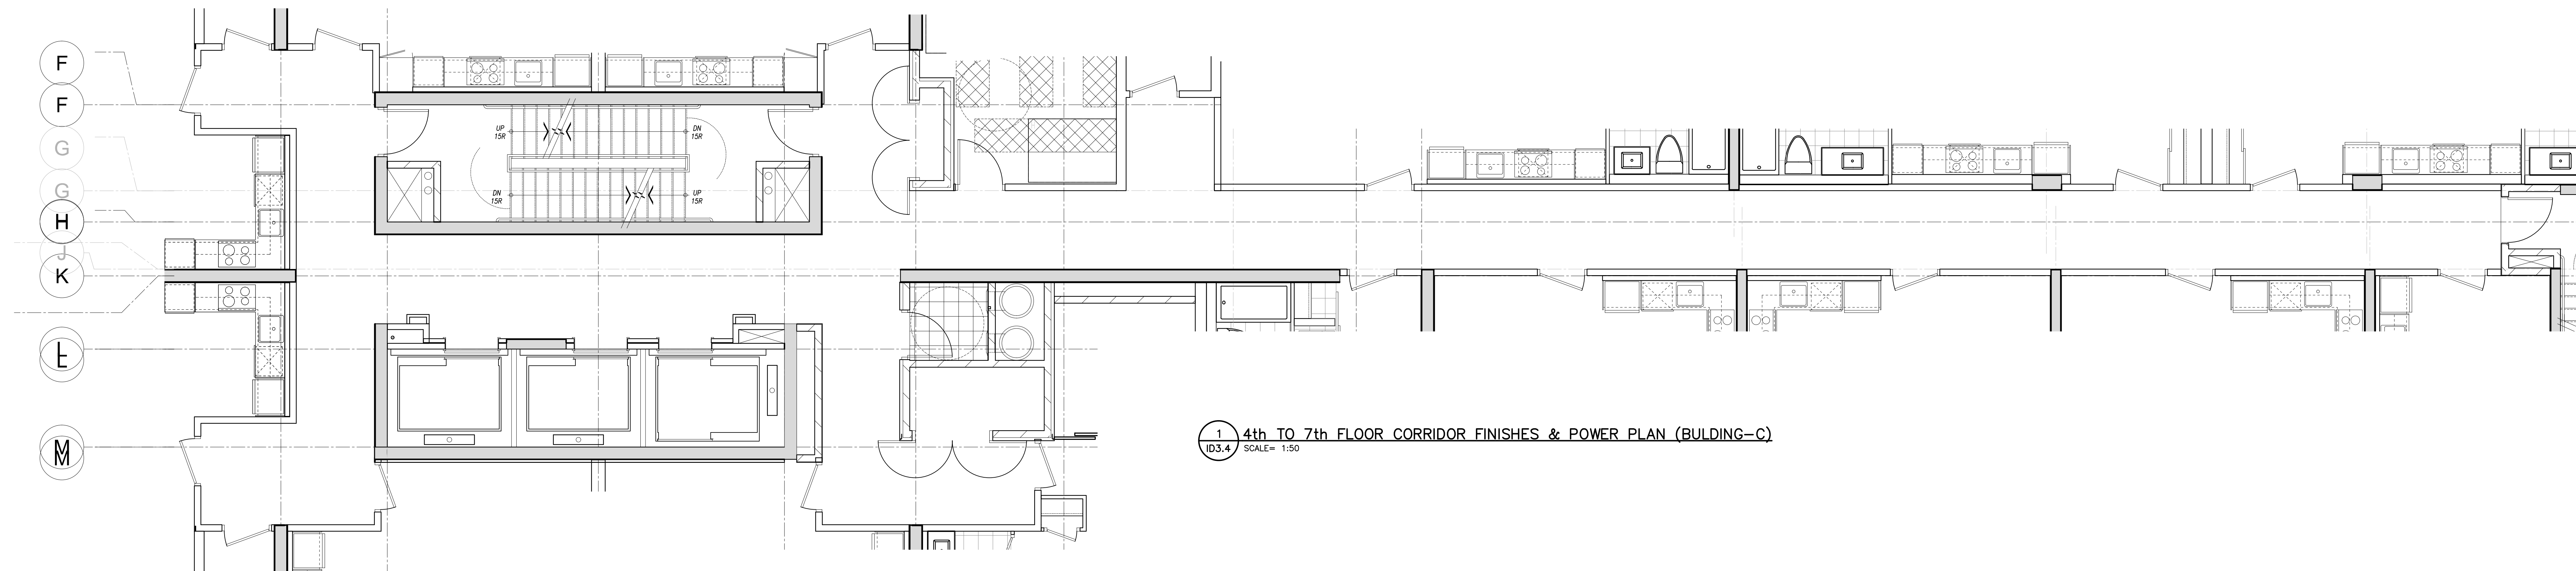

1 4th TO 7th FLOOR CORRIDOR FINISHES & POWER PLAN (BUILDING-C)
ID3.4 SCALE= 1:50

ml

munge // leung

171 East Liberty Street, Suite 290
Toronto, ON, Canada, M6K 3P6
Tel: 416.588.1668
Fax: 416.588.3393
www.mungeleung.com
e-mail> studio@mungeleung.com

Contractor must check and verify
all job dimensions, drawings,
details and specifications; and
report any discrepancies to
designer before proceeding with
work.

Drawing
Title
4th to 7th FLOOR
CORRIDOR PLANS

Project
K&G DEVELOPMENT GROUP
TRIDEL

ARISTO at AVONSHIRE

120 & 130 HARRISON GARDEN BLVD.
NORTH YORK, ONTARIO

1:50 Scale

AUGUST 2011 Date

Drawn by

10126 Project No.

Drawing No.

ID3.4