




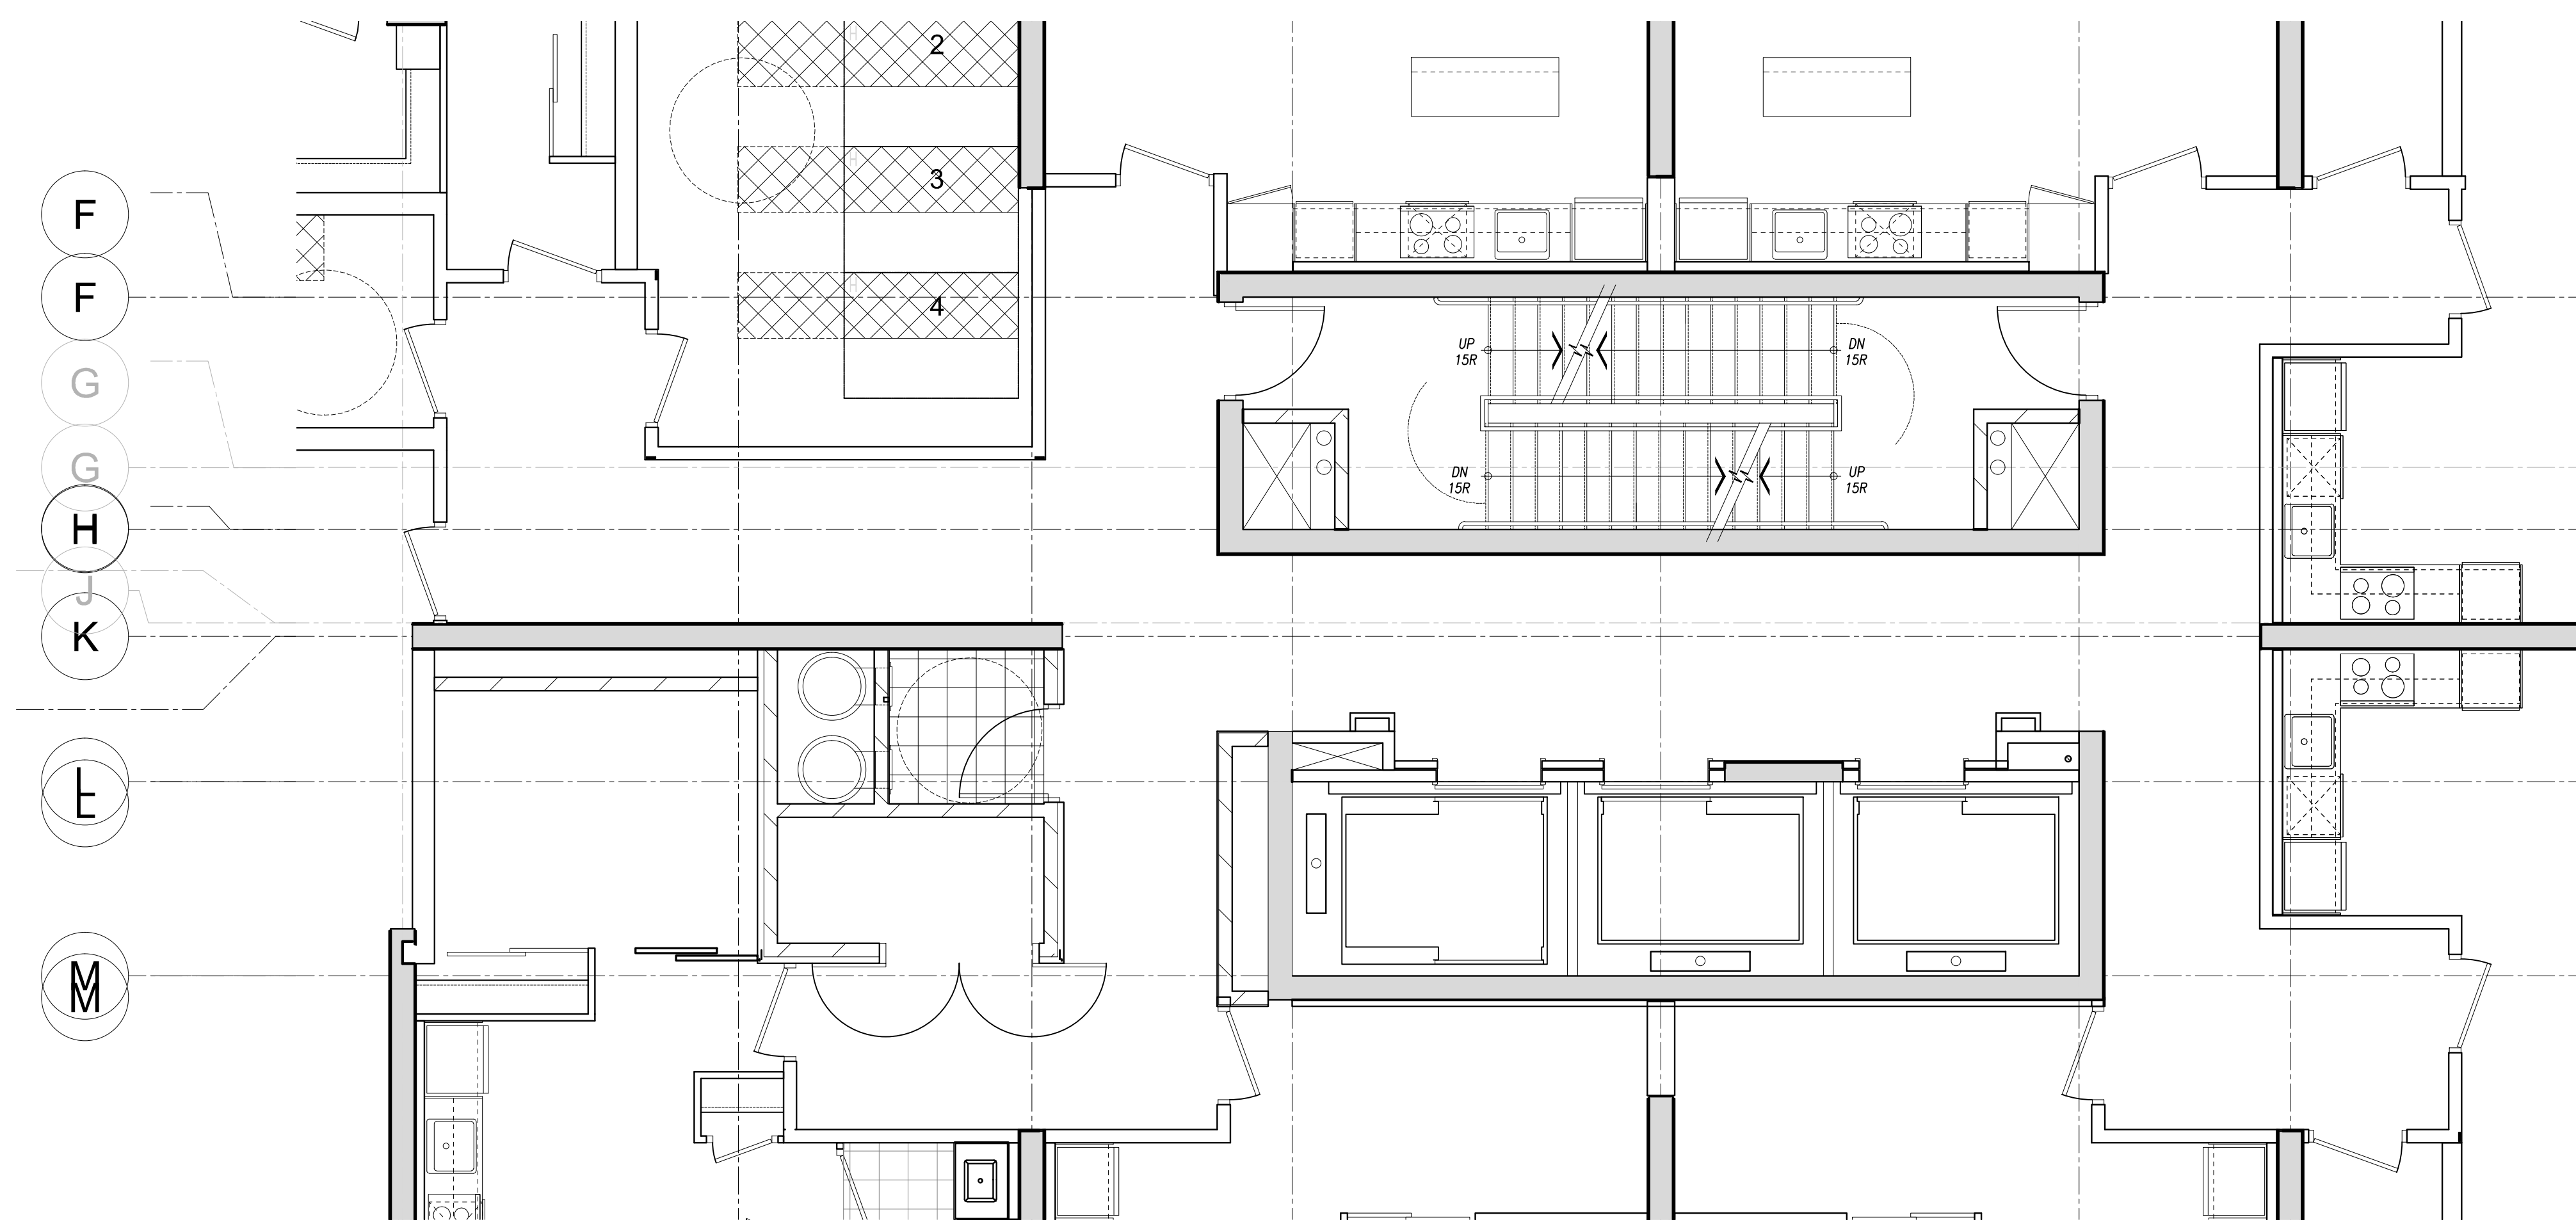


3 8th FLOOR CORRIDOR FINISHES & POWER PLAN (BUILDING-D)
ID3.5 SCALE= 1:50

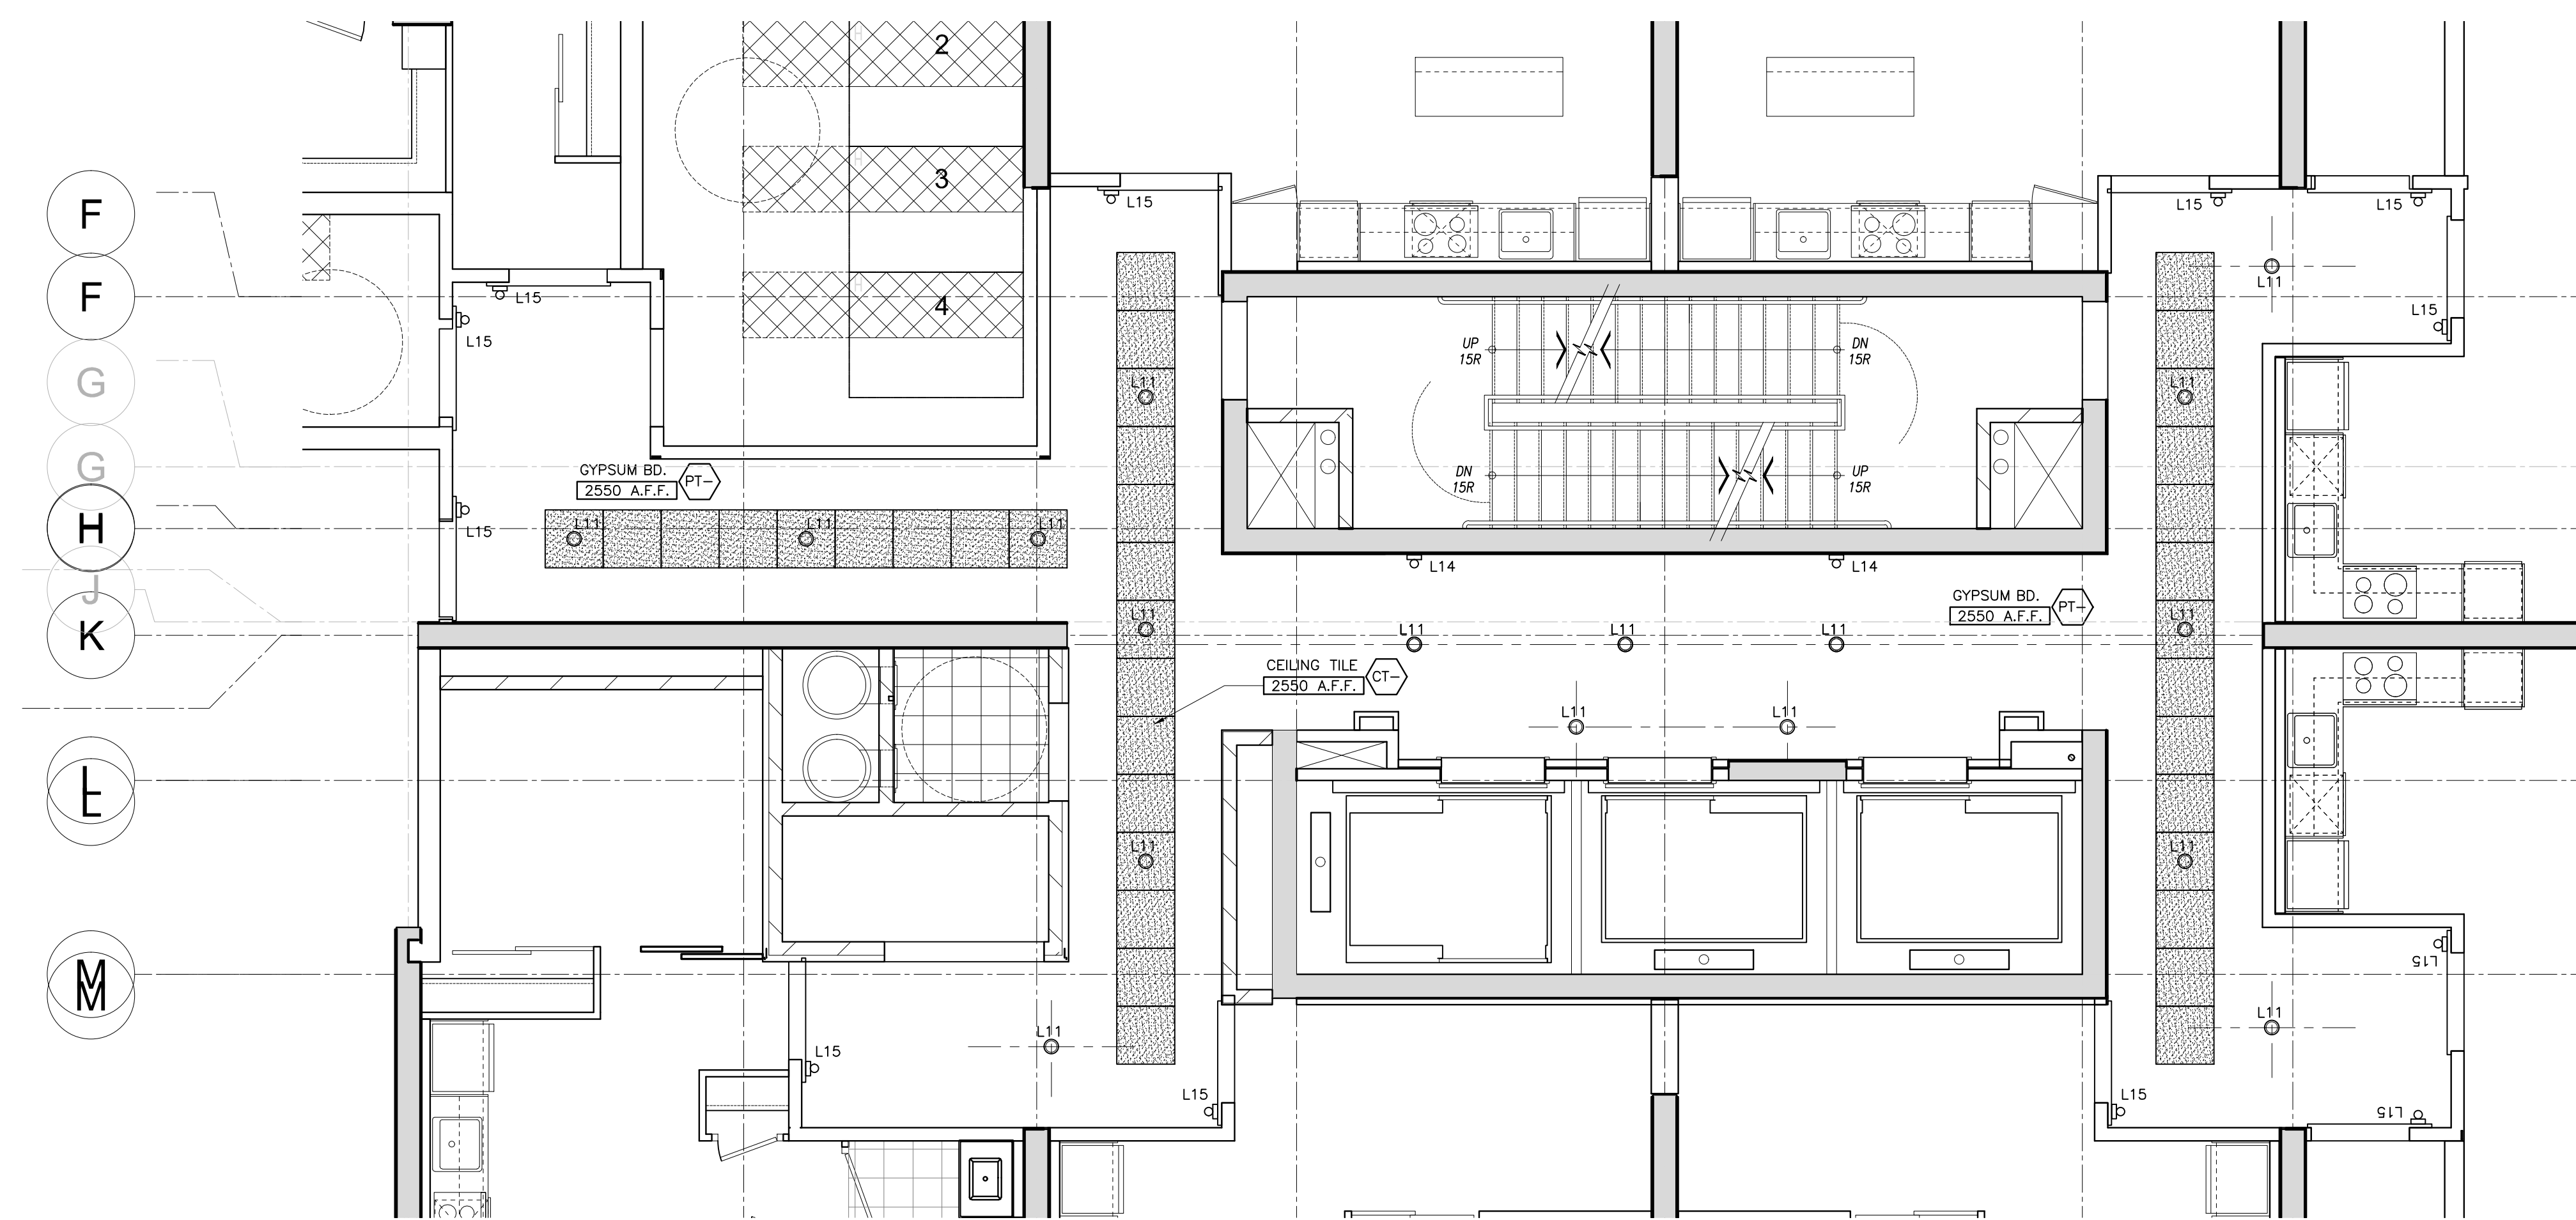

4 8th FLOOR CORRIDOR RCP (BUILDING-D)
ID3.5 SCALE= 1:50

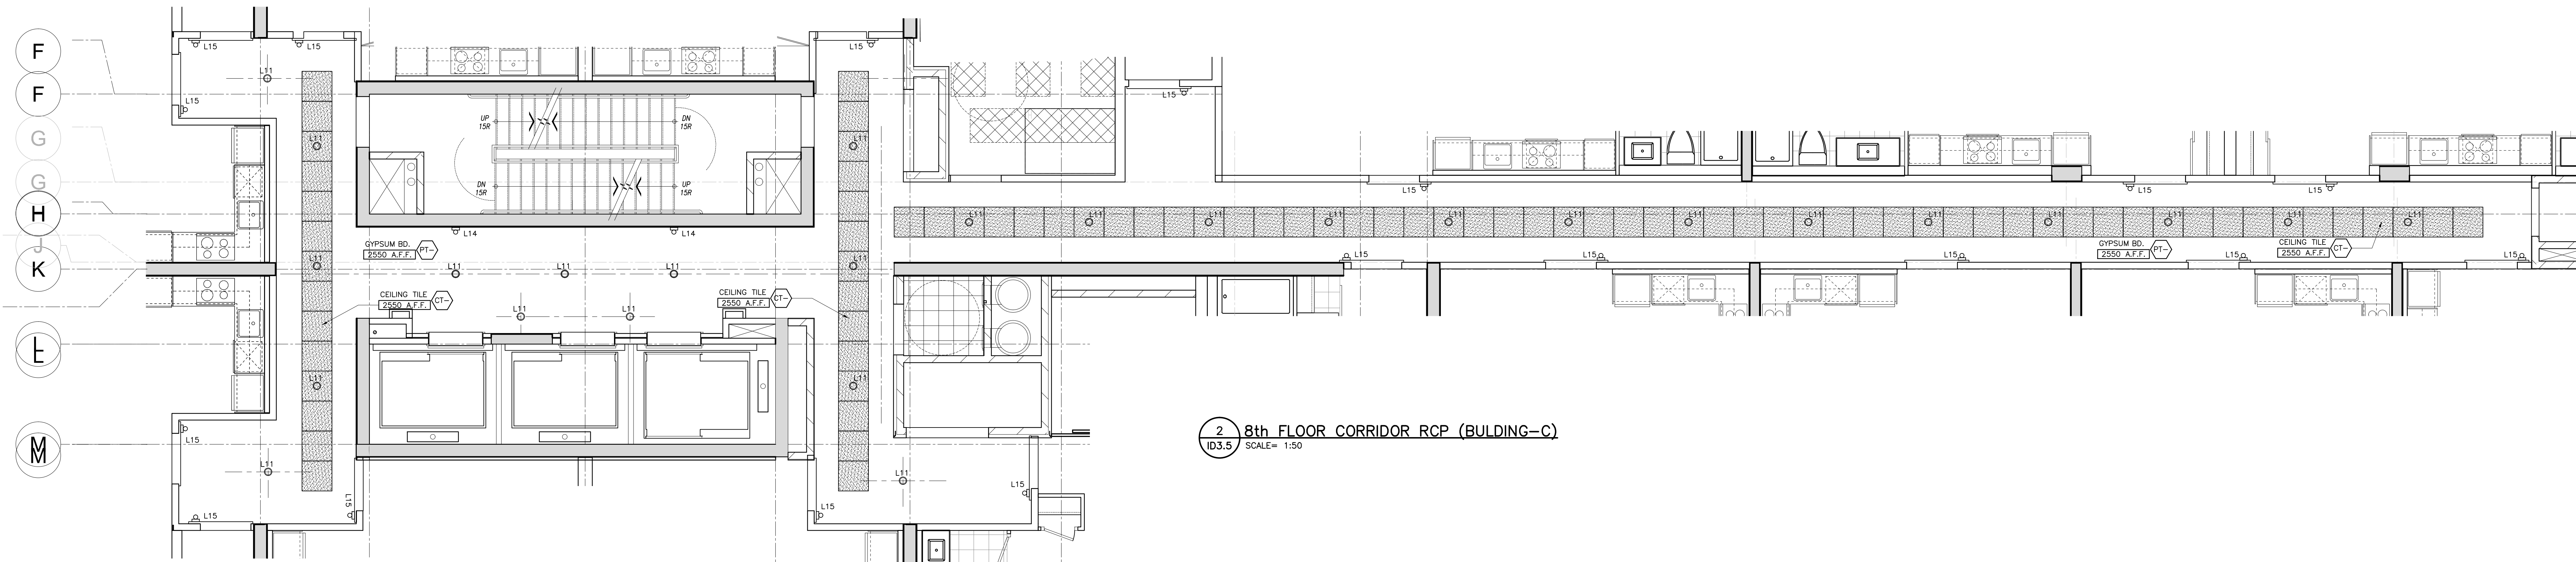

2 8th FLOOR CORRIDOR RCP (BUILDING-C)
ID3.5 SCALE= 1:50

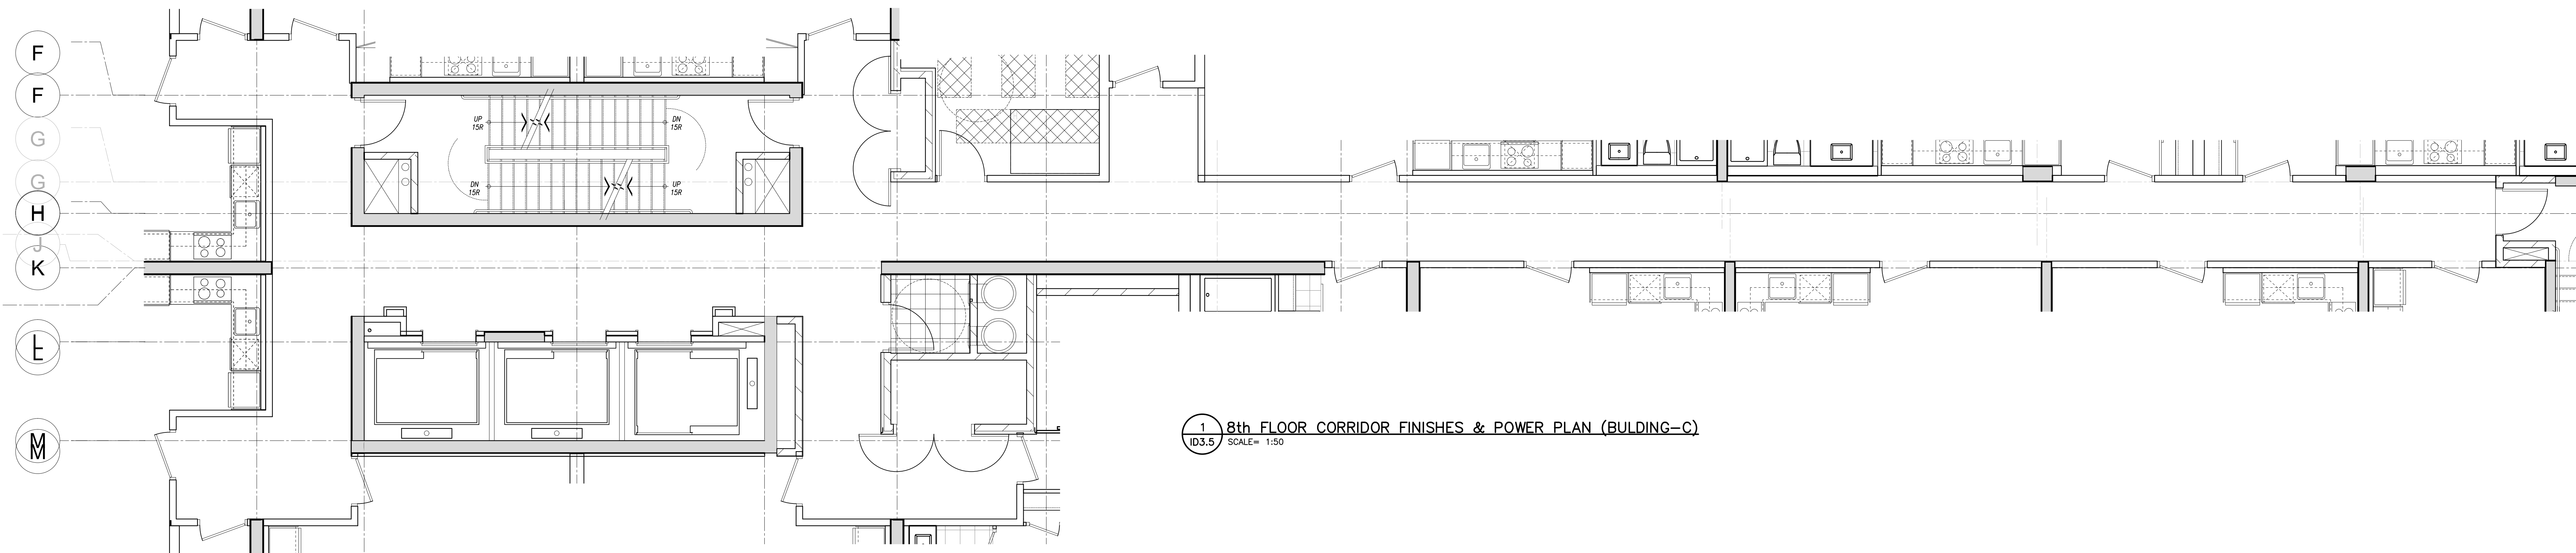

1 8th FLOOR CORRIDOR FINISHES & POWER PLAN (BUILDING-C)
ID3.5 SCALE= 1:50

ml

munge // leung

171 East Liberty Street, Suite 290
Toronto, ON, Canada, M6K 3P6
Tel: 416.588.1668
Fax: 416.588.3393
www.mungeleung.com
e-mail> studio@mungeleung.com

Contractor must check and verify
all job dimensions, drawings,
details and specifications; and
report any discrepancies to
designer before proceeding with
work.

Drawing
Title

8th FLOOR
CORRIDOR PLANS

Project

K&G DEVELOPMENT GROUP
TRIDEL

ARISTO at AVONSHIRE

120 & 130 HARRISON GARDEN BLVD.
NORTH YORK, ONTARIO


1:50 Scale

AUGUST 2011 Date

Drawn by

10126 Project No.

Drawing No.

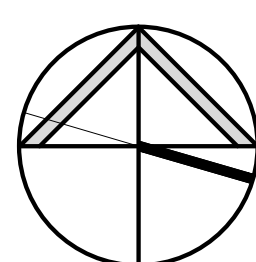

ID3.5