



MCW Consultants Ltd.

Site Instruction

Date: November 30, 2016

Queen's Quay Terminal
207 Queen's Quay West, Suite 615
Toronto, Ontario M5J 1A7

Phone (416) 598-2920
Fax (416) 598-5394
www.mcw.com

Project Name: AQUAVISTA - Bayside
Client: TRIDEL Corporation
To: TRIDEL Corporation
Attention: Chadi Loza
Fax number: -

Project No.: 8489D
SI No.: E 008
Page No.: 1 of 1+ 2 Attached
Office: Toronto
From: Sunanda Perera
Tao Li

Distribution: Vince Mirarchi –TRIDEL
Chadi Loza - TRIDEL
Christina Lee -KIRKOR
Al Medeiros –MCW
Michael Hunter-MCW
Mark Furtado-MCW
Sarfraz H. Jaffrey-MCW

Provide itemized labour, equipment and material costs for Work listed below. Do not proceed with any of the listed Work prior to issuance of signed Change Order.

Title: Relocate Mechanical Equipment Power Connection/ Miscellaneous clarifications.

Specification:

Spec	Issued	Items
		N/A

Electrical:



Drawing No.	Drawing Issued	Items
E0-01	No	Clarification for exit lights – Two exit signs shall be provided where bi-directional is shown on the location. Refer to the Legend for detail.
E1-02	Yes	Relocate power connections for ACUC-14/15/16 as shown.
E4-02	Yes	Revise note #1 on detail-7. 'Suite meter supplied by Toronto Hydro, installed by Toronto Hydro.'









 
ME Schedule:

Drawing No.	Drawing Issued	Items
-	-	N/A.

Reason for Issue – Design Coordination with SI-M002.

End of SI-E008

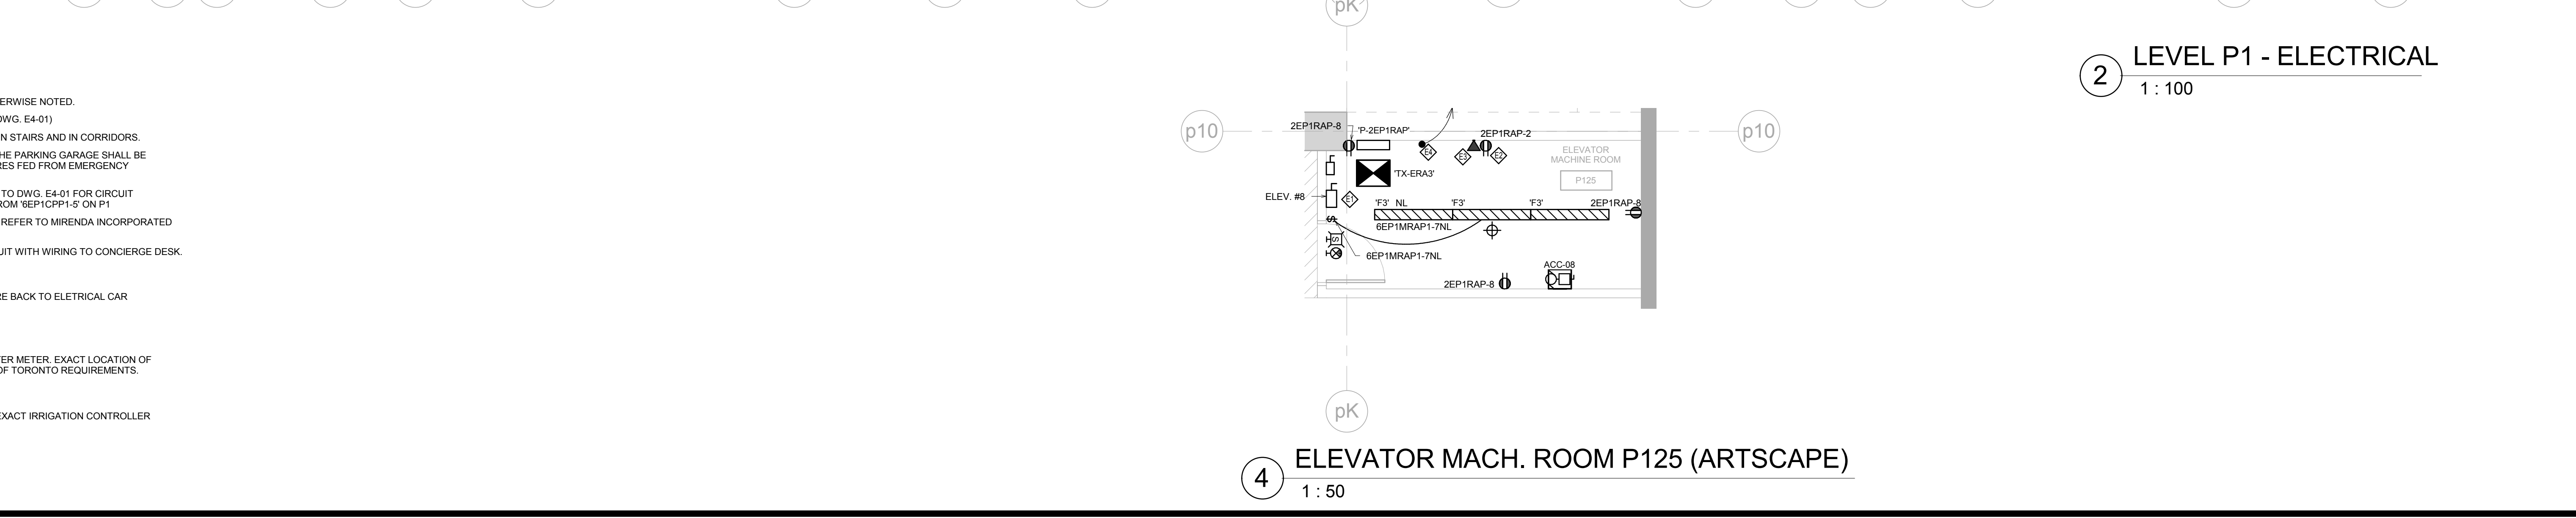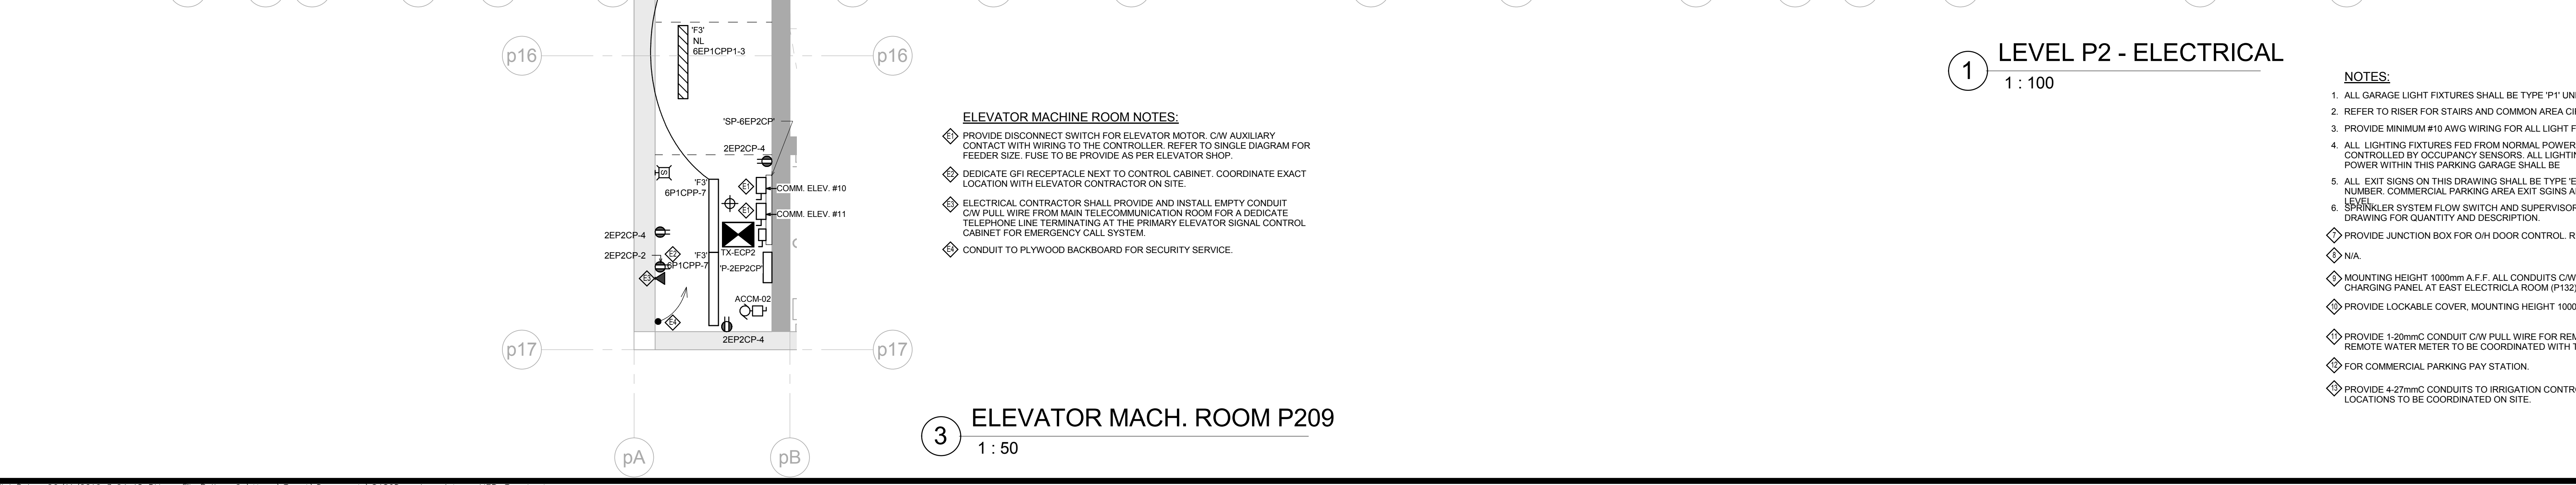

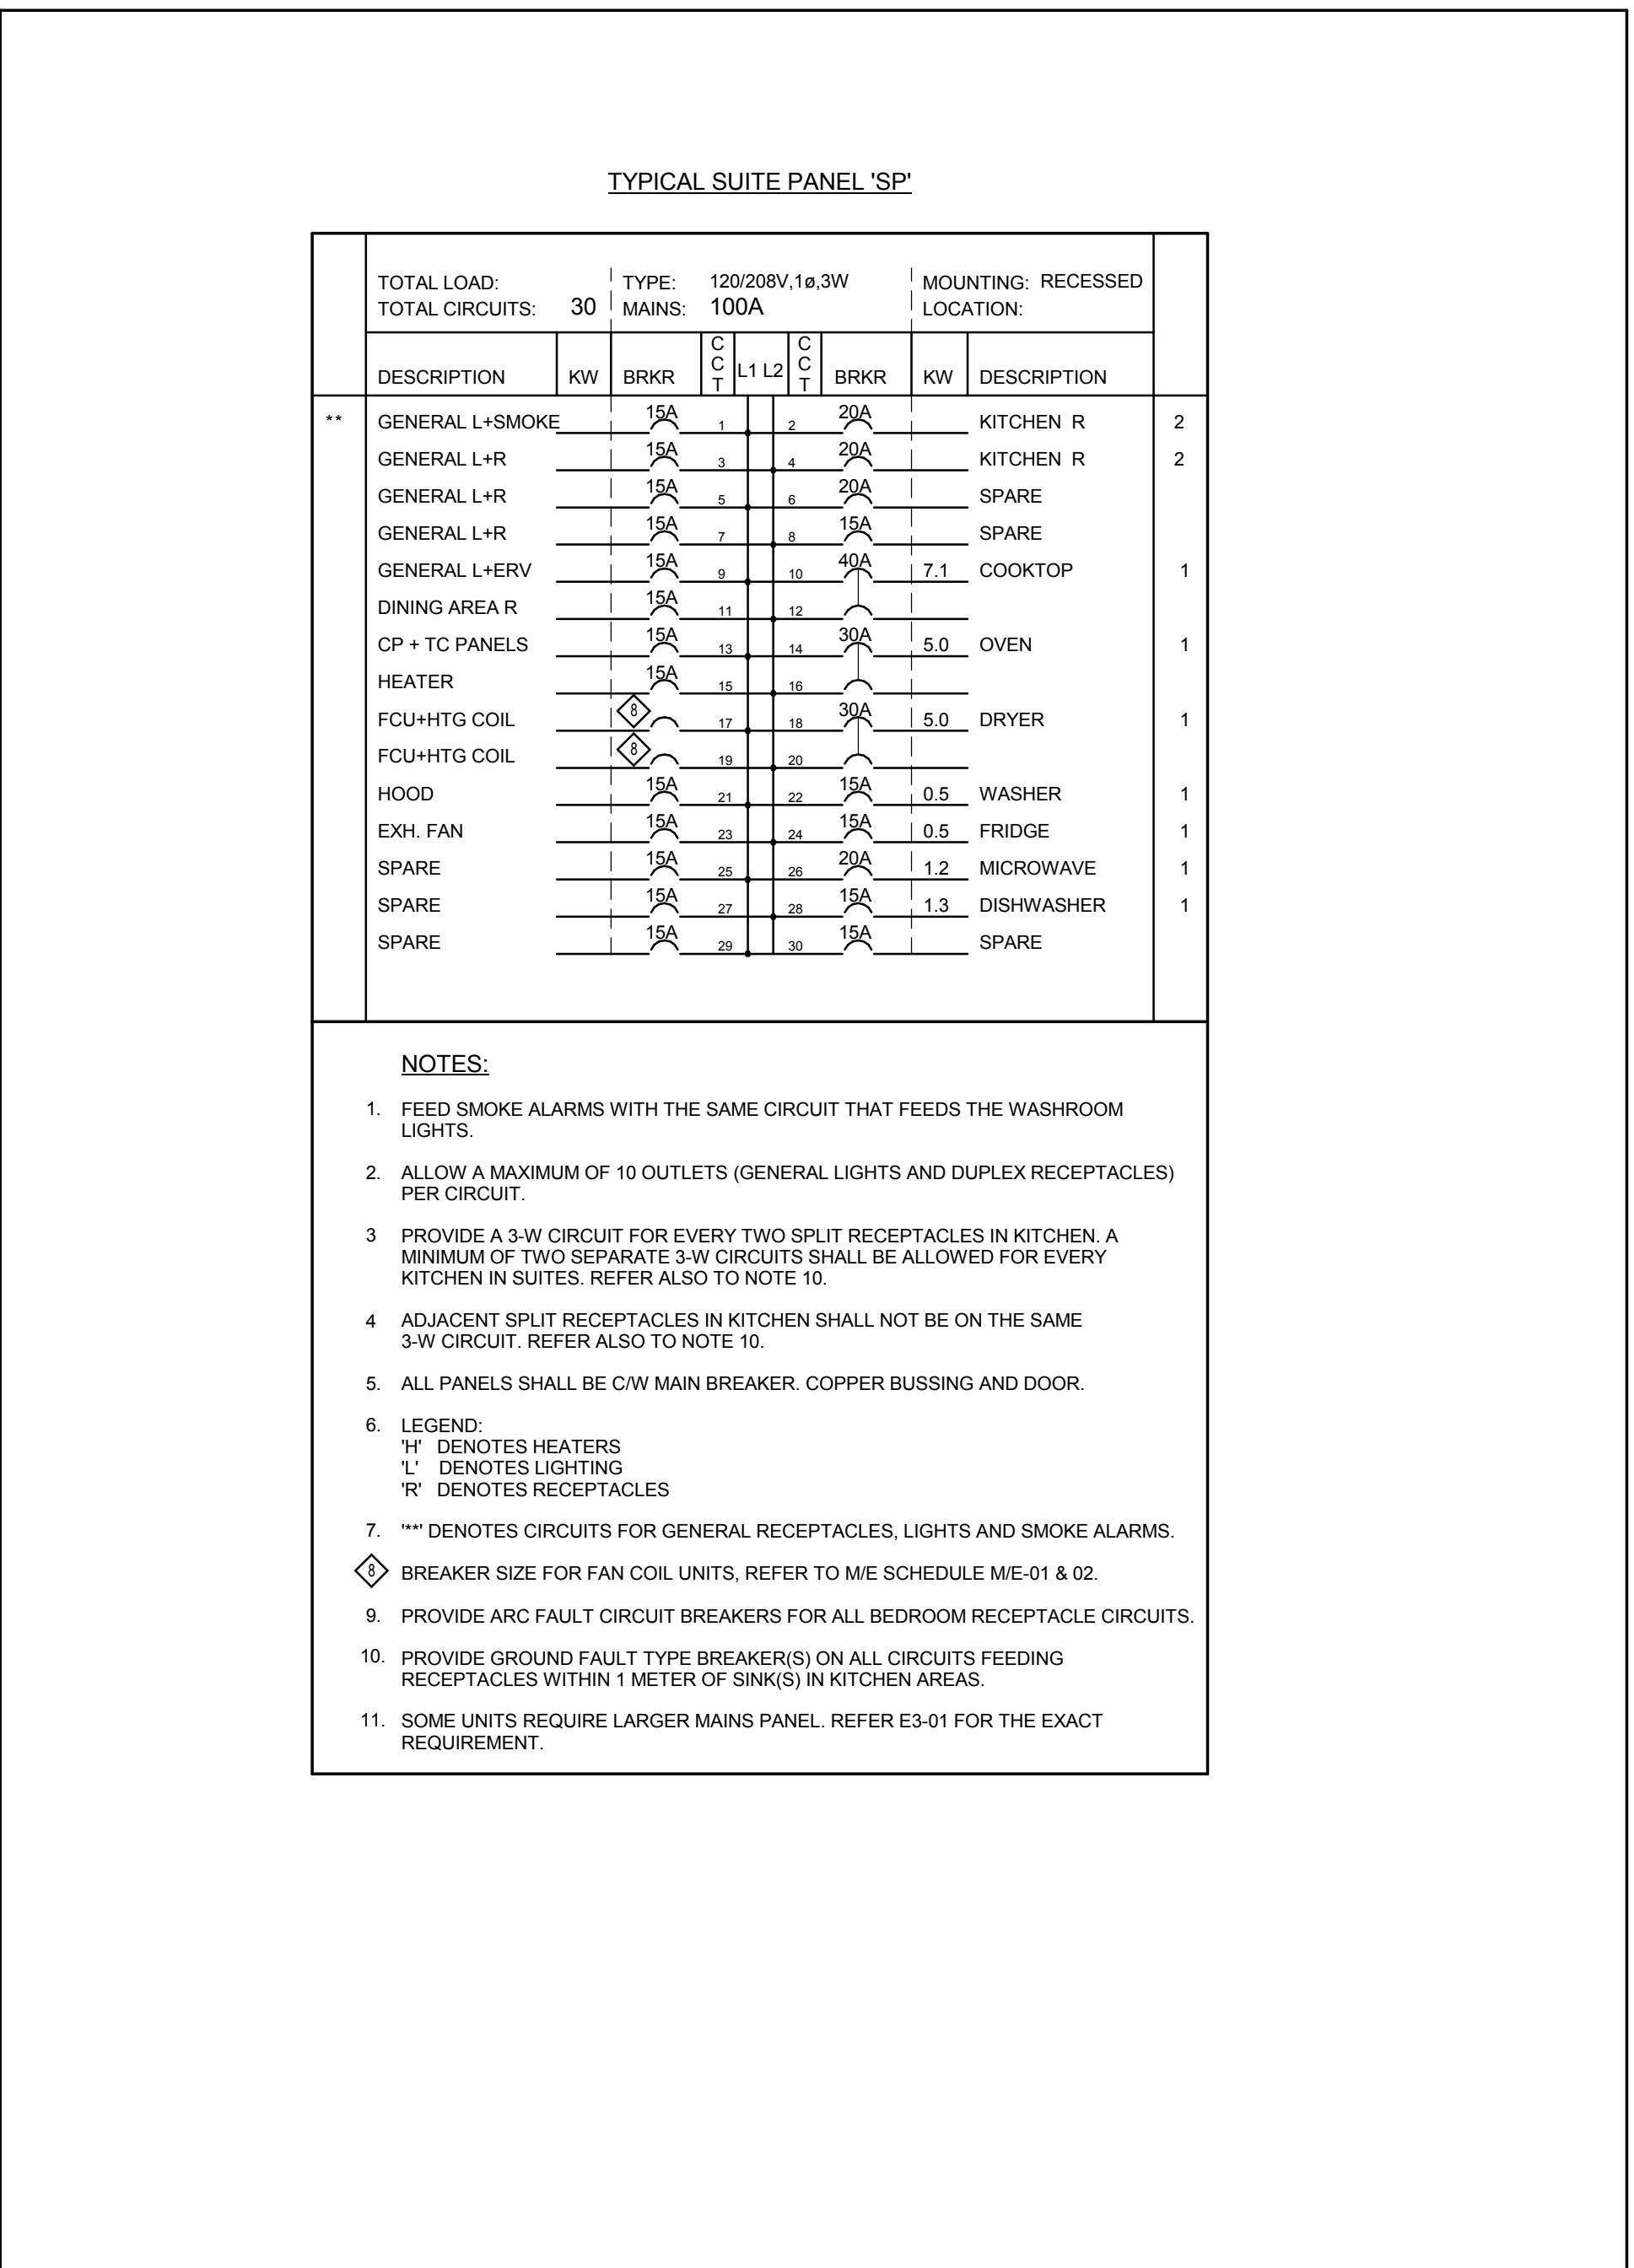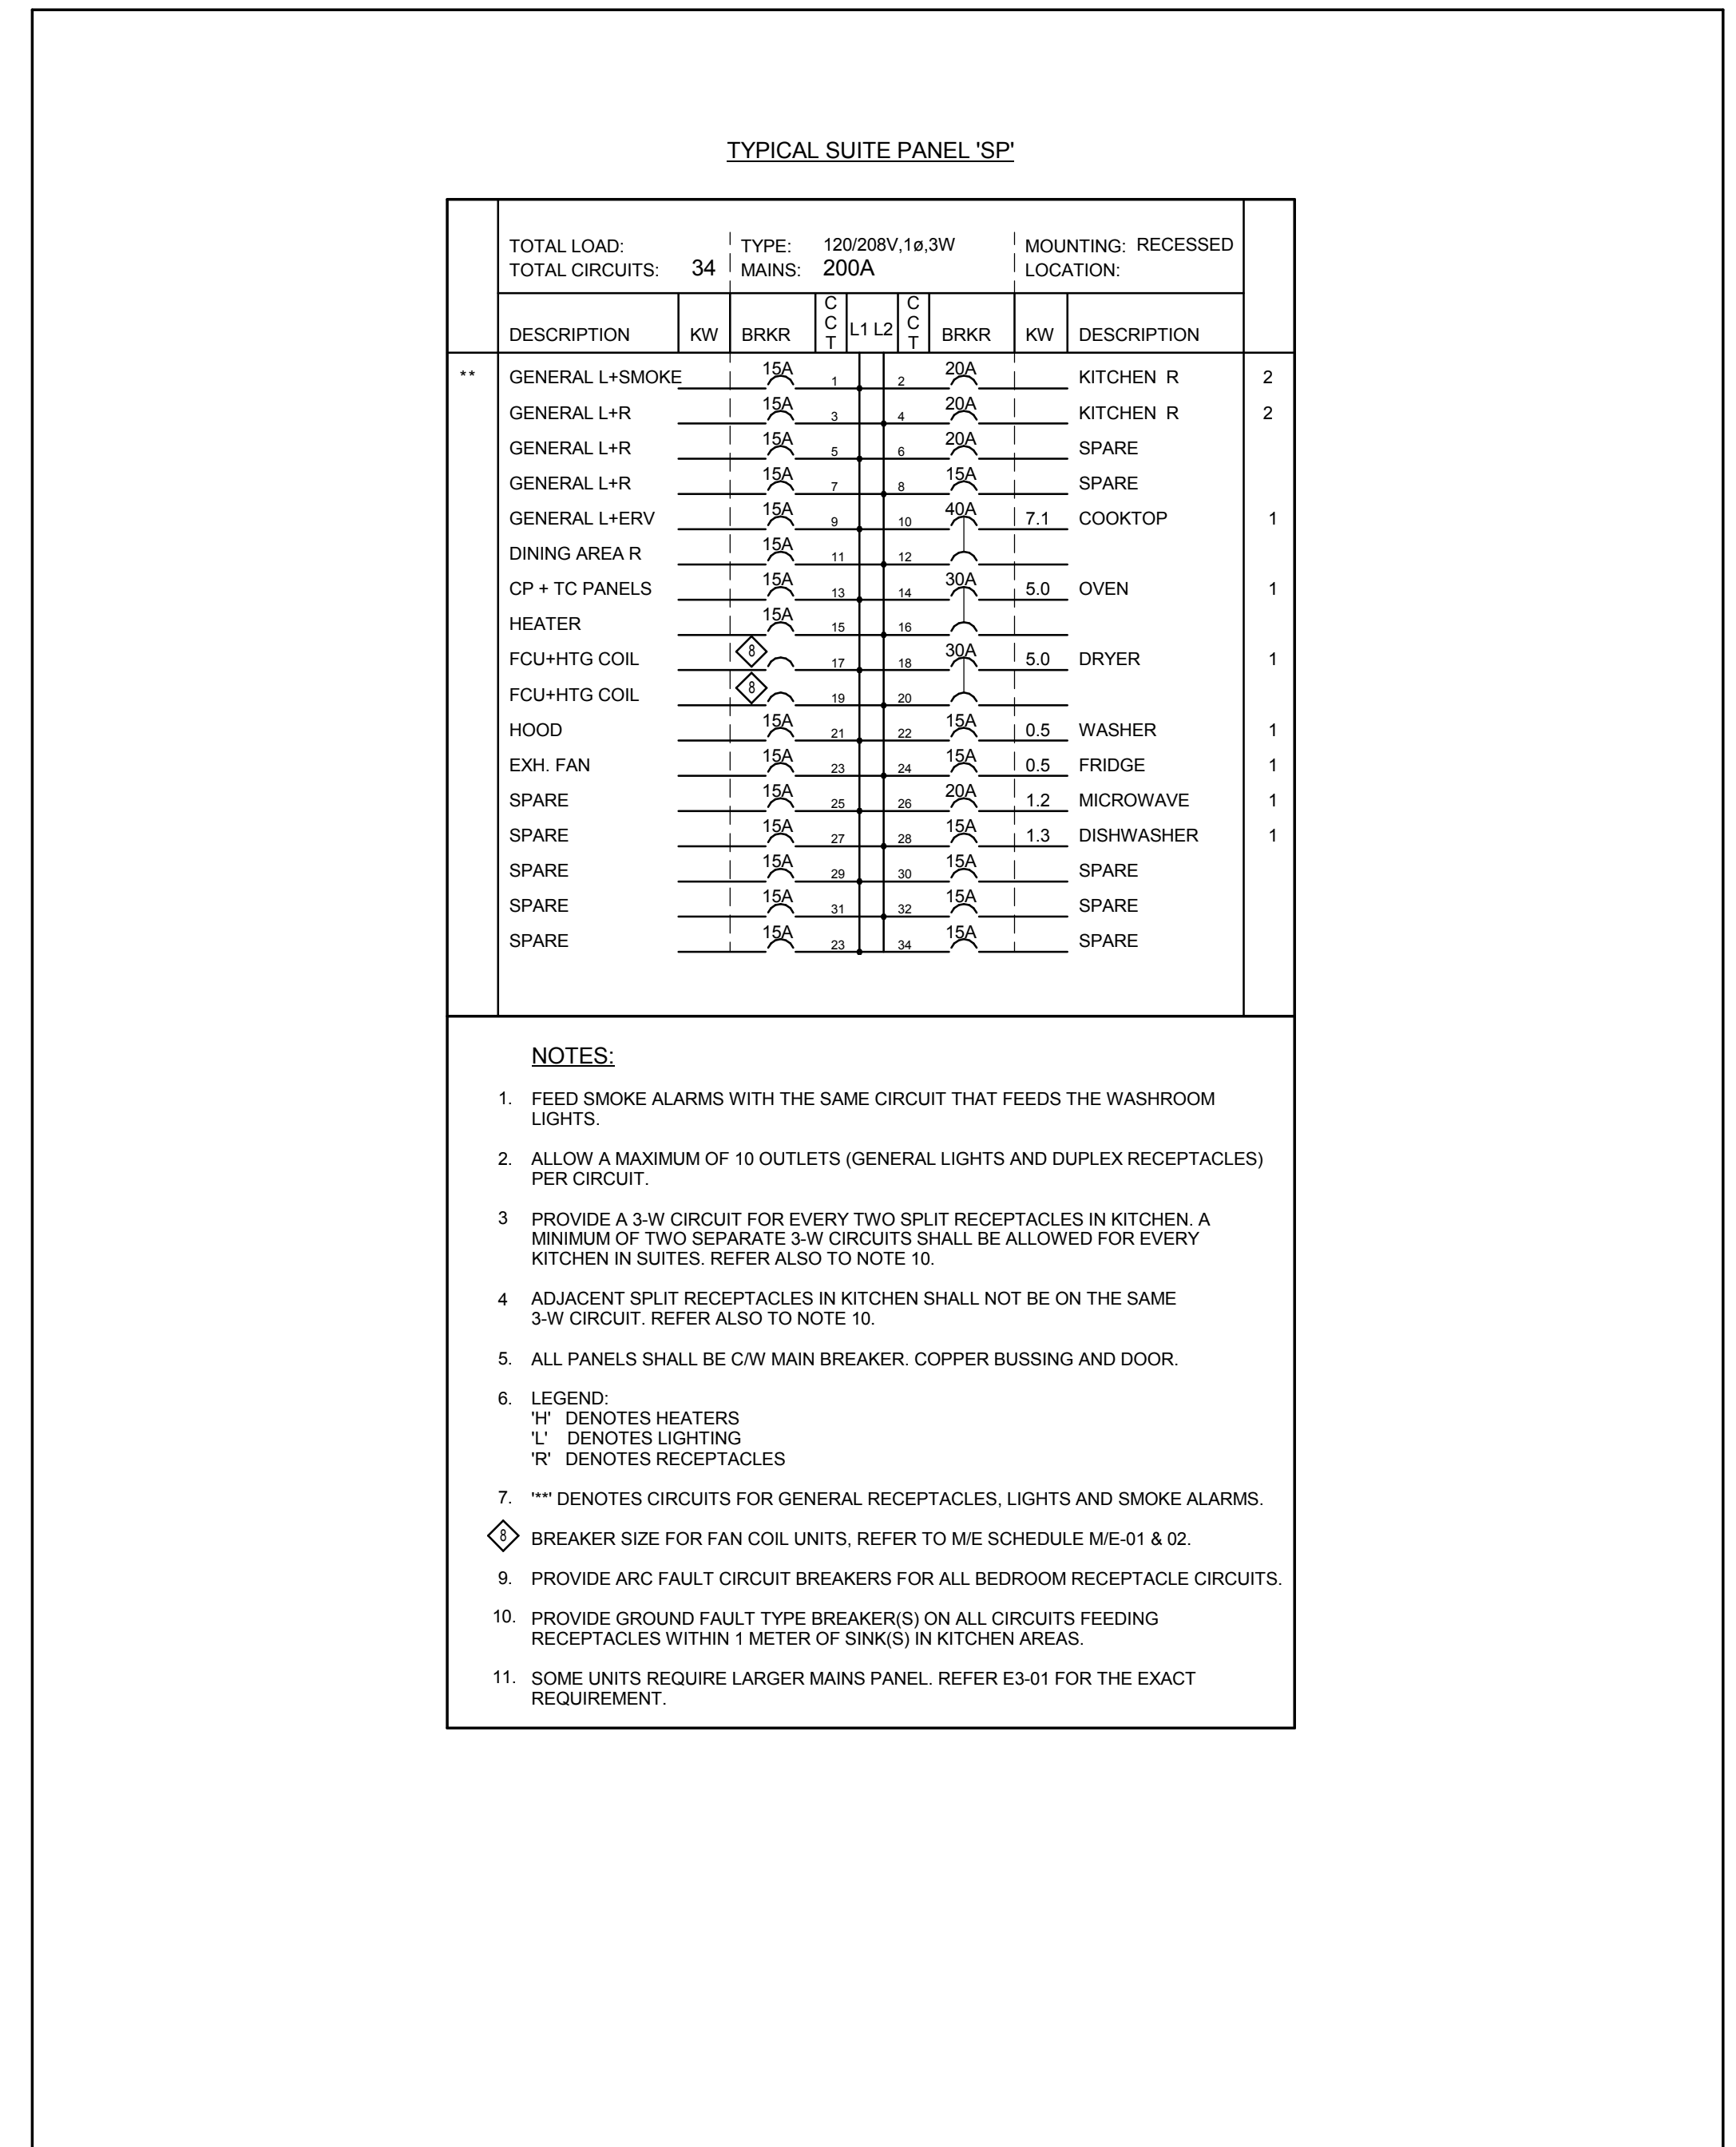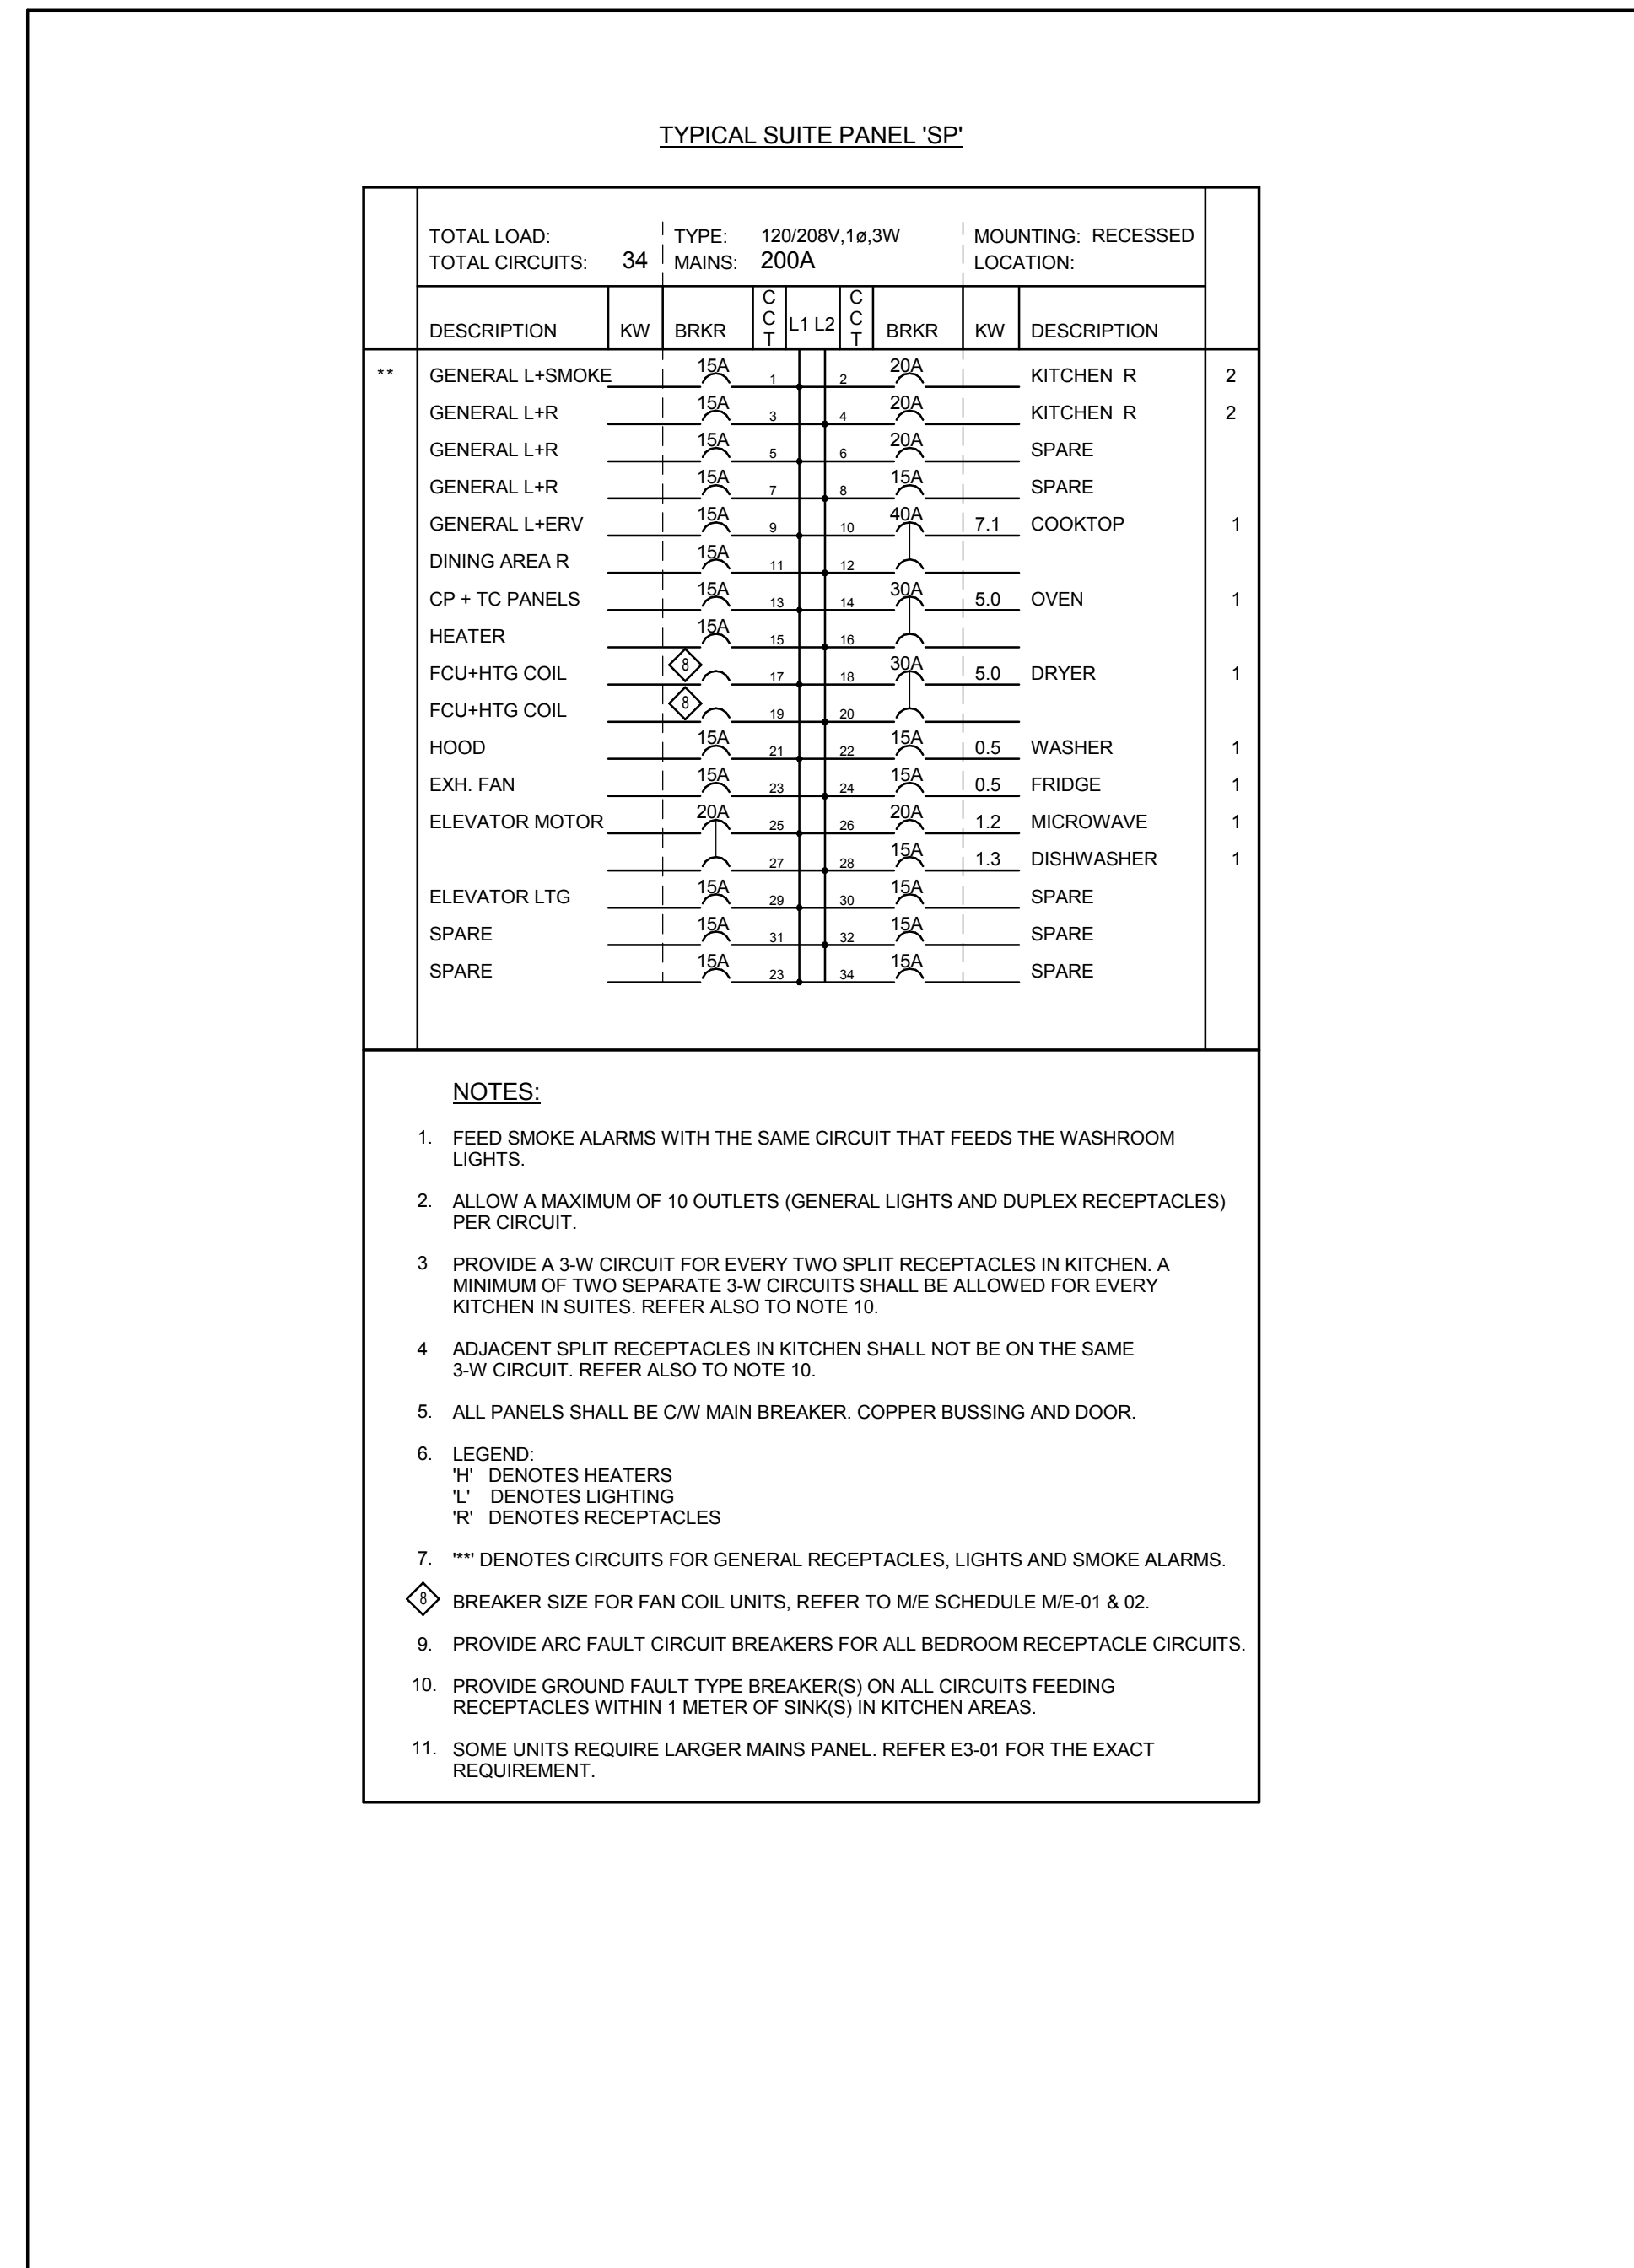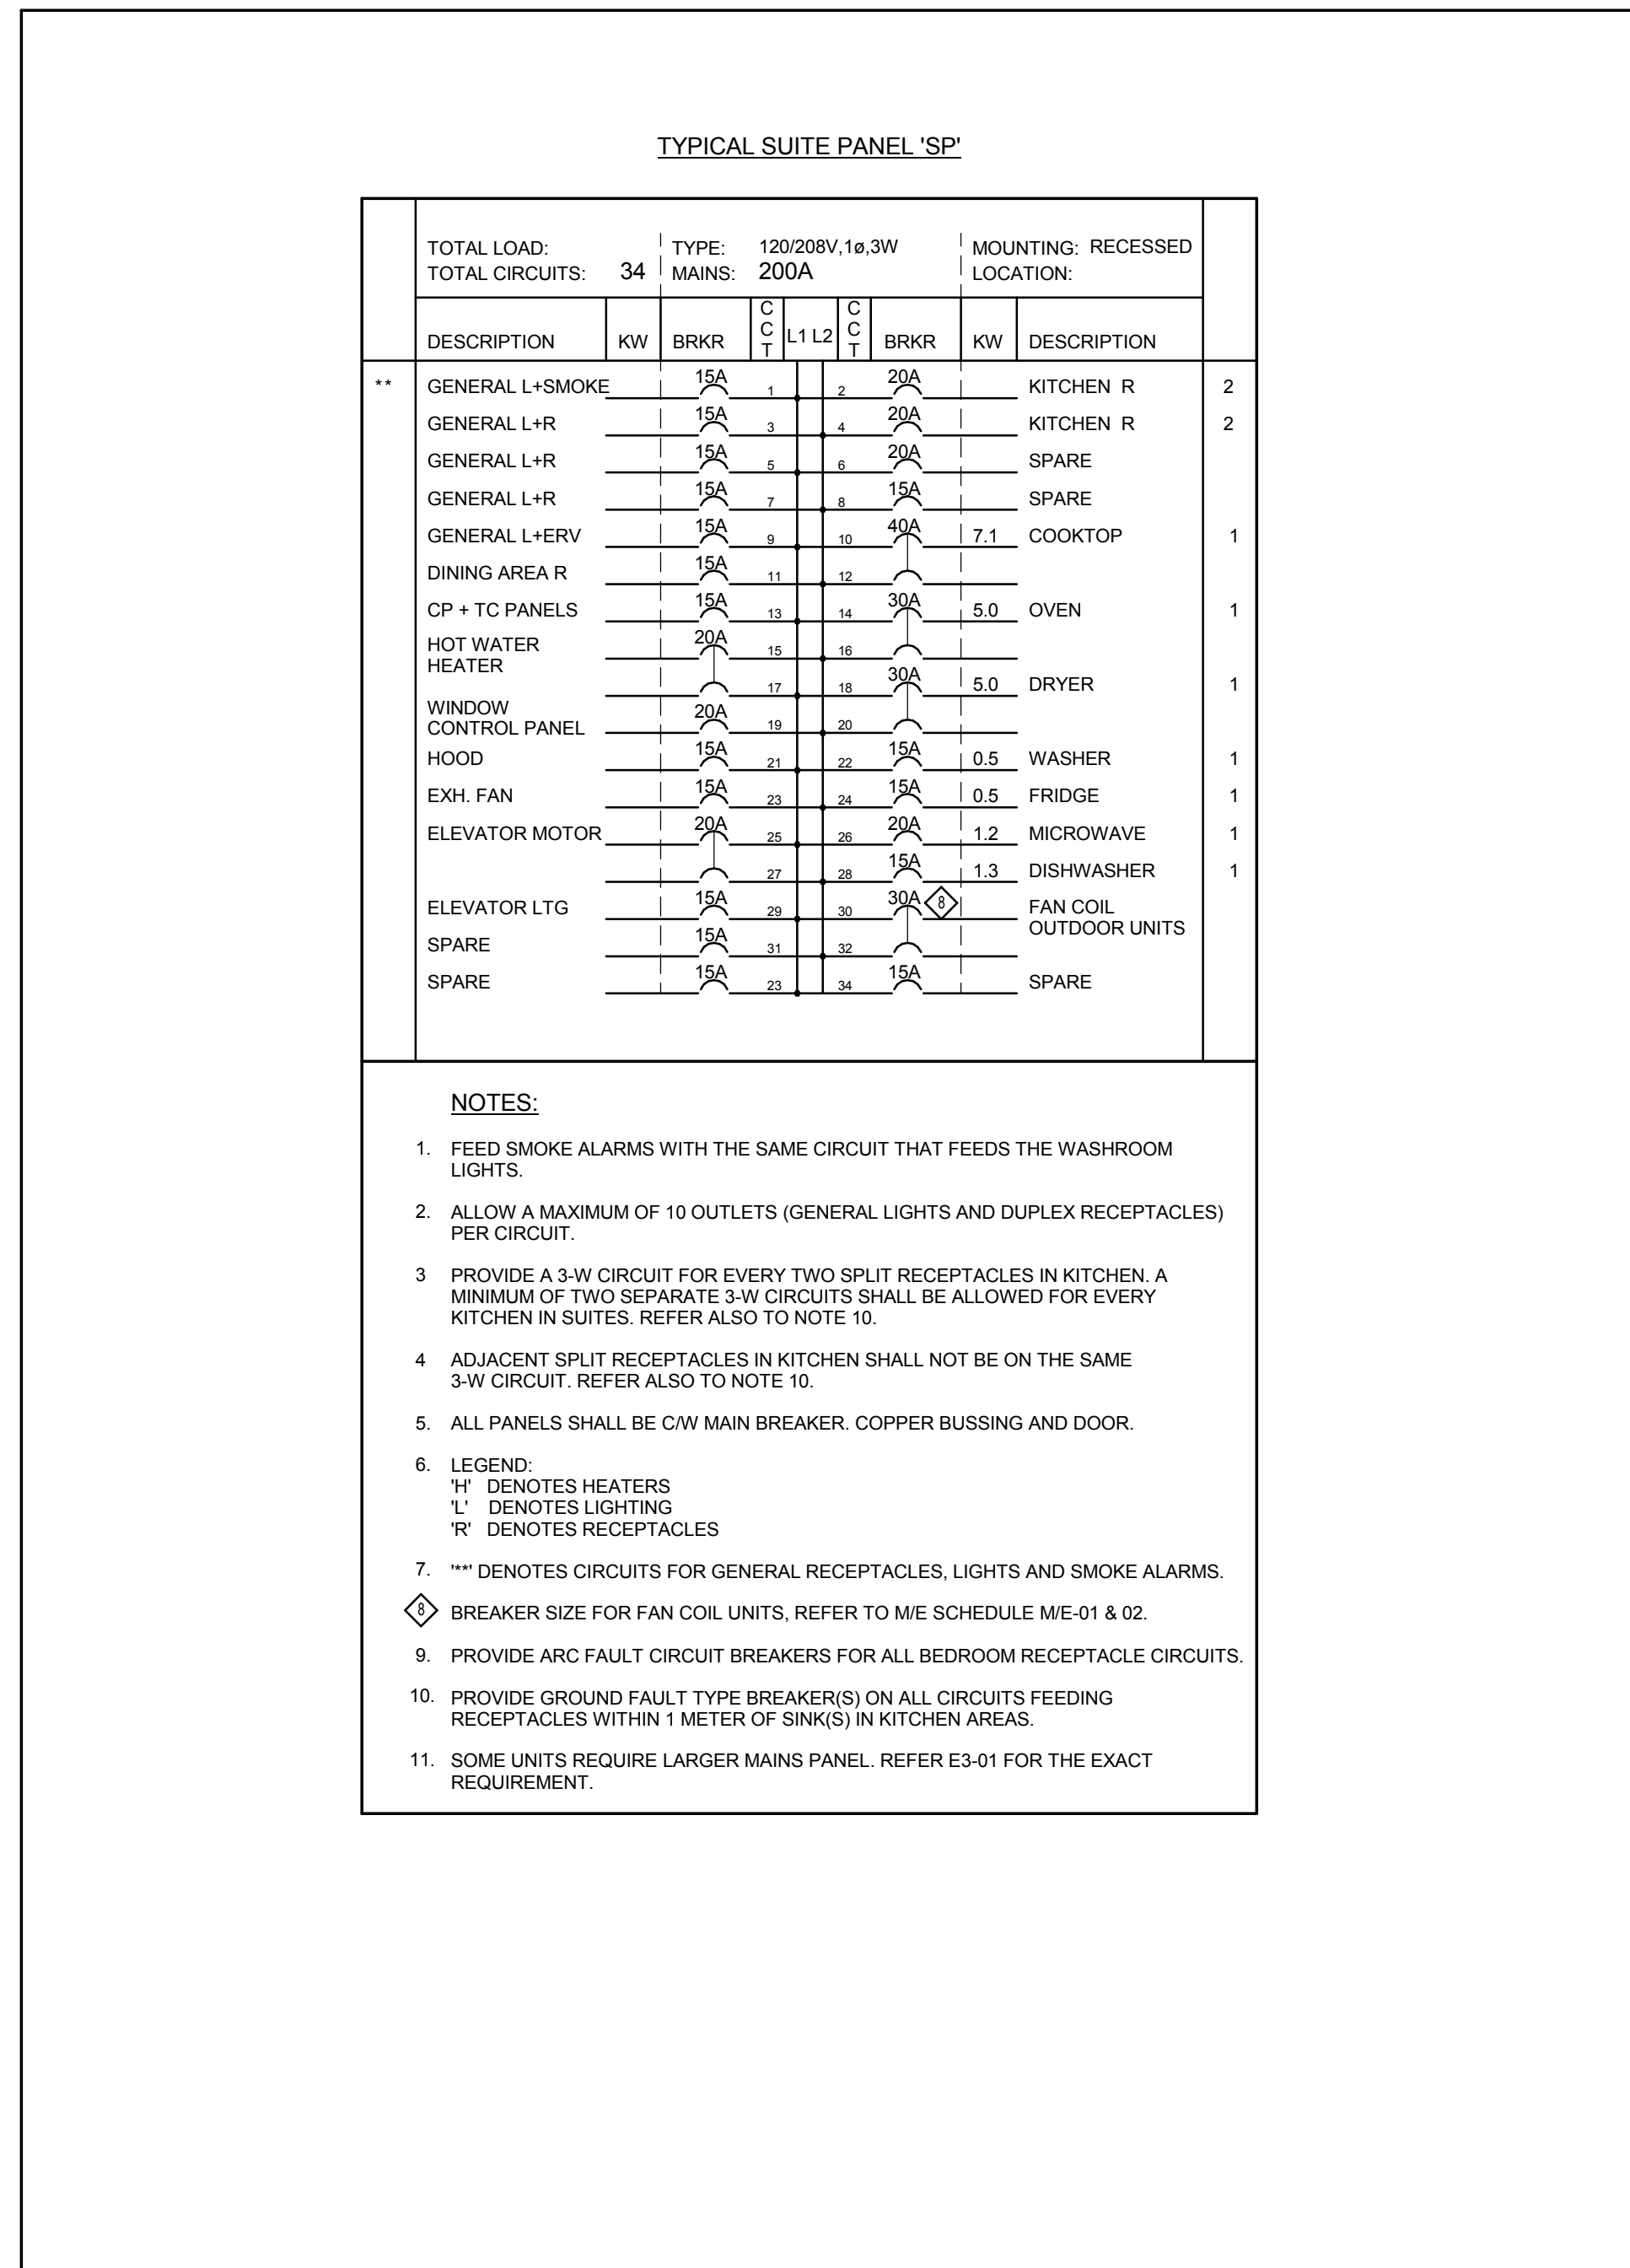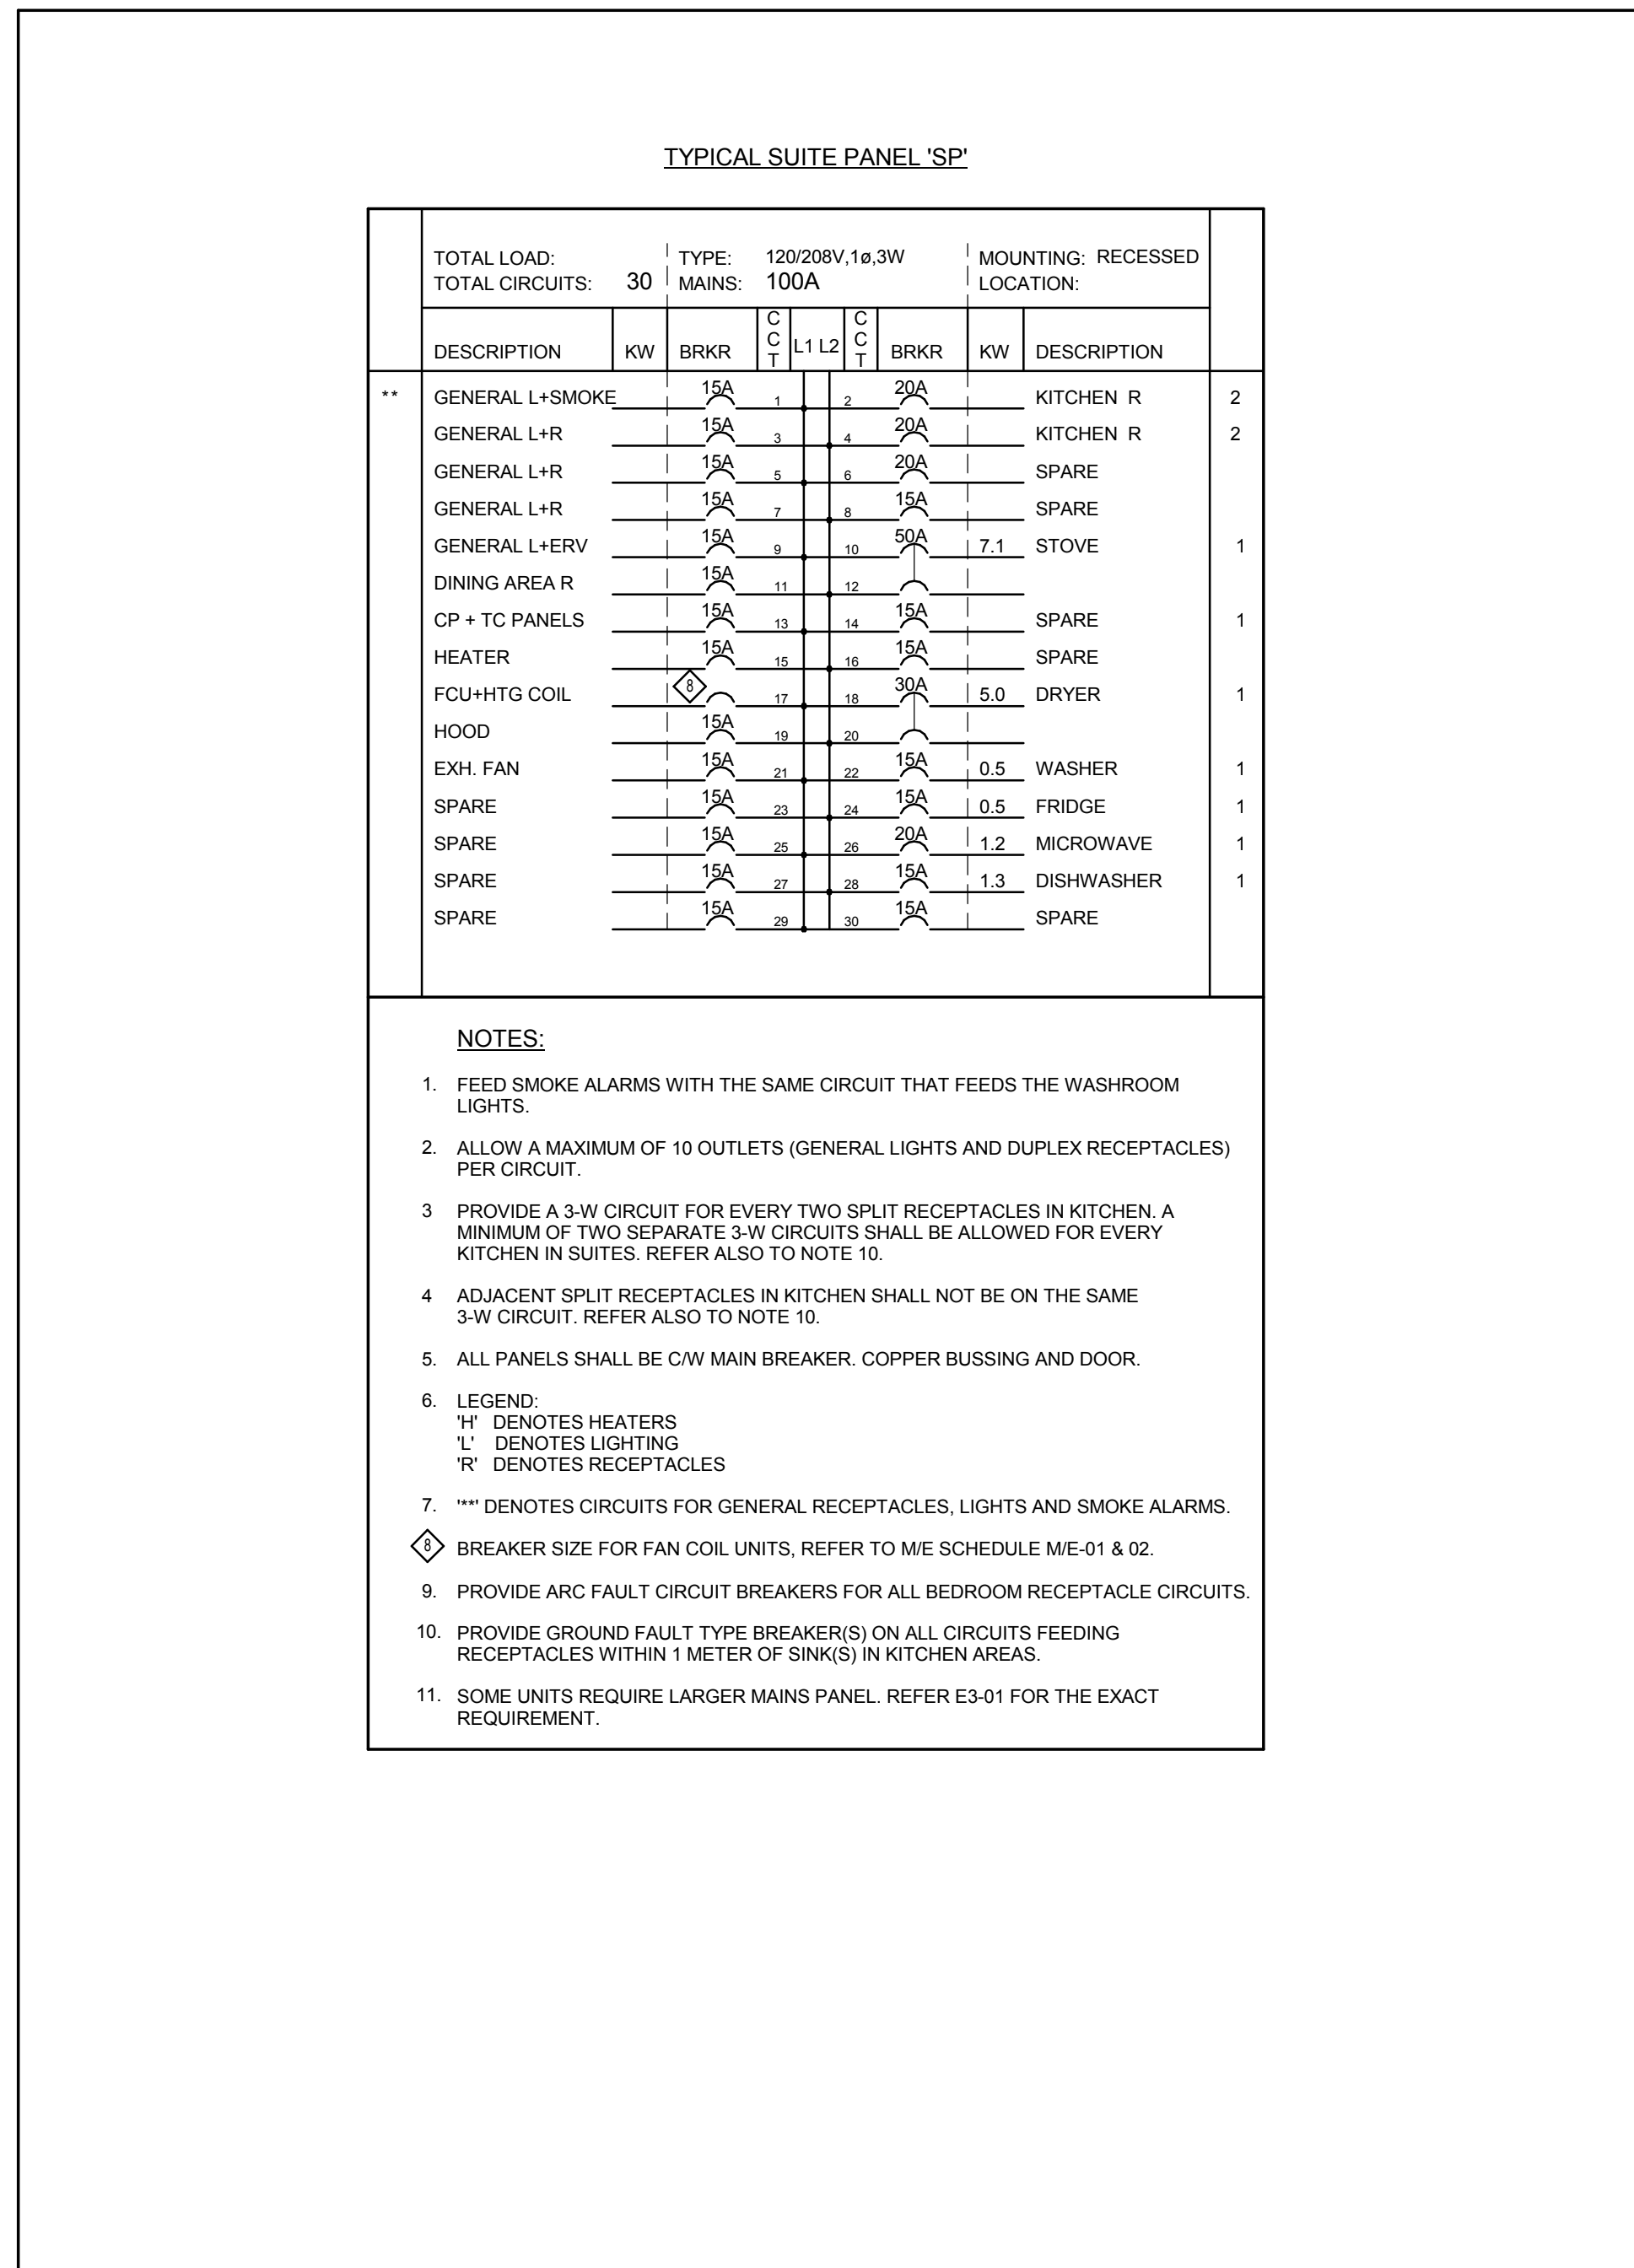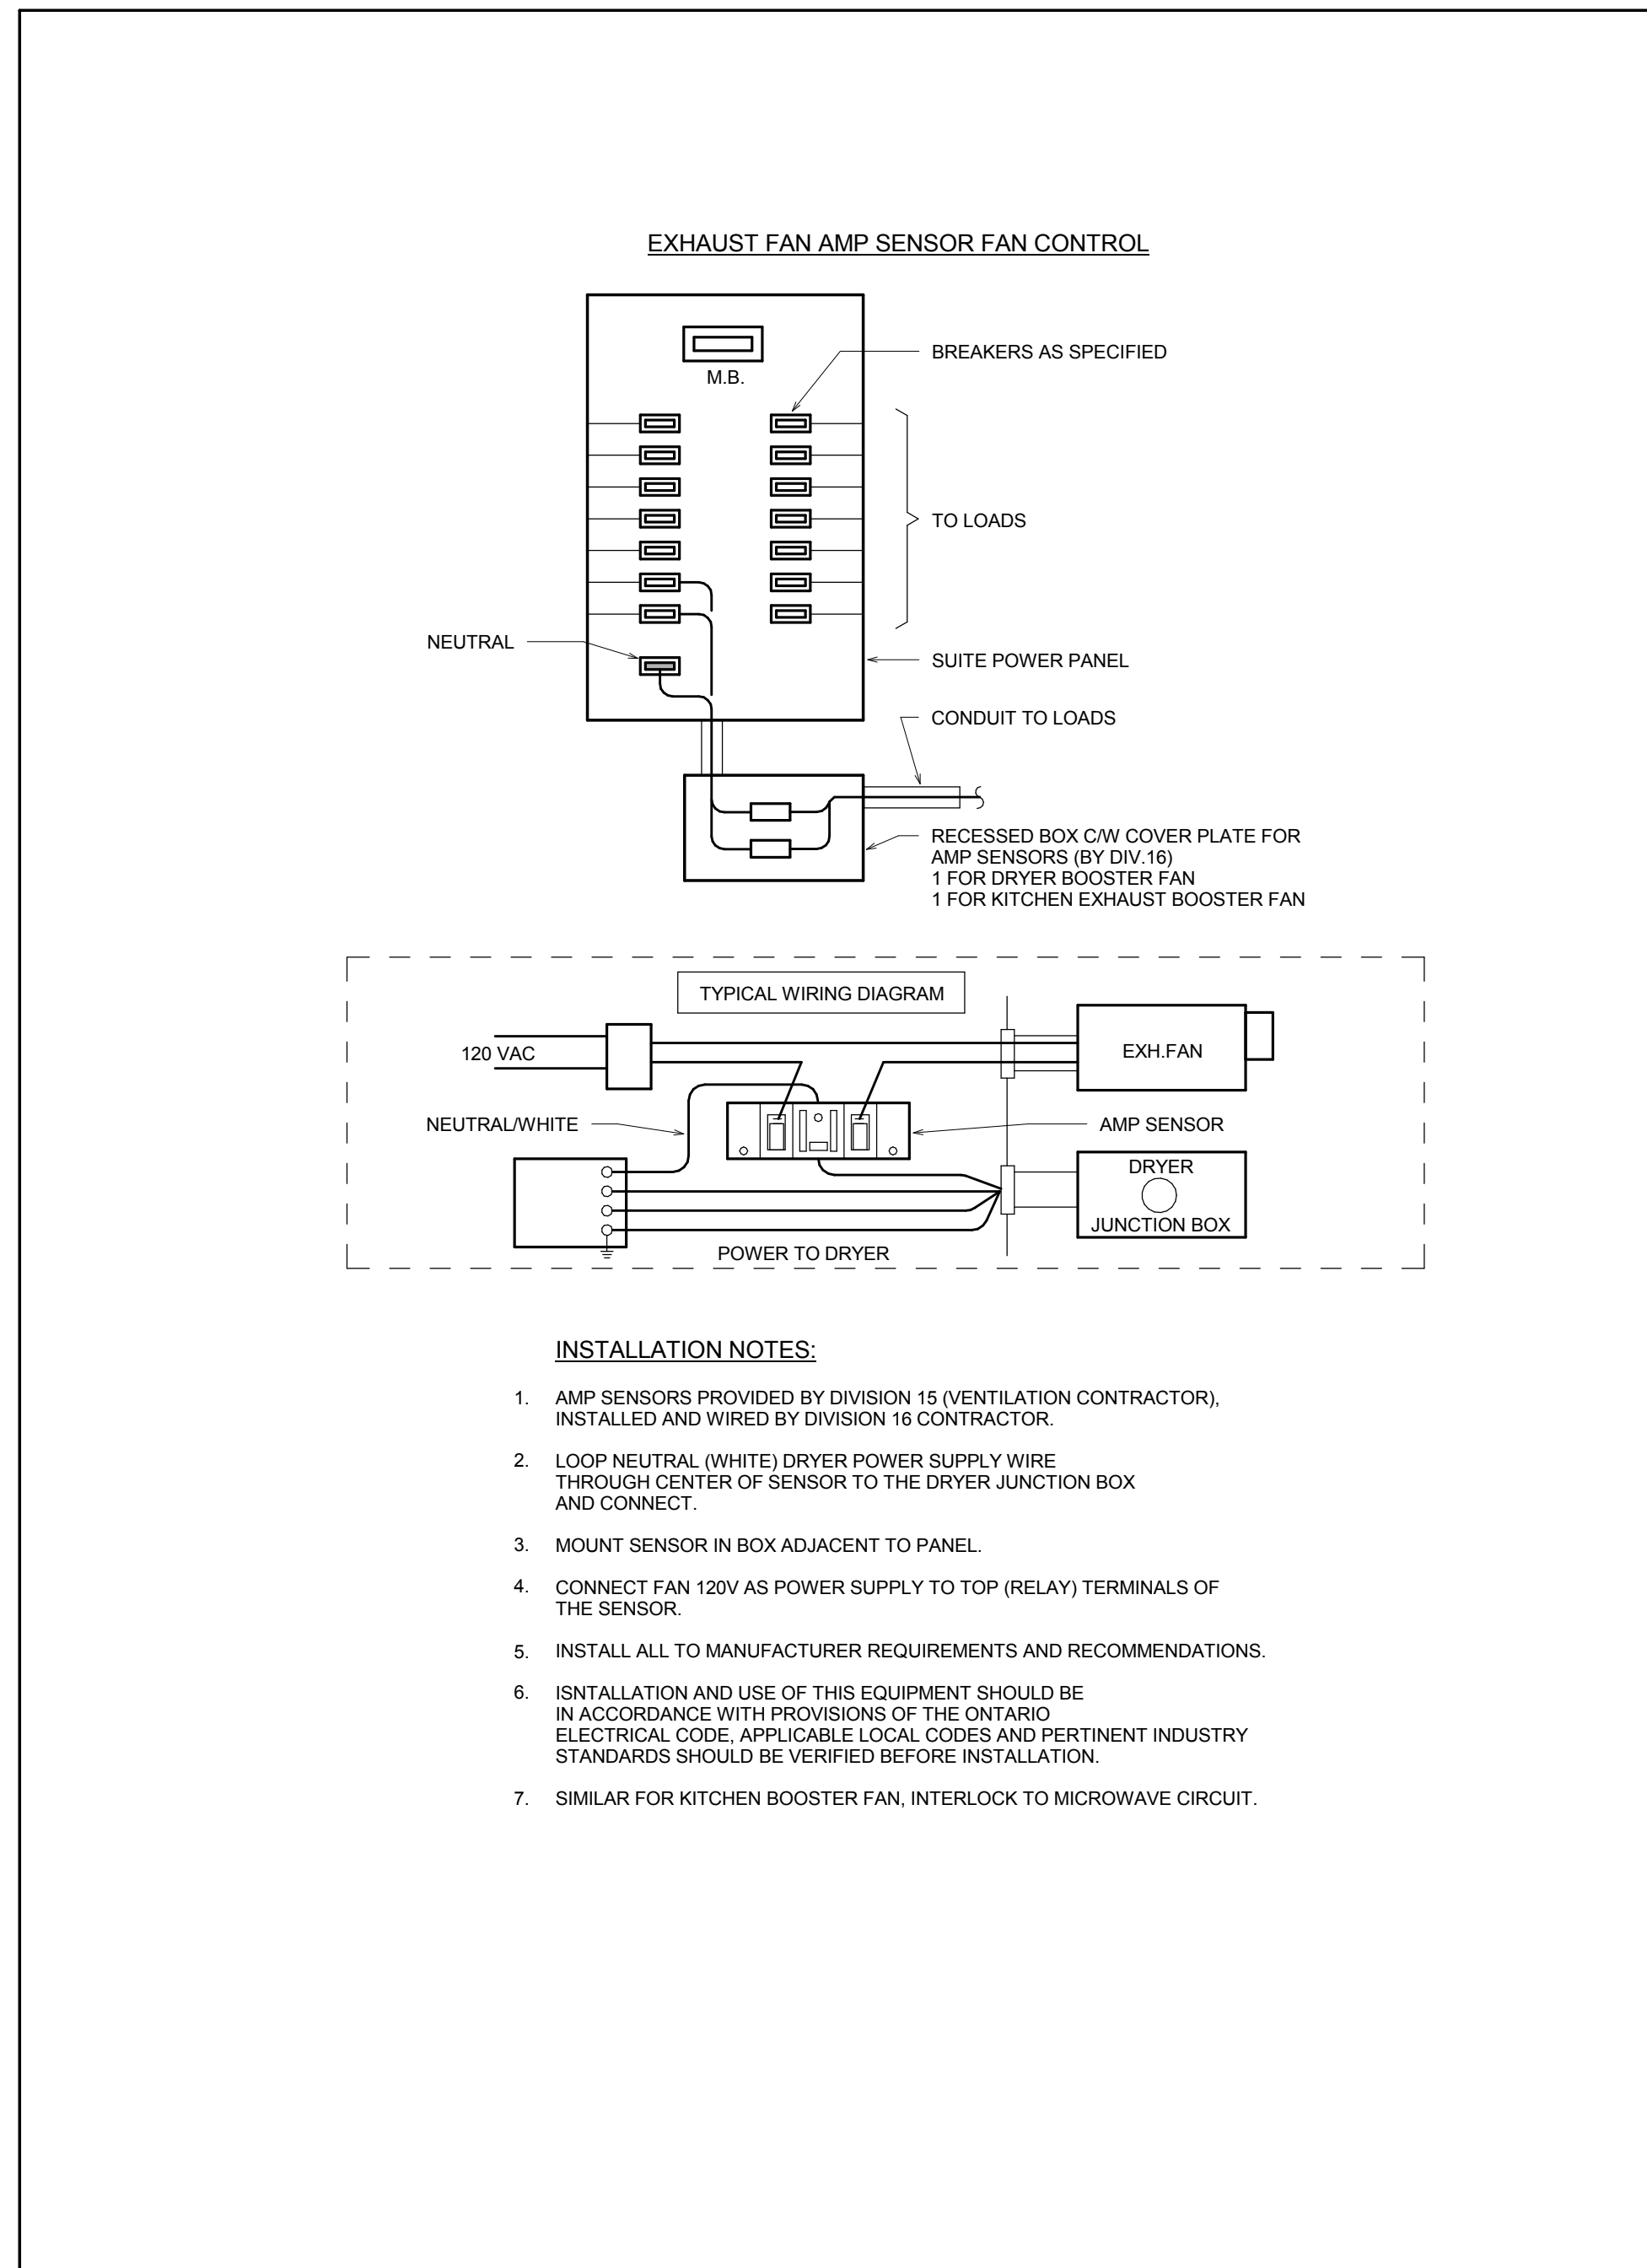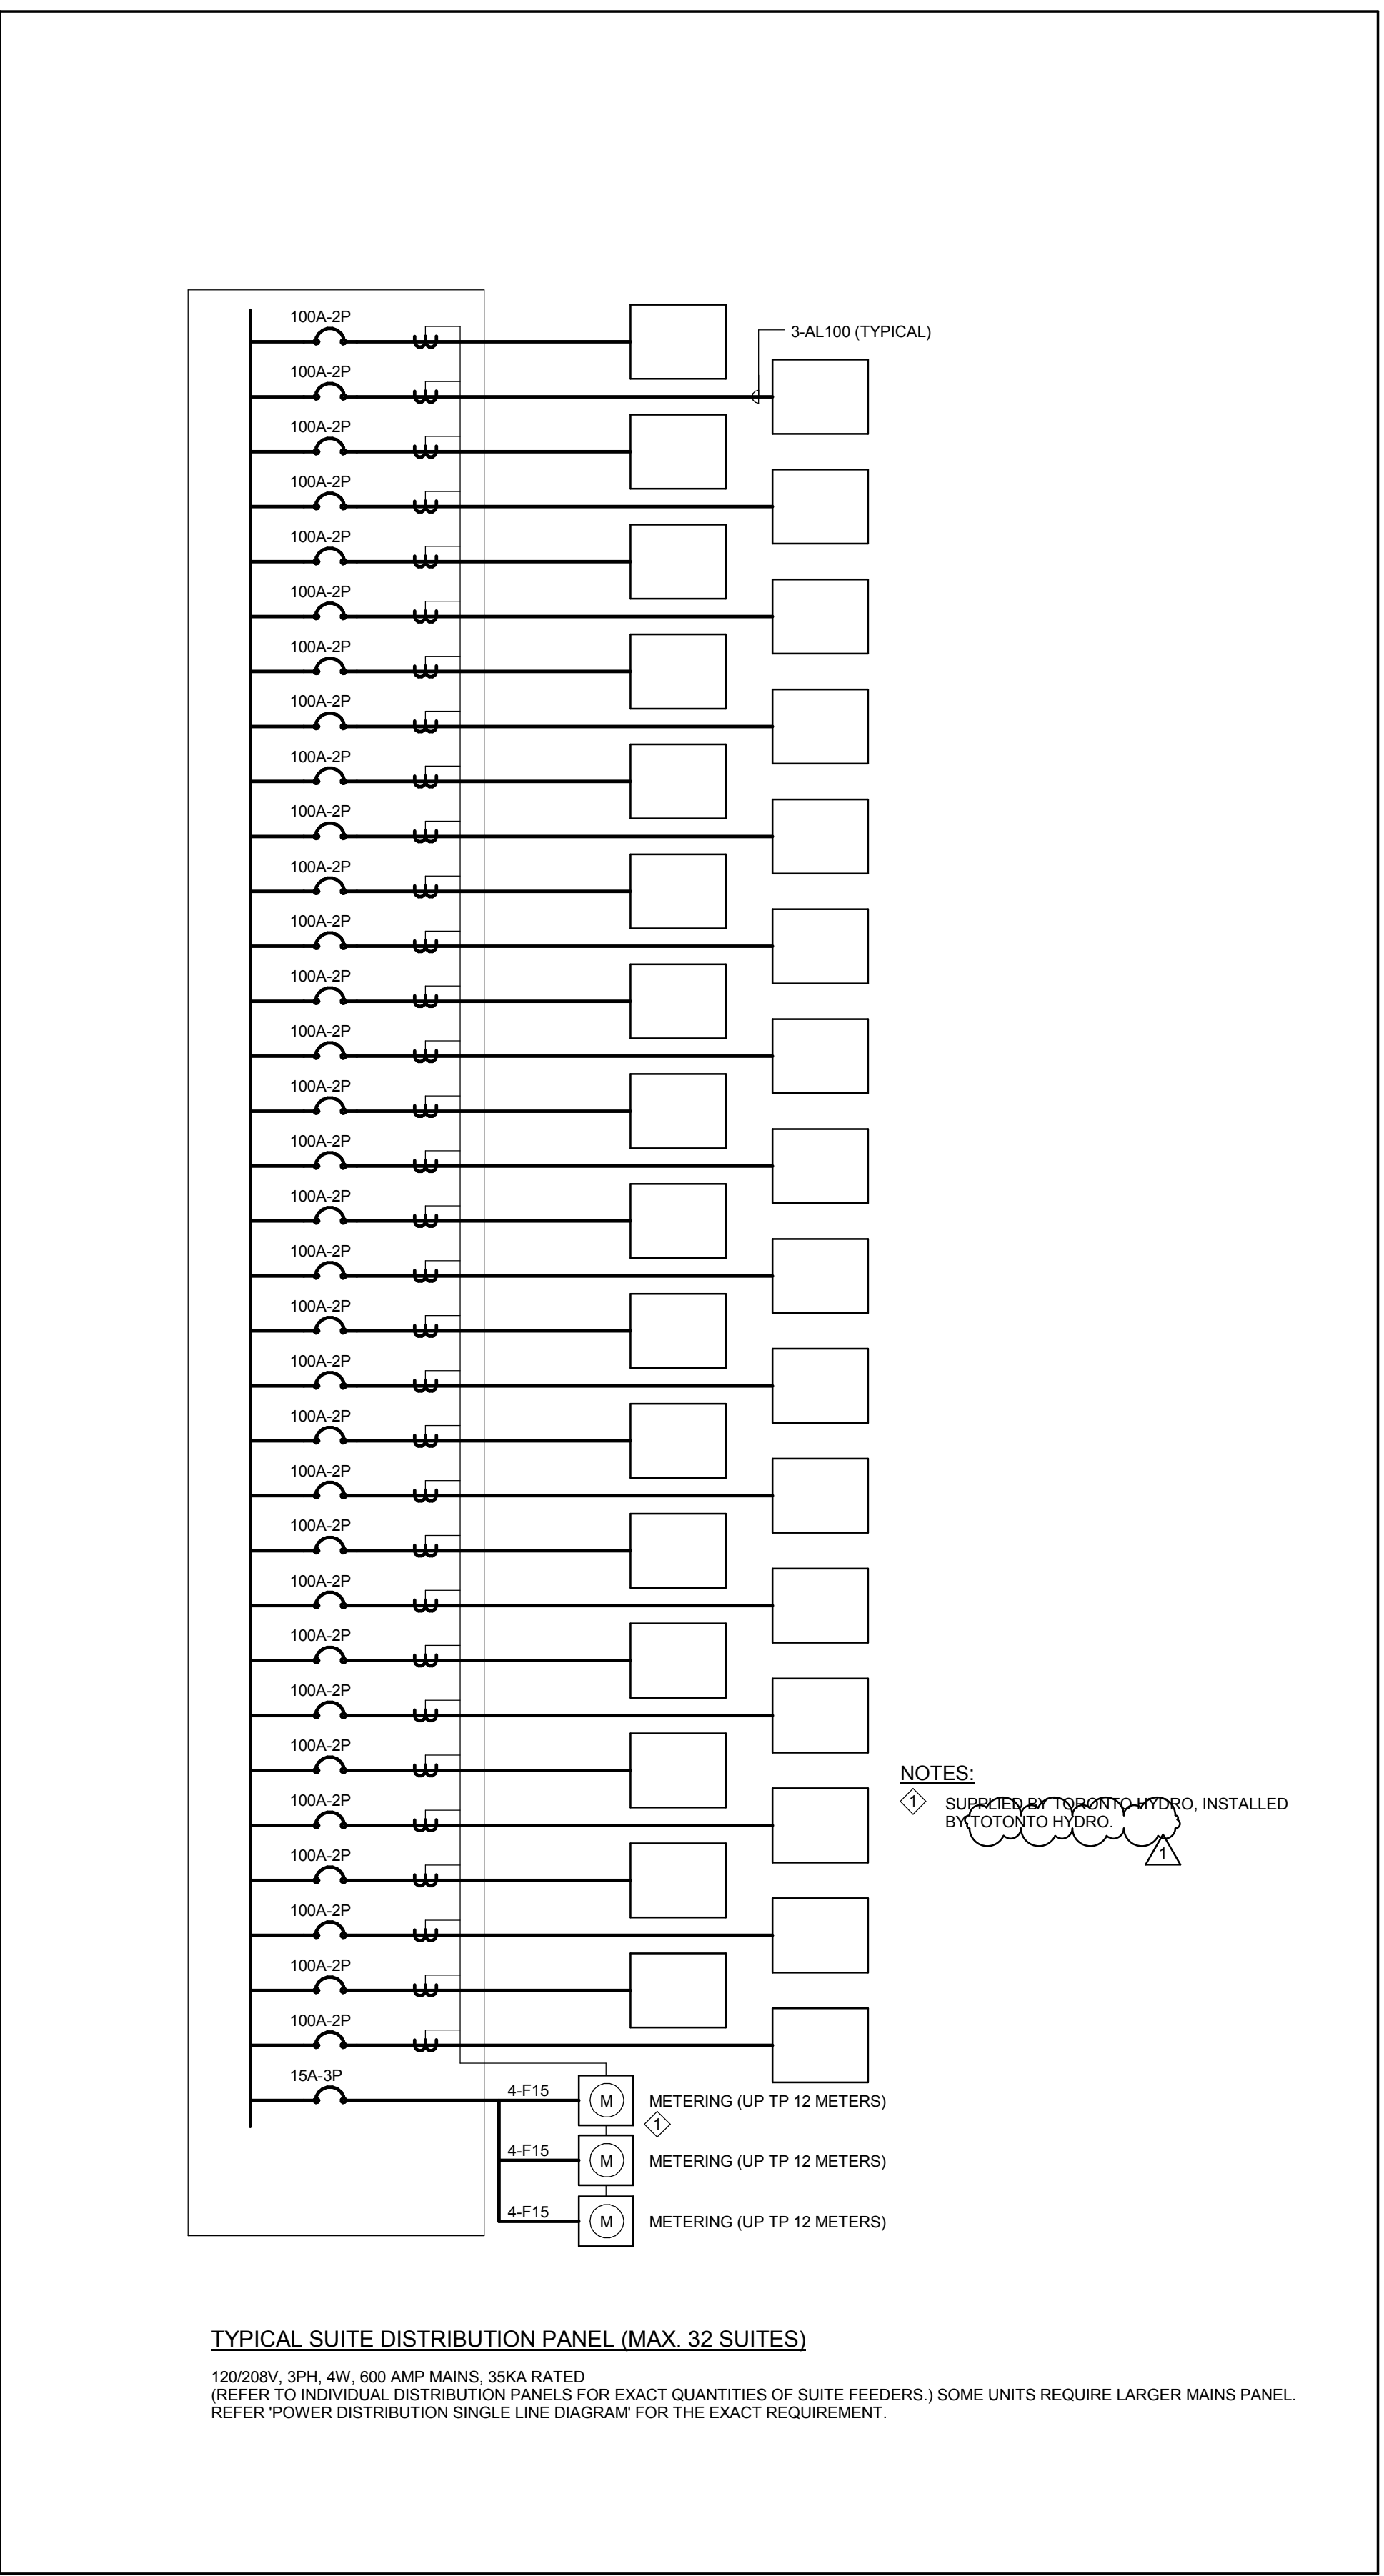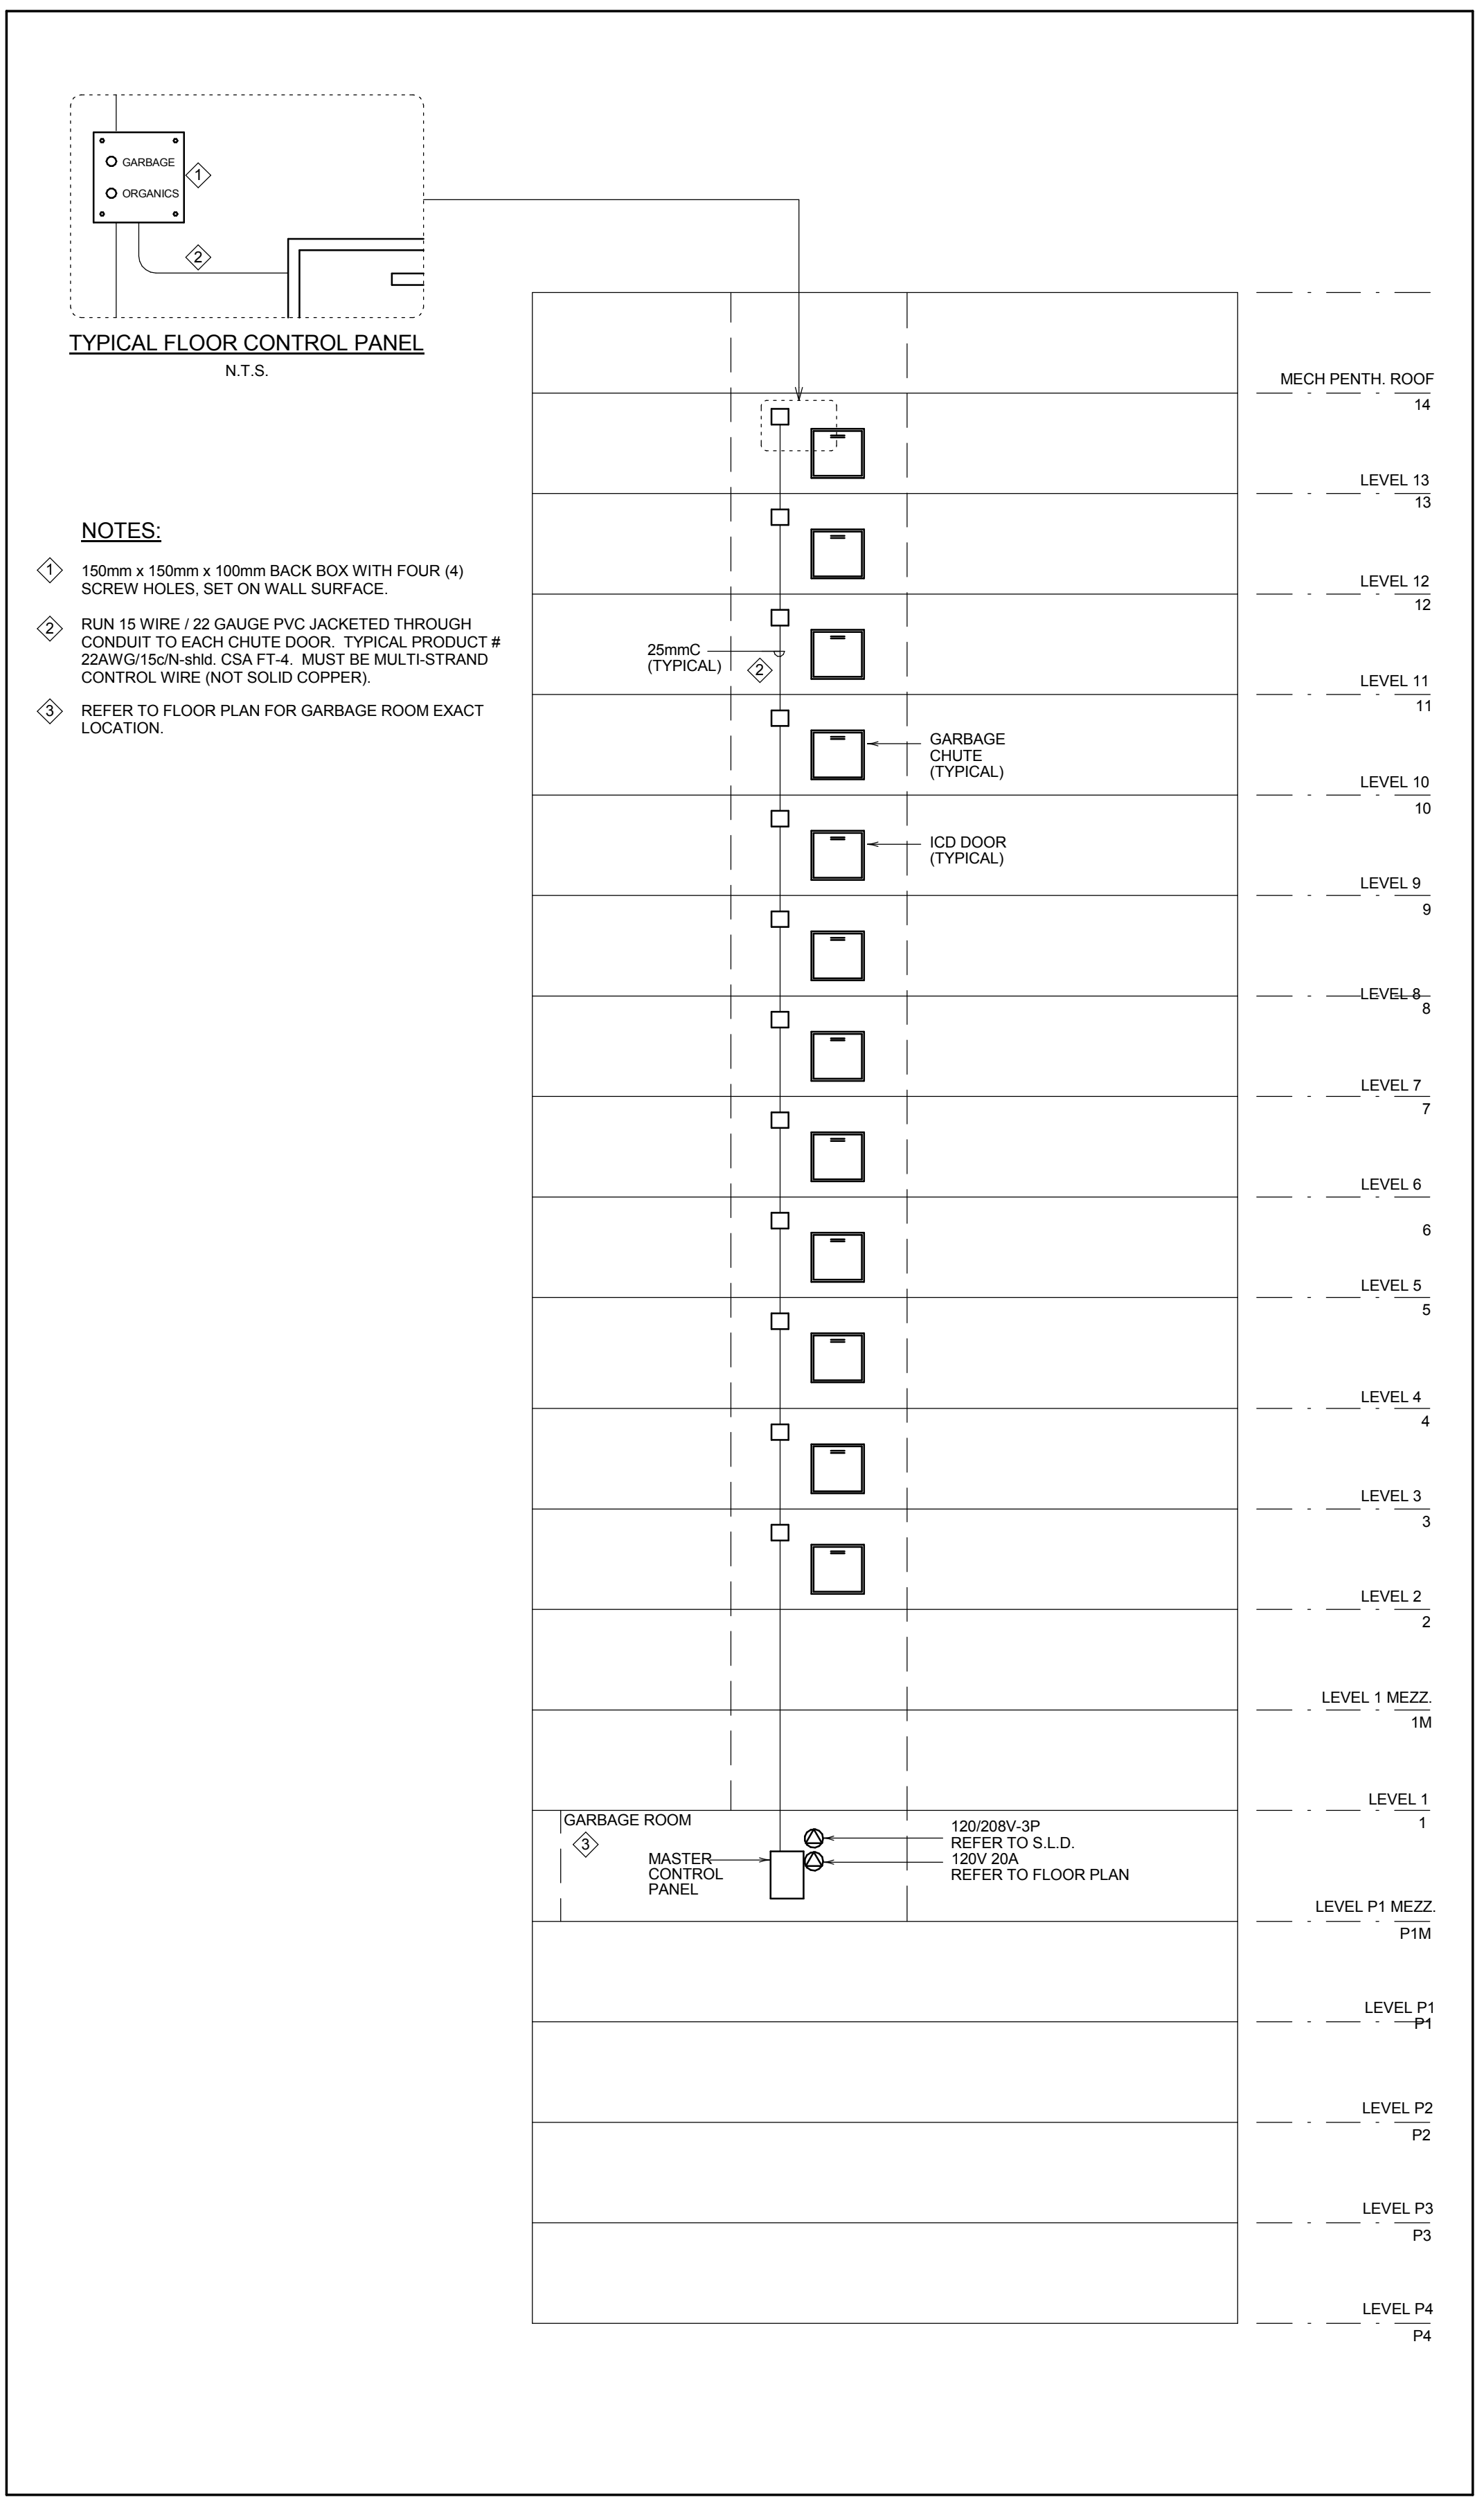

Contractor Must Check And Verify All Dimensions On The Drawings.
 On Not From The Drawings.
 All Drawings, Specifications And Related Documents Are The Copyright Of The Architect And Must Be Returned Upon Request.
 Reproduction Of Drawings, Specifications And Related Documents In Part Or In Whole Is Prohibited Without The Architect's Written Permission.
 This Drawing Is Not To Be Used For Construction Until Signed By The Architect.
 Date: 10/14/15

MCW Consultants Ltd.
 207 Queen's Quay West, Suite 615, Toronto, ON, M5J 1A7
 E-Mail: 1004.1004@mcw.com Tel: 416-596-2500 Fax: 416-596-0304
 Toronto Vancouver Winnipeg Montreal Ottawa Halifax
 Daughin Kalamita Trail Salt Lake City

No.	Revision	Date
1	ISSUED FOR SI-E08	2016/10/25

4
3
2
1

ISSUED FOR CONSTRUCTION
 ISSUED FOR TENDER
 PROJECT FOR

2016-04-21
 2015-10-26

AQUAVISTA
 AT BAYSIDE TORONTO

Drawn by: [Signature]
 Project: [Signature]
 Typical Suite Distribution Panel & Typical Suite Panel Schedules
 Block 3 - R3 & R4
 Queen's Quay East
 Toronto, ON

N.T.S.
 Author: [Signature]
 Checked by: [Signature]
 8489D
 Date: 10/14/15
 Drawing No: E4-02