



MCW Consultants Ltd.

Site Instruction

Date: May 24, 2017

Queen's Quay Terminal
207 Queen's Quay West, Suite 615
Toronto, Ontario M5J 1A7

Phone (416) 598-2920
Fax (416) 598-5394
www.mcw.com

Project Name: AQUAVISTA - Bayside
Client: TRIDEL Corporation
To: TRIDEL Corporation
Attention: Chadi Loza
Fax number: -

Project No.: 8489D
SI No.: E 021
Page No.: 1 of 1+ 1 attached
Office: Toronto
From: Sunanda Perera
Tao Li

Distribution: Vince Mirarchi –TRIDEL
Chadi Loza - TRIDEL
Christina Lee -KIRKOR
Al Medeiros –MCW
Michael Hunter-MCW
Mark Furtado-MCW
Sarfray H. Jaffrey-MCW

Provide itemized labour, equipment and material costs for Work listed below. Do not proceed with any of the listed Work prior to issuance of signed Change Order.

Title: Revision – Artscape Security System Riser

Specification:

Spec	Issued	Items
		N/A

Electrical:


Drawing No.	Drawing Issued	Items
E4-06	Yes	Delete typical suite riser conduits to Artscape security system as shown.

ME Schedule:


Drawing No.	Drawing Issued	Items
		N/A

Reason for Issue – Design Coordination.


End of SI-E021

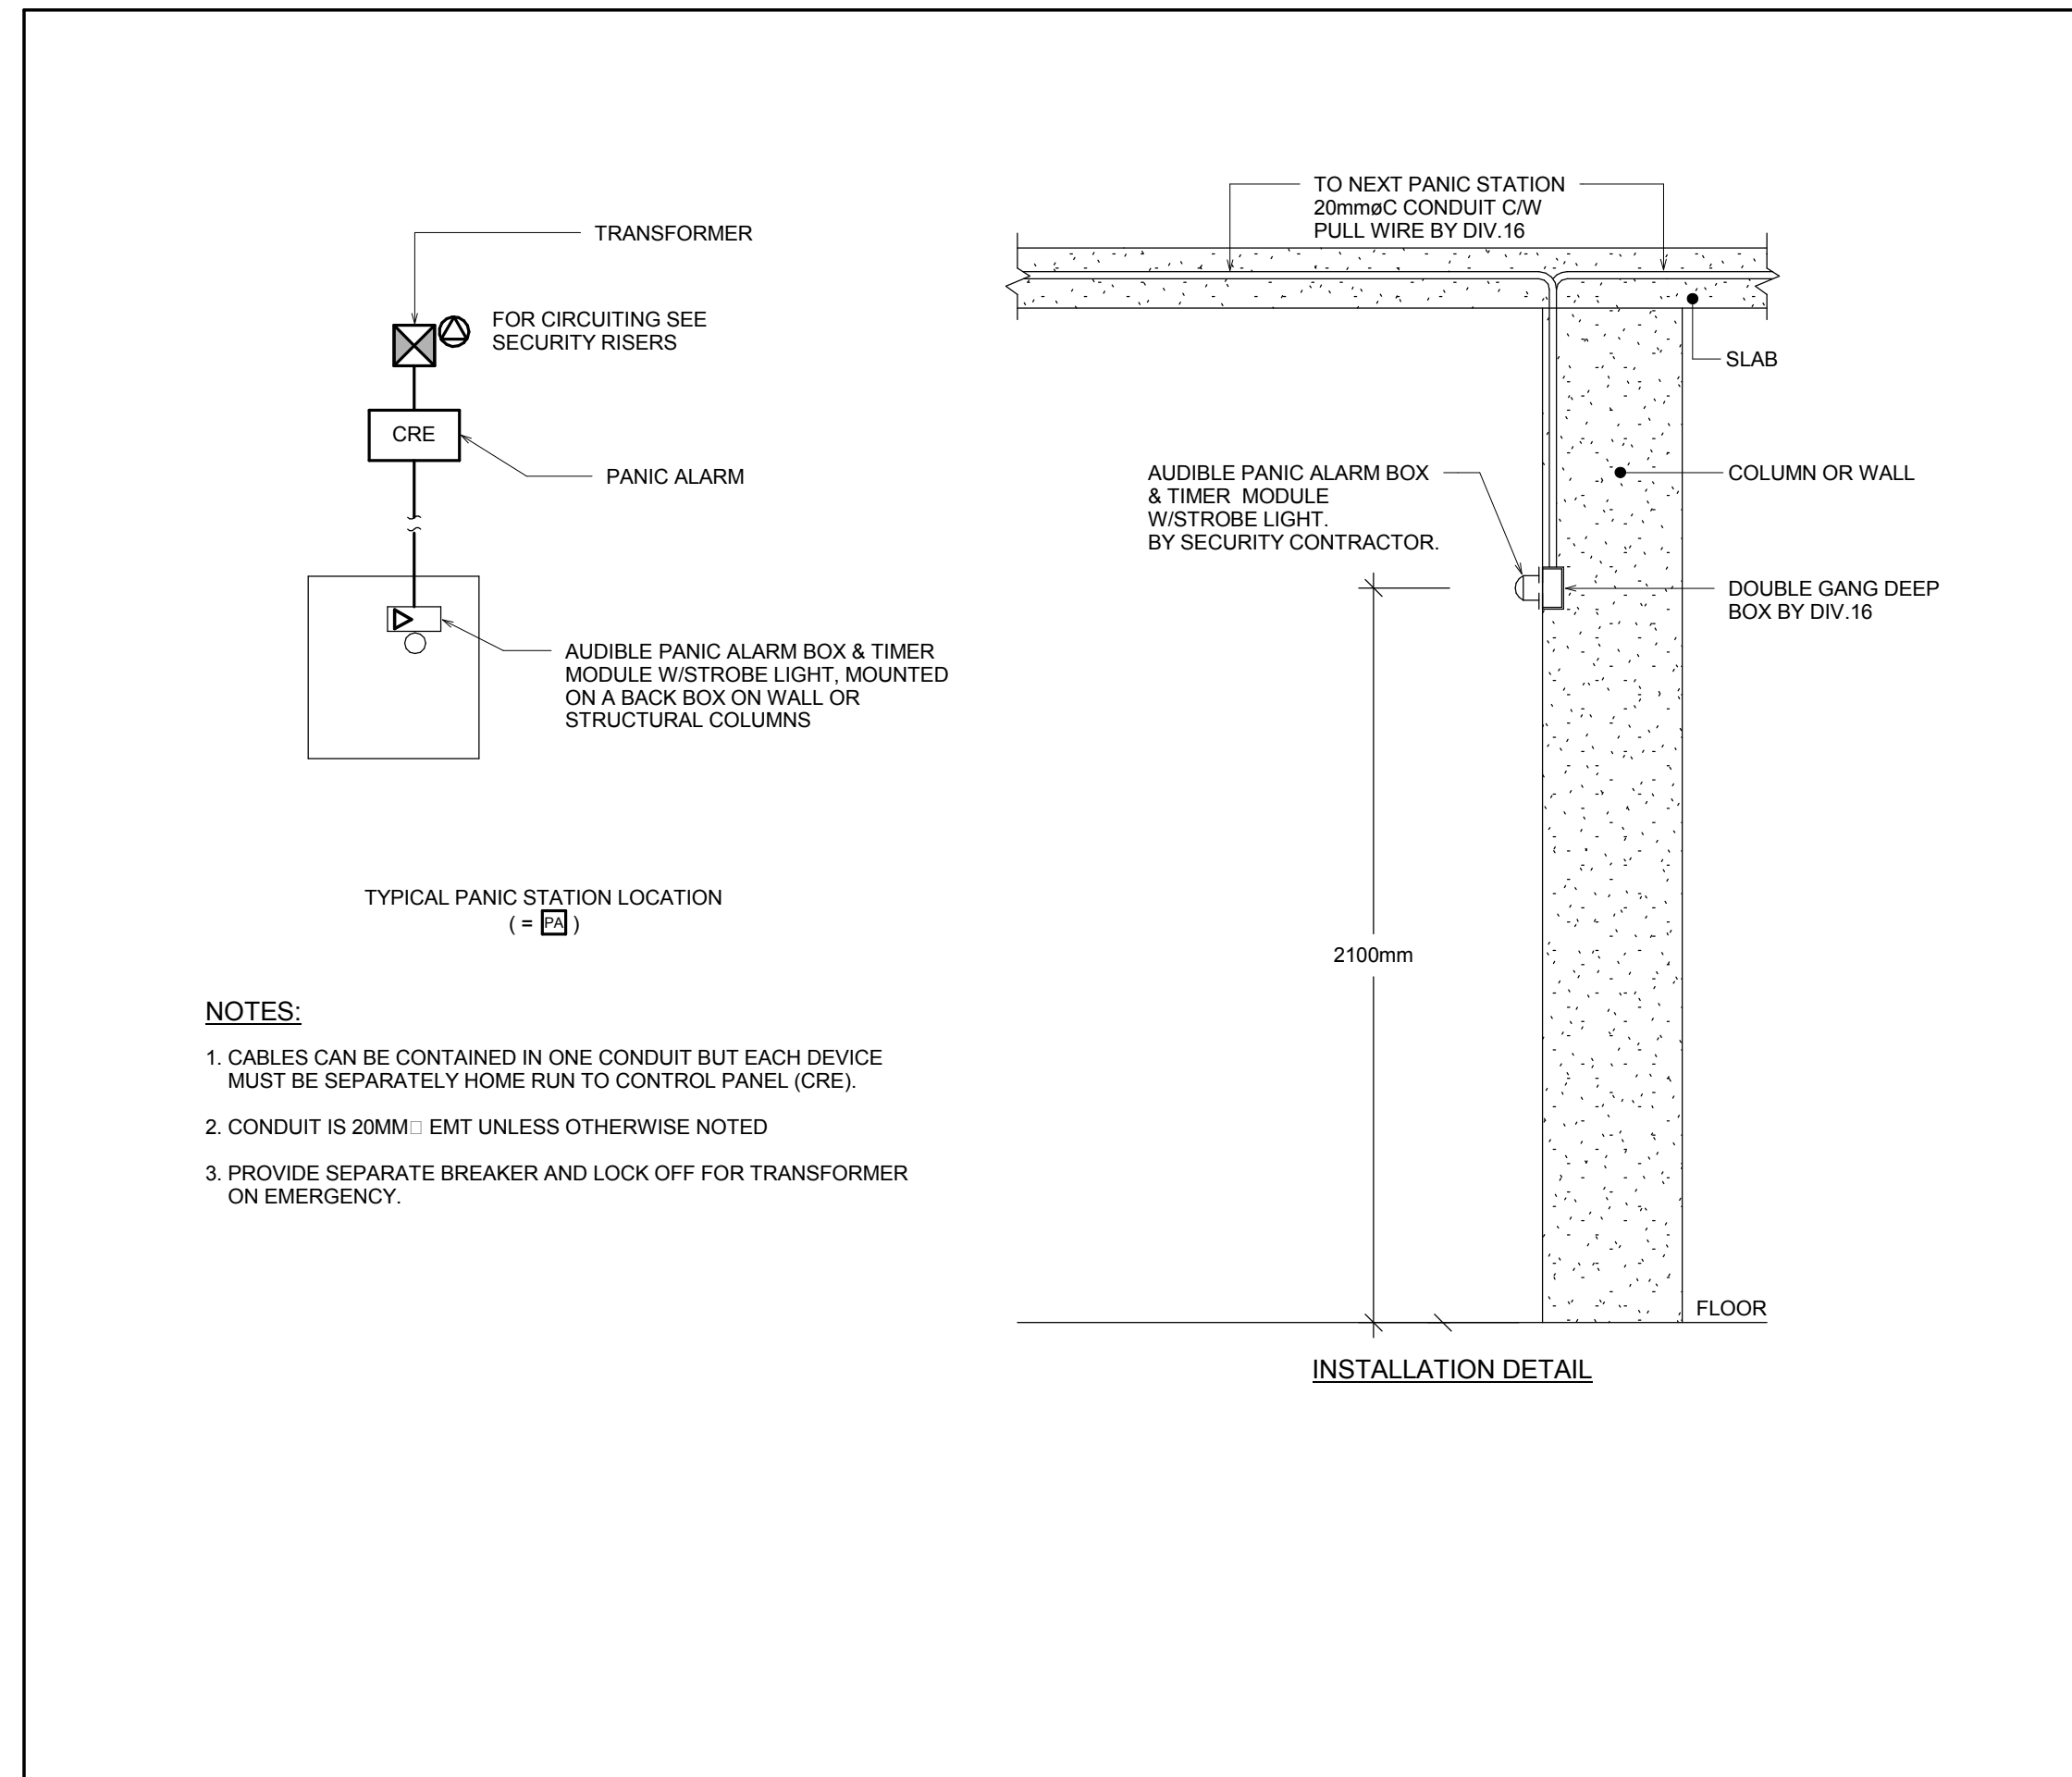


12 PANIC ALARM SYSTEM DETAILS
1:1

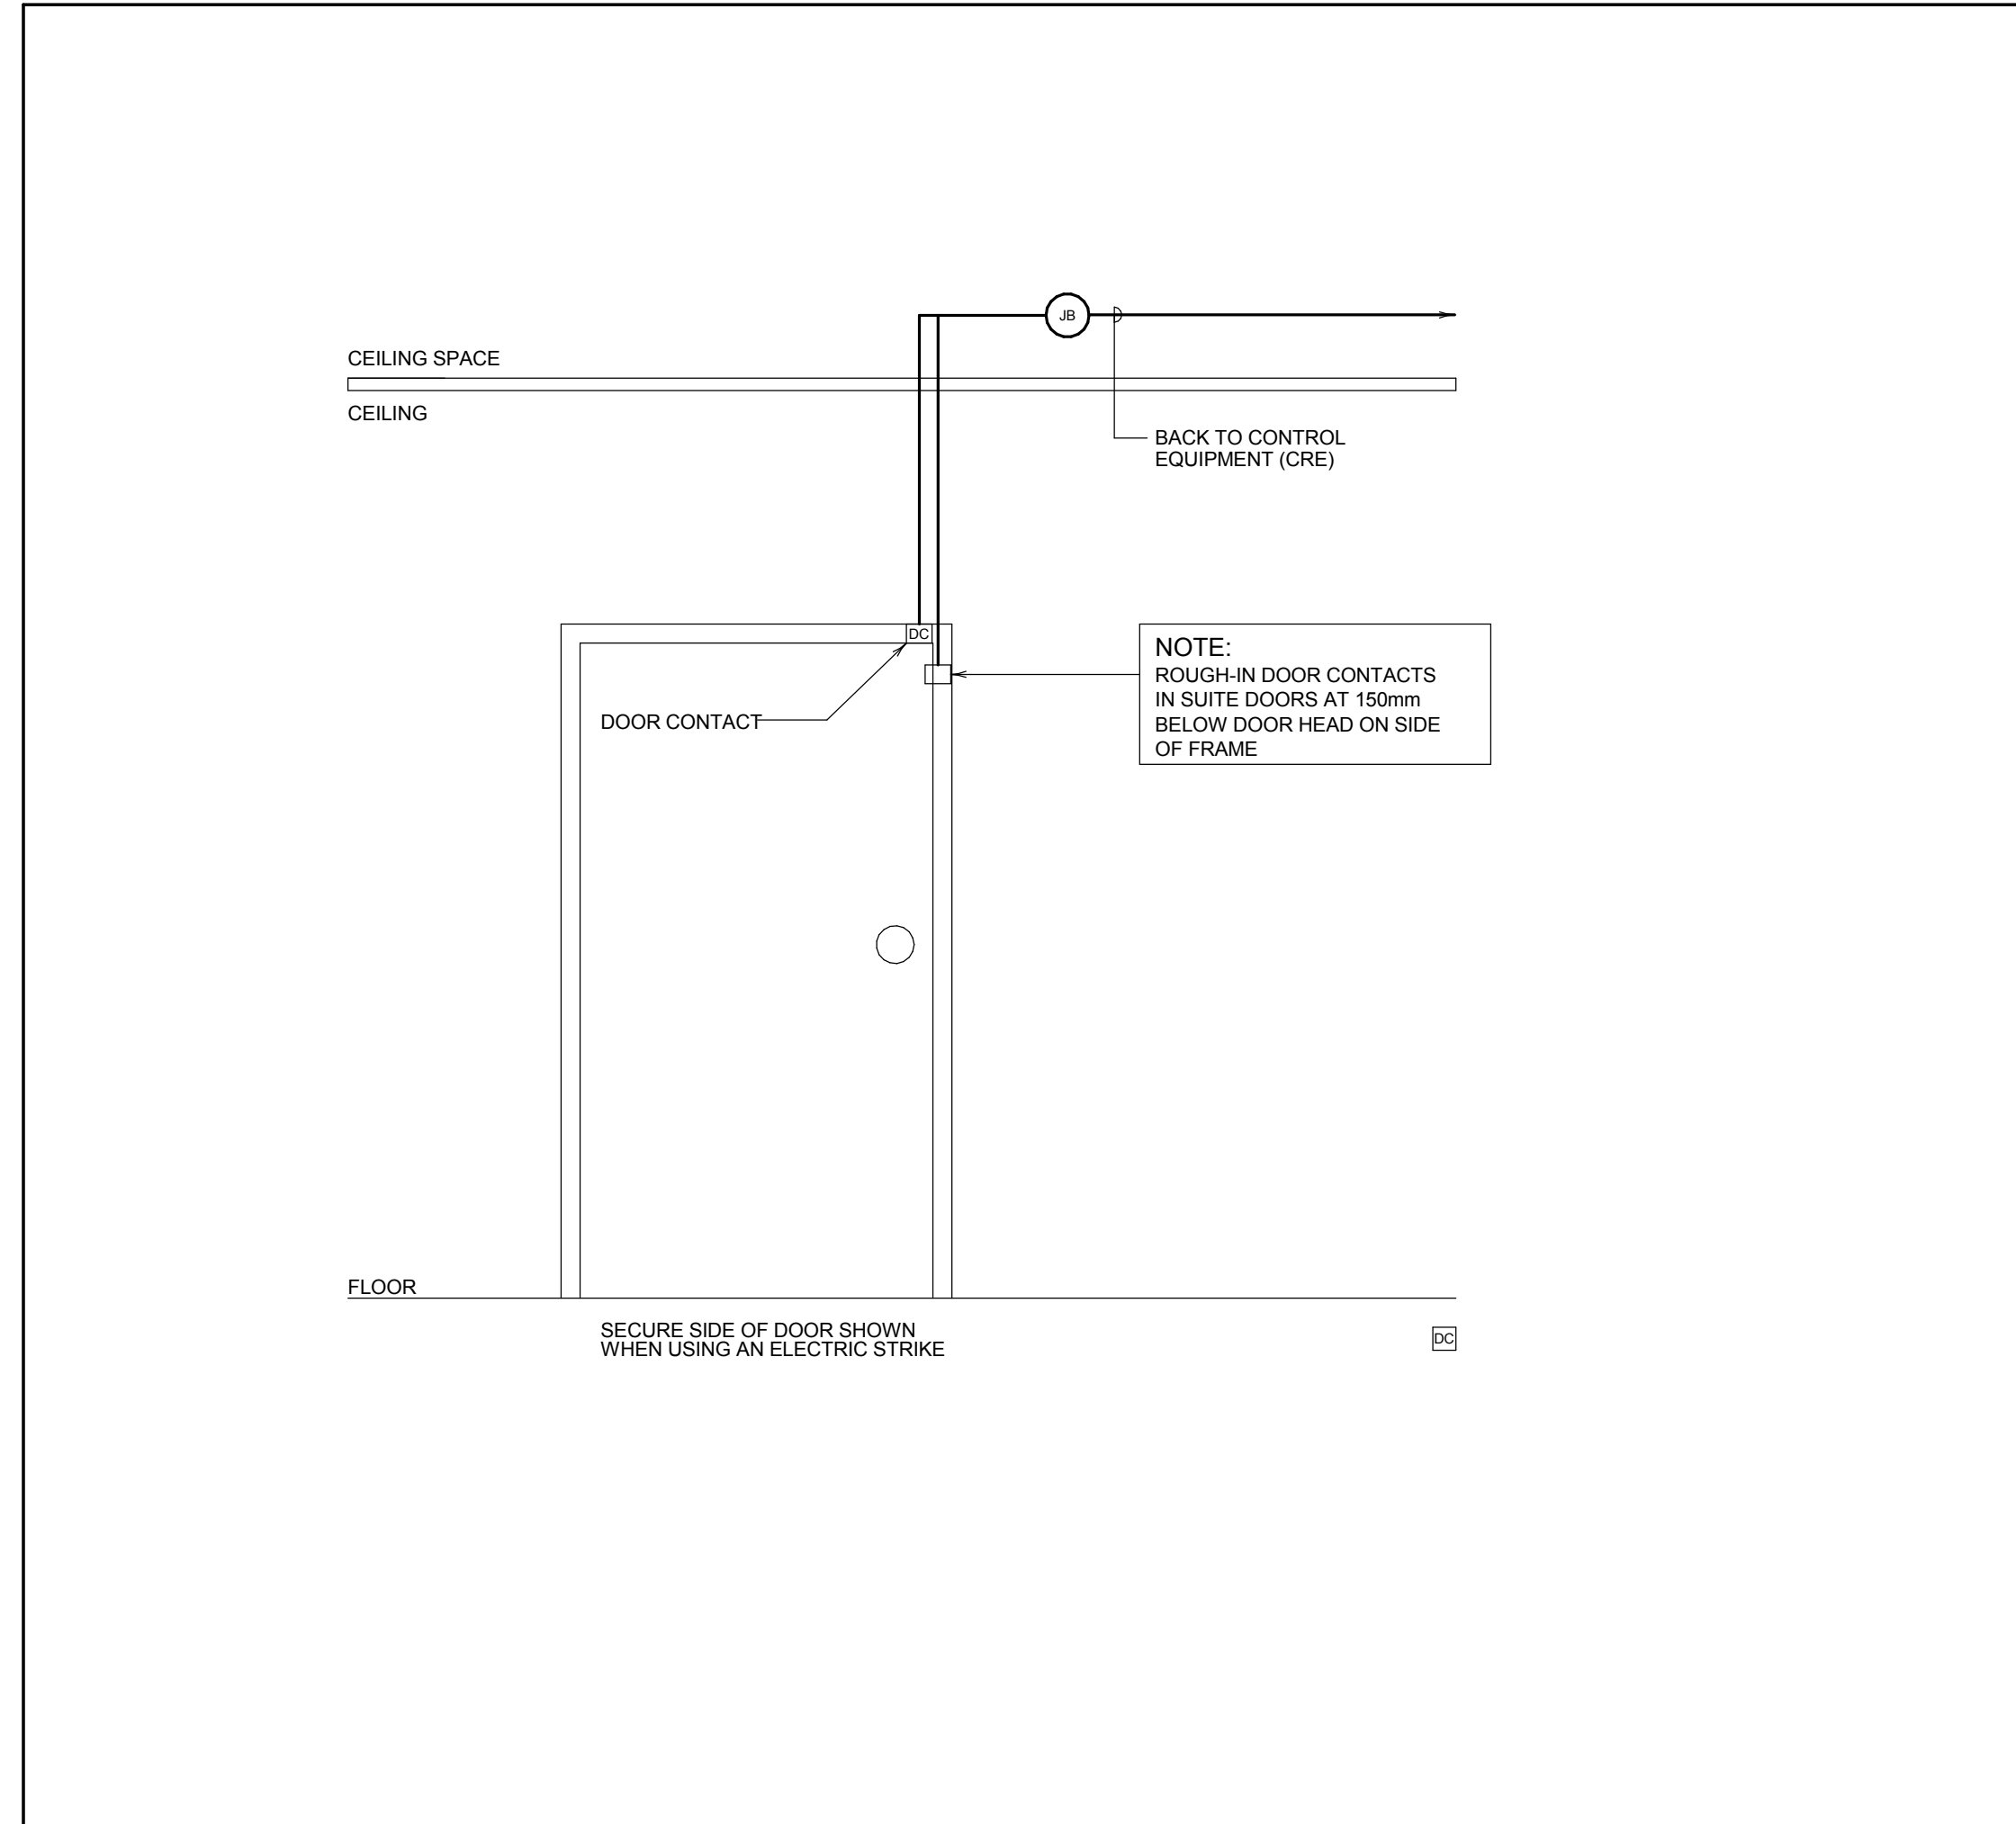


11 SECURED SINGLE DOOR WITH DOOR CONTACT
N.T.S.

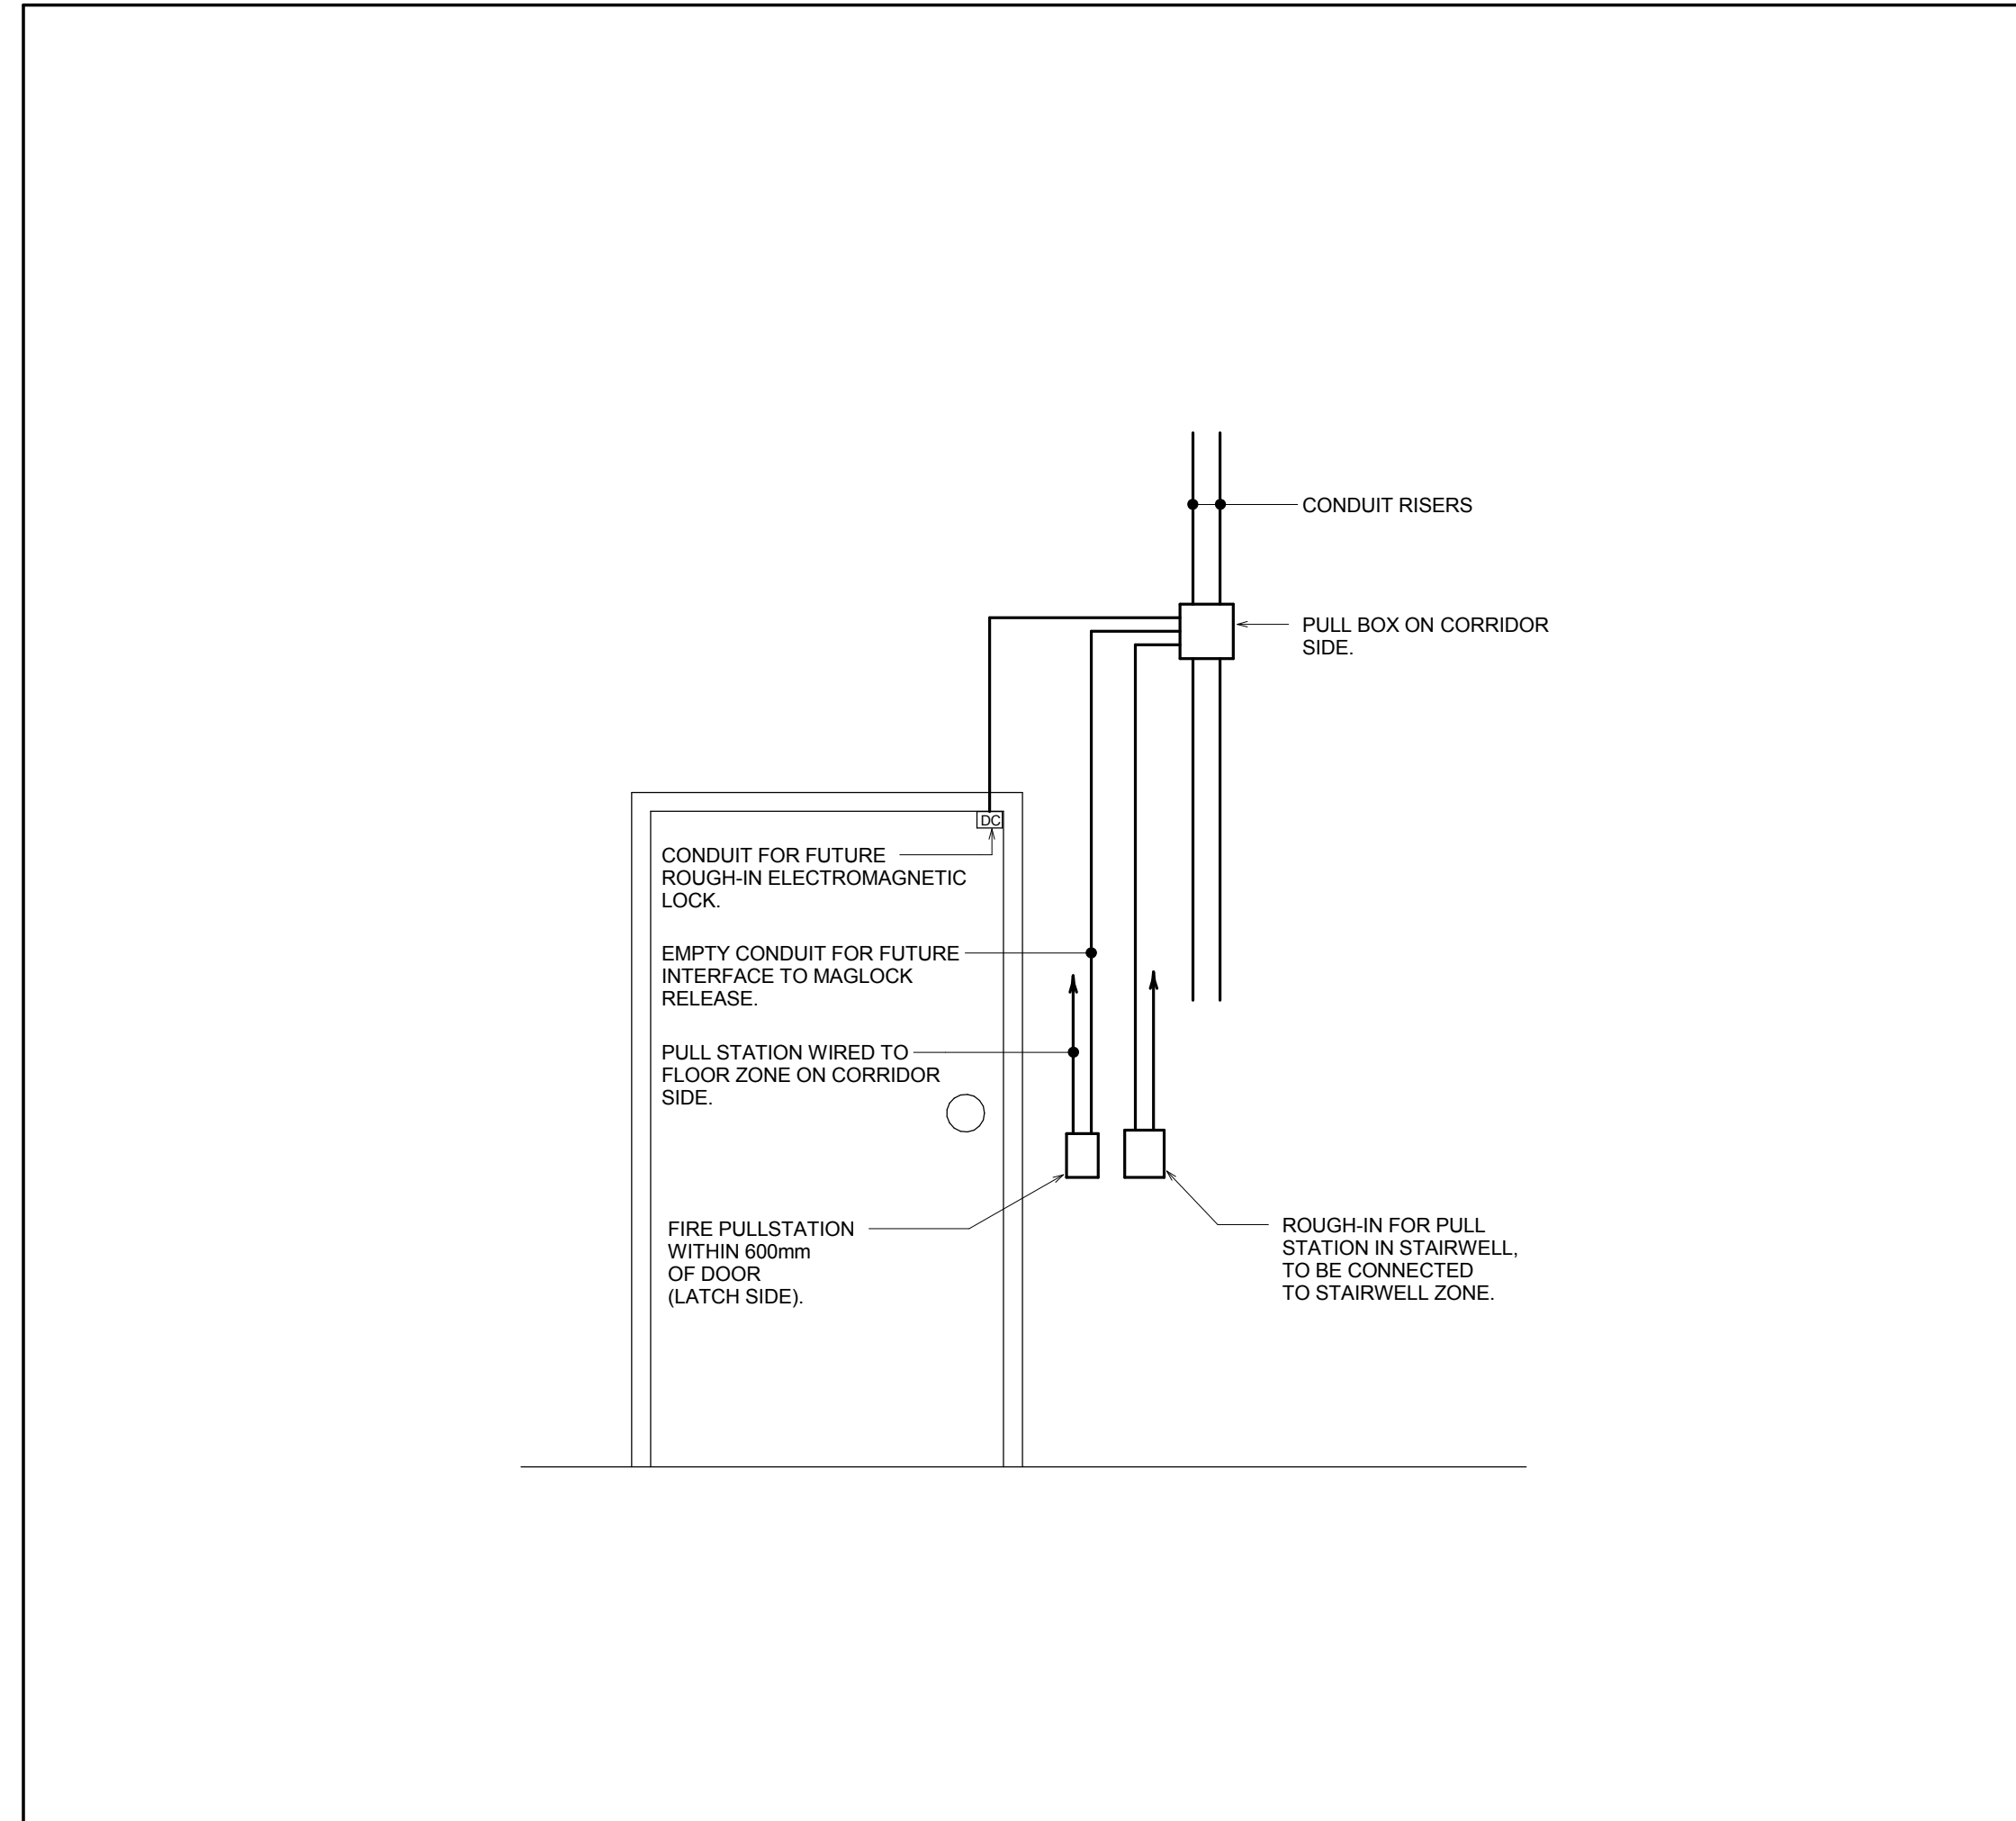


10 ROUGH-IN REQUIREMENTS AT CROSS-OVER DOOR LOCATION
N.T.S.

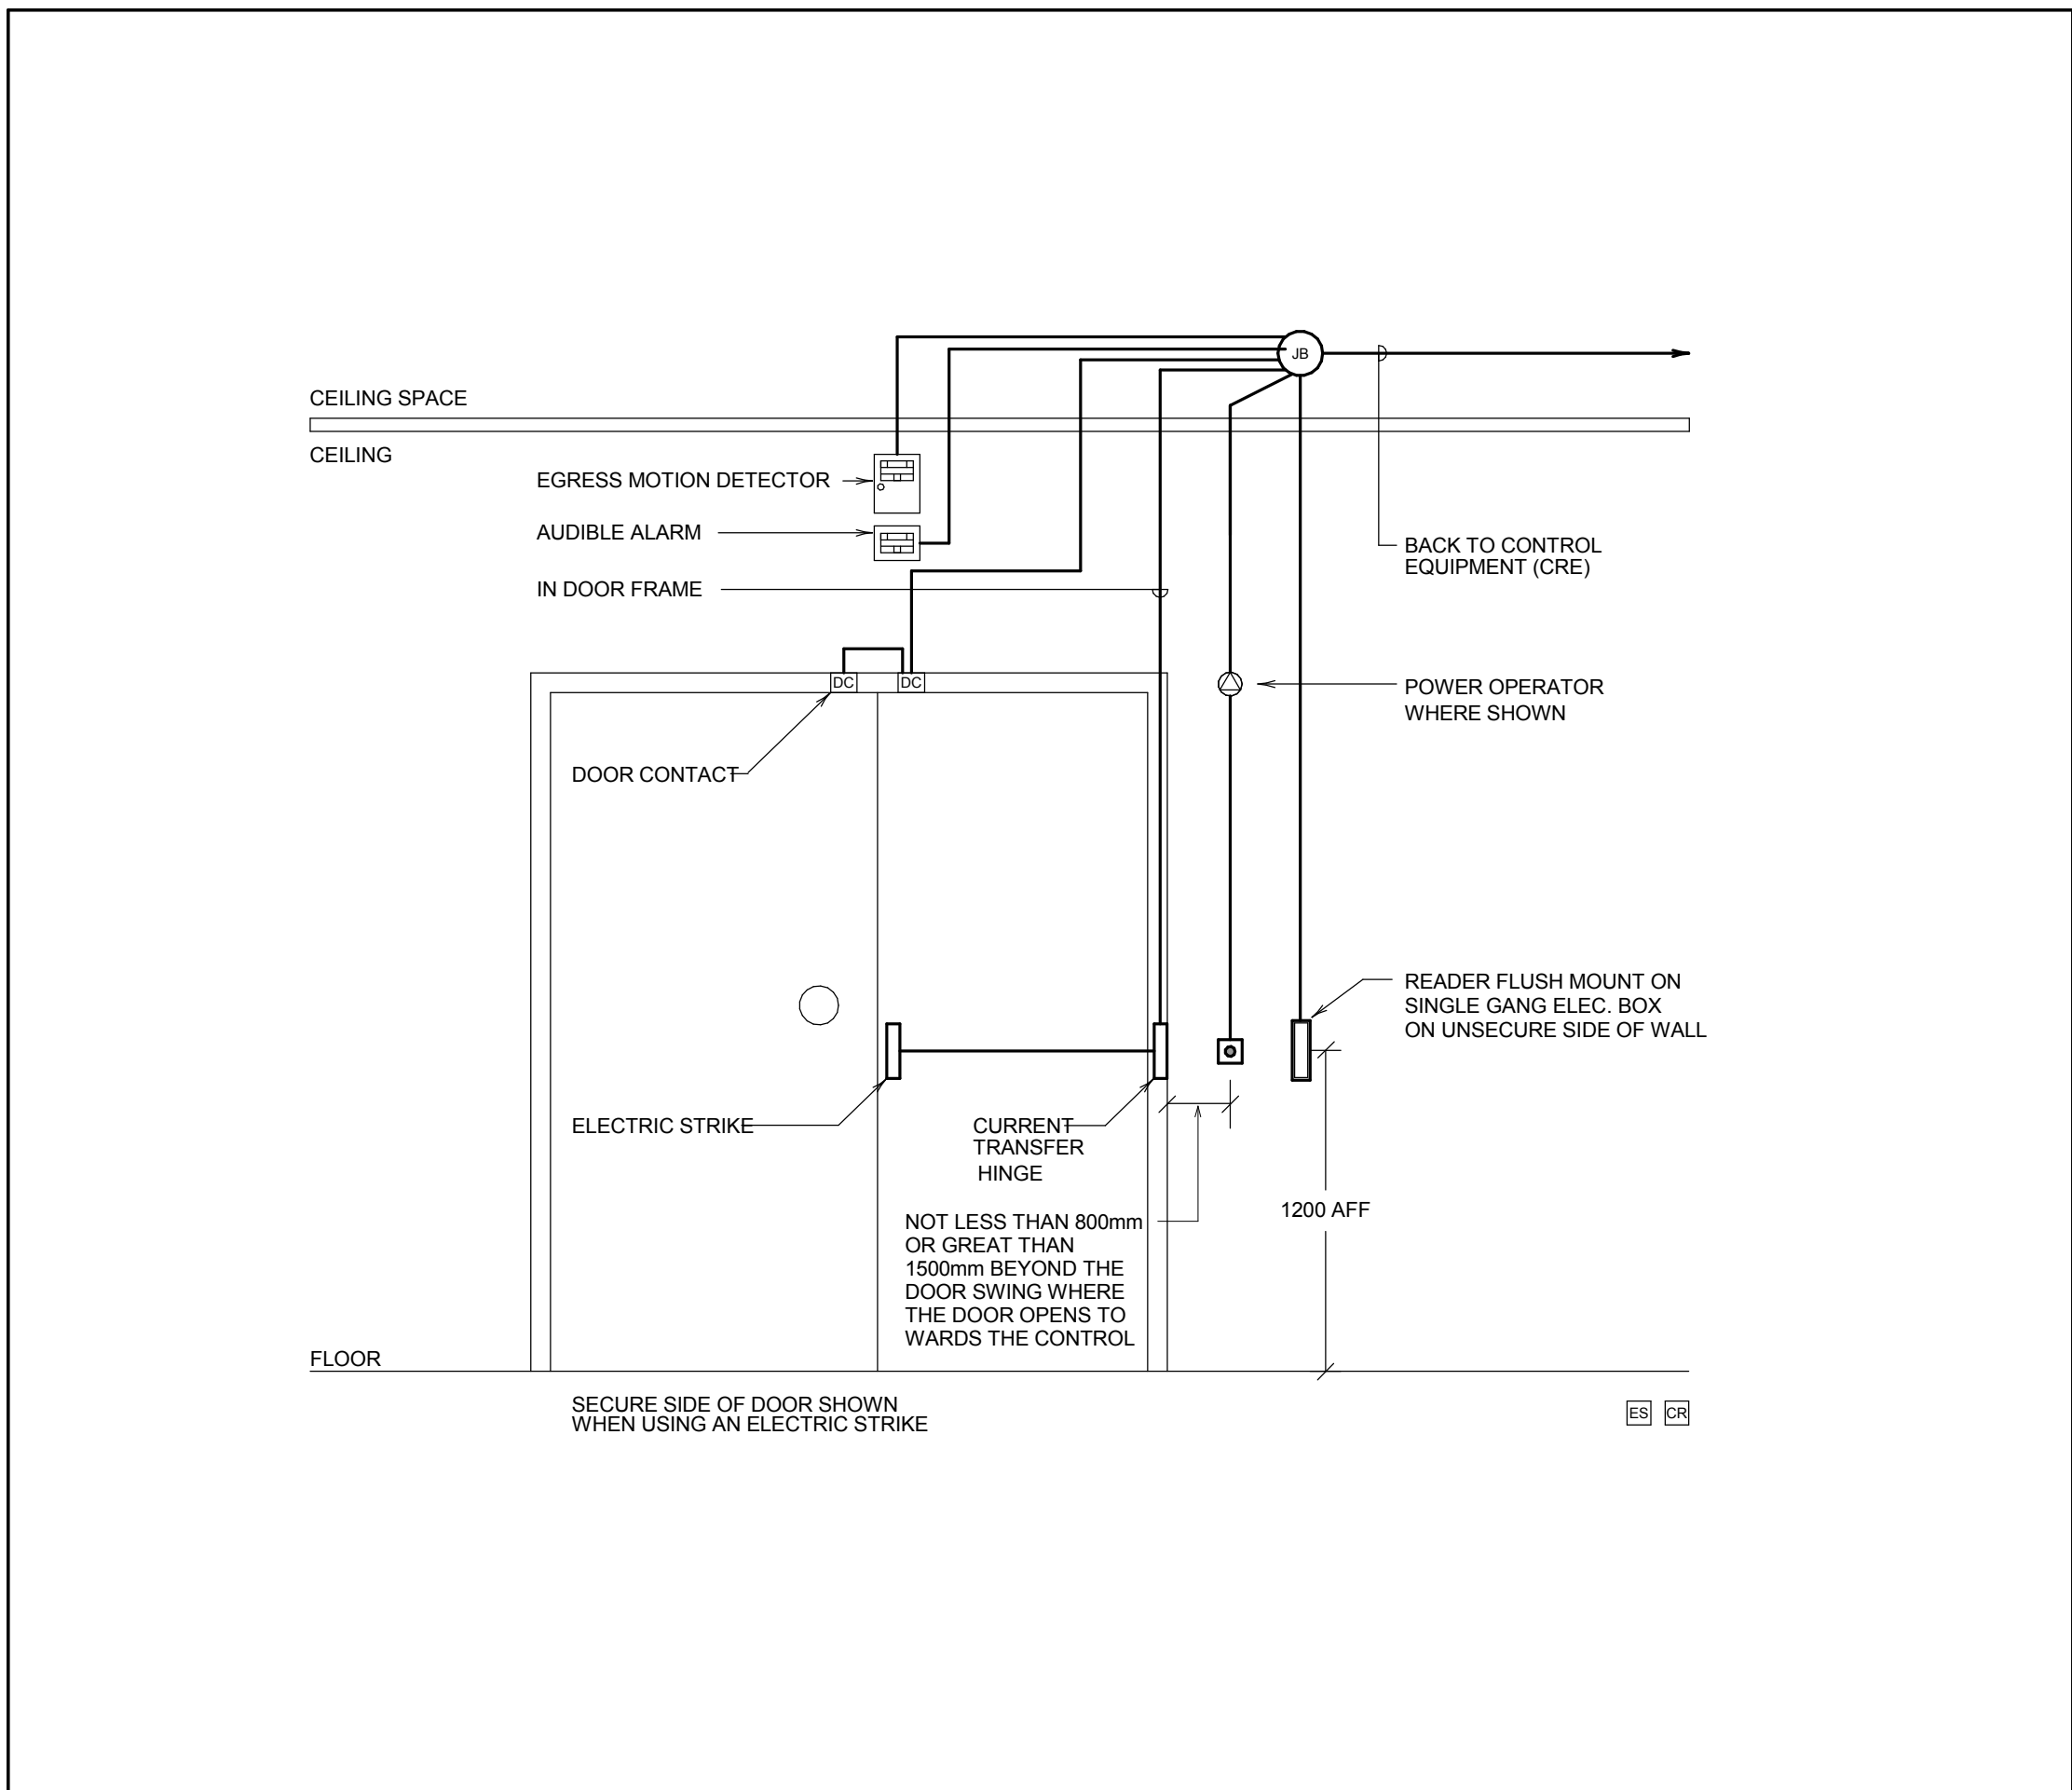


9 SECURED DOUBLE DOOR WITH ELECTRIC STRIKE
N.T.S.

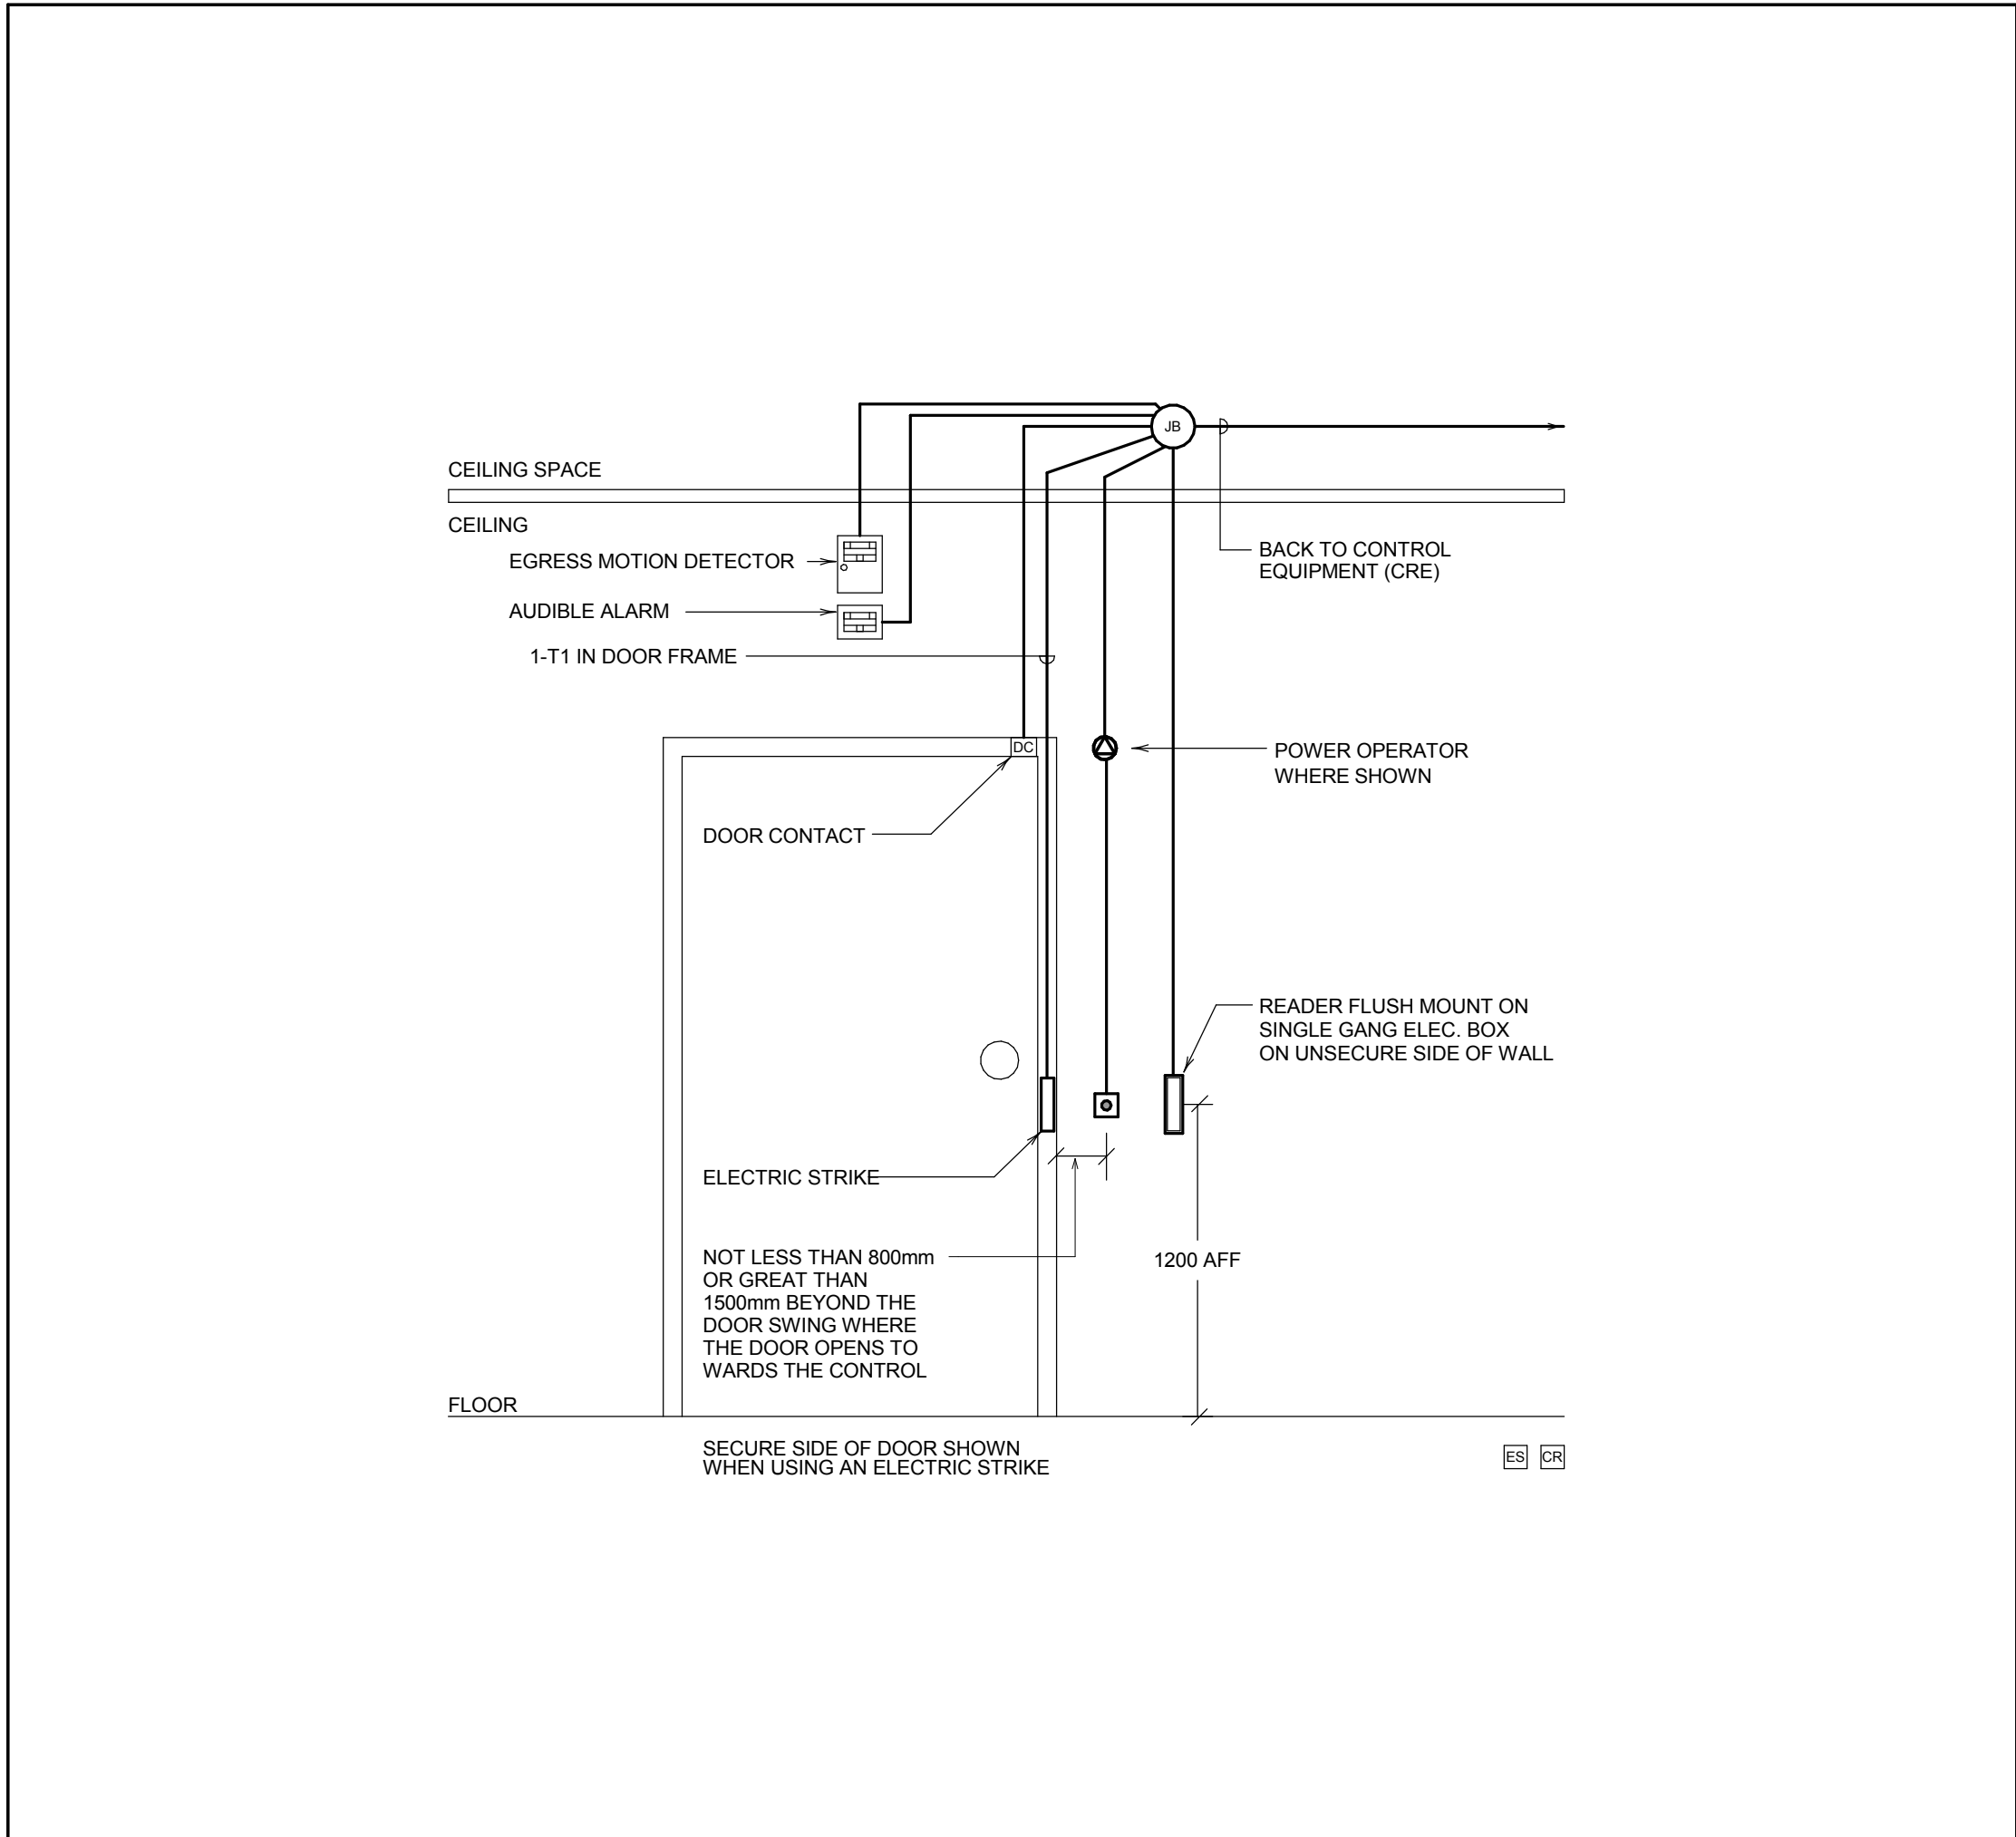


8 SECURED SINGLE DOOR WITH ELECTRIC STRIKE
N.T.S.

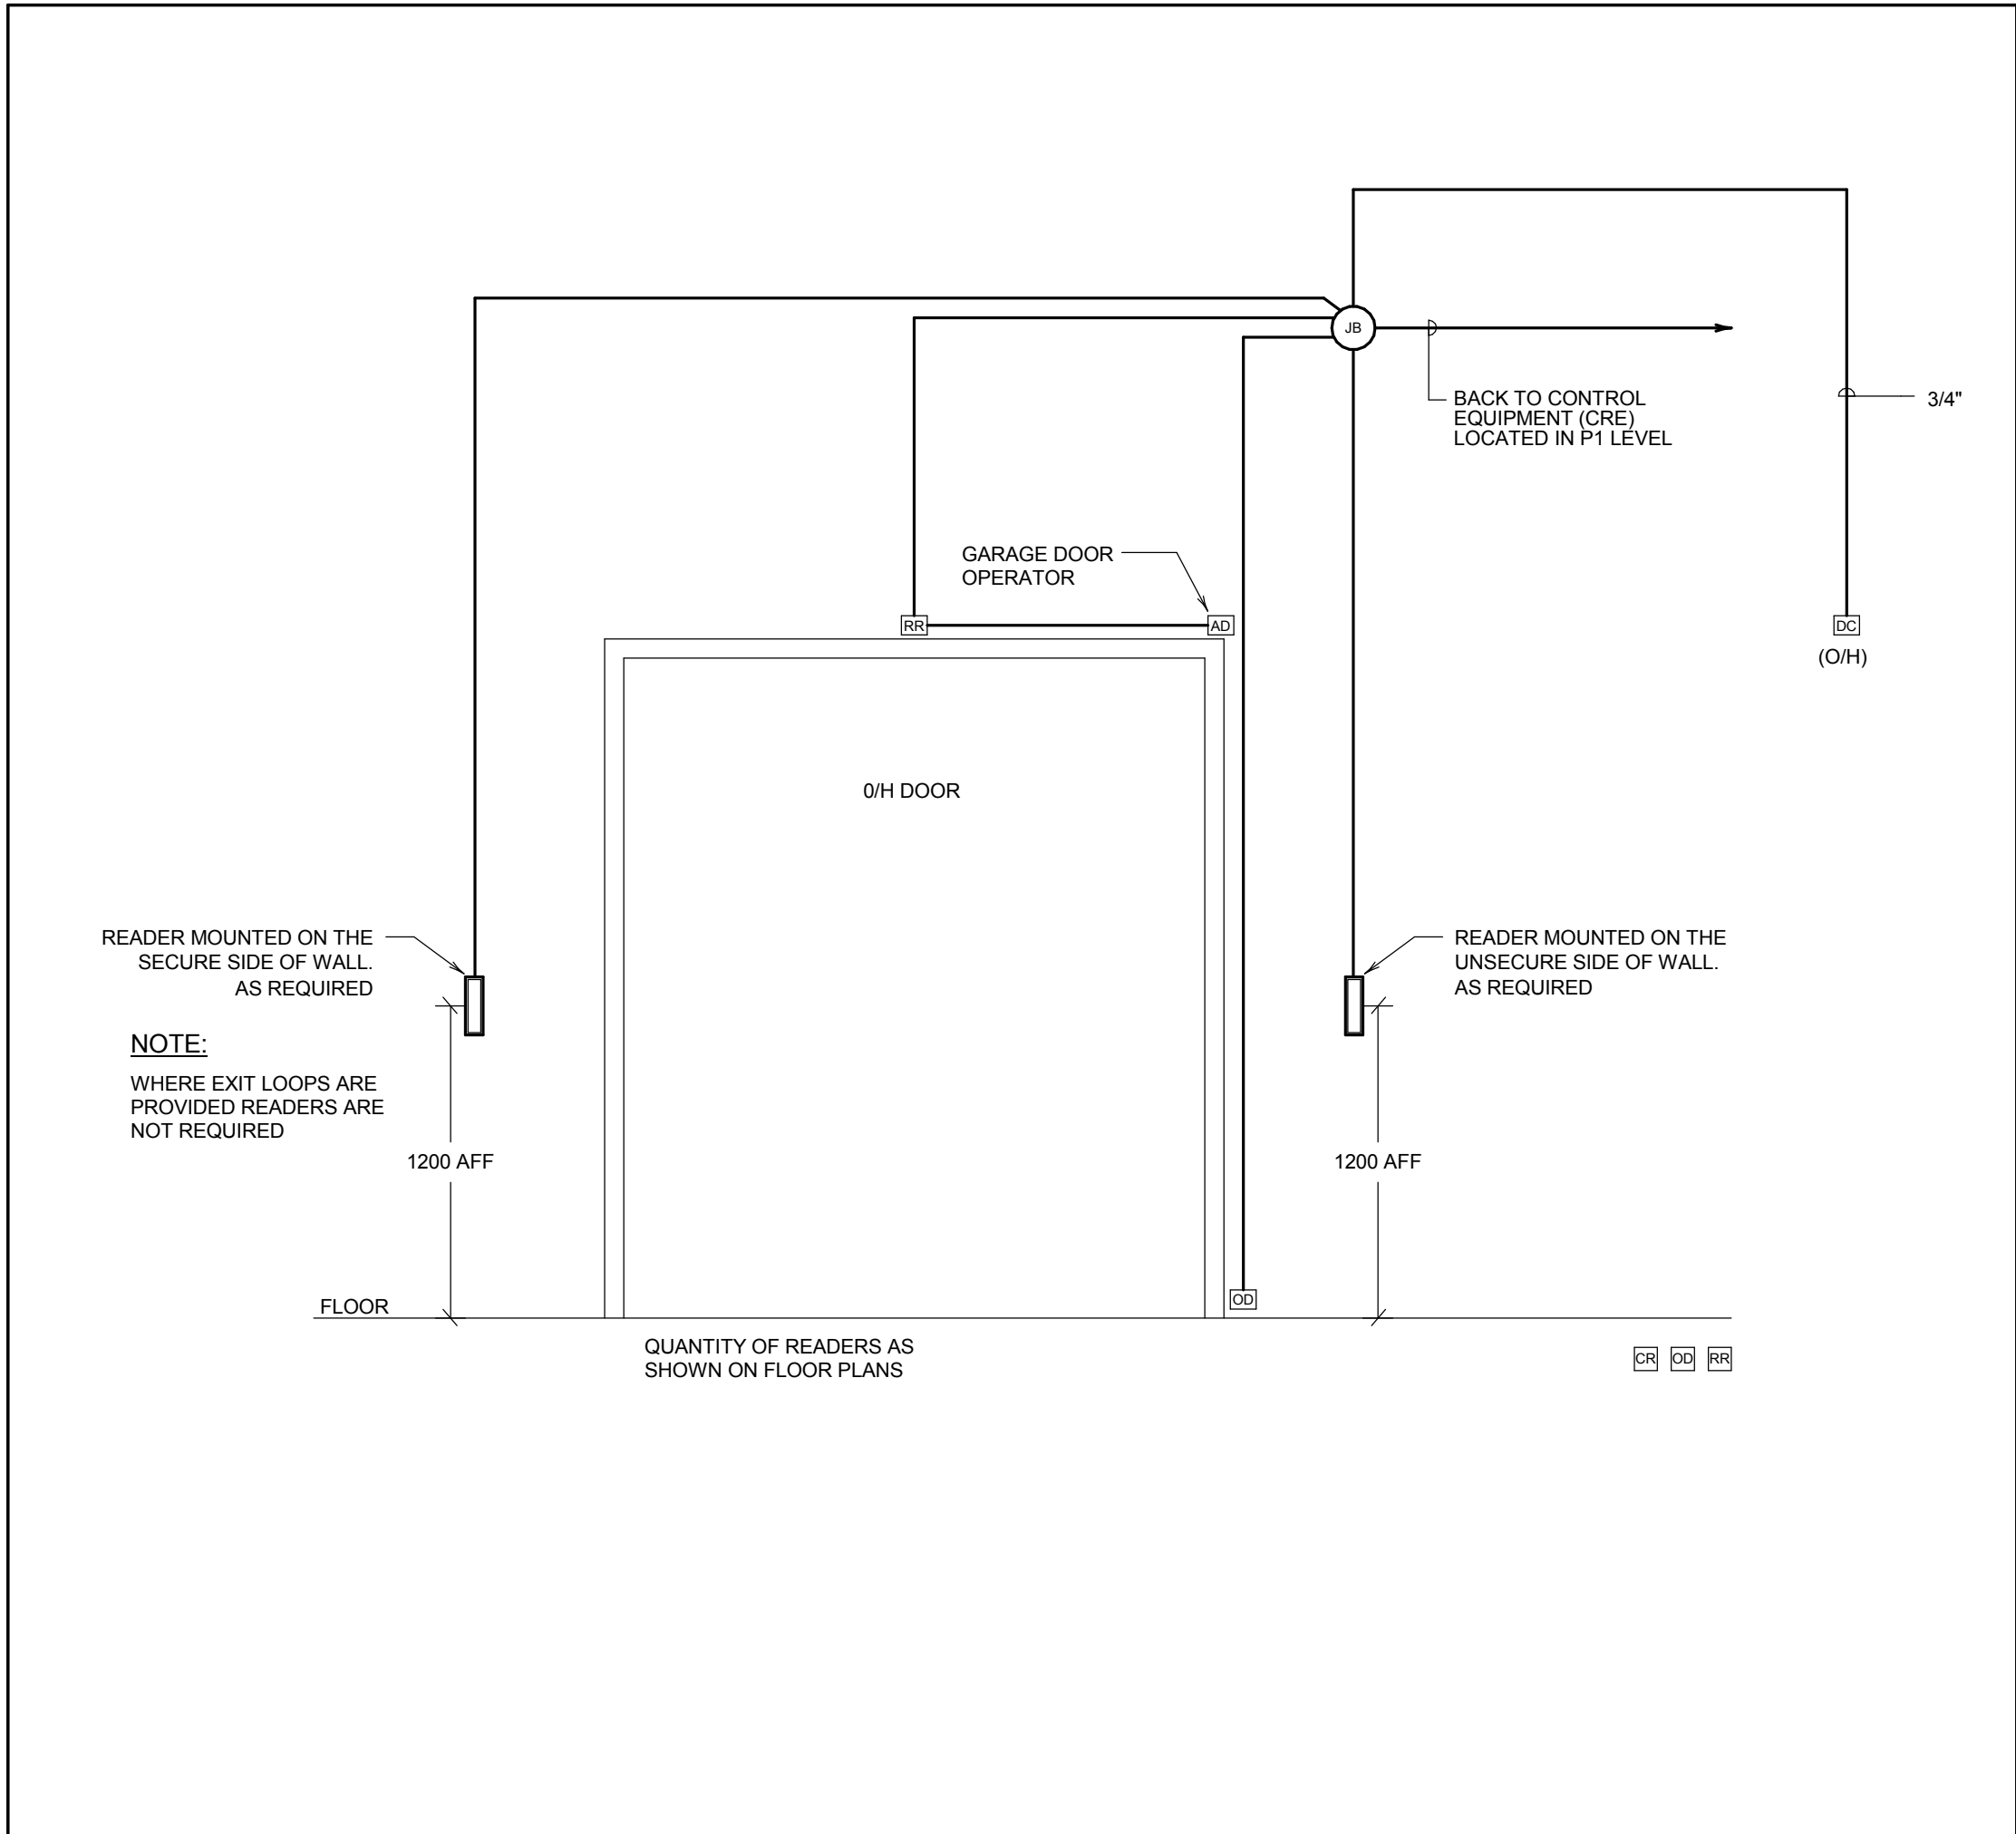


7 SECURED OVERHEAD GARAGE DOOR
N.T.S.

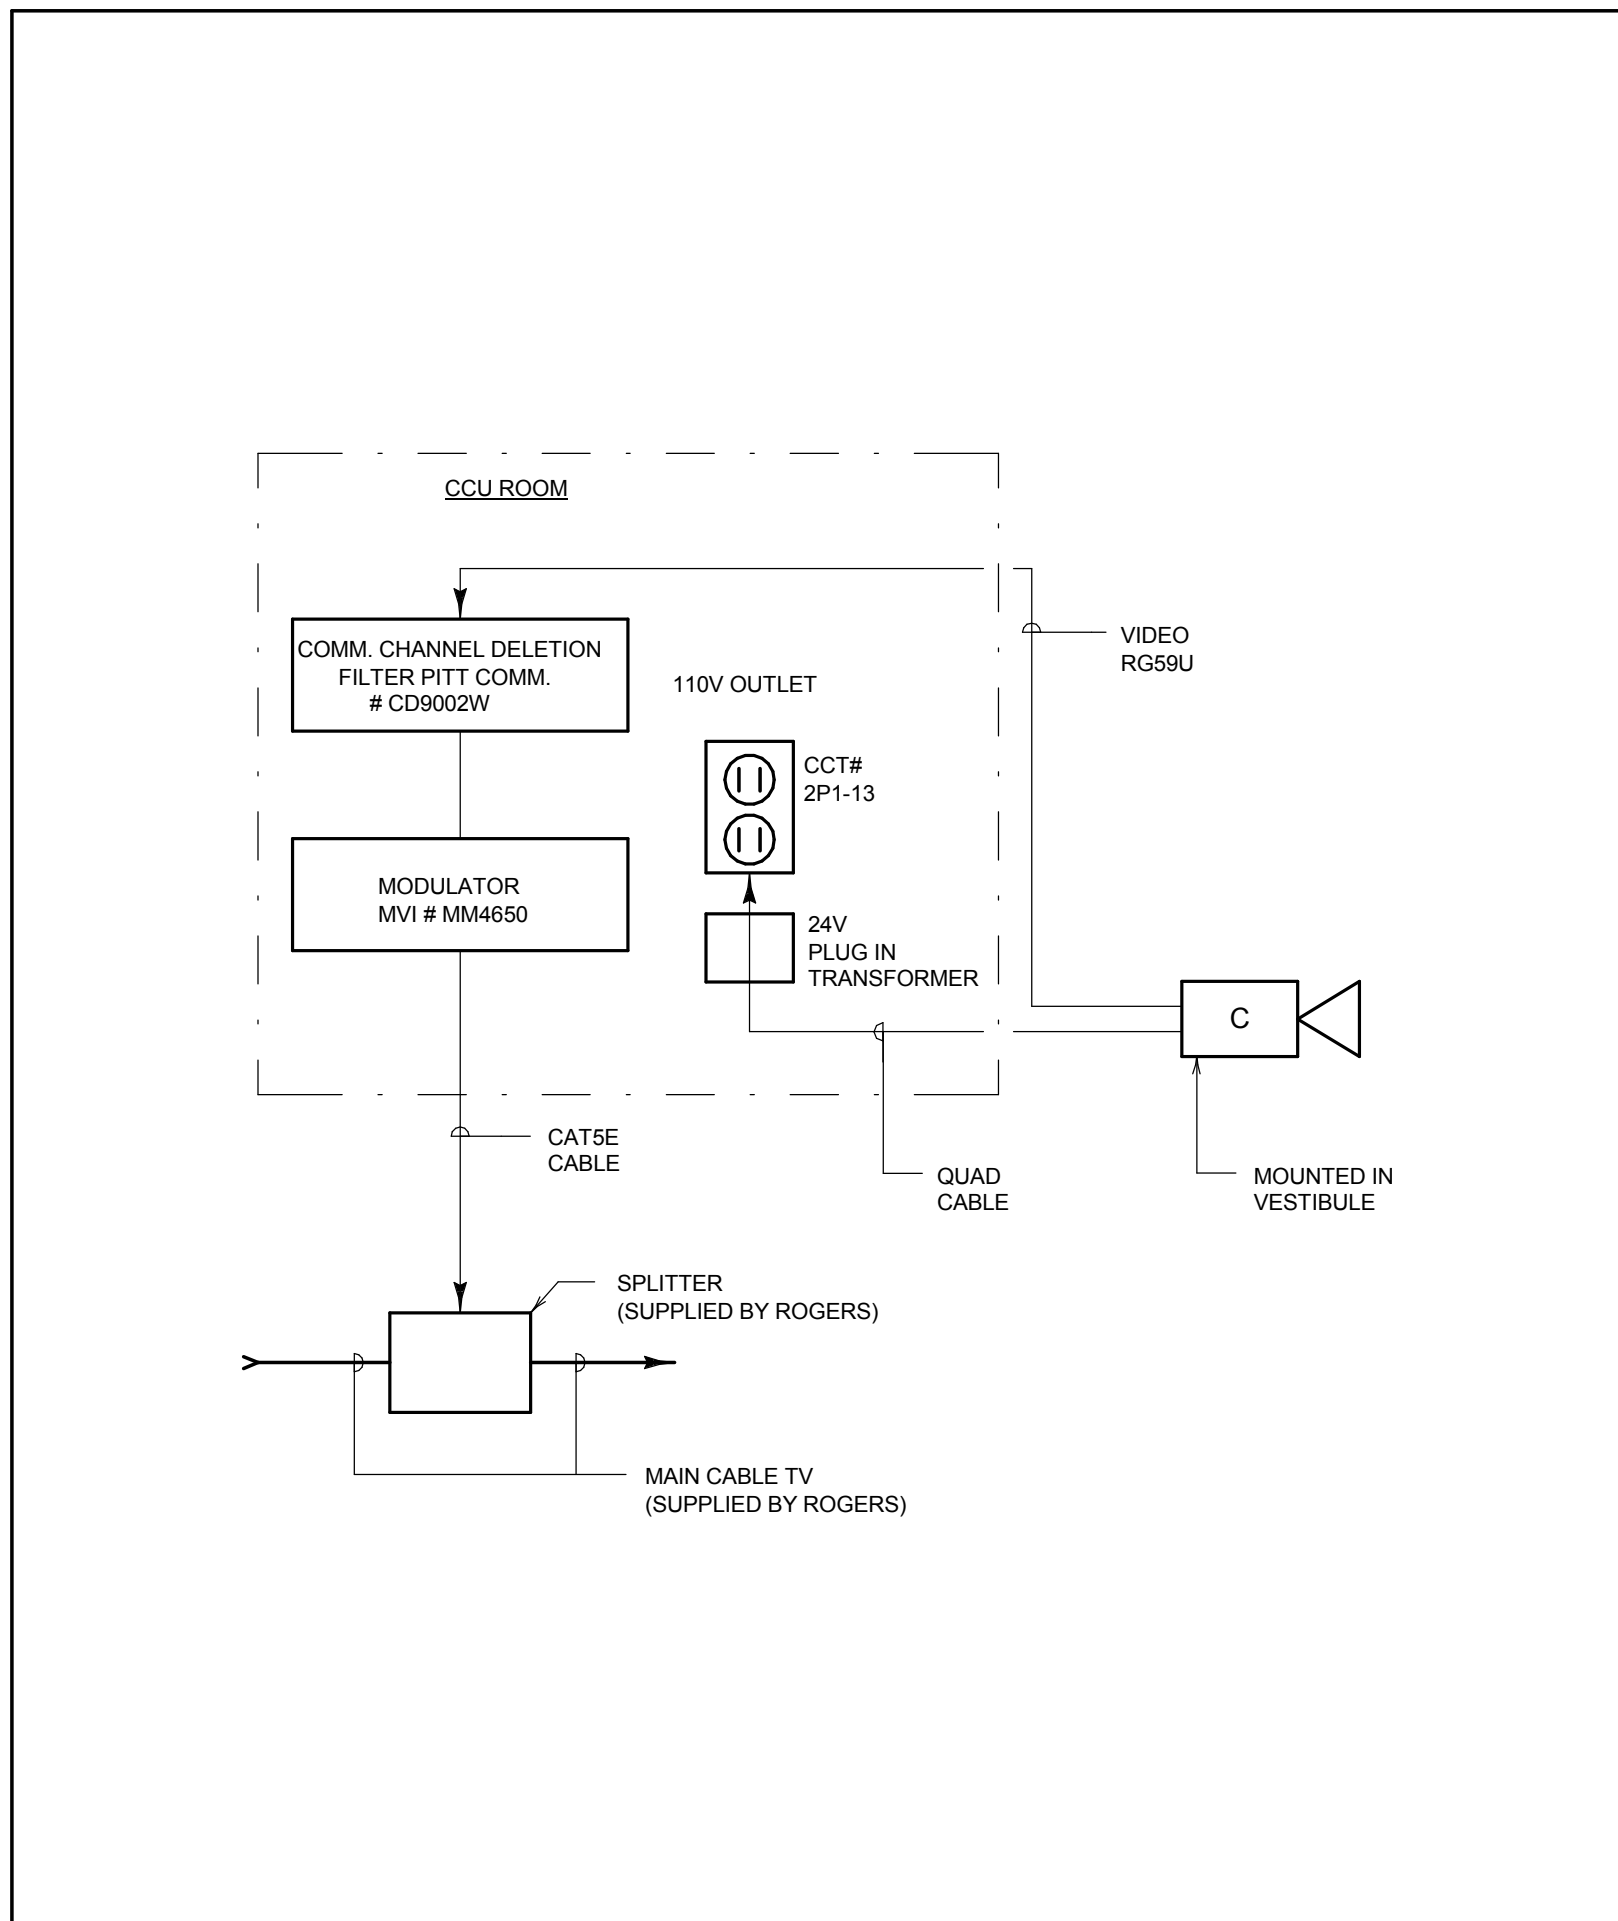


6 LOBBY CAMERA INSTALLATION
N.T.S.

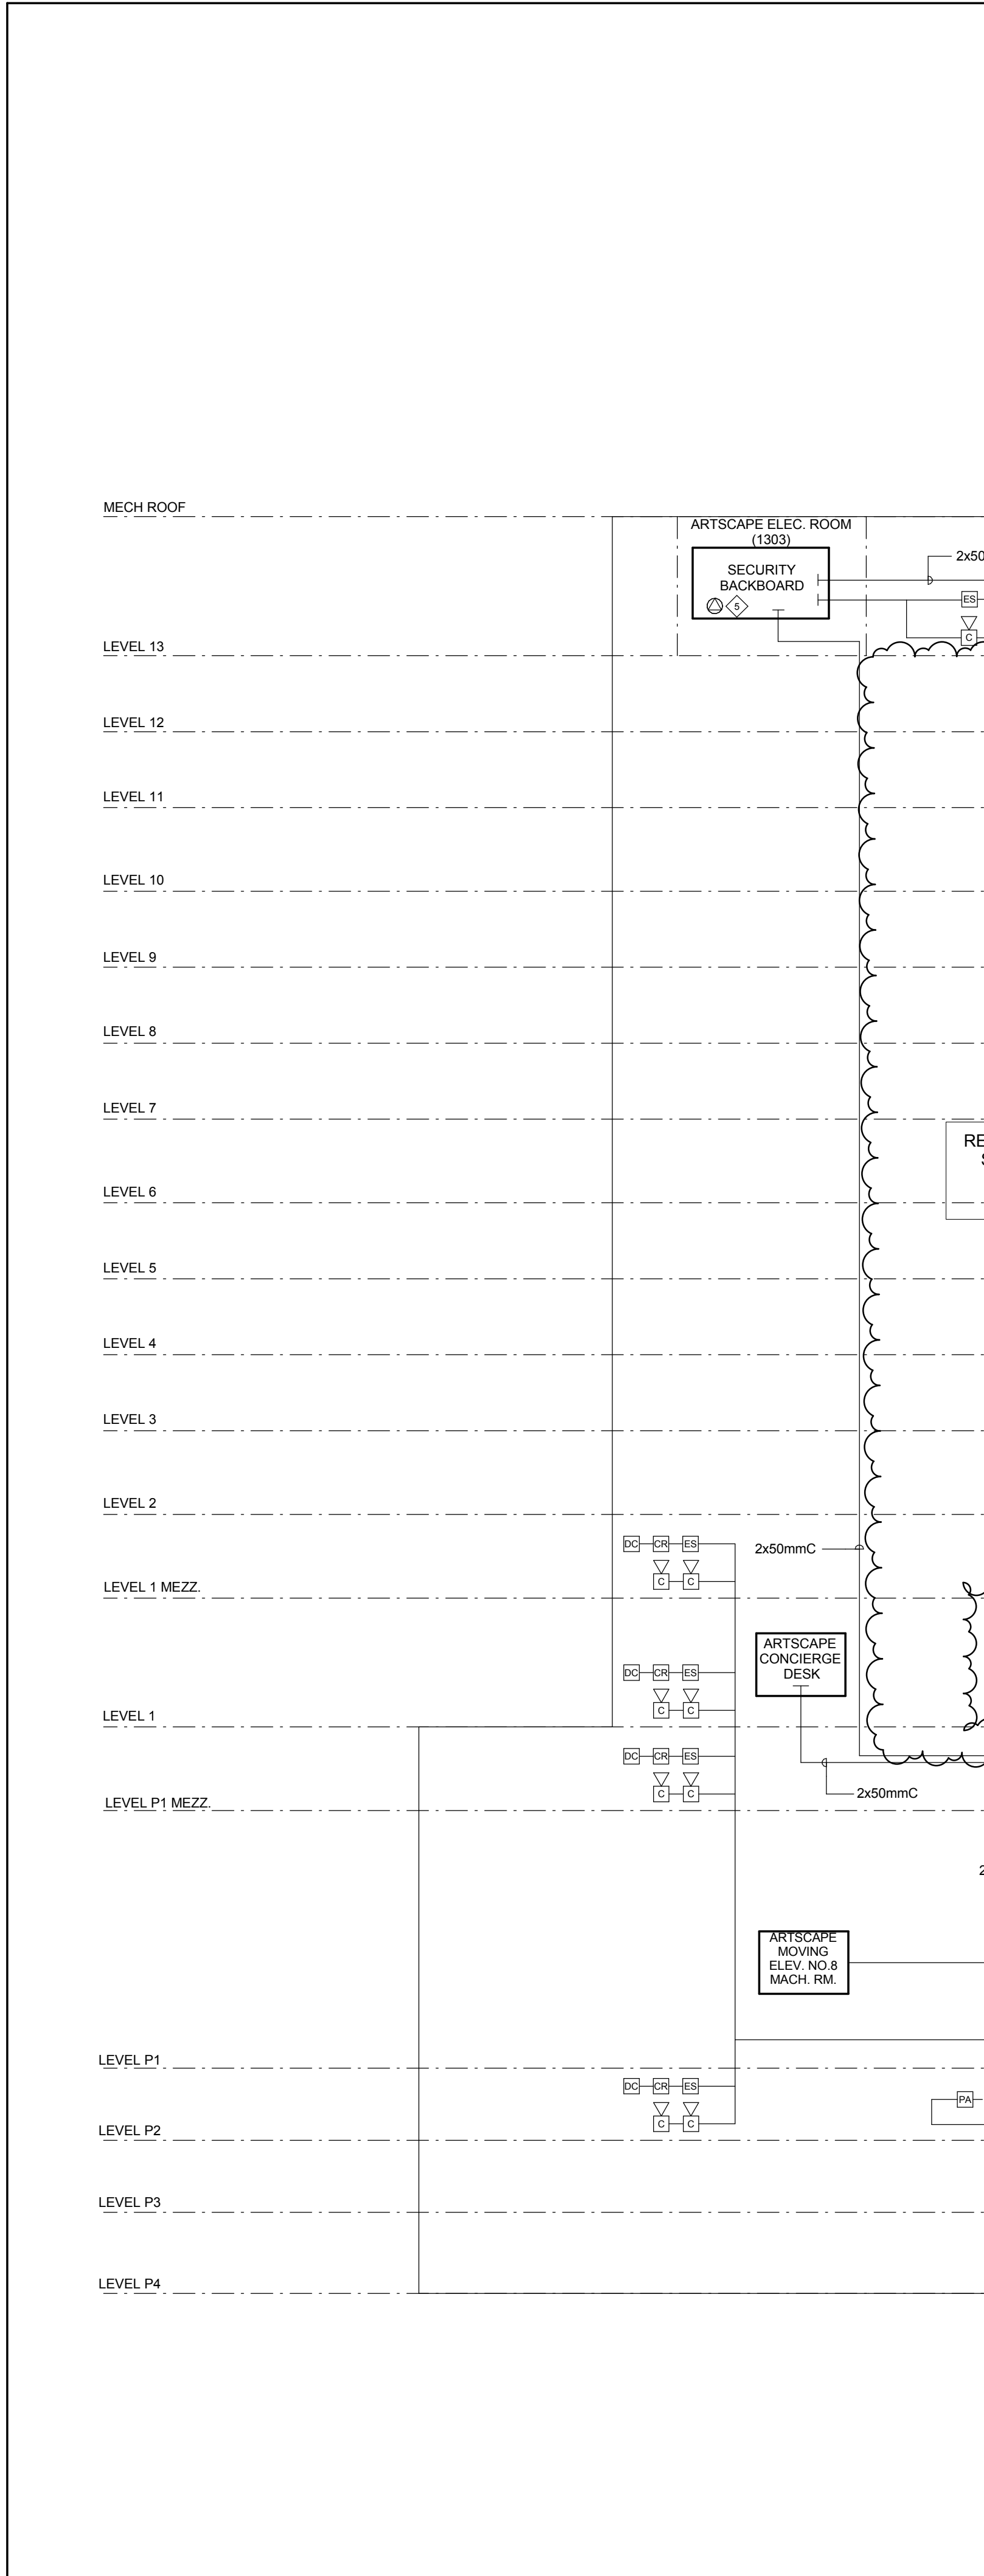


1 SECURITY RISER DIAGRAM
N.T.S.

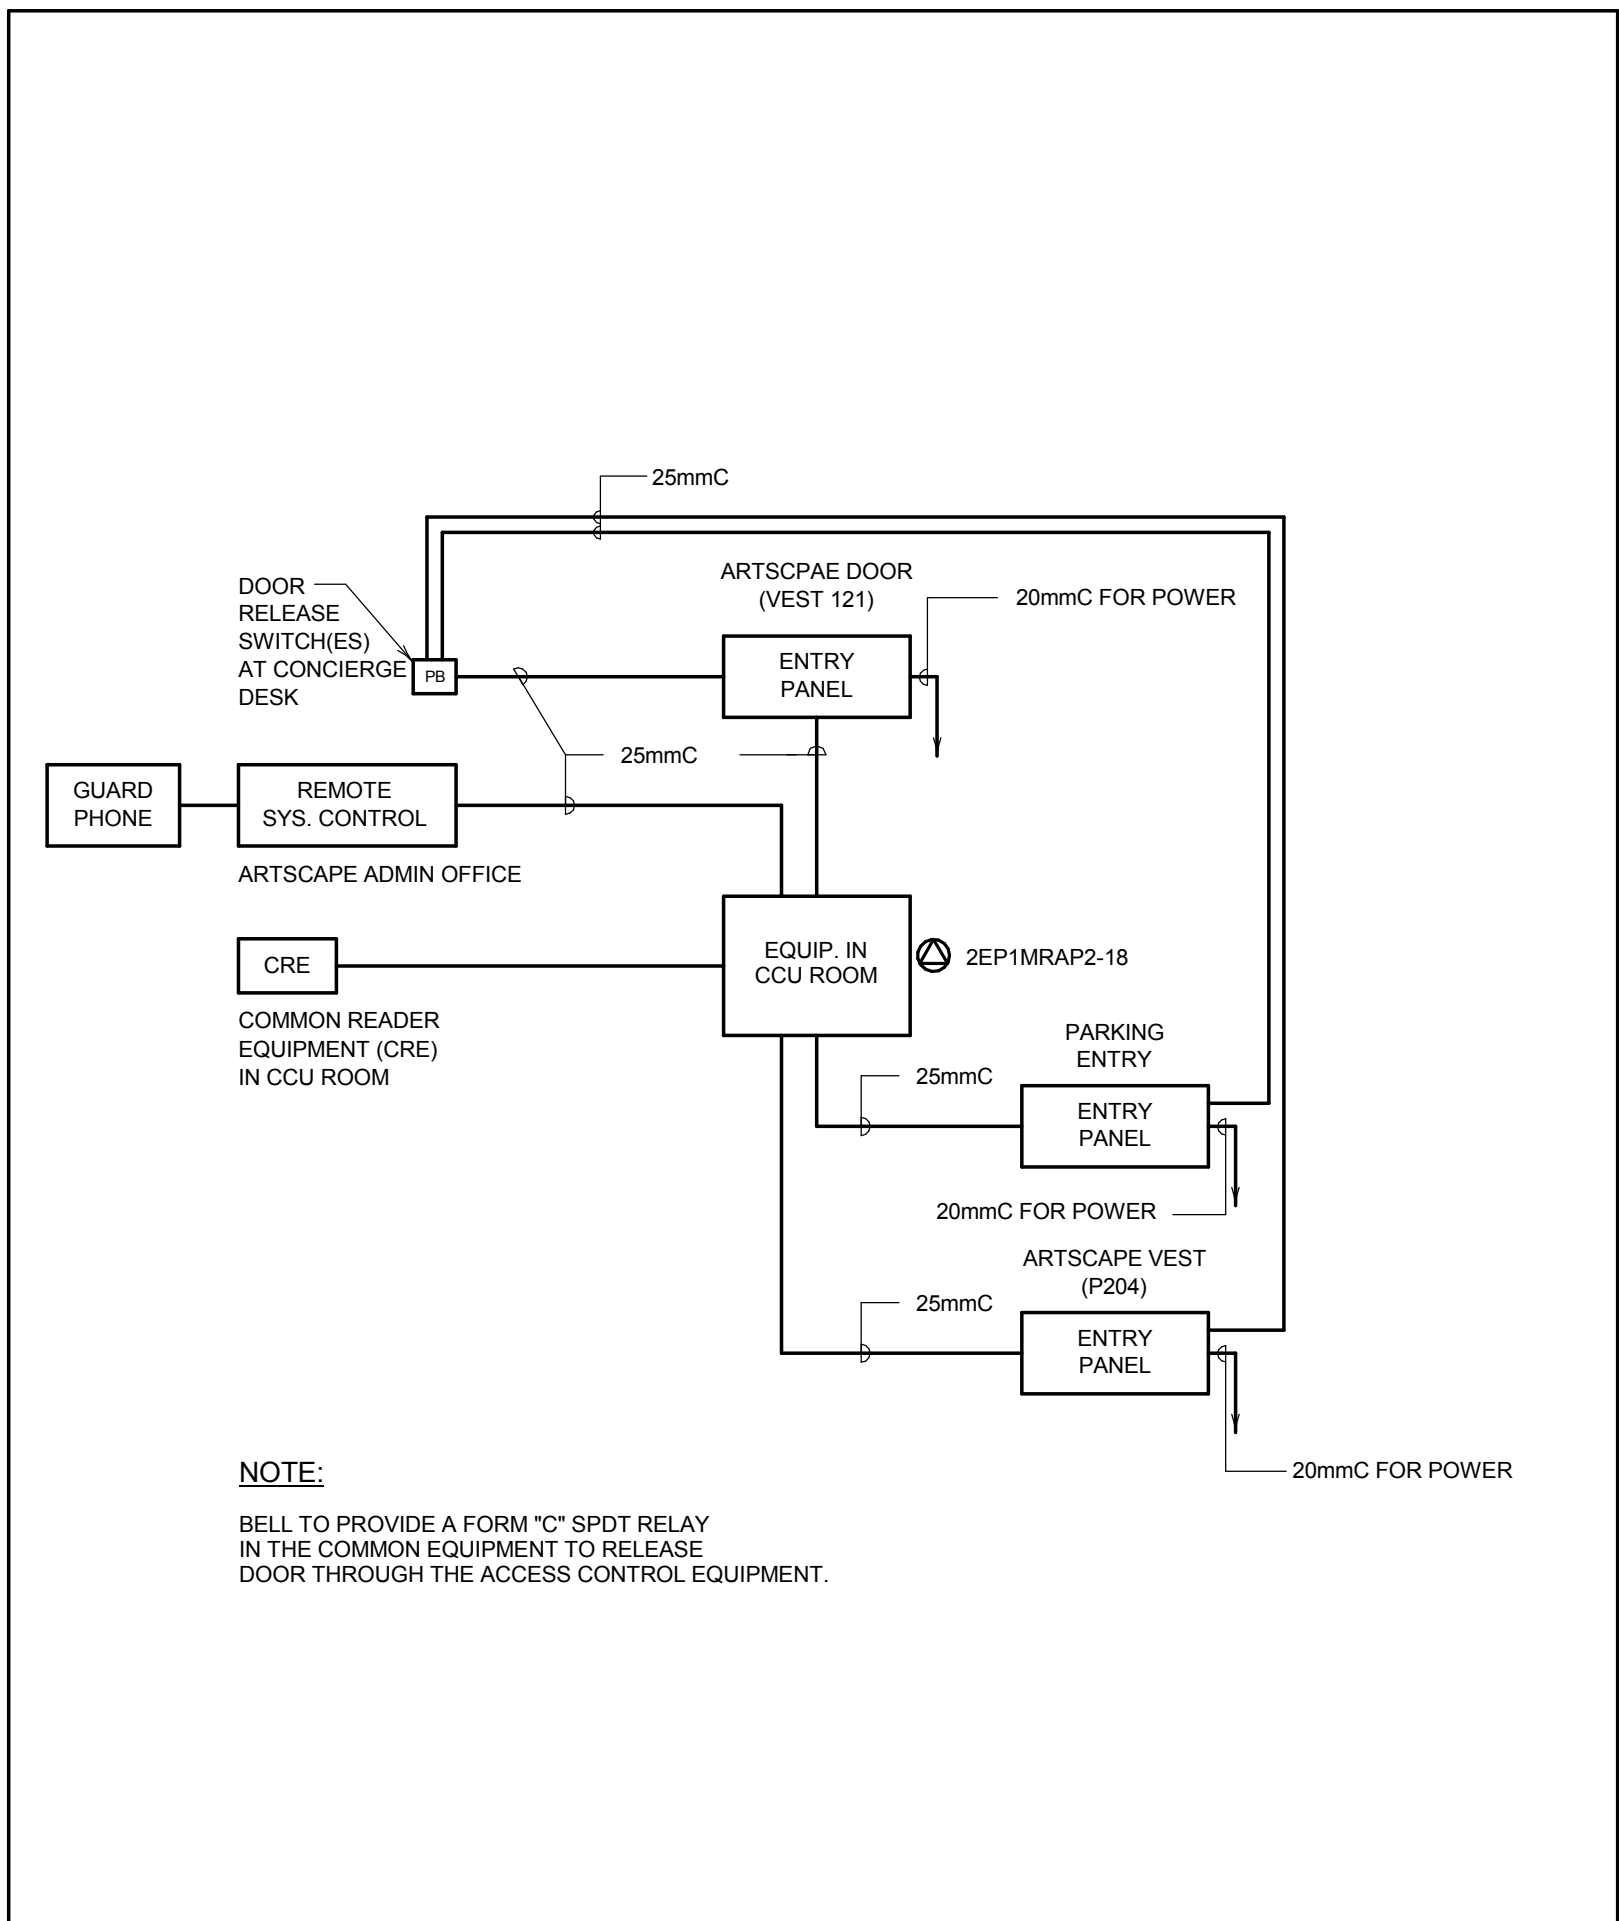


5 ENTERPHONE SYSTEM (ARTSCAPE)
N.T.S.

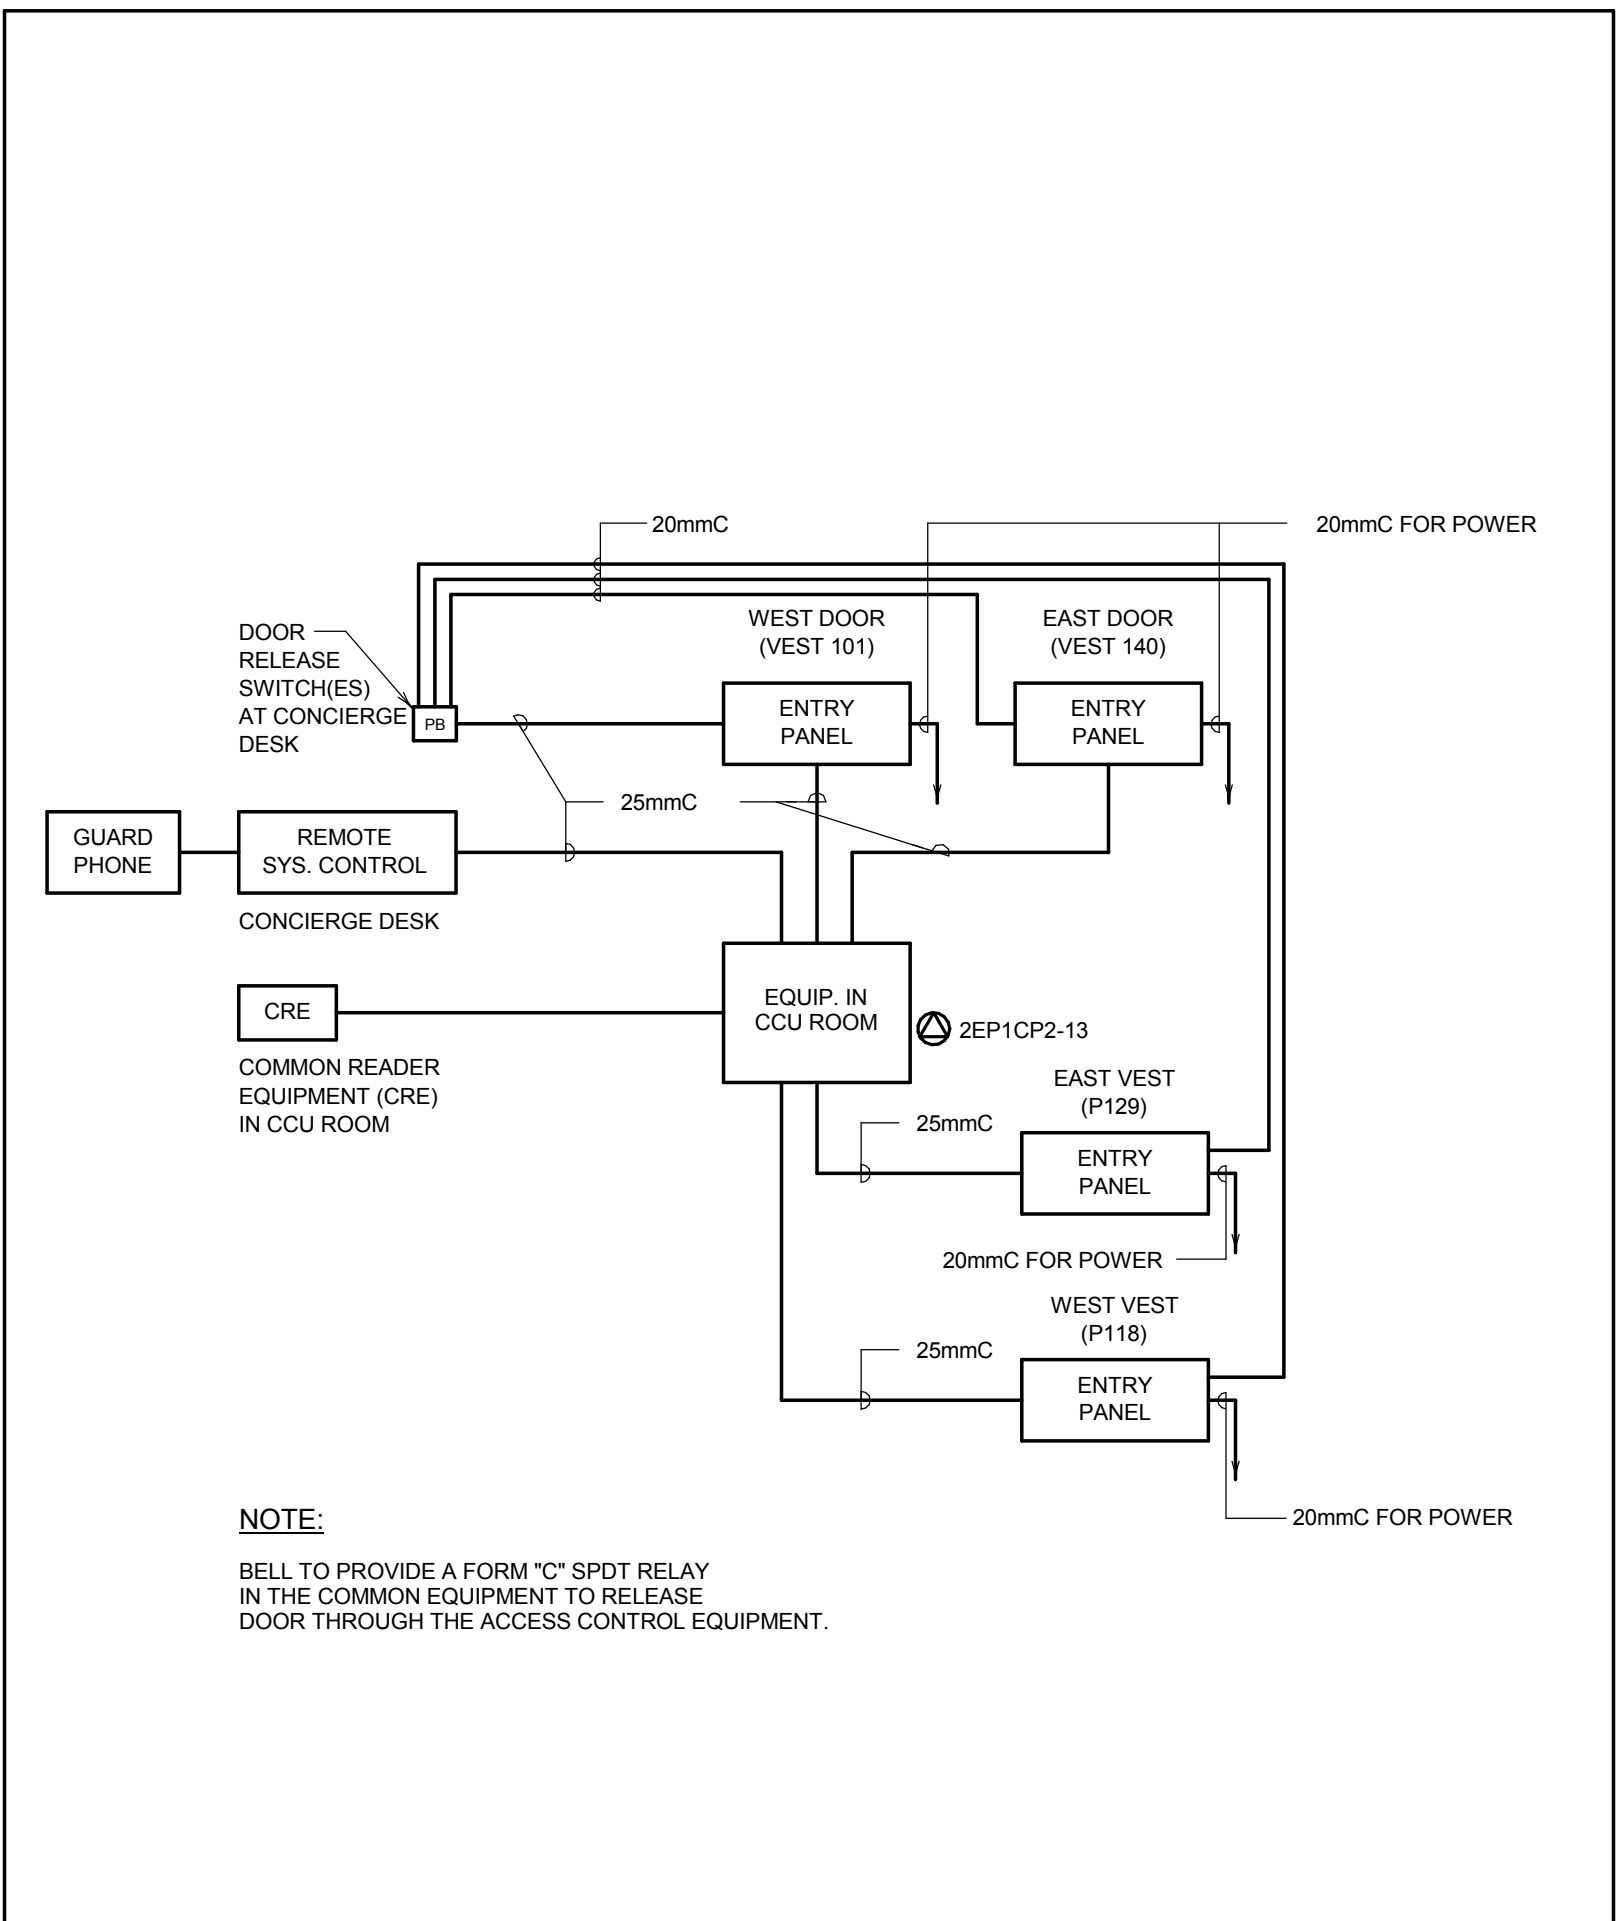

4 ENTERPHONE SYSTEM (CONDO)
N.T.S.

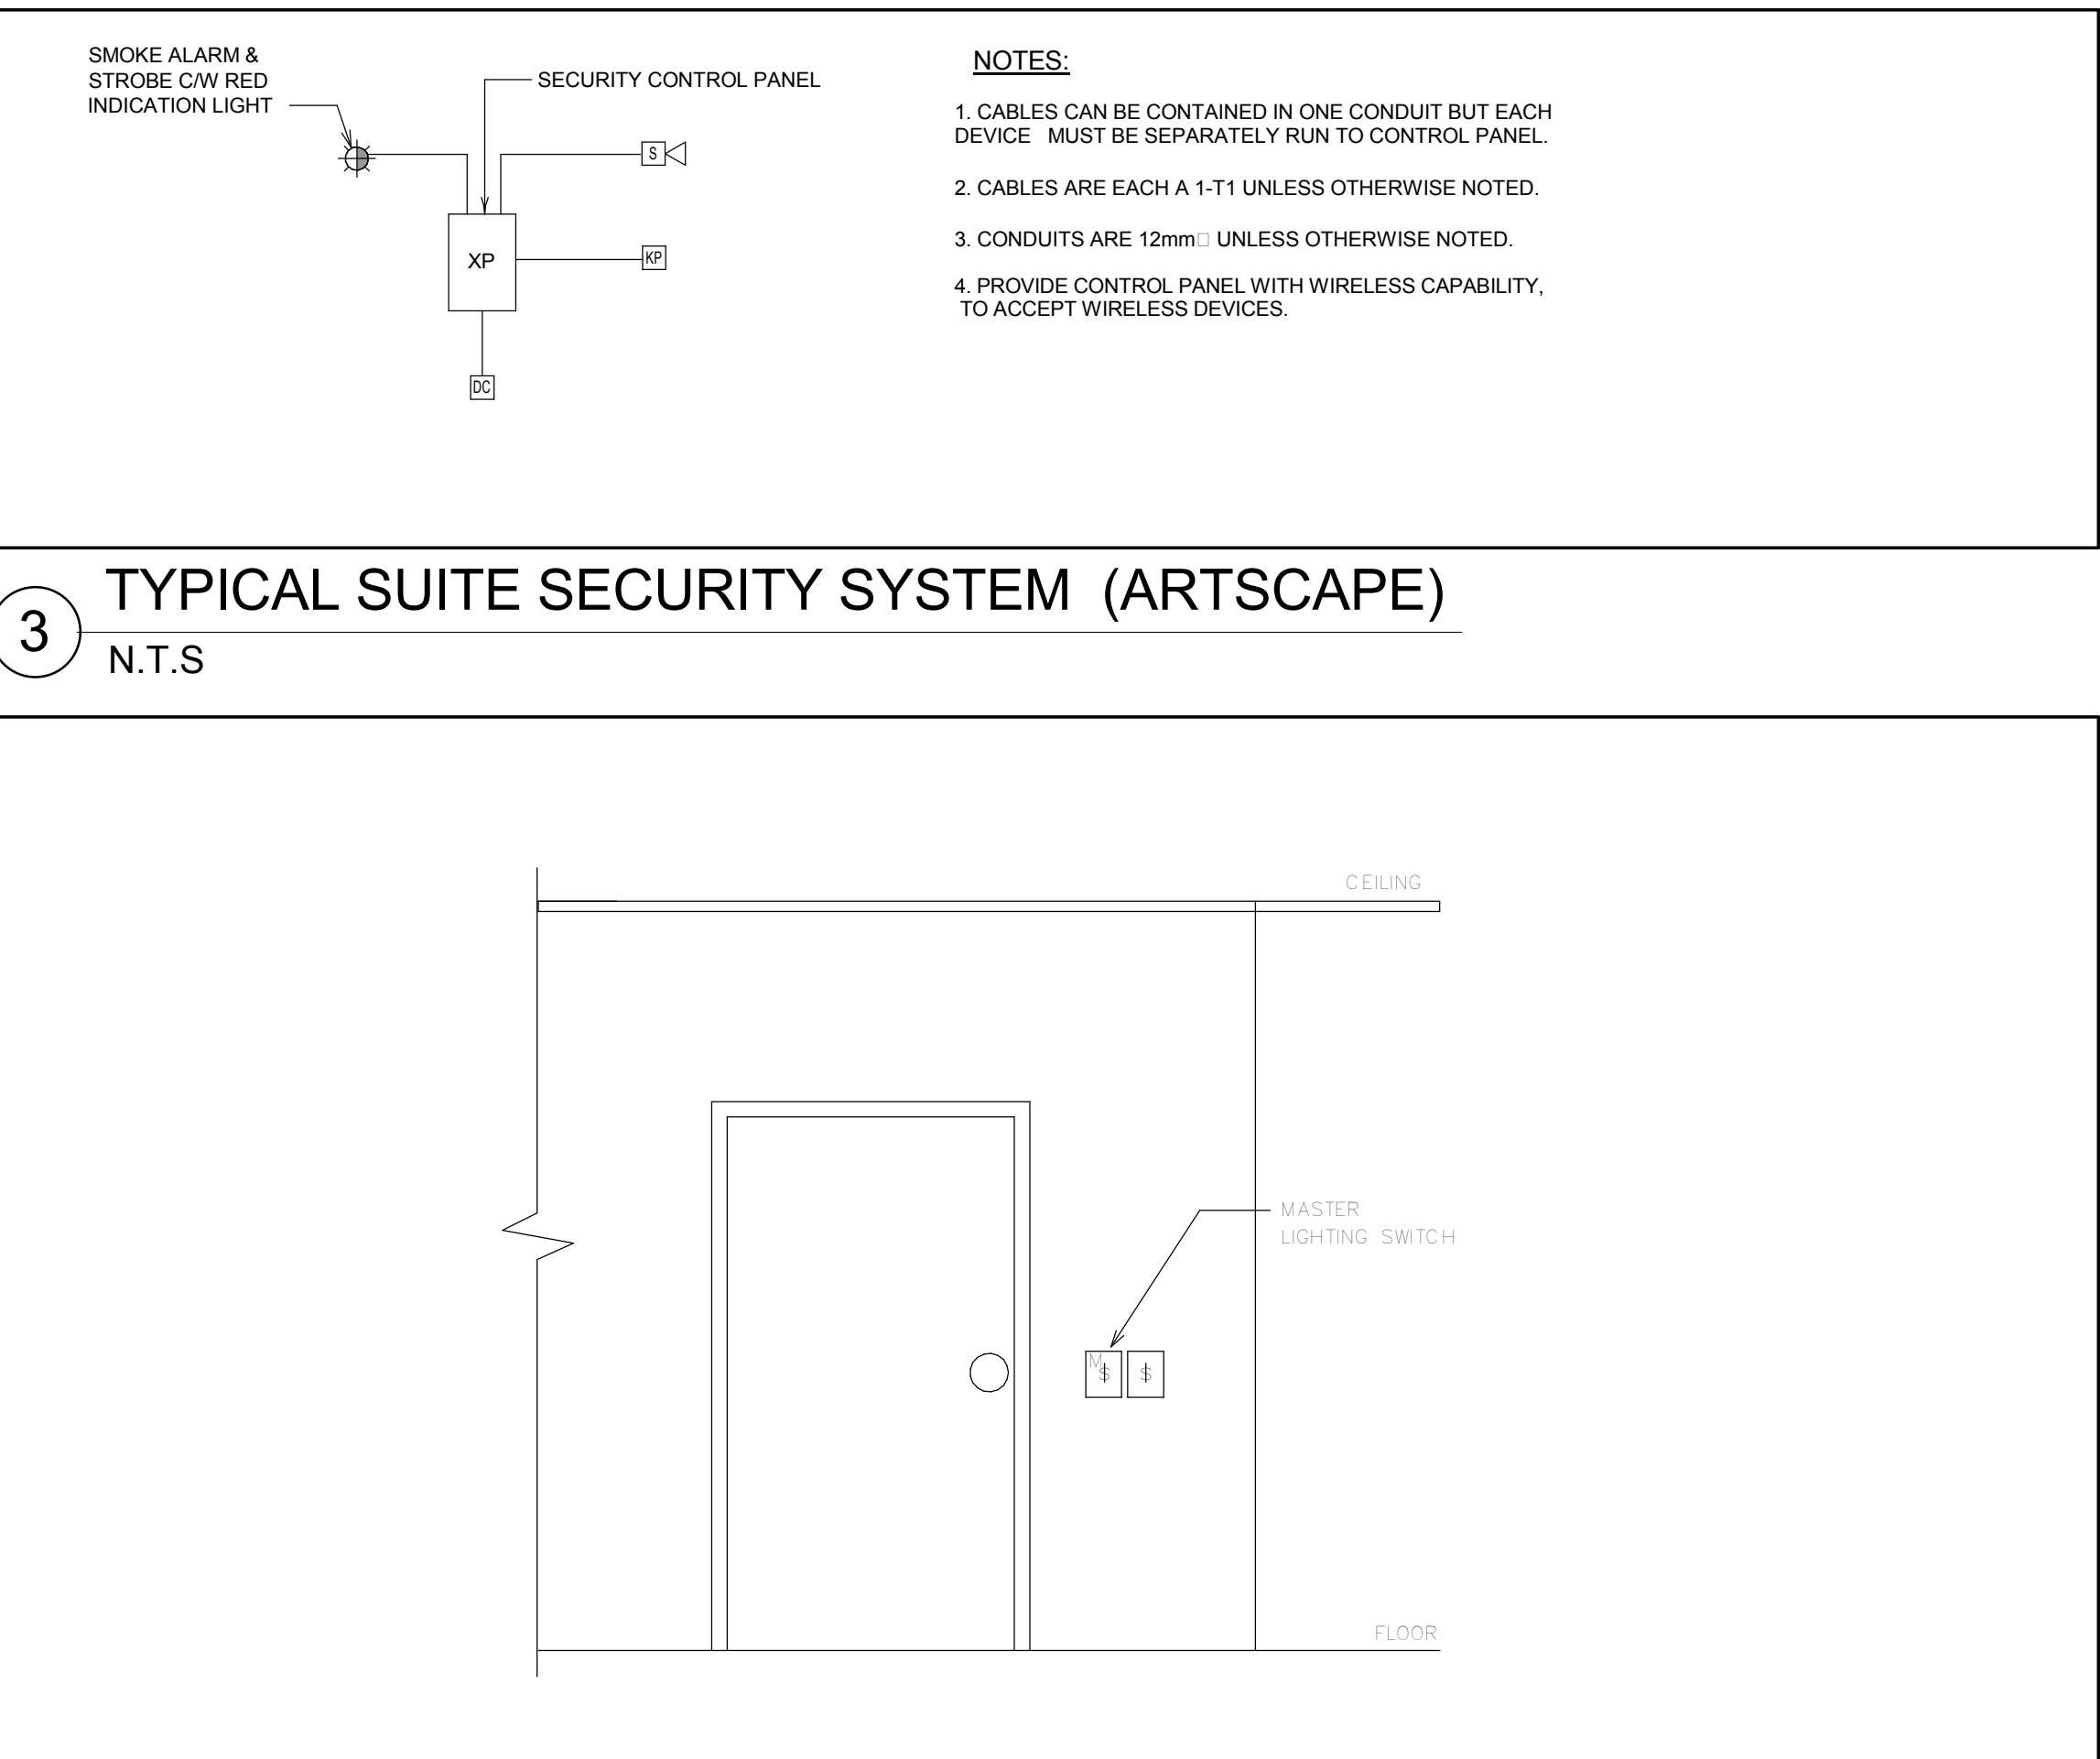

3 TYPICAL SUITE SECURITY SYSTEM (ARTSCAPE)
N.T.S.

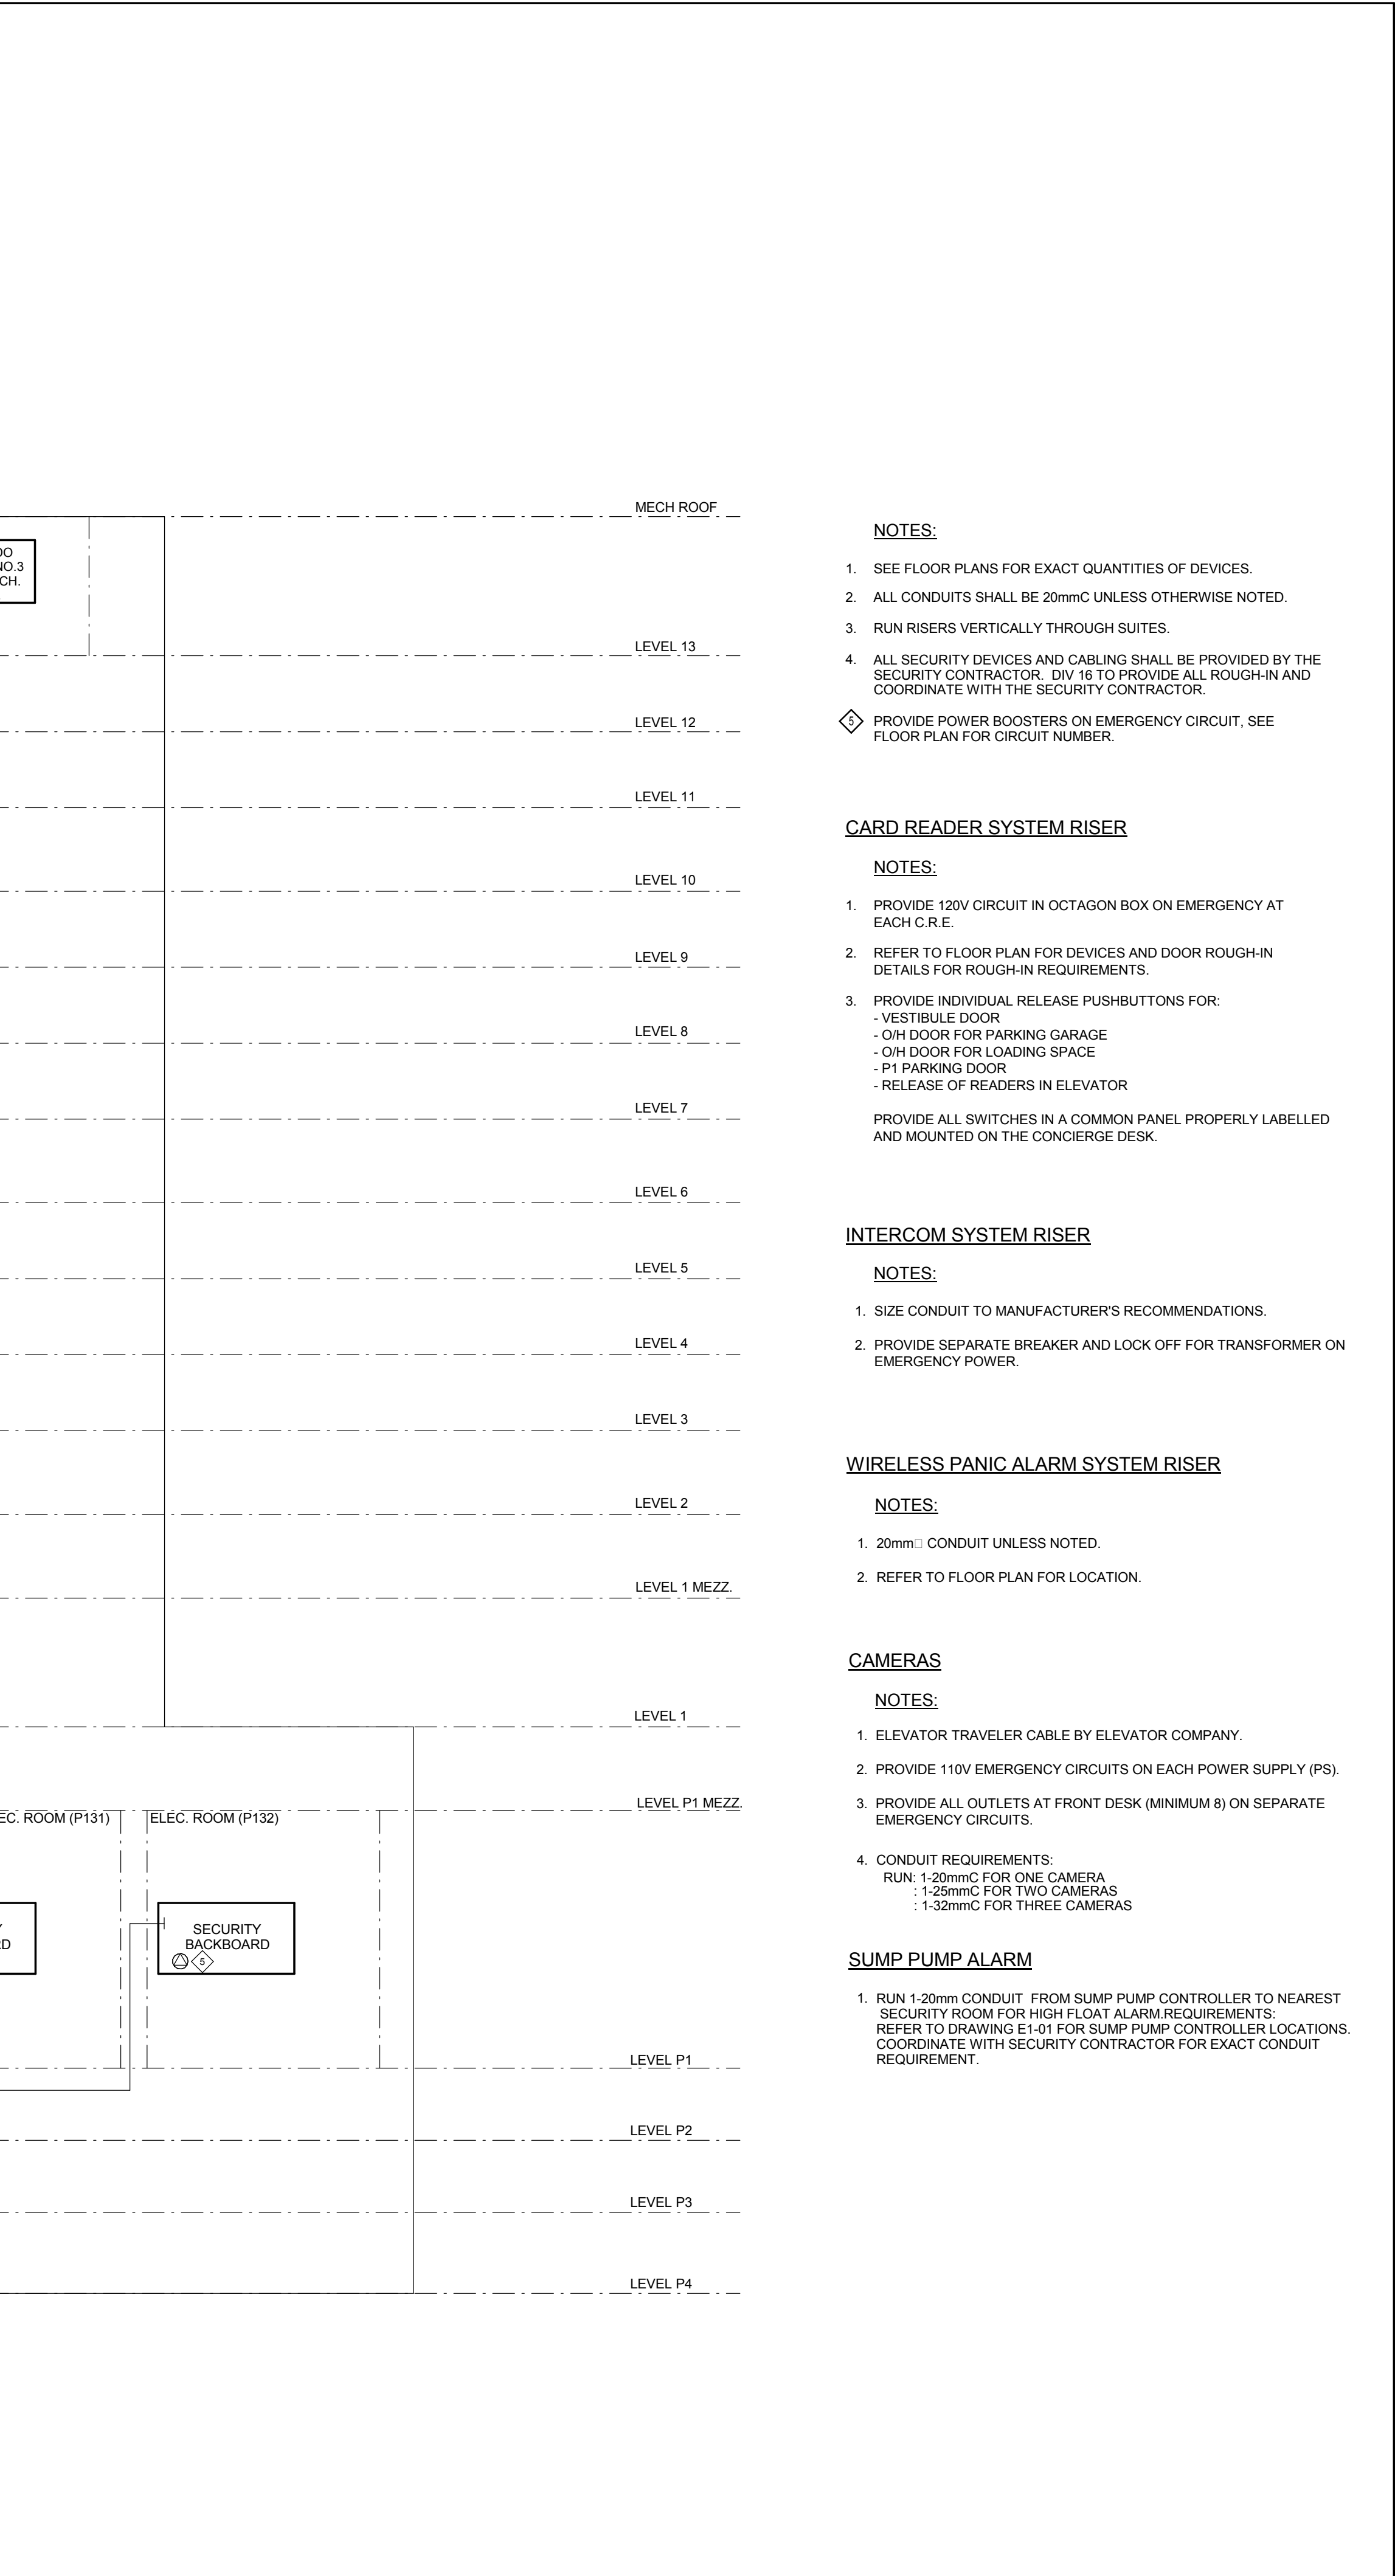

2 TYPICAL SUITE MASTER SWITCH DETAILS (ARTSCAPE)
N.T.S.

Contractor Must Check And Verify All Dimensions On The Job.
Do Not Print This Drawing.
All Drawings, Specifications And Related Documents Are The Copyright Of The Architect And Shall Be Returned Upon Request.
Reproduction Of Drawings, Specifications And Related Documents Without The Architect's Written Permission Is Prohibited.
This Drawing Is Not To Be Used For Construction Until Signed By The Architect.
Date: 03/09/15

MCW Consultants Ltd.
207 Queen's Quay West, Suite 615, Toronto, ON, M5J 1A7
Tel: 416-598-2500 Fax: 416-598-0384
Toronto, Mississauga, Winnipeg, Montreal, Ottawa, Halifax, Dauphin, Kelowna, Trail, Salt Lake City

No.	Revision	Date
1	ISSUED FOR CONSTRUCTION	2016/04/25
2	ISSUED FOR S-E-008	2016/11/16
3	ISSUED FOR S-E-021	2017/02/24

Project: Security Riser Diagram & Details
Drawing No: E4-06

Author: N.T.S.
Checked by: N.T.S.
Project No: 8489D
Date: 03/09/15
Drawing No: E4-06