

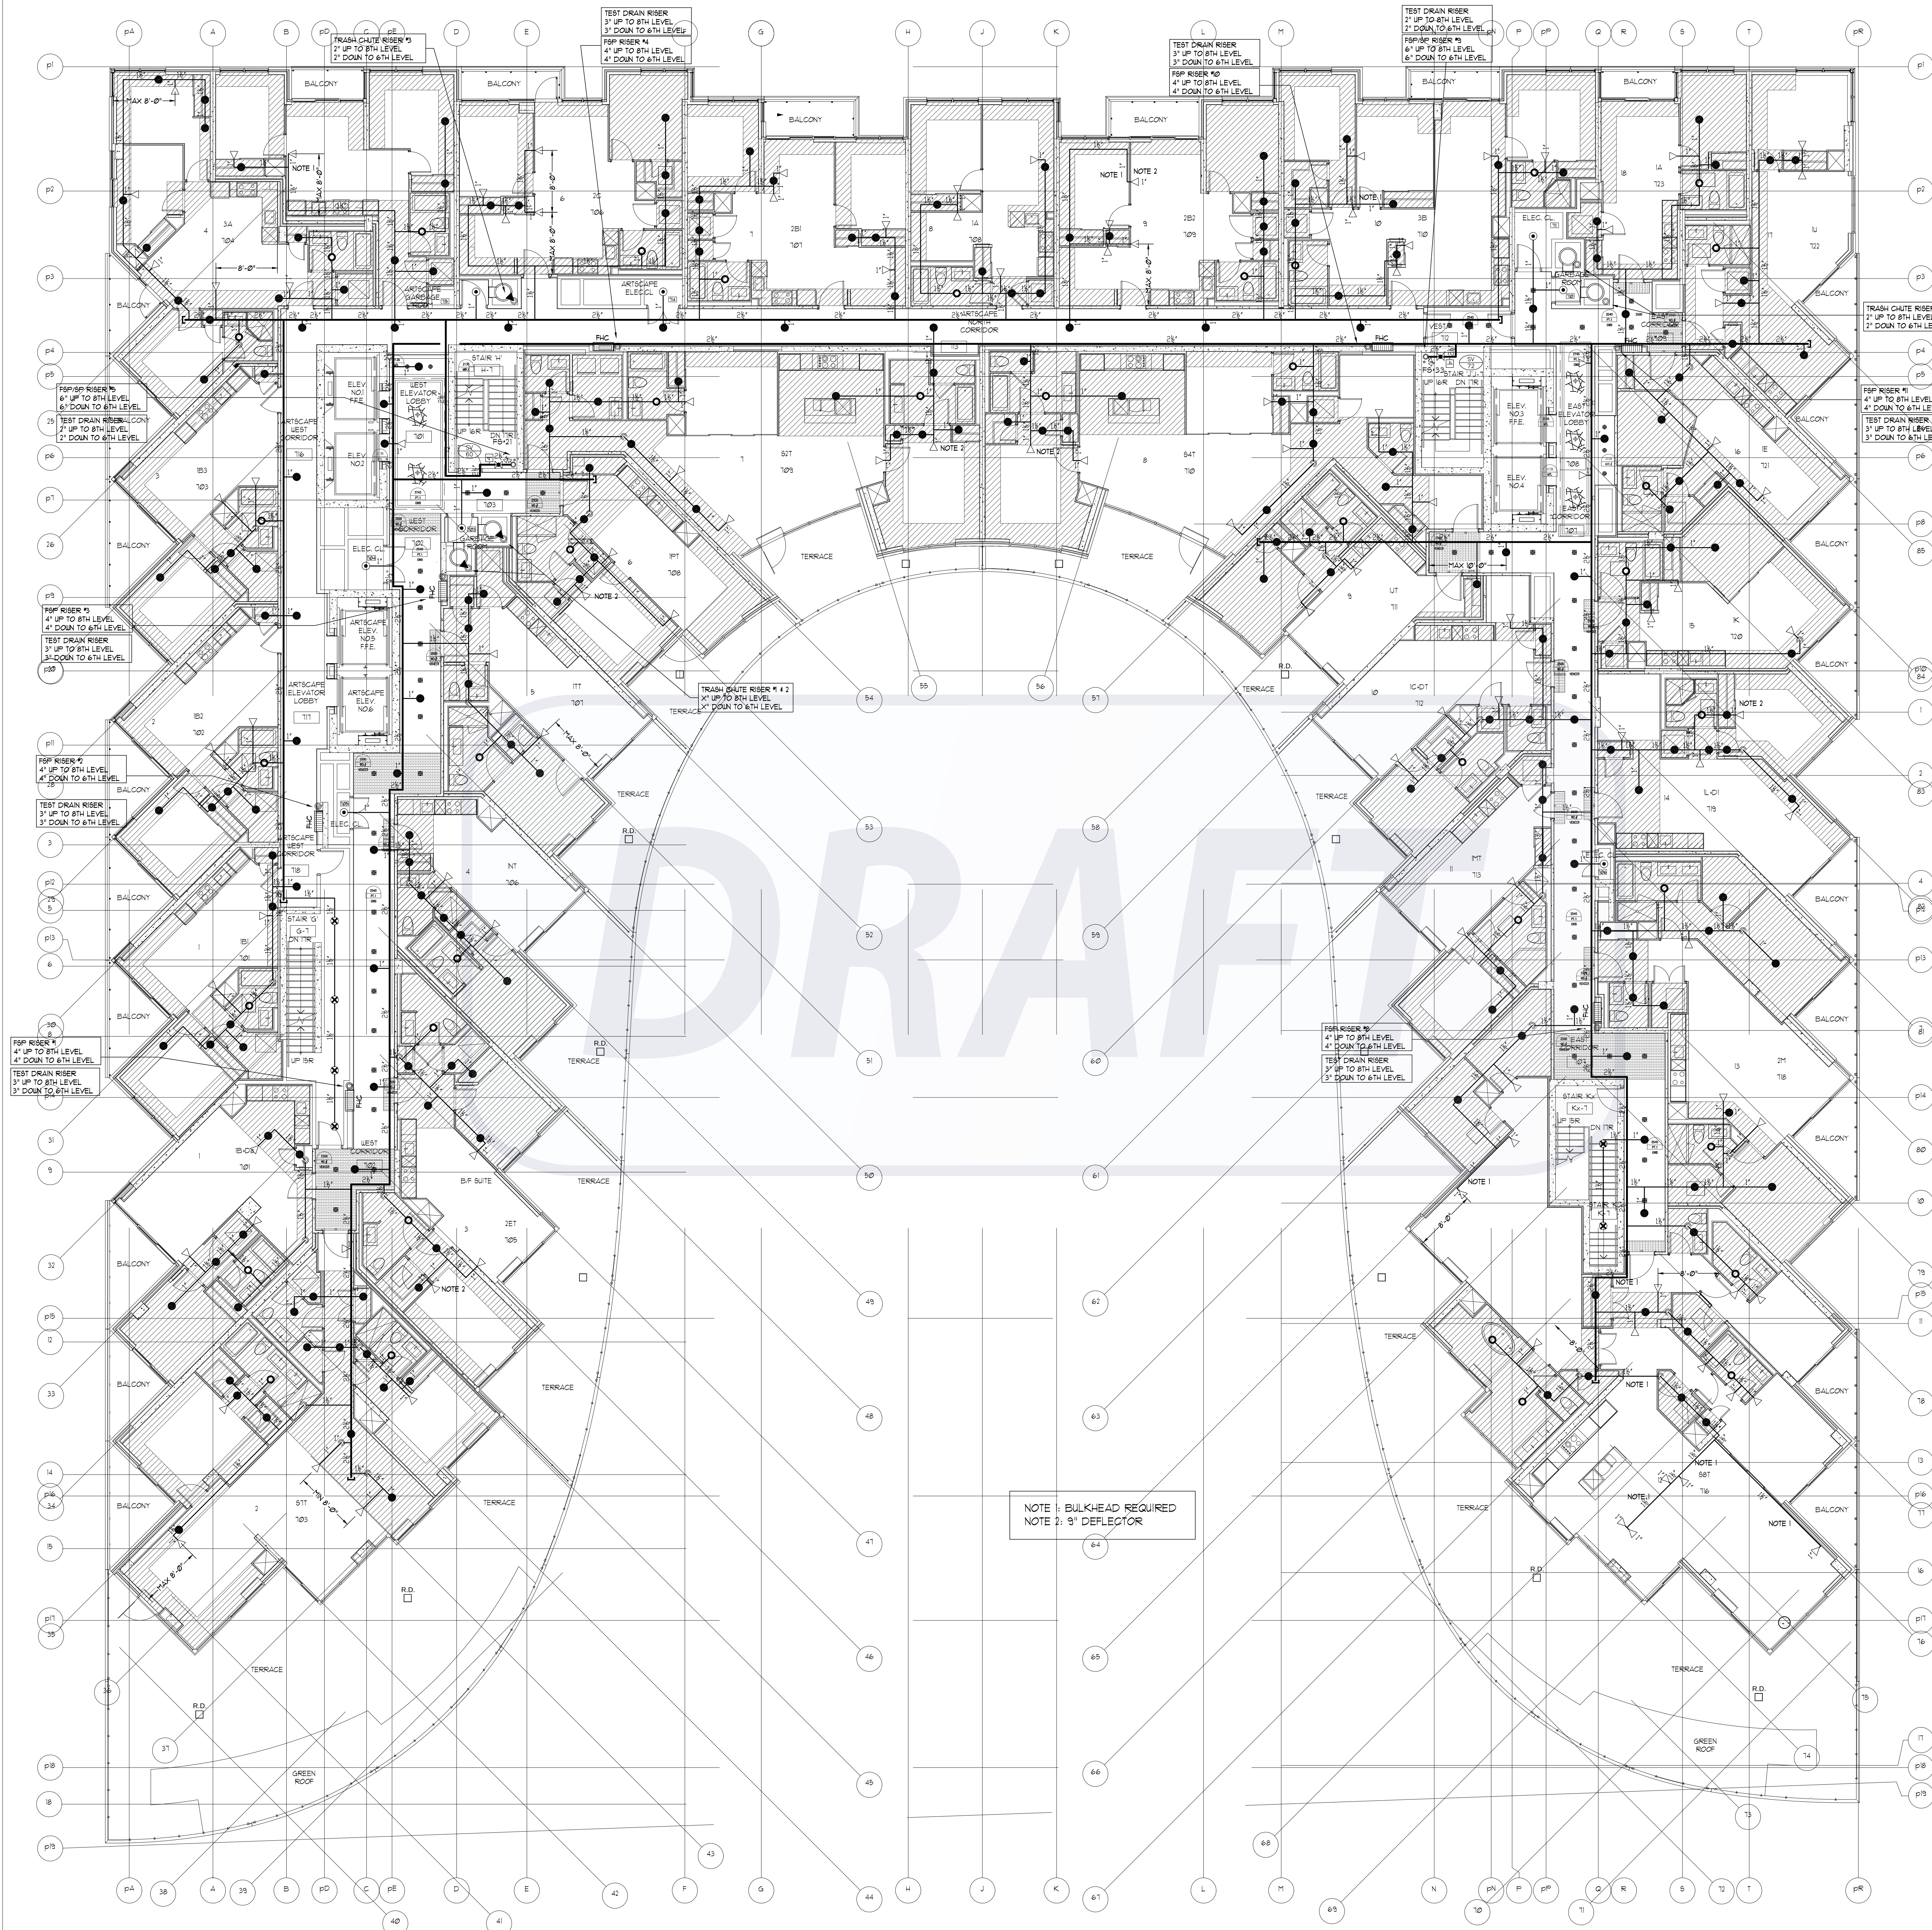


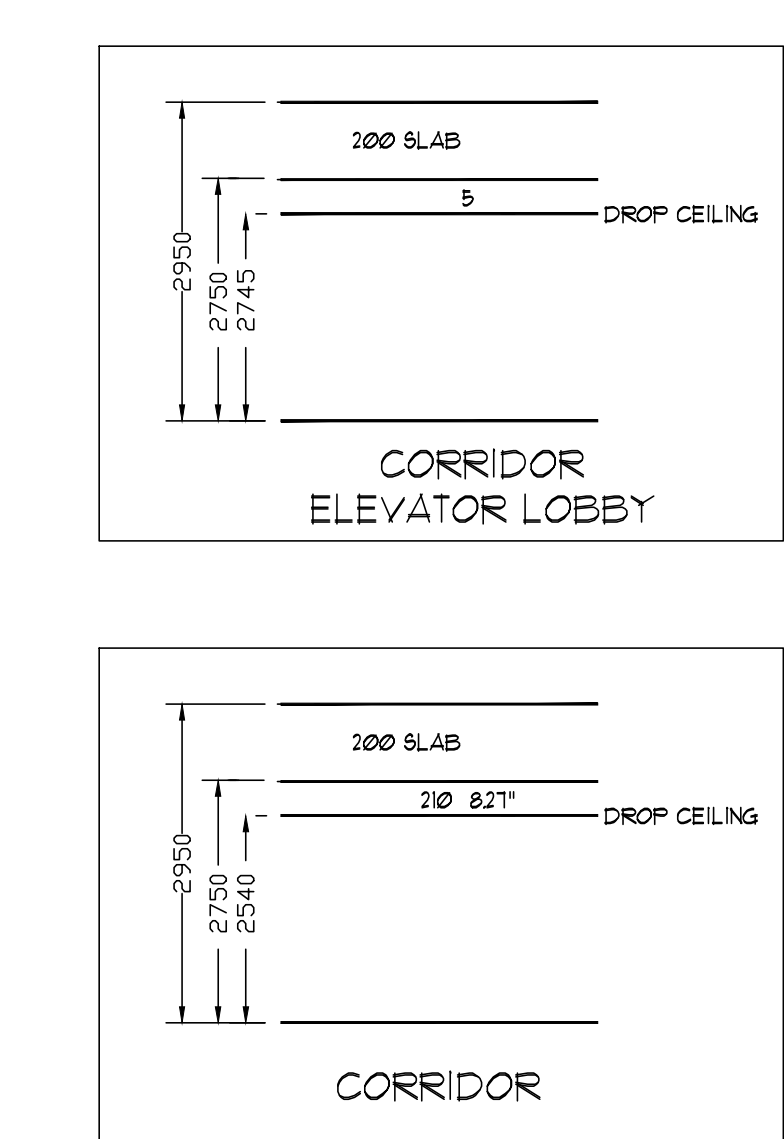

7TH LEVEL SPRINKLER LAYOUT
SCALE: 1/8" = 1'-0"

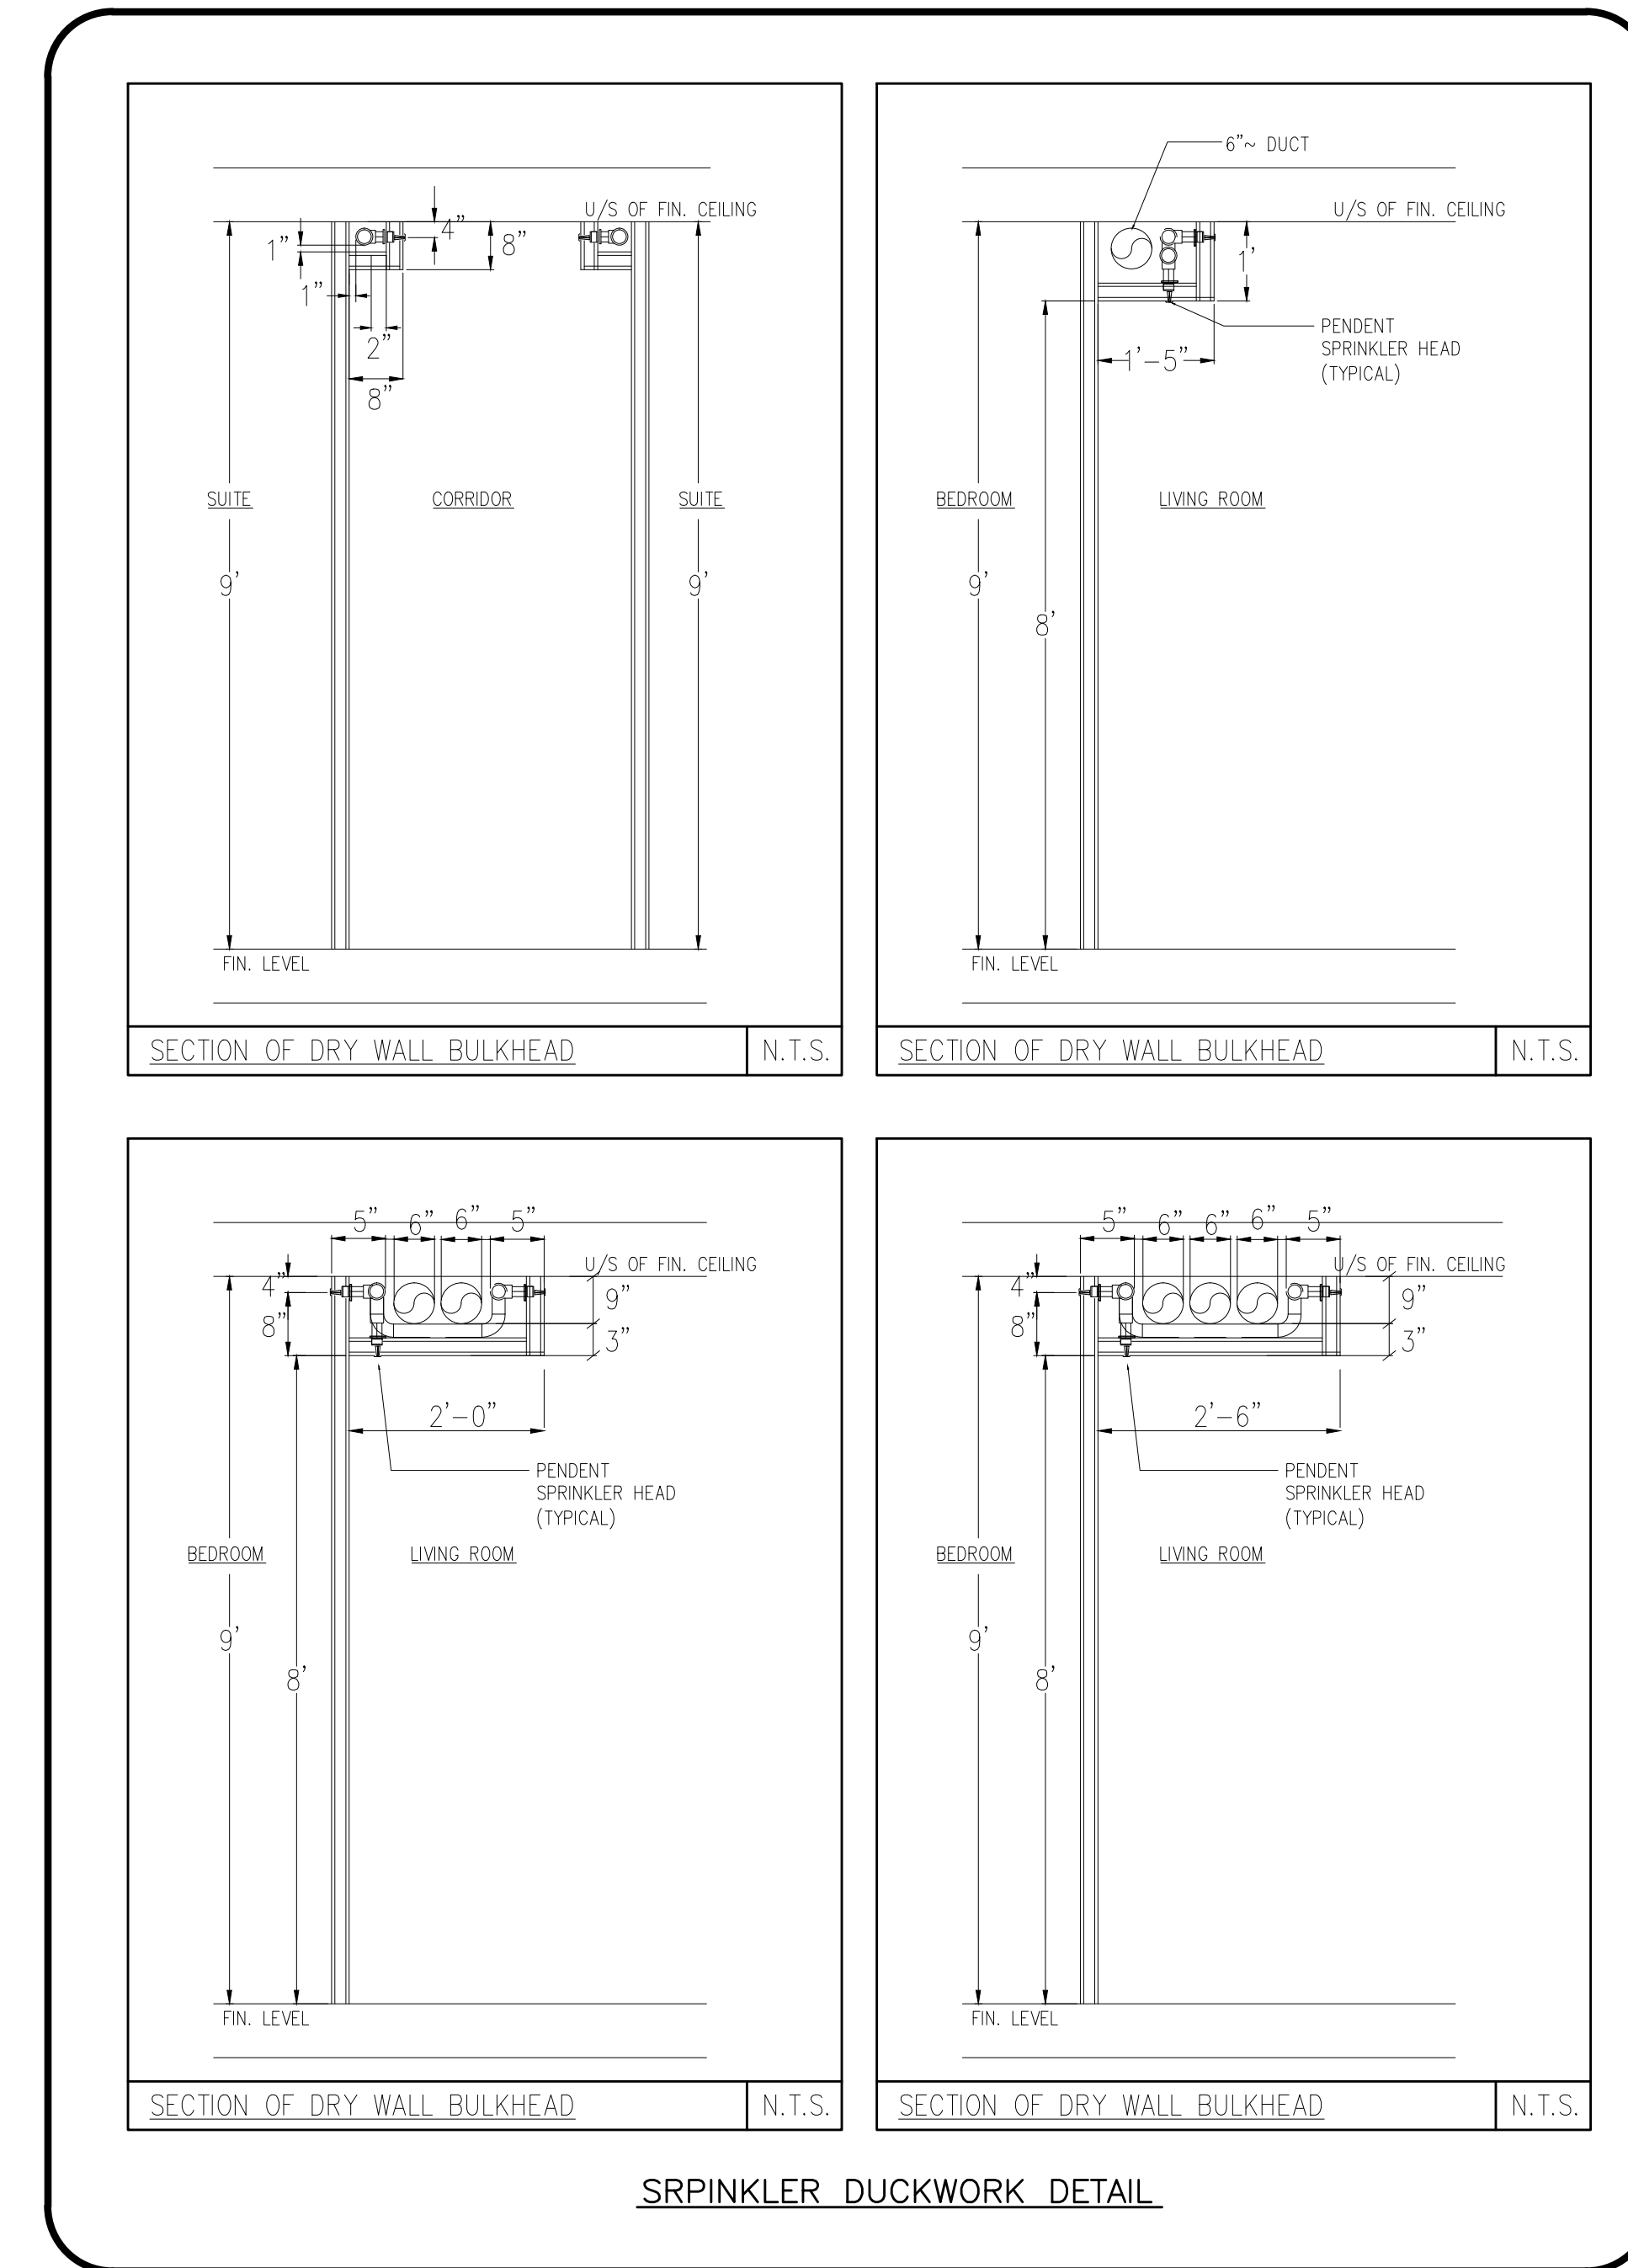

- NOTES - RESIDENTIAL SIDEWALL SPRINKLERS:
1. MAXIMUM COVERAGE FOR RESIDENTIAL SIDEWALL SPRINKLERS NOT TO EXCEED 16' x 16'.
 2. MINIMUM DISTANCE BETWEEN SPRINKLERS TO BE 8'-0".
 3. MAXIMUM DISTANCE FROM ANY SIDE WALL TO SPRINKLER NOT TO EXCEED 8'-0".
 4. SIDEWALL SPRINKLERS SHALL BE LOCATED AT LEAST 3'-0" FROM OBSTRUCTIONS SUCH AS CEILING FANS AND LIGHT FIXTURES.
 5. SEE OBSTRUCTION TABLE ON DRAWING SP1.
- NOTES - RESIDENTIAL PENDENT SPRINKLERS:
1. MAXIMUM COVERAGE FOR RESIDENTIAL PENDENT SPRINKLERS NOT TO EXCEED 350 FT².
 2. MINIMUM DISTANCE BETWEEN SPRINKLERS TO BE 8'-0".
 3. MAXIMUM DISTANCE FROM ANY SIDE WALL TO SPRINKLER NOT TO EXCEED 10'-0".
 4. PENDENT SPRINKLERS SHALL BE LOCATED AT LEAST 3'-0" FROM OBSTRUCTIONS SUCH AS CEILING FANS AND LIGHT FIXTURES.
 5. SEE OBSTRUCTION TABLE ON DRAWING SP1.

REVISIONS		
1.0	ISSUED FOR TENDER	10/15/15
2.0	ISSUED FOR TENDER ADDENDUM #1	10/23/15
3.0	ISSUED FOR CONSTRUCTION	11/27/15

NOTES	

SPRINKLER LEGEND	
1/2" 165°F SC BR BRASS UPRIGHT SPRINKLER K=5.6	4
1/2" 165°F SC BR CONCEALED PENDENT SPRINKLER K=5.6 LH	00
1/2" 165°F SC BR BRASS UPRIGHT SPRINKLER K=5.6 OH	8
VIKING MODEL VK457 FREEDOM RESIDENTIAL CONCEALED PENDENT SPRINKLER C/W WHITE 3-5/16" COVER PLATE K=4.9 165°F	23.3
VIKING MODEL VK457 FREEDOM RESIDENTIAL CONCEALED PENDENT SPRINKLER C/W WHITE 3-5/16" COVER PLATE K=4.9 165°F ENTICORROSION RESISTANT COATING	38
VIKING MODEL VK480 FREEDOM RESIDENTIAL HORIZONTAL WHITE SIDEWALL SPRINKLER C/W WHITE ESCUTCHEON PLATE 1/2" K=4.0 165°F 8" DEFLECTOR U.N.O. (MAXIMUM COVERAGE 16'x16' U.N.O.)	110
1/2" 165°F SC SR SIDEWALL SPRINKLER K=5.6 OH	3
FIRE HOSE CABINET SEE DETAIL SHEET SP1	7

TRIDEL
BUILT FOR LIFE

4800 Dufferin St
Toronto, Ontario M3H 5S9
(tel): 416-861-9290

MIRENDA
INCORPORATED

15171 Yonge Street Suite 202
Aurora Ontario L4G 1M1
(tel): 905-727-0092
(fax): 905-727-5517

NORTH		STAMP	
PROJECT: AQUAVISTA			
MERCHANTS WHARF TORONTO, ONTARIO			
DWG TITLE: 7TH LEVEL SPRINKLER LAYOUT			
DATE: 11/27/2015	PROJECT NO.: 15-678	DWG NO.: SP12	
SCALE: 1/8" = 1'-0"		OF SP21	
DWN BY: JL			
ISSUED FOR REVISION NO.: 3.0			