

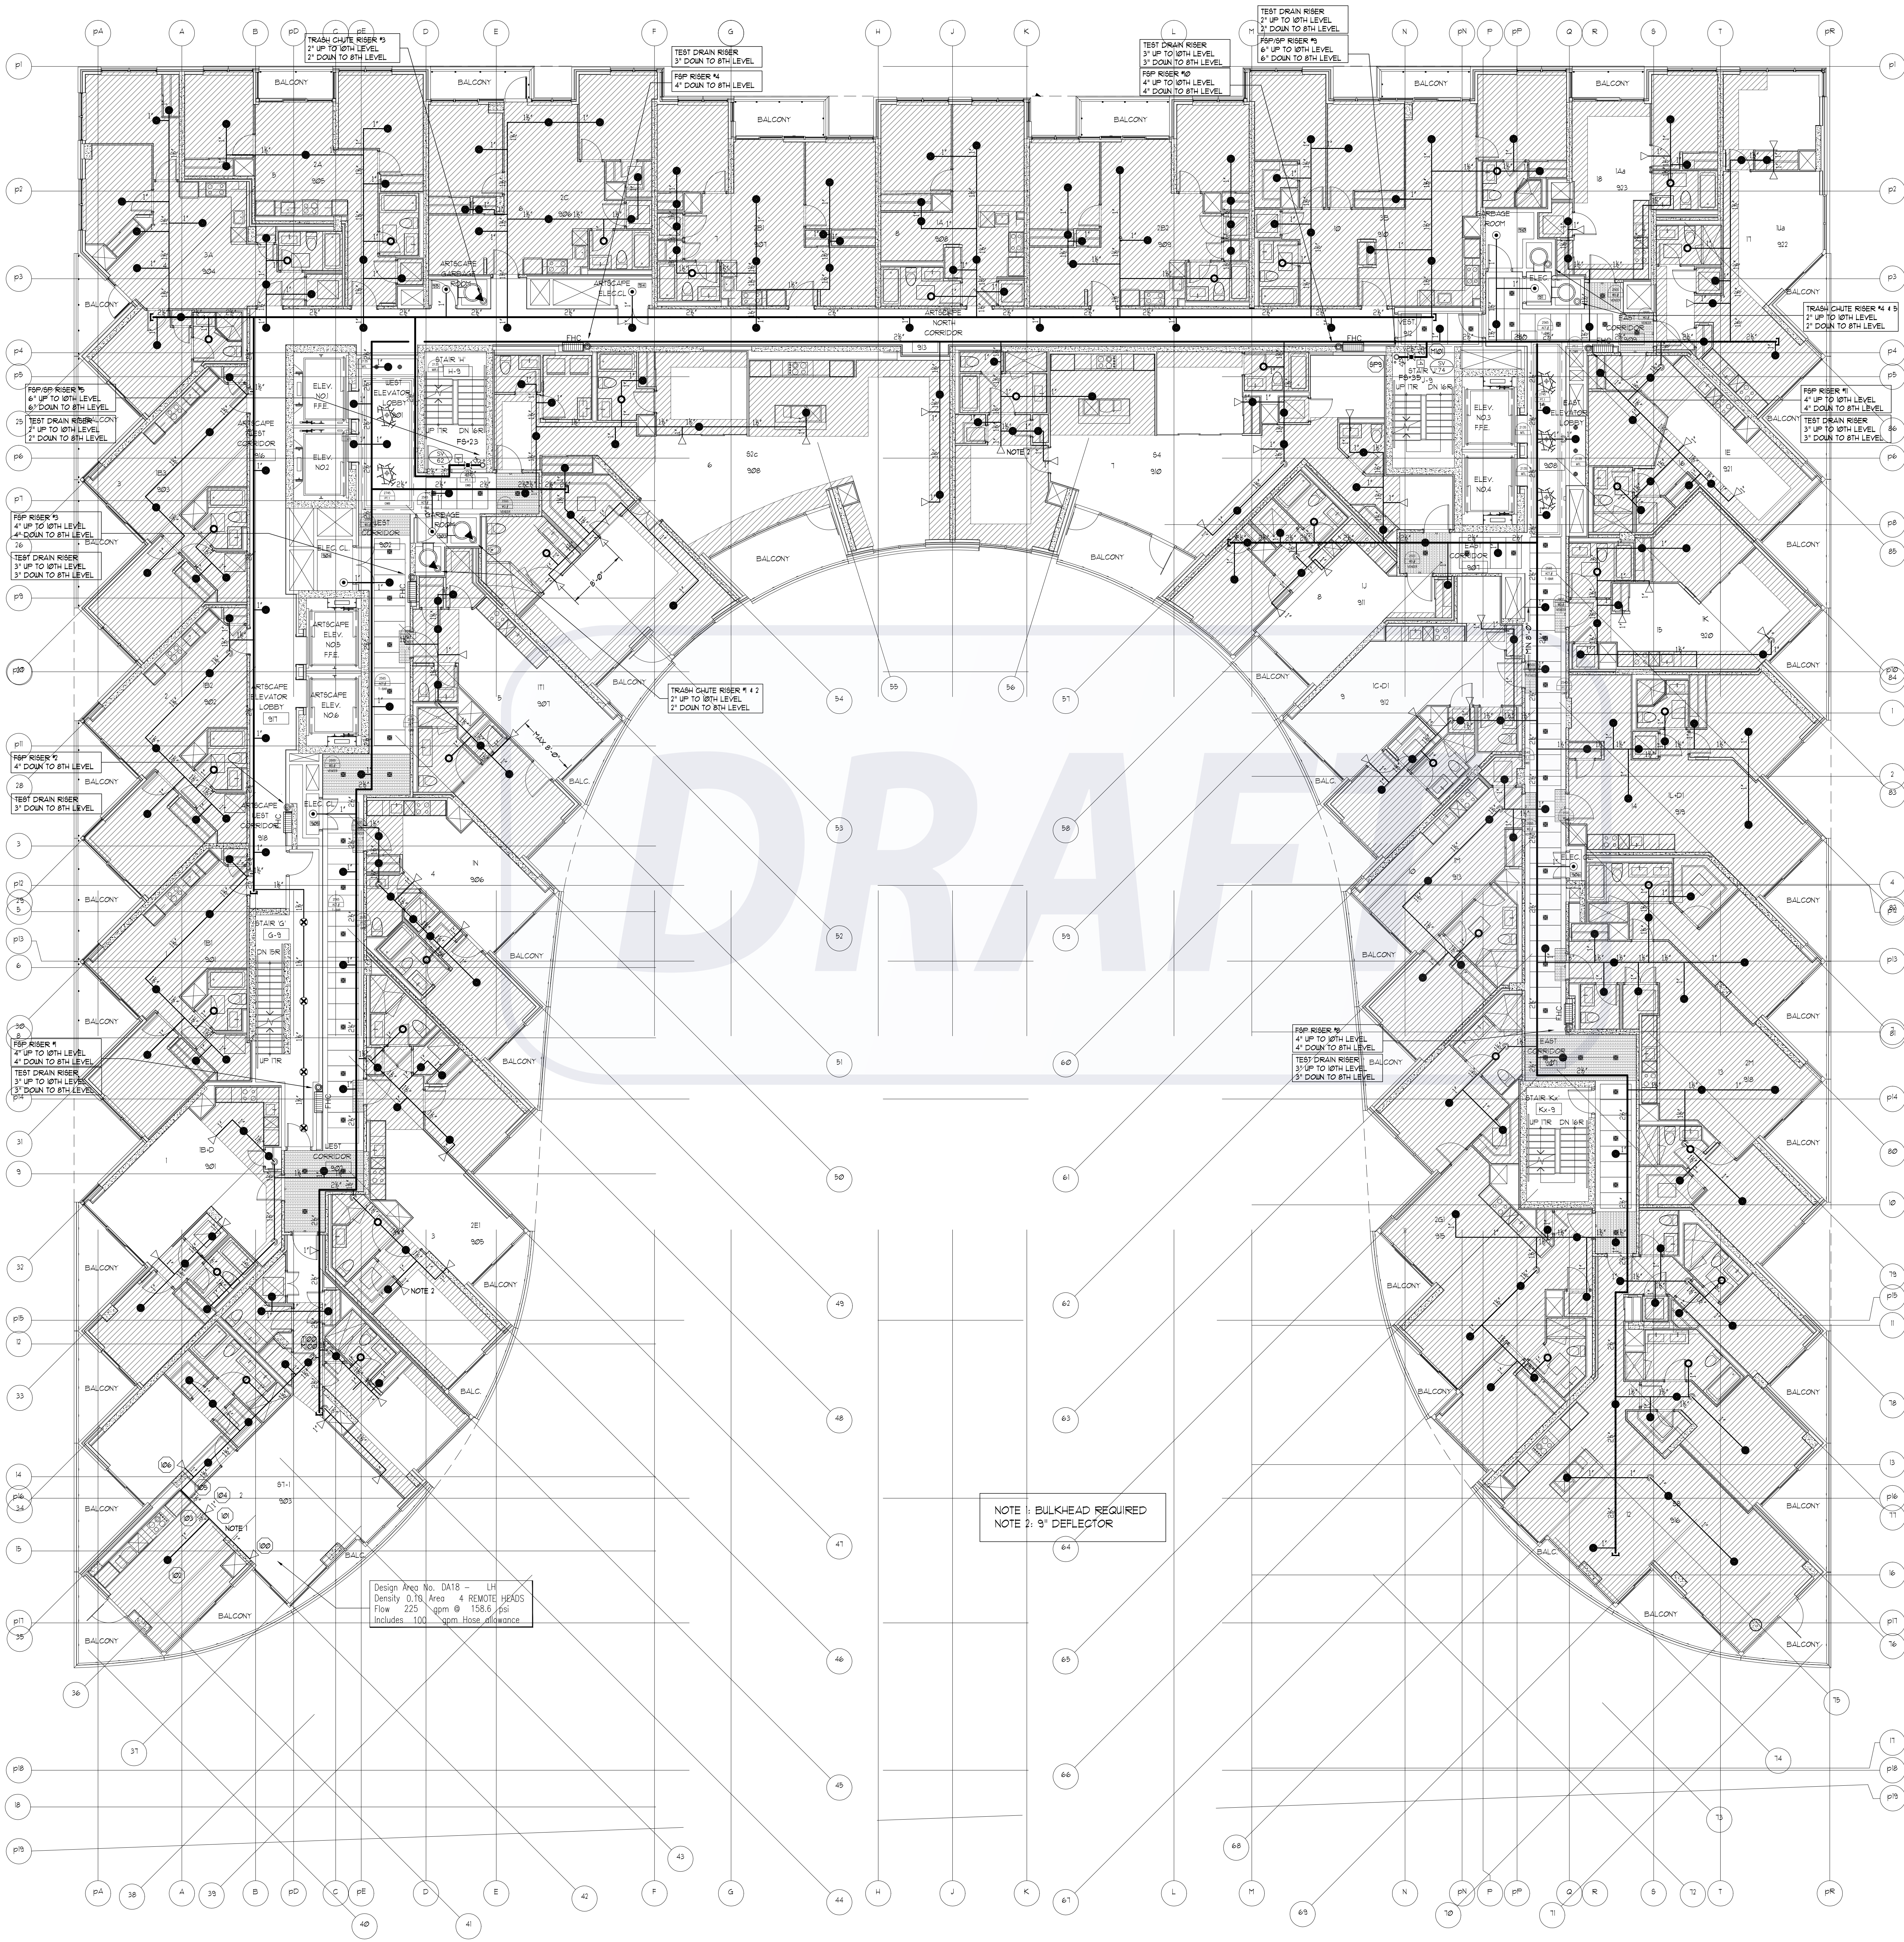


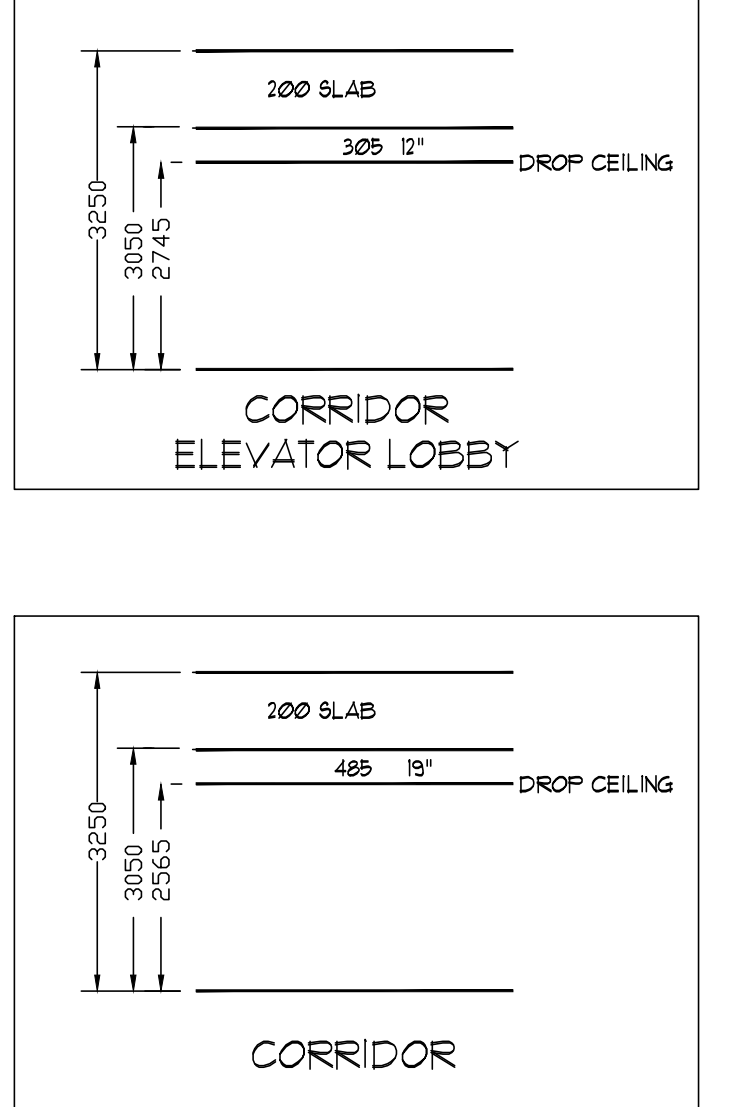

9TH LEVEL SPRINKLER LAYOUT
SCALE: 1/8" = 1'-0"

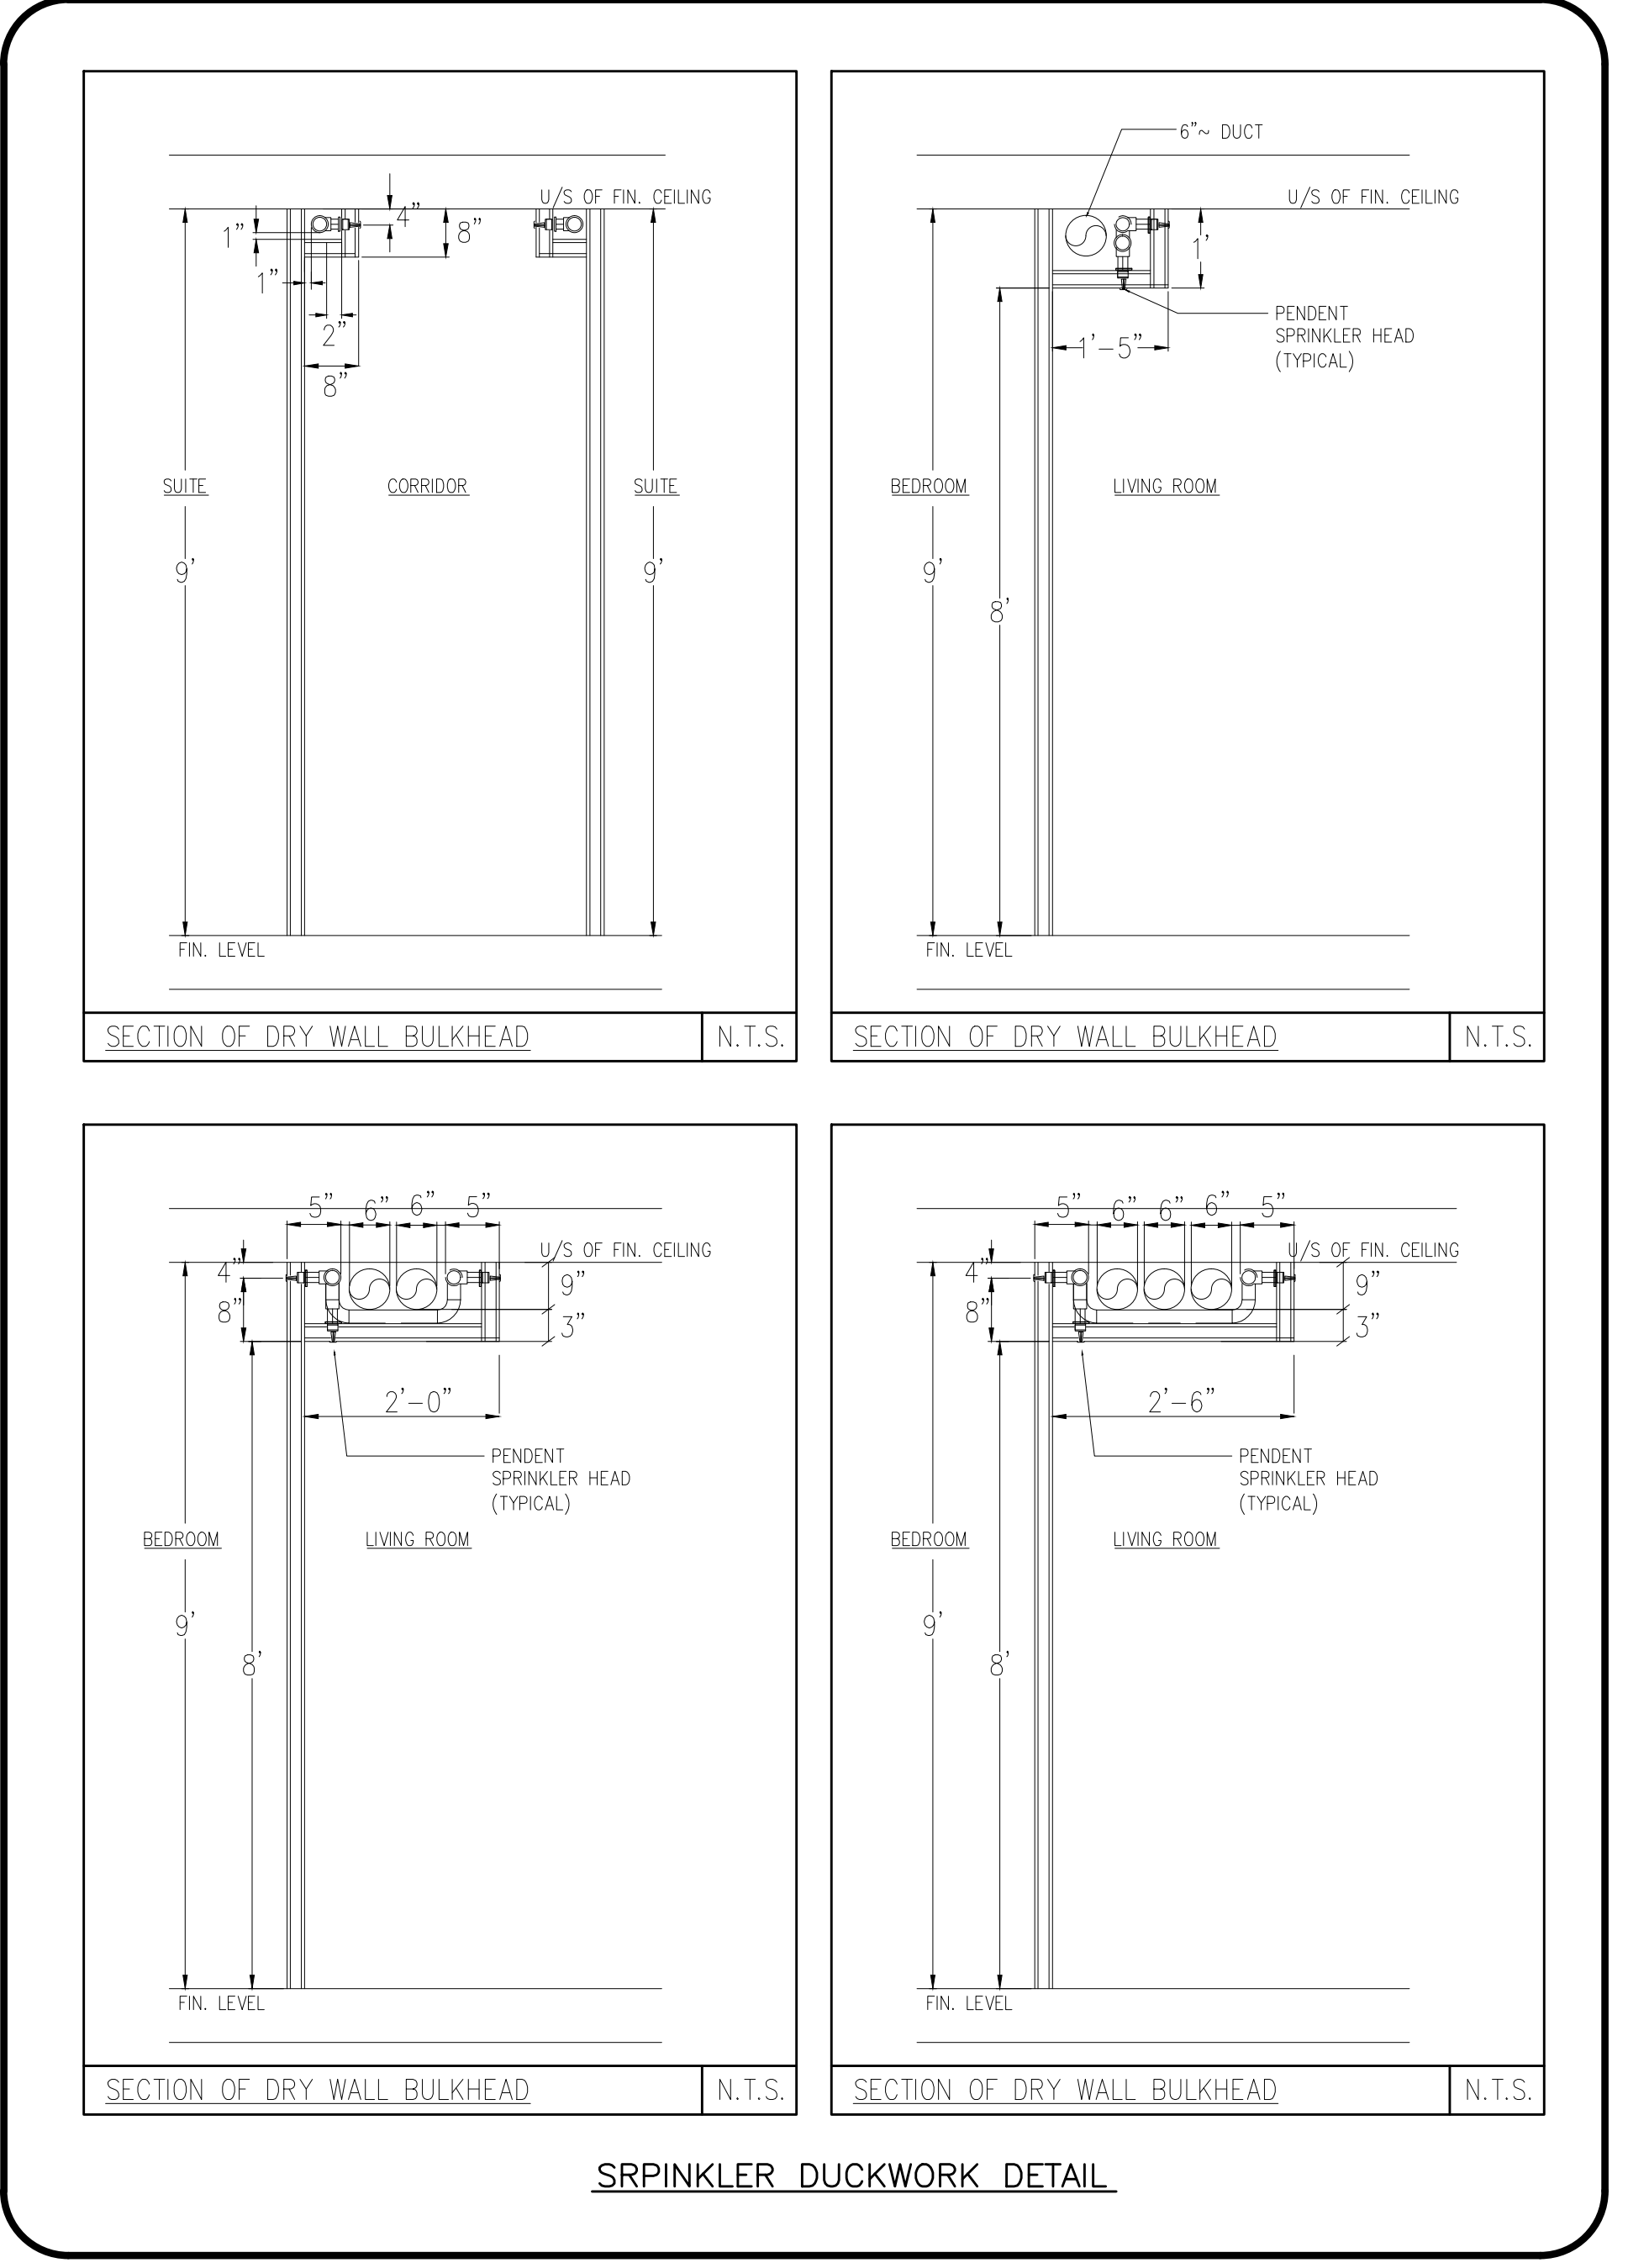

- NOTES - RESIDENTIAL SIDEWALL SPRINKLERS:
1. MAXIMUM COVERAGE FOR RESIDENTIAL SIDEWALL SPRINKLERS NOT TO EXCEED 16 x 16.
 2. MINIMUM DISTANCE BETWEEN SPRINKLERS TO BE 8'-0".
 3. MAXIMUM DISTANCE FROM ANY SIDE WALL TO SPRINKLER NOT TO EXCEED 8'-0".
 4. SIDEWALL SPRINKLERS SHALL BE LOCATED AT LEAST 5'-0" FROM OBSTRUCTIONS SUCH AS CEILING FANS AND LIGHT FIXTURES.
 5. SEE OBSTRUCTION TABLE ON DRAWING SP1.
- NOTES - RESIDENTIAL PENDENT SPRINKLERS:
1. MAXIMUM COVERAGE FOR RESIDENTIAL PENDENT SPRINKLERS NOT TO EXCEED 350 FT².
 2. MINIMUM DISTANCE BETWEEN SPRINKLERS TO BE 8'-0".
 3. MAXIMUM DISTANCE FROM ANY SIDE WALL TO SPRINKLER NOT TO EXCEED 10'-0".
 4. PENDENT SPRINKLERS SHALL BE LOCATED AT LEAST 3'-0" FROM OBSTRUCTIONS SUCH AS CEILING FANS AND LIGHT FIXTURES.
 5. SEE OBSTRUCTION TABLE ON DRAWING SP1.

REVISIONS

1.0	ISSUED FOR TENDER	10/15/15
2.0	ISSUED FOR TENDER ADDENDUM #1	10/23/15
3.0	ISSUED FOR CONSTRUCTION	11/27/15

NOTES

SPRINKLER LEGEND

	1/2" 165°F SC OR BRASS UPRIGHT SPRINKLER K= 5.6	4
	1/2" 165°F SC SR SIDEWALL SPRINKLER K= 5.6 OH	5
	1/2" 165°F SC SR BRASS UPRIGHT SPRINKLER K= 5.6 OH	8
	VIKING MODEL VK457 FREEDOM RESIDENTIAL CONCEALED PENDENT SPRINKLER C/W WHITE 3-5/16" COVER PLATE K=4.9 165°F	268
	VIKING MODEL VK457 FREEDOM RESIDENTIAL CONCEALED PENDENT SPRINKLER C/W WHITE 3-5/16" COVER PLATE K=4.9 165°F (ANTICORROSION RESISTANT COATING)	37
	VIKING MODEL VK480 FREEDOM RESIDENTIAL HORIZONTAL WHITE SIDEWALL SPRINKLER C/W WHITE ESCUTCHEON PLATE 1/2" K=4.9 165°F 8" DEFLECTOR U.N.O. (MAXIMUM COVERAGE 16'X18' U.N.O.)	46
	FIRE HOSE CABINET SEE DETAIL SHEET SP1	7

TRIDEL
BUILT FOR LIFE

4800 Dufferin St.
Toronto, Ontario M3H 5S9
(tel): 416-661-9290

MIRENDA
INCORPORATED

15171 Yonge Street Suite 202
Aurora Ontario L4G 1M1
(tel): 905-727-0092
(fax): 905-727-5517

NORTH

STAMP

PROJECT

AQUAVISTA
MERCHANTS WHARF
TORONTO, ONTARIO

DWG TITLE

9TH LEVEL
SPRINKLER LAYOUT

DATE

11/27/2015

SCALE

1/8"=1'-0"

DWN BY

JL

ISSUED FOR REVISION NO.

3.0

PROJECT NO.

15-678

DWG NO.

SP14

OF SP21