

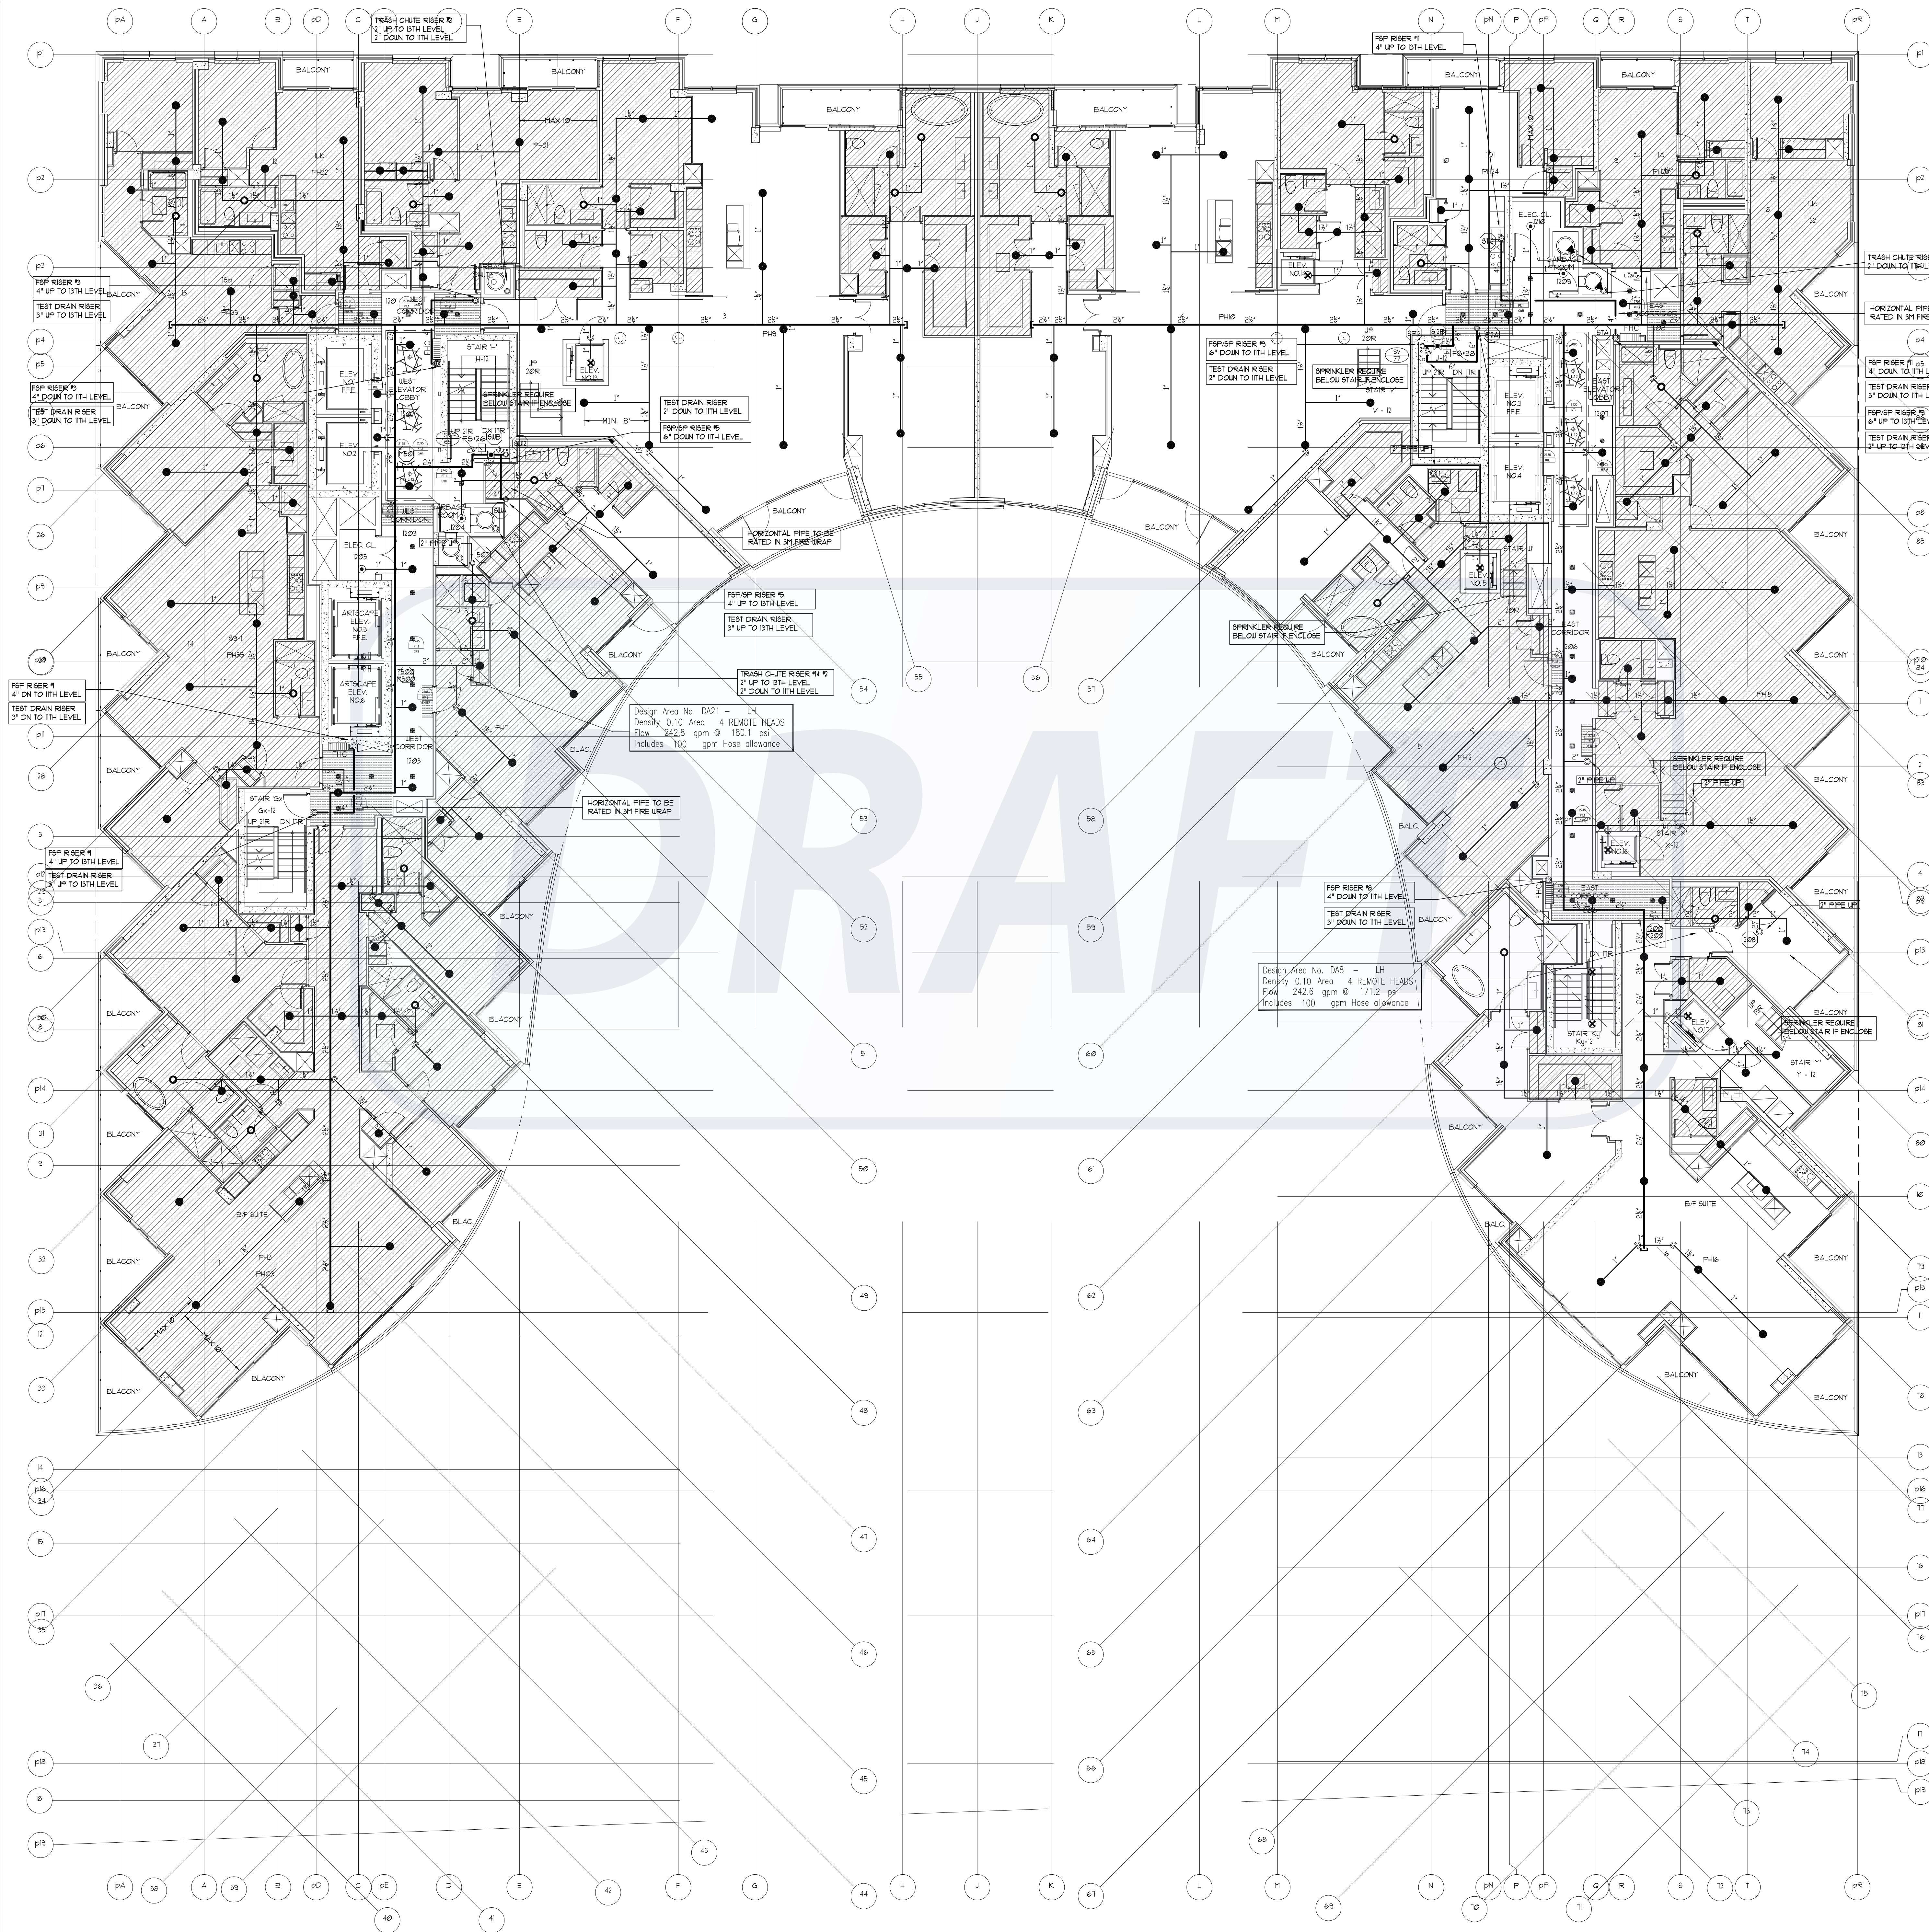


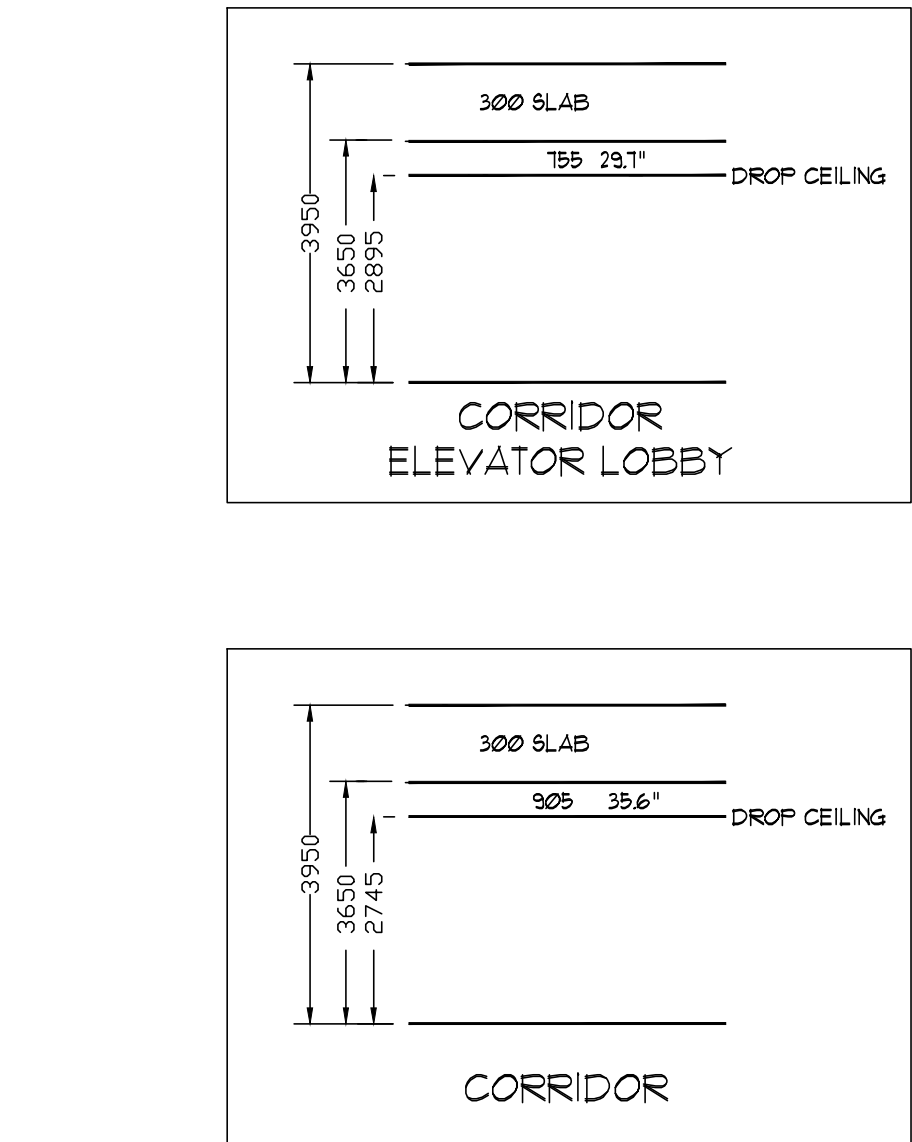

12TH LEVEL SPRINKLER LAYOUT
SCALE: 1/8" = 1'-0"

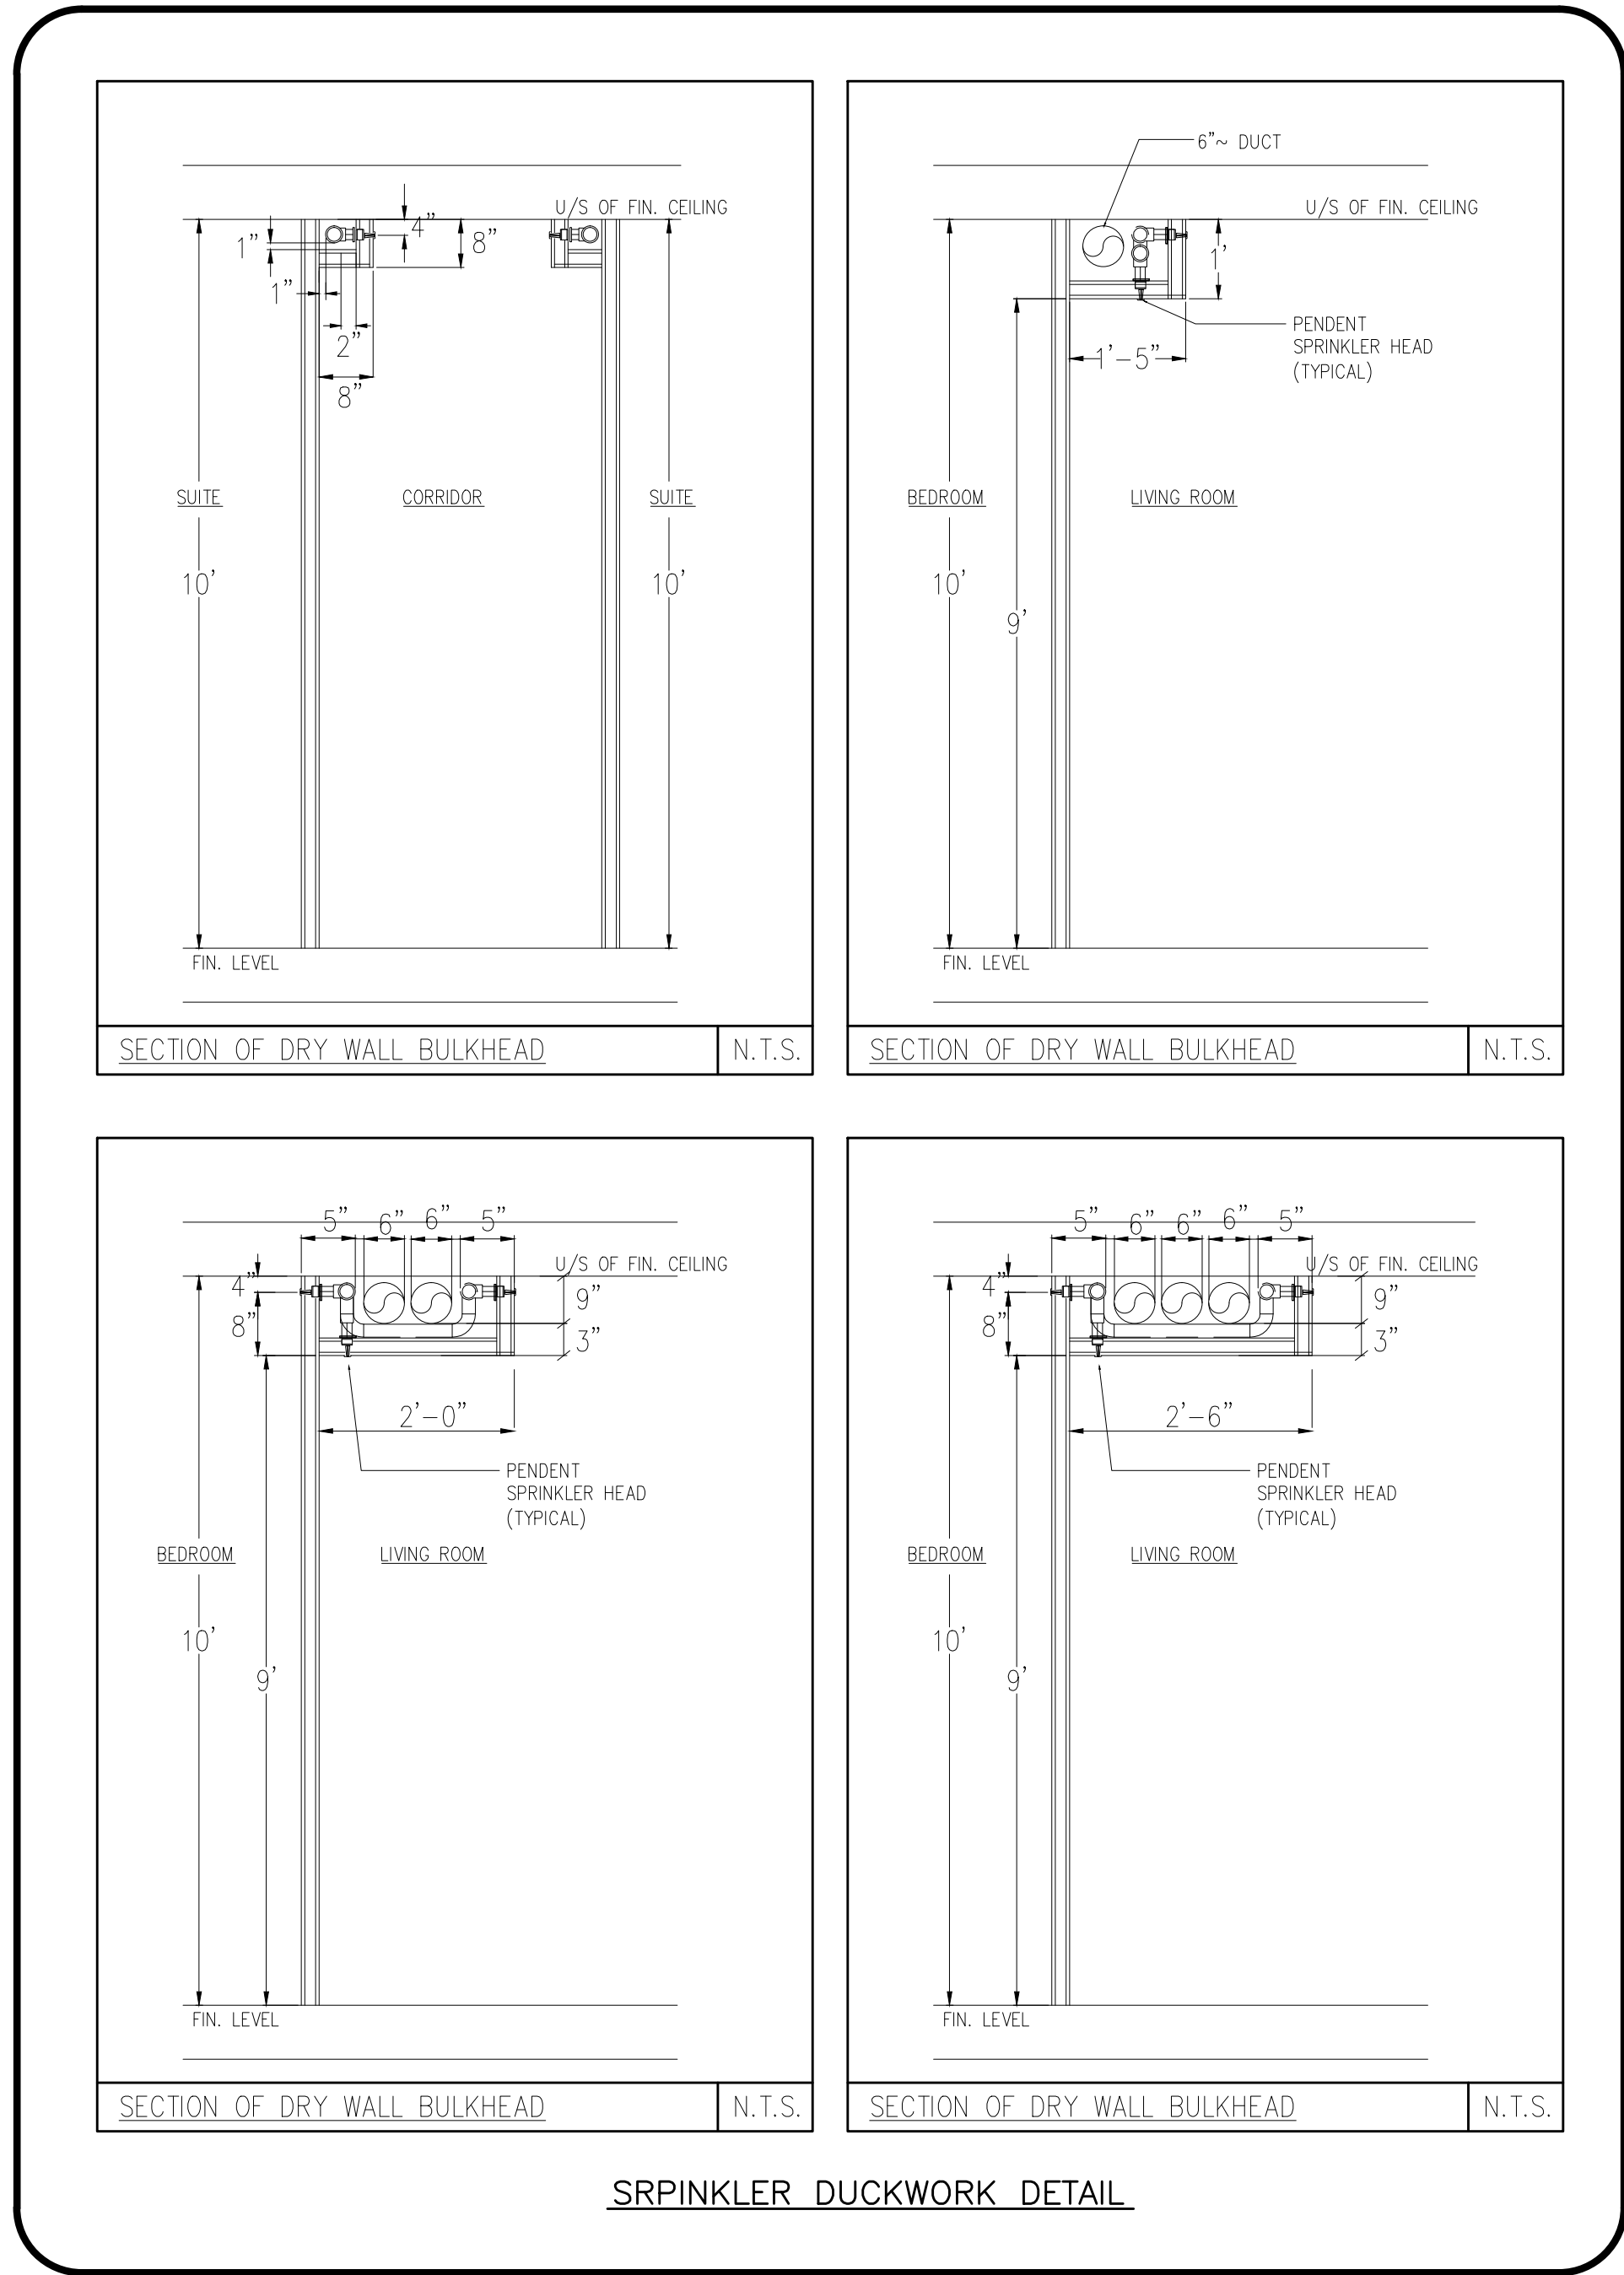

NOTES - RESIDENTIAL SIDEWALL SPRINKLERS:

1. MAXIMUM COVERAGE FOR RESIDENTIAL SIDEWALL SPRINKLERS NOT TO EXCEED 16 X 16.
2. MINIMUM DISTANCE BETWEEN SPRINKLERS TO BE 8'-0".
3. MAXIMUM DISTANCE FROM ANY SIDE WALL TO SPRINKLER NOT TO EXCEED 8'-0".
4. SIDEWALL SPRINKLERS SHALL BE LOCATED AT LEAST 5'-0" FROM OBSTRUCTIONS SUCH AS CEILING FANS AND LIGHT FIXTURES.
5. SEE OBSTRUCTION TABLE ON DRAWING SP1.

NOTES - RESIDENTIAL PENDENT SPRINKLERS:

1. MAXIMUM COVERAGE FOR RESIDENTIAL PENDENT SPRINKLERS NOT TO EXCEED 350 FT².
2. MINIMUM DISTANCE BETWEEN SPRINKLERS TO BE 8'-0".
3. MAXIMUM DISTANCE FROM ANY SIDE WALL TO SPRINKLER NOT TO EXCEED 10'-0".
4. PENDENT SPRINKLERS SHALL BE LOCATED AT LEAST 3'-0" FROM OBSTRUCTIONS SUCH AS CEILING FANS AND LIGHT FIXTURES.
5. SEE OBSTRUCTION TABLE ON DRAWING SP1.

REVISIONS	
1.0	ISSUED FOR TENDER 10/15/15
2.0	ISSUED FOR TENDER ADDENDUM #1 10/23/15
3.0	ISSUED FOR CONSTRUCTION 11/27/15

NOTES

SPRINKLER LEGEND	
1/2" 165°F SC OR BRASS UPRIGHT SPRINKLER K=5.6 LH	7
1/2" 165°F SC SR BRASS UPRIGHT SPRINKLER K=5.6 OH	4
VIKING MODEL VK457 FREEDOM RESIDENTIAL CONCEALED PENDENT SPRINKLER C/W WHITE 3-5/16" COVER PLATE K=4.9 165°F	216
VIKING MODEL VK457 FREEDOM RESIDENTIAL CONCEALED PENDENT SPRINKLER C/W WHITE 3-5/16" COVER PLATE K=4.9 165°F ENT(CORROSION RESISTANT COATING)	24
1/2" 165°F SC SR SIDEWALL SPRINKLER K=5.6 OH	2
FIRE HOSE CABINET SEE DETAIL SHEET SP1	5

TRIDEL
BUILT FOR LIFE

4800 Dufferin St
Toronto, Ontario M3H 5S9
(tel): 416-661-9290

MIRENDA
INCORPORATED

15171 Yonge Street Suite 202
Aurora Ontario L4G 1M1
(tel): 905-727-0092
(fax): 905-727-3517

NORTH

STAMP

15171 YONGE STREET SUITE 202
AURORA ONTARIO L4G 1M1
(TEL): 905-727-0092
(FAX): 905-727-3517

RAKVERINI
2170

PROVINCE OF ONTARIO

PROJECT	
AQUAVISTA	
MERCHANTS WHARF TORONTO, ONTARIO	
DWG TITLE	
12TH LEVEL SPRINKLER LAYOUT	
DATE	11/27/2015
SCALE	1/8"=1'-0"
DWN BY	L.W.
ISSUED FOR REVISION NO.	3.0
PROJECT NO.	15-678
DWG NO.	SP17
OF SP21	