


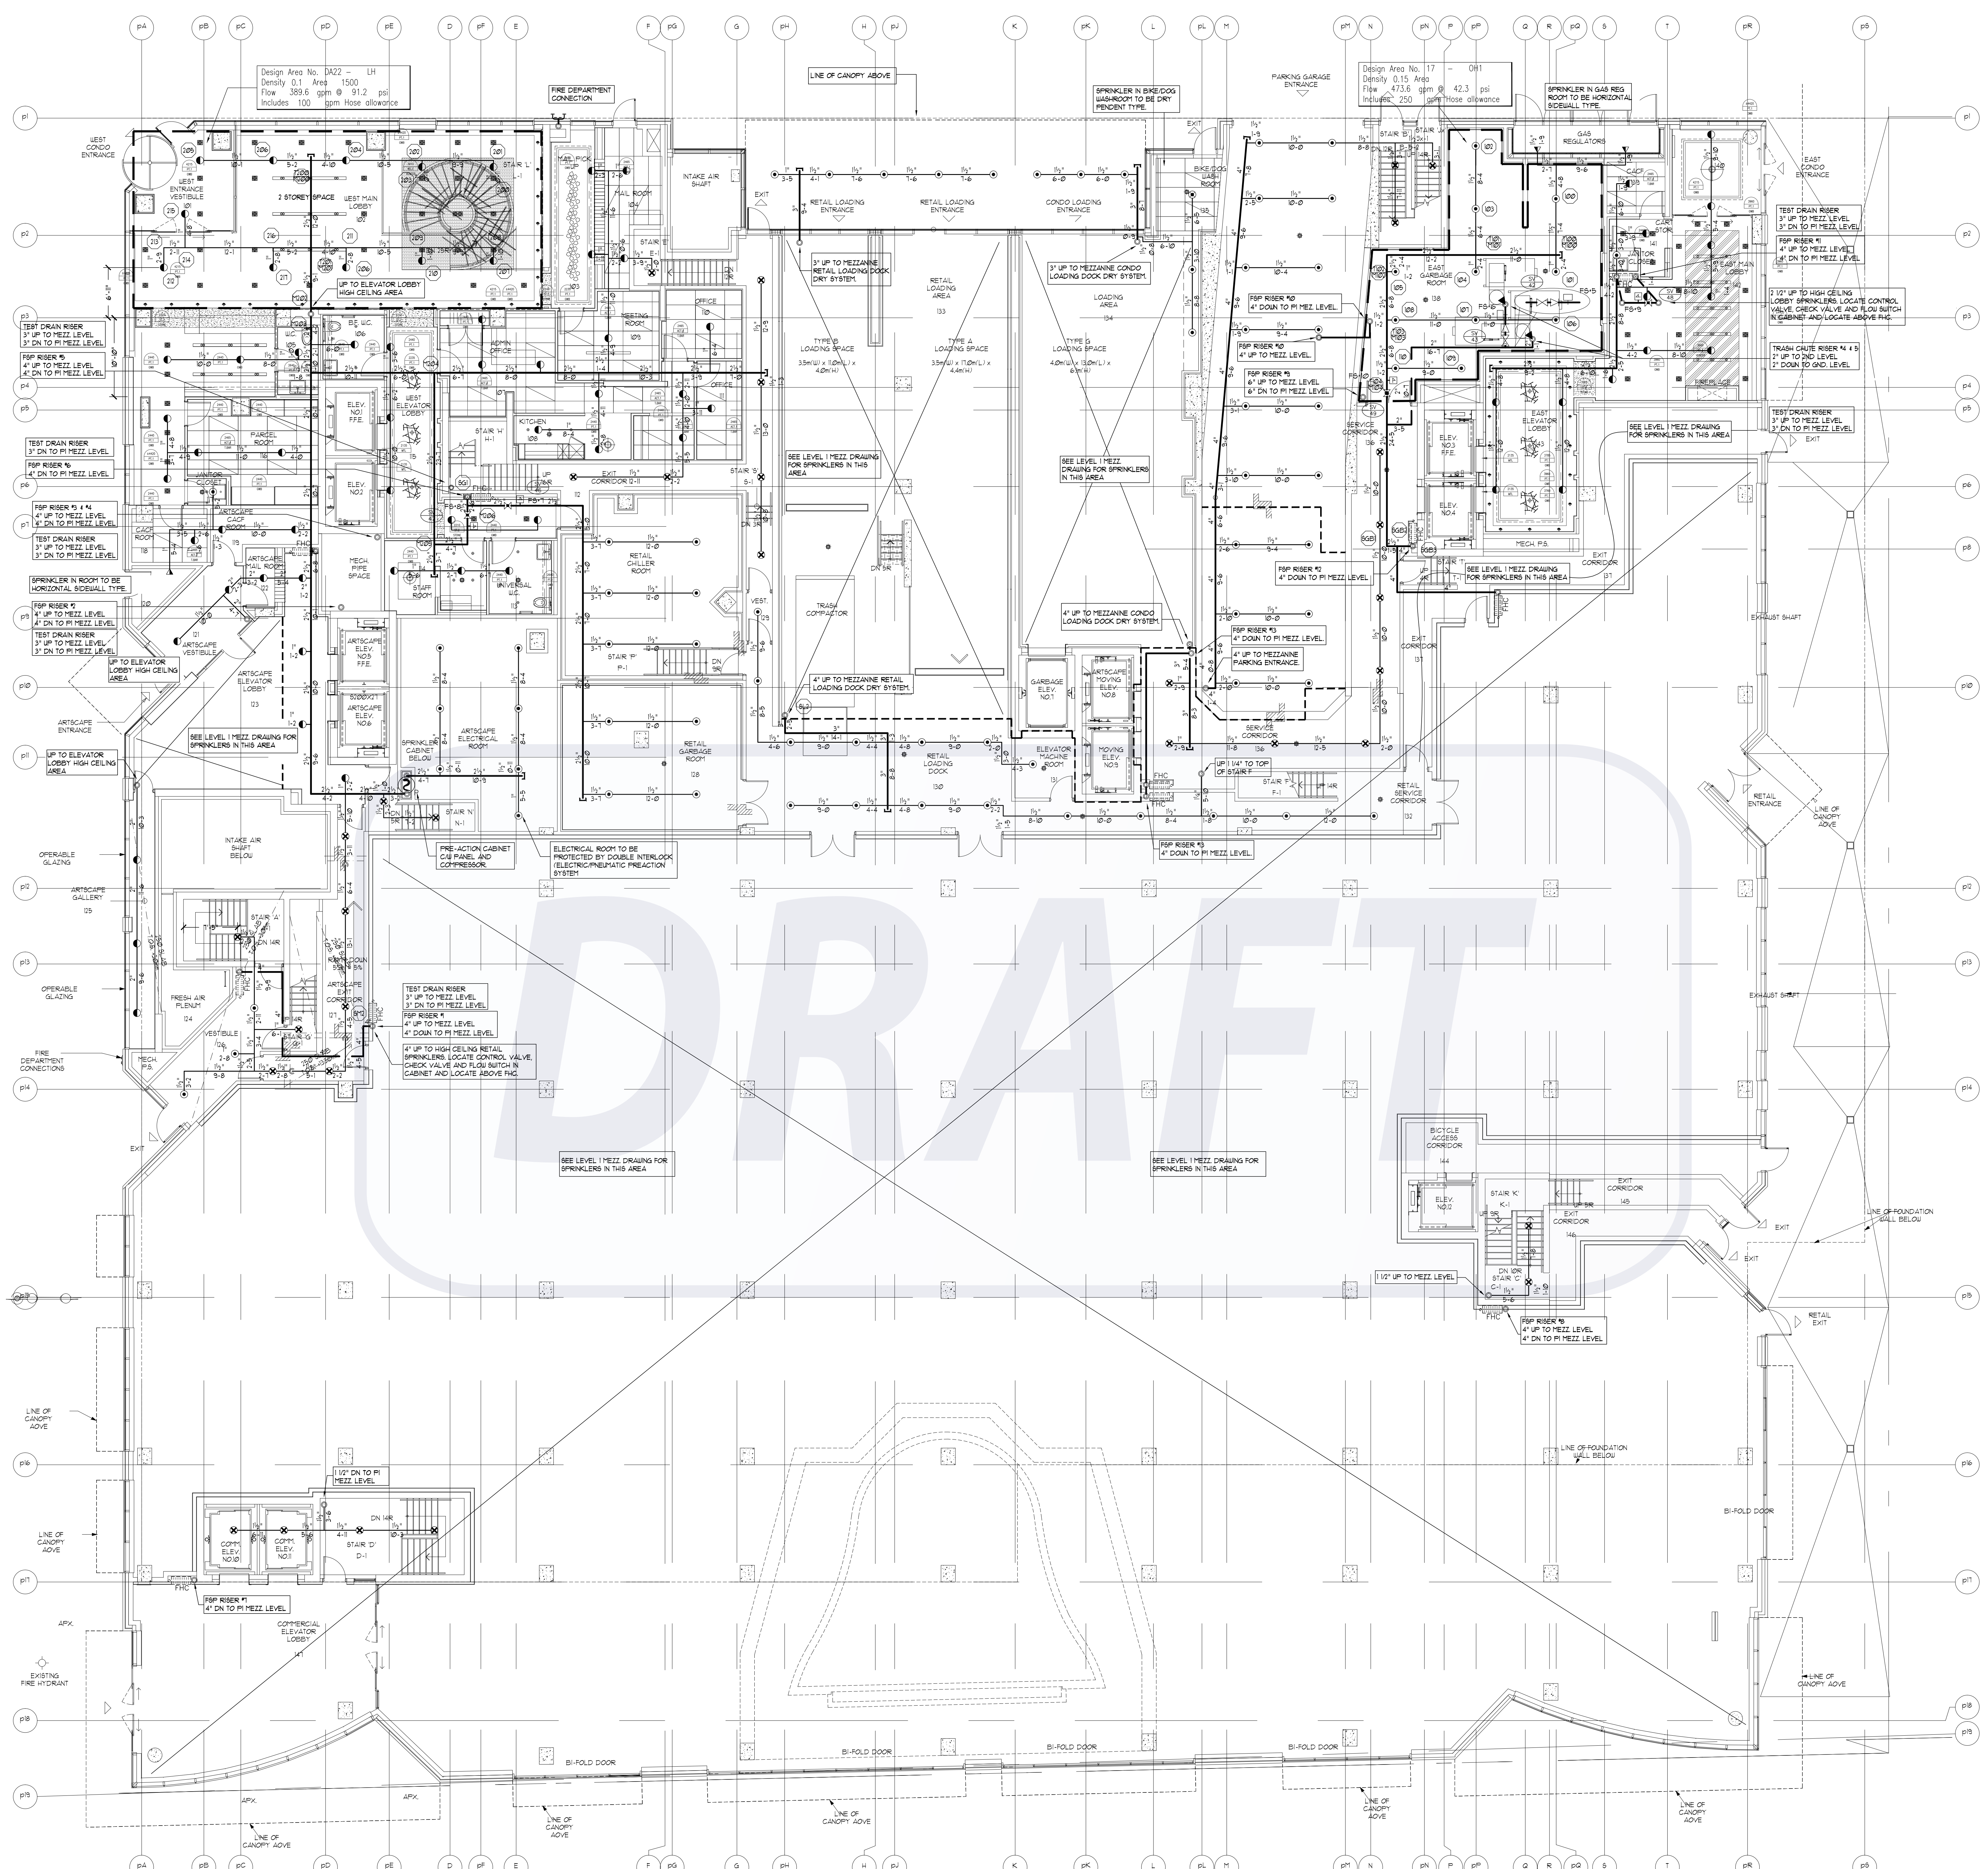

GROUND LEVEL SPRINKLER LAYOUT
SCALE: 1/8"=1'-0"

REVISIONS	
1.0	ISSUED FOR TENDER 10/15/15
2.0	ISSUED FOR TENDER ADDENDUM #1 10/23/15
3.0	ISSUED FOR CONSTRUCTION 11/27/15

NOTES	

SPRINKLER LEGEND	
1/2" 165°F SC QR DRY HORIZONTAL SIDEWALL SPRINKLER K= 5.6	2
1/2" 165°F SC QR BRASS UPRIGHT SPRINKLER K= 5.6	33
1/2" 165°F SC SR SIDEWALL SPRINKLER K= 5.6 OH	2
1/2" 165°F SC QR CONCEALED PENDENT SPRINKLER K= 5.6 LH	69
1/2" 165°F SC SR BRASS UPRIGHT SPRINKLER K= 5.6 OH	77
FIRE HOSE CABINET SEE DETAIL SHEET SP1	10

TRIDEL
BUILT FOR LIFE
4800 Dufferin St.
Toronto, Ontario M3H 5S9
(tel): 416-661-9290

MIRENDA
INCORPORATED
15171 Yonge Street Suite 202
Aurora Ontario L4G 1M1
(tel): 905-727-0092
(fax): 905-727-5517

NORTH		STAMP	
PROJECT AQUAVISTA MERCHANTS WHARF TORONTO, ONTARIO		DWG TITLE GROUND LEVEL SPRINKLER LAYOUT	
DATE 11/27/2015	PROJECT NO. 15-678	DWG NO. SP6	
SCALE 1/8"=1'-0"	DWN BY R.S.	ISSUED FOR REVISION NO. 3.0	
OF SP21			