



REVISIONS	DATE
1.0	10/15/15
ISSUED FOR TENDER	

NOTES

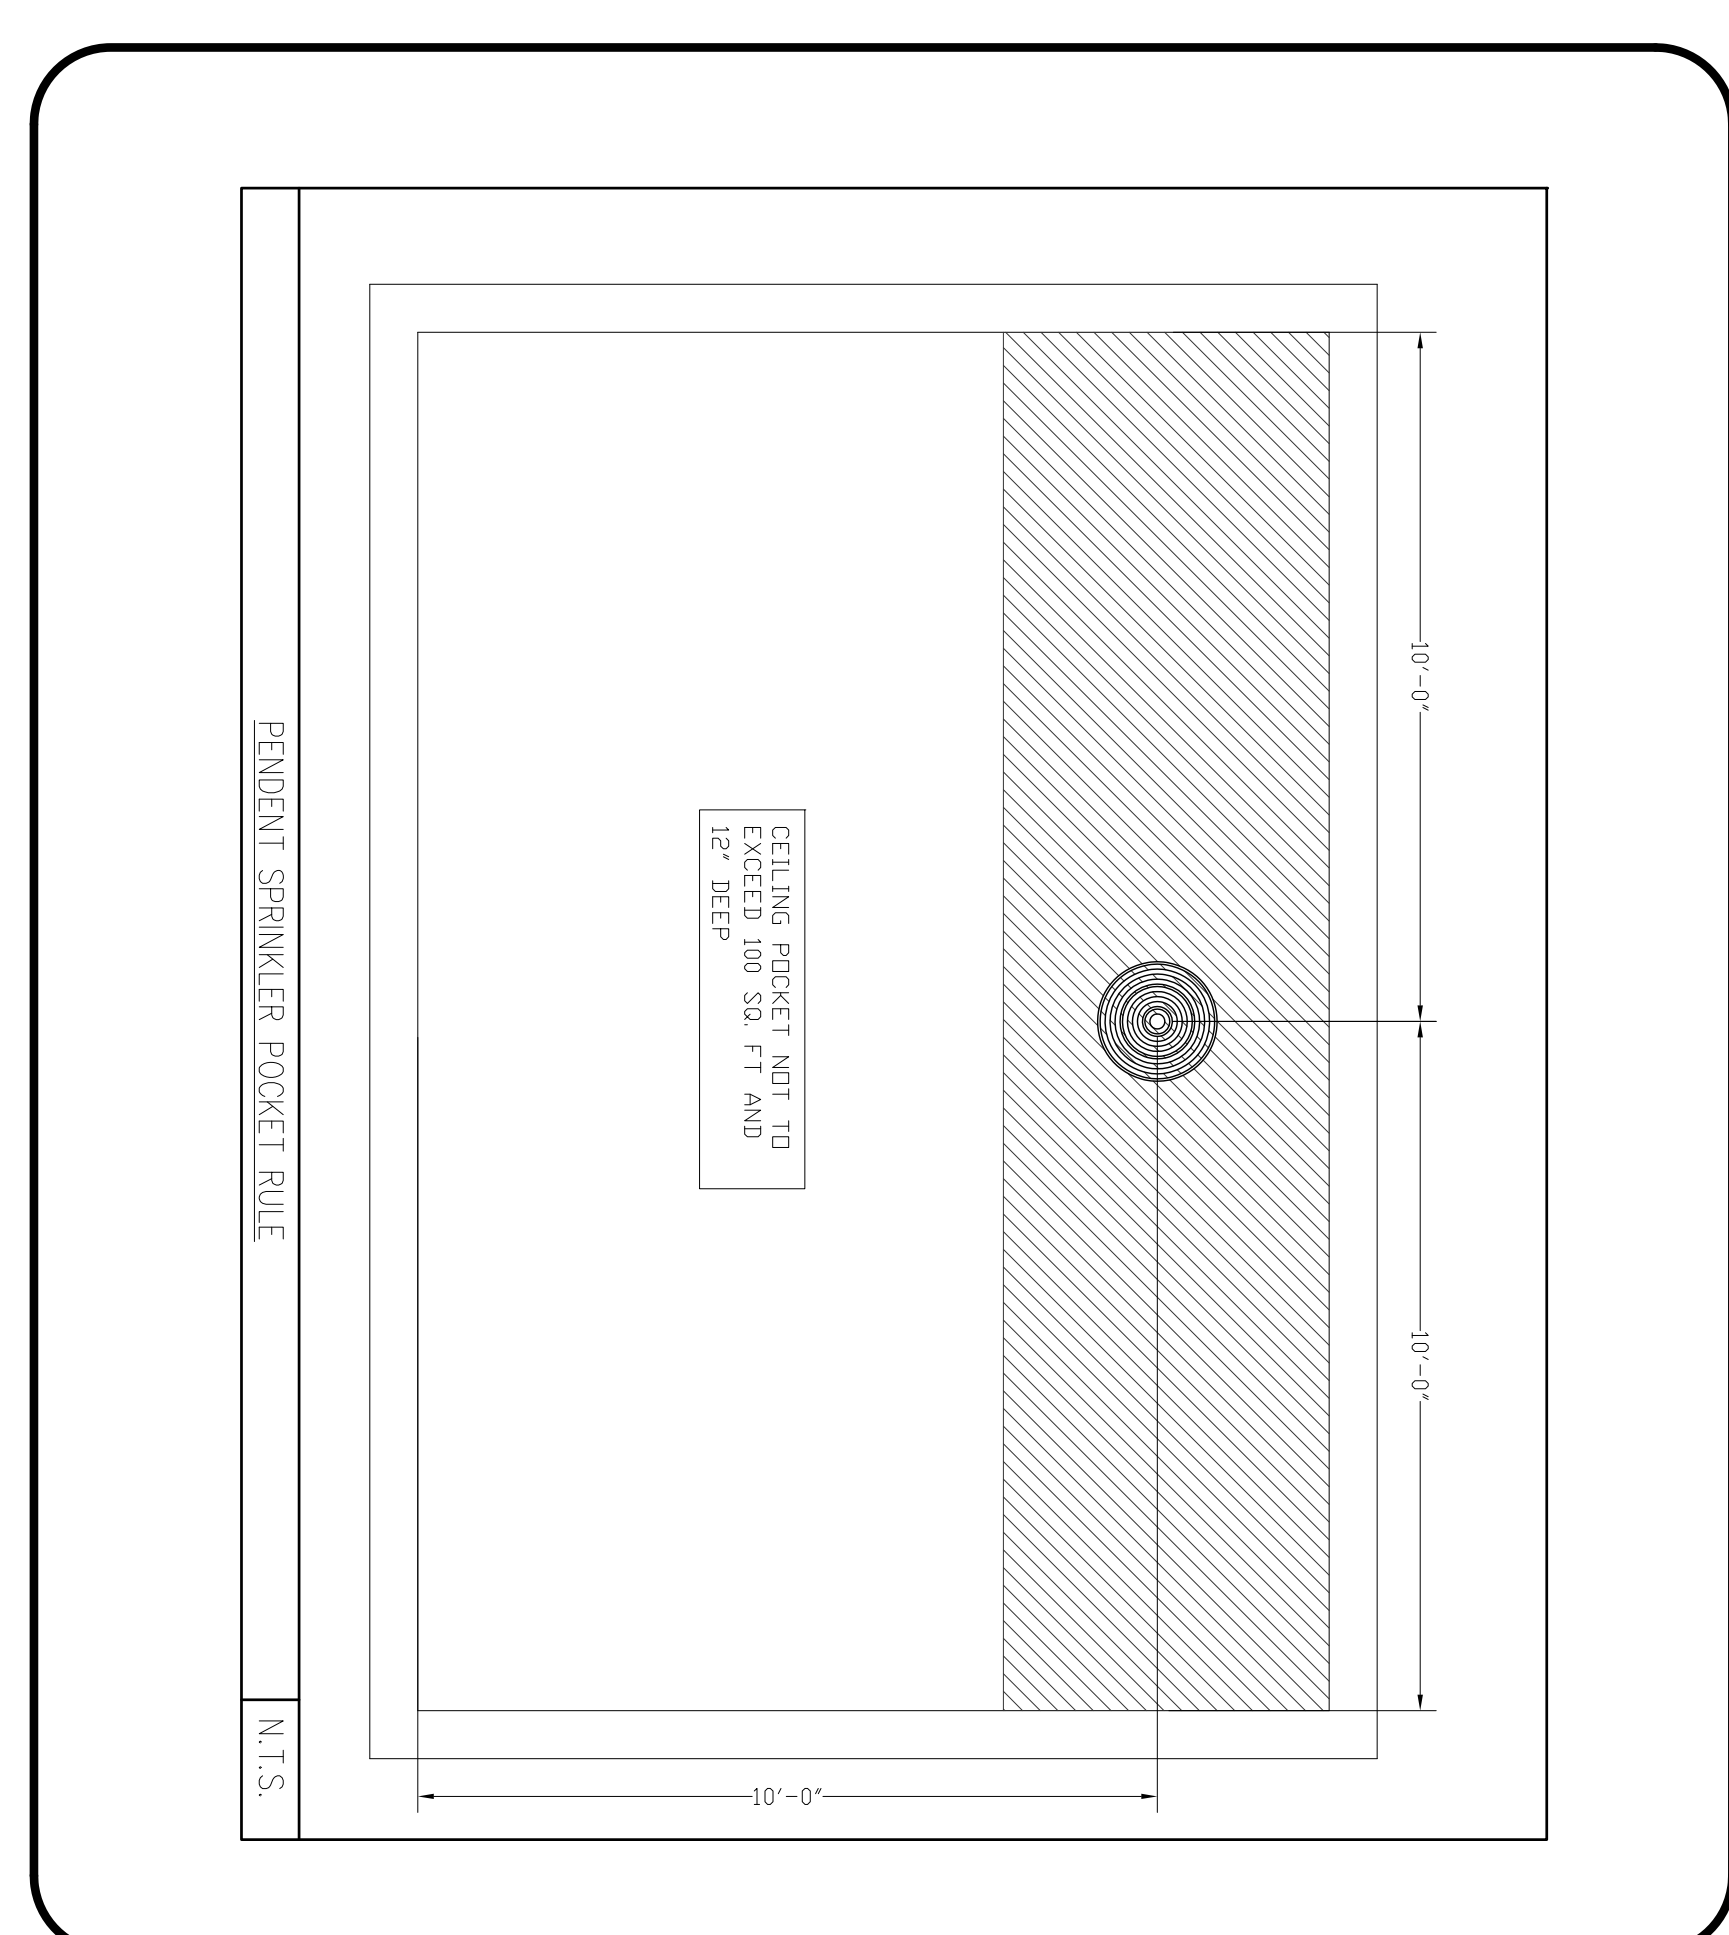

- NOTES - RESIDENTIAL SIDEWALL SPRINKLERS:**
1. MAXIMUM COVER/SPACE FOR RESIDENTIAL SIDEWALL SPRINKLERS NOT TO EXCEED 8' x 8'.
 2. MINIMUM DISTANCE BETWEEN SPRINKLERS TO BE 8'-0".
 3. SPRINKLERS SHALL BE LOCATED AT LEAST 3'-0" FROM ANY SIDE WALL.
 4. SPRINKLERS SHALL BE LOCATED AT LEAST 3'-0" FROM OBSTRUCTIONS SUCH AS CEILING FANS AND LIGHT FIXTURES.
 5. SEE OBSTRUCTION TABLE ON DRAWING SP1.
- NOTES - RESIDENTIAL PENDENT SPRINKLERS:**
1. MAXIMUM COVER/SPACE FOR RESIDENTIAL PENDENT SPRINKLERS NOT TO EXCEED 10'-0".
 2. MINIMUM DISTANCE BETWEEN SPRINKLERS TO BE 8'-0".
 3. SPRINKLERS SHALL BE LOCATED AT LEAST 3'-0" FROM OBSTRUCTIONS SUCH AS CEILING FANS AND LIGHT FIXTURES.
 4. SEE OBSTRUCTION TABLE ON DRAWING SP1.

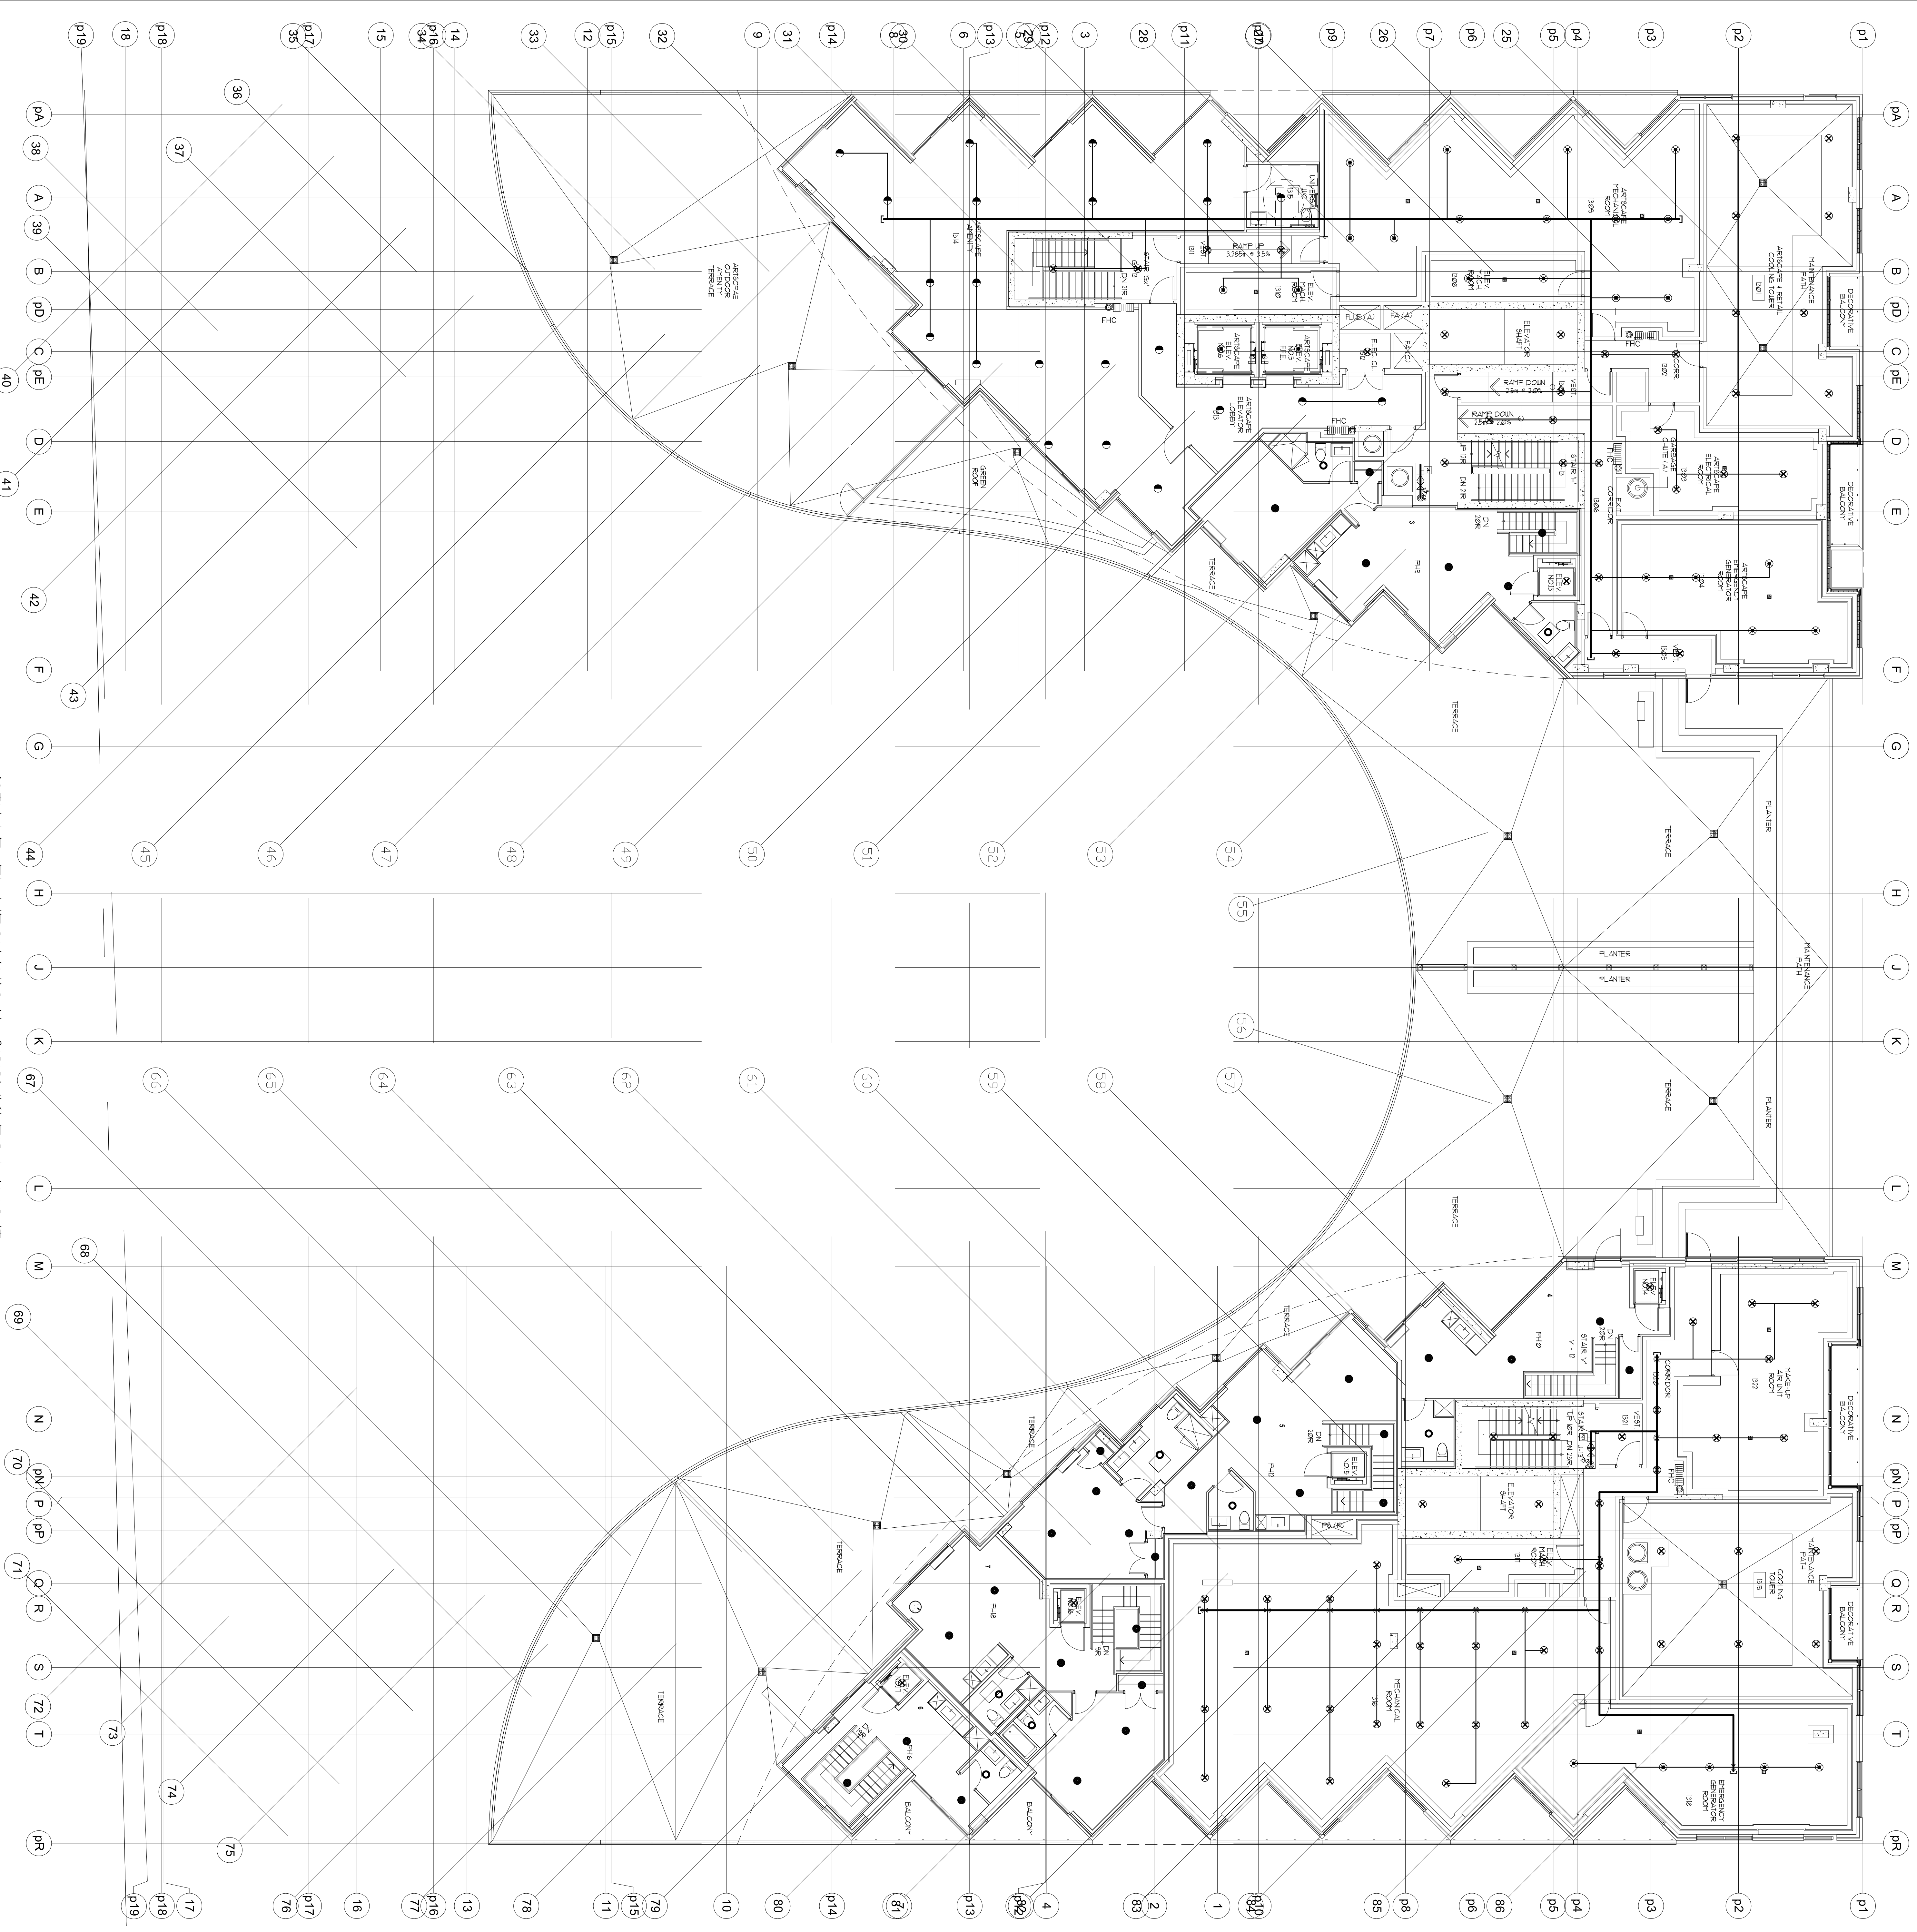

13TH LEVEL MECHANICAL SPRINKLER LAYOUT
SCALE: 1/8" = 1'-0"

SPRINKLER LEGEND

1/2" 180° SC OR CONCEALED PENDENT SPRINKLER K=5.8 1/8"	00
1/2" 180° SC SR BRASS 8.0H	00
WIRING W/SPRINKLER T-RESPOND	00
RESIDENTIAL CONCEALED PENDENT SPRINKLER C/W WHITE 5-32/1/8"	00
WIRING MODEL W489 FREEDOM RESIDENTIAL CONCEALED PENDENT COVER PLATE K=4.9 1/8" 1/8"	00
WIRING MODEL W489 FREEDOM RESIDENTIAL CONCEALED PENDENT COVER PLATE K=4.9 1/8" 1/8" (ANTICORROSION RESISTANT COATING)	00
WIRING MODEL W489 FREEDOM SIDEWALL SPRINKLER C/W WHITE 5-32/1/8" (WARRANTY CONCEALED 18X18" UNO)	00
1/4" 90° SC OR BRASS UPRIGHT SPRINKLER K=5.8 0H	00
1/4" 90° SC OR BRASS SIDE SPRINKLER K=5.8 0H	00
FIRE HOSE CABINET	00
SEE DETAIL SHEET SP1	

TRIDEL
BUILT FOR LIFE

4800 Dufferin Street
Toronto, Ontario M3J 5S9
(416) 415-8230

MIRENDA
INCORPORATED

15171 Yonge Street Suite 202
Aurora Ontario L4G 1M1
(905) 965-27-0092
(905) 965-27-5017

PROJECT AQUAVISTA
DESIGNER'S MARK MIRENDA
DWG TITLE 13TH MECH. LEVEL SPRINKLER LAYOUT

DATE 10/15/2015
SCALE 1/8" = 1'-0"
DWG NO. 15-678
PROJECT NO. SP18
REVISION NO. 1.0
OF SP20