


- NOTES - RESIDENTIAL SIDEWALL SPRINKLERS:**
1. MAXIMUM COVERAGE FOR RESIDENTIAL SIDEWALL SPRINKLERS NOT TO EXCEED 16' x 16'.
 2. MINIMUM DISTANCE BETWEEN SPRINKLERS TO BE 8'-0".
 3. MINIMUM DISTANCE FROM ANY SIDE WALL TO SPRINKLER NOT TO EXCEED 8'-0".
 4. SIDEWALL SPRINKLERS SHALL BE LOCATED AT LEAST 3'-0" FROM OBSTRUCTIONS SUCH AS CEILING FANS AND LIGHT FIXTURES.
 5. SEE OBSTRUCTION TABLE ON DRAWING SP1.
- NOTES - RESIDENTIAL PENDENT SPRINKLERS:**
1. MAXIMUM COVERAGE FOR RESIDENTIAL PENDENT SPRINKLERS NOT TO EXCEED 17' x 17'.
 2. MINIMUM DISTANCE BETWEEN SPRINKLERS TO BE 8'-0".
 3. MINIMUM DISTANCE FROM ANY SIDE WALL TO SPRINKLER NOT TO EXCEED 8'-0".
 4. PENDENT SPRINKLERS SHALL BE LOCATED AT LEAST 3'-0" FROM OBSTRUCTIONS SUCH AS CEILING FANS AND LIGHT FIXTURES.
 5. SEE OBSTRUCTION TABLE ON DRAWING SP1.

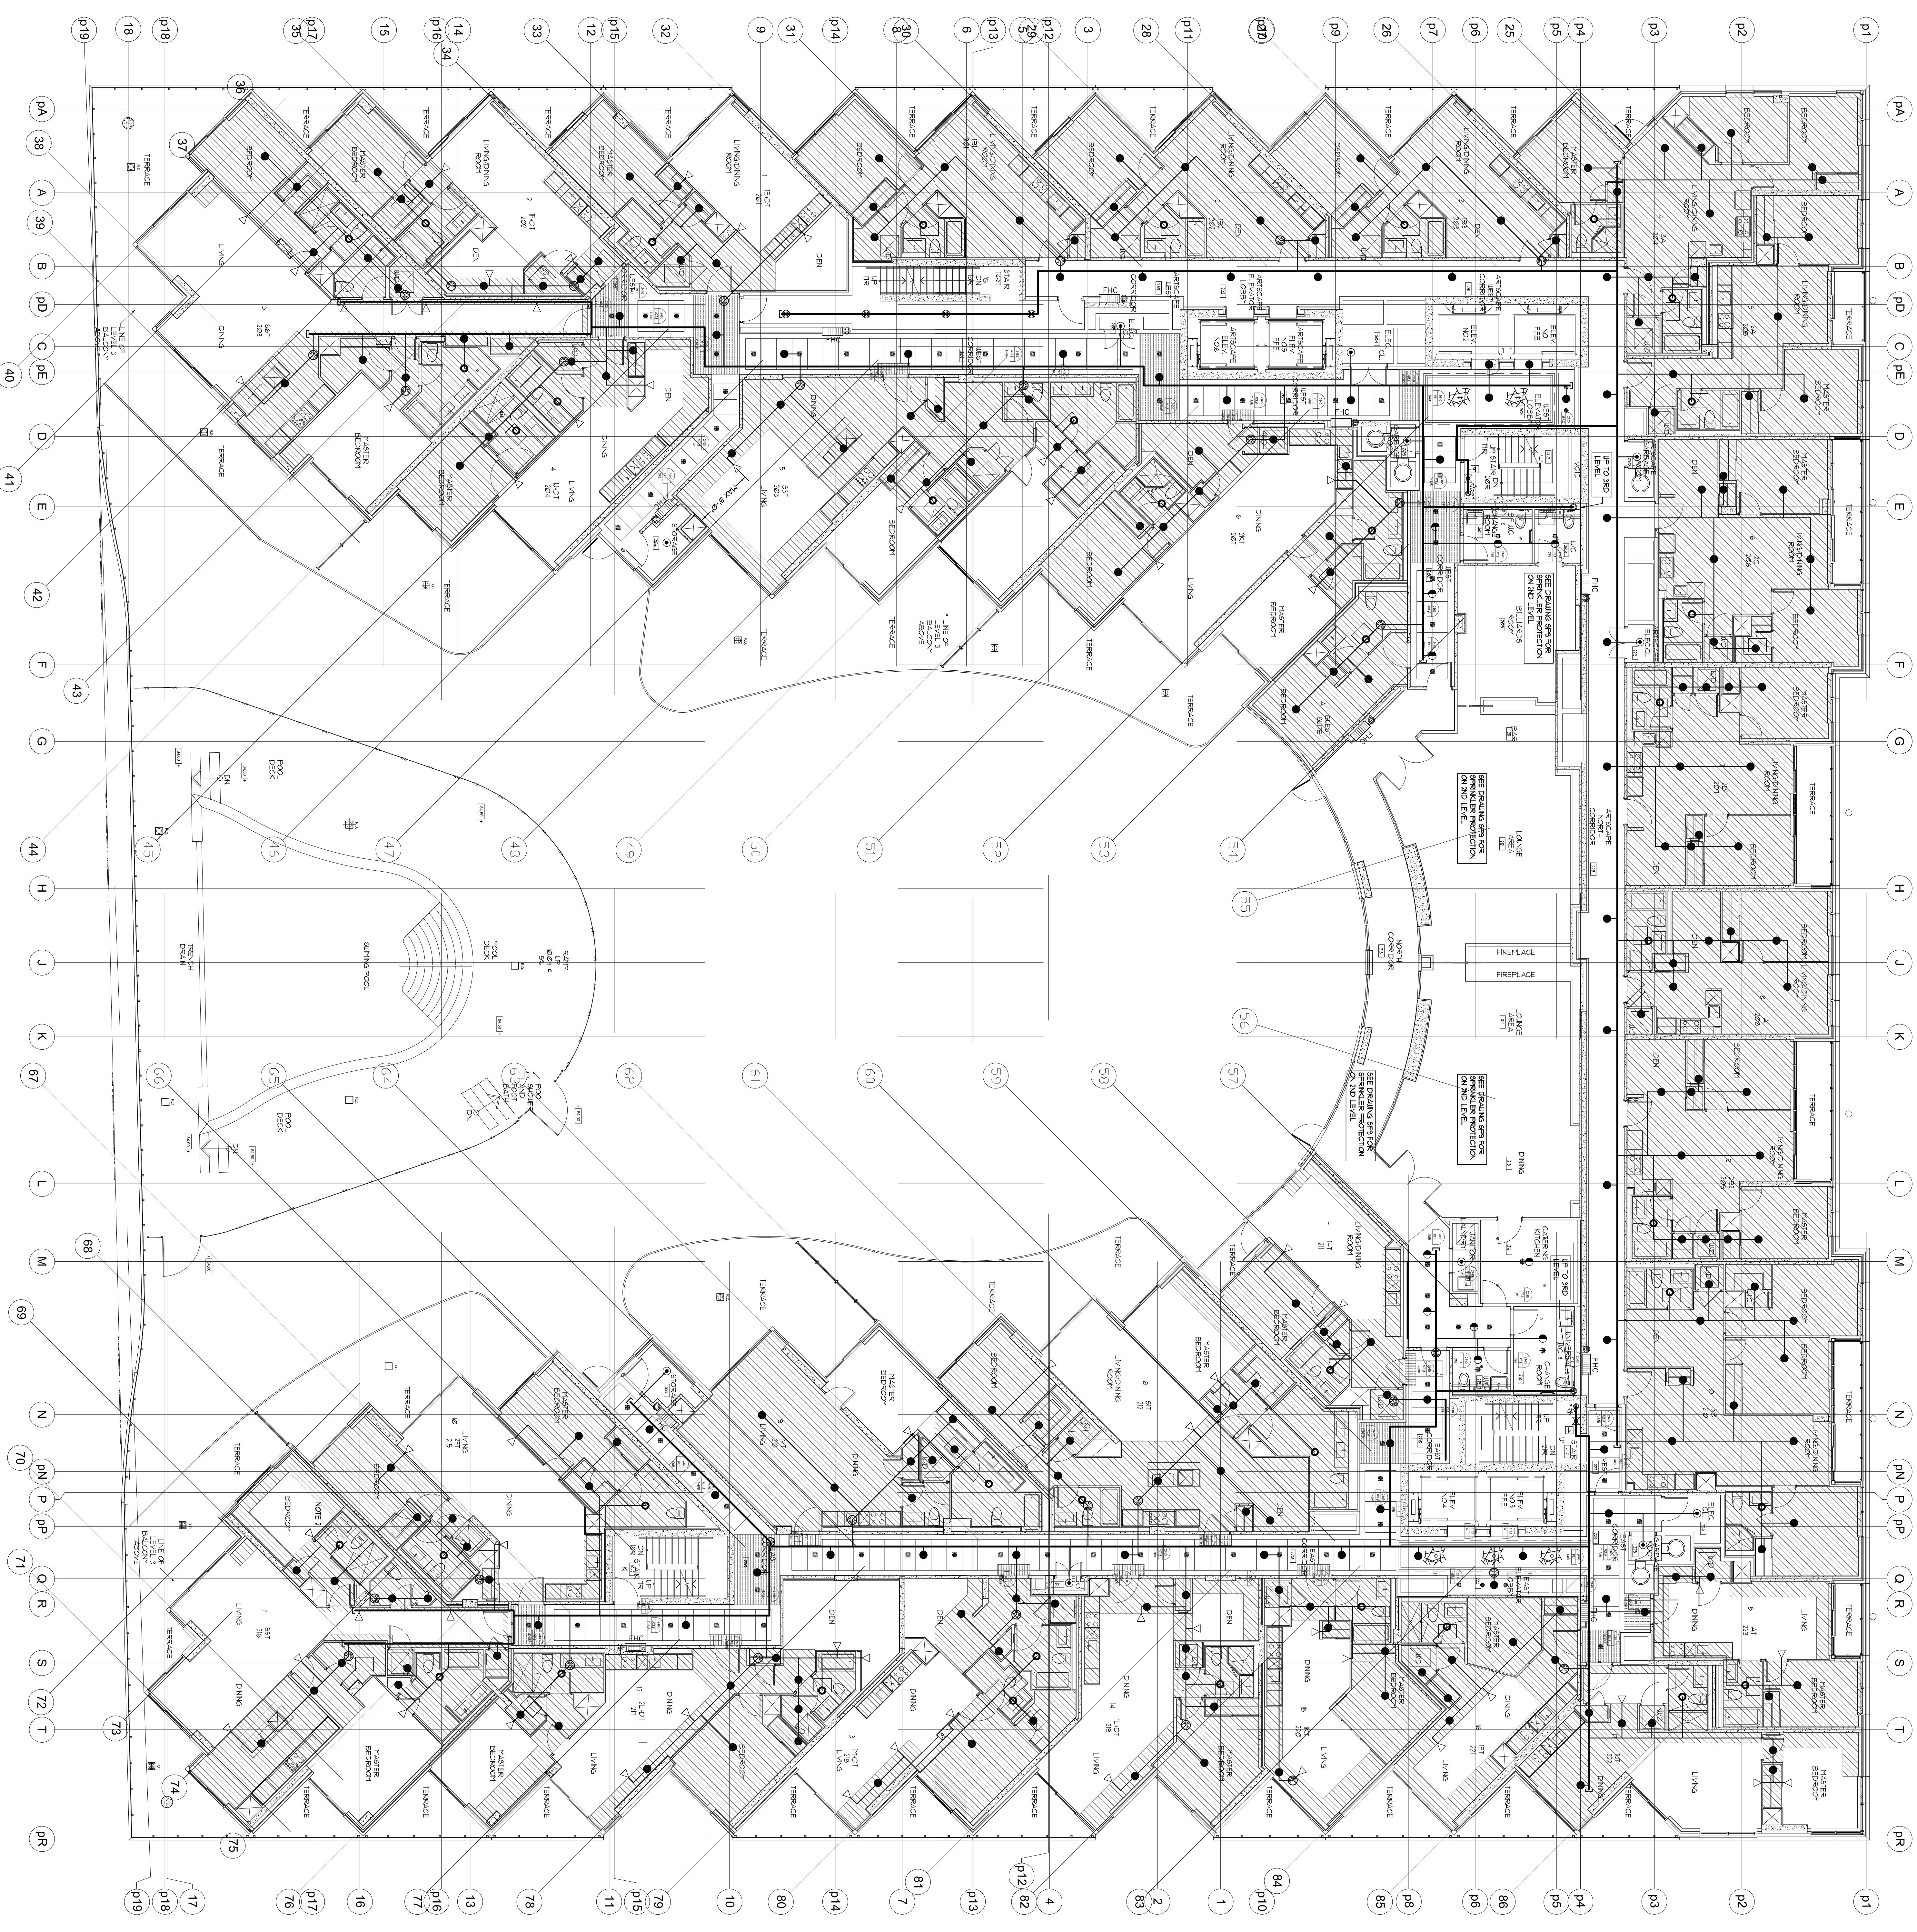

2ND FLOOR SPRINKLER LAYOUT
SCALE: 1/8" = 1'-0"

SPRINKLER LEGEND

- 1/2" 169T 5C 50 BRASS Upright Sprinkler K=5.8
- 1/2" 169T 5C 50 BRASS Upright Sprinkler K=5.8 1H
- 1/2" 169T 5C 50 BRASS Upright Sprinkler K=5.8 0H
- WINKING MODEL W457 FREEDOM RESIDENTIAL CONCEALED PENDENT COVER PLATE K=4.8 180°
- WINKING MODEL W457 FREEDOM COVER PLATE K=4.8 180°
- COVER PLATE K=4.8 180° (CONING)
- RESIDENTIAL CONCEALED PENDENT SPRINKLER C/W WHITE FIRST 8" DEFLECTOR (UNO) (MAXIMUM COVERAGE 16'x16')
- 1/2" 169T 5C 50 SIDEWALL SPRINKLER K=5.6 0H
- 1/2" 169T 5C 50 SIDEWALL SPRINKLER K=5.6 0H
- FREE HOSE CABINET
- SEE DETAIL SHEET SP1

MIRENDA
INCORPORATED
4800 Durheim St.
Toronto, Ontario M3J 5S3
(416) 416-8515

TRIDEL
BUILT FOR LIFE

PROJEC AQUAVISTA
DESIGNERS MWH
CLIENT TORONTO DIVERSITY

DATE 10/15/2018
SCALE 1/8"=1'-0"
DWG NO. 15-678
PROJECT NO. SP18
REVISION NO. 1.0
OF SP20

STAMP
NORTH
15171 Yonge Street, Suite 202
Aurora, Ontario L4G 1M1
(416) 305-7210
(416) 305-7211