

REVISIONS		
1.0	ISSUED FOR TENDER	10/15/15
2.0	ISSUED FOR TENDER	10/23/15
	APPENDIX #1	

NOTES

PROJECT	AQUAVISTA	PROJECT NO.	
DWG TITLE	8TH LEVEL SPRINKLER LAYOUT	DWG NO.	SP13
DATE	10/23/2015	SCALE	1/8"=1'-0"
DWN BY	JL	ISSUED FOR	REVISION NO. 2.0
		OF SP13	


NORTH

15171 Yonge Street Suite 202
Aurora, Ontario L4G 1W1
(416) 965-1721/2002
(416) 965-1731/5137

4800 Dufferin St Unit 553
Mississauga, ON L4W 5G9
(905) 415-8511/5200

SPRINKLER LEGEND	
1/2" 1697 SC OR BRASS	4
UPRICH SPRINKLER K=5.6	
1/2" 1697 SC SR BRASS	8
WINKER MODEL W4457 PRECOND SPRINKLER C/W WHITE 3-5/16" COVER PLATE K=4.9 1697	277
WINKER MODEL W4457 PRECOND SPRINKLER C/W WHITE 3-5/16" COVER PLATE K=4.9 1697	37
WINKER MODEL W4457 PRECOND SPRINKLER C/W WHITE 3-5/16" COVER PLATE K=4.9 1697	105
1/2" 1697 SC SR SIDEWALL	5
FIRE HOSE CABINET	7
SEE DETAIL SHEET SP1	

- NOTES - RESIDENTIAL SIDEWALL SPRINKLERS
- MAXIMUM COVERAGE FOR RESIDENTIAL SIDEWALL SPRINKLERS NOT TO EXCEED 8' x 16'
 - MINIMUM DISTANCE BETWEEN SPRINKLERS TO BE 8'-0"
 - MAXIMUM DISTANCE FROM ANY SIDE WALL TO SPRINKLER NOT TO EXCEED 8'-0"
 - SPRINKLERS SHALL BE LOCATED AT LEAST 3'-0" FROM OBSTRUCTIONS SUCH AS CEILING FANS AND LIGHT FIXTURES
 - SEE OBSTRUCTION TABLE ON DRAWING SP1
- NOTES - RESIDENTIAL PENDENT SPRINKLERS
- MAXIMUM COVERAGE FOR RESIDENTIAL PENDENT SPRINKLERS NOT TO EXCEED 8' x 16'
 - MINIMUM DISTANCE BETWEEN SPRINKLERS TO BE 8'-0"
 - MAXIMUM DISTANCE FROM ANY SIDE WALL TO SPRINKLER NOT TO EXCEED 8'-0"
 - SPRINKLERS SHALL BE LOCATED AT LEAST 3'-0" FROM OBSTRUCTIONS SUCH AS CEILING FANS AND LIGHT FIXTURES
 - SEE OBSTRUCTION TABLE ON DRAWING SP1

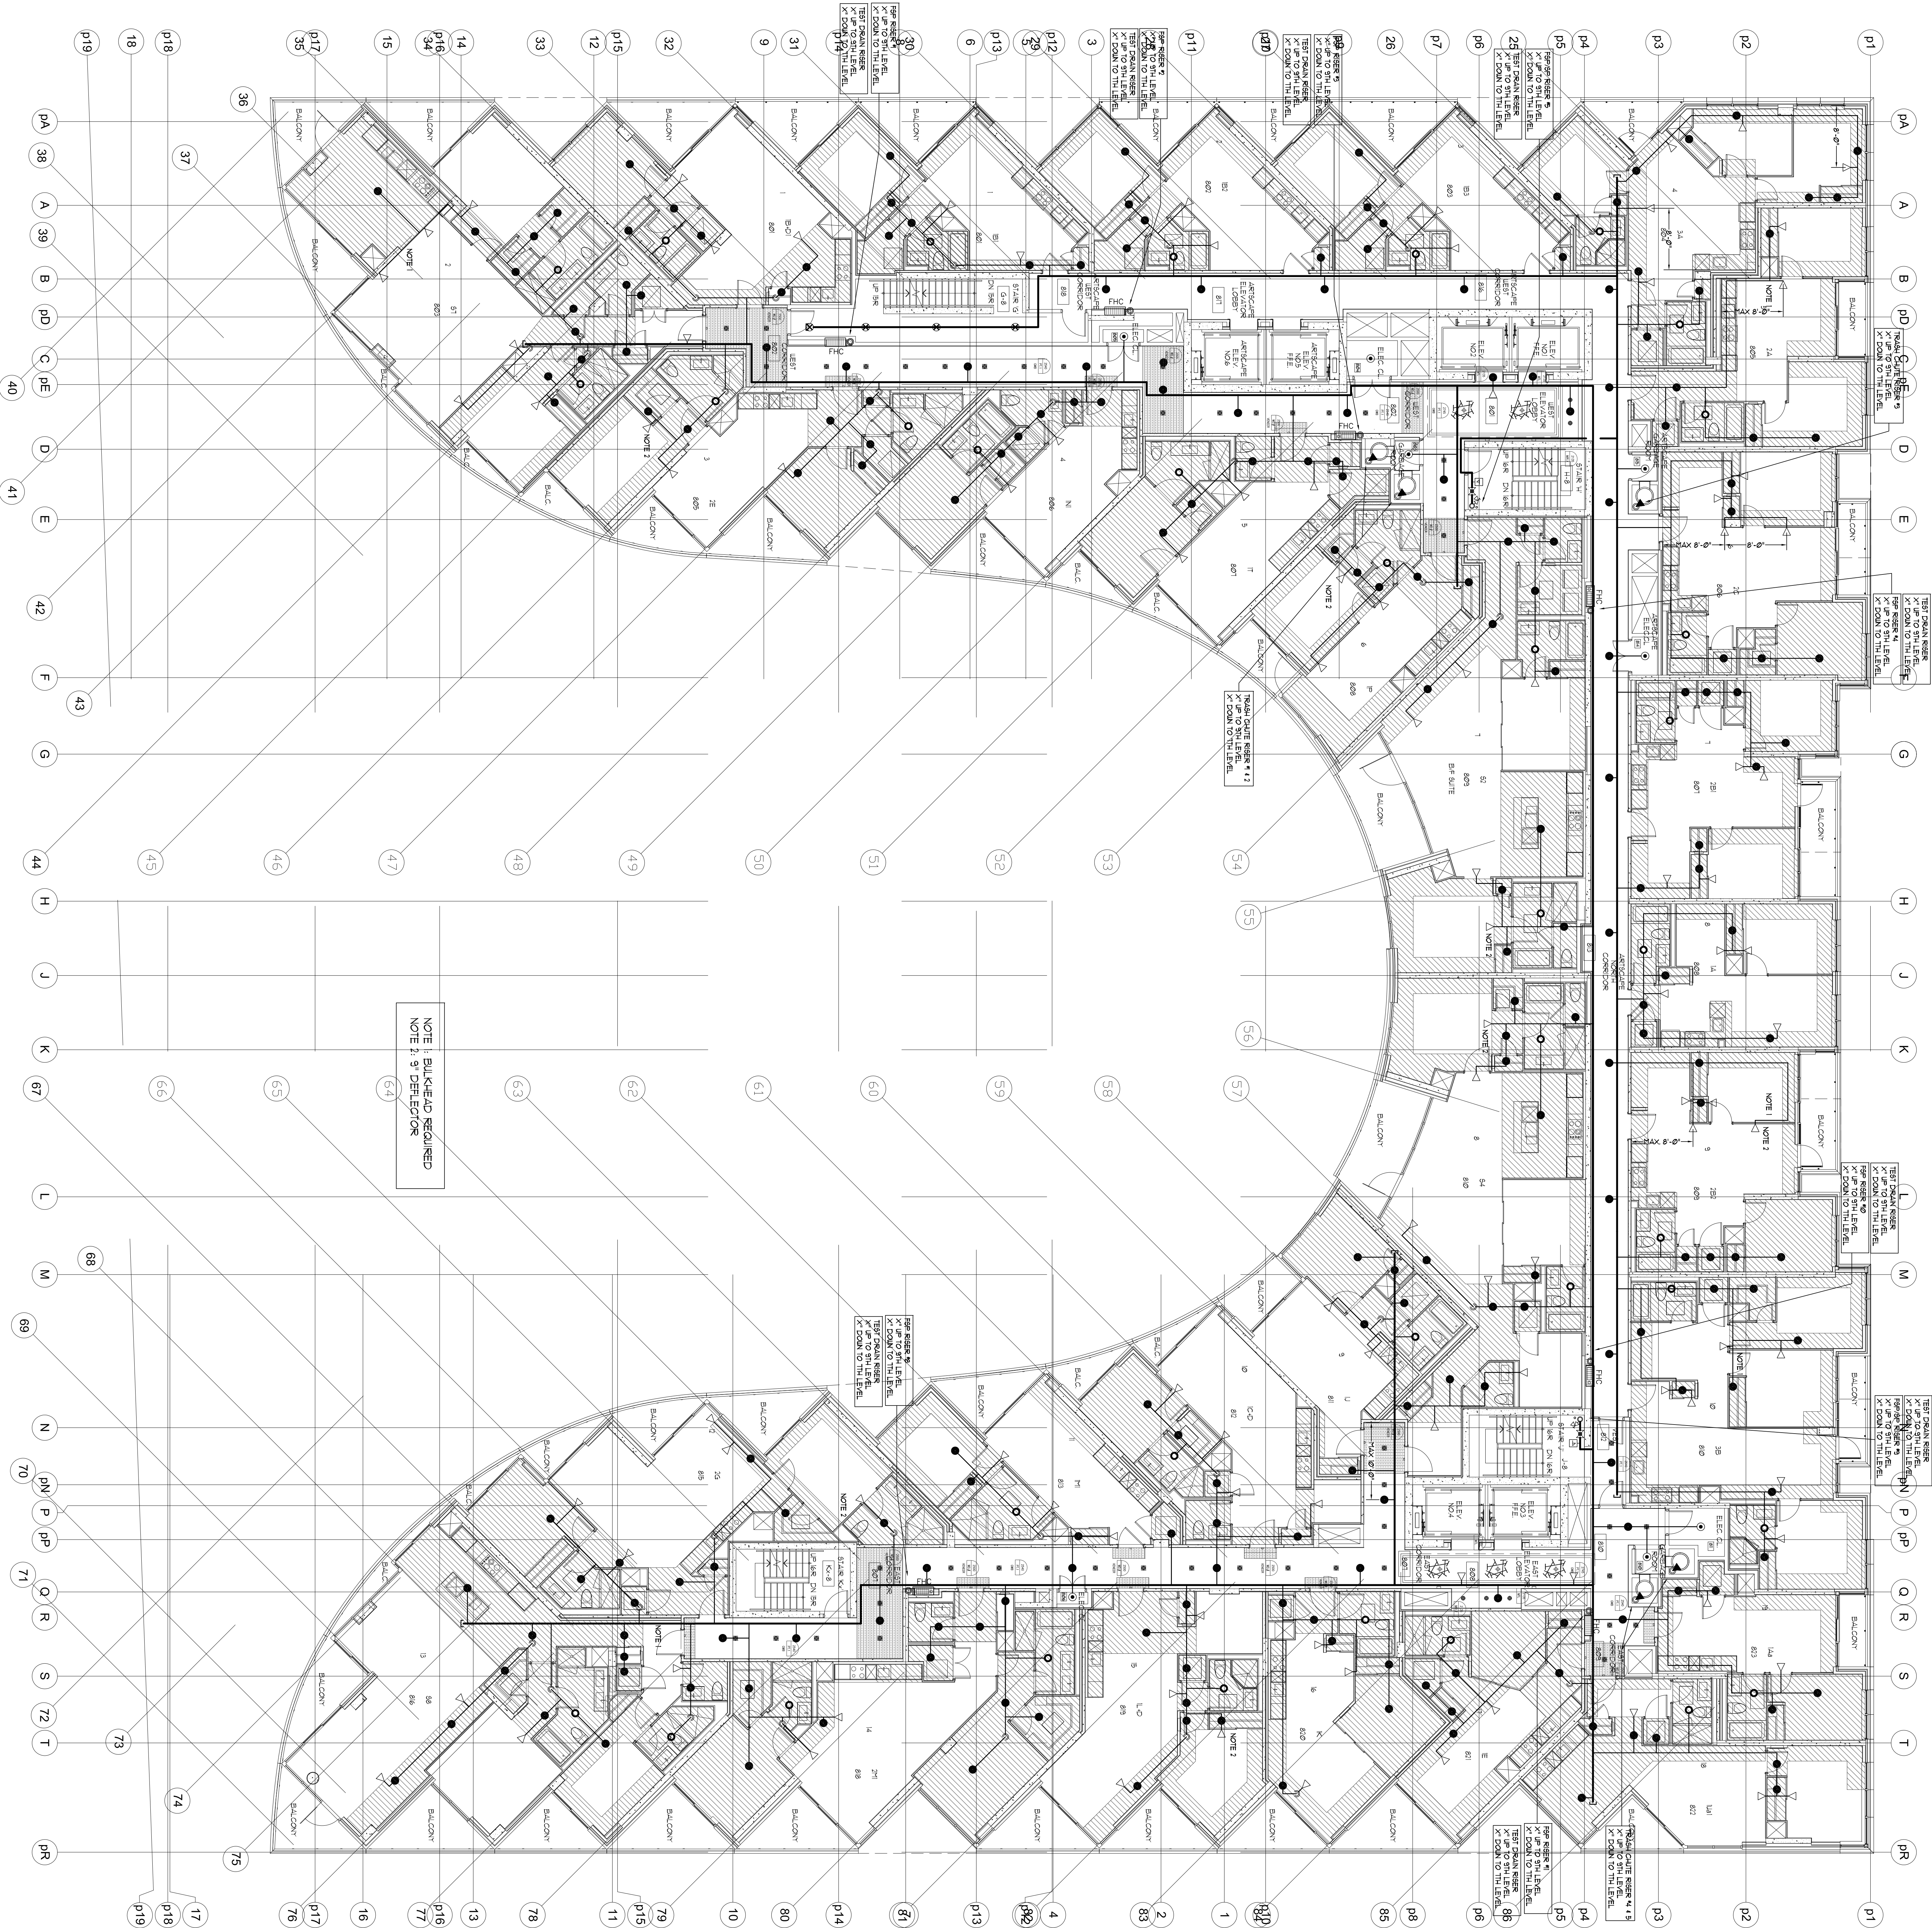

8TH LEVEL SPRINKLER LAYOUT

SCALE: 1/8"=1'-0"