

REVISIONS	
1.0	ISSUED FOR TENDER
2.0	ISSUED FOR TENDER ADDENDUM #1


NOTES

SPRINKLER LEGEND	
1/2" KEST 50K BRASS	4
UPHORN SPRINKLER 1/2" 56	4
1/2" KEST 50K 95 BRASS	8
UPHORN SPRINKLER 1/2" 56 OH	8
IRVING MODEL W480 FREEDOM	268
REINFORCED CONCEALED PENDANT COVER PLATE W480 FREEDOM	268
IRVING MODEL W480 FREEDOM	37
REINFORCED CONCEALED PENDANT COVER PLATE W480 FREEDOM	37
REINFORCED CONCEALED PENDANT COVER PLATE K-480 1857 OH	37
INTEGROFORM RESISTANT COATING	37
IRVING MODEL W480 FREEDOM REINFORCED HORIZONTAL WALL MOUNTED CONCEALED PENDANT DISCHARGE PLATE 1/2" K480 1857 OH DEFLECTOR UANO (MAXIMUM 18" X 6" UANO)	46
THE HOSE CABINET	46
THE HOSE CABINET (SEE DETAIL SHEET 381)	46

1. MAXIMUM CORRELATOR FOR RESIDENTIAL, PENDENT SPRINKLERS
NOT TO EXCEED $8' \times 8'$.
2. MINIMUM DISTANCE BETWEEN SPRINKLERS TO BE $8' - 0"$.
3. MINIMUM DISTANCE FROM ANY STEEL TUB TO SPRINKLER NOT TO EXCEED $8' - 0"$.
4. RESIDENTIAL SPRINKLERS SHALL BE LOCATED AT LEAST $3' - 0"$ FROM OBSTRUCTIONS SUCH AS CEILING FANS AND LIGHT FIXTURES.
5. SEE OBSTRUCTION TABLE ON DRAWING SET.

NOTES - RESIDENTIAL, PENDENT SPRINKLERS:

1. MAXIMUM CORRELATOR FOR RESIDENTIAL, PENDENT SPRINKLERS NOT TO EXCEED THREE FT.
2. MINIMUM DISTANCE BETWEEN SPRINKLERS TO BE $8' - 0"$.
3. MINIMUM DISTANCE FROM ANY STEEL TUB TO SPRINKLER NOT TO EXCEED $8' - 0"$.
4. RESIDENTIAL SPRINKLERS SHALL BE LOCATED AT LEAST $3' - 0"$ FROM OBSTRUCTIONS SUCH AS CEILING FANS AND LIGHT FIXTURES.
5. SEE OBSTRUCTION TABLE ON DRAWING SET.

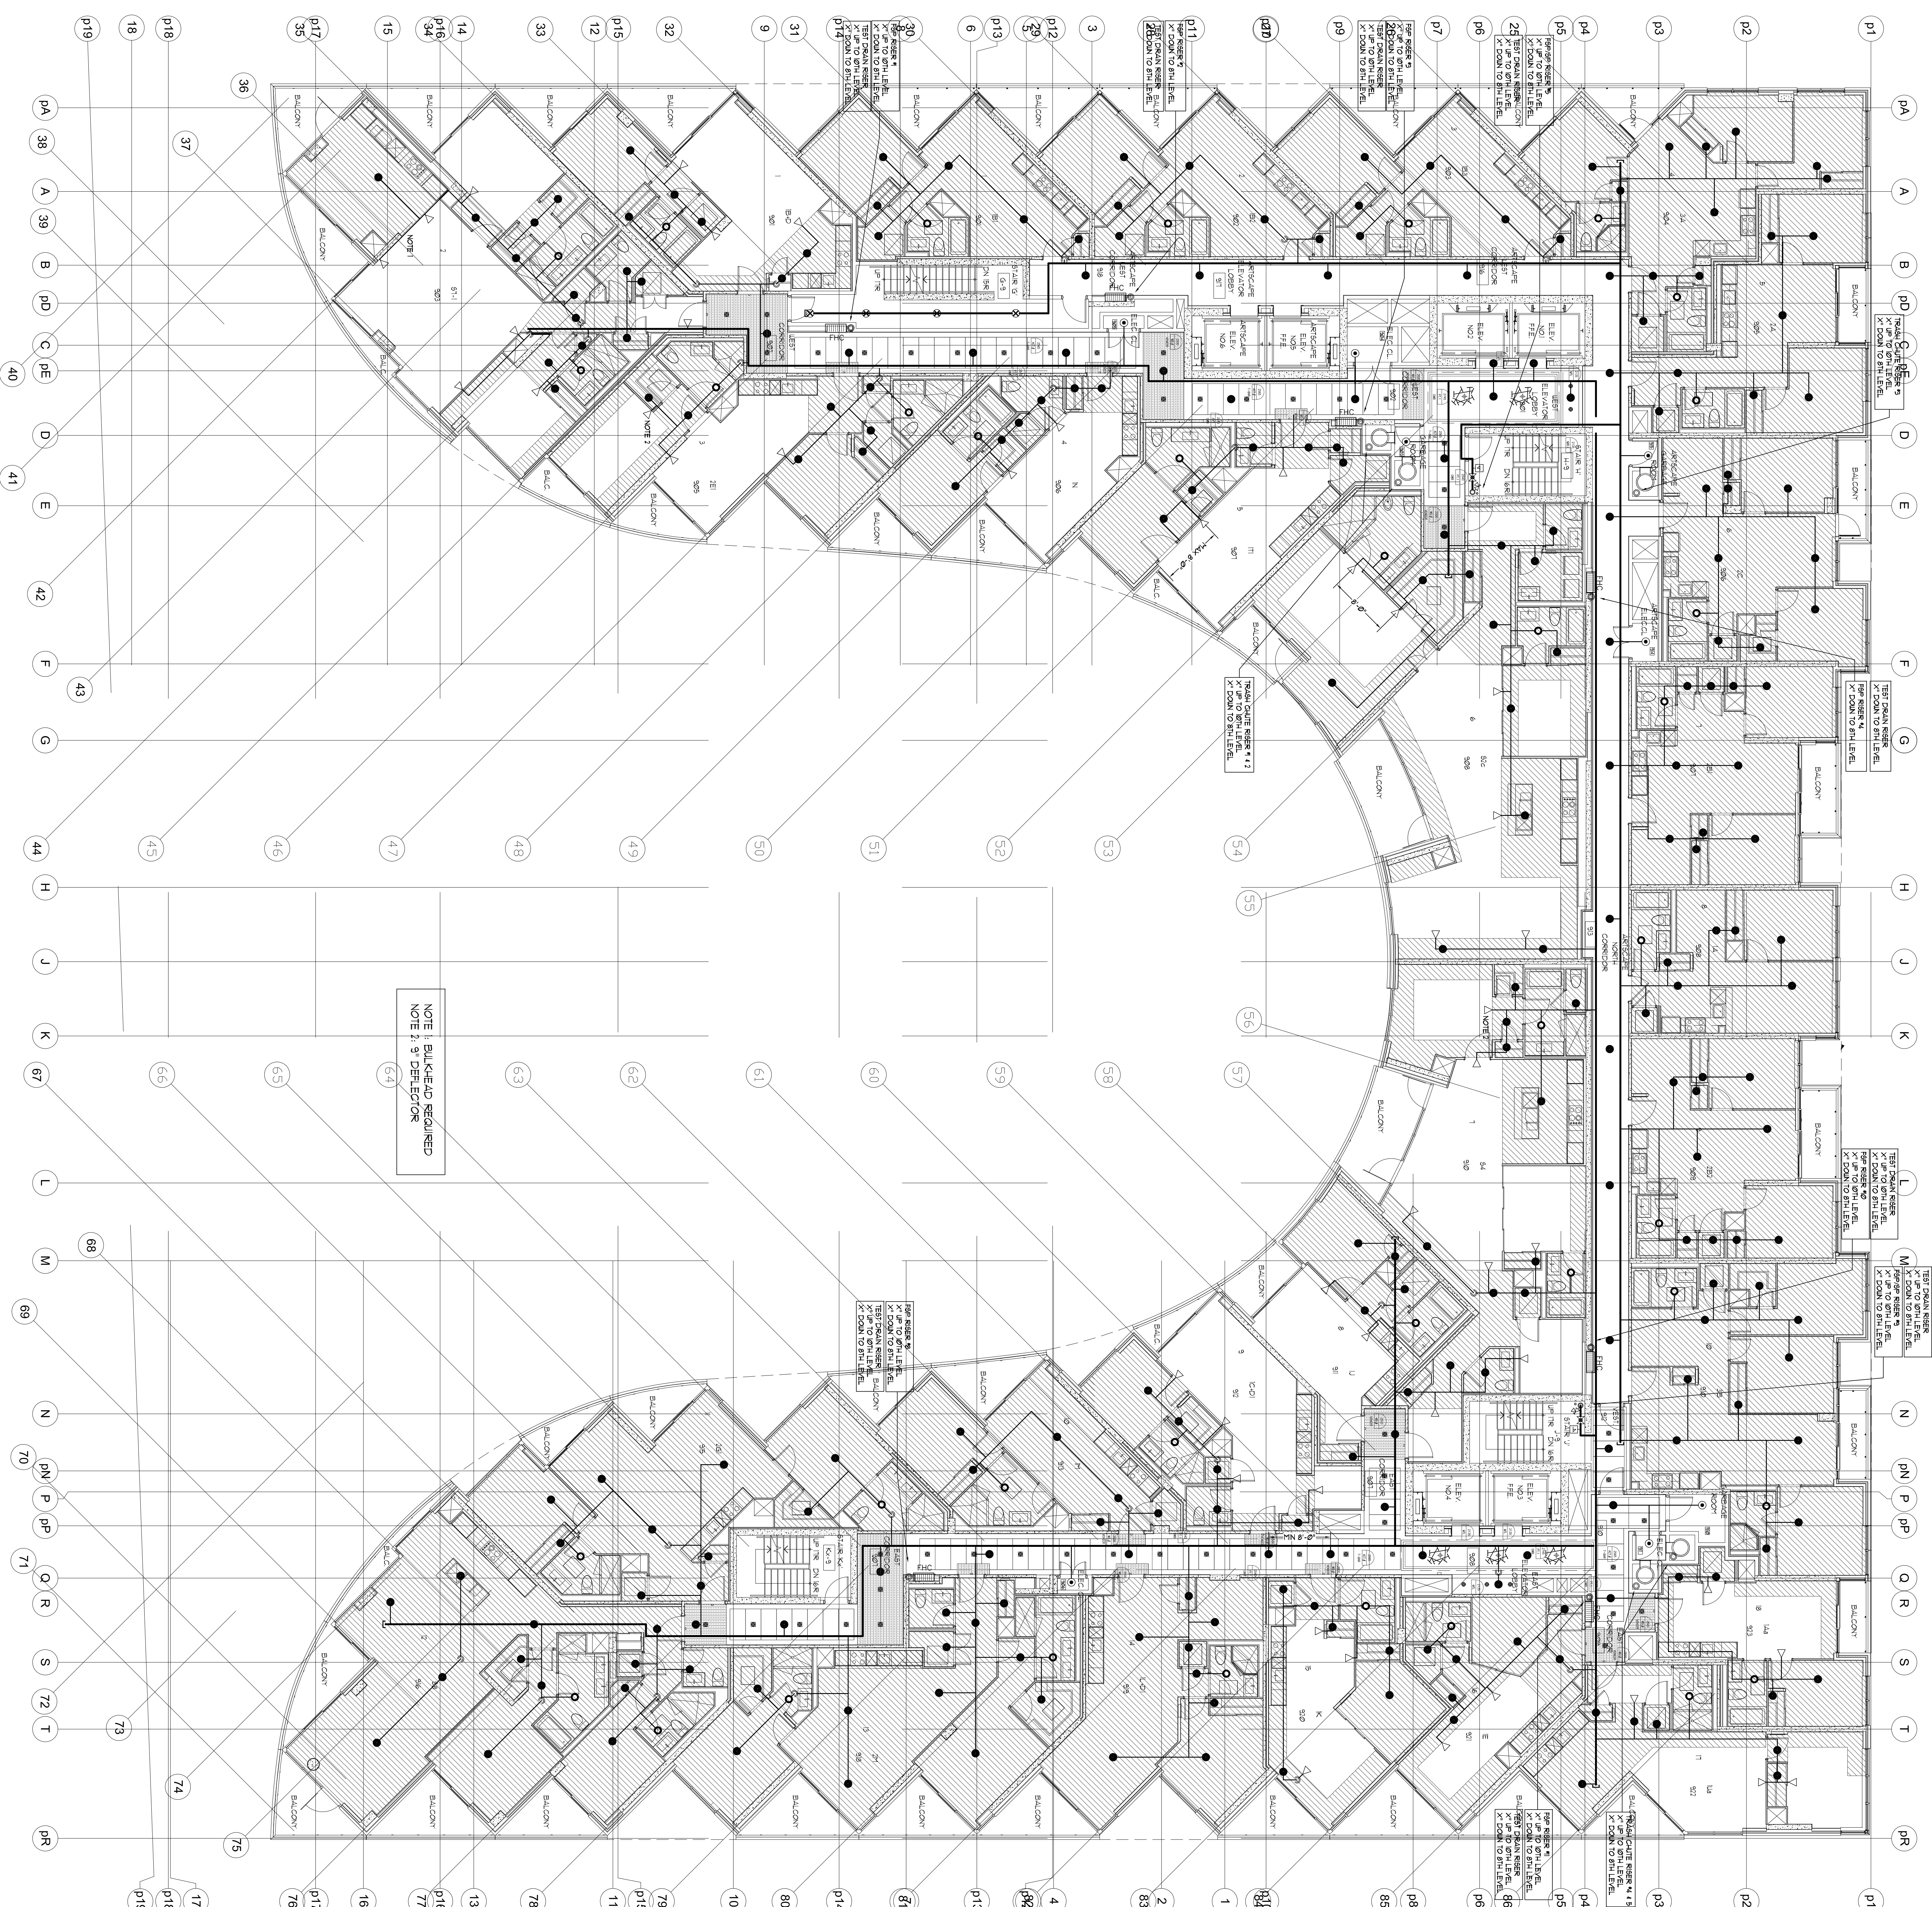

9TH LEVEL SPRINKLER LAYOUT

AQUANISTA REGALANTE: DANIEL TORONTO, ONTARIO	
DWG TITLE	9TH LEVEL SPRINKLER LAYOUT
DATE	10/23/2015
SCALE	1/8" = 1'-0"
DWGN BY	JL
ISSUED FOR REVISION NO.	SP 14 2.0
PROJECT NO.	15-678
DWG NO.	SP 14
OR SP21	