

REVISIONS	
1.0	ISSUED FOR TENDER 10/15/15
2.0	ISSUED FOR TENDER 10/23/15
DEPENDENT #1	

NOTES

PROJECT		AQUAVISTA	
DESIGNER'S NAME		PENGWYN SWANDB	
DWG TITLE		11TH LEVEL SPRINKLER LAYOUT	
DATE	10/23/2015	PROJECT NO.	
SCALE	1/8"=1'-0"		15'-6/78
DWG BY	JL	DWG NO.	SP16
ISSUED FOR	REVISION NO. 2.0	OF SP21	

NORTH

STAMP


15171 Yonge Street Suite 202
Aurora Ontario L4G 1M1
(416) 305-727-5517

4800 Dundas St. Unit 529
(416) 416-661-9290

SPRINKLER LEGEND	
	2
	4
	1986
	32
	68

11TH LEVEL SPRINKLER LAYOUT

SCALE: 1/8"=1'-0"

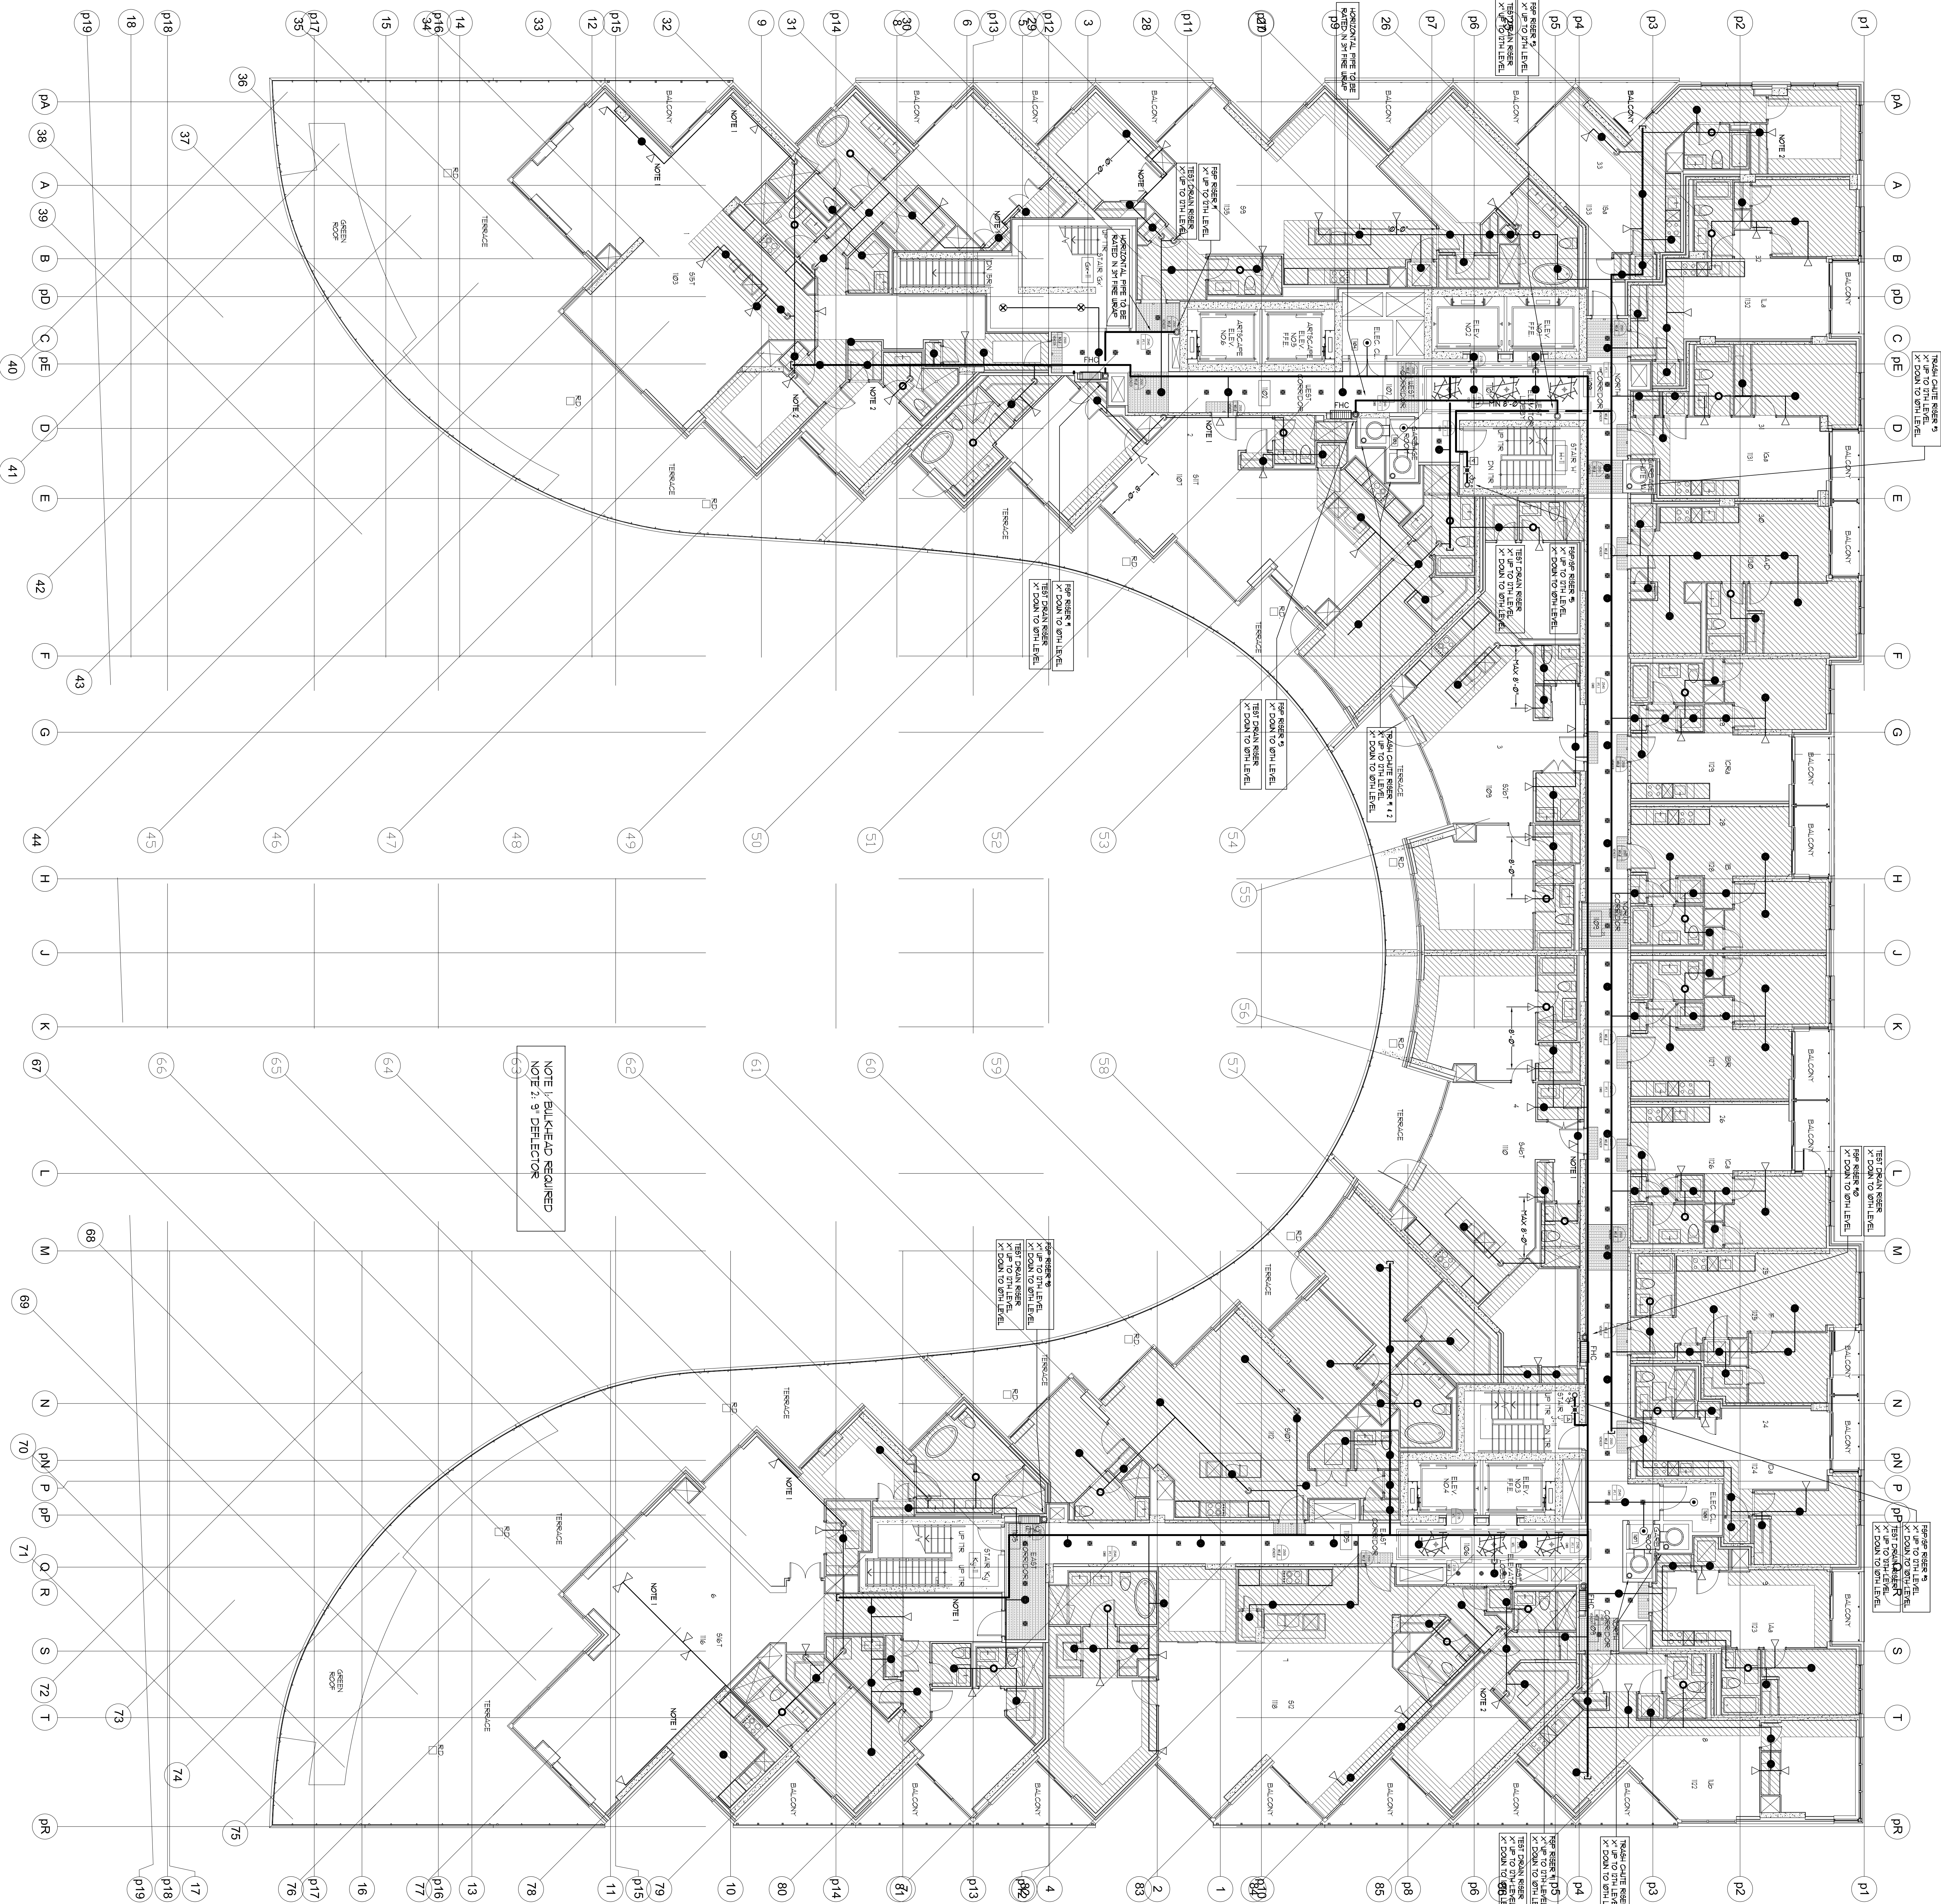

- NOTES - RESIDENTIAL SIDEWALL SPRINKLERS:
1. MAXIMUM COVERAGE FOR RESIDENTIAL SIDEWALL SPRINKLERS NOT TO EXCEED 8'-0"
 2. MINIMUM DISTANCE BETWEEN SPRINKLERS TO BE 8'-0"
 3. MINIMUM DISTANCE BETWEEN SPRINKLERS TO BE 8'-0"
 4. MINIMUM DISTANCE BETWEEN SPRINKLERS TO BE 8'-0"
 5. MINIMUM DISTANCE BETWEEN SPRINKLERS TO BE 8'-0"
- NOTES - RESIDENTIAL PENDENT SPRINKLERS:
1. MAXIMUM COVERAGE FOR RESIDENTIAL PENDENT SPRINKLERS NOT TO EXCEED 11 FT
 2. MINIMUM DISTANCE BETWEEN SPRINKLERS TO BE 8'-0"
 3. MINIMUM DISTANCE BETWEEN SPRINKLERS TO BE 8'-0"
 4. MINIMUM DISTANCE BETWEEN SPRINKLERS TO BE 8'-0"
 5. MINIMUM DISTANCE BETWEEN SPRINKLERS TO BE 8'-0"
- NOTES - RESIDENTIAL PENDENT SPRINKLERS:
1. MAXIMUM COVERAGE FOR RESIDENTIAL PENDENT SPRINKLERS NOT TO EXCEED 11 FT
 2. MINIMUM DISTANCE BETWEEN SPRINKLERS TO BE 8'-0"
 3. MINIMUM DISTANCE BETWEEN SPRINKLERS TO BE 8'-0"
 4. MINIMUM DISTANCE BETWEEN SPRINKLERS TO BE 8'-0"
 5. MINIMUM DISTANCE BETWEEN SPRINKLERS TO BE 8'-0"