




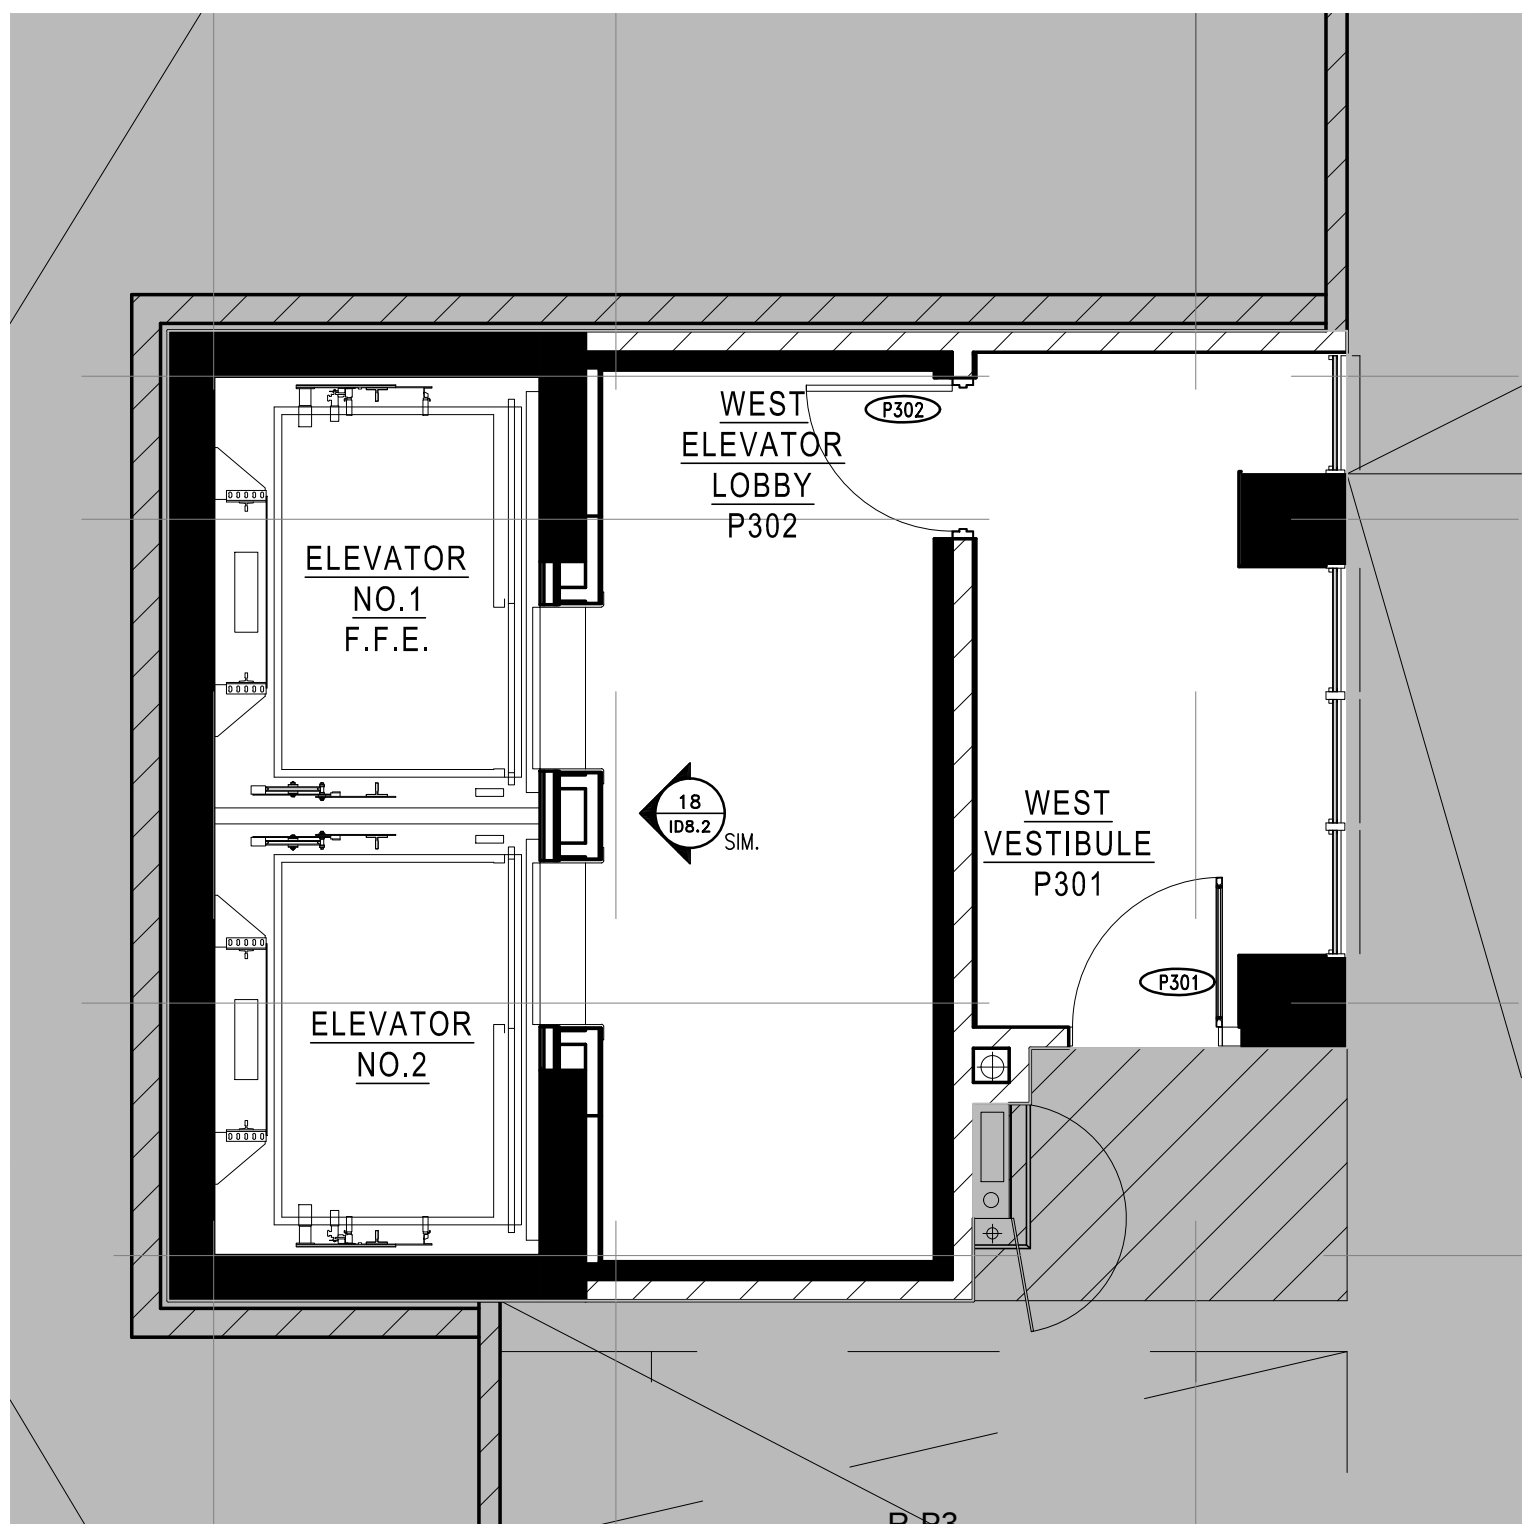


1 CONSTRUCTION PLAN
R3.2 SCALE 1:50

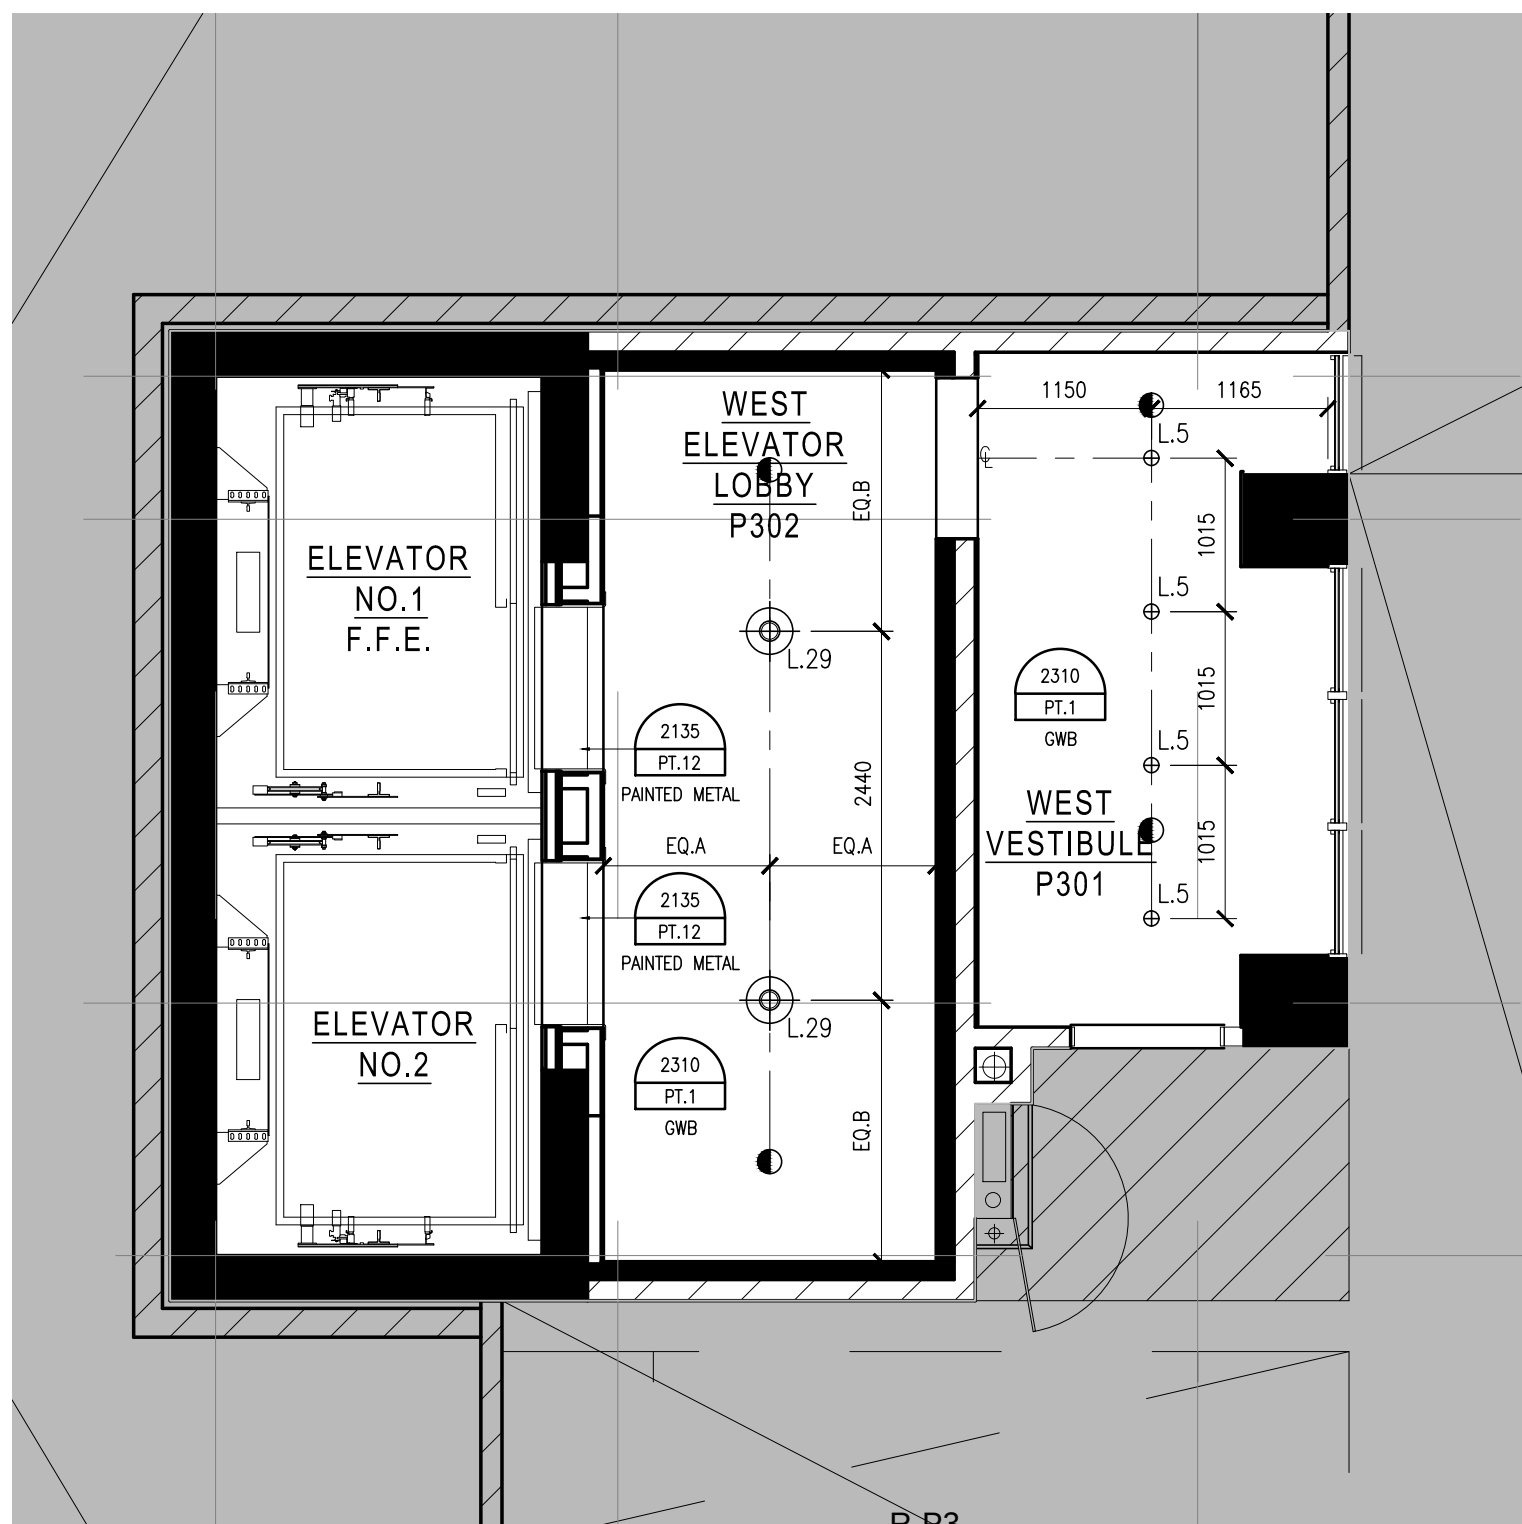


2 REFLECTED CEILING PLAN
R3.2 SCALE 1:50

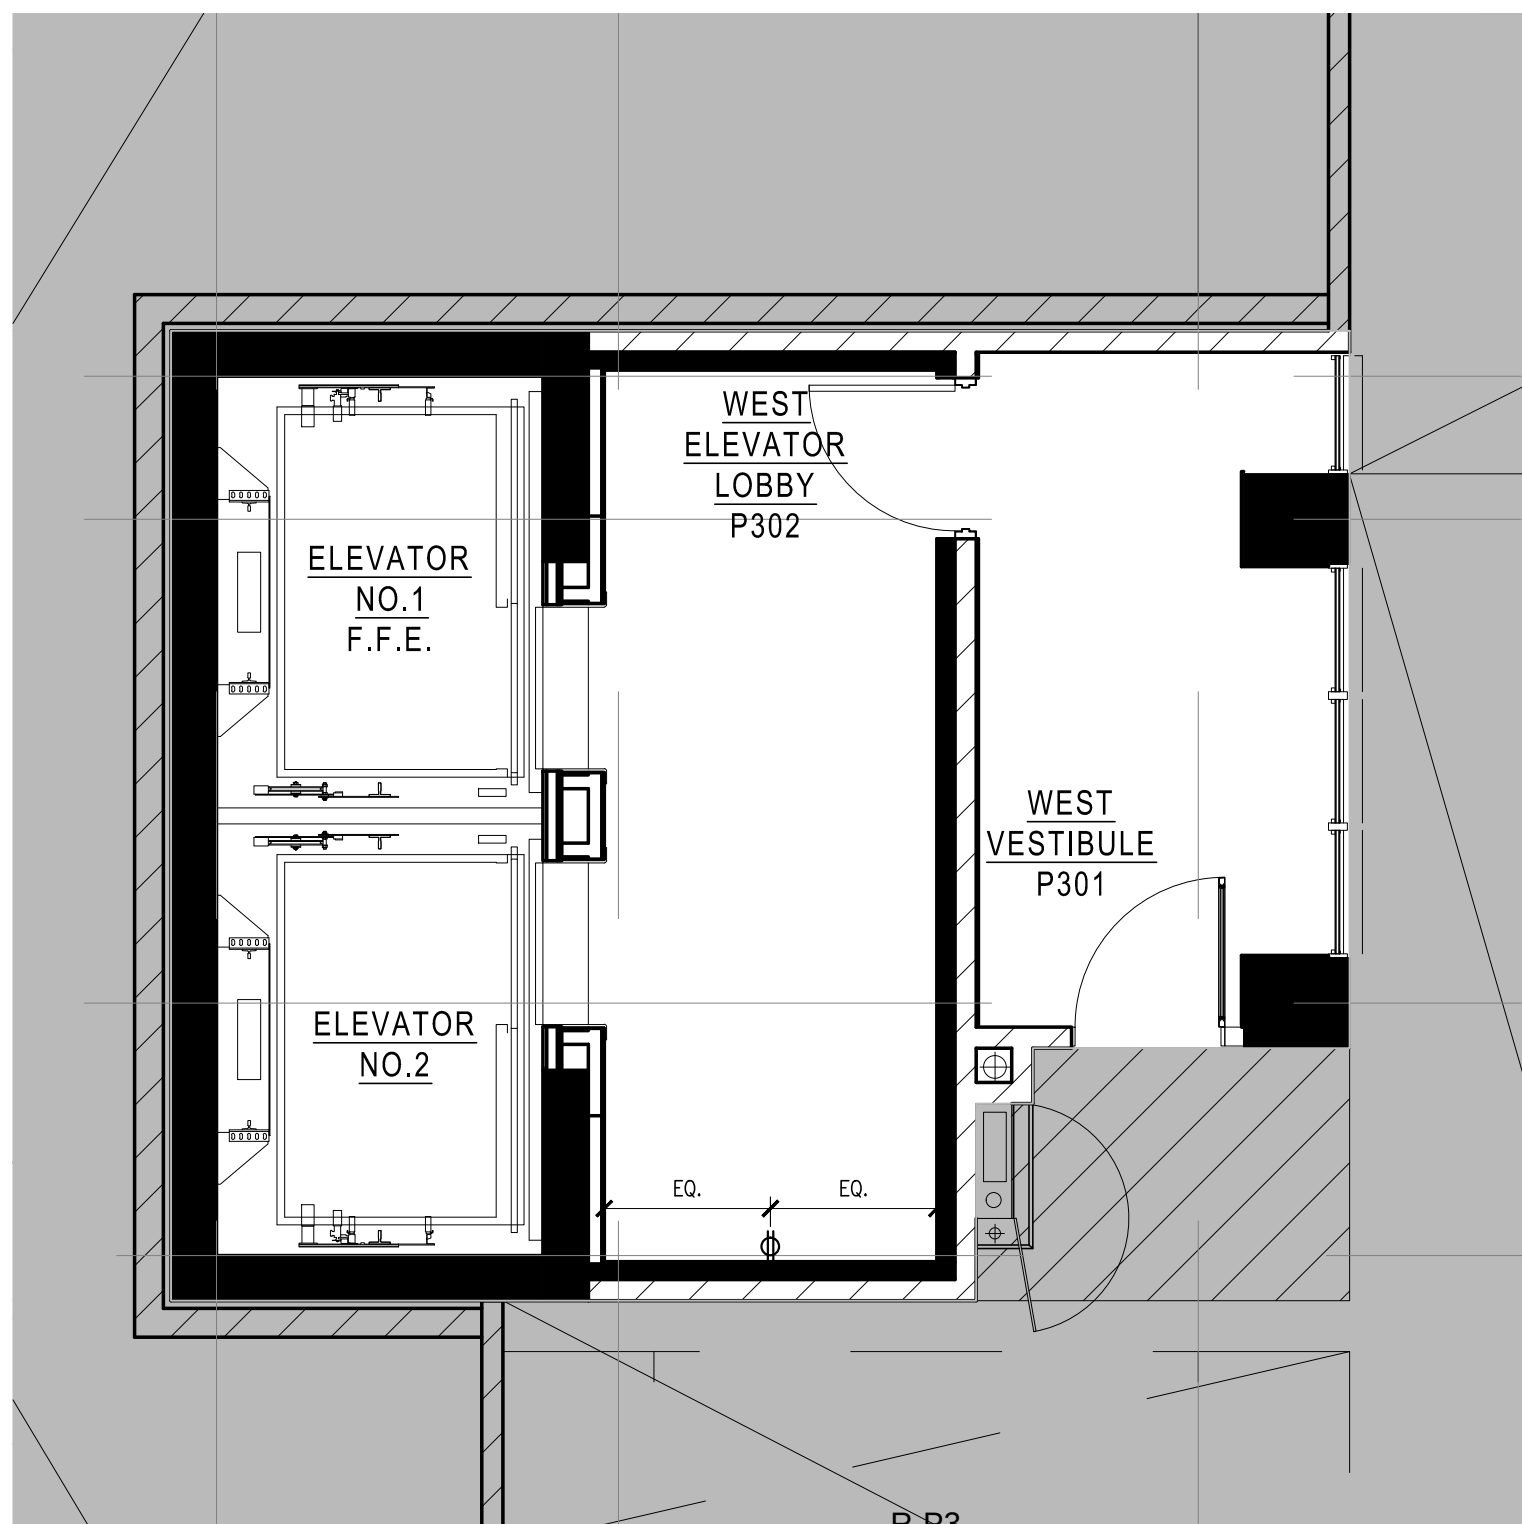


3 POWER AND COMMUNICATION PLAN
R3.2 SCALE 1:50

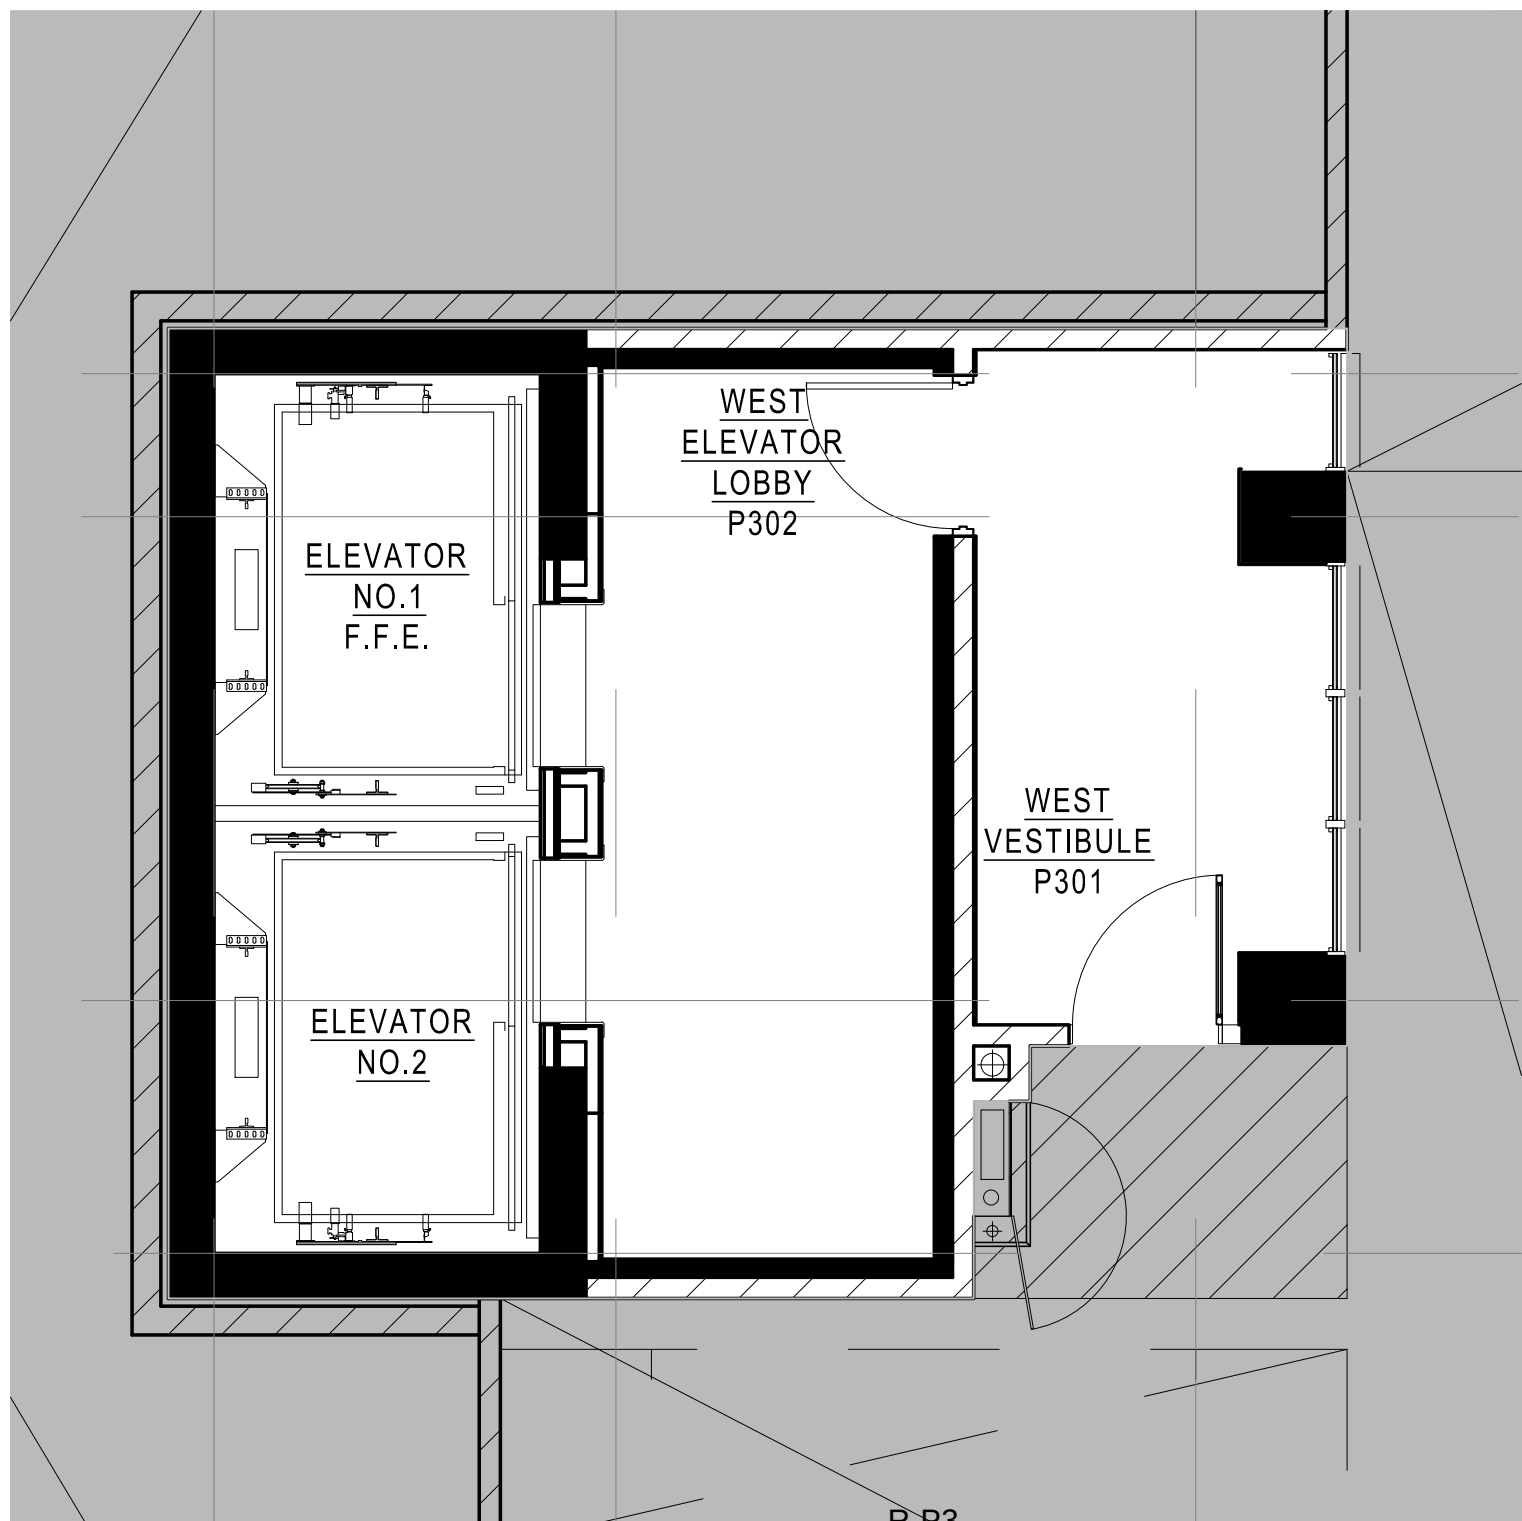

4 FURNITURE PLAN
R3.2 SCALE 1:50

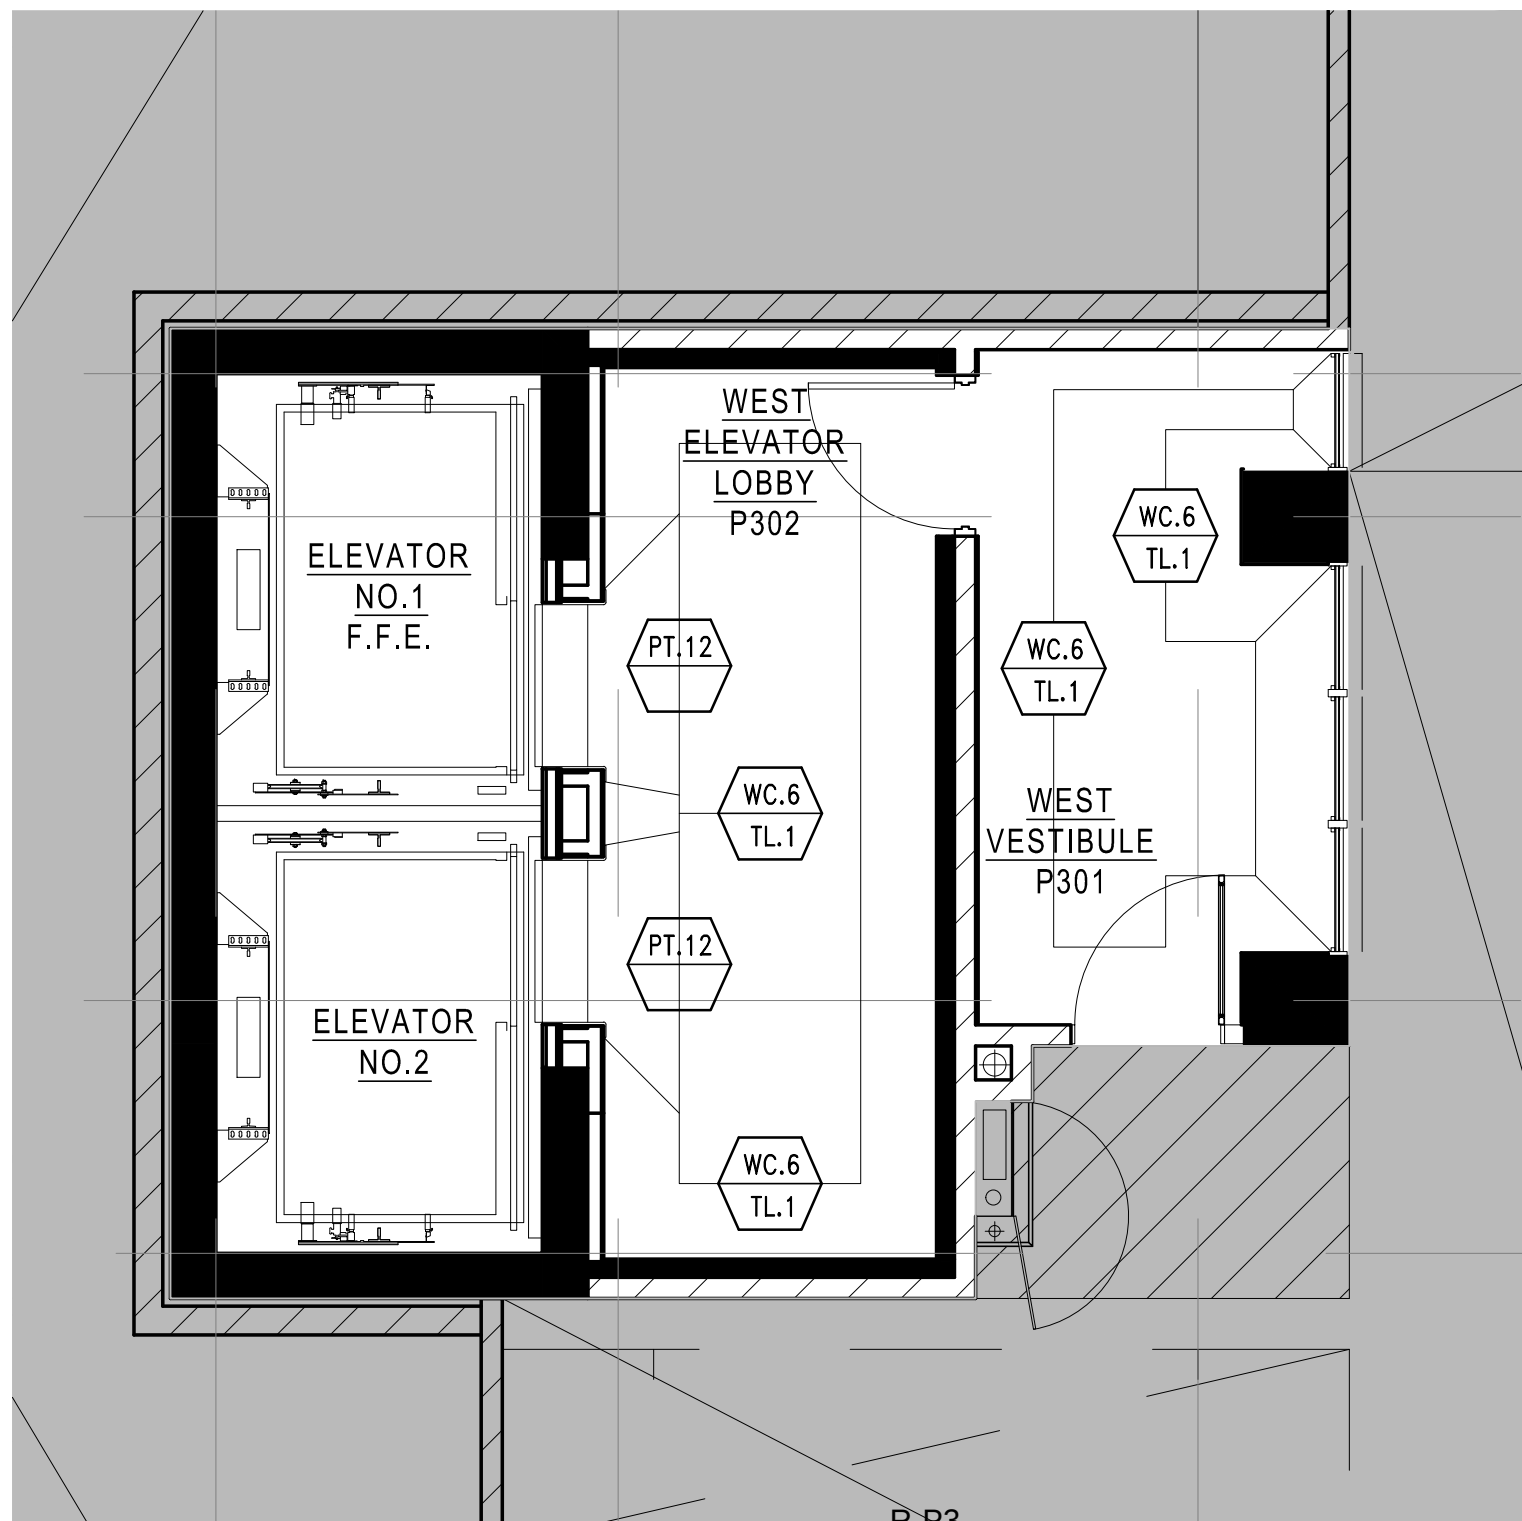

5 WALL FINISH PLAN
R3.2 SCALE 1:50

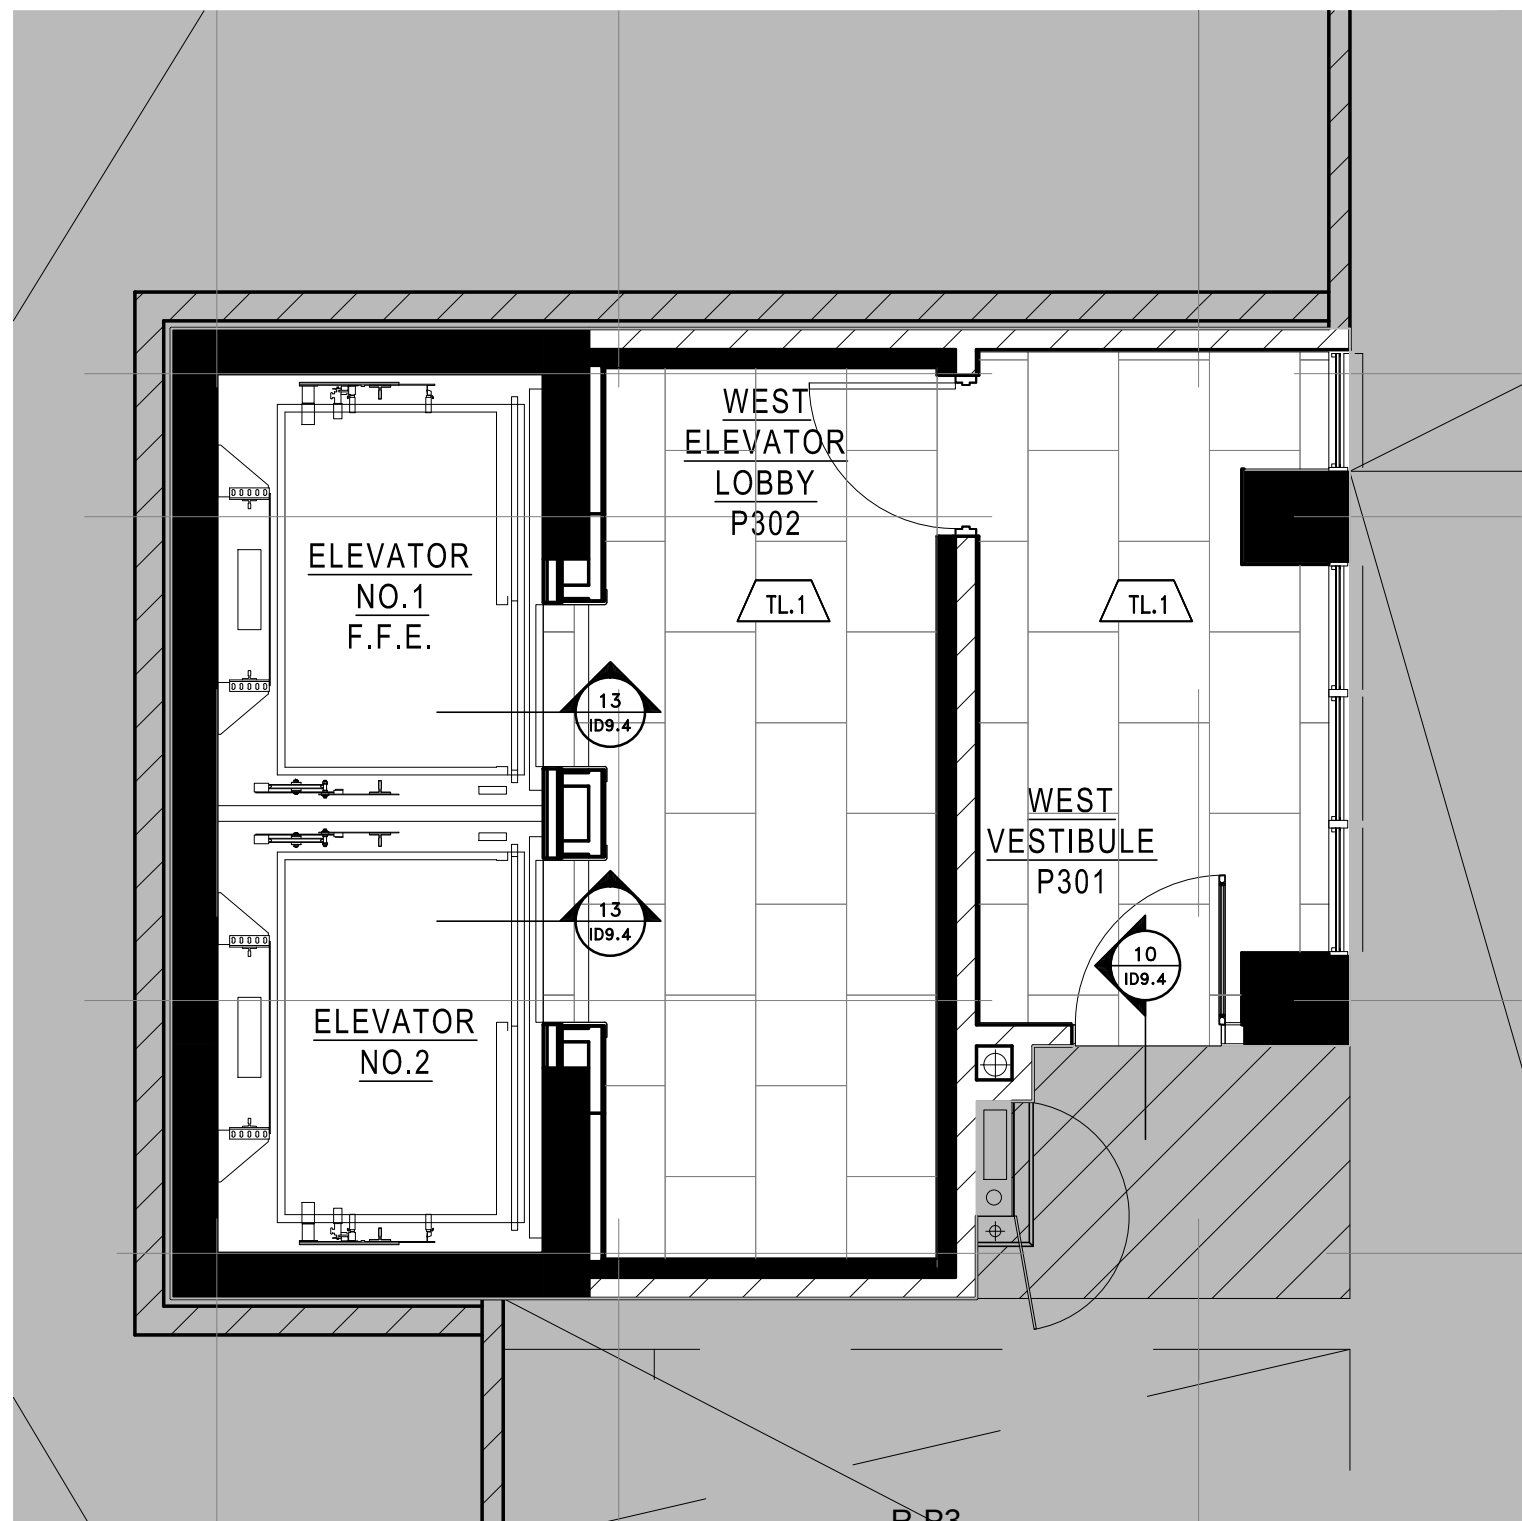

6 FLOOR FINISH PLAN
R3.2 SCALE 1:50

LEGEND : DRAWING SYMBOLS		
SYMBOL	DESCRIPTION	
	DETAIL NUMBER	REFER TO 34" X 48" DETAILS
	DETAIL NUMBER	REFER TO 11" X 17" DETAILS
	ELEVATION NUMBER PAGE NUMBER	REFER TO 34" X 48" ELEVATIONS
	EQUIPMENT CODE	REFER TO 11" X 17" EQUIPMENT SPECIFICATIONS
	DOOR CODE	REFER TO 11" X 17" DOOR SPECIFICATIONS

- PARTITION NOTES**
- THIS DRAWING IS TO BE READ IN CONJUNCTION WITH ARCHITECTURAL, MECHANICAL AND ELECTRICAL DRAWINGS AND SPECIFICATIONS. REPORT DISCREPANCIES TO THE DESIGNER FOR CLARIFICATION.
 - CONTRACTOR IS RESPONSIBLE FOR FIELD MEASUREMENTS AND DIMENSIONS. REPORT DISCREPANCIES TO THE DESIGNER FOR CLARIFICATION.
 - WORK TO BE CARRIED OUT ACCORDING TO RELEVANT CODES, STANDARDS AND AS PER SPECIFICATIONS ISSUED BY THE DESIGNER.
 - CONTRACTOR MUST OBTAIN CONSTRUCTION PERMITS REQUIRED BY RELEVANT AUTHORITIES BEFORE THE COMMENCEMENT OF WORK.
 - DIMENSIONS ARE TAKEN FROM FACE OF FINISHED PARTITION TO FACE OF FINISHED PARTITION, UNLESS OTHERWISE NOTED.
 - DIMENSIONS TAKEN FROM THE CORNER, COLUMNS OR CONVECTORS ARE TAKEN FROM THE FACE OF THAT ARCHITECTURAL ELEMENT TO THE CENTRE OF THE PARTITION.
 - NEW PARTITIONS TO BE FIXED DIRECTLY TO CLEAN CONCRETE SLAB. PARTITIONS TO BE PAPER, SHEET SMOOTH AND WARE READY TO RECEIVE FINISHES.
 - DRYWALL PARTITION JOINTS TO BE SMOOTH AND FLAME LINE TRUE.
 - CONTRACTOR TO ENSURE VARYING PARTITION THICKNESS TO COORDINATE WITH DOOR FRAME SIZES. REPORT DISCREPANCIES TO THE DESIGNER FOR CLARIFICATION.
 - CONTRACTOR TO ENSURE SUFFICIENT BLOODING IS PROVIDED IN AREAS REQUIRING SUPPORT OF THE PARTITION OR CEILING FOR MOUNTED EQUIPMENT OR MATERIALS.
 - CONTRACTOR TO ENSURE FLOOR IS LEVEL PRIOR TO CONSTRUCTION OF PARTITIONS. PROVIDE DAM COAT IF NECESSARY. VARIANCE NOT TO EXCEED 3/4" IN AREAS WHERE FLAME CABINETS OR SINKING UNITS ARE TO BE LOCATED. REFER TO FURNITURE PLAN FOR CABINET LAYOUTS.
 - CONTRACTOR TO REPAIR DAMAGE TO EXISTING FINE SEPARATION WITHIN THE AREA SCOPE OF WORK.
 - CONTRACTOR TO REFER TO MECHANICAL DRAWINGS TO ENSURE PROVISION FOR AIR TRANSFER OPENINGS ABOVE CEILING PARTITION CONSTRUCTION.
 - CONTRACTOR TO ENSURE ACOUSTICAL CHAILING IS PROVIDED AT PARTITION CONNECTIONS TO COLUMNS, CORE, FINISHED CEILING, FLOOR SLAB AND U/S OF STRUCTURE.
 - MATERIALS USED SHALL BE NEW UNLESS OTHERWISE NOTED.
 - LOCATIONS WHERE BASES INCLUDING PARTITIONS OR COLUMNS ARE TO RECEIVE ELECTRICAL CONDUIT AND BOXES, DRYPWALL CONTRACTOR IS RESPONSIBLE FOR FURRING, CUTTING, FINISHING AND FINISHING AS PER SPECIFICATIONS IN CONJUNCTION OF ELECTRICAL WORK.
 - REFER TO ARCHITECT'S PERMIT DRAWINGS FOR ALL PARTITION TYPES, PARTITION LOCATIONS AND DOOR SCHEDULES.

LEGEND : DRAWING SYMBOLS		
SYMBOL	DESCRIPTION	
	DETAIL NUMBER	REFER TO 11" X 17" DETAIL PNG
	CEILING HEIGHT CEILING FINISH CEILING MATERIAL	REFER TO 11" X 17" PRODUCT SPECIFICATIONS
	LIGHTING CODE	REFER TO 11" X 17" LIGHTING SPECIFICATIONS
	WOOD GRAIN DIRECTION	
	UPRIGHT SPRINKLER CODE	REFER TO CONSULTANT'S DRAWINGS FOR SPRINKLER SPECIFICATIONS & LOCATIONS
	PENDANT SPRINKLER CODE	REFER TO CONSULTANT'S DRAWINGS FOR SPRINKLER SPECIFICATIONS & LOCATIONS
	SIDEWALL SPRINKLER CODE	REFER TO CONSULTANT'S DRAWINGS FOR SPRINKLER SPECIFICATIONS & LOCATIONS

- REFLECTED CEILING NOTES**
- MECHANICAL AND ELECTRICAL WORK TO COMPLY WITH THE REQUIREMENTS OF THE BUILDING LAYOUTS AND AUTHORITIES' HAVING JURISDICTION.
 - REFER TO DESIGNER DRAWINGS FOR LOCATION OF CEILING FIXTURES. REFER TO ENGINEERING DRAWINGS FOR SPECIFICATIONS.
 - CONTRACTOR TO CROSS REFERENCE BETWEEN DESIGNER'S ELECTRICAL DRAWINGS, ENGINEER'S MECHANICAL DRAWING AND SITE CONDITIONS. REPORT DISCREPANCIES TO THE DESIGNER FOR CLARIFICATION.
 - CONTRACTOR TO PROVIDE OPENINGS IN DRYWALL CEILING TO ACCOMMODATE SPRINKLERS, EXIT LIGHTS, ACCESS PANELS, PREPRESSED DOWN LIGHTS, AIR DIFFUSERS. CONTRACTOR TO REFER TO REFLECTED CEILING PLAN AND ENGINEERING DRAWINGS AND SPECIFICATIONS.
 - LIGHT FIXTURES AND SWITCHES TO BE LOCATED IN ACCORDANCE WITH DESIGNER DRAWINGS. REPORT DISCREPANCIES TO THE DESIGNER PRIOR TO INSTALLATION.
 - CONTRACTOR TO PROVIDER AIR TRANSFER DUCTS IN ACCORDANCE WITH MECHANICAL DRAWINGS WHERE CONSTRUCTION OCCURS ABOVE SUSPENDED CEILING TO U/S OF SLAB.
 - REFER TO ENGINEERING DRAWINGS FOR LIFE SAFETY SYSTEMS.
 - ELECTRICAL CONSULTANT TO CONFIRM QUANTITY AND LOCATION OF LUMINAIRES REQUIRED TO ACHIEVE LIGHTING LEVELS AND DISTRIBUTION AS REQUIRED BY LOCAL GOVERNING CODES AND REGULATIONS.
 - ALL LIGHT FIXTURE TO BE ON DIMMERS.
 - CONTRACTOR TO CONFIRM CEILING HEIGHT & CONDITIONS AND NOTIFY DESIGNER OF ANY DISCREPANCIES.
 - CONTRACTOR & LIGHTING SUPPLIER TO VERIFY QUANTITY OF FIXTURES PRIOR TO ORDERING AND INSTALLING.

LEGEND : POWER		
SYMBOL	DESCRIPTION	QTY
	120 VOLTS DUPLEX OUTLET TO BE WALL MOUNTED @ 12" A.F.F. O.C. UNLESS OTHERWISE NOTED	-
	120 VOLTS DUPLEX OUTLET W/ GROUND FAULT INTERRUPTER TO BE WALL MOUNTED @ 12" A.F.F. O.C. UNLESS OTHERWISE NOTED	-
	TELEPHONE OUTLET TO BE WALL MOUNTED AS NOTED O.C. (CAT3 VOICE)	-
	DATA OUTLET TO BE WALL MOUNTED (CAT3 DATA)	-
	DEDICATED OUTLET FOR COMPUTER TO BE WALL MOUNTED @ 12" A.F.F. O.C. UNLESS OTHERWISE NOTED	-
	FLOOR MOUNTED DEDICATED OUTLET @ CASH AREA FOR COMPUTER	-
	FLOOR MOUNTED DUPLEX OUTLET	-
	FLOOR MOUNTED TELEPHONE OUTLET @ CASH AREA (CAT3 VOICE)	-
	FLOOR MOUNTED DATA OUTLET @ CASH AREA (CAT3 DATA)	-
	POWER REQUIRED	-
	SPENDER- WIRED TO OFFICE STEREO UNIT. CONTRACTOR TO PROVIDE ONLY IF NONE EXISTS	-
	EXISTING DUPLEX OUTLETS AND POWER TO REWORK	-
	CABLE TELEVISION OUTLET	-

- POWER AND COMMUNICATION NOTES**
- POWER AND COMMUNICATION DRAWINGS TO BE USED FOR LOCATION PURPOSES ONLY. REFER TO ELECTRICAL ENGINEERING DRAWINGS FOR DETAILS, SPECIFICATIONS AND REQUIREMENTS.
 - ELECTRICAL AND COMMUNICATION WORK TO COMPLY WITH THE REQUIREMENTS OF THE BUILDING LAYOUTS AND AUTHORITIES' HAVING JURISDICTION.
 - CONTRACTOR TO REPORT DISCREPANCIES BETWEEN ENGINEERING AND DESIGN DRAWINGS TO THE DESIGNER AND ELECTRICAL ENGINEER PRIOR TO COMMENCEMENT OF WORK.
 - SUMMIT REQUIRES CHANGES TO THE DESIGNER FOR APPROVAL, PRIOR TO COMMENCEMENT OF WORK.
 - DIMENSIONS OF SERVICES ARE TAKEN AT THE CENTRE OF THE SERVICE OR GROUP OF SERVICES, UNLESS OTHERWISE NOTED.
 - DIMENSIONS FROM A PARTITION ARE TAKEN FROM FACE OF PARTITION TO CENTRE OF THE SERVICE OR GROUP OF SERVICES, UNLESS OTHERWISE NOTED.
 - DIMENSIONS FROM THE PERIMETER OF THE BUILDING ARE TAKEN FROM FACE OF THE CONVECTOR OR BASE BUILDING ELEMENT TO CENTRE OF THE SERVICE OR GROUP OF SERVICES, UNLESS OTHERWISE NOTED.
 - REFER TO ENGINEERING DRAWINGS FOR SPECIFICATION OF COVER PLATE, RESISTANCE TYPE AND COLOUR. REFER TO DESIGNER DRAWINGS FOR MOUNTING HEIGHT.
 - WHERE POWER AND COMMUNICATION SERVICES ARE ADJACENT ON PLAN, DANGER COVER PLATES SHALL BE USED.
 - CONTRACTOR TO ENSURE THAT TRUNKS HAVE COMPLETED THEIR PORTION OF THE WORK BEFORE BOARDING UP BOTH SIDES OF THE STUDS. THIS IS TO INCLUDE INSPECTIONS AS REQUIRED BY LOCAL AND PROVINCIAL BY-LAW AND BUILDING CODES.
 - SOUND BATS IN PARTITIONS ARE TO CONTINUE BEHIND POWER AND TELEPHONE OUTLETS WITHOUT INTERRUPTION.
 - CHARGER OUTLETS OCCURRING ON OPPOSITE SIDES OF THE SAME PARTITION TO MAINTAIN ACOUSTICAL INTEGRITY.
 - FURNITURE SYSTEM FEEDS TO BE SUPPLIED BY SYSTEMS FURNITURE MANUFACTURER AND ELECTRICAL CONNECTION OF SYSTEM FURNITURE BY ELECTRICAL CONTRACTOR.
 - CONTRACTOR TO SUPPLY, INSTALL, CONNECT AND VERIFY SECURITY ACCESS CONTROLS EQUIPMENT INCLUDING THE SUPPLY AND INSTALLATION OF BOXES, CONDUITS, WIRING AND SEALING AS PER SECURITY CONSULTANT'S SPECIFICATIONS AND DETAILS.
 - TYPICAL WALL OUTLETS TO BE MOUNTED AT 12" A.F.F.
 - REFER TO MECHANICAL & ELECTRICAL ENGINEER'S DRAWINGS FOR SPECIFICATIONS.
 - ALL POWER SHOWN ON THIS PLAN TO BE COORDINATED AND APPROVED BY CLIENT PRIOR TO INSTALLATION AND FABRICATION OF ANY MILLWORK WITH POWER REQUIREMENTS.
 - CONTRACTOR SHALL CONFIRM ALL QUANTITIES PRIOR TO ORDERING.
 - CONTRACTOR IS RESPONSIBLE FOR:
 - DISCONNECTING ALL LIGHTING, COMPUTERS, DATA LINES, PHONE LINES, ELECTRICAL TRUNKS, ETC.
 - REMOVING AND RELOCATION OF EXISTING ELECTRICAL, AS REQUIRED.
 - REMOVING ALL EXISTING FLAT WIRE SYSTEMS UNDER EXISTING FLOORCOVERING IF REQUIRED.
 - CLIENT IS RESPONSIBLE FOR ALL POS AND LIGHT WORK.
 - THE ELECTRICAL CONTRACTOR MUST VISIT THE SITE AND DO TAKE OFF ON QUANTITY AND MATERIALS REQUIRED BEFORE STARTING PROJECT. ALL FUTURE LAYOUTS AND ELECTRICAL ROOM UPS ARE TO BE CONFIRMED ON SITE AND DESIGNER NOTIFIED IF THERE ARE ANY DISCREPANCIES.

LEGEND : DRAWING SYMBOLS		
SYMBOL	DESCRIPTION	
	FURNITURE CODE	REFER TO 11" X 17" FURNITURE SPECIFICATIONS

- FURNITURE PLAN NOTES:**
- CONTRACTOR AND/OR CLIENT TO VERIFY QUANTITIES FOR ALL DISPLAY FIXTURES AND FURNITURE REQUIREMENTS PRIOR TO ORDERING.

LEGEND : DRAWING SYMBOLS		
SYMBOL	DESCRIPTION	
	WALL FINISH	REFER TO 11" X 17" FINISH SPECIFICATIONS
	WALL BASE FINISH	

- FINISHES NOTES**
- CONTRACTOR TO PROVIDE DRAW-DOWNS OF EACH PAINT COLOUR TO B BY IV FOR DESIGNER'S APPROVAL, PRIOR TO COMMENCEMENT OF WORK.
 - ALL NEW MATERIALS FOR INSTALLATION, FINISHING AND SEALING ARE TO BE EXCLUDED TO MANUFACTURER'S BEST INSTRUCTIONS AND SPECIFICATIONS FOR APPLICATION AND INTENDED USAGE.
 - ALL MATERIALS LISTED TO BE USED AS SPECIFIED. ANY ALTERNATIVES TO BE SUBMITTED TO DESIGNER FOR APPROVAL, PRIOR TO ORDERING AND INSTALLATION.
 - CONTRACTOR TO INSURE THAT ALL DRYWALL IS FLUSH, CLEAN AND FREE FROM DUST PRIOR TO APPLICATION OF ALL WALL FINISHES.
 - ALLOW FOR PAINT TOUCH-UPS AFTER MILLWORK AND FURNITURE INSTALLATION.
 - ALL NEW PARTITIONS AND EXISTING BASE BUILDING SURFACES REQUIRING REPAIR SHALL BE PRIMED AND RECEIVE 2 COATS OF FINISH PAINT SPECIFIED.
 - ALL FIRE HOSE CABINETS AND FRAMING TO BE FINISHED WITH SEMI-GLOSS PAINT.
 - CONTRACTOR TO MAKE SITE GOOD, LEVEL AND READY TO ACCEPT INSTALLATION OF ALL FLOOR FINISHES. SKIN FLOOR AS REQUIRED TO ENSURE LEVEL SURFACE.
 - PROVIDE MANUFACTURER'S MAINTENANCE DATA FOR ALL FINISHES TO CLIENT AT THE COMPLETION OF THE PROJECT.
 - GENERAL CONTRACTOR TO COORDINATE INSTALLATION OF CARPET WITH INSTALLATION OF OTHER FLOOR AND BASE MATERIALS.
 - TRANSITION BETWEEN ONE CARPET TYPE AND ANOTHER OR BETWEEN FLOOR FINISHES AT DOOR WILL OCCUR DIRECTLY BELOW THE DOOR (IN CLOSED POSITION). NEW WRECKERS TO BE APPROVED BY DESIGNER PRIOR TO INSTALLATION.
 - CONTRACTOR TO PROVIDE CARPET SEAMING TO DESIGNER FOR REVIEW.
 - QUICK RELEASE ADHESIVE IS TO BE USED FOR CARPET INSTALLATION.

LEGEND : DRAWING SYMBOLS		
SYMBOL	DESCRIPTION	
	FLOOR FINISH NUMBER	REFER TO 11" X 17" FINISH SPECIFICATIONS

- FINISHES NOTES**
- CONTRACTOR TO PROVIDE DRAW-DOWNS OF EACH PAINT COLOUR TO B BY IV FOR DESIGNER'S APPROVAL, PRIOR TO COMMENCEMENT OF WORK.
 - ALL NEW MATERIALS FOR INSTALLATION, FINISHING AND SEALING ARE TO BE EXCLUDED TO MANUFACTURER'S BEST INSTRUCTIONS AND SPECIFICATIONS FOR APPLICATION AND INTENDED USAGE.
 - CONTRACTOR TO MAKE SITE GOOD, LEVEL AND READY TO ACCEPT INSTALLATION OF ALL FLOOR FINISHES. SKIN FLOOR AS REQUIRED TO ENSURE LEVEL SURFACE.
 - PROVIDE MANUFACTURER'S MAINTENANCE DATA FOR ALL FINISHES TO CLIENT AT THE COMPLETION OF THE PROJECT.
 - REMOVE EXCESS ADHESIVE FROM VINYL FLOOR, BASE AND WALL SURFACES WITHOUT DAMAGE. CLEAN, SEAL AND MAX FLOOR AND BASE SURFACES TO FLOORING MANUFACTURER'S INSTRUCTIONS.
 - GENERAL CONTRACTOR TO COORDINATE INSTALLATION OF CARPET WITH INSTALLATION OF OTHER FLOOR AND BASE MATERIALS.
 - QUICK RELEASE ADHESIVE IS TO BE USED FOR CARPET INSTALLATION.

Notes:

1. CONTRACTOR AND ALL SUB-TRADES SHALL VERIFY ALL SITE DIMENSIONS. ALL DRAWINGS, DETAILS AND SPECIFICATIONS AND REPORT ANY DISCREPANCIES TO THE INTERIOR DESIGNER IN WRITING FOR APPROVAL BEFORE PROCEEDING WITH THE WORK.

2. CONTRACTOR AND SUB-CONTRACTORS, BEFORE PROCEEDING WITH WORK, MUST SUBMIT ALL NECESSARY SAMPLES FOR APPROVAL OF QUALITY AND FINISH TO THE INTERIOR DESIGNER.

3. CONTRACTOR MUST COMPLY WITH THE CONTRACT DOCUMENTS, PERFORMANCE REQUIREMENTS, APPLICABLE CODES AND REGULATIONS.

4. ALL DRAWINGS AND WRITTEN MATERIAL HEREIN CONSTITUTES THE ORIGINAL AND UNPUBLISHED WORK OF "IBY IV DESIGN ASSOCIATES INC." AND MAY NOT BE DUPLICATED, USED OR DISCLOSED WITHOUT PRIOR WRITTEN CONSENT OF "IBY IV DESIGN ASSOCIATES INC."

5. DRAWINGS NOT TO BE SCALED

Issue:

04 ISSUED FOR COORDINATION	16.11.11
05 ISSUED FOR COORDINATION	16.01.11
06 ISSUED FOR CLIENT REVIEW	16.01.15
07 ISSUED FOR TENDER	16.03.18

-

-

**LEVEL P3
WEST ELEVATOR LOBBY
PLANS**

Our Project Number:
14008

Designed By: DMJR, VW-SG
Detailed By: DMJR, VW-SG, BP

Drawing Number:

ID3.2