


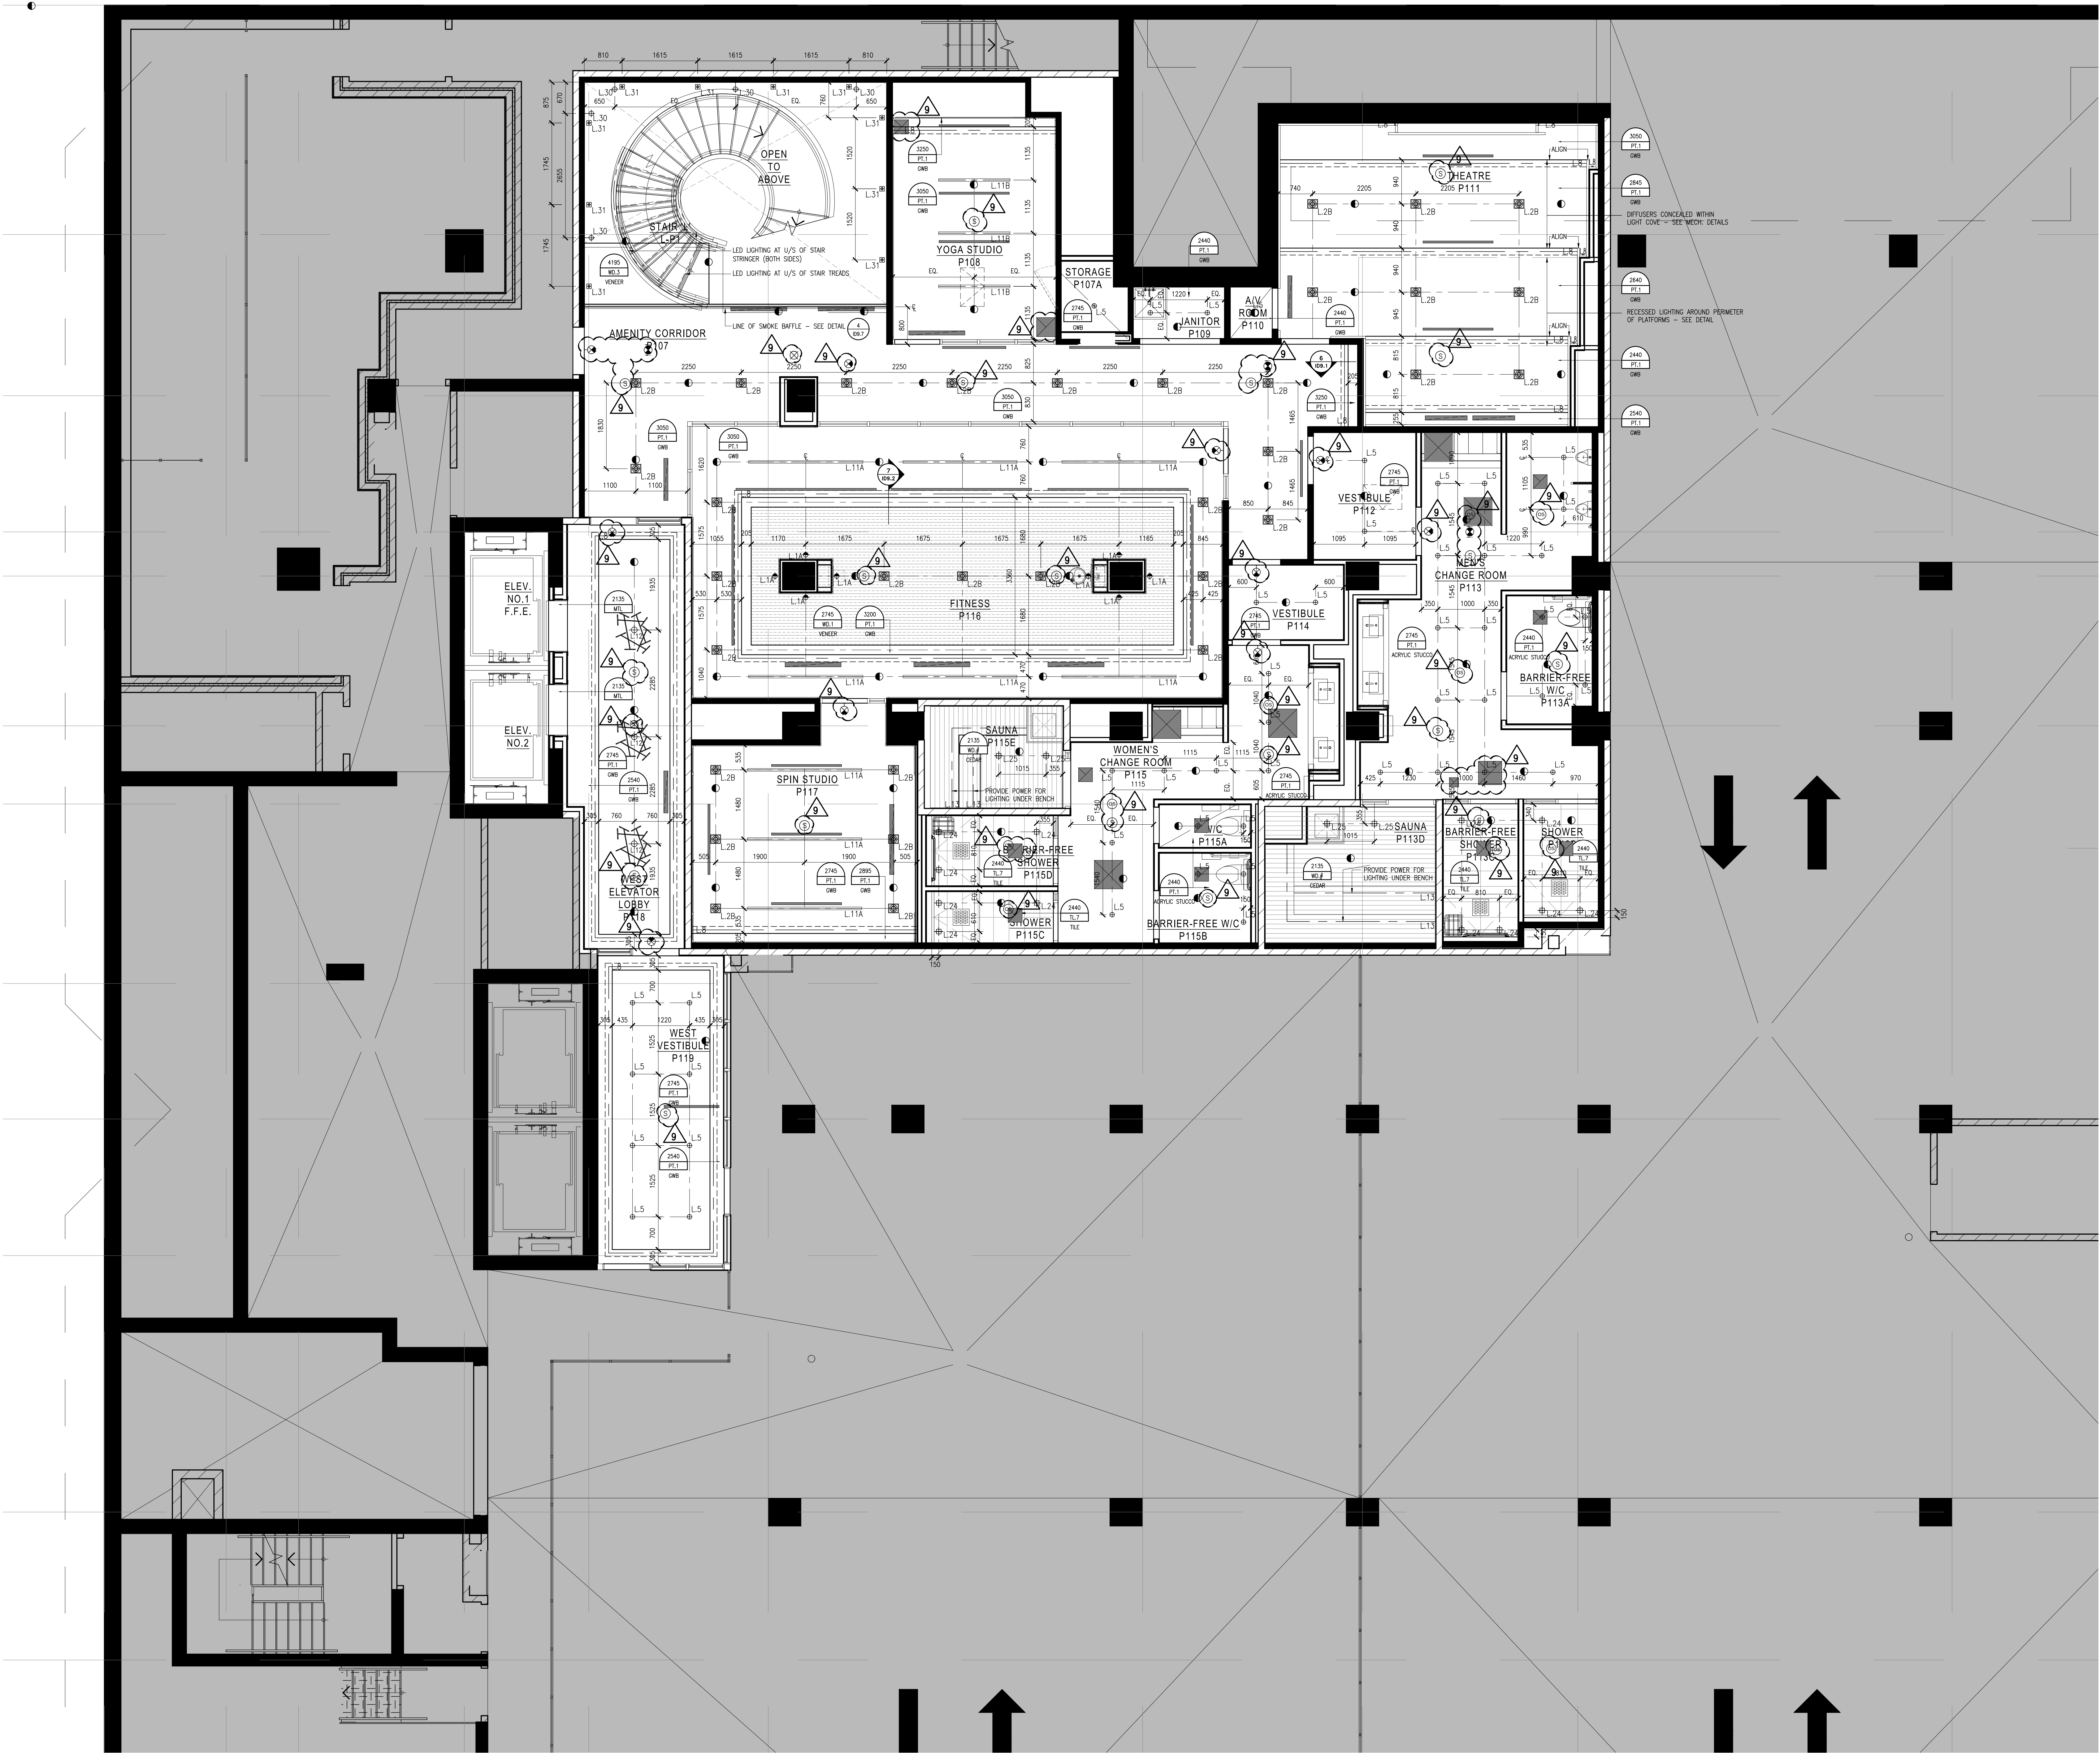

LEGEND : DRAWING SYMBOLS	
SYMBOL	DESCRIPTION
	DETAIL NUMBER REFER TO 11" x 17" DETAIL PNG
	CEILING HEIGHT CEILING FINISH CEILING MATERIAL REFER TO 11" x 17" PRODUCT SPECIFICATIONS
	LIGHTING CODE REFER TO 11" x 17" LIGHTING SPECIFICATIONS
	WOOD GRAIN DIRECTION
	UPRIGHT SPRINKLER CODE REFER TO CONSULTANT'S DRAWINGS FOR SPRINKLER SPECIFICATIONS & LOCATIONS
	PENDANT SPRINKLER CODE REFER TO CONSULTANT'S DRAWINGS FOR SPRINKLER SPECIFICATIONS & LOCATIONS
	SIDEWALL SPRINKLER CODE REFER TO CONSULTANT'S DRAWINGS FOR SPRINKLER SPECIFICATIONS & LOCATIONS
	LINEAR DIFFUSER CODE REFER TO MECHANICAL CONSULTANT'S DRAWINGS FOR SPECIFICATIONS & LOCATIONS
	RETURN AIR CODE REFER TO MECHANICAL CONSULTANT'S DRAWINGS FOR SPECIFICATIONS & LOCATIONS
	SUPPLY AIR CODE REFER TO MECHANICAL CONSULTANT'S DRAWINGS FOR SPECIFICATIONS & LOCATIONS
	EXHAUST AIR CODE REFER TO MECHANICAL CONSULTANT'S DRAWINGS FOR SPECIFICATIONS & LOCATIONS
	ACCESS PANEL CODE REFER TO MECHANICAL CONSULTANT'S DRAWINGS FOR SPECIFICATIONS & LOCATIONS
	CEILING MOUNTED SPRINKLER REFER TO CONSULTANT'S DRAWINGS FOR SPECIFICATIONS & LOCATIONS
	WALL MOUNTED EXIT LIGHT REFER TO CONSULTANT'S DRAWINGS FOR SPECIFICATIONS & LOCATIONS
	CEILING MOUNTED EXIT LIGHT REFER TO CONSULTANT'S DRAWINGS FOR SPECIFICATIONS & LOCATIONS
	CEILING MOUNTED OCCUPANCY SENSOR REFER TO CONSULTANT'S DRAWINGS FOR SPECIFICATIONS & LOCATIONS
	CEILING OR WALL MOUNTED SMOKE DETECTOR REFER TO CONSULTANT'S DRAWINGS FOR SPECIFICATIONS & LOCATIONS
REFLECTED CEILING NOTES	
1. MECHANICAL AND ELECTRICAL WORK TO COMPLY WITH THE REQUIREMENTS OF THE BUILDING LANDLORD AND AUTHORITIES HAVING JURISDICTION.	
2. REFER TO DESIGNER DRAWINGS FOR LOCATION OF CEILING FIXTURES. REFER TO ENGINEERING DRAWINGS FOR SPECIFICATIONS.	
3. CONTRACTOR TO CROSS REFERENCE BETWEEN DESIGNER'S ELECTRICAL DRAWINGS, ENGINEER'S MECHANICAL DRAWINGS AND SITE CONDITIONS. REPORT DISCREPANCIES TO THE DESIGNER FOR CLARIFICATION.	
4. CONTRACTOR TO PROVIDE GROUNDS IN DRYWALL CEILING TO ACCOMMODATE SPRINKLERS, EXIT LIGHTS, ACCESS PANELS, RECESSED DOWN LIGHTS, AIR DIFFUSERS. CONTRACTOR TO REFER TO REFLECTED CEILING PLAN AND ENGINEERING DRAWINGS AND SPECIFICATIONS.	
5. LIGHT FIXTURES AND SWITCHES TO BE LOCATED IN ACCORDANCE WITH DESIGNER DRAWINGS. REPORT DISCREPANCIES TO THE DESIGNER PRIOR TO INSTALLATION.	
6. CONTRACTOR TO PROVIDER AIR TRANSFER DUCTS IN ACCORDANCE WITH MECHANICAL DRAWINGS WHERE CONSTRUCTION OCCURS ABOVE SUSPENDED CEILING TO U/S OF SLAB.	
7. REFER TO ENGINEERING DRAWINGS FOR LIFE SAFETY SYSTEMS.	
8. ALL LIGHT FIXTURE TO BE ON DIMMERS.	
10. CONTRACTOR TO VERIFY CEILING HEIGHT & CONDITIONS AND NOTIFY DESIGNER OF ANY DISCREPANCIES.	
11. CONTRACTOR & LIGHTING SUPPLIER TO VERIFY QUANTITY OF FIXTURES PRIOR TO ORDERING AND INSTALLING.	

- Notes:
1. CONTRACTOR AND ALL SUB-TRADES SHALL VERIFY ALL SITE CONDITIONS. ALL DRAWINGS, DETAILS AND SPECIFICATIONS AND REPORT ANY DISCREPANCIES TO THE INTERIOR DESIGNER IN WRITING FOR APPROVAL BEFORE PROCEEDING WITH THE WORK.
 2. CONTRACTOR AND SUB-CONTRACTORS, BEFORE PROCEEDING WITH WORK, MUST SUBMIT ALL NECESSARY SAMPLES FOR APPROVAL OF QUALITY AND FINISH TO THE INTERIOR DESIGNER.
 3. CONTRACTOR MUST COMPLY WITH THE CONTRACT DOCUMENTS, PERFORMANCE REQUIREMENTS, APPLICABLE CODES AND REGULATIONS.
 4. ALL DRAWINGS AND WRITTEN MATERIAL HEREIN CONSTITUTES THE ORIGINAL AND UNPUBLISHED WORK OF "IBY IV DESIGN ASSOCIATES INC." AND MAY NOT BE DUPLICATED, USED OR DISCLOSED WITHOUT PRIOR WRITTEN CONSENT OF "IBY IV DESIGN ASSOCIATES INC."
 5. DRAWINGS NOT TO BE SCALED

Issue:	
01 ISSUED FOR COORDINATION	15.04.09
02 ISSUED FOR COORDINATION	15.04.13
04 ISSUED FOR COORDINATION	15.11.11
05 ISSUED FOR COORDINATION	16.01.11
06 ISSUED FOR CLIENT REVIEW	16.01.15
07 ISSUED FOR TENDER	16.03.18
08 ISSUED FOR ADDENDUM	16.09.20
09 ISSUED FOR ADDENDUM	17.01.27
-	-
-	-
-	-
-	-

1 REFLECTED CEILING PLAN
SCALE 1:150

Hines TRIDEL

AQUAVISTA
AT BAYSIDE TORONTO
1 EDGEWATER DRIVE, TORONTO ONTARIO

IBY
IV
DESIGN

77 MOWAT AVENUE, SUITE 140
TORONTO, ONTARIO M5S 2E1 CANADA
T + 1 416 531 2224
12 DESBOROUGH STREET
NEW YORK, NEW YORK 10013-USA
T + 1 212 392 4952

Drawing Title:
LEVEL P1
REFLECTED CEILING
PLAN

Our Project Number:
14008
Designed By:
DMJ/R, VW/SG
Detailed By:
DMJ/R, VW/SG, BP
Drawing Number:

ID3.4