




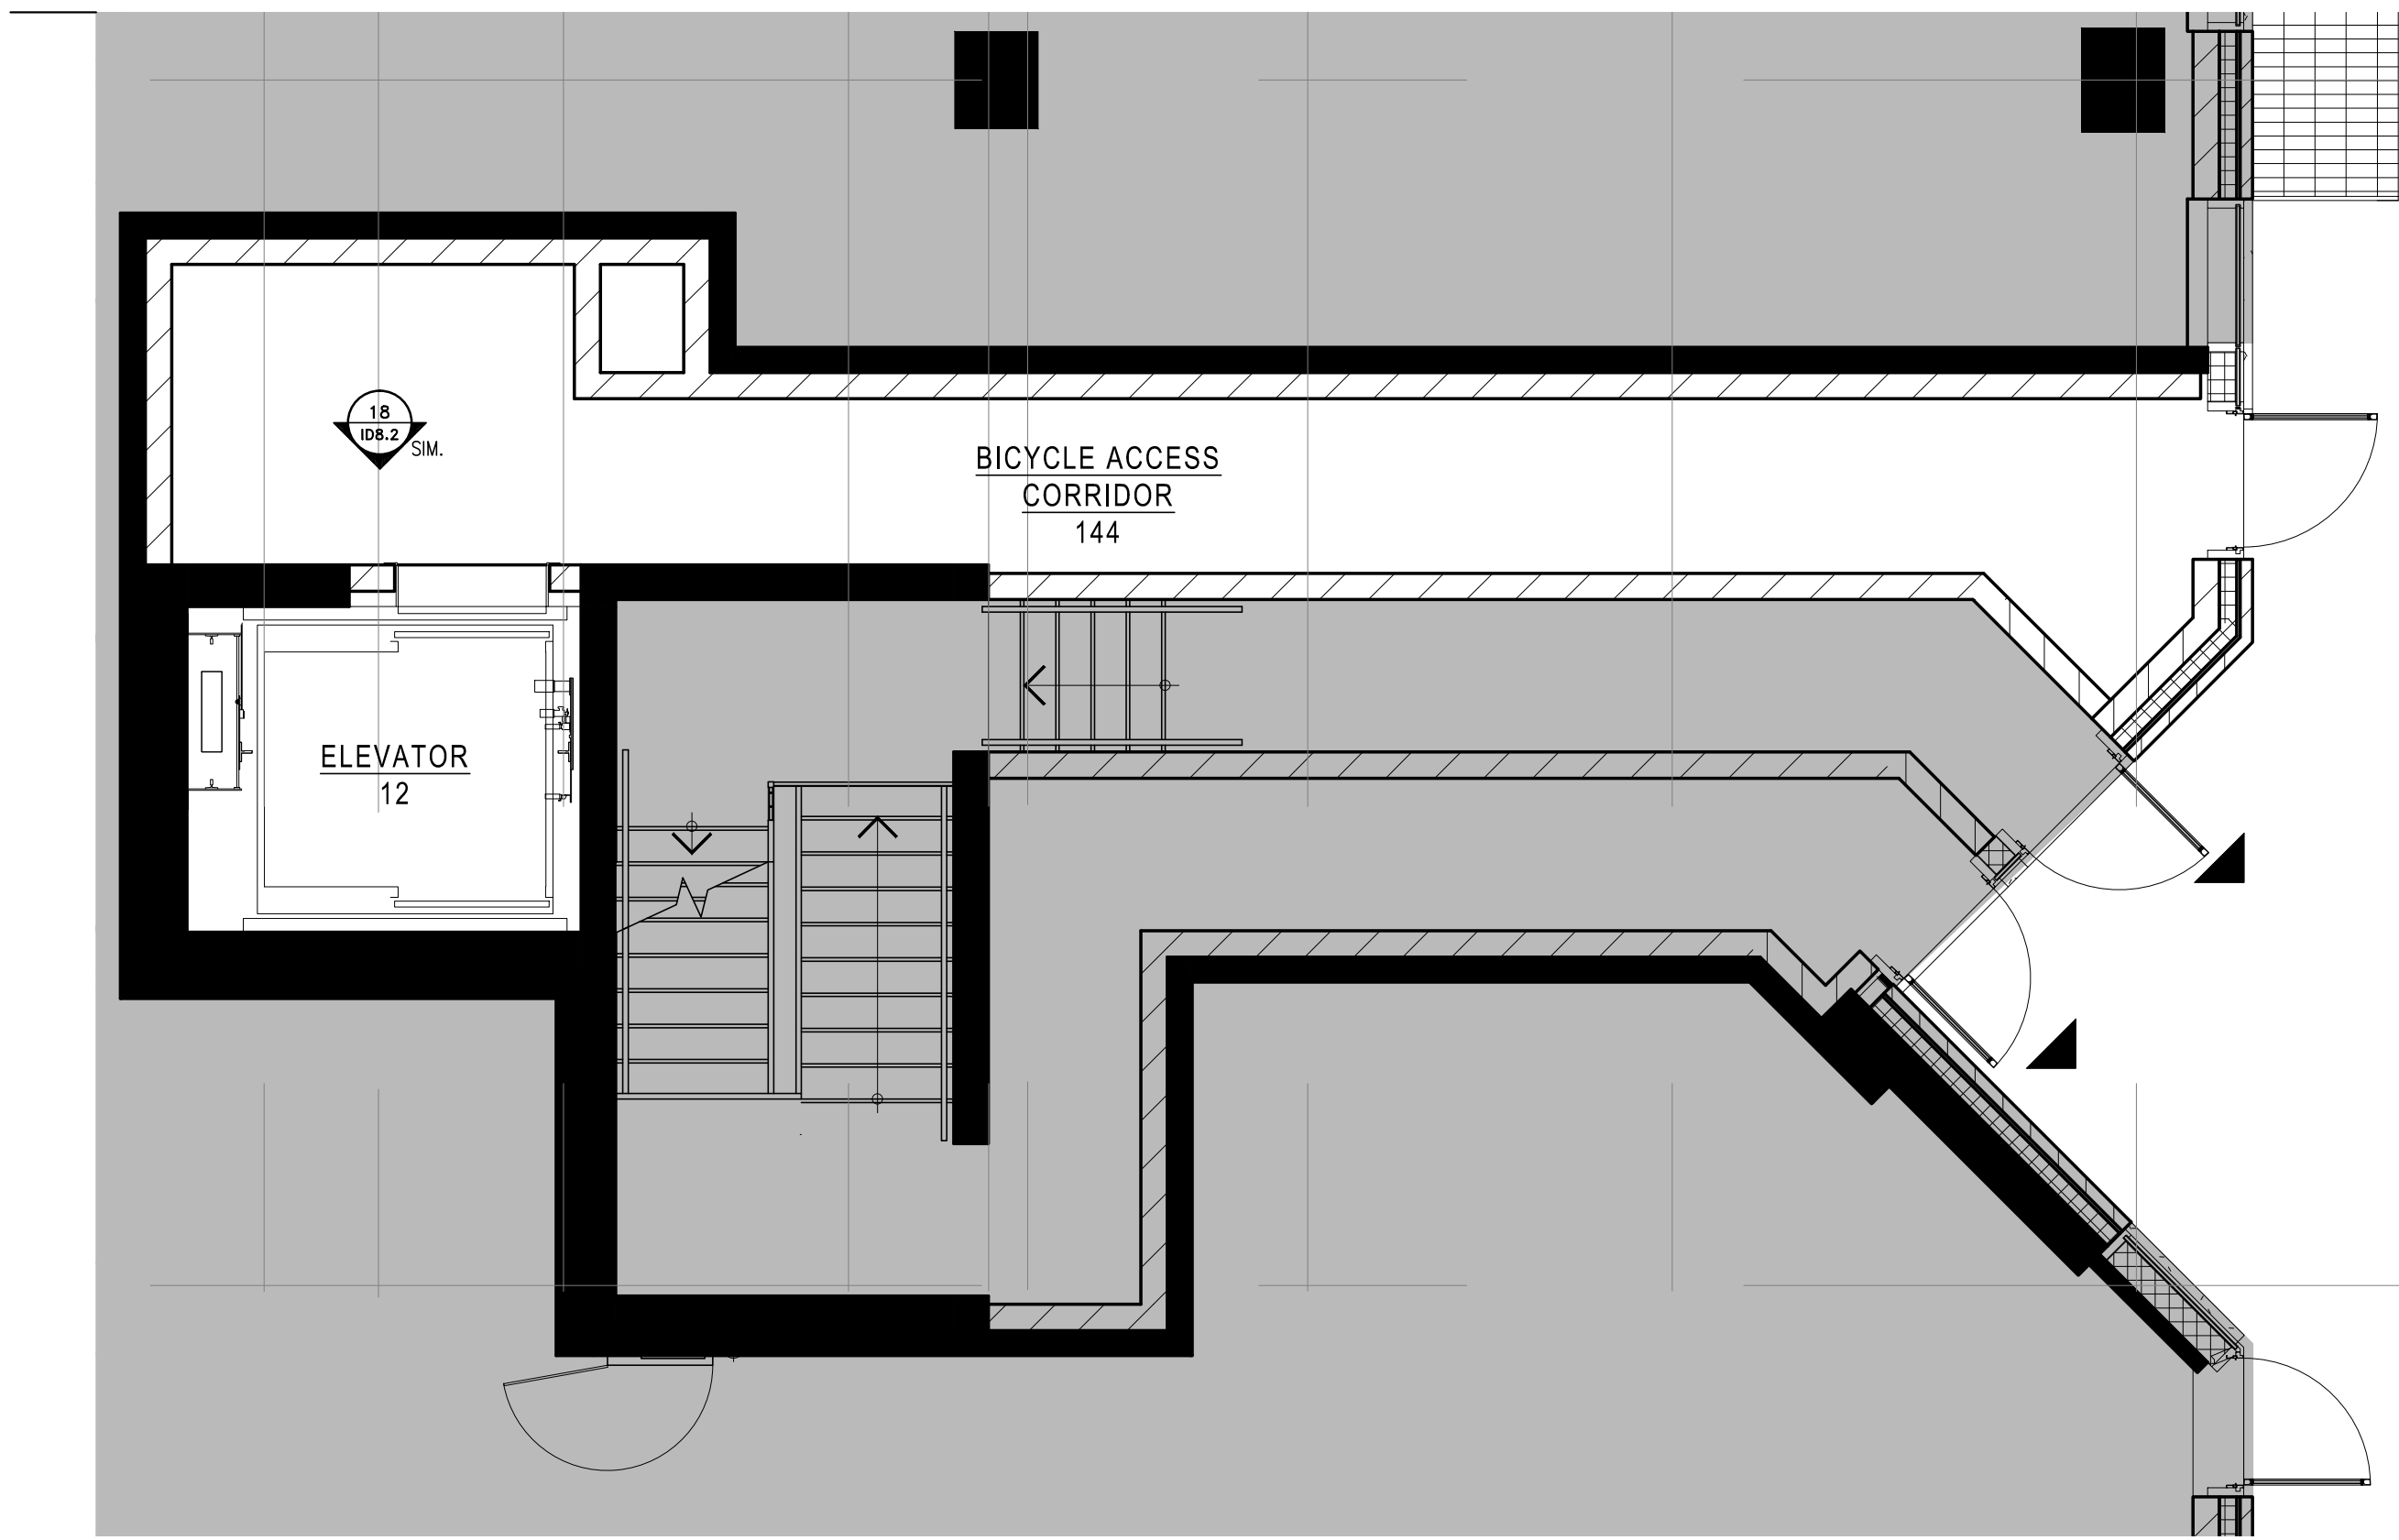


1 CONSTRUCTION PLAN
02.3 SCALE 1:50

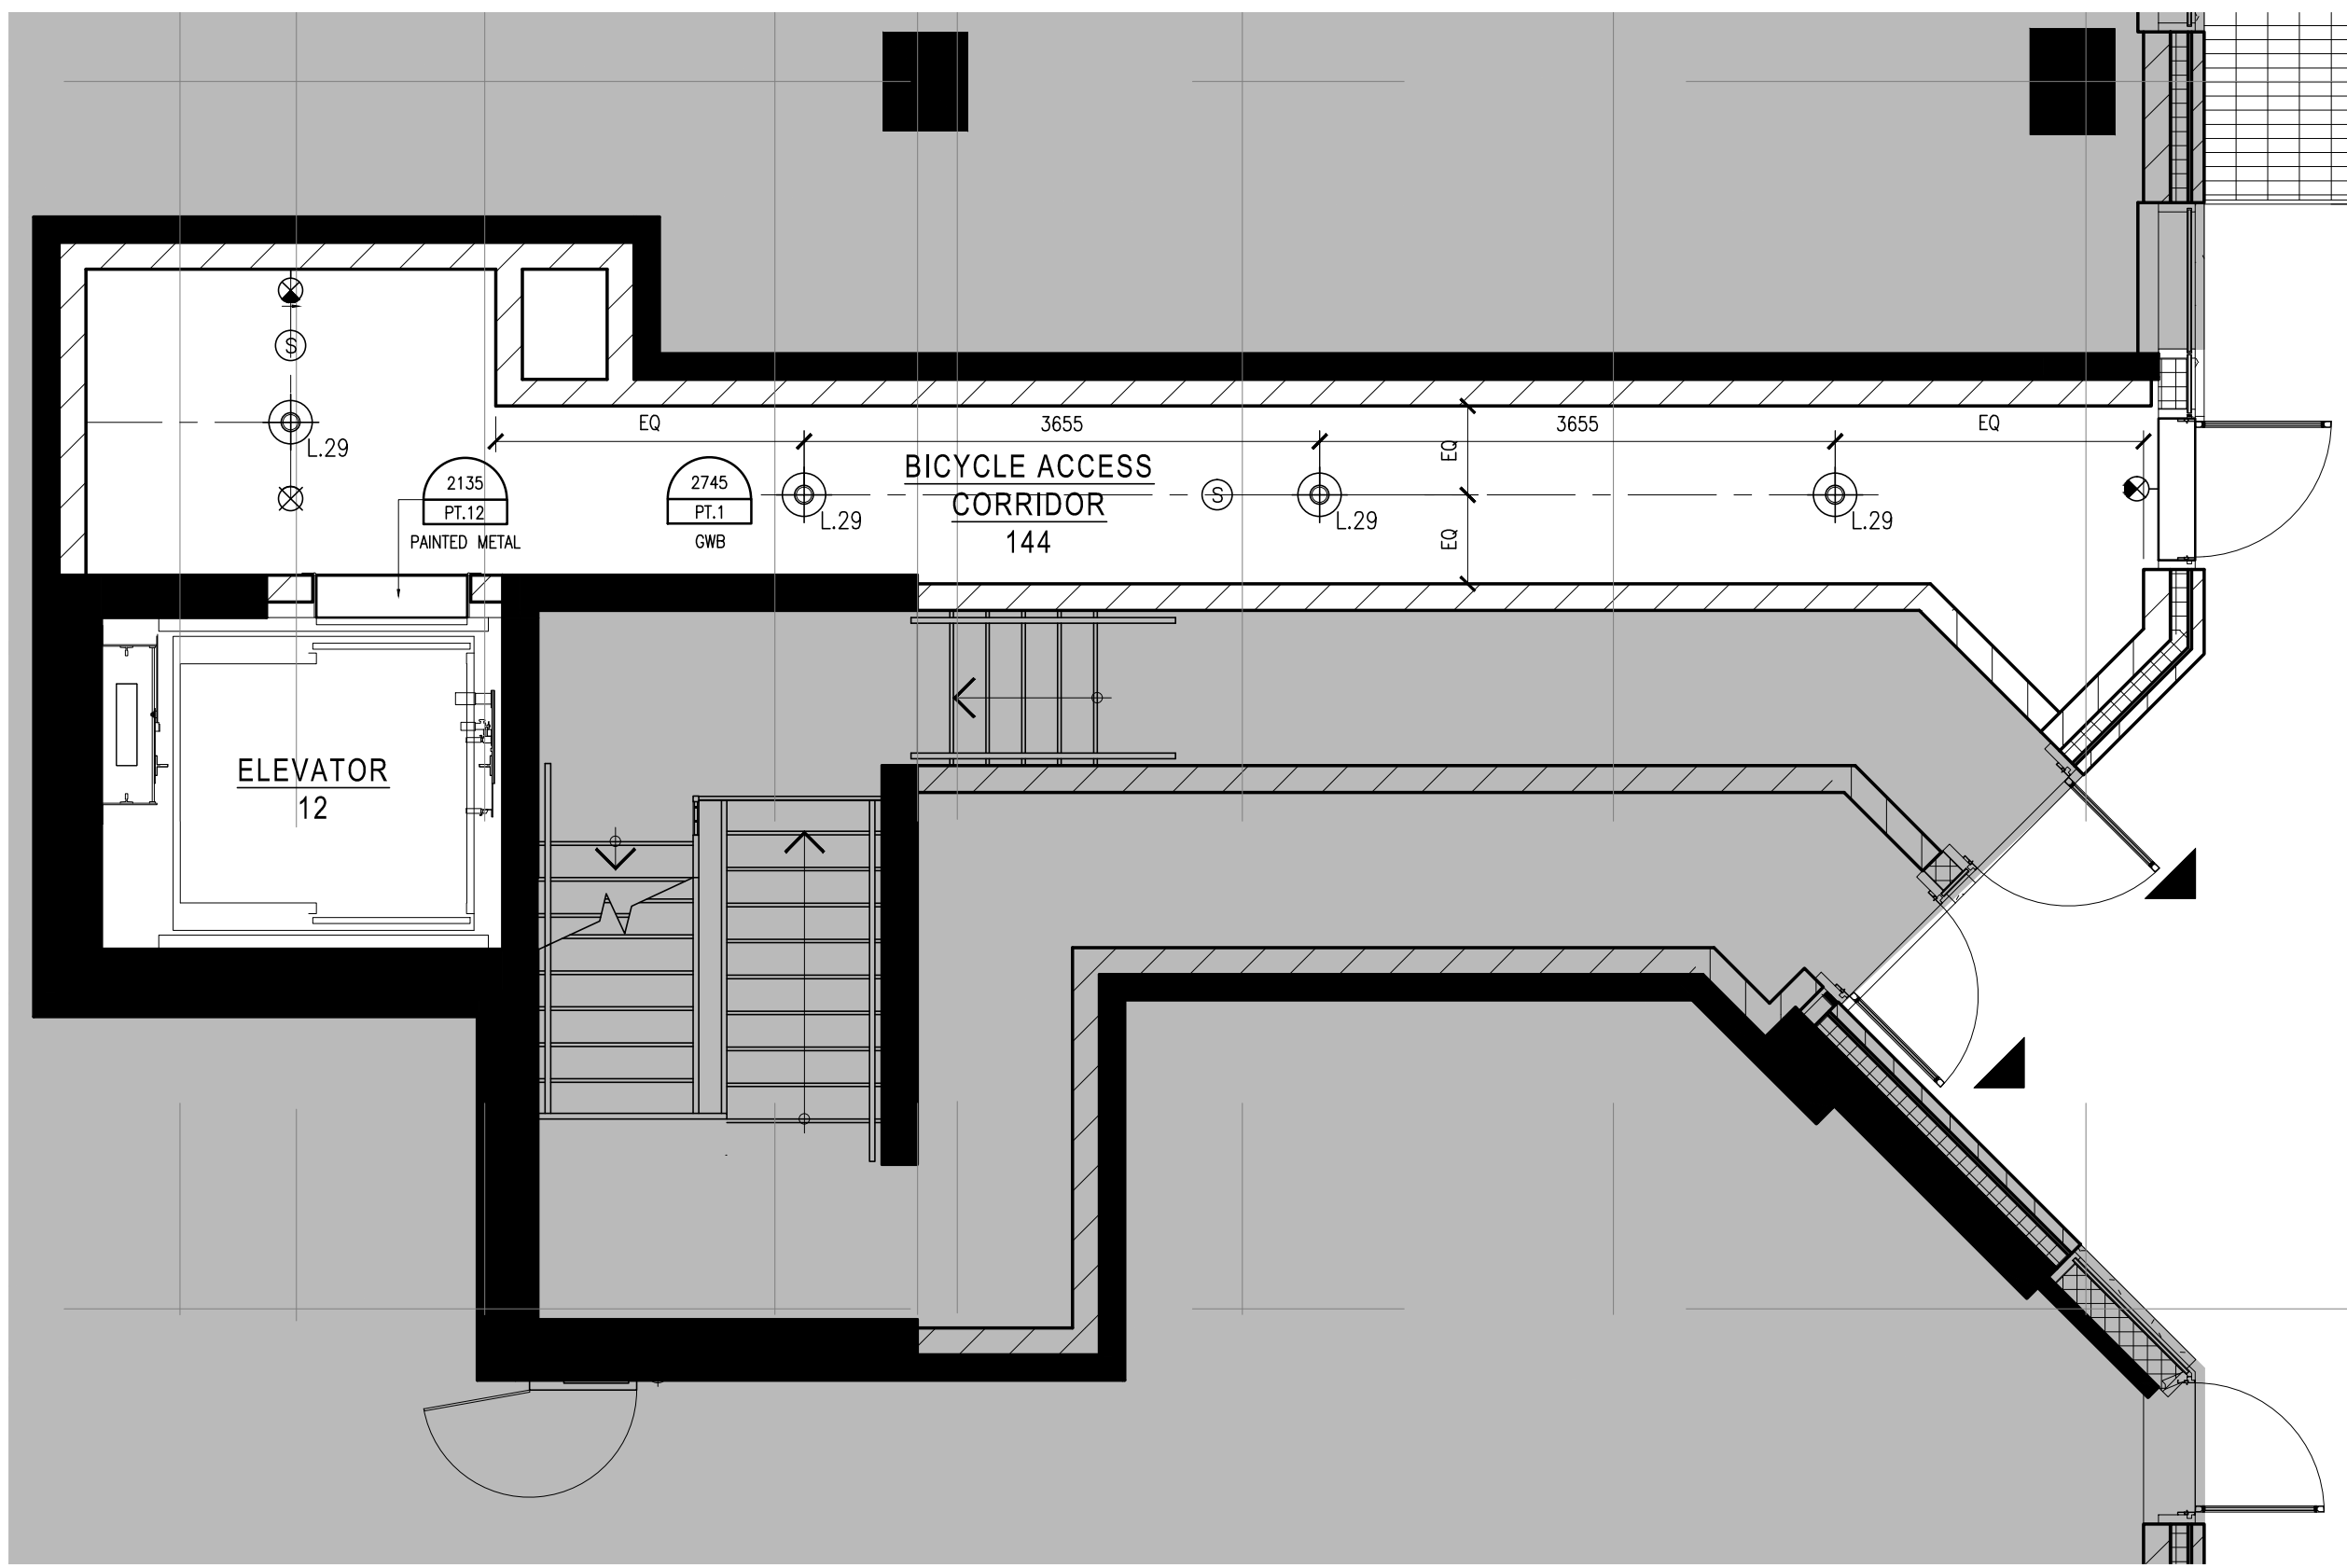


2 REFLECTED CEILING PLAN
02.3 SCALE 1:50

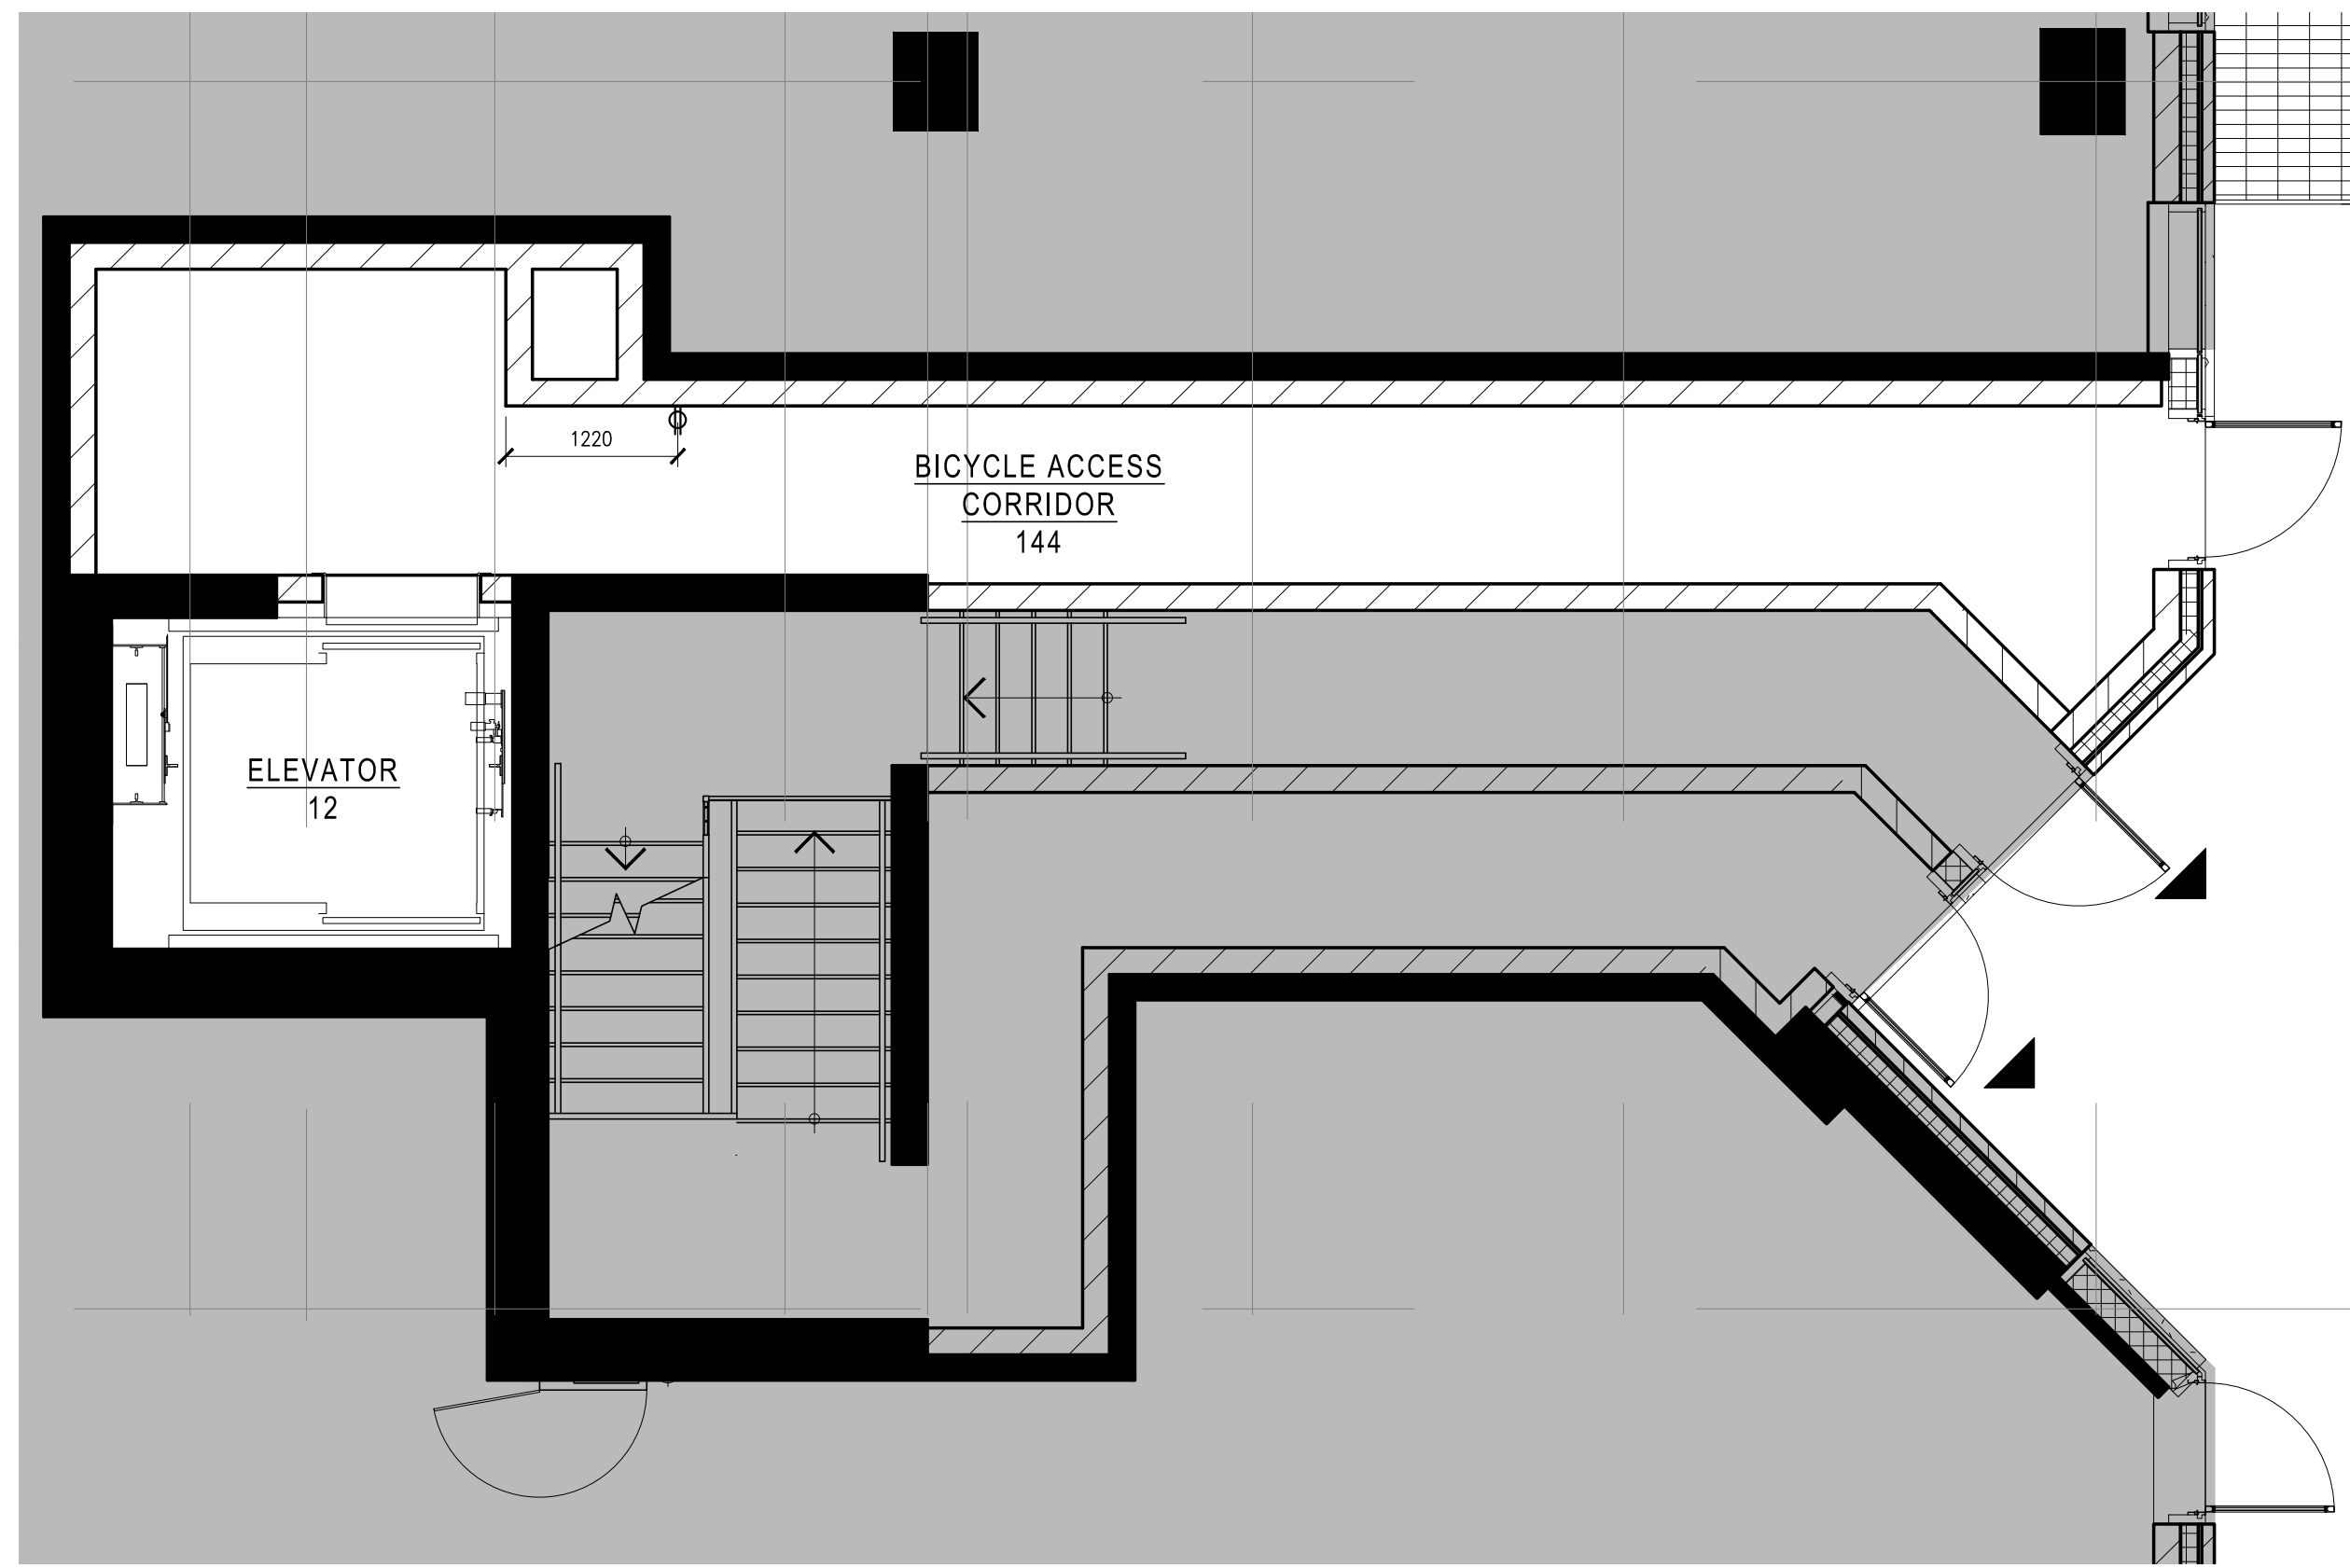


3 POWER AND COMMUNICATION PLAN
02.3 SCALE 1:50

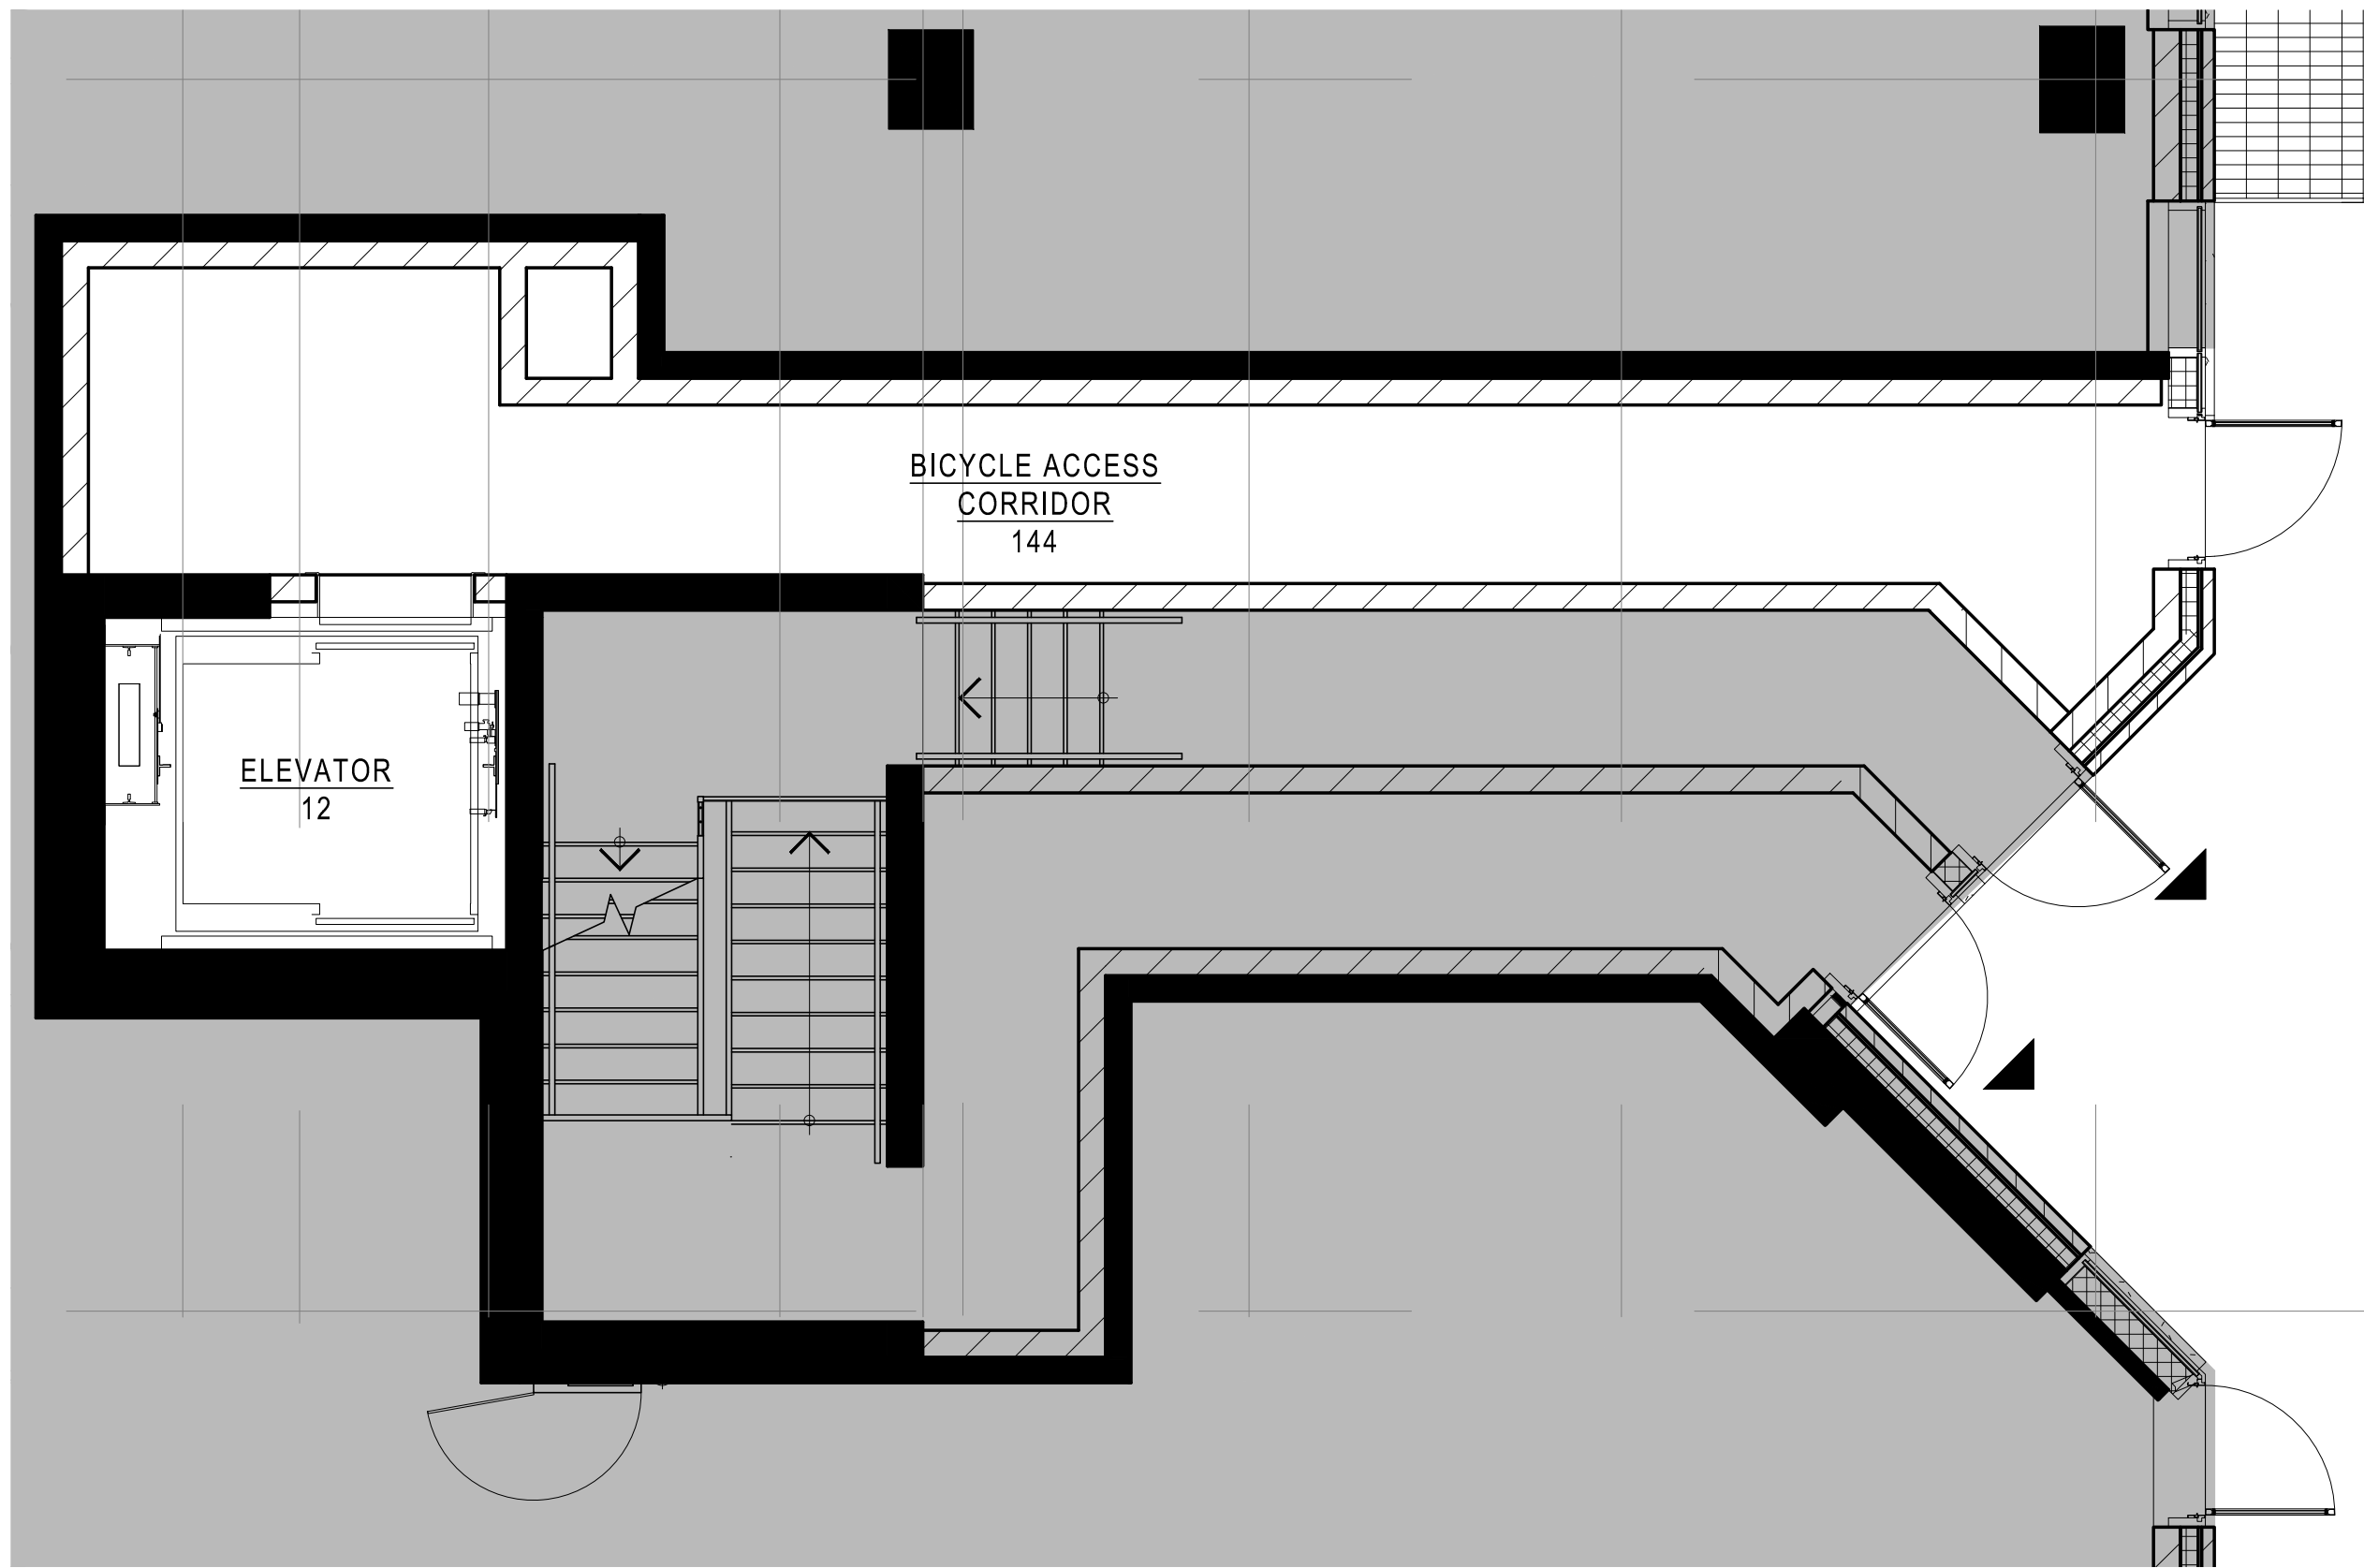

4 FIXTURE PLAN
02.3 SCALE 1:50

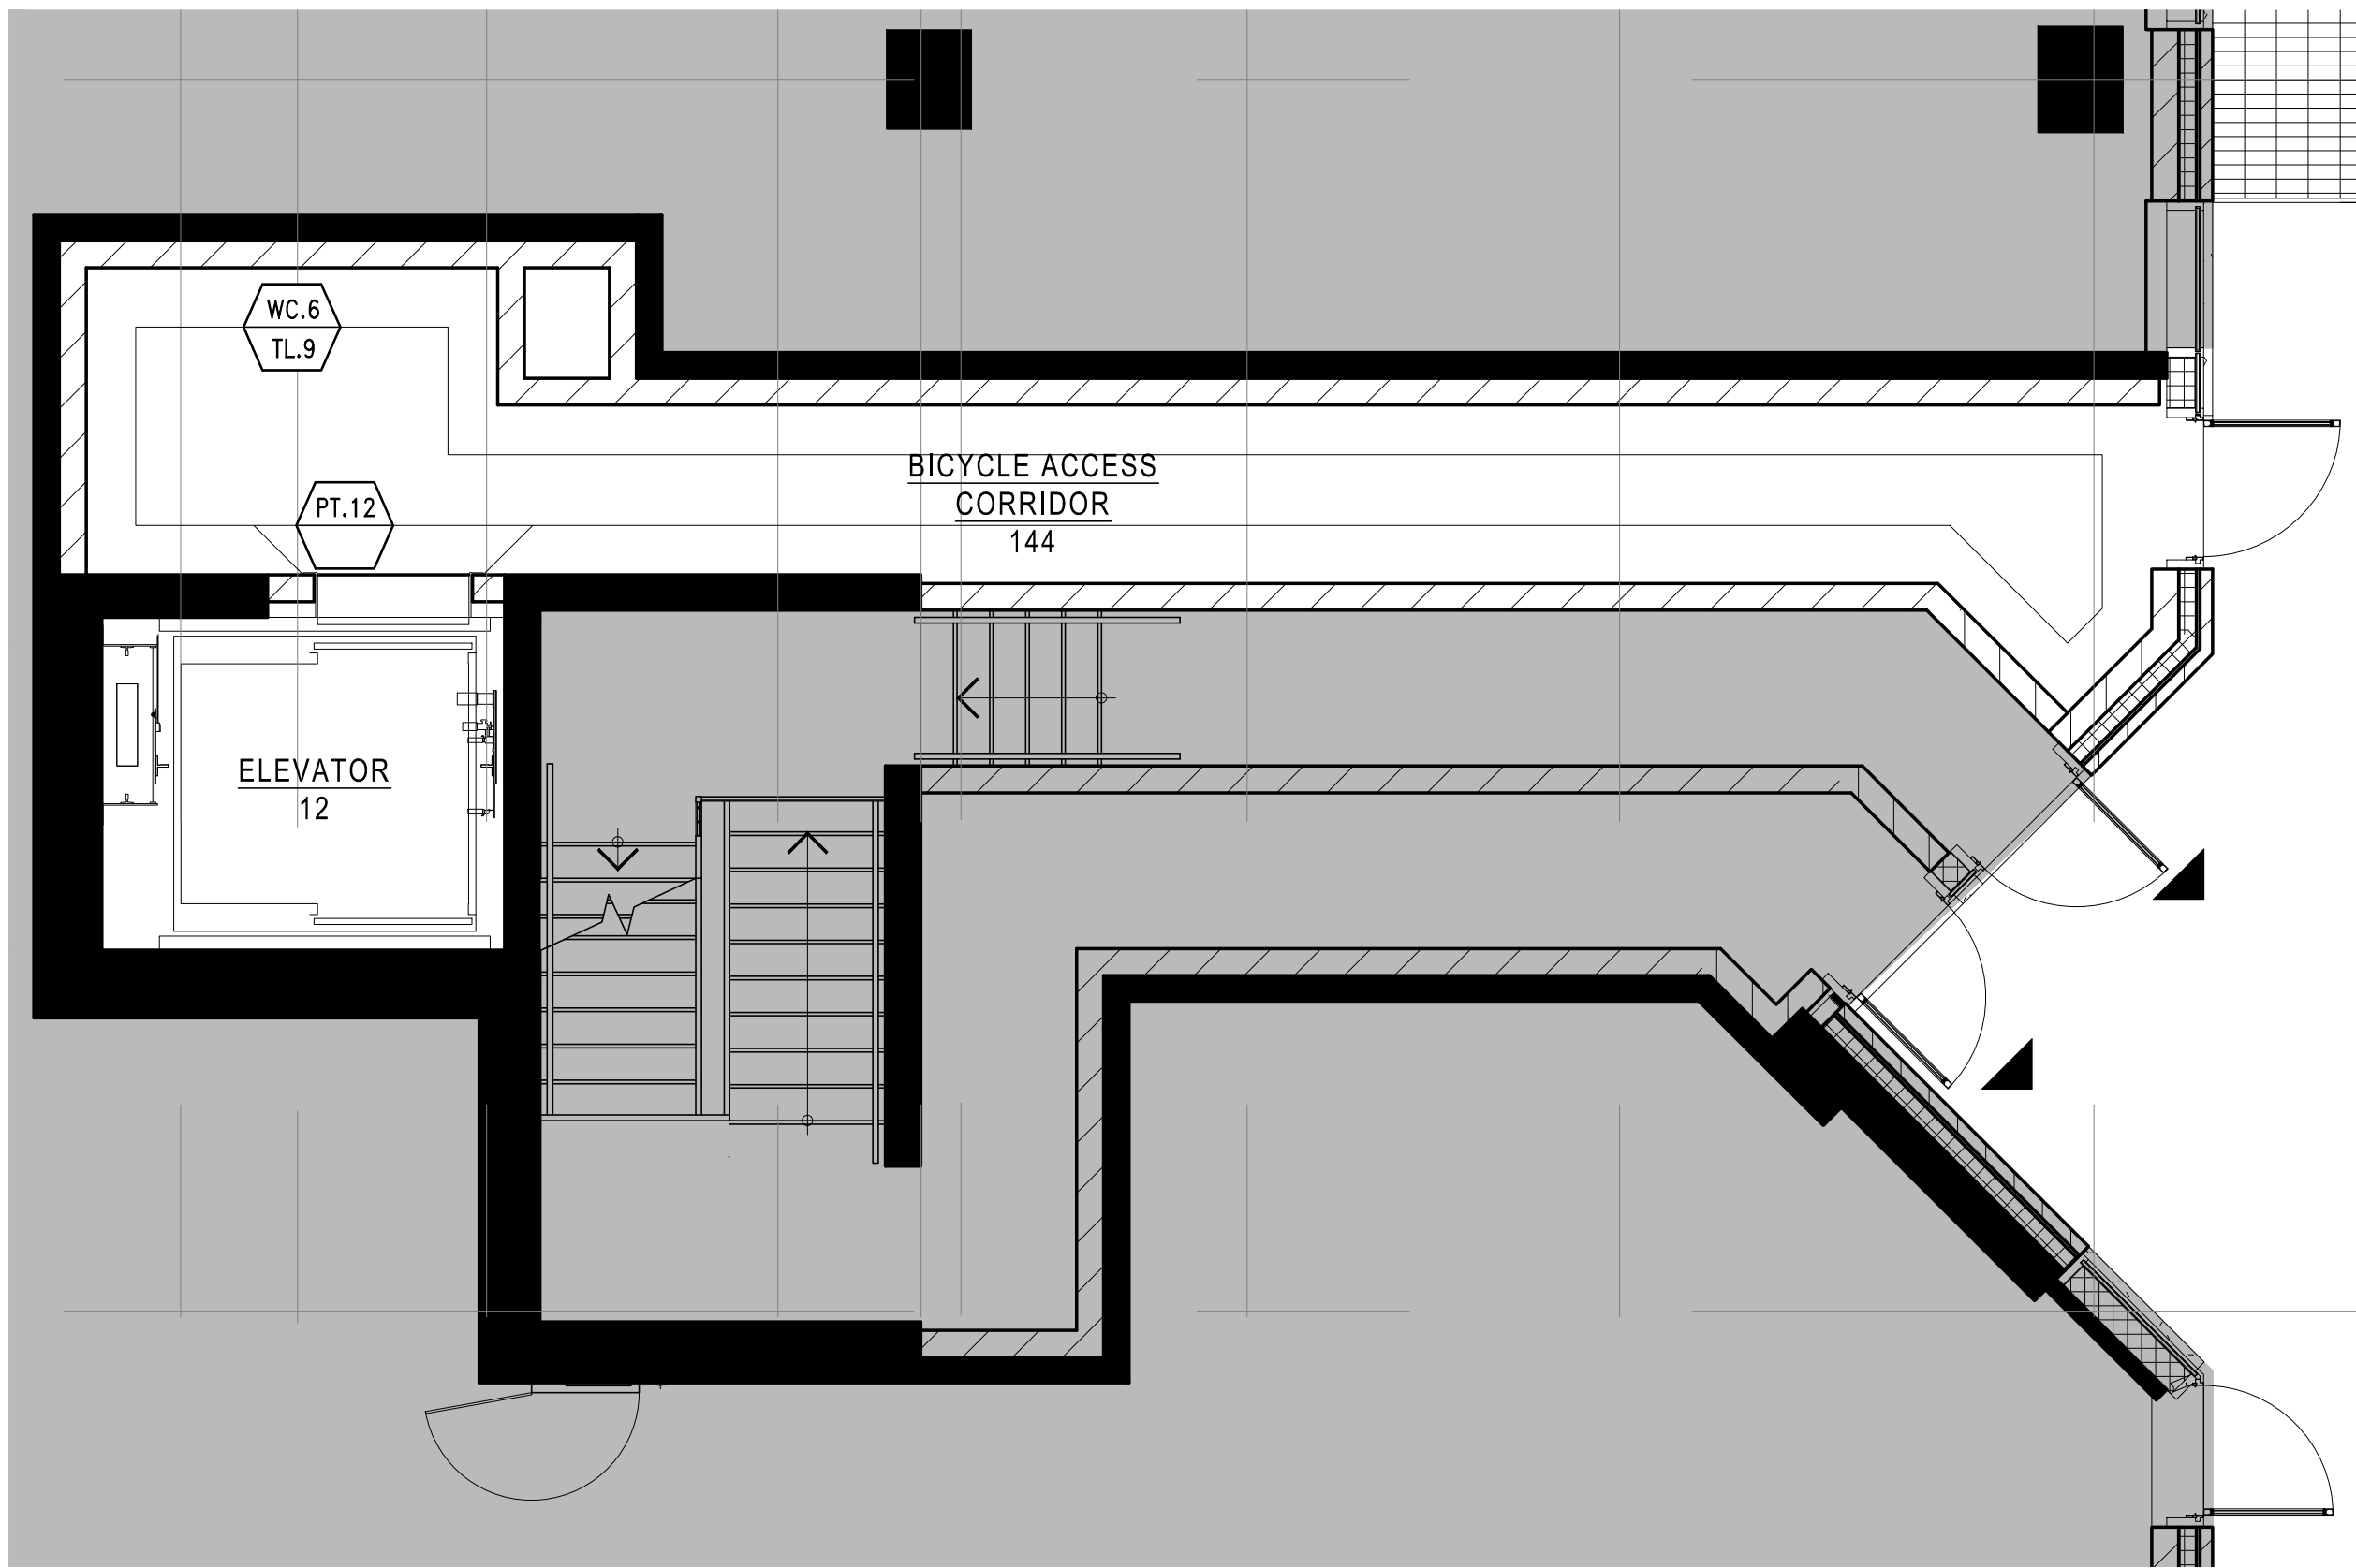

5 WALL FINISH PLAN
02.3 SCALE 1:50

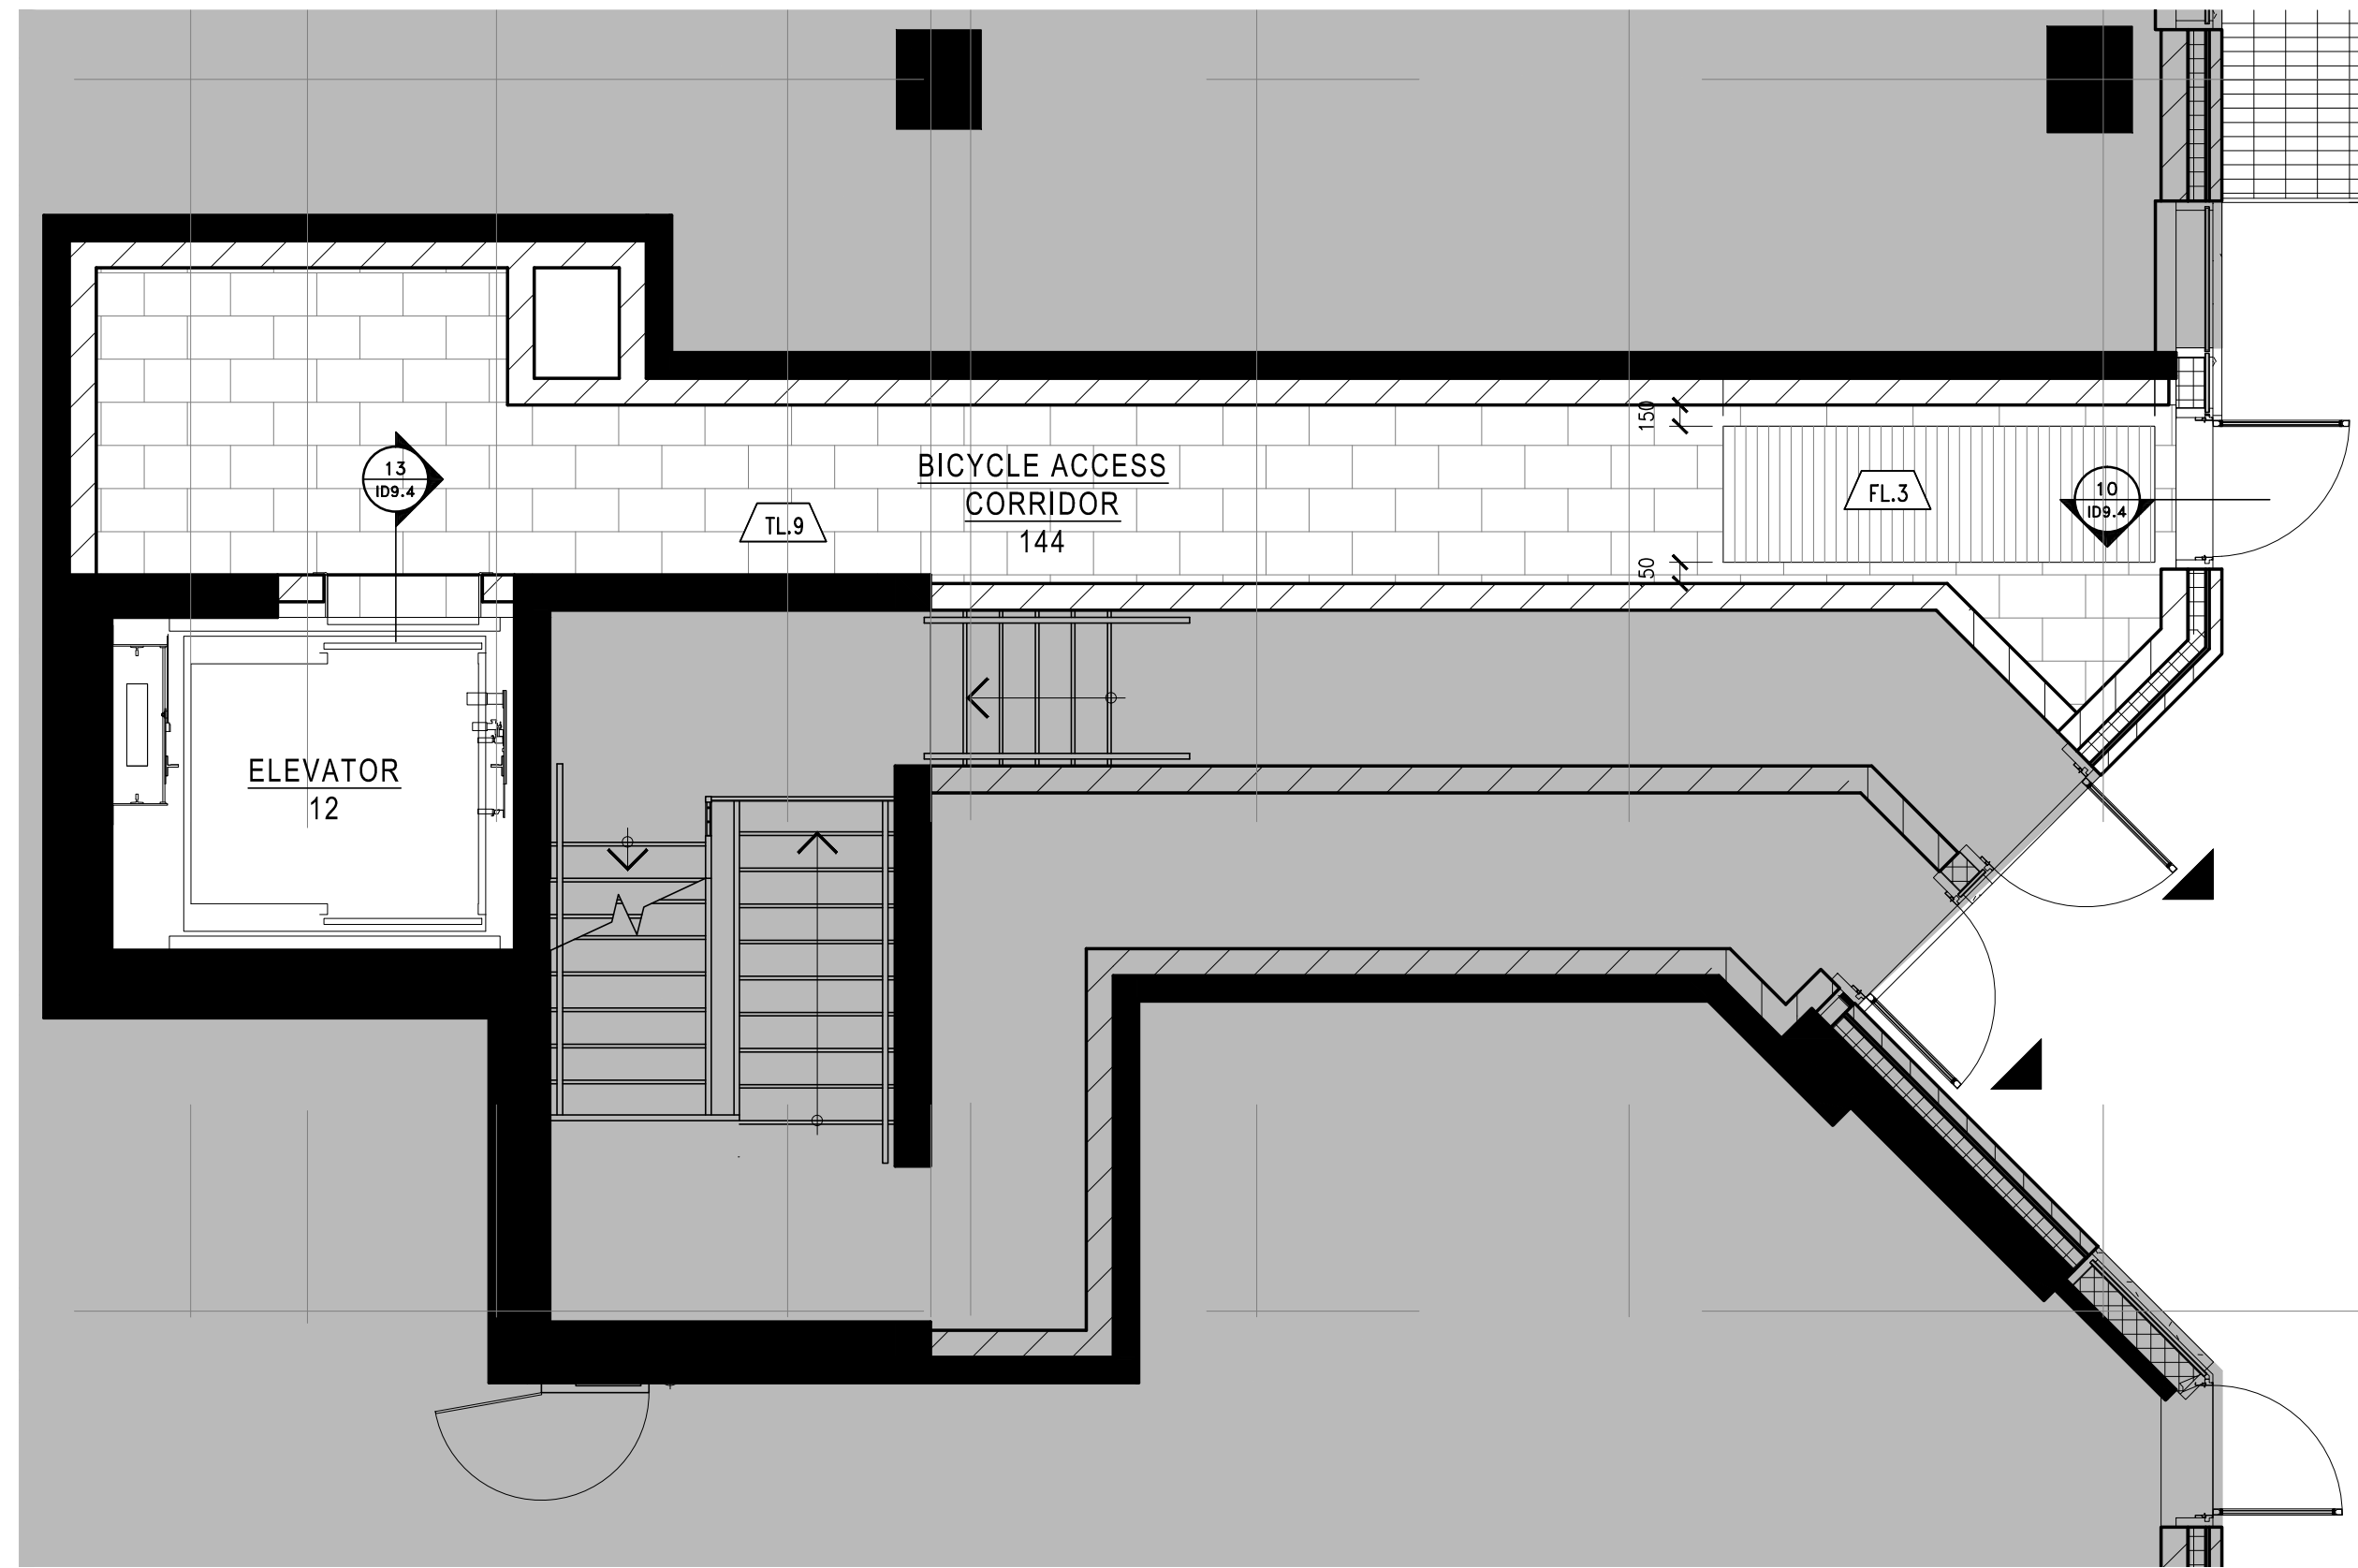

6 FLOOR FINISH PLAN
02.3 SCALE 1:50

Note:

1. CONTRACTOR AND ALL SUB-TRADES SHALL VERIFY ALL SITE DIMENSIONS, ALL DRAWINGS, DETAILS AND SPECIFICATIONS AND REPORT ANY DISCREPANCIES TO THE INTERIOR DESIGNERS IN WRITING FOR APPROVAL BEFORE PROCEEDING WITH THE WORK.
2. CONTRACTOR AND SUB-CONTRACTORS, BEFORE PROCEEDING WITH WORK, MUST SUBMIT ALL NECESSARY SAMPLES FOR APPROVAL OF QUALITY AND FINISH TO THE INTERIOR DESIGNER.
3. CONTRACTOR MUST COMPLY WITH THE CONTRACT DOCUMENTS, PERFORMANCE REQUIREMENTS, APPLICABLE CODES AND REGULATIONS.
4. ALL DRAWINGS AND WRITTEN MATERIAL HEREIN CONSTITUTES THE ORIGINAL AND UNPUBLISHED WORK OF "I BY IV DESIGN ASSOCIATES INC." AND MAY NOT BE DUPLICATED, USED OR DISCLOSED WITHOUT PRIOR WRITTEN CONSENT OF "I BY IV DESIGN ASSOCIATES INC."
5. DRAWINGS NOT TO BE SCALED

Issue:

08 ISSUED FOR ADDENDUM	16.09.20
09 ISSUED FOR ADDENDUM	17.01.27
10 ISSUED FOR CONSTRUCTION	17.06.19
-	-
-	-
-	-
-	-
-	-
-	-
-	-
-	-

Hines TRIDEL®

AQUAVISTA
AT BAYSIDE TORONTO

1 EDGEWATER DRIVE, TORONTO ONTARIO

77 MONMAY AVENUE, SUITE 100
TORONTO, ONTARIO M6M 3E3 - CANADA
T + 1 416 531 2224
12 DESMARADES STREET
NEW YORK, NEW YORK 10013 - USA
T + 1 212 390 4952

Drawing Title:
**LEVEL 1
BICYCLE ACCESS
CORRIDOR PLANS**

Our Project Number:
14009
Designed By:
DM,KR,VW,SG
Drawing Number:
DM,KR,VW,SG,BP

ID2.6A